



FLOOR PLAN

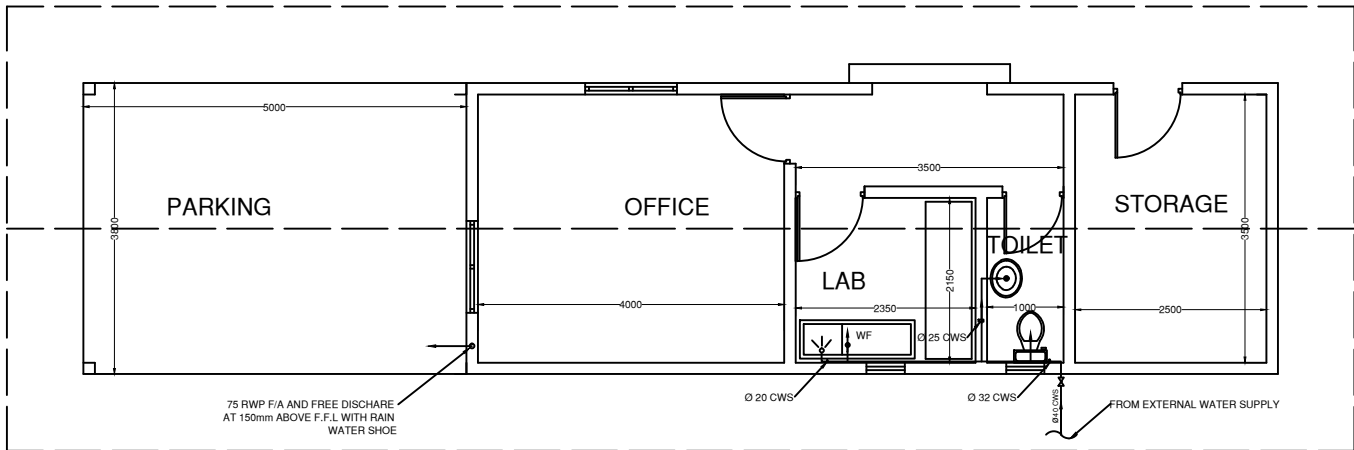


FLOOR PLAN

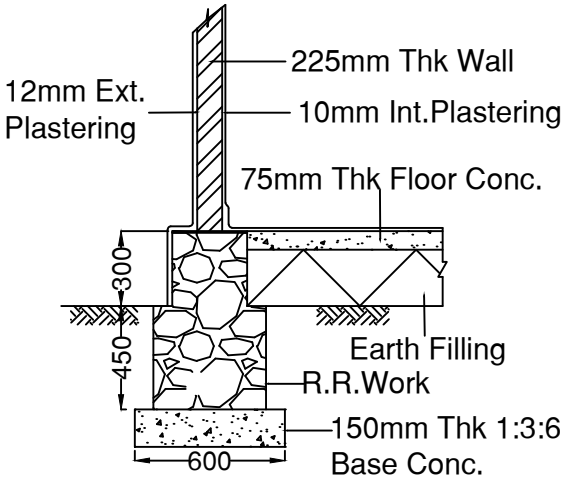


DETAIL OF FOUNDATION

NOTE:  
1.ALL DIAMENSIONS ARE IN MILLMETER  
2.ALL LEVELS SHOWN ARE IN METERS  
3.THIS DRAWING TO BE READ IN CONJECTION WITH ALL OTHER RELEVENT DRAWINGS, GENERAL NOTHES AND SPECIFICATIONS

LEGEND:  
1.NGL - NATURAL GROUND LEVEL  
2.FFL - FINISHED FLOOR LEVEL  
3.PCC- PLAIN CEMENT CONCRETE  
4.FD - FLOOR DRAIN  
5.GEO- GROUND CLEAN OUT  
6.CWS- COLD WATER SUPPLY

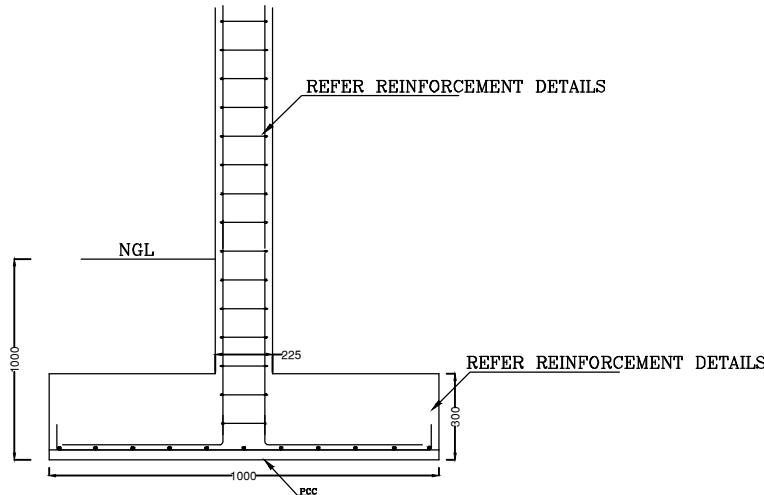

FOOTING DETAIL  
SCALE 1:10

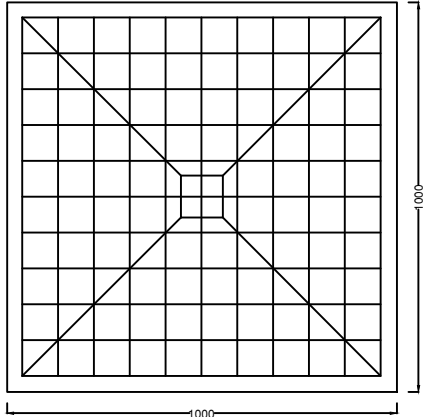

PLAN

T10@150 C/C

T12@150 C/C

	<p>CLIENT: MINISTRY OF ENVIRONMENT AND ENERGY</p>	<p>CONSULTANCY SERVICES FOR DESIGN OF WATER SUPPLY FACILITIES IN Ha.HORAFUSHI, Hdh.HANIMAADHOO,Sh.MILANDHOO,R.UNGOOFAARU,Lh.NAIFARU,Dh,KUDAHUVADHOO ,Th.GURAI DHOO AND Ga.VILLINGILI , MALDIVES</p>	<p>DESIGN ENGINEER</p>	<p>DRAWN DATE</p>	<p>CHECKED DESIGN CHIEF</p>	<p>APPROVED</p>	<p>SL.NO</p>	<p>DRWING NO</p>	<p>DESCRIPTION</p>
	<p>GREENTECH CONSULTANTS (Pvt.) Ltd IN ASSOCIATION WITH DEVELOPMENT COLLABORATION PARTNERSHIP (Pvt.) Ltd MALDIVES AND OPTIMUM SOLOUTIONS (Pvt) Ltd, MALDIVES</p>	<p>TITLE:  RO PLANT ADMIN BUILDING SEWERAGE AND WATER SUPPLY LAYOUT MILANDHOO</p>			<p>DRG.NO: MILANDHOO/ADMIN/05 SCALE: NOT TO SCALE</p>				