





NOTE:
1.ALL DIAMENSIONS ARE IN MILLMETER
2.ALL LEVELS SHOWN ARE IN METERS
3.THIS DRAWING TO BE READ IN CONJECTION
RELEVENT DRAWINGS, GENERAL NOTHES AN

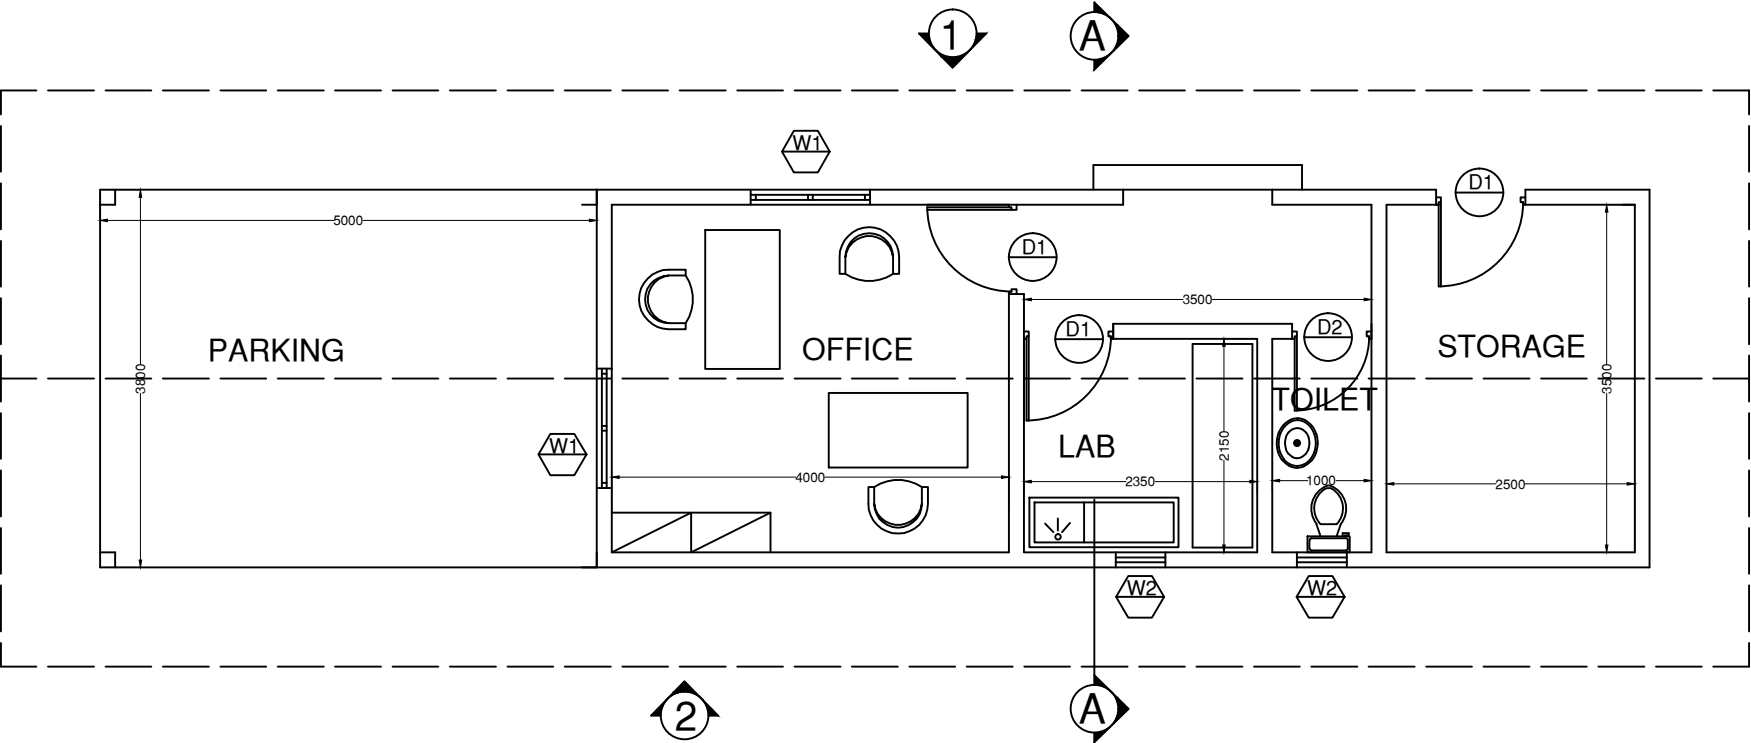

FLOOR PLAN

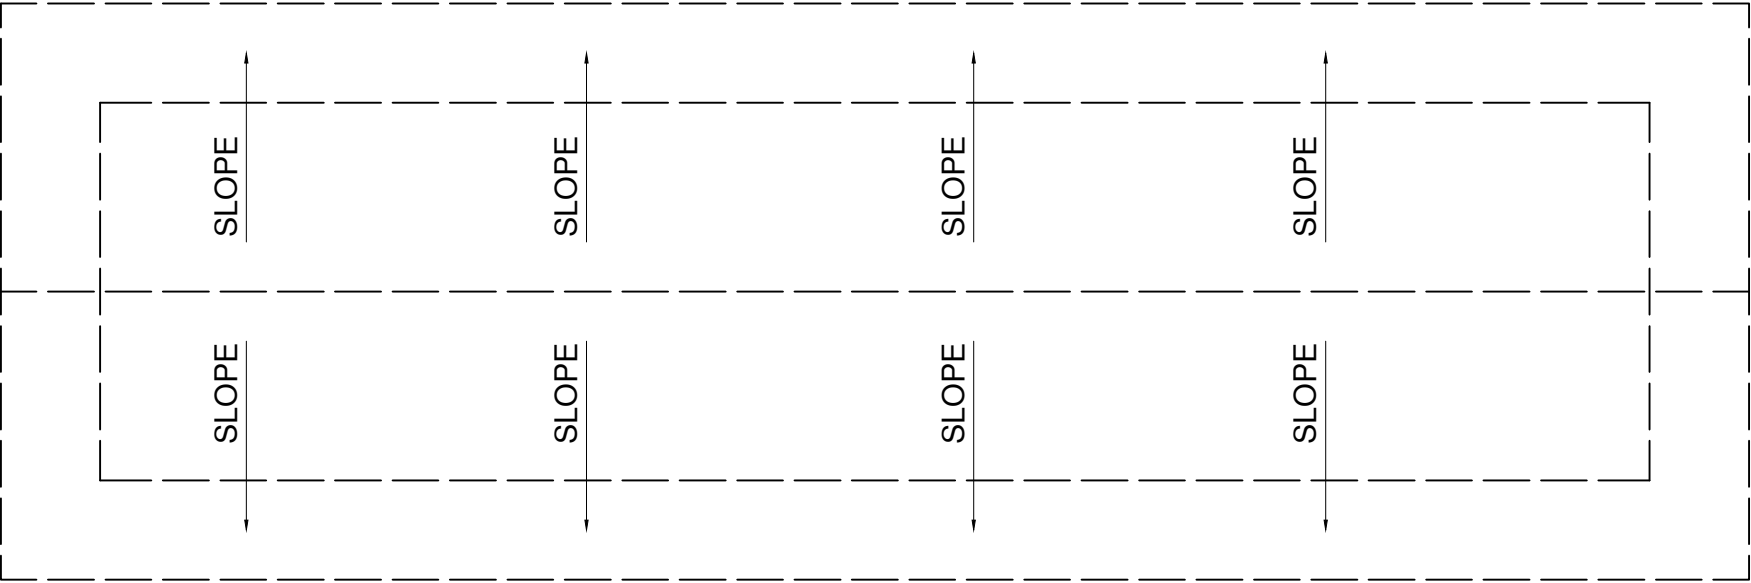

ROOF PLAN

	CLIENT: MINISTRY OF ENVIRONMENT AND ENERGY	CONSULTANCY SERVICES FOR DESIGN OF WATER SUPPLY FACILITIES IN Ha.HORAFUSHI, Hdh.HANIMAADHOO,Sh.MILANDHOO,R.UNGOOFAARU,Lh.NAIFARU,Dh,KUDAHUVADHOO ,Th.GURaidhoo AND Ga.VILLINGILI , MALDIVES	DESIGN	DRAWN	CHECKED	APPROVED	SL.NO	DRWING NO	DESCRIPTION
			ENGINEER		DESIGN CHIEF				
			DATE	DRG.NO: MILANDHOO/ADMIN/02					
				SCALE: NOT TO SCALE					
	GREENTECH CONSULTANTS (Pvt.) Ltd IN ASSOCIATION WITH DEVELOPMENT COLLABORATION PARTNERSHIP (Pvt.) Ltd MALDIVES AND OPTIMUM SOLOUTIONS (Pvt) Ltd, MALDIVES	TITLE: RO PLANT ADMIN BUILDING FLOOR & ROOF PLAN MILANDHOO							