


**PROPOSED 2 STOREY HOSPITAL EXTENSION AT
SH.FUNADHOO
REPUBLIC OF MALDIVES**

ELECTRICAL DRAWINGS

CLIENT
MINISTRY OF HEALTH
MALE' REPUBLIC OF MALDIVES


APRIL 2016

ARCHITECT

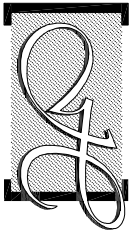

Hannan Yoosuf Architects

| | | |
|------------------------|-------------------------|----------------------|
| MILANO | (3 ST FLOOR) | RAHDHEBAI MAGU |
| MACHCHANGOLHI | | MALE' 20159 MALDIVES |
| TEL: (960) 331 8765 | FAX: (960) 331 8763 | |
| EMAIL: info@nyarch.net | | WEB: www.nyarch.net |

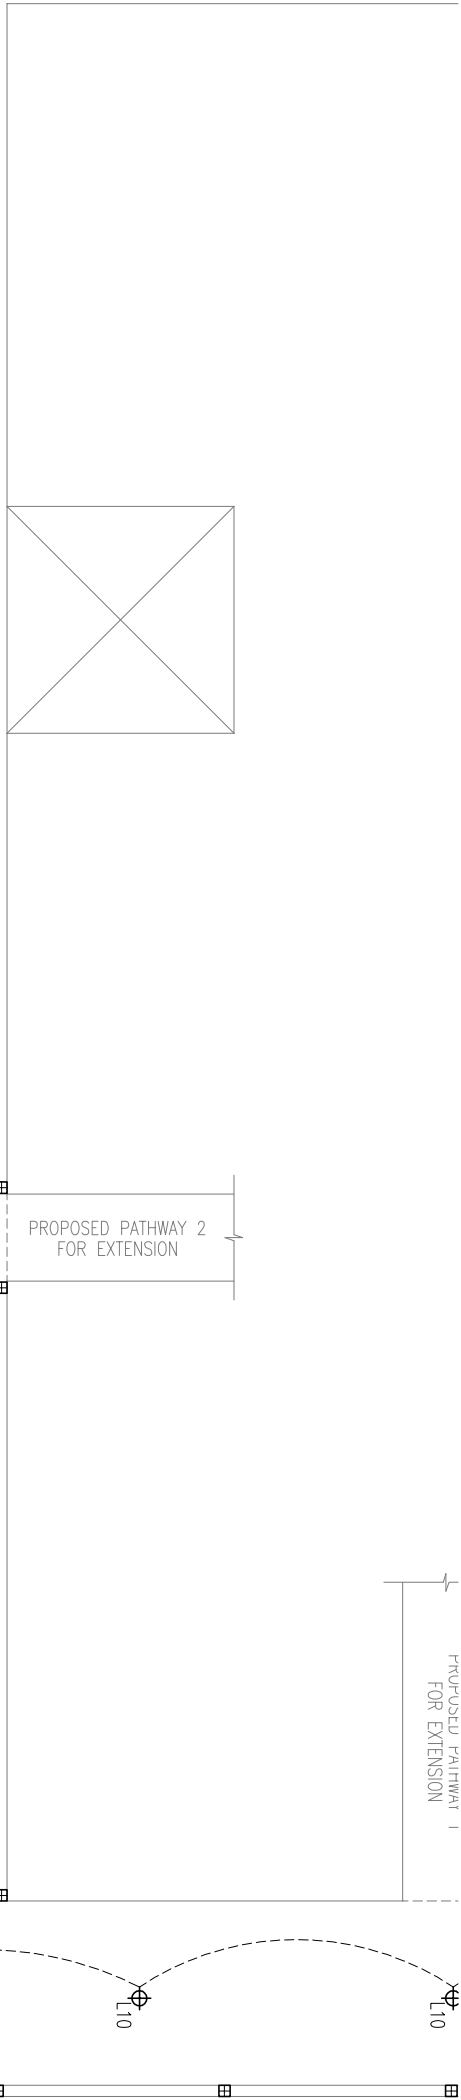


- ELECTRICAL LEGEND**
- ⊕ ENERGY SAVING LIGHT WITH FROSTED COVERING
 - ⊕ WALL MOUNTED LIGHT
 - ⊕ CEILING FAN
 - ⊕ EXHAUST FAN
 - ⊕ WEATHER PROOF
 - ⊕ EMERGENCY LIGHT
 - ⊕ ONE WAY SWITCH AT 1.2M HT
 - ⊕ GARDEN LIGHT


NOTE:

THE DRAWINGS ARE SCHEMATIC.

DETAILED SYSTEMS DESIGN AND CONDUITING SHALL BE DONE BY CONTRACTOR AND SUBMITTED FOR APPROVAL BEFORE INSTALLATION.

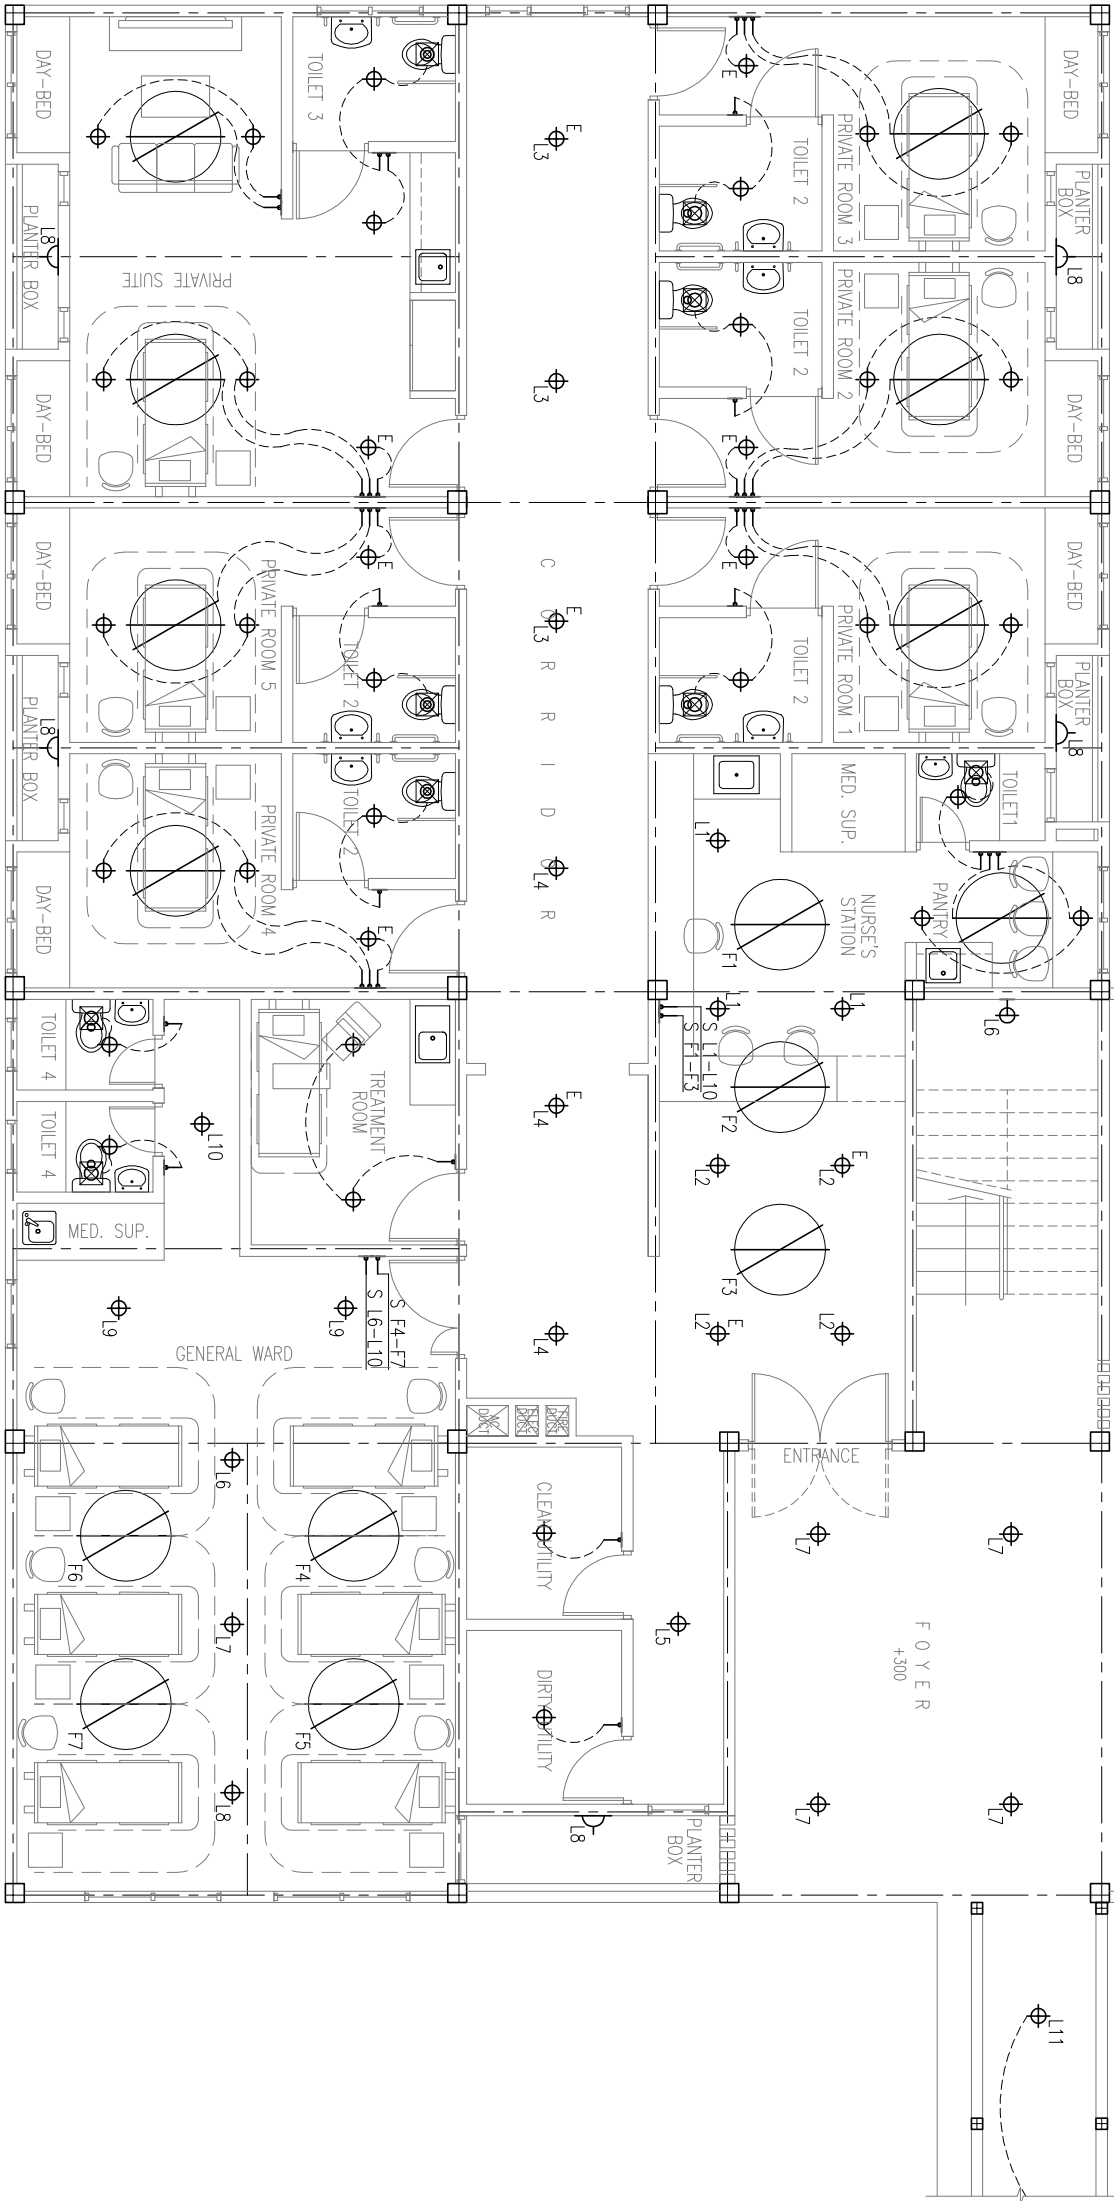

 
**GROUND FLOOR
LIGHTING & FAN LAYOUT 1:100**



1
E-01/04

| | | | |
|--|---|-------------------|--|
| <div><div></div><div>Hannan Yoosuf Architects MILANO (3RD FLOOR) RAHDHEBAI MAGU MACHCHANGOLHI MALE 20159 MALDIVES TEL: (960) 331 8765 FAX: (960) 331 8763 EMAIL: info@hyarch.net WEB: www.hyarch.net</div></div> | | | |
| CLIENT MINISTRY OF HEALTH | | | |
| PROJECT PROPOSED 2 STOREY EXTENSION OF SH.FUMADHOO HOSPITAL | | | |
| REPUBLIC OF MALDIVES | | | |
| STAGE SUBMISSION DRAWINGS | | | |
| CONTENTS | | | |
| GROUND FLOOR LIGHTING & FAN LAYOUT | | | |
| DESIGN YUS | DRAWN YUS | CHECKED RAZZAN | |
| PROJECT NO. 2016L-14/21 | DRAWING NO. E-01 OF 04 | | |
| PROJECT DATE APRIL 2016 | | | |


COPYRIGHT, THE CONCEPT AND DESIGN IN THIS DRAWING ARE THE PROPERTIES OF HANNAH YOOSUF ARCHITECTS PVT LTD. UNAUTHORISED USE OF ANY KIND OR COPYING OF WHOLE OR PART OF THIS DRAWING, CONCEPT OR DESIGN OR USE ON PROJECTS OR SITES OTHER THAN SPECIFIED ON THIS DRAWING IS PROHIBITED.

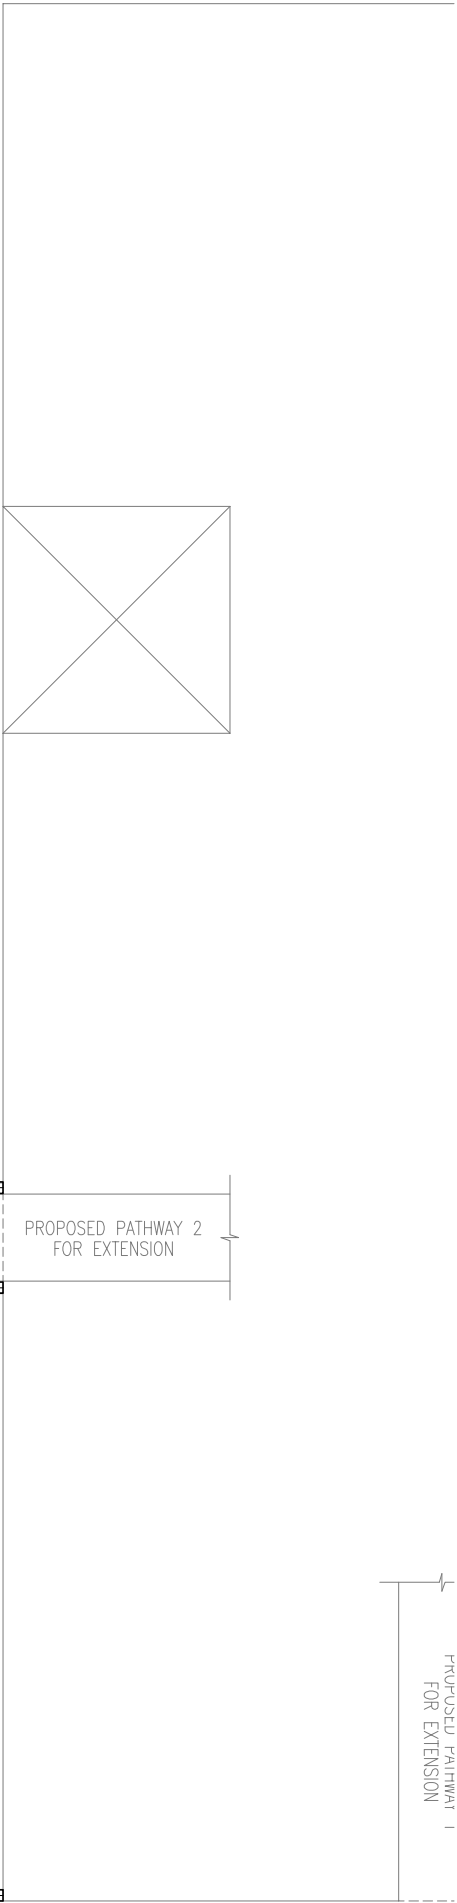


| ELECTRICAL LEGEND | |
|-------------------|--|
| | WALL SOCKET 13A (LOW LV) |
| | WALL SOCKET 13A (HIGH LV) |
| | WALL SOCKET 15A (HIGH LV) |
| | CEILING SOCKET 15A (HIGH LV) |
| | CABLE TV SOCKET |
| | TELEPHONE SOCKET |
| | TELEPHONE SOCKET FOR FACSIMILE MACHINE |
| | NETWORK SOCKET |
| | D-BOARD |
| | WEATHERPROOF |
| | AIR-CONDITIONING |
| | CCTV CAMERA (180°) |

NOTE:

THE DRAWINGS ARE SCHEMATIC.
DETAILED SYSTEMS DESIGN AND CONDUITING
SHALL BE DONE BY CONTRACTOR AND SUBMITTED
FOR APPROVAL BEFORE INSTALLATION.

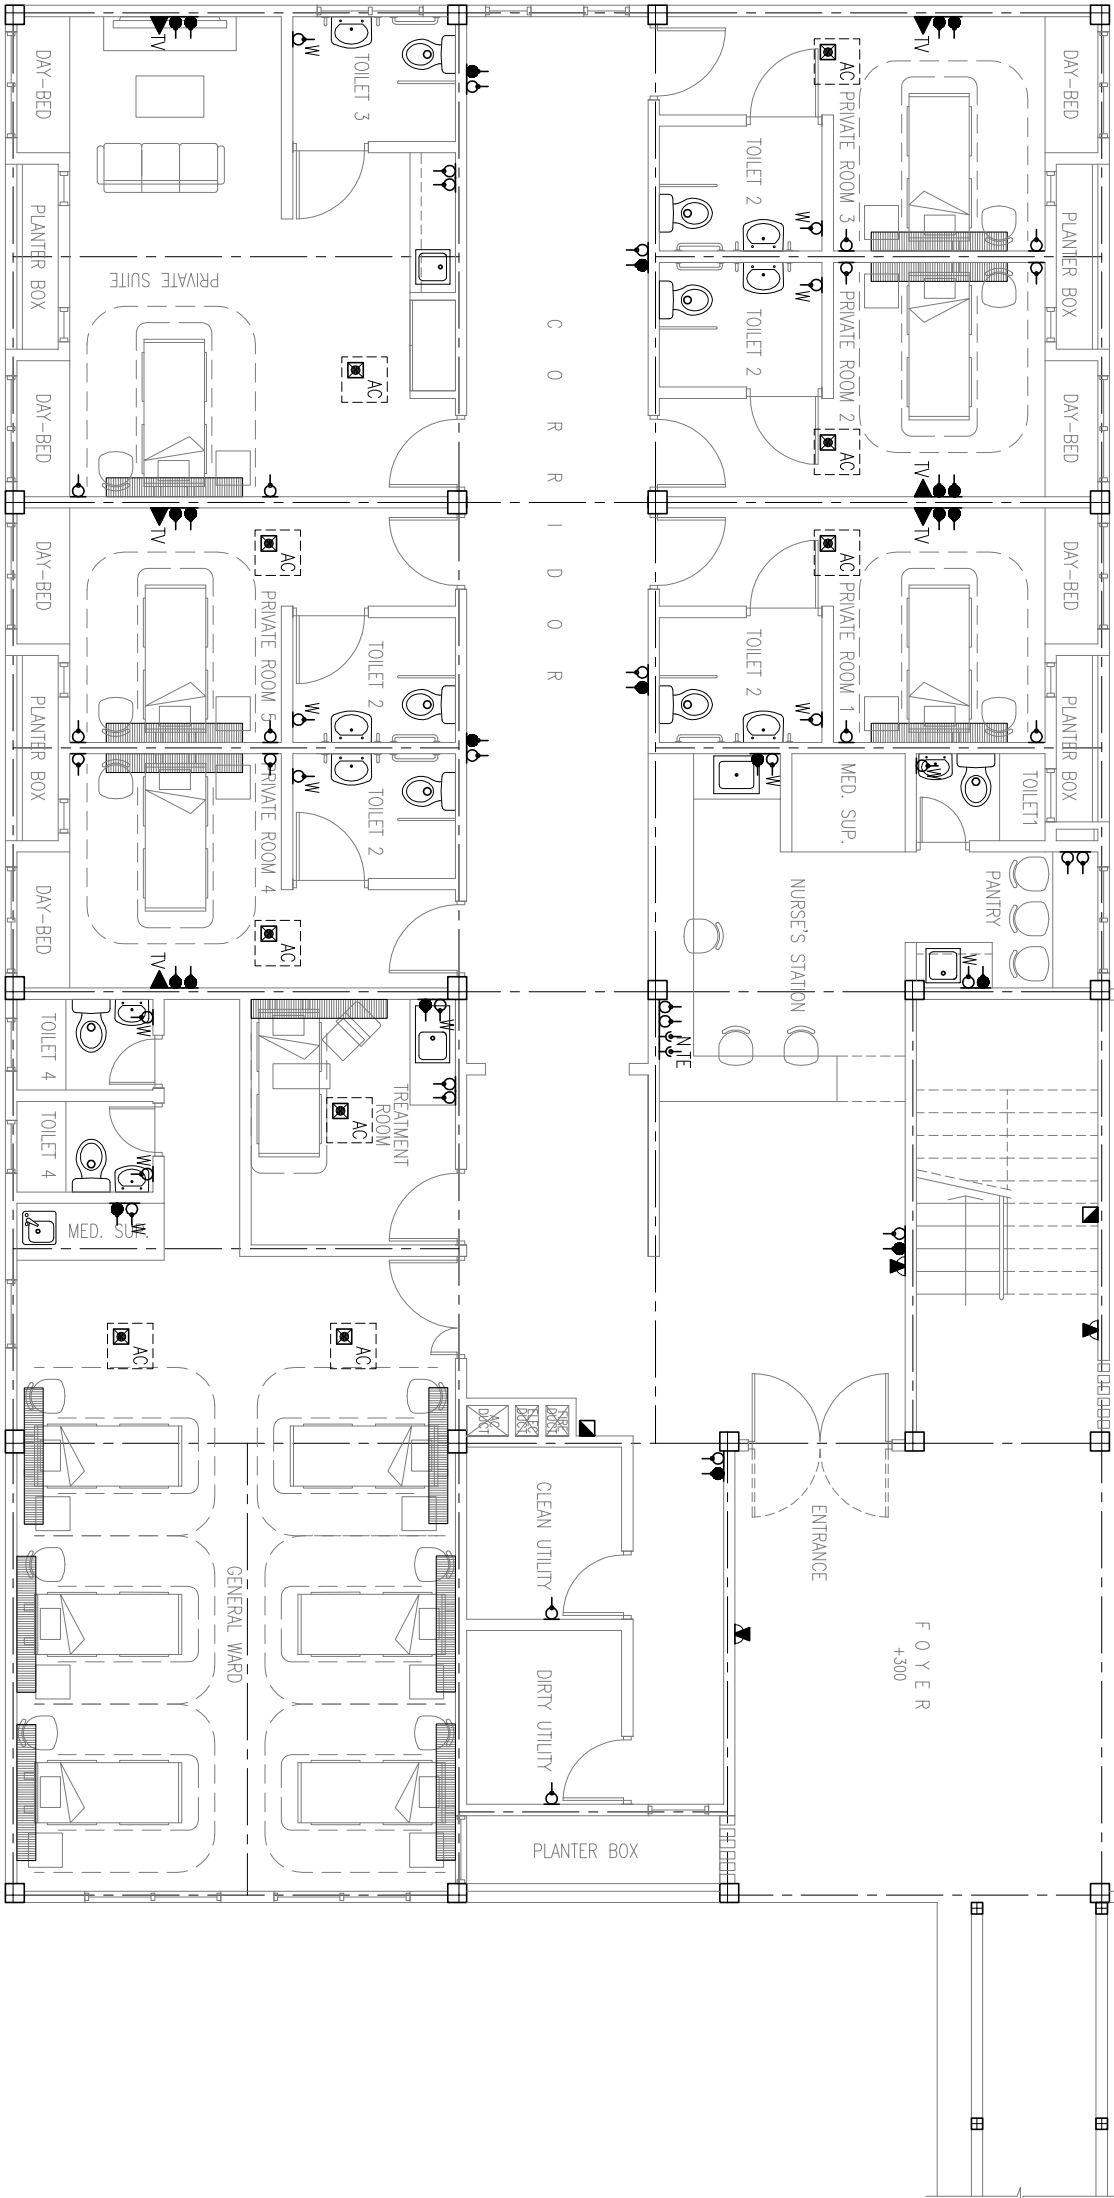


| | |
|--|---------------------|
| Hannan Yoosuf Architects | |
| MILANO (3 RD FLOOR) RAHDHEBAI MAGU MACHCHANGOLHI MALE' 20159 MALDIVES TEL: (960) 331 8765 FAX: (960) 331 8763 EMAIL: info@hyarch.net WEB: www.hyarch.net | |
| CLIENT MINISTRY OF HEALTH | |
| PROJECT PROPOSED 2 STOREY EXTENSION OF SH.FUMADHOO HOSPITAL | |
| REPUBLIC OF MALDIVES | |
| STAGE SUBMISSION DRAWINGS | |
| CONTENTS GROUND FLOOR POWER LAYOUT | |
| DESIGN YUS | DRAWN YUS |
| CHECKED RAZZAN | |
| PROJECT NO. 2016L-14/21 | DRAWING NO. E-02 |
| PROJECT DATE APRIL 2016 | OF 04 |

 


- ELECTRICAL LEGEND**
- ⊕ ENERGY SAVING LIGHT WITH FROSTED COVERING
 - ⊕ WALL MOUNTED LIGHT
 - ⊕ CEILING FAN
 - ⊕ EXHAUST FAN
 - W WEATHER PROOF
 - E EMERGENCY LIGHT
 - ⊕ ONE WAY SWITCH AT 1.2M HT

NOTE:

THE DRAWINGS ARE SCHEMATIC.
DETAILED SYSTEMS DESIGN AND CONDUITING
SHALL BE DONE BY CONTRACTOR AND SUBMITTED
FOR APPROVAL BEFORE INSTALLATION.

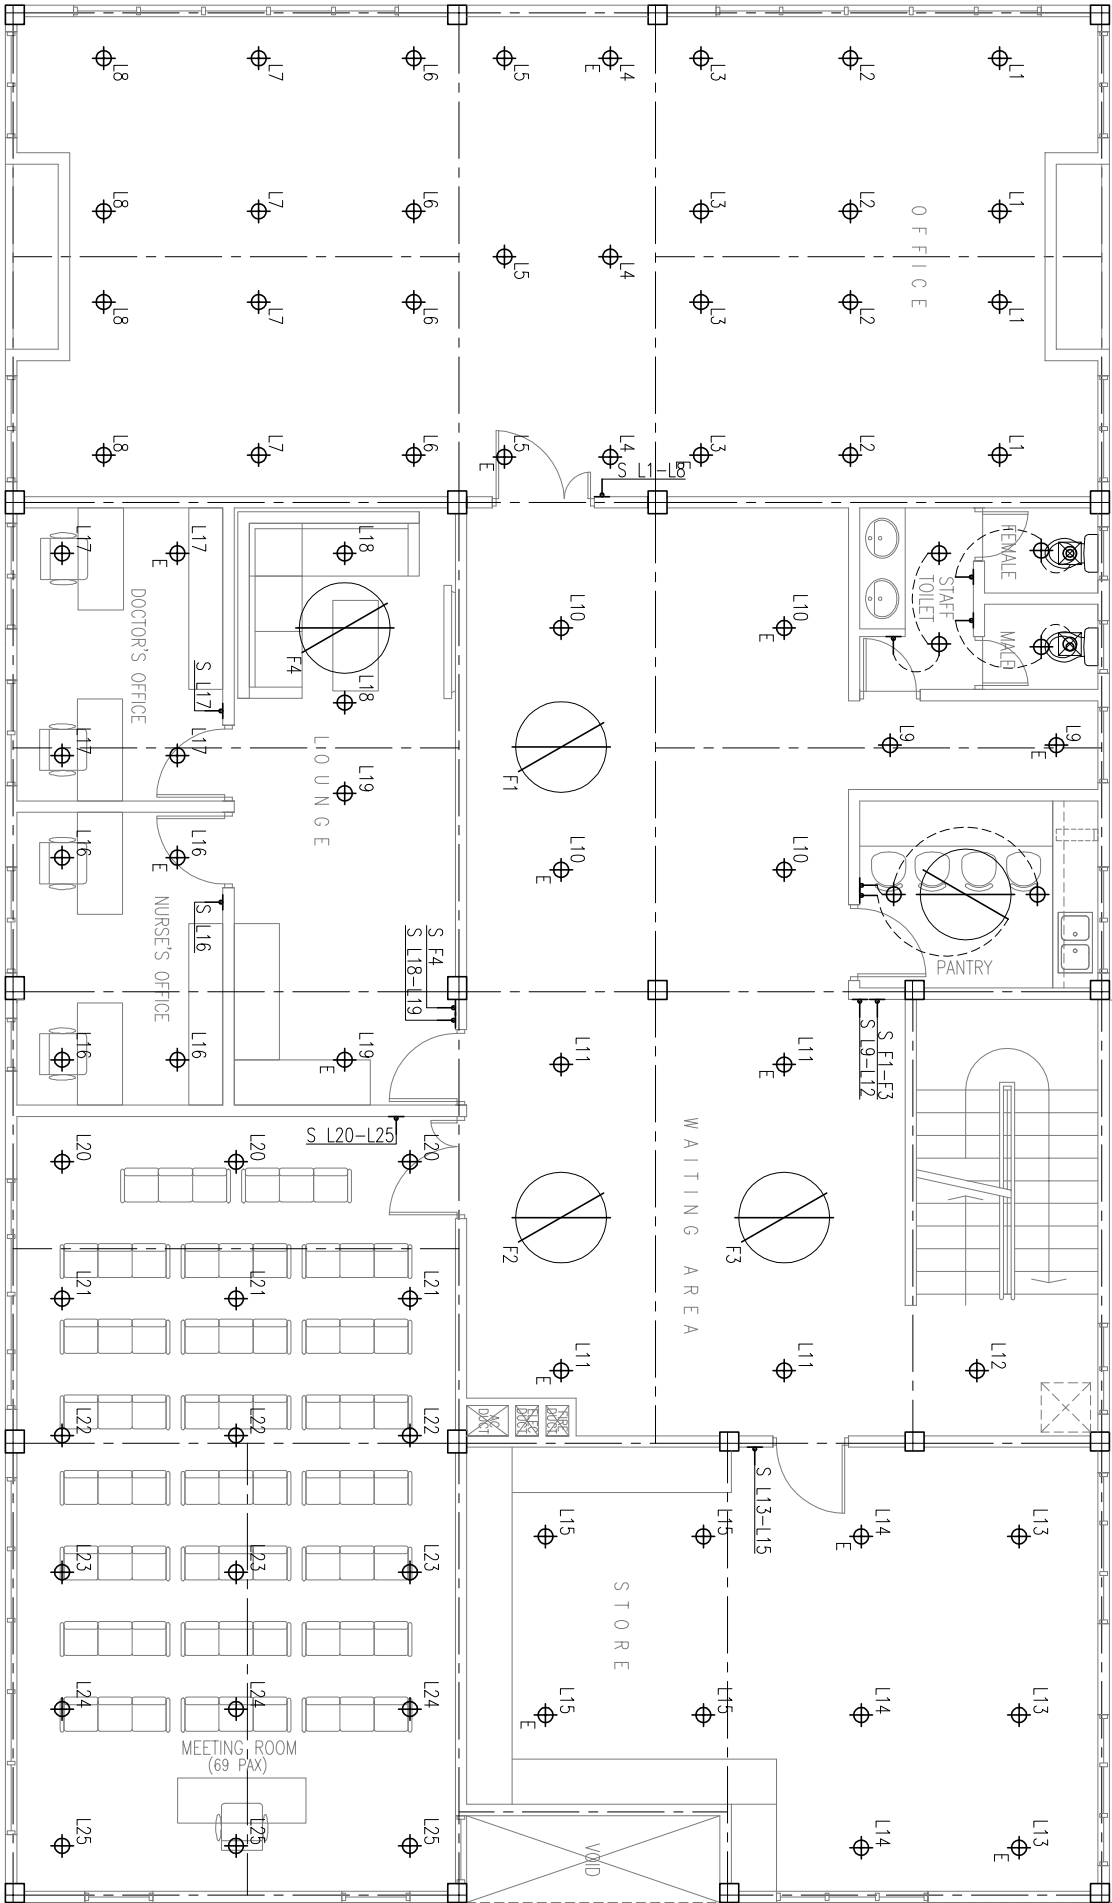

 **FIRST FLOOR
LIGHTING & FAN LAYOUT 1:100**




1
E-03/04

| | | | |
|--|--|-------------|--|
| NOTES | | | |
| ARCHITECT | | | |
| Hannan Yoosuf Architects | | | |
| MILANO (3 RD FLOOR) RAHDHEBAL MAGU | | | |
| MACHCHANGOLHI MALE 20159 MALDIVES | | | |
| TEL: (960) 331 8765 FAX: (960) 331 8763 | | | |
| EMAIL: info@hyarch.net WEB: www.hyarch.net | | | |
| CLIENT | | | |
| MINISTRY OF HEALTH | | | |
| PROJECT | | | |
| PROPOSED 2 STOREY EXTENSION OF SH.FUADHOO HOSPITAL | | | |
| SH.FUADHOO | | | |
| REPUBLIC OF MALDIVES | | | |
| STAGE | | | |
| SUBMISSION DRAWINGS | | | |
| CONTENTS | | | |
| FIRST FLOOR | | | |
| LIGHTING & FAN LAYOUT | | | |
| DESIGN | | | |
| YUS | | | |
| DRAWN | | | |
| YUS | | | |
| CHECKED | | | |
| RAZZAN | | | |
| PROJECT NO. | | DRAWING NO. | |
| 2016L-14/21 | | E-03 | |
| PROJECT DATE | | OF | |
| APRIL 2016 | | 04 | |


| ELECTRICAL LEGEND | |
|-------------------|--|
| | WALL SOCKET 13A (LOW LV) |
| | WALL SOCKET 13A (HIGH LV) |
| | WALL SOCKET 15A (HIGH LV) |
| | CEILING SOCKET 15A (HIGH LV) |
| | CABLE TV SOCKET |
| | TELEPHONE SOCKET |
| | TELEPHONE SOCKET FOR FACSIMILE MACHINE |
| | NETWORK SOCKET |
| | D-BOARD |
| | WEATHERPROOF |
| | AIR-CONDITIONING |
| | CCTV CAMERA (180°) |

NOTE:

THE DRAWINGS ARE SCHEMATIC.
DETAILED SYSTEMS DESIGN AND CONDUITING
SHALL BE DONE BY CONTRACTOR AND SUBMITTED
FOR APPROVAL BEFORE INSTALLATION.

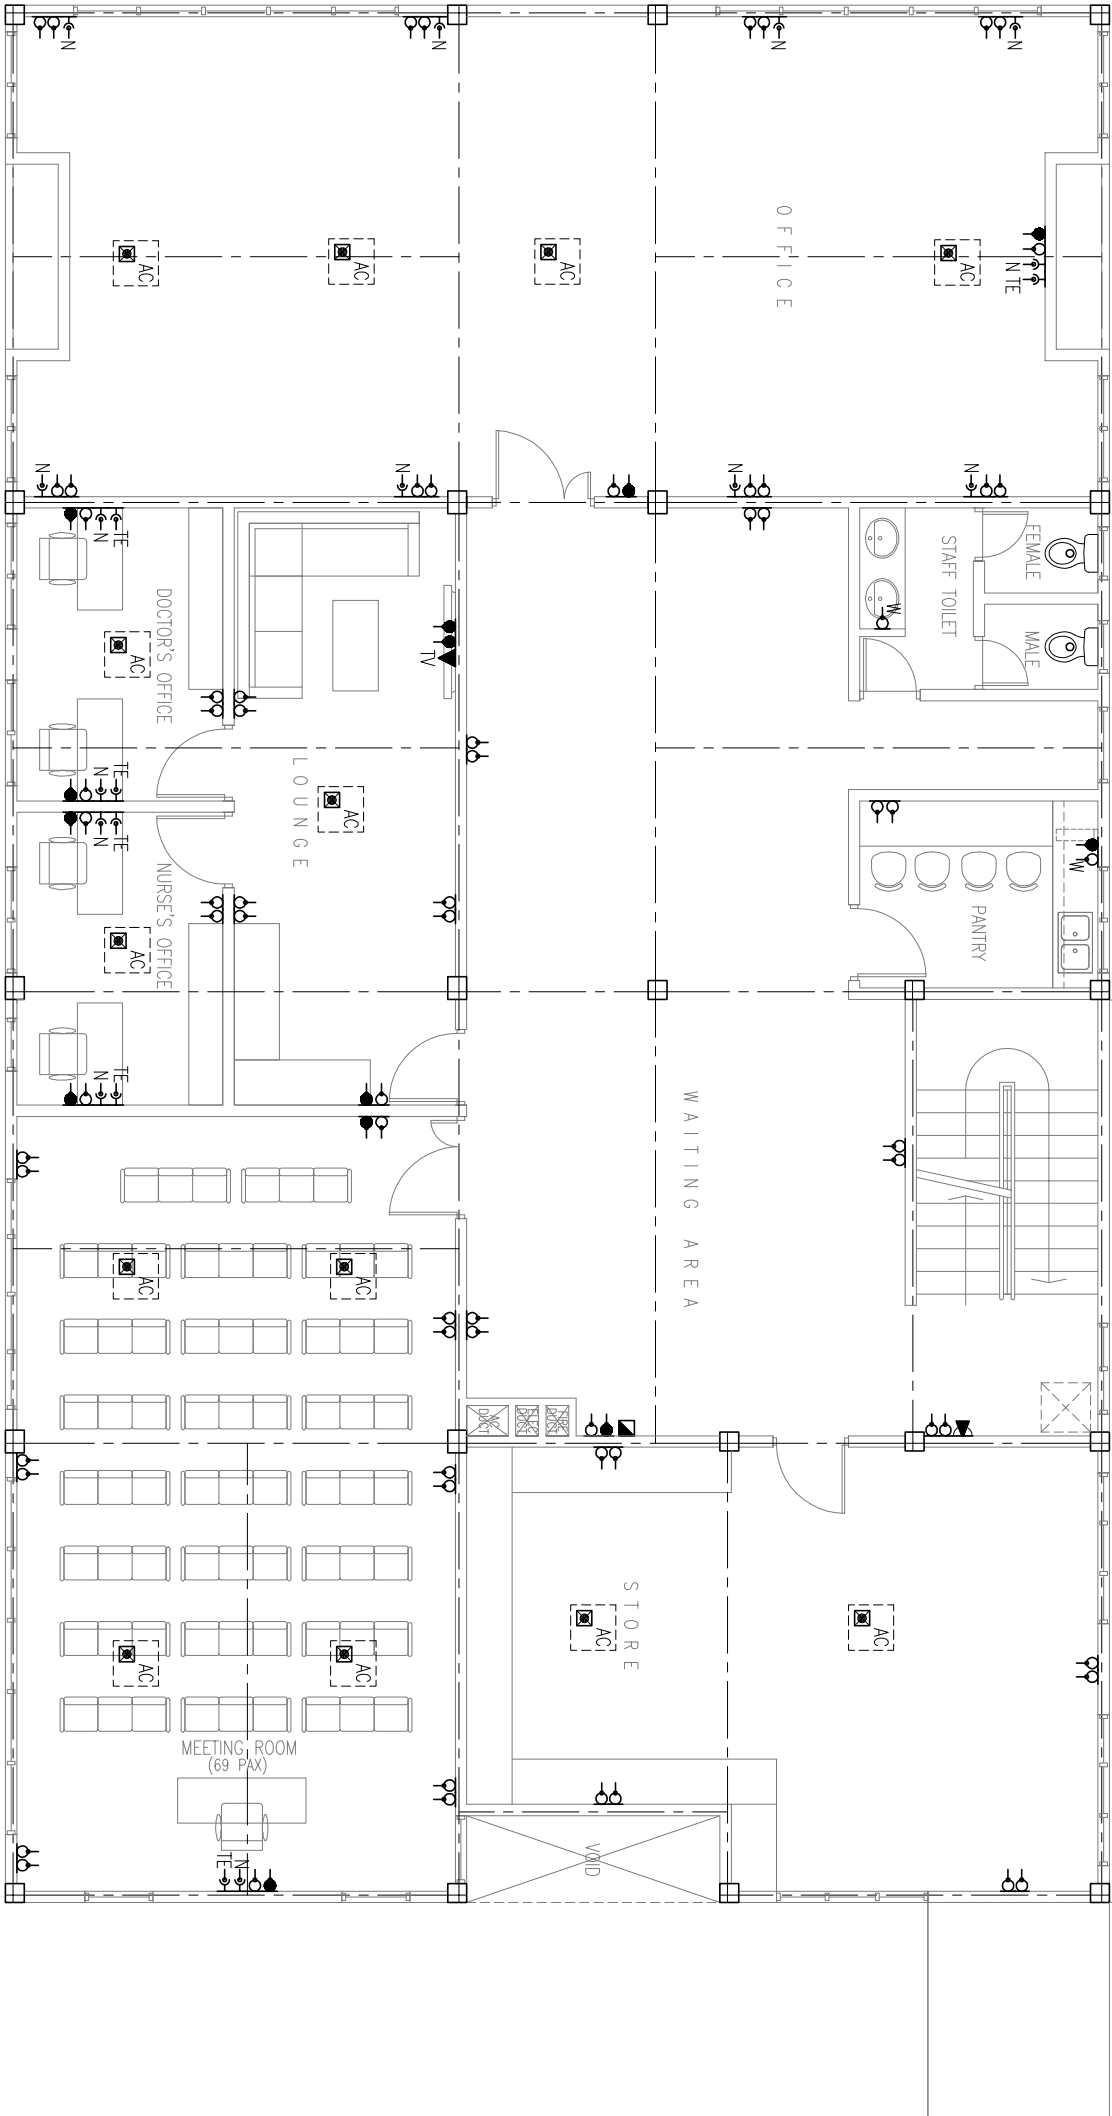

FIRST FLOOR POWER LAYOUT 1:100

 

1
E-04/04

| | | | |
|--|-------|-------------|--|
| NOTES | | | |
| ARCHITECT | | | |
| Hannan Yoosuf Architects | | | |
| MILANO (3 RD FLOOR) RAHDHEBAI MAGU | | | |
| MACHCHANGOLHI MALE 20159 MALDIVES | | | |
| TEL: (960) 331 8765 FAX: (960) 331 8763 | | | |
| EMAIL: info@hyarch.net WEB: www.hyarch.net | | | |
| CLIENT | | | |
| MINISTRY OF HEALTH | | | |
| PROJECT | | | |
| PROPOSED 2 STOREY EXTENSION OF SH.FUNDHOO HOSPITAL | | | |
| SH.FUNDHOO | | | |
| REPUBLIC OF MALDIVES | | | |
| STAGE | | | |
| SUBMISSION DRAWINGS | | | |
| CONTENTS | | | |
| FIRST FLOOR POWER LAYOUT | | | |
| DESIGN | | | |
| YUS | DRAWN | CHECKED | |
| YUS | YUS | RAZZAN | |
| PROJECT NO. | | DRAWING NO. | |
| 2016L-14/21 | | E-04 | |
| PROJECT DATE | | OF | |
| APRIL 2016 | | 04 | |