


**PROPOSED 2 STOREY HOSPITAL EXTENSION AT
SH.FUNADHOO
REPUBLIC OF MALDIVES**

PLUMBING DRAWINGS

CLIENT
MINISTRY OF HEALTH
MALE' REPUBLIC OF MALDIVES

APRIL 2016

ARCHITECT

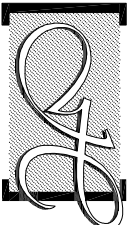


Hannan Yoosuf Architects

MILANO (3ST FLOOR) RAHDHEBAI MAGU

MACHCHANGOLHI MALE' 20159 MALDIVES

TEL: (960) 331 8765 FAX: (960) 331 8763

EMAIL: info@nyarch.net WEB: www.nyarch.net

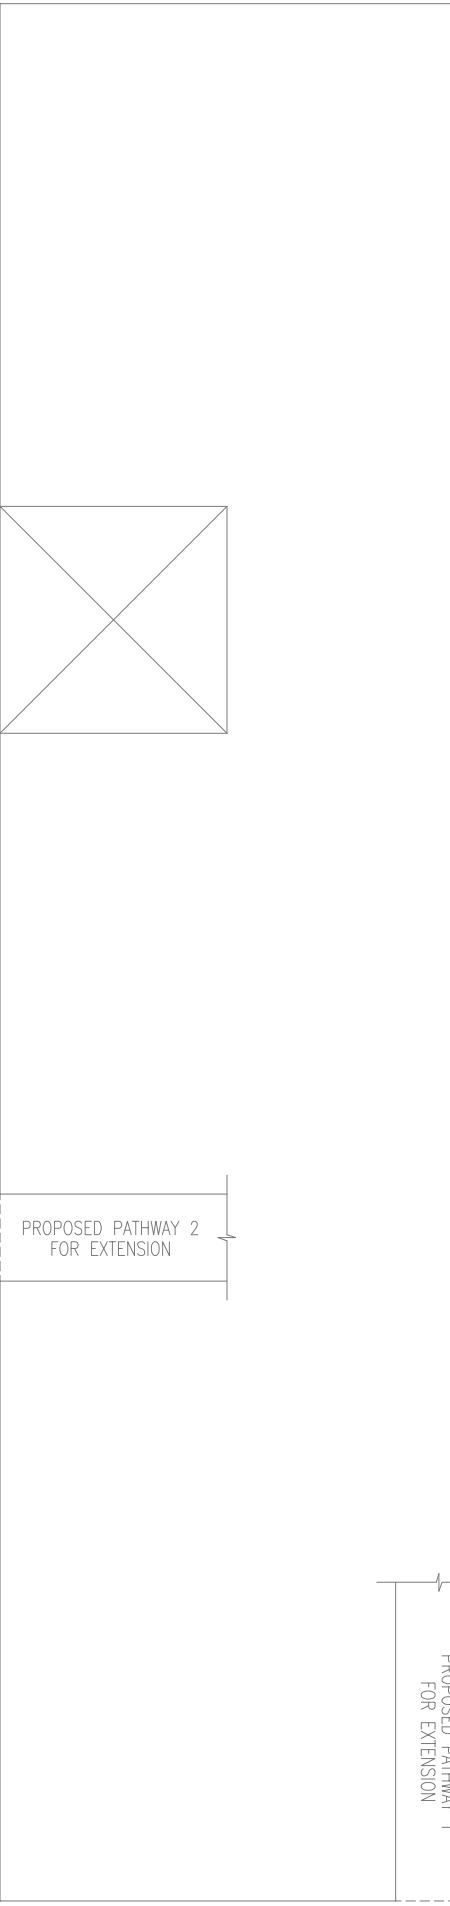




LEGEND

FAUCET/TAP

FRESH-WATER LINE

DOWN PIPE FROM TERRACE

  VALVE

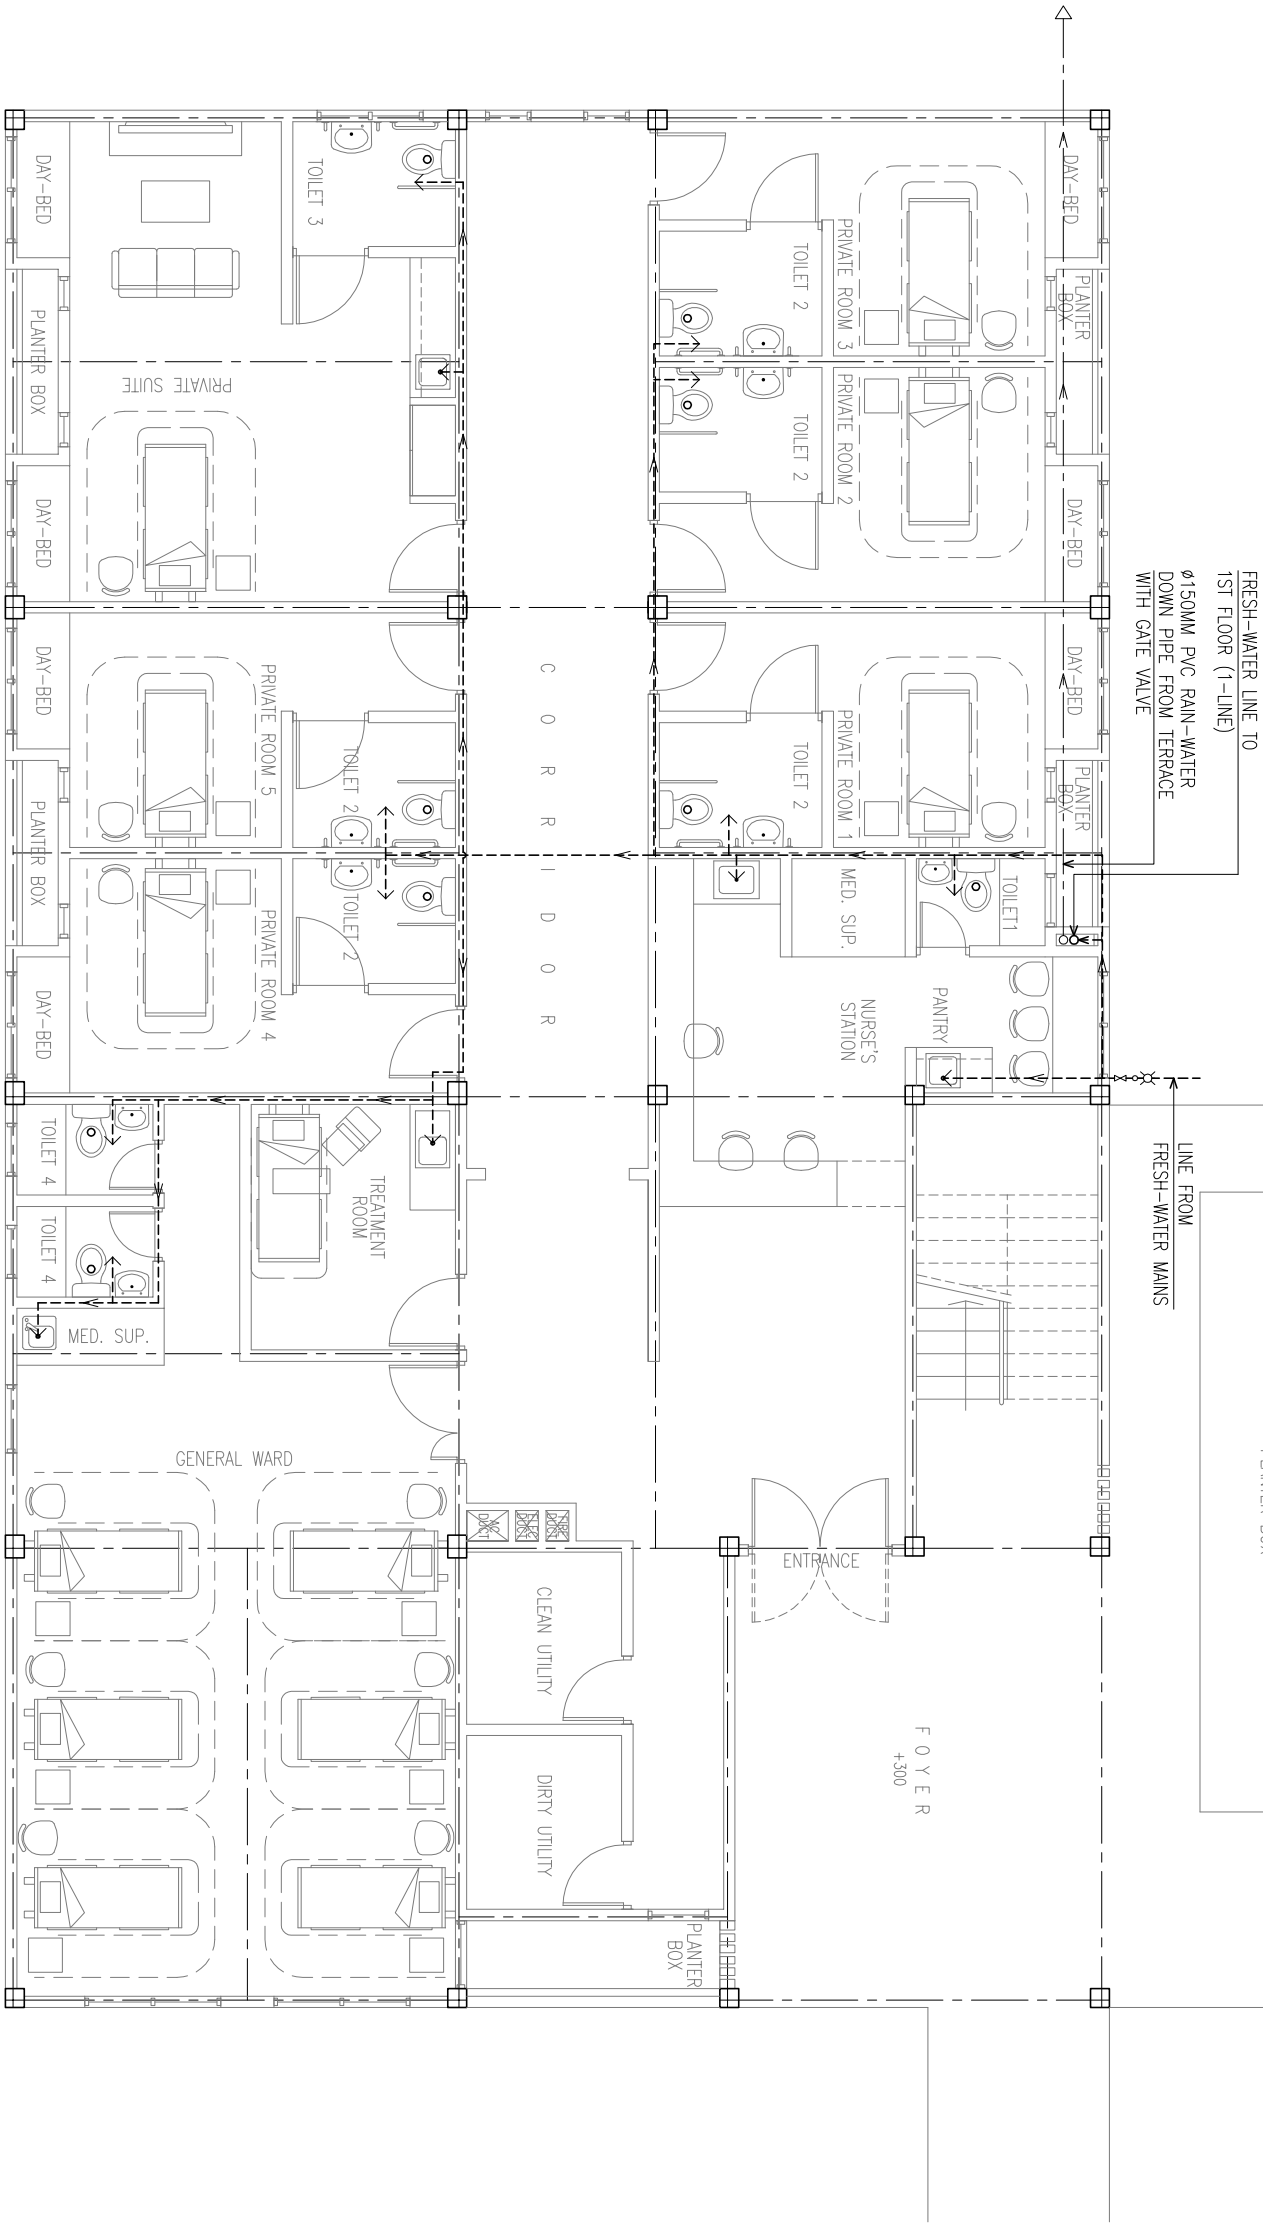

GROUND FLOOR
WATER SUPPLY LAYOUT 1:100

NOTE: DETAILED PLUMBING SYSTEM TO BE DESIGNED BY THE CONTRACTOR

NOTES

ARCHITECT

Hannan Yoosuf Architects
MILANO (3RD FLOOR) RAHDHEBAI MAGU
MACHCHANGOLHI MALE 20159 MALDIVES
TEL: (960) 331 8765 FAX: (960) 331 8763
EMAIL: info@hyarch.net WEB: www.hyarch.net

CLIENT

MINISTRY OF HEALTH

PROJECT

PROPOSED 2 STOREY EXTENSION OF
SH.FUMADHOO HOSPITAL

SH.FUMADHOO
REPUBLIC OF MALDIVES

STAGE

SUBMISSION DRAWINGS

CONTENTS

GROUND FLOOR
WATER SUPPLY LAYOUT

DESIGN
YUS

DRAWN
YUS

CHECKED
RAZZAN


PROJECT NO.
2016L-14/21

DRAWING NO.
P-01

PROJECT DATE
APRIL 2016

OF
08

COPYRIGHT, THE CONCEPT AND DESIGN IN THIS DRAWING ARE THE PROPERTIES OF HANNAH YOOUSUF ARCHITECTS PVT LTD. UNAUTHORISED USE OF ANY KIND OR COPYING OF WHOLE OR PART OF THIS DRAWING, CONCEPT OR DESIGN OR USE ON PROJECTS OR SITES OTHER THAN SPECIFIED ON THIS DRAWING IS PROHIBITED

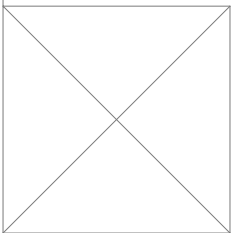


PROPOSED PATHWAY 1
FOR EXTENSION

PROPOSED PATHWAY 2
FOR EXTENSION

PLANTER BOX

WASTE WATER
DISCHARGE STACK
FROM ABOVE FLOORS


SEWAGE
DISCHARGE STACK
FROM ABOVE FLOORS

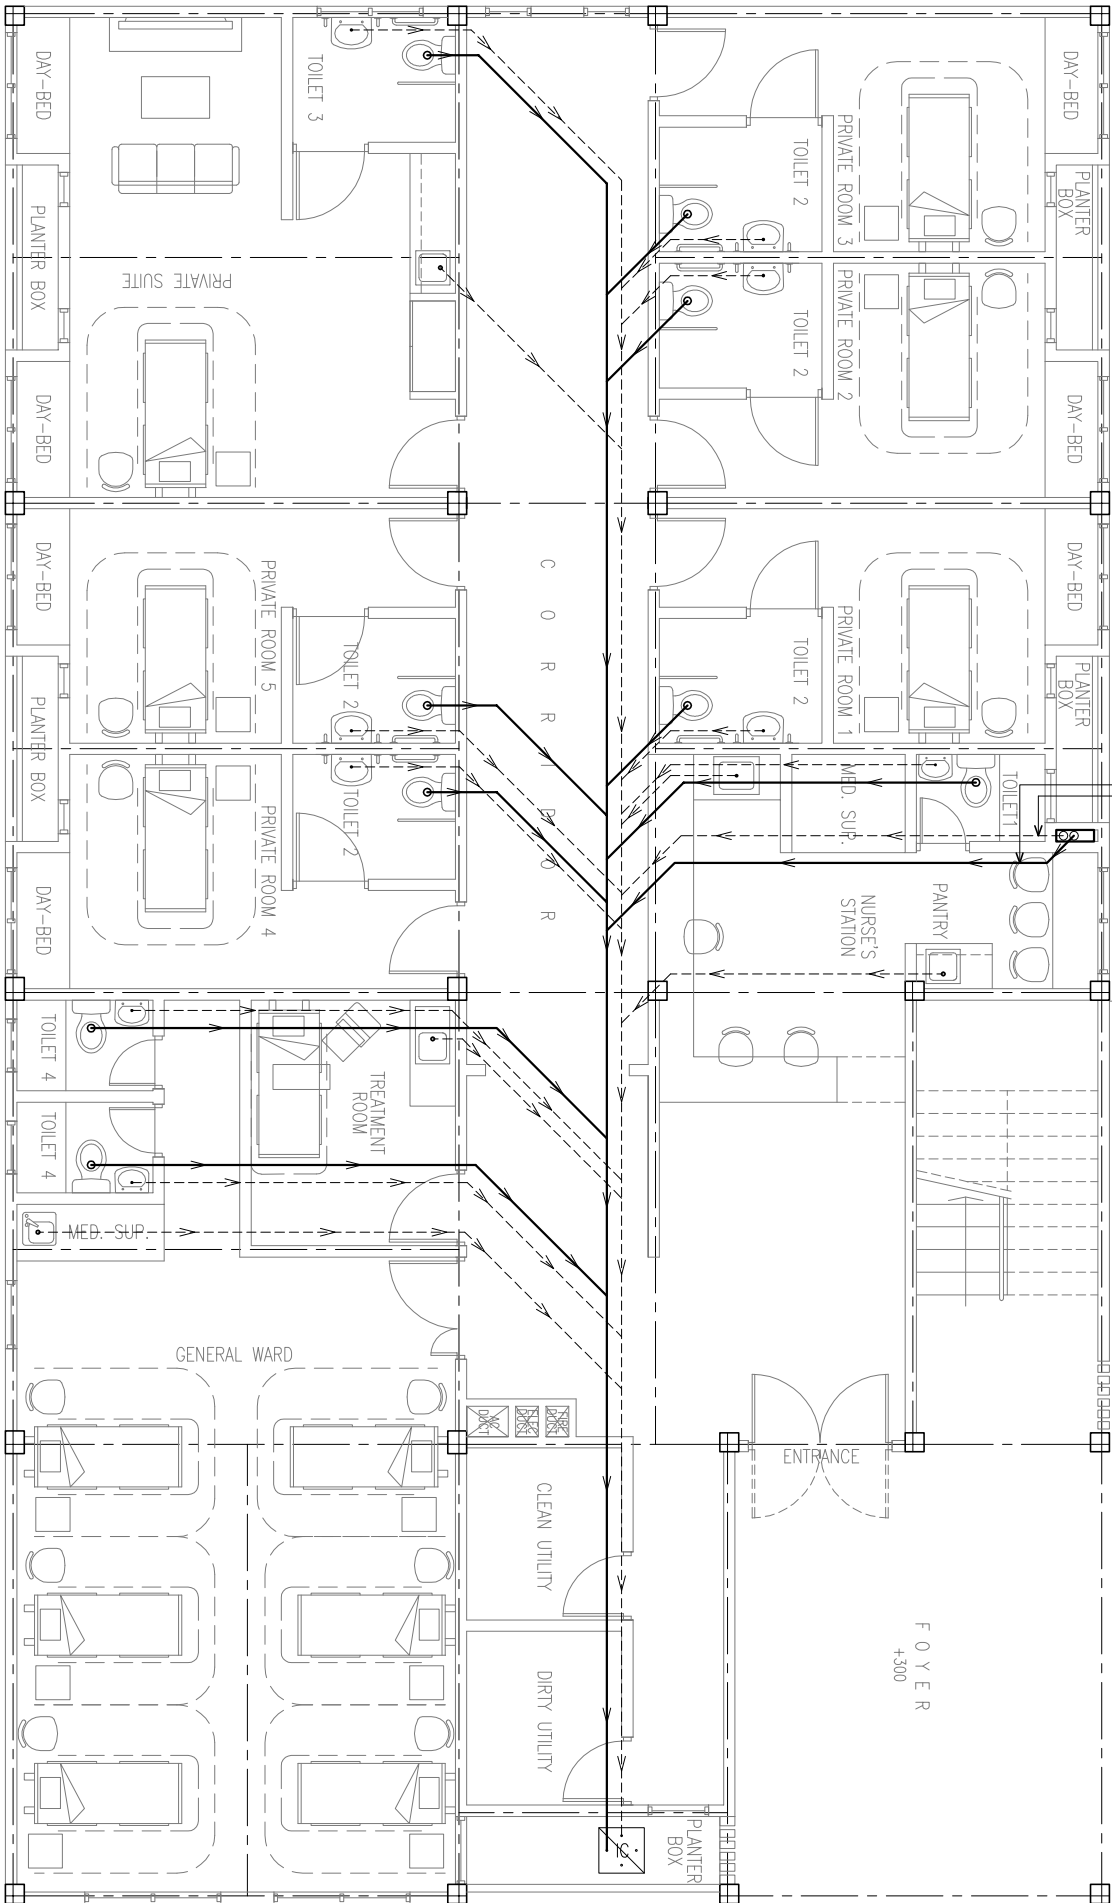

NORTH

GROUND FLOOR WASTE WATER/SEWAGE DISPOSAL 1:100

 NOTE: DETAILED PLUMBING SYSTEM TO BE DESIGNED BY THE CONTRACTOR



1

E-02/08

LEGEND



INSPECTION CHAMBER

SEWAGE DISPOSAL PIPE

GREY WATER LINE

NOTES

ARCHITECT



Hannan Yoosuf Architects
MIL AND (3RD FLOOR) RAHDEHBAI MAGU
MAGCHANGOLHI MALE 20159 MALDIVES
TEL: (960) 331 8765 FAX: (960) 331 8763
EMAIL: info@hyarch.net WEB: www.hyarch.net

CLIENT
MINISTRY OF HEALTH

PROJECT
**PROPOSED 2 STOREY EXTENSION OF
SH. FUMADHOO HOSPITAL**

SHE FUMADHOO
REPUBLIC OF MALDIVES
STAGE
SUBMISSION DRAWINGS

 
CONTENTS
GROUND FLOOR
WASTE WATER/SEWAGE DISPOSAL

DESIGN
YUS
DRAWN
YUS
CHECKED
RAZZAN


PROJECT NO.
2016/L-14/21
PROJECT DATE
APRIL 2016

DRAWING NO.
P-02
OF
08

COPYRIGHT, THE CONCEPT AND DESIGN IN THIS DRAWING ARE THE PROPERTIES OF HANNAH YOOUSUF ARCHITECTS PVT LTD. UNAUTHORISED USE OF ANY KIND OR COPYING OF WHOLE OR PART OF THIS DRAWING, CONCEPT OR DESIGN OR USE ON PROJECTS OR SITES OTHER THAN SPECIFIED ON THIS DRAWING IS PROHIBITED






LEGEND



INSPECTION CHAMBER

SEWAGE DISPOSAL PIPE

  GREY WATER LINE

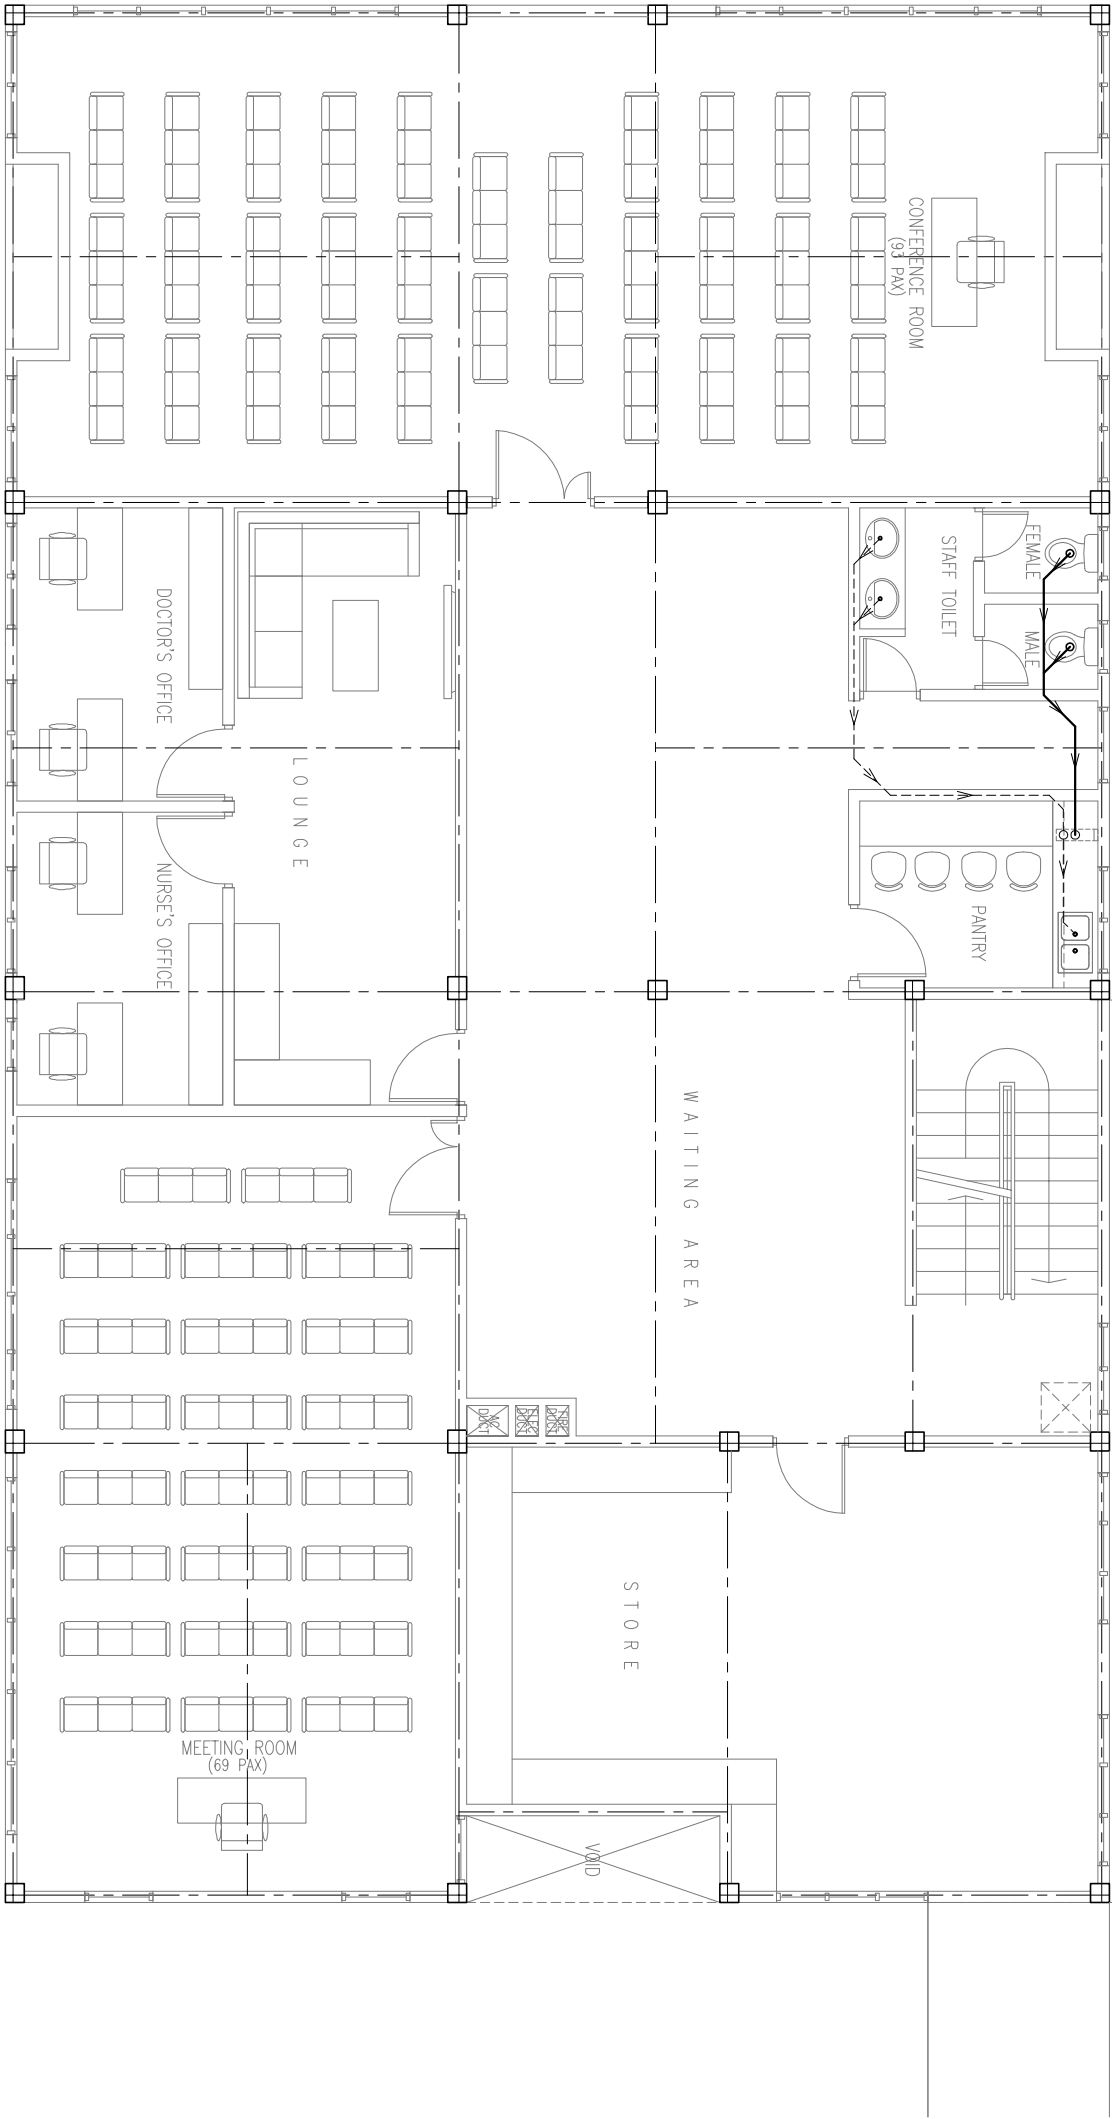

FIRST FLOOR
WATER SUPPLY LAYOUT 1:100

NOTES

ARCHITECT



Hannan Yoosuf Architects

MILANO (3RD FLOOR) RAHDHEBAI MAGU
MACHCHANGOLHI MALE 20159 MALDIVES
TEL: (960) 331 8765 FAX: (960) 331 8763
EMAIL: info@hyarch.net WEB: www.hyarch.net

CLIENT

MINISTRY OF HEALTH

PROJECT

PROPOSED 2 STOREY EXTENSION OF
SH.FUJADHOO HOSPITAL

SH.FUJADHOO
REPUBLIC OF MALDIVES

STAGE

SUBMISSION DRAWINGS

CONTENTS

FIRST FLOOR
WATER SUPPLY LAYOUT

DESIGN
YUS

DRAWN
YUS

CHECKED
RAZZAN

 

PROJECT NO.
2016L-14/21

DRAWING NO.
P-03

PROJECT DATE
APRIL 2016



OF
08

COPYRIGHT, THE CONCEPT AND DESIGN IN THIS DRAWING ARE THE PROPERTIES OF HANNAH YOOUSUF ARCHITECTS PVT LTD. UNAUTHORISED USE OF ANY KIND OR COPYING OF WHOLE OR PART OF THIS DRAWING, CONCEPT OR DESIGN OR USE ON PROJECTS OR SITES OTHER THAN SPECIFIED ON THIS DRAWING IS PROHIBITED

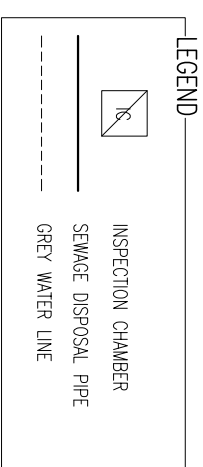


NOTE: DETAILED PLUMBING SYSTEM TO BE DESIGNED BY THE CONTRACTOR

[illegible]

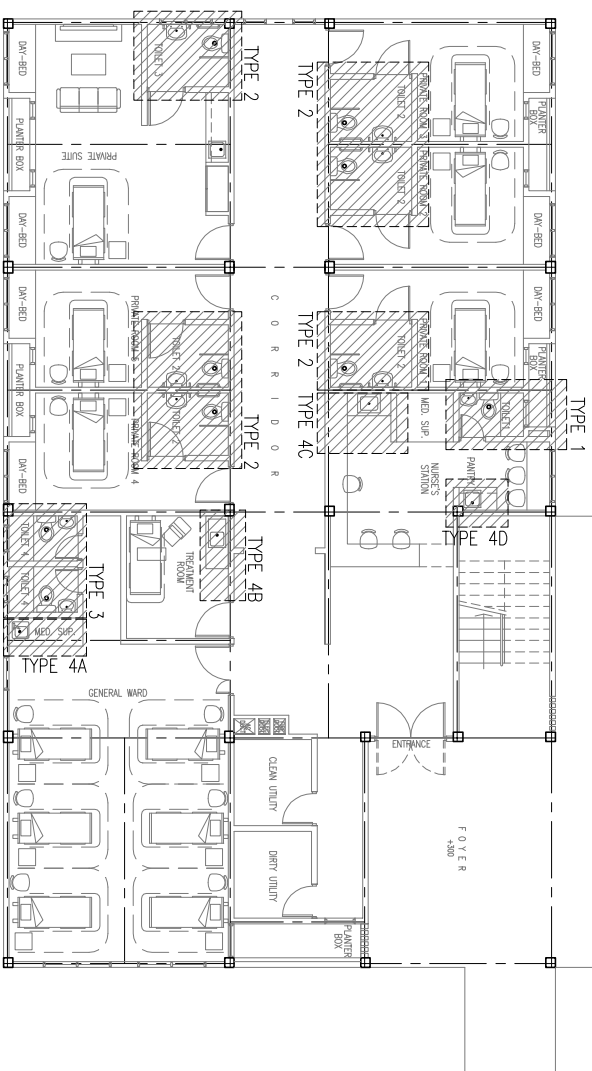
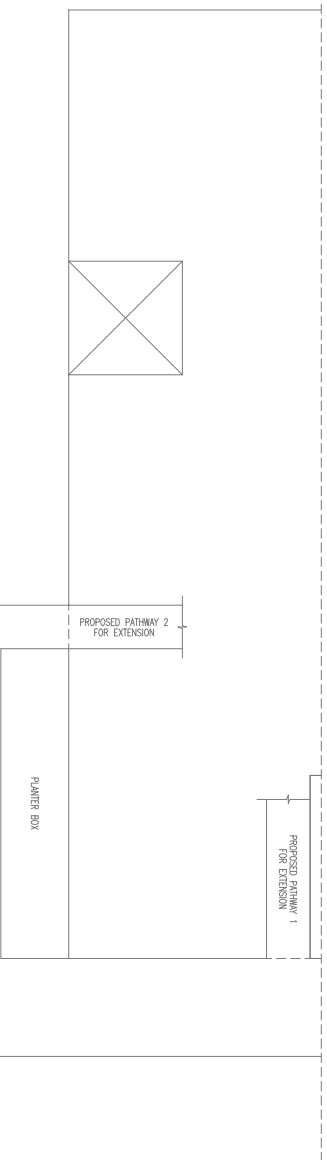



GROUND FLOOR PLAN

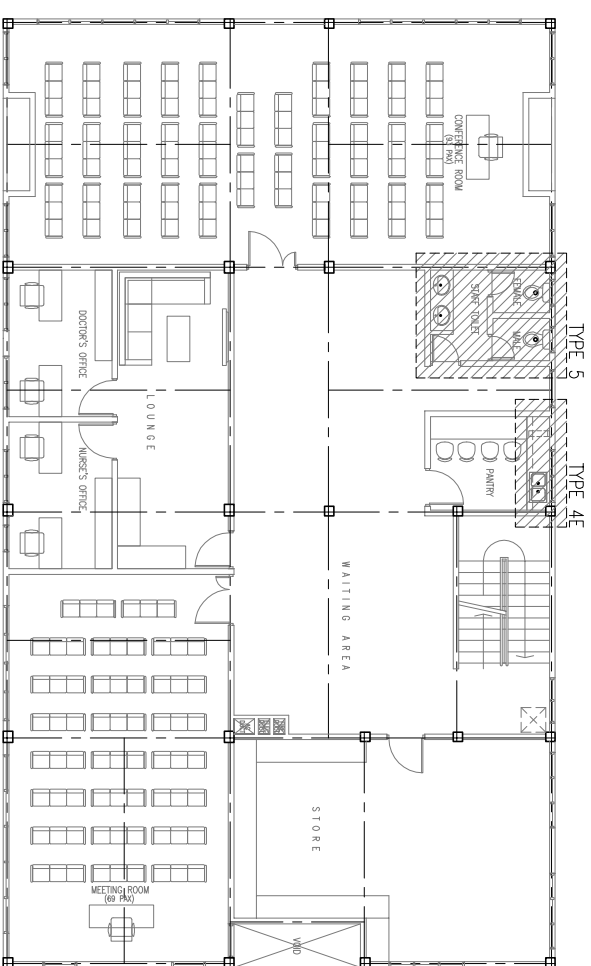


FIRST FLOOR PLAN

PLUMBING KEY PLANS

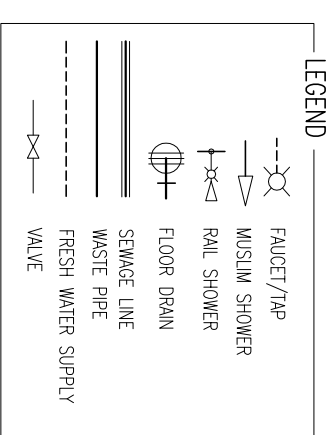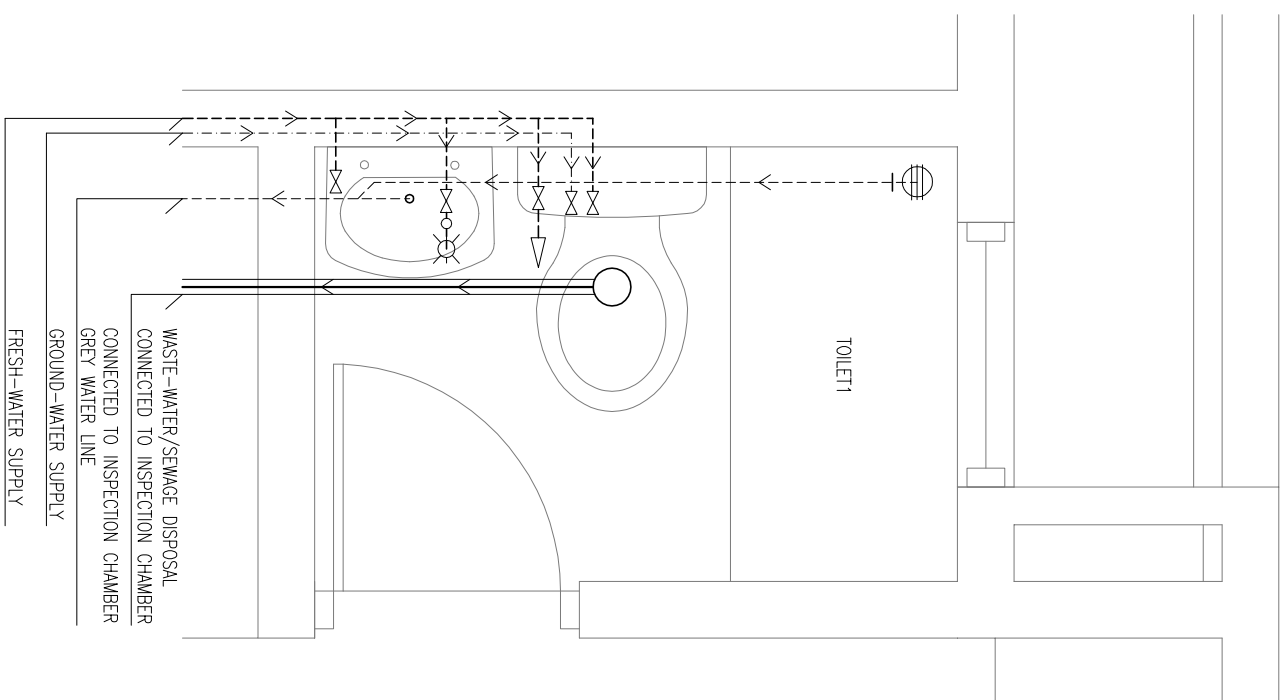
[illegible]

			
Hannan Yousuf Architects			
MILLANO (3 RD FLOOR) RAHDE BAL MARGAL MACHCHANGOLHI MALTE 20159 MALDIVES			
TEL: (960) 331 8765		FAX: (960) 331 8765	
EMAIL: info@yarch.net		WEB: www.lyarch.net	
CLIENT MINISTRY OF HEALTH			
PROJECT PROPOSED 2 STOREY EXTENSION O SH.FUNADHOO HOSPITAL			
SH.FUNADHOO REPUBLIC OF MALDIVES			
STAGE SUBMISSION DRAWINGS			
CONTENTS PLUMBING KEY PLANS DETAIL PLUMBING LAYOUTS TYPE 1 (TOILET 1,GROUND FLR)			
DESIGN YUS	DRAWN YUS	CHECKED RAZZAN	
PROJECT NO. 2016/L-14/21		DRAWING NO. P-05	
PROJECT DATE APRIL 2016		OF 08	

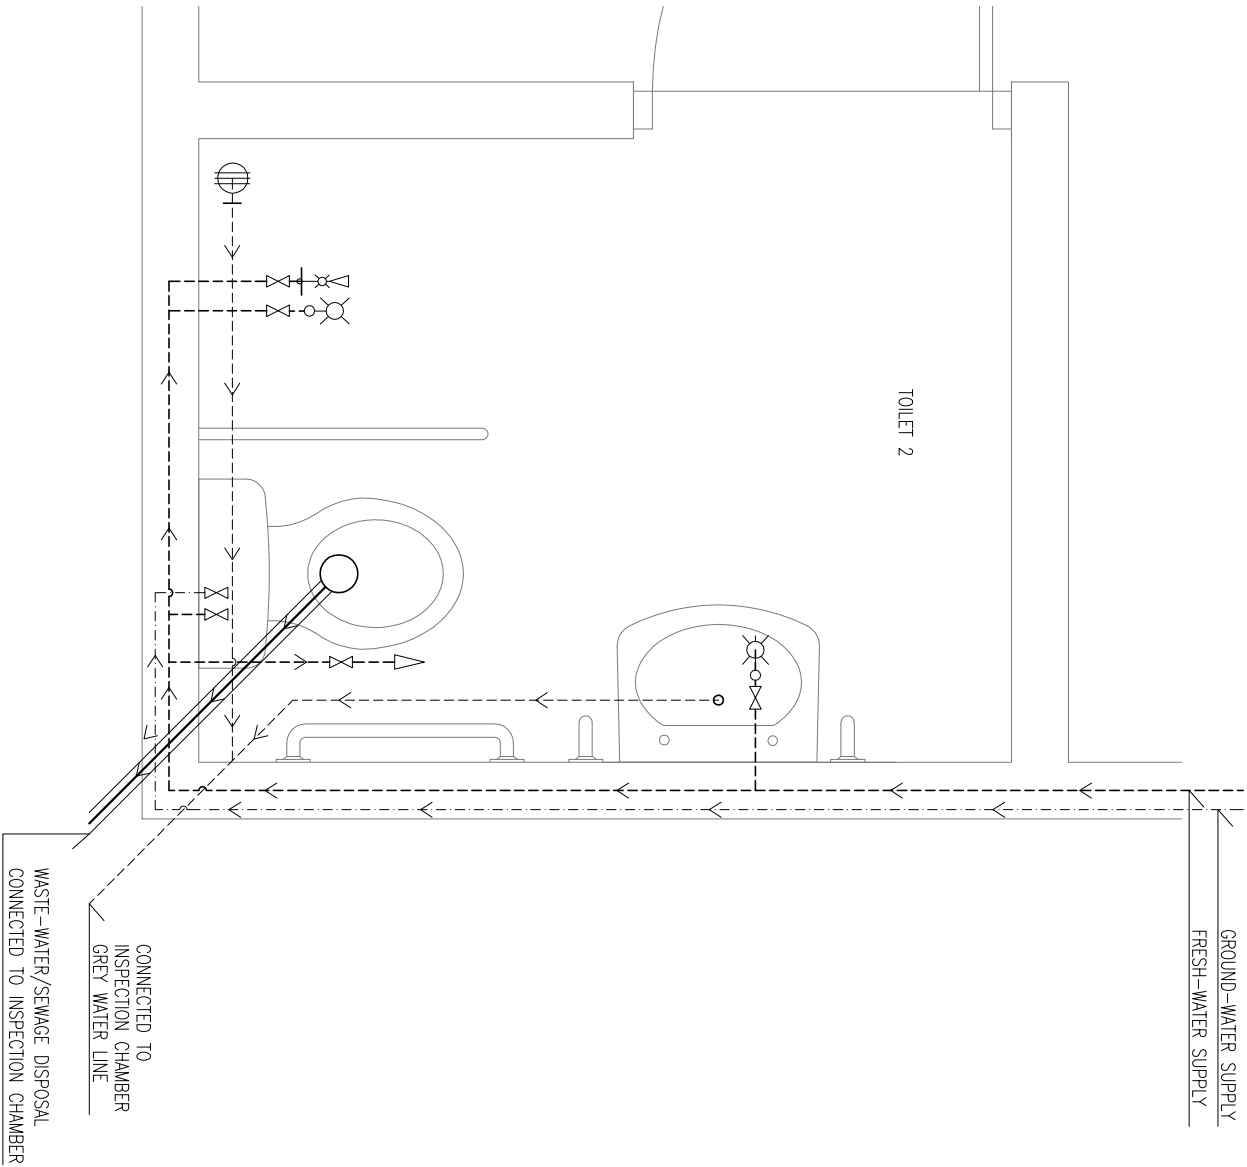


TYPE 2 (TOILET 2 & 3,GROUND FLR)
DETAIL PLUMBING LAYOUTS 2 1: 20


1
P-06/08
NOTE: DETAILED PLUMBING SYSTEM TO BE DESIGNED BY THE CONTRACTOR

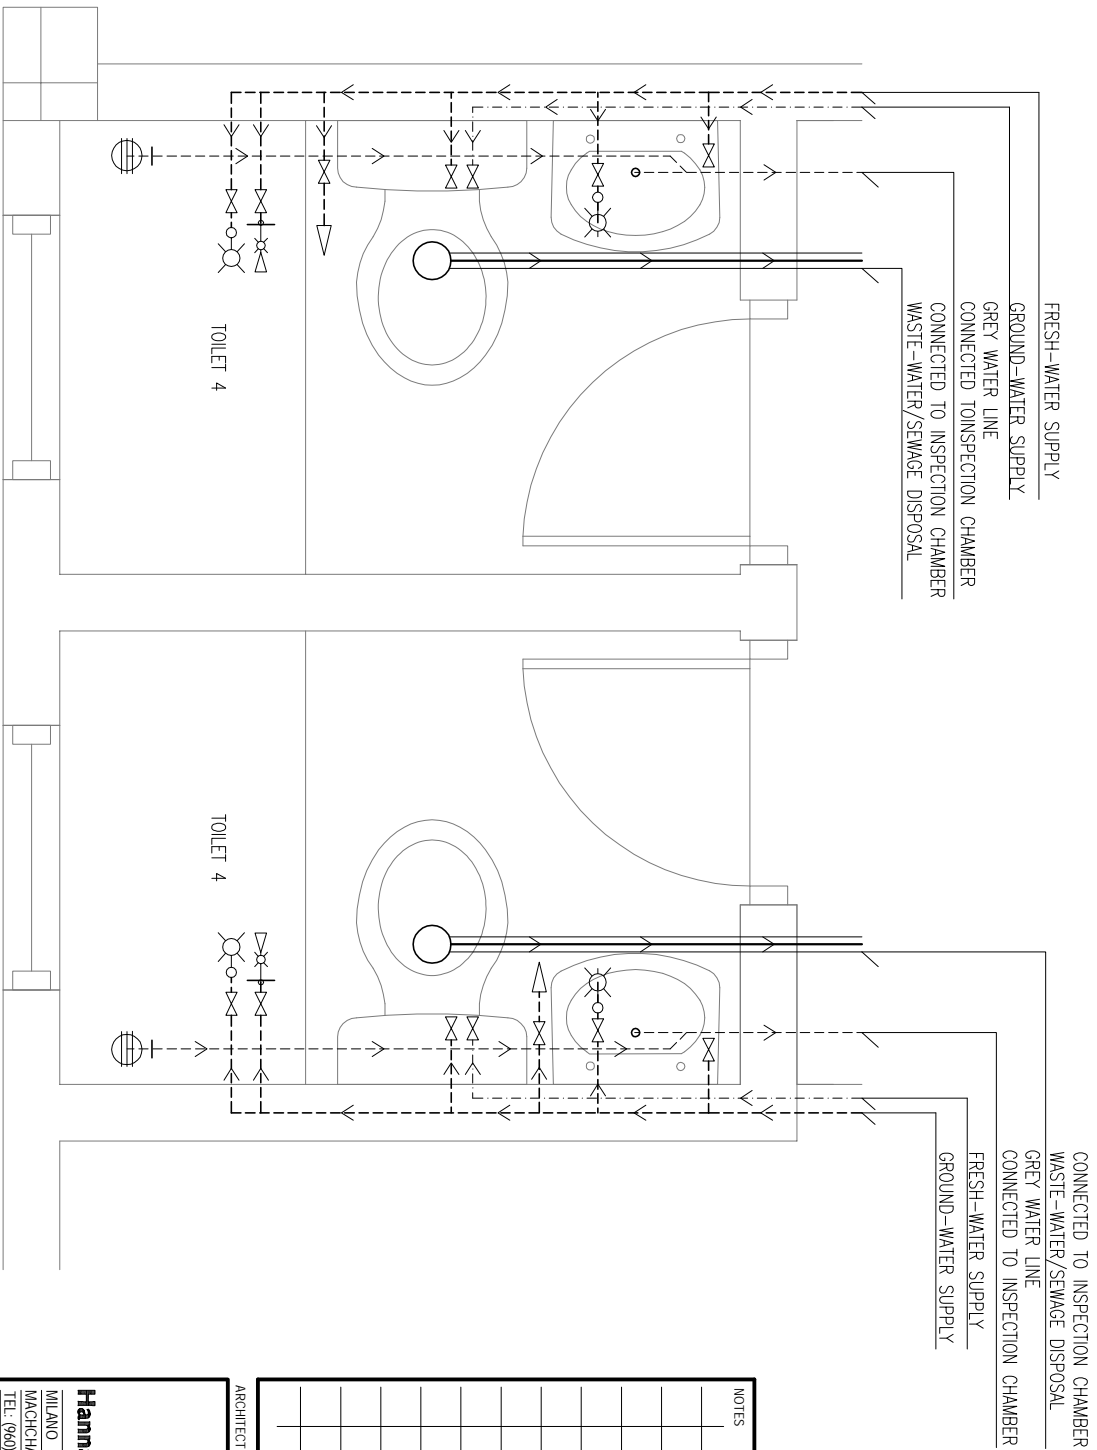


TYPE 3 (TOILET 4,GROUND FLR)
DETAIL PLUMBING LAYOUTS 3 1: 20

2
P-06/08
NOTE: DETAILED PLUMBING SYSTEM TO BE DESIGNED BY THE CONTRACTOR

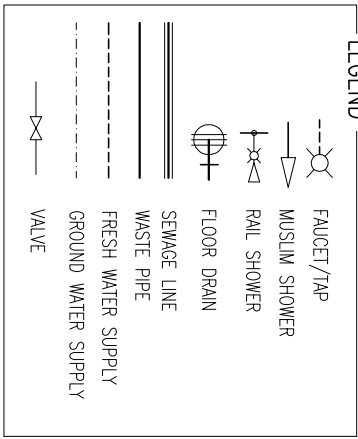


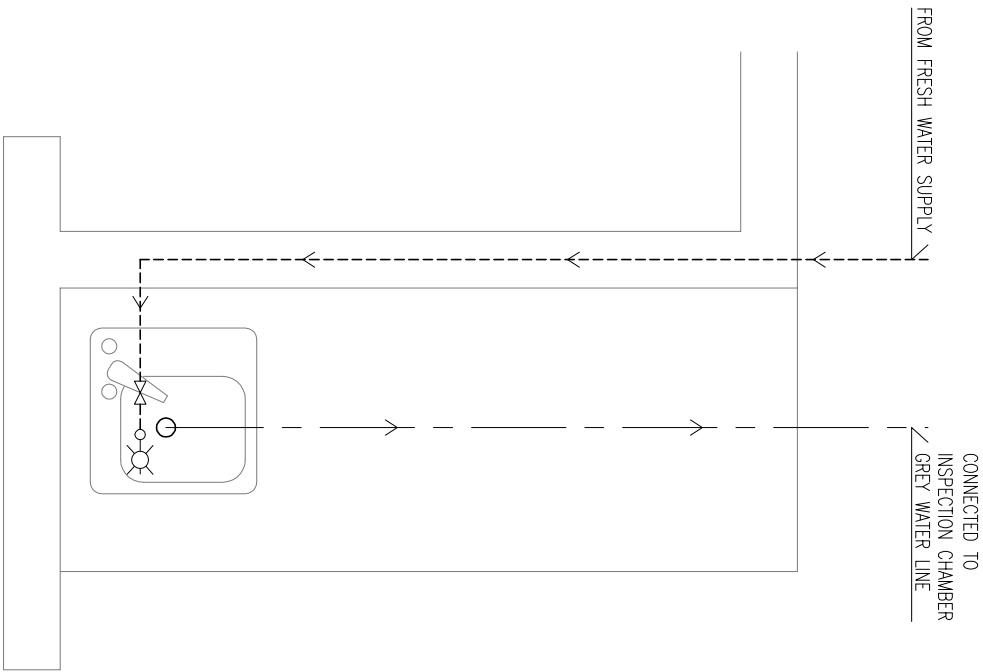


TYPE 4A (GENERAL WARD,GROUND FLR)

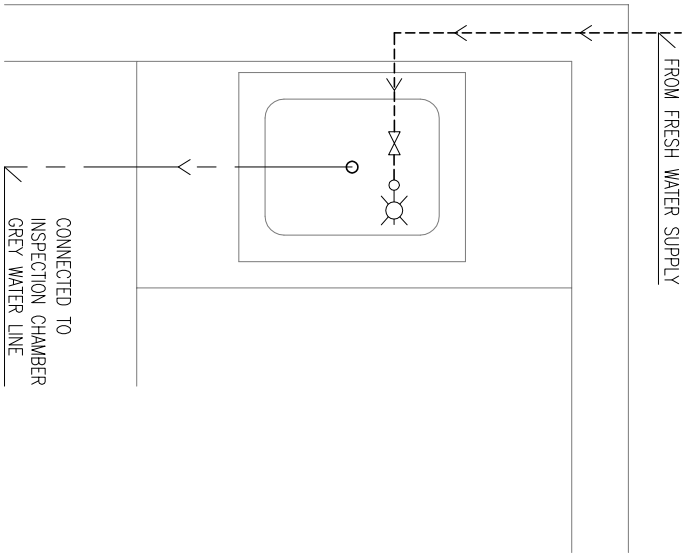


TYPE 4C (NURSE'S STATION, GROUND FLR)

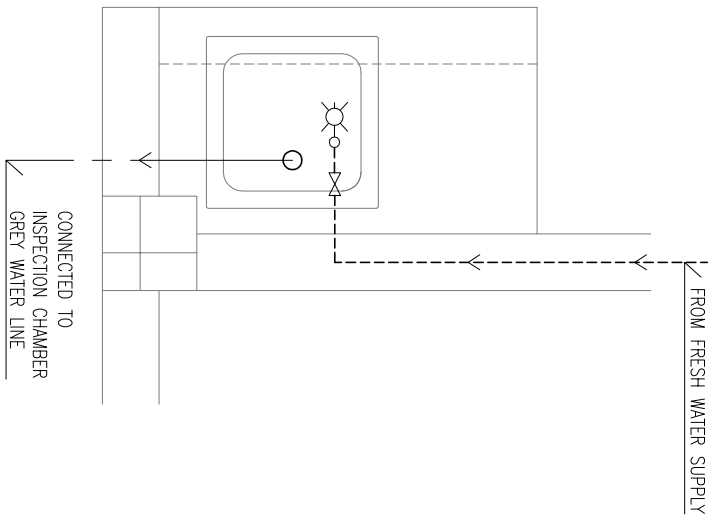


TYPE 4D (PANTRY, GROUND FLR)

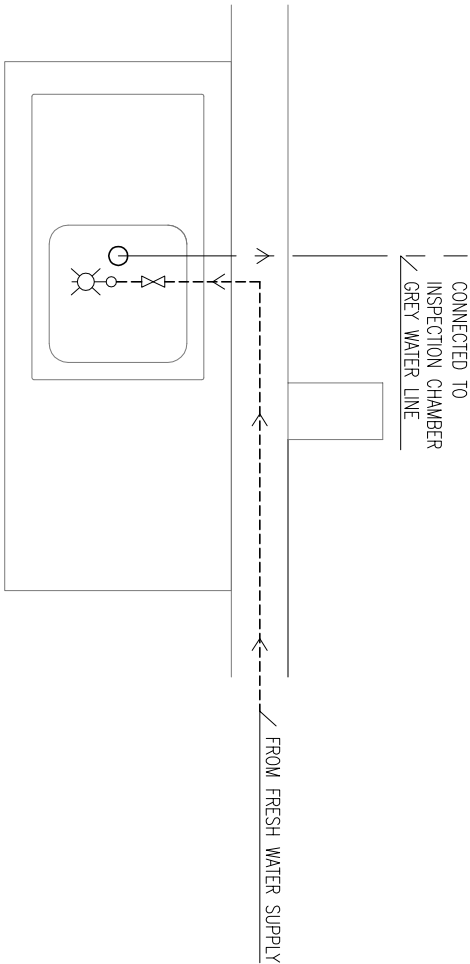

TYPE 4B (TRITMNT ROOM, GROUND FLR)

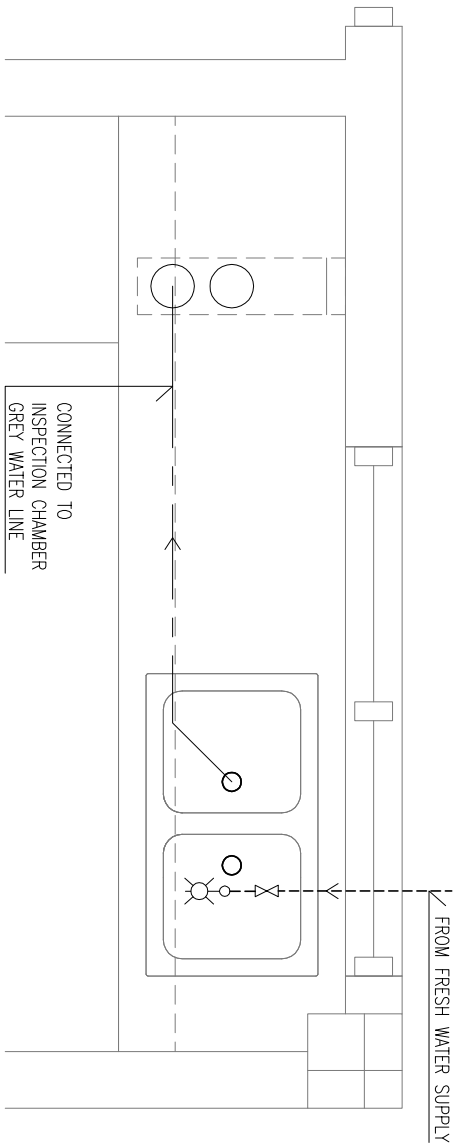

TYPE 4E (PANTRY, FIRST FLR)

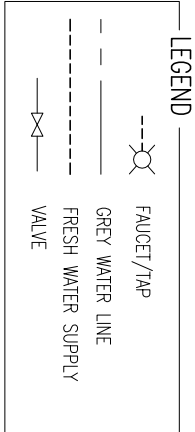

NOTES

ARCHITECT

Hannan Yoosuf Architects

MILANO (3RD FLOOR) RAHDHEBAI MAGU
MAGHC-HANGOLHI MALE 20159 MALDIVES
TEL: (960) 331 8765 FAX: (960) 331 8763
EMAIL: info@hyarch.net WEB: www.hyarch.net

CLIENT
MINISTRY OF HEALTH

PROJECT
PROPOSED 2 STOREY EXTENSION OF SH.FUMADHOO HOSPITAL
SH.FUMADHOO
REPUBLIC OF MALDIVES
STAGE
SUBMISSION DRAWINGS

CONTENTS
DETAIL PLUMBING LAYOUTS 4
TYPE 4A - 4E



DESIGN	DRAWN	CHECKED
YUS	YUS	RAZZAN

PROJECT NO.	DRAWING NO.
2016L-1421	P-07
PROJECT DATE	OF
APRIL 2016	08

DETAIL PLUMBING LAYOUTS 4 1: 20

NOTE: DETAILED PLUMBING SYSTEM TO BE DESIGNED BY THE CONTRACTOR

COPYRIGHT, THE CONCEPT AND DESIGN IN THIS DRAWING ARE THE PROPERTIES OF HANNAH YOOSUF ARCHITECTS PVT.LTD. UNAUTHORISED USE OF ANY KIND OR COPYING OF WHOLE OR PART OF THIS DRAWING, CONCEPT OR DESIGN OR USE ON PROJECTS OR SITES OTHER THAN SPECIFIED ON THIS DRAWING IS PROHIBITED

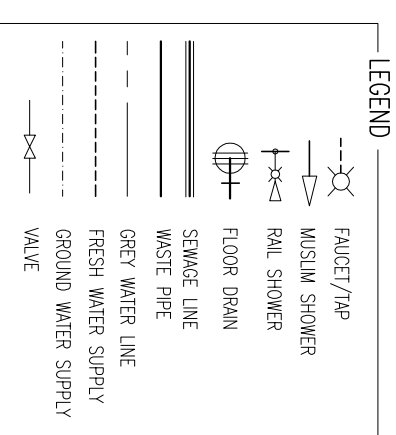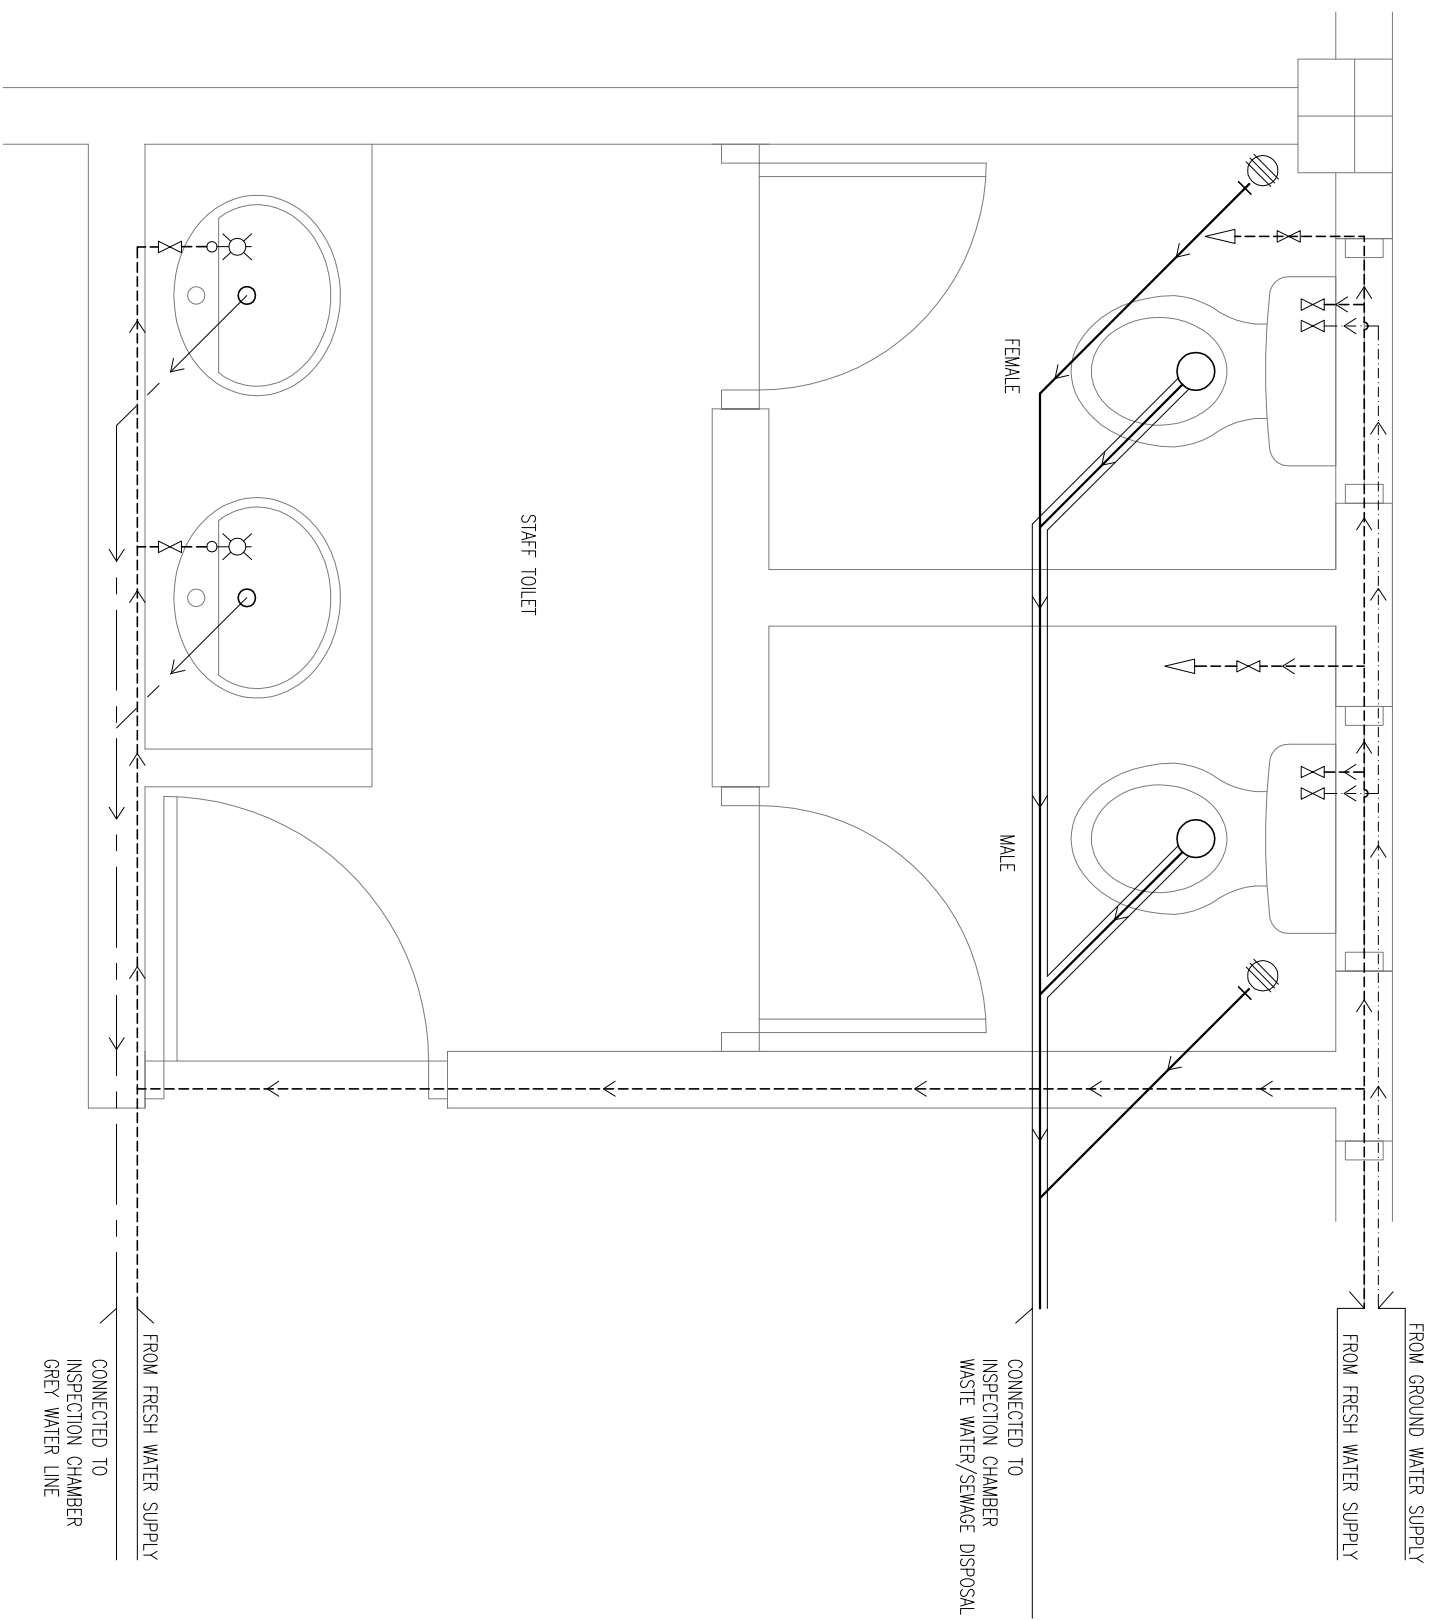[illegible]