

9 STOREY ACCOMMODATION BUILDING

BANDAAARA KOSHI / MALE

SHEET CONTENT:

DESIGN APPROVAL:

BRIG. GEN. AHMED SHAHID

VICE CHIEF OF DEFENCE FORCE

RECOM. APPROVAL:

CPT. AHMED SHARIM

OFFICER COMMANDING

APPROVED:

MAJ. GEN. AHMED SHIYAM

CHIEF OF DEFENCE FORCE

APPROVED DATE:

DESIGNED:

L.CPT. AUI MUTHASIM

PTE. M. SAIF ABDULLA

Architectural

WO1. AHMED SHAZEEL

Structural

CHECKED:

CPT. MOHAMED SHIFA'AU

Architectural

WO3. AMINATH AUI

Structural

Electrical & Mechanical

Communication

DRAWN:

REVISION:

L.CPT. AUI MUTHASIM

PTE. M. SAIF ABDULLA

DATE:

PTE. HUSSAIN GASIM

PTE. YAMIN SAEED

DATE:

07 AUGUST 2015

11 SEPTEMBER 2016

SCALE:

SHEET NO:


1:200

-




NATIONAL ENGINEERS  
MALDIVES NATIONAL DEFENCE FORCE  
Male, Republic of Maldives

The drawings, concept and design contained are the properties of Military Engineers MNDFF. Use of any kind or copy of whole or part of this drawing, concept or design or use on other projects or sites other than that specified on this drawing is strictly prohibited.

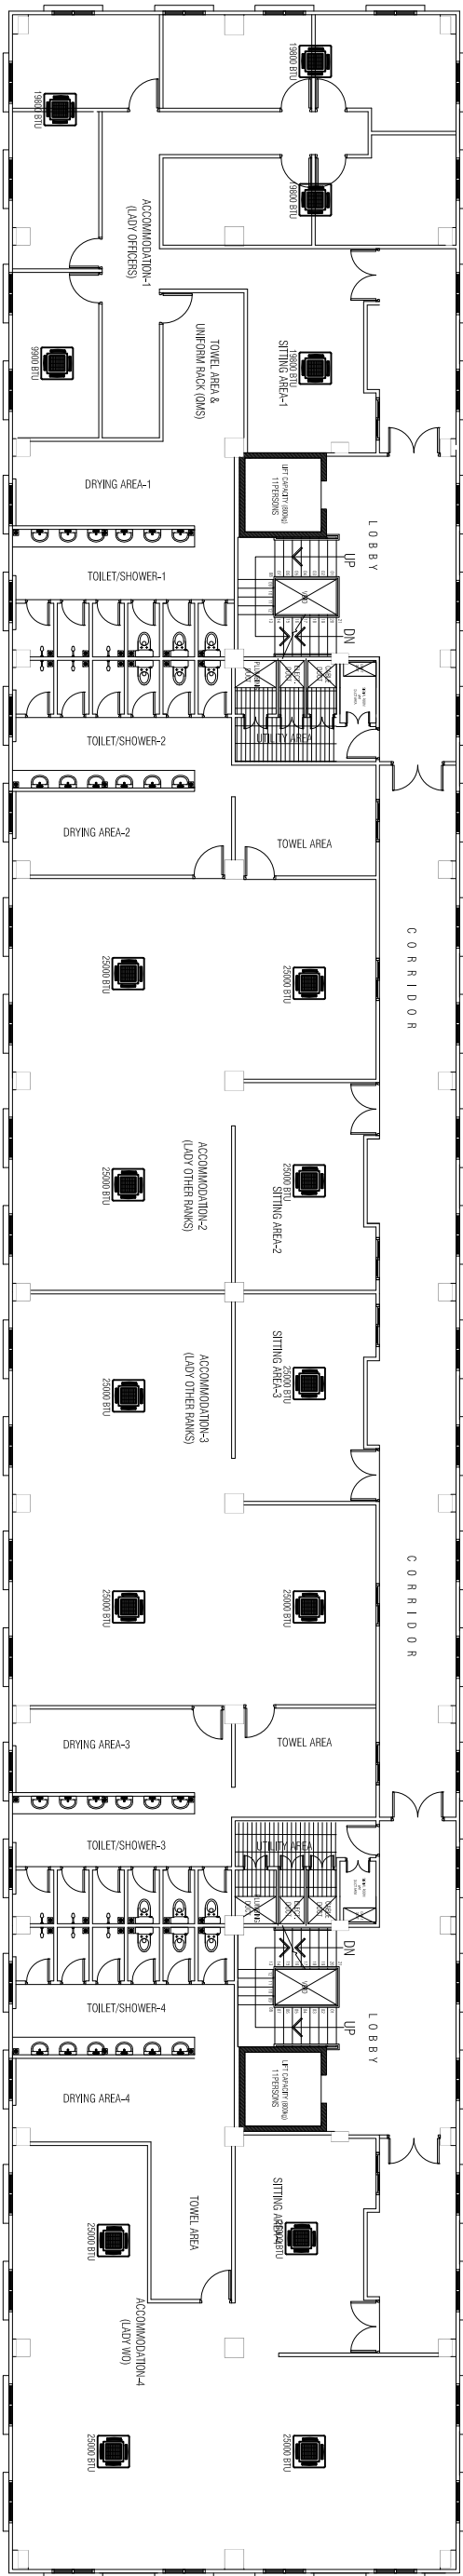

SECOND FLOOR PLAN

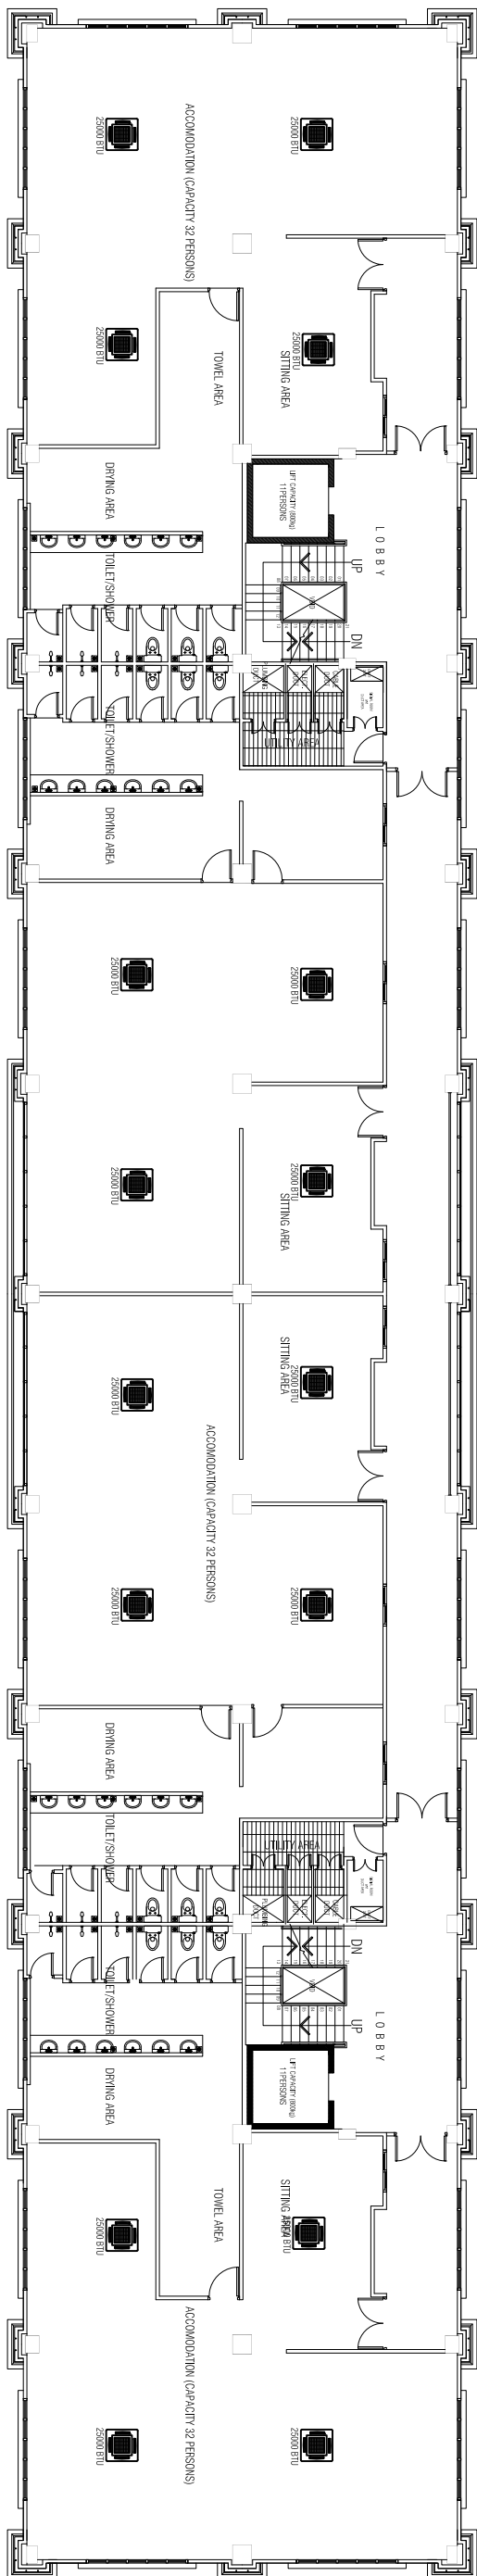

THIRD FLOOR PLAN

LEGEND:

SYMBOL	QUANTITY	DESCRIPTION
	2ND 3RD	
	12	CASSETTE TYPE AC UNIT (25000 BTU)
	04	CASSETTE TYPE AC UNIT (25000 BTU)
	01	CASSETTE TYPE AC UNIT (9000 BTU)

9 STOREY ACCOMMODATION BUILDING

BANDAAARA KOSHI / MALE

SHEET CONTENT:

DESIGN APPROVAL:

**BRIG. GEN. AHMED SHAHID**  
VICE CHIEF OF DEFENCE FORCE

RECOM. APPROVAL:

**CPT. AHMED SHARIM**  
OFFICER COMMANDING

APPROVED:

**MAJ. GEN. AHMED SHIYAM**  
CHIEF OF DEFENCE FORCE

APPROVED DATE:

DESIGNED:

**L.CPT. ALI MUTHASIM**  
**PTE. M. SAIF ABDULLA**  
Architectural

**WO1. AHMED SHAZEEL**  
Structural

CHECKED:

**CPT. MOHAMED SHIFA'AU**  
Architectural

**WO3. AMINATH ALI**  
Structural

Electrical & Mechanical

Communication

DRAWN:

REVISION:

**L.CPT. ALI MUTHASIM**  
**PTE. M. SAIF ABDULLA**  
DATE:

**PTE. HUSSAIN GASIM**  
**PTE. YAMIN SAEED**  
DATE:


**07 AUGUST 2015**  
**11 SEPTEMBER 2016**

SCALE:

SHEET NO.:


1:200

-

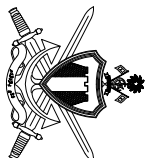


MALDIVES NATIONAL DEFENCE FORCE  
State, Republic of Maldives

The drawings, concept and design contained are the properties of Military Engineers MNDFF. Use of any kind or copy of whole or part of this drawing, concept or design or use on other projects or sites other than that specified on this drawing is strictly prohibited.

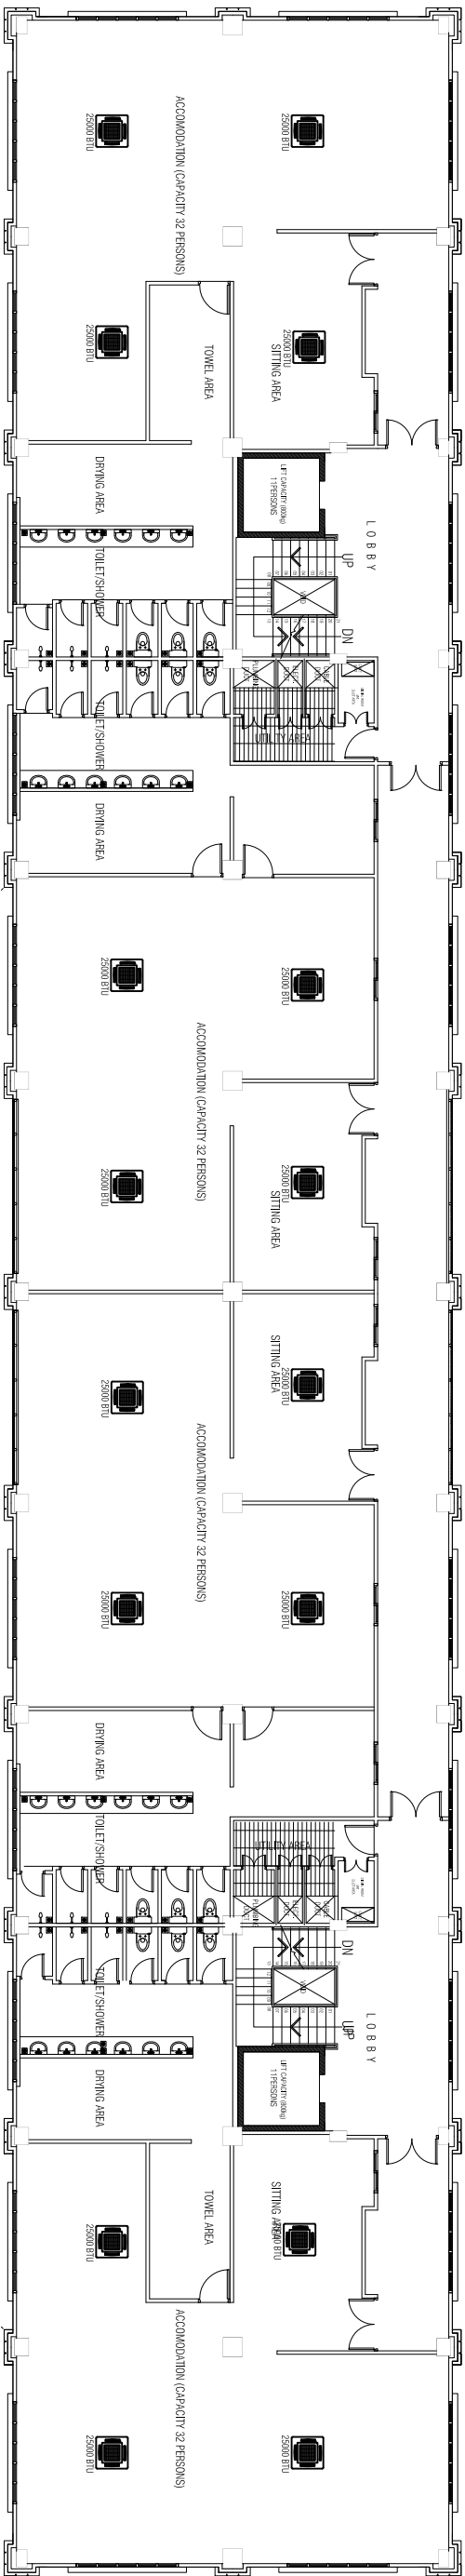

**FOURTH FLOOR PLAN**  
SCALE 1:200

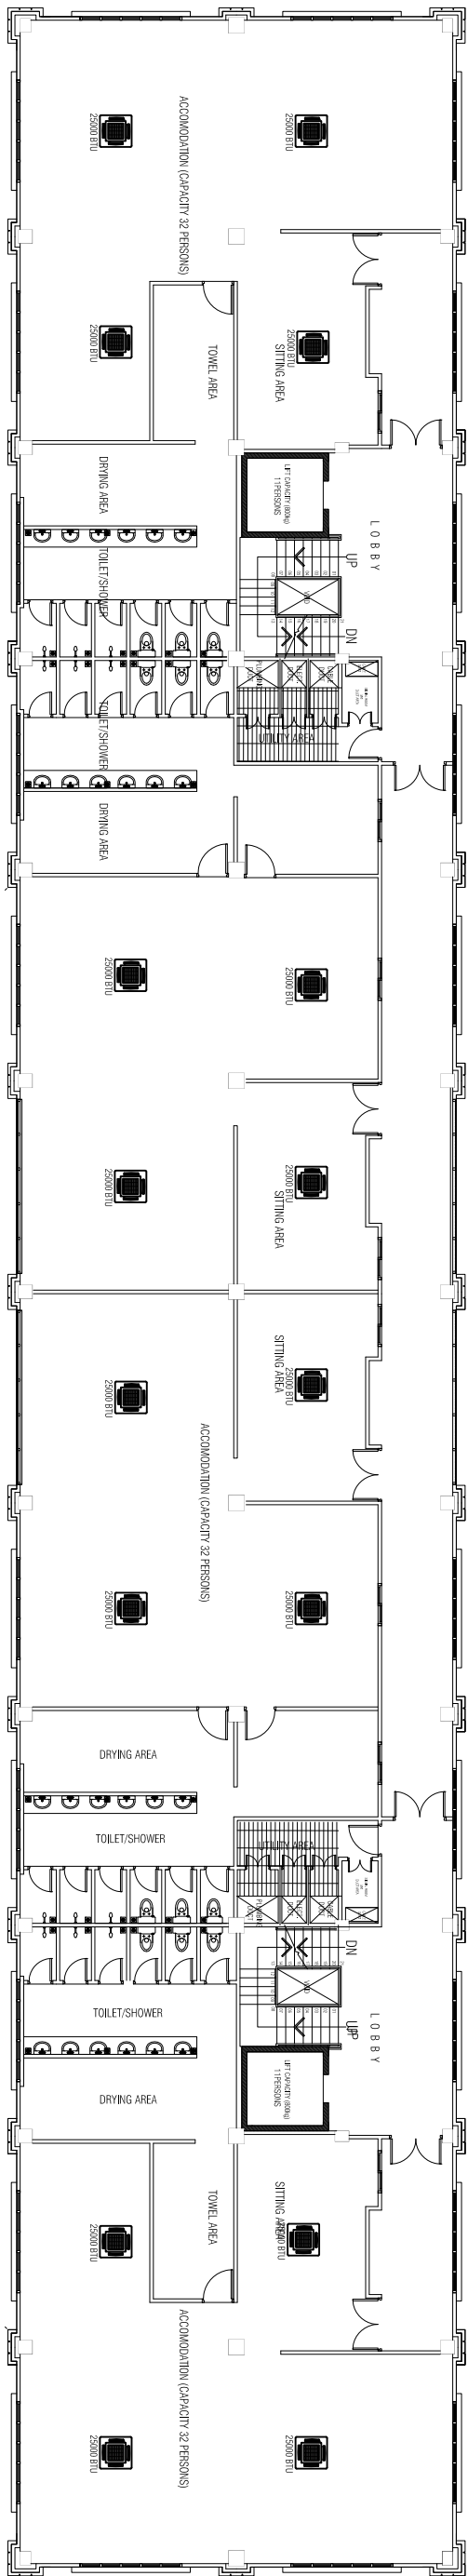

**FIFTH & SIXTH FLOOR PLAN**  
SCALE 1:200

LEGEND:

SYMBOL	QUANTITY	DESCRIPTION
4TH	16	16
5TH	16	16
6TH	16	16
CASSETTE TYPE AC UNIT (25000 BTU)		

9 STOREY ACCOMMODATION BUILDING

BANDAAFA KOSHI / MALE

SHEET CONTENT:

DESIGN APPROVAL:

**BRIG. GEN. AHMED SHAHID**  
VICE CHIEF OF DEFENCE FORCE

RECOM. APPROVAL:

**CPT. AHMED SHARIM**  
OFFICER COMMANDING

APPROVED:

**MAJ. GEN. AHMED SHIYAM**  
CHIEF OF DEFENCE FORCE

APPROVED DATE:

DESIGNED:

**L.CPT. AUI MUTHASIM**  
**PTE. M. SAIF ABDULLA**  
Architectural

**WO1. AHMED SHAZEEL**  
Structural

CHECKED:

**CPT. MOHAMED SHIFA'AU**  
Architectural

**WO3. AMINATH AUI**  
Structural

Electrical & Mechanical

Communication

DRAWN:


REVISION:

**L.CPT. AUI MUTHASIM**  
**PTE. M. SAIF ABDULLA**  
DATE: 07 AUGUST 2015

**PTE. HUSSAIN GASIM**  
**PTE. YAMIN SAIED**  
DATE: 11 SEPTEMBER 2016

SCALE: 1:200

SHEET NO.:

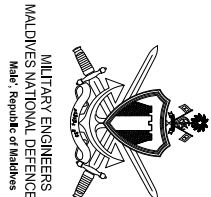

NATIONAL ENGINEERS  
MALDIVES  
Maldives National Defence Force  
Male, Republic of Maldives

The drawings, concept and design contained are the properties of Military Engineers MNDFF. Use of any kind or copy of whole or part of this drawing, concept or design or use on other projects or sites other than that specified on this drawing is strictly prohibited.

9 STOREY ACCOMMODATION BUILDING

BANDARA KOSHI / MALE

SHEET CONTENT:

DESIGN APPROVAL:

**BRIG. GEN. AHMED SHAHID**

VICE CHIEF OF DEFENCE FORCE

RECOM. APPROVAL:

**CPT. AHMED SHARIM**

OFFICER COMMANDING

APPROVED:

**MAJ. GEN. AHMED SHIYAM**

CHIEF OF DEFENCE FORCE

APPROVED DATE:

DESIGNED:

**L.CPT. ALI MUTHASIM**

**PTE. M. SAIF ABDULLA**

Architectural

**WO1. AHMED SHAZEEL**

Structural

CHECKED:

**CPT. MOHAMED SHIFA'AU**

Architectural

**WO3. AMINATH ALI**

Structural

Electrical & Mechanical

Communication

DRAWN:

REVISION:

**L.CPT. ALI MUTHASIM**

**PTE. M. SAIF ABDULLA**

DATE:

**PTE. HUSSAIN GASIM**

**PTE. YAMIN SAEED**

DATE:

**07 AUGUST 2015**


**11 SEPTEMBER 2016**

SCALE:


SHEET NO:

**1:200**

-

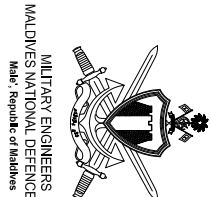

The drawings, concept and design contained are the properties of Military Engineers MNDFF. Use of any kind or copy of whole or part of this drawing, concept or design or use on other projects or sites other than that specified on this drawing is strictly prohibited.

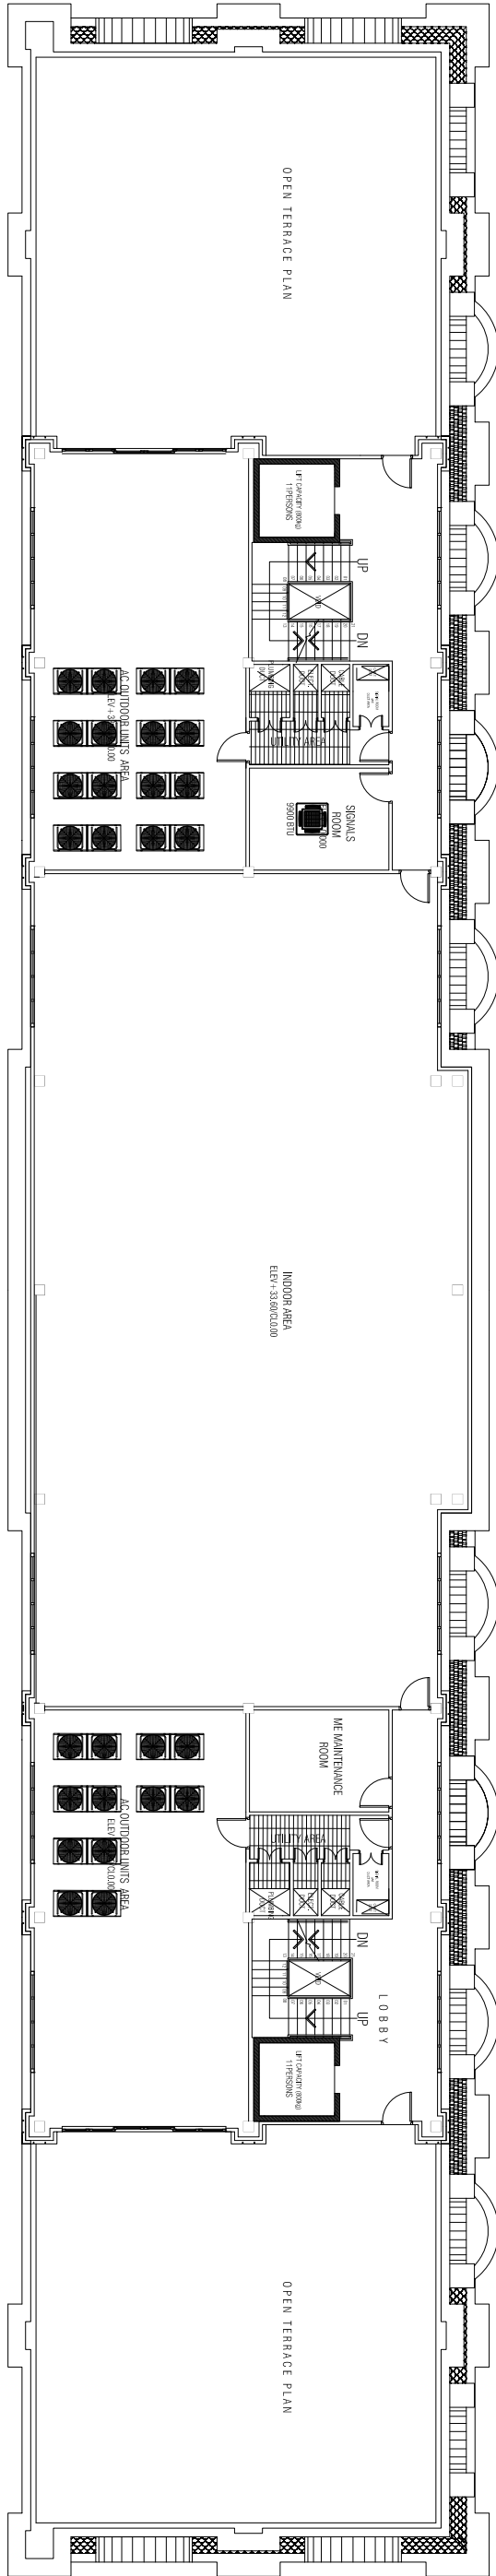

**TERRACE FLOOR PLAN**

SCALE: 1:200

LEGEND:

SYMBOL	QUANTITY	DESCRIPTION
	01	CASSETTE TYPE AC UNIT (9000 BTU)
	14	CASSETTE TYPE AC UNIT (9000 BTU)

9 STOREY ACCOMMODATION BUILDING

BANDAAFA KOSHI / MALE

SHEET CONTENT:

DESIGN APPROVAL:

BRIG. GEN. AHMED SHAHID

VICE CHIEF OF DEFENCE FORCE

RECOM. APPROVAL:

CPT. AHMED SHARIM

OFFICER COMMANDING

APPROVED:

MAJ. GEN. AHMED SHIYAM

CHIEF OF DEFENCE FORCE

APPROVED DATE:

DESIGNED:

L.CPT. ALI MUTHASIM  
PTE. M. SAIF ABDULLA

Architectural

WO1. AHMED SHAZEEL

Structural

CHECKED:

CPT. MOHAMED SHIFA'AU  
Architectural

WO3. AMINATH ALI

Structural

Electrical & Mechanical

Communication

DRAWN:

REVISION:

L.CPT. ALI MUTHASIM  
PTE. M. SAIF ABDULLA

PTE. HUSSAIN GASIM  
PTE. YAMIN SAEED

DATE:

DATE:

07 AUGUST 2015


11 SEPTEMBER 2016

SCALE:

SHEET NO:


1:200

-

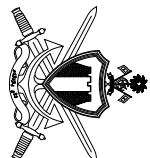


NATIONAL DEFENCE FORCE  
MALDIVES  
State, Republic of Maldives

The drawings, concept and design contained are the properties of Military Engineers MNDFF. Use of any kind or copy of whole or part of this drawing, concept or design or use on other projects or sites other than that specified on this drawing is strictly prohibited.

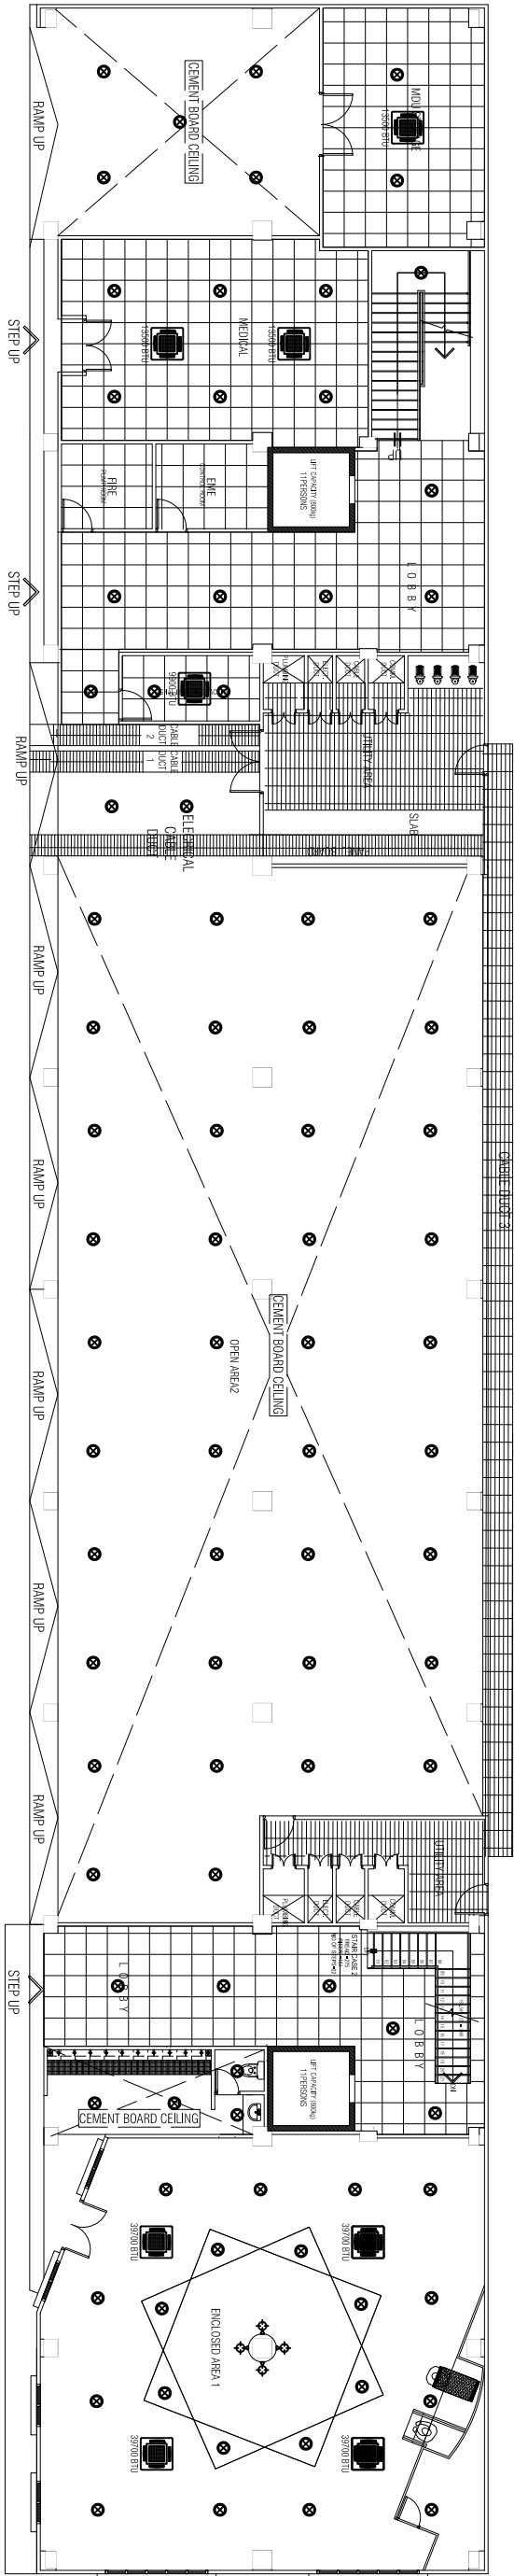

GROUND FLOOR PLAN

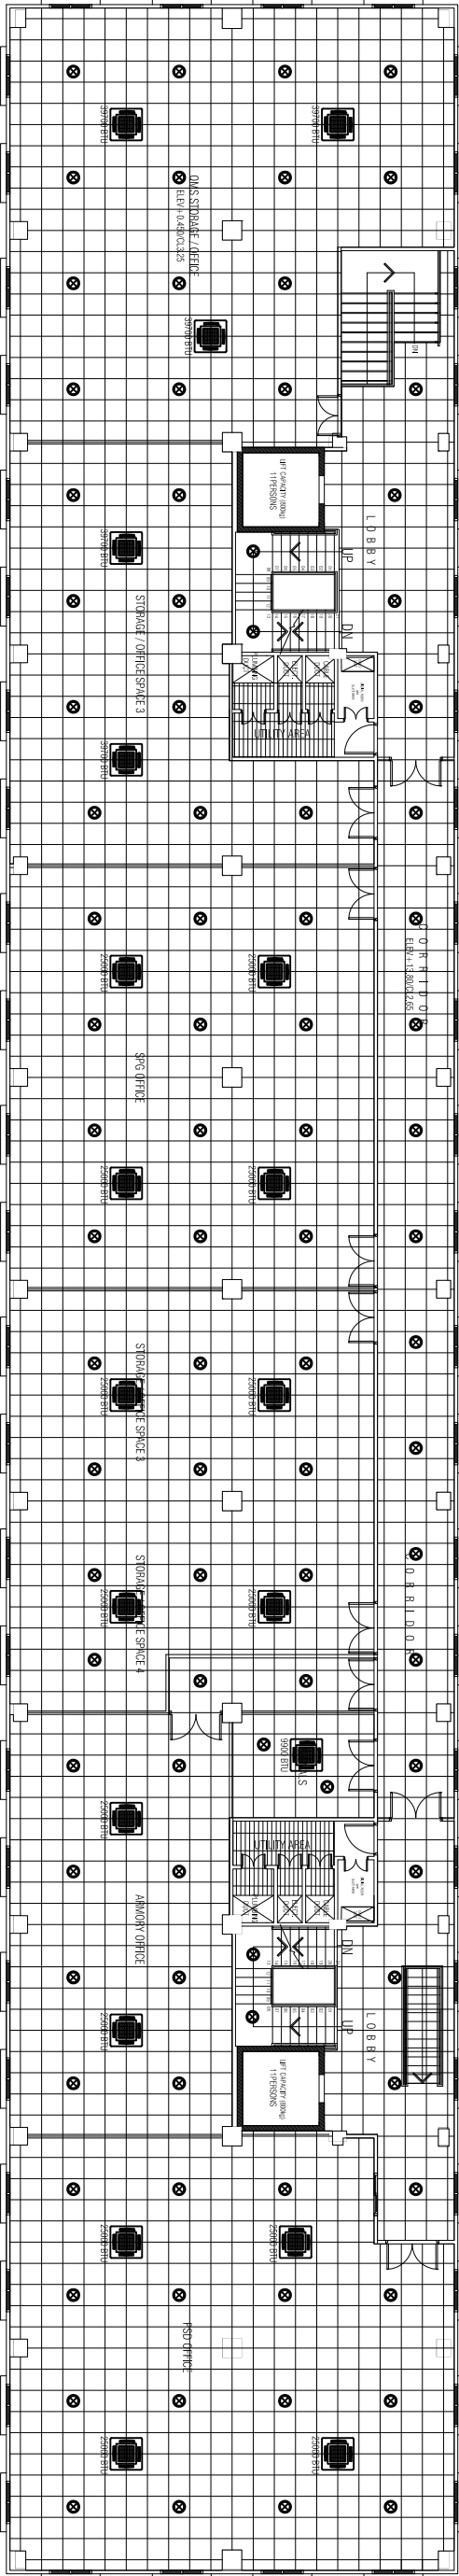

FIRST FLOOR PLAN

LEGEND:		
SYMBOL	QUANTITY	DESCRIPTION
GRND 1ST		
93	92	DOWNLIGHTS C/W 20W PIREXO SWIRS
00	14	CASSETTE TYPE AC UNIT (25000 BTU)
04	05	CASSETTE TYPE AC UNIT (35100 BTU)
03	00	CASSETTE TYPE AC UNIT (35000 BTU)
01	01	CASSETTE TYPE AC UNIT (35000 BTU)

## BANDARA KOSHI / MALE

DESIGN APPROVAL:

**BRIG. GEN. AHMED SHAHID**

VICE CHIEF OF DEFENCE FORCES

RECOM. APPROVAL

**CPT. AHMED SHARIM**

OFFICER COMMANDING

APPROVED:

MAJ. GEN. AHMED SHIYAM

CHIEF OF DEFENCE FORCE

APPROVED DATE:

DESIGNED:

L. CPL ALI MUTHASIM  
PTE. M. SAIF ABDULLA

---

WO1. AHMED SHAZEE

Architectura

**CPT. MOHAMED SHIFAU**      **WO3. AIMINATH AL**

Architectural Structural

Electrical &amp; Mechanical Communication

DRAWN:

L.CPL ALI MUTHASIM	PTE. HUSSAIN GASIM
PTE. M. SAIF ABDULLA	PTE. YAMIN SAEED

DATE:

07 AUGUST 2015	11 SEPTEMBER 2016
----------------	-------------------

SCALE: SHEET NO

1:200



The drawings, concept and design contained are the property of Military Engineers MNDF. Use of any kind of copy of whole or part of this drawing, concept or design for use on other projects or sites other than that specified in this drawing is strictly prohibited.

9 STOREY ACCOMMODATION BUILDING

BANDARA KOSHI / MALE

SHEET CONTENT:

DESIGN APPROVAL:

BRIG. GEN. AHMED SHAHID

VICE CHIEF OF DEFENCE FORCE

RECOM. APPROVAL:

CPT. AHMED SHARIM

OFFICER COMMANDING

APPROVED:

MAJ. GEN. AHMED SHIYAM

CHIEF OF DEFENCE FORCE

APPROVED DATE:

DESIGNED:

L.CPT. AU MUTHASIM

PTE. M. SAIF ABDULLA

Architectural

WO1. AHMED SHAZEEL

Structural

CHECKED:

CPT. MOHAMED SHIFA AU

Architectural

WO3. AMINATH AU

Structural

Electrical & Mechanical

Communication

DRAWN:

L.CPT. AU MUTHASIM

PTE. M. SAIF ABDULLA

DATE:

07 AUGUST 2015

SCALE:

1:200

REVISION:

PTE. HUSSAIN GASIM

PTE. YAMIN SAIED

DATE:

11 SEPTEMBER 2016


SHEET NO:

-




NATIONAL DEFENCE FORCE  
MALDIVES  
State, Republic of Maldives

The drawings, concept and design contained are the properties of Military Engineers MNDFF. Use of any kind or copy of whole or part of this drawing, concept or design or use on other projects or sites other than that specified on this drawing is strictly prohibited.

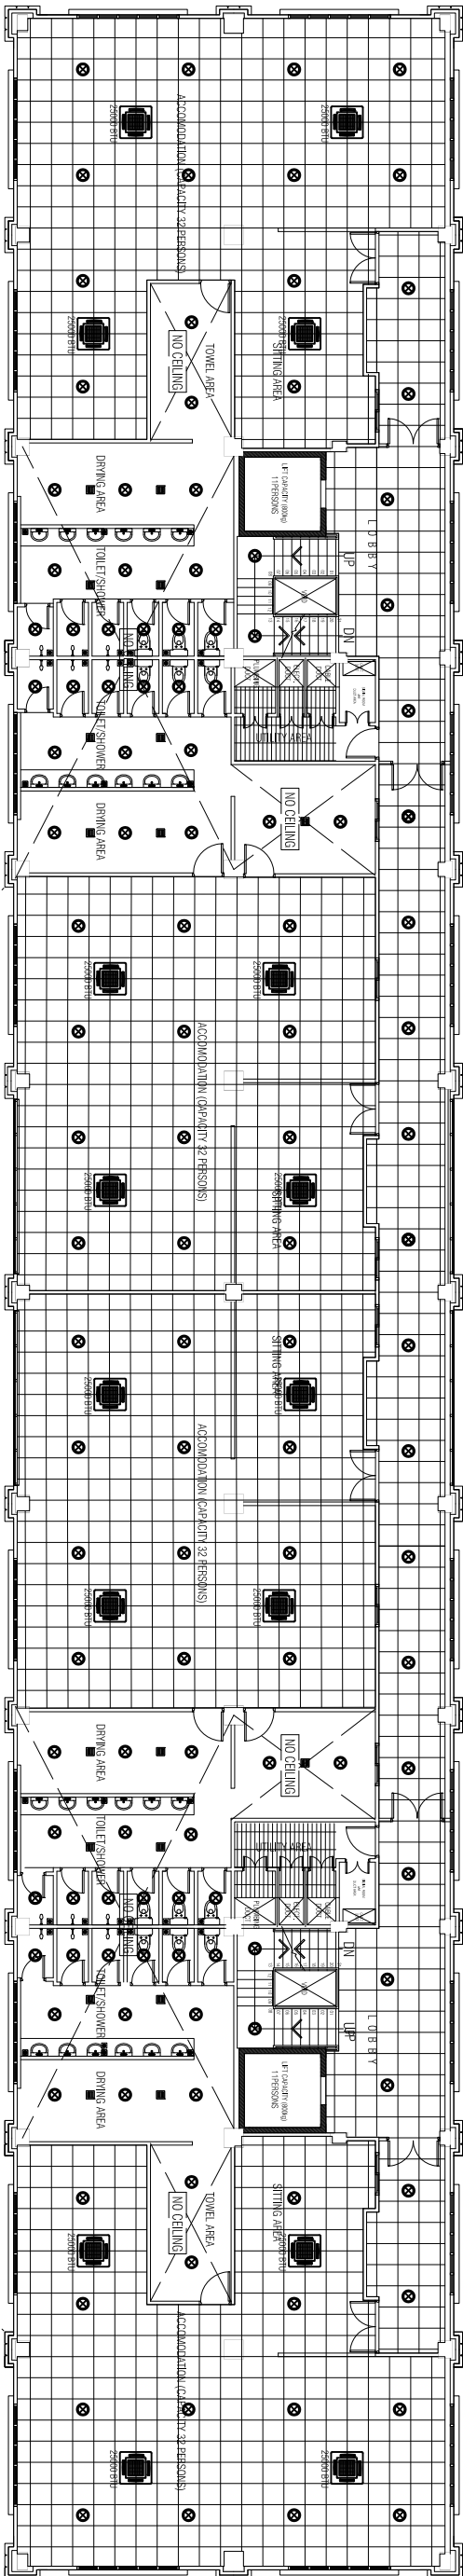

4TH FLOOR PLAN  
SCALE: 1:200

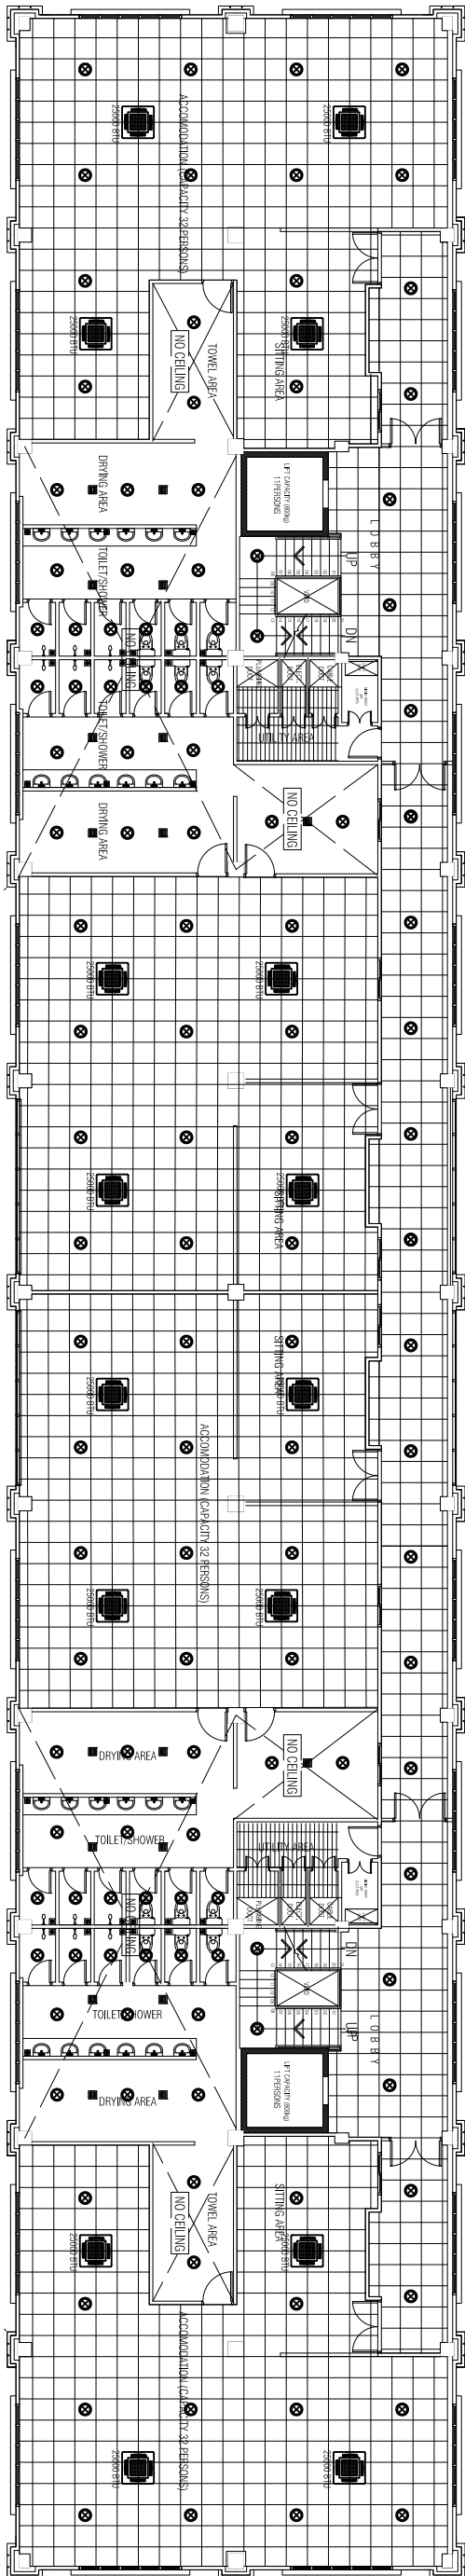

5TH & 6TH FLOOR PLAN  
SCALE: 1:200

LEGEND:		
SYMBOL	QUANTITY	DESCRIPTION
○	2ND 3RD 3RD	DOWN LIGHTS (4W 20W ENERGY SAVERS)
■	20 20 20	CEILING EXHAUST
■	16 16 16	CASSETTE TYPE AC UNIT (25000 BTU)
■	00 00 00	CASSETTE TYPE AC UNIT (9000 BTU)

## BANDAARA KOSHI / MALE

---

VICE CHIEF OF DEFENCE FORCE

---

OFFICER COMMANDING

CHIEF OF DEFENCE FORCE

---

Architectural

Architectural

1 CPI ALL MI

DATE: \_\_\_\_\_

--	--

\_\_\_\_\_

Downloaded from <http://ajph.org/> on November 10, 2014



this drawing is strictly prohibited.



9 STOREY ACCOMMODATION BUILDING

BANDAAFA KOSHI / MALE

SHEET CONTENT:

DESIGN APPROVAL:

BRIG. GEN. AHMED SHAHID

VICE CHIEF OF DEFENCE FORCE

RECOM. APPROVAL:

CPT. AHMED SHARIM

OFFICER COMMANDING

APPROVED:

MAJ. GEN. AHMED SHIYAM

CHIEF OF DEFENCE FORCE

APPROVED DATE:

DESIGNED:

L.CPT. AU MUTHASIM

PTE. M. SAIF ABDULLA

Architectural

WO1. AHMED SHAZEEL

Structural

CHECKED:

CPT. MOHAMED SHIFA'AU

Architectural

WO3. AMINATH AU

Structural

Electrical & Mechanical

Communication

DRAWN:

REVISION:

L.CPT. AU MUTHASIM

PTE. HUSSAIN GASIM

PTE. M. SAIF ABDULLA

PTE. YAMIN SAEED

DATE:

DATE:

07 AUGUST 2015


11 SEPTEMBER 2016

SCALE:

SHEET NO:

1:200

-

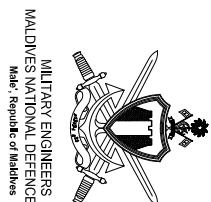

The drawings, concept and design contained are the properties of Military Engineers MNDF. Use of any kind or copy of whole or part of this drawing, concept or design or use on other projects or sites other than that specified on this drawing is strictly prohibited.