

9 STOREY ACCOMMODATION BUILDING

BANDAAARA KOSHI / MALE

SHEET CONTENT:

DESIGN APPROVAL:

BRIG. GEN. AHMED SHAHID

VICE CHIEF OF DEFENCE FORCE

RECOM. APPROVAL:

CPT. AHMED SHARIM

OFFICER COMMANDING

APPROVED:

MAJ. GEN. AHMED SHIYAM

CHIEF OF DEFENCE FORCE

APPROVED DATE:

DESIGNED:

L.CPT. ALI MUTHASIM

PTE. M. SAIF ABDULLA

Architectural

WO1. AHMED SHAZEEL

Structural

CHECKED:

CPT. MOHAMED SHIFA'AU

Architectural

WO3. AMINATH ALI

Structural

Electrical & Mechanical

Communication

DRAWN:

REVISION:

L.CPT. ALI MUTHASIM

PTE. M. SAIF ABDULLA

DATE:

DATE:

07 AUGUST 2015

11 SEPTEMBER 2016

SCALE:

SHEET NO:


1:200

NOTE:
ALL OUTLET @ 0.4 FROM FL.
ALL THROUGH OUT & ARE TUN. CONNECTION PAGE
PLATES. DO NOT SPLIT. CABLE FROM EACH




MALDIVES NATIONAL DEFENCE FORCE
State, Republic of Maldives

The drawings, concept and design contained are the properties of Military Engineers MNDFF. Use of any kind or copy of whole or part of this drawing, concept or design or use on other projects or sites other than that specified on this drawing is strictly prohibited.

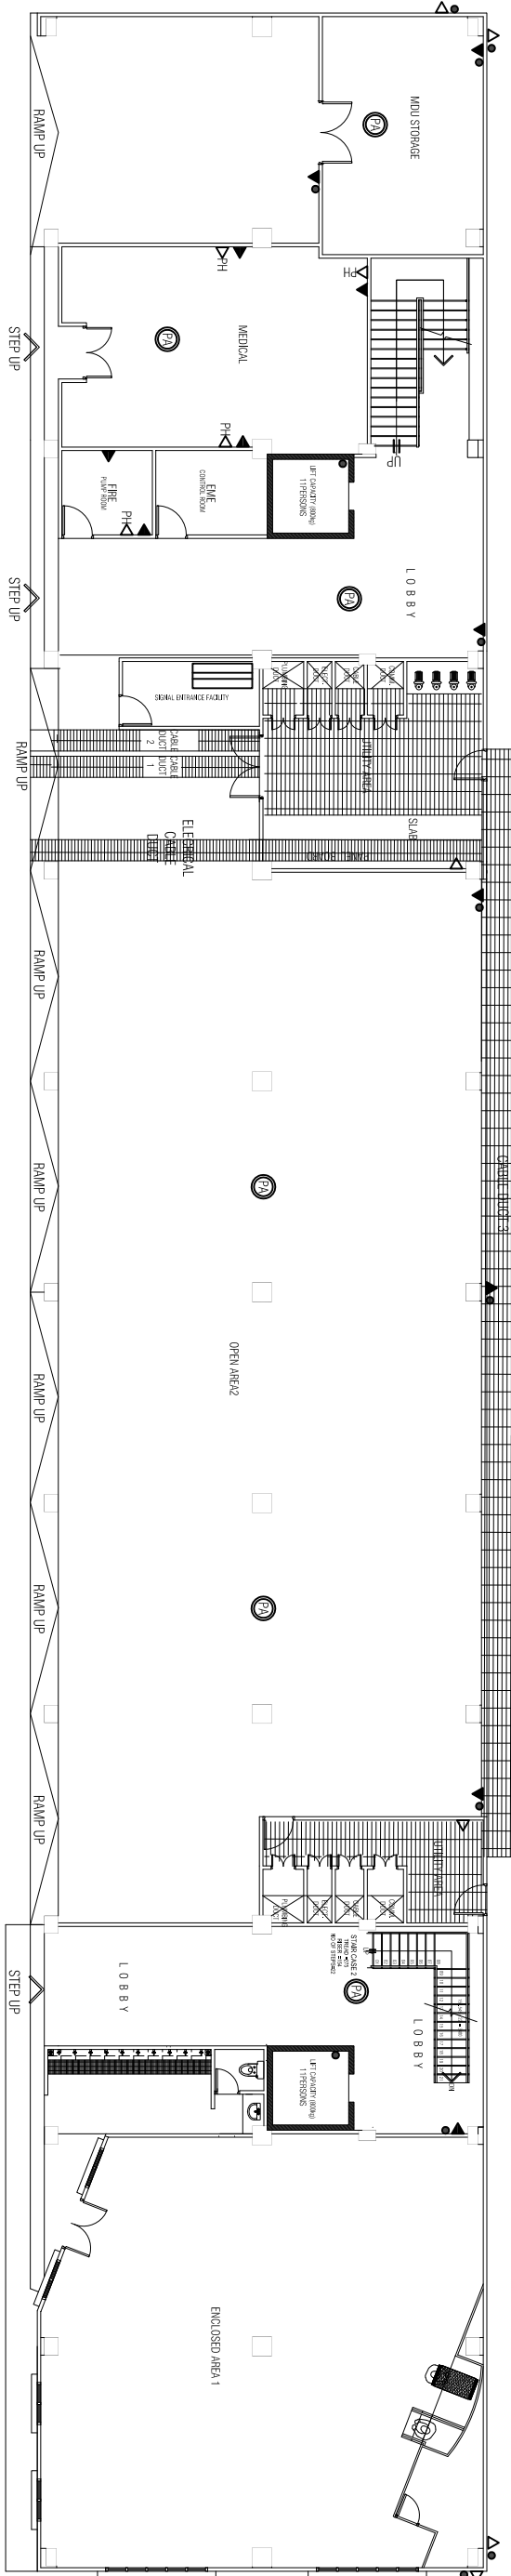

GROUND FLOOR PLAN

SCALE 1:200

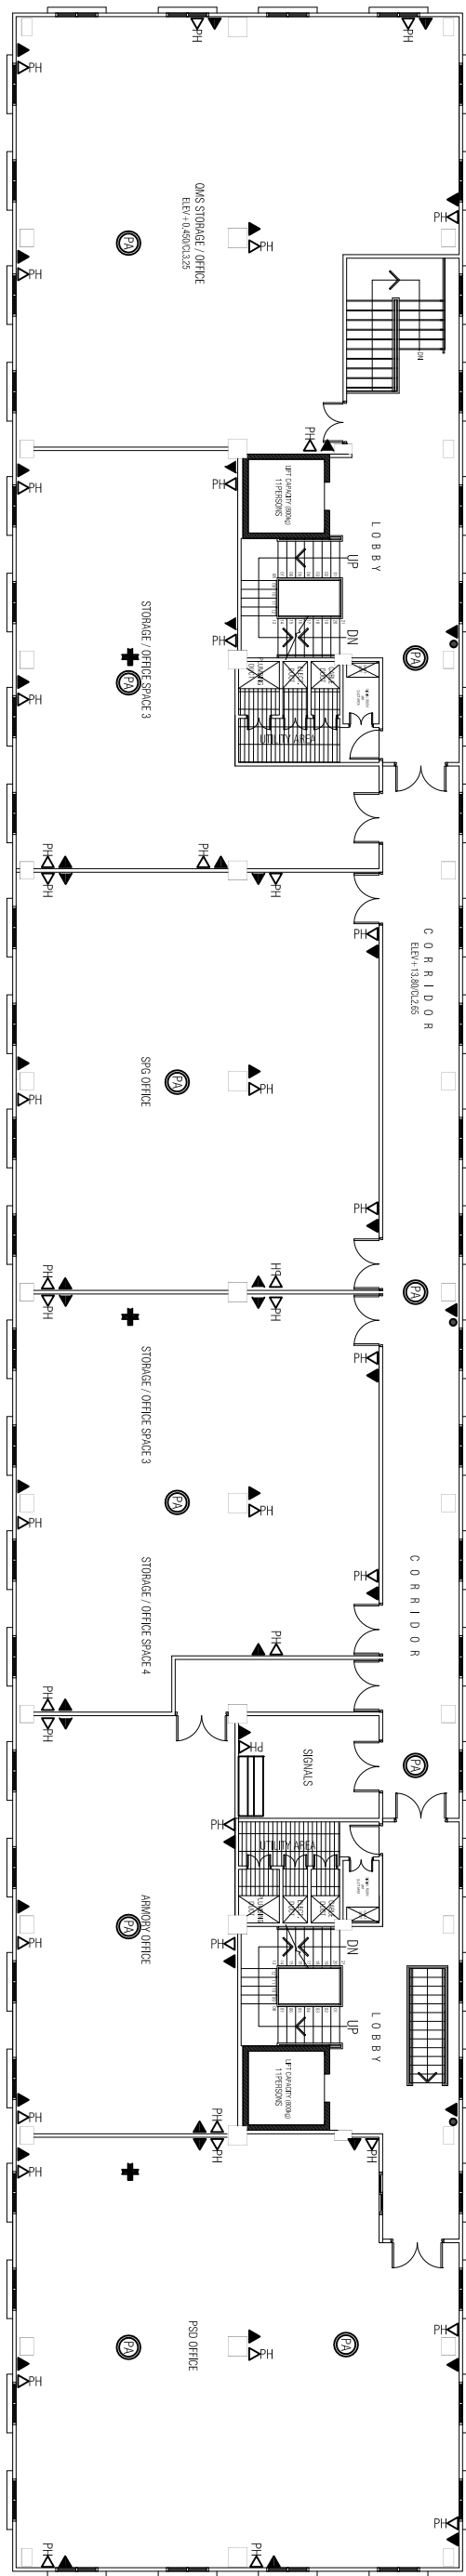

FIRST FLOOR PLAN

SCALE 1:200

LEGEND:		
SYMBOL	QUANTITY	DESCRIPTION
GRIND ISI		
▷	04	TELEPHONE OUTLET
▷	06	SINGLE CABLE NETWORK OUTLET
▷	11	DUAL CABLE NETWORK OUTLET
+	00	WFLAP
●	12	CCIV POINT
●	06	PA SYSTEM
■	01	12 U/NETWORK RACK

NOTE:
ALL OUTLET @ 0.4 FROM FL.
ALL THROUGH OUT & ARE TUN. CONNECTION PAGE
PLATES. DO NOT SPLIT. CABLE FROM EACH

9 STOREY ACCOMMODATION BUILDING

BANDAAARA KOSHI / MALE

SHEET CONTENT:

DESIGN APPROVAL:

BRIG. GEN. AHMED SHAHID

VICE CHIEF OF DEFENCE FORCE

RECOM. APPROVAL:

CPT. AHMED SHARIM

OFFICER COMMANDING

APPROVED:

MAJ. GEN. AHMED SHIYAM

CHIEF OF DEFENCE FORCE

APPROVED DATE:

DESIGNED:

L.CPT. AII MUTHASIM

PTE. M. SAIF ABDULLA

Architectural

WO1. AHMED SHAZEEL

Structural

CHECKED:

CPT. MOHAMED SHIFA'AU

Architectural

WO3. AMINATH AII

Structural

Electrical & Mechanical

Communication

DRAWN:

REVISION:

L.CPT. AII MUTHASIM

PTE. M. SAIF ABDULLA

Architectural

PTE. HUSSAIN GASIM

PTE. YAMIN SAEED

DATE:

DATE:

07 AUGUST 2015


11 SEPTEMBER 2016

SCALE:

SHEET NO:


1:200

-

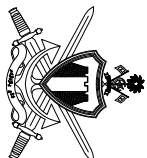


NATIONAL ENGINEERS
MALDIVES
Maldives National Defence Force

The drawings, concept and design contained are the properties of Military Engineers MNDFF. Use of any kind or copy of whole or part of this drawing, concept or design or use on other projects or sites other than that specified on this drawing is strictly prohibited.

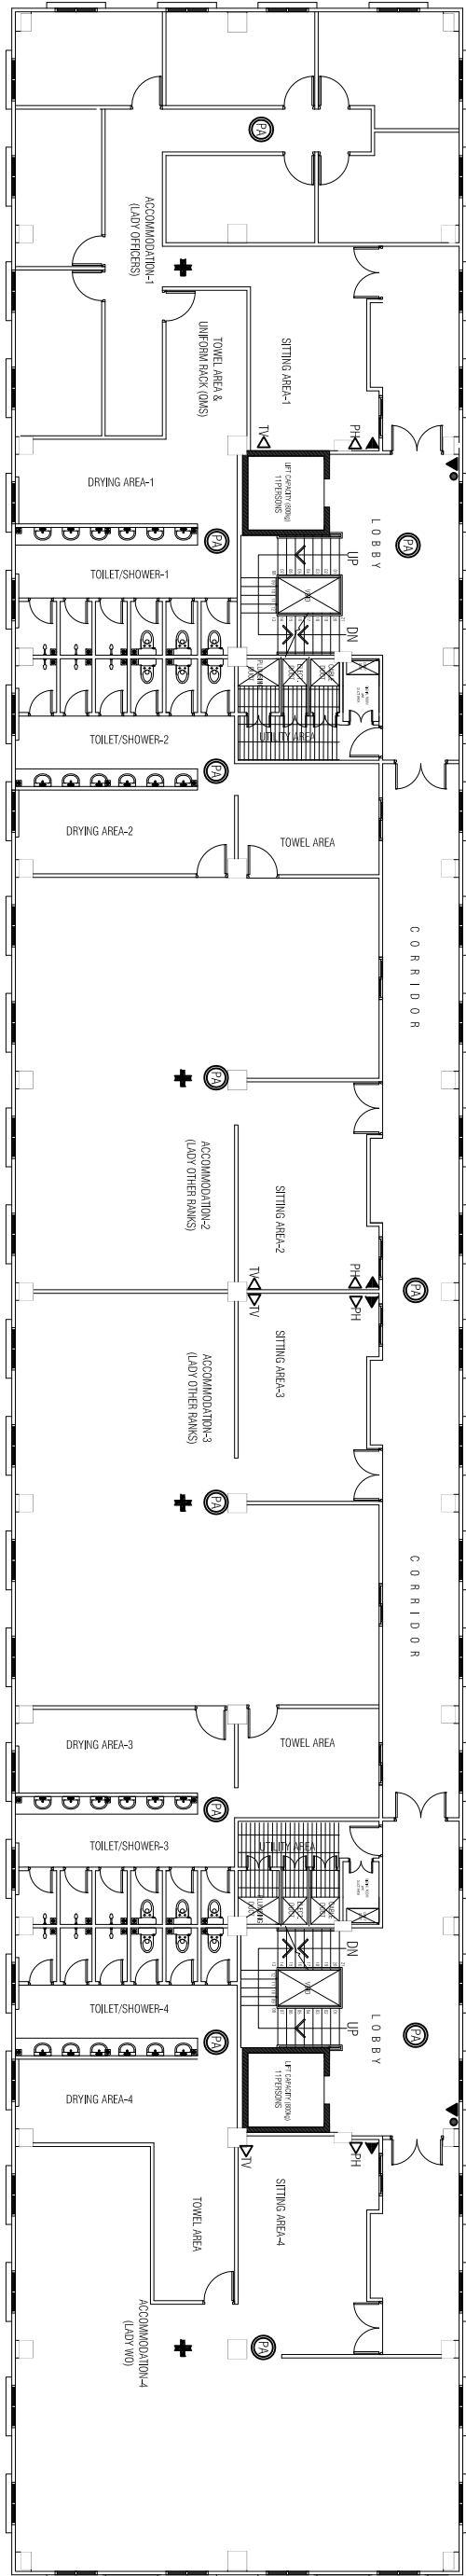

SECOND FLOOR PLAN

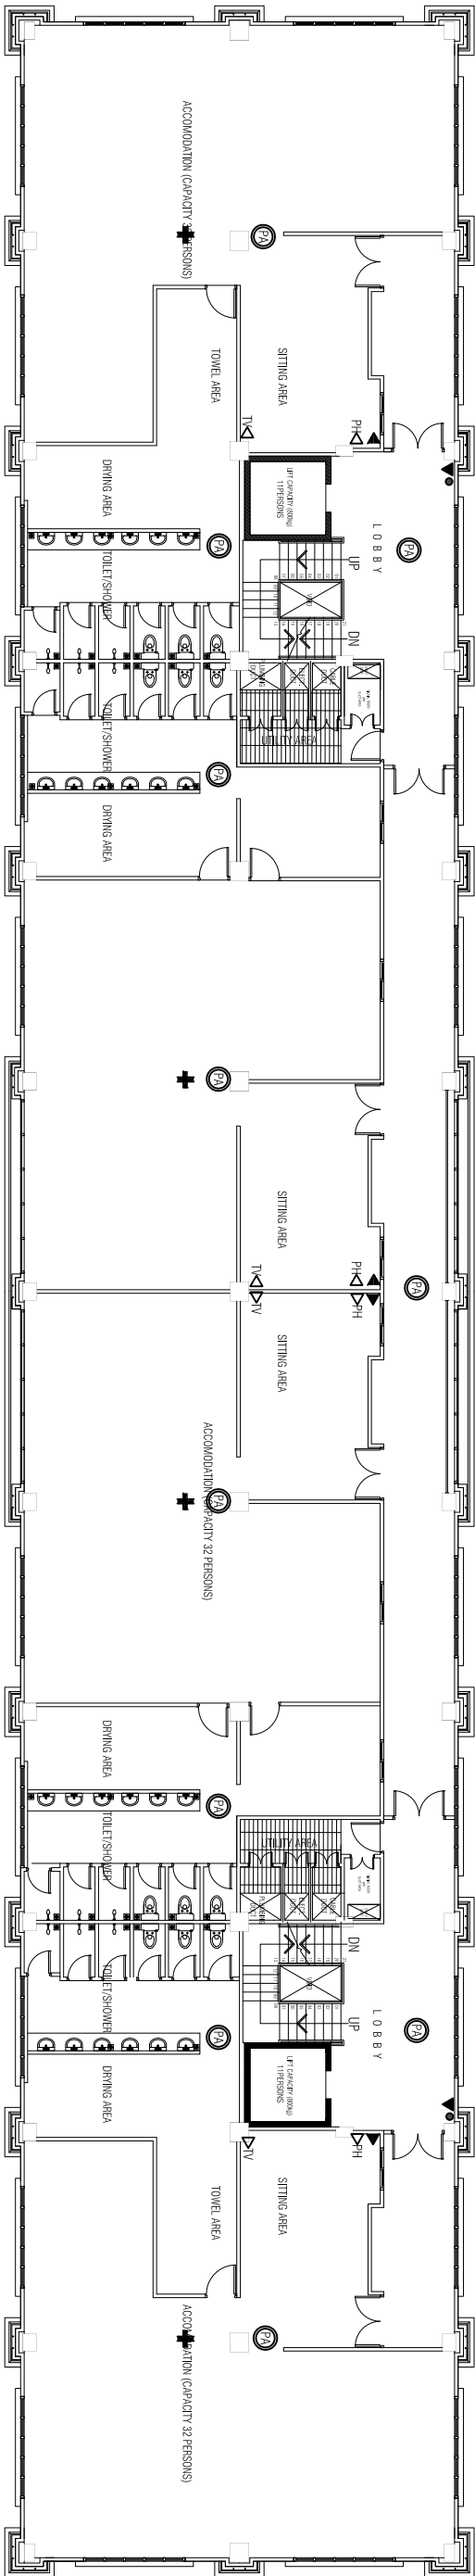

THIRD & FORTH FLOOR PLAN

LEGEND:		
SYMBOL	QUANTITY	DESCRIPTION
DPV	2ND 3RD 4RD	CATV OUTLET
DPH	04 04 04	TELEPHONE OUTLET
DPV	04 04 04	DUAL CABLE NETWORK OUTLET
DPV	06 06 06	WIRING
DPV	02 02 02	CCTV POINT
DPV	11 11 11	PA SYSTEM

NOTE:
ALL OUTLET @ 0.4 FROM THE
ALL EXTERIOR COR & ARE DUAL CONNECTION FACE
FACES, DO NOT SPILT CABLE FOR HIGH

9 STOREY ACCOMMODATION BUILDING

BANDAAARA KOSHI / MALE

SHEET CONTENT:

DESIGN APPROVAL:

BRIG. GEN. AHMED SHAHID

VICE CHIEF OF DEFENCE FORCE

RECOM. APPROVAL:

CPT. AHMED SHARIM

OFFICER COMMANDING

APPROVED:

MAJ. GEN. AHMED SHIYAM

CHIEF OF DEFENCE FORCE

APPROVED DATE:

DESIGNED:

L.CPT. AUI MUTHASIM
PTE. M. SAIF ABDULLA
Architectural

WO1. AHMED SHAZEEL
Structural

CHECKED:

CPT. MOHAMED SHIFA'AU
Architectural

WO3. AMINATH AUI
Structural

Electrical & Mechanical

Communication

DRAWN:

L.CPT. AUI MUTHASIM
PTE. M. SAIF ABDULLA
DATE:

PTE. HUSSAIN GASIM
PTE. YAMIN SAEED
DATE:

07 AUGUST 2015

11 SEPTEMBER 2016

SCALE:

SHEET NO.:

1:200

NOTE


ALL OUTLET @ 0.4 FROM FTL

ALL ETHERNET CAT 6 & PE DUAL CONNECTION FACE

PLATES DO NOT SPILT CABLE FROM EACH




The drawings, concept and design contained are the properties of Military Engineers MNDFF. Use of any kind or copy of whole or part of this drawing, concept or design or use on other projects or sites other than that specified on this drawing is strictly prohibited.

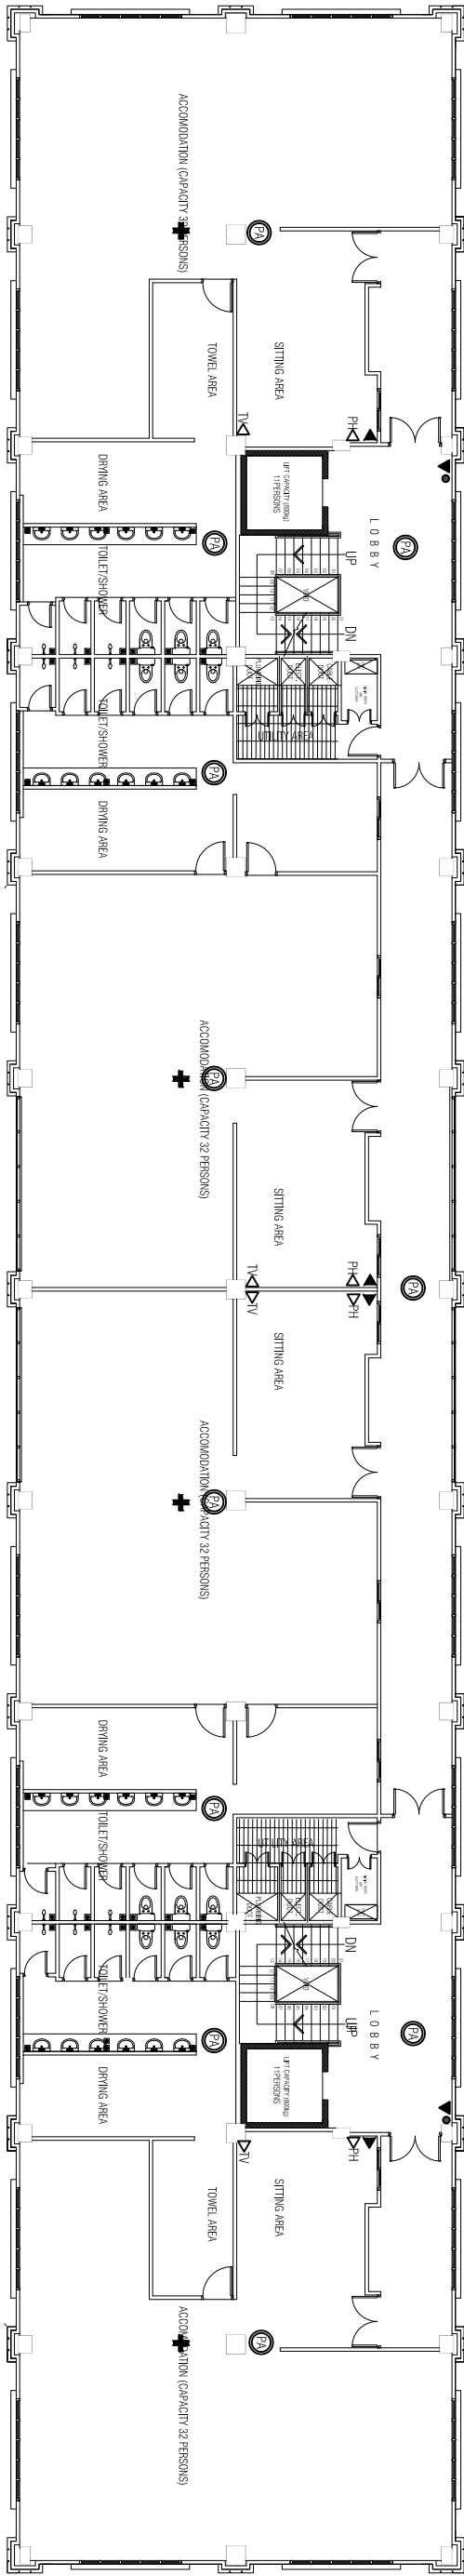

 **FORTH FLOOR PLAN**

SCALE 1:200

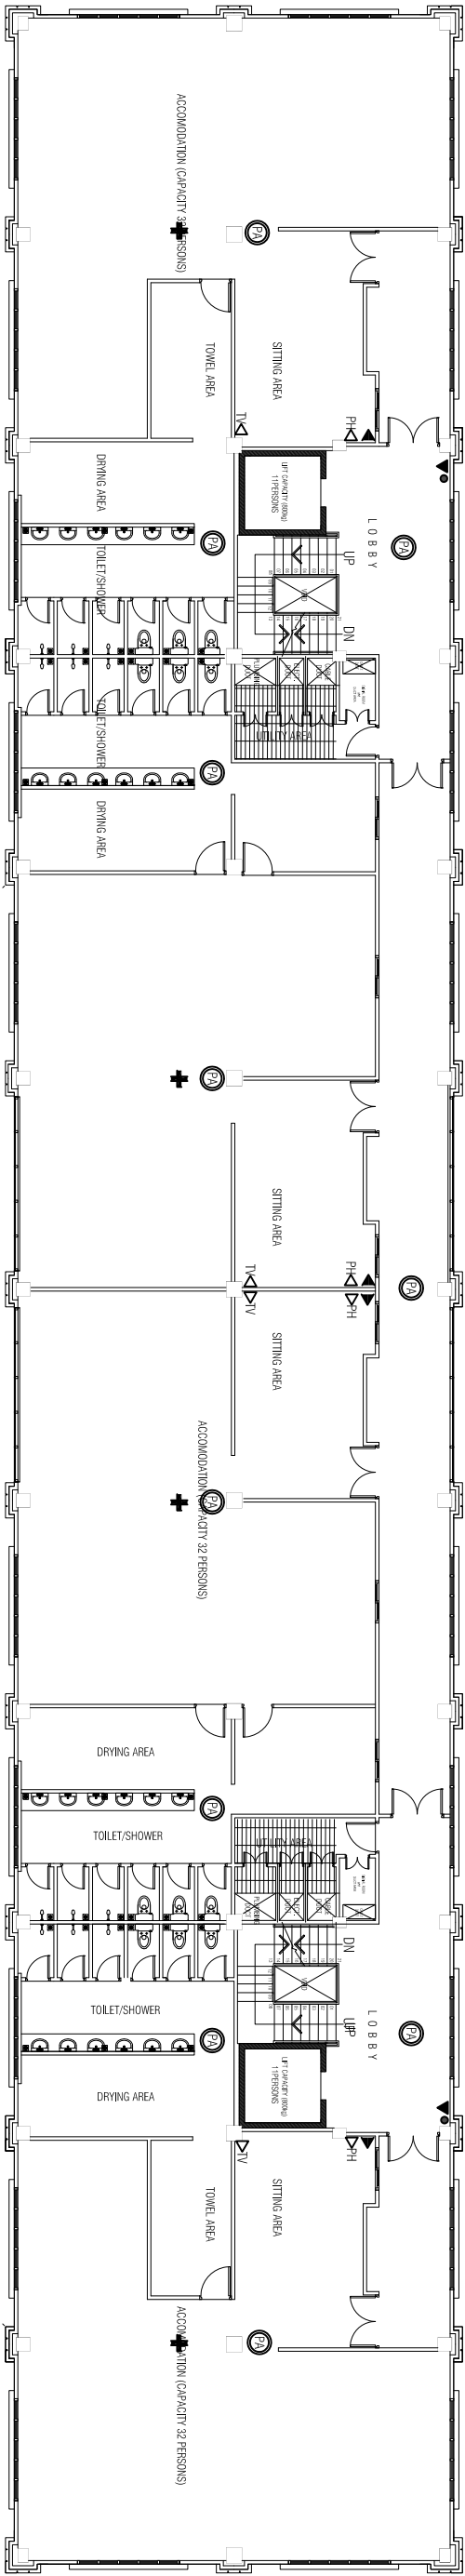

 **FIFTH & SIXTH FLOOR PLAN**

SCALE 1:200

LEGEND:

SYMBOL	QUANTITY	DESCRIPTION
DN	4TH 5TH 6TH	CAN OUTLET
DN	04 04 04	TELEPHONE OUTLET
DN	06 06 06	DUAL CABLE NETWORK OUTLET
+	04 04 04	WH/4P
●	02 02 02	CCTV POINT
●	11 11 17	PA SYSTEM

9 STOREY ACCOMMODATION BUILDING

BANDAAARA KOSHI / MALE

SHEET CONTENT:

DESIGN APPROVAL:

BRIG. GEN. AHMED SHAHID

VICE CHIEF OF DEFENCE FORCE

RECOM. APPROVAL:

CPT. AHMED SHARIM

OFFICER COMMANDING

APPROVED:

MAJ. GEN. AHMED SHIYAM

CHIEF OF DEFENCE FORCE

APPROVED DATE:

DESIGNED:

L.CPL AU MUTHASIM

PTE. M. SAIF ABDULLA

Architectural

WO1. AHMED SHAZEEL

Structural

CHECKED:

CPT. MOHAMED SHIFA'AU

Architectural

WO3. AMINATH AU

Structural

Electrical & Mechanical

Communication

DRAWN:

L.CPL AU MUTHASIM

PTE. M. SAIF ABDULLA

Architectural

PTE. HUSSAIN GASIM

PTE. YAMIN SAEED

DATE:

07 AUGUST 2015

DATE:


11 SEPTEMBER 2016

SCALE:

1:200


SHEET NO.:

-

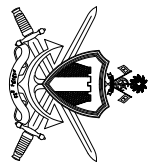


NATIONAL DEFENCE FORCE
MALDIVES
State, Republic of Maldives

The drawings, concept and design contained are the properties of Military Engineers MNDFF. Use of any kind or copy of whole or part of this drawing, concept or design or use on other projects or sites other than that specified on this drawing is strictly prohibited.

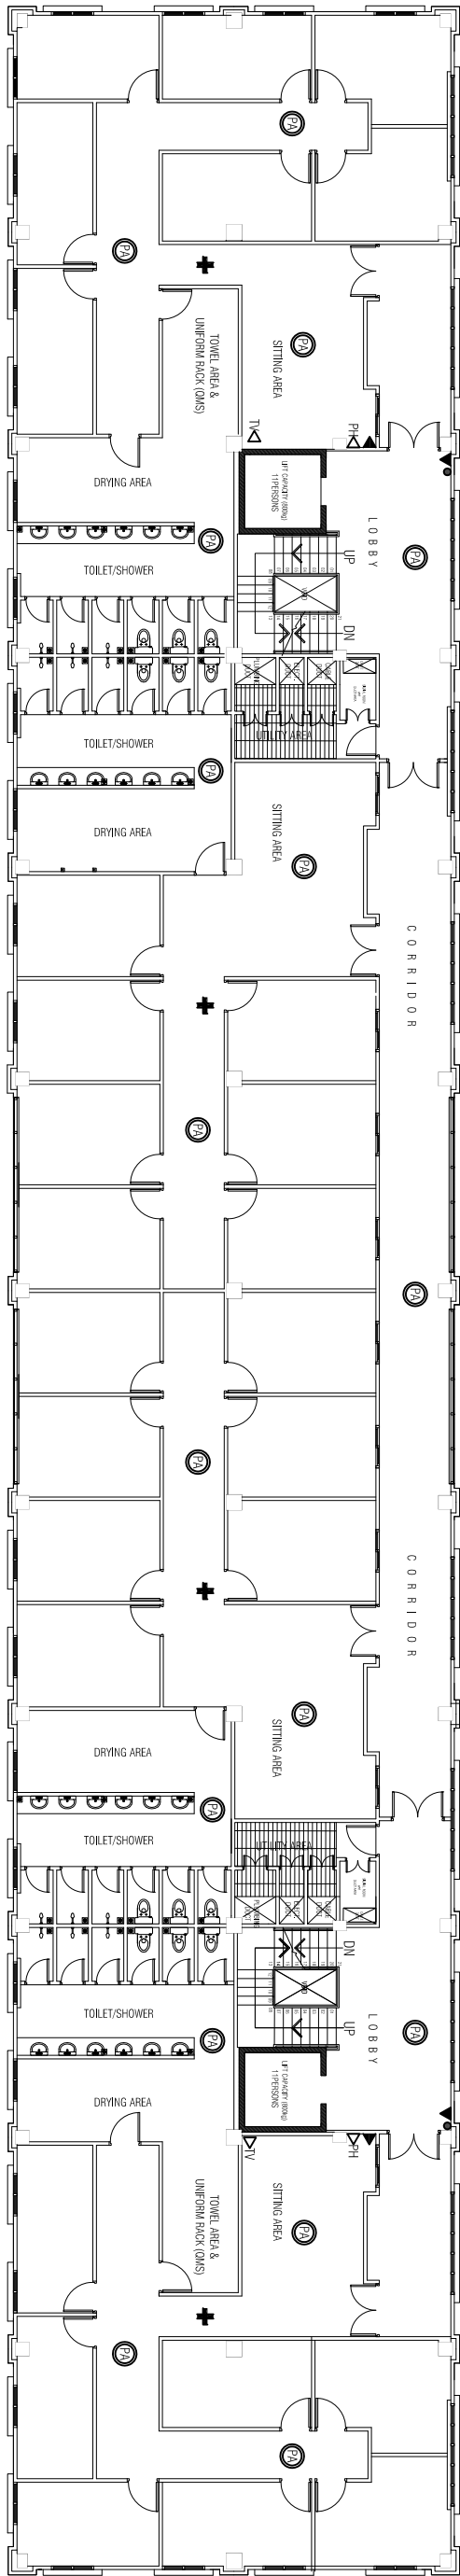

SEVENTH FLOOR PLAN

SCALE 1:200

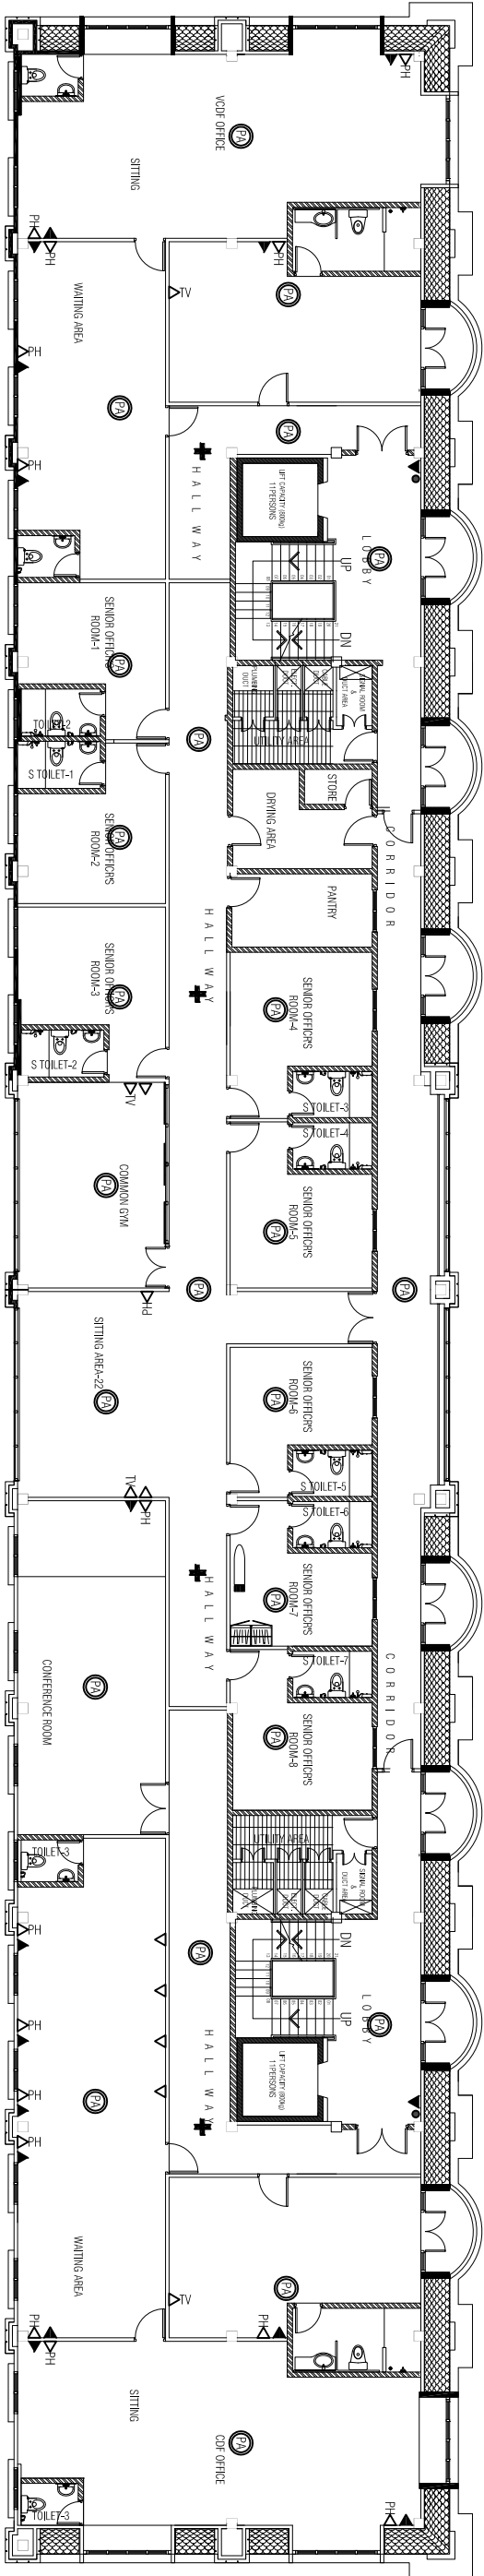

EIGHT FLOOR PLAN



SCALE 1:200

LEGEND:

SYMBOL	QUANTITY	DESCRIPTION
7TH 8TH		
D-1	02	CAN OUTLET
D-2	02	TELEPHONE OUTLET
D-3	06	SINGLE POLE NETWORK OUTLET
D-4	17	DUAL COLE NETWORK OUTLET
D-5	04	WIFI AP
D-6	02	CCTV POINT
D-7	24	PA SYSTEM

NOTE:

ALL OUTLET @ 04 FROM FH
ALL ELECTRICAL & PAE DUAL CONNECTION FACE
FANETS DO NOT SPILL COBLE FOR EACH

9 STOREY ACCOMMODATION BUILDING

BANDARA KOSHI / MALE

SHEET CONTENT:

DESIGN APPROVAL:

BRIG. GEN. AHMED SHAHID

VICE CHIEF OF DEFENCE FORCE

RECOM. APPROVAL:

CPT. AHMED SHARIM

OFFICER COMMANDING

APPROVED:

MAJ. GEN. AHMED SHIYAM

CHIEF OF DEFENCE FORCE

APPROVED DATE:

DESIGNED:

L.CPT. ALI MUTHASIM

PTE. M. SAIF ABDULLA

Architectural

WO1. AHMED SHAZEEL

Structural

CHECKED:

CPT. MOHAMED SHIFA'AU

Architectural

WO3. AMINATH ALI

Structural

Electrical & Mechanical

Communication

DRAWN:

REVISION:

L.CPT. ALI MUTHASIM

PTE. M. SAIF ABDULLA

Architectural

PTE. HUSSAIN GASIM

PTE. YAMIN SAEED

DATE:

DATE:

07 AUGUST 2015

11 SEPTEMBER 2016

SCALE:


SHEET NO:

1:200

-



The drawings, concept and design contained are the properties of Military Engineers MNDFF. Use of any kind or copy of whole or part of this drawing, concept or design or use on other projects or sites other than that specified on this drawing is strictly prohibited.

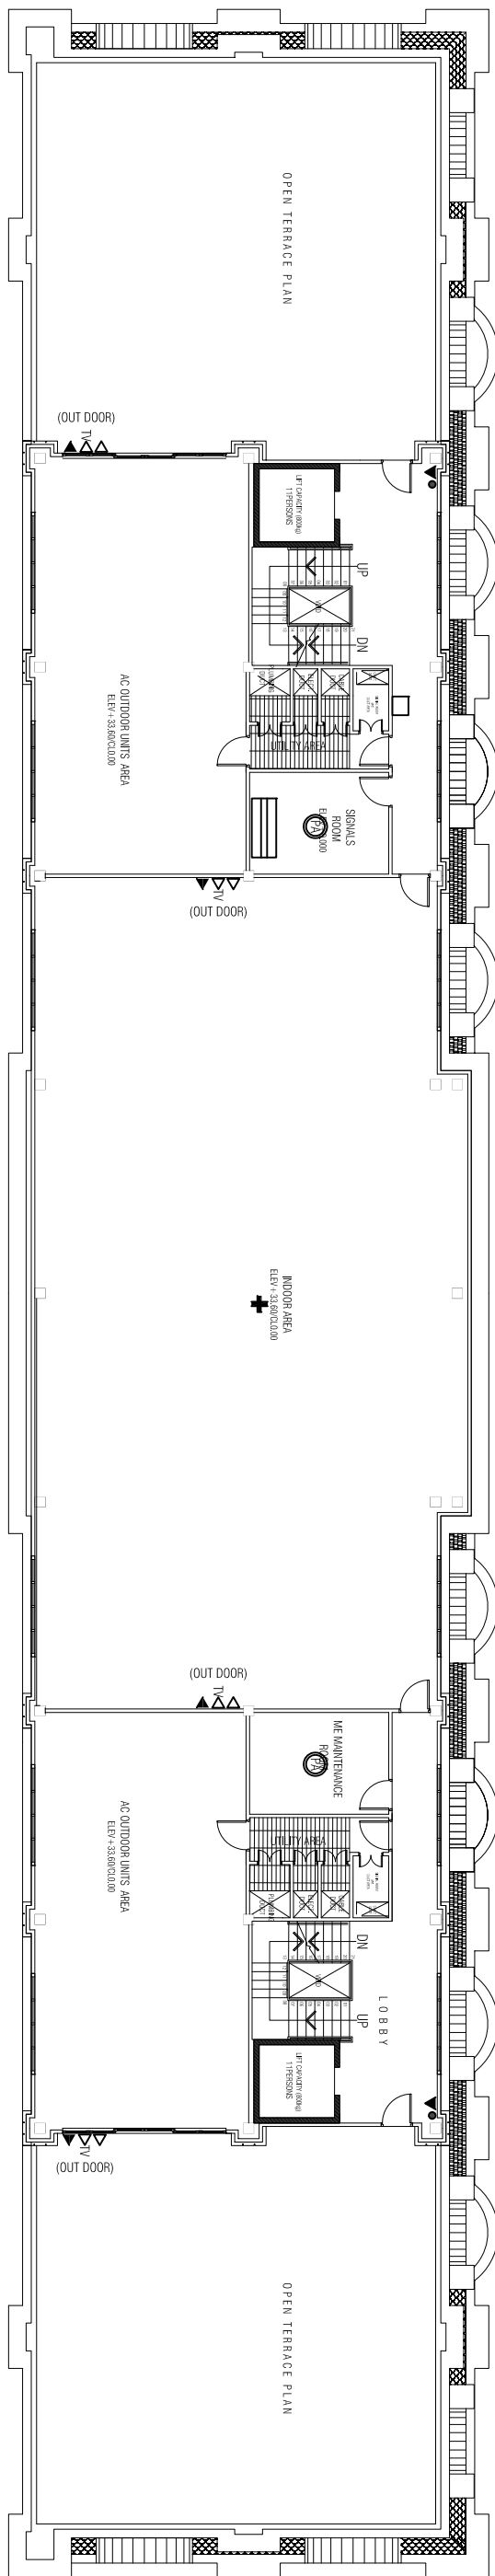

TERRACE FLOOR PLAN

SCALE 1:200

SYMBOL	QUANTITY	DESCRIPTION
DN	04	CATY OUTLET
UP	04	SINGLE CABLE NETWORK OUTLET
+	06	DUAL CABLE NETWORK OUTLET
+	01	WIFI AP
●	02	CCTV POINT
●	02	PAS SYSTEM
■	01	12 U NETWORK RACK

9 STOREY ACCOMMODATION BUILDING

BANDAAARA KOSHI / MALE

SHEET CONTENT:

DESIGN APPROVAL:

BRIG. GEN. AHMED SHAHID

VICE CHIEF OF DEFENCE FORCE

RECOM. APPROVAL:

CPT. AHMED SHARIM

OFFICER COMMANDING

APPROVED:

MAJ. GEN. AHMED SHIYAM

CHIEF OF DEFENCE FORCE

APPROVED DATE:

DESIGNED:

L.CPT. ALI MUTHASIM

PTE. M. SAIF ABDULLA

Architectural

WO1. AHMED SHAZEEL

Structural

CHECKED:

CPT. MOHAMED SHIFA'AU

Architectural

WO3. AMINATH ALI

Structural

Electrical & Mechanical

Communication

DRAWN:

REVISION:

L.CPT. ALI MUTHASIM

PTE. M. SAIF ABDULLA

Architectural

PTE. HUSSAIN GASIM

PTE. YAMIN SAEED

Structural

DATE:

DATE:

07 AUGUST 2015


11 SEPTEMBER 2016

SCALE:

SHEET NO:


1:200

-

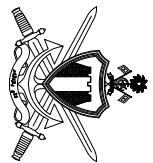


NATIONAL DEFENCE FORCE
MALDIVES
State, Republic of Maldives

The drawings, concept and design contained are the properties of Military Engineers MNDFF. Use of any kind or copy of whole or part of this drawing, concept or design or use on other projects or sites other than that specified on this drawing is strictly prohibited.

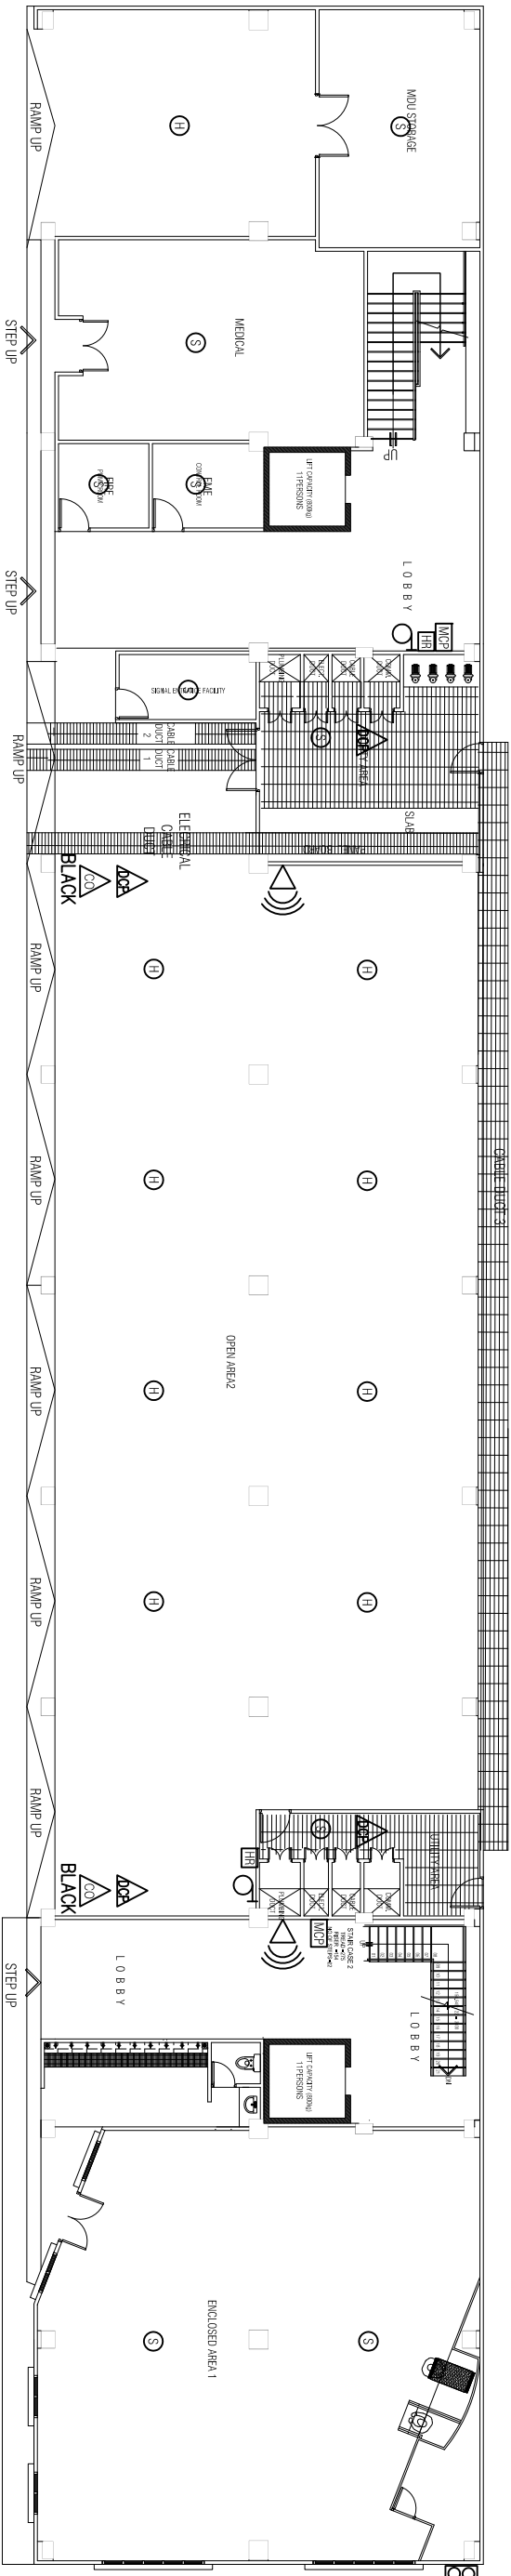

GROUND FLOOR PLAN
SCALE 1:200

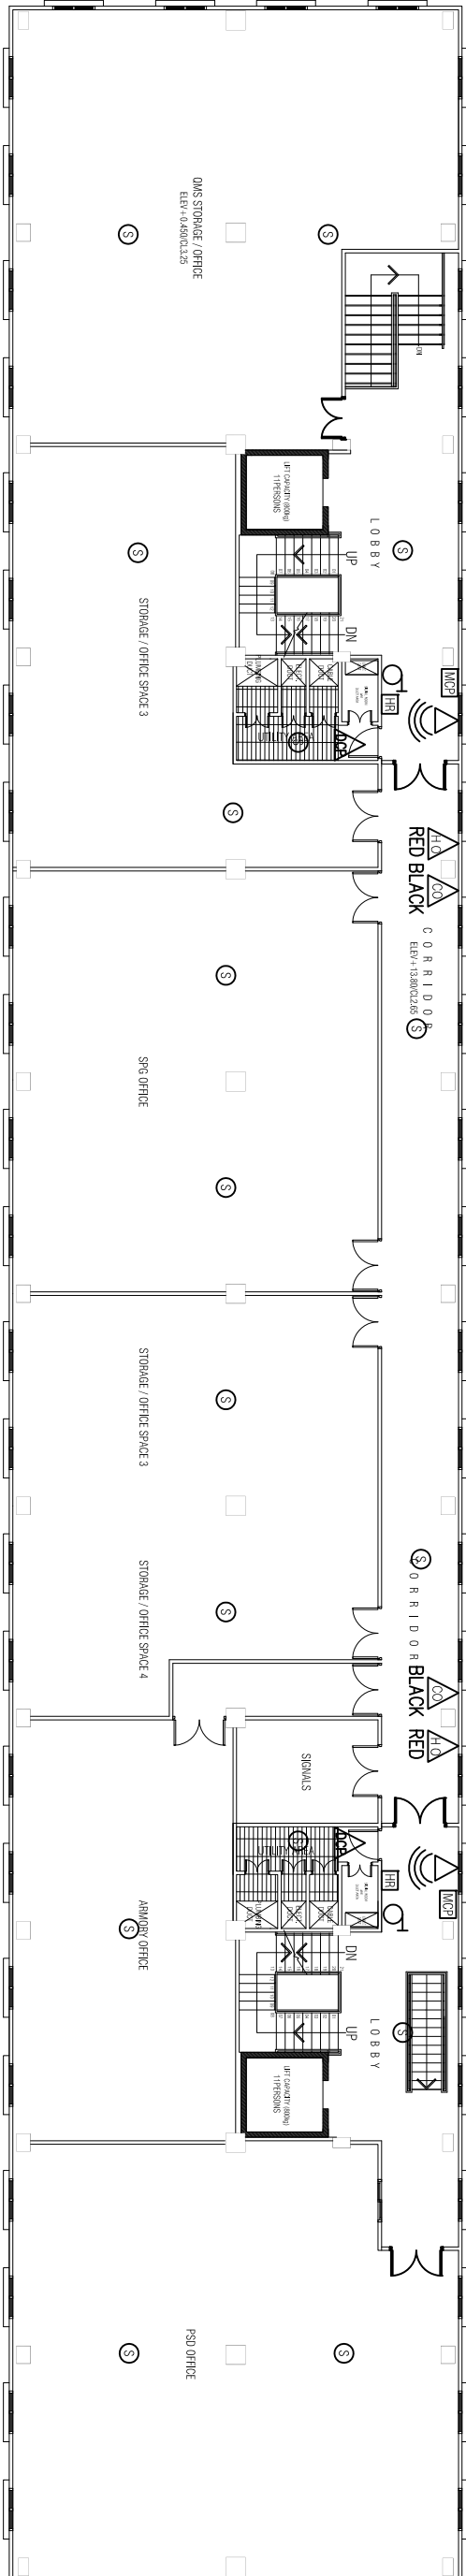

FIRST FLOOR PLAN
SCALE 1:200

LEGEND:
SYMBOL QUANTITY DESCRIPTION
GRND 1ST

09	00	HEAT DETECTOR
09	17	SMOKE DETECTOR
02	02	HOSE REEL (DOWN LENGTH) W/ HGT. APR. RELEASENG VALVE ON TOP FLOOR
02	02	MANUAL CALL POINT
02	02	CO2 (2M)
02	02	WATER
04	02	DRY CHEMICAL POWDER (8kg 100%)
02	02	SOUNDER STROBE
02	02	DRY RISER OUTLET W/ CABINET HOSE AND NOZZLE
01	00	DRY RISER INLET (NO) W/ BREEDING INLET WALL (NG)
00	03	FIRE DOOR (WIDTH 1000)
00	01	FIRE DOOR (WIDTH 1200)

9 STOREY ACCOMMODATION BUILDING

BANDARA KOSHI / MALE

SHEET CONTENT:

DESIGN APPROVAL:

BRIG. GEN. AHMED SHAHID

VICE CHIEF OF DEFENCE FORCE

RECOM. APPROVAL:

CPT. AHMED SHARIM

OFFICER COMMANDING

APPROVED:

MAJ. GEN. AHMED SHIYAM

CHIEF OF DEFENCE FORCE

APPROVED DATE:

DESIGNED:

L.CPT. AU MUTHASIM
PTE. M. SAIF ABDULLA

WO1. AHMED SHAZEEL

CHECKED:

CPT. MOHAMED SHIFA'AU
WO3. AMINATH AU

Architectural

Structural

Electrical & Mechanical

Communication

DRAWN:

REVISION:

L.CPT. AU MUTHASIM
PTE. M. SAIF ABDULLA

PTE. HUSSAIN GASIM
PTE. YAMIN SAEED

DATE:

DATE:

07 AUGUST 2015


11 SEPTEMBER 2016

SCALE:

SHEET NO:


1:200

-

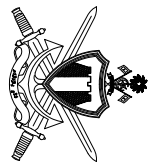


NATIONAL DEFENCE FORCE
MALDIVES
State, Republic of Maldives

The drawings, concept and design contained are the properties of Military Engineers MNDFF. Use of any kind or copy of whole or part of this drawing, concept or design or use on other projects or sites other than that specified on this drawing is strictly prohibited.

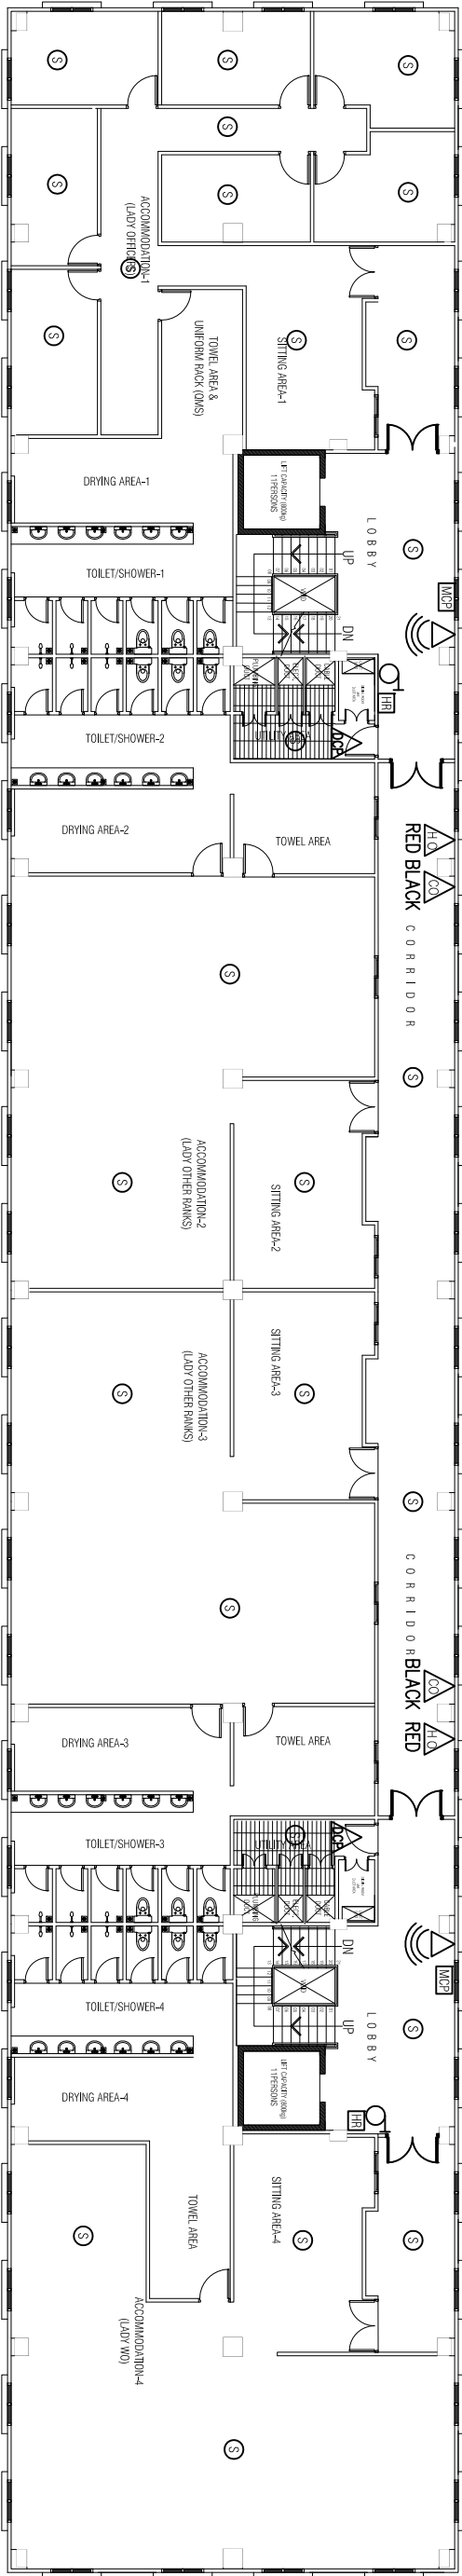

SECOND FLOOR PLAN
SCALE 1:200

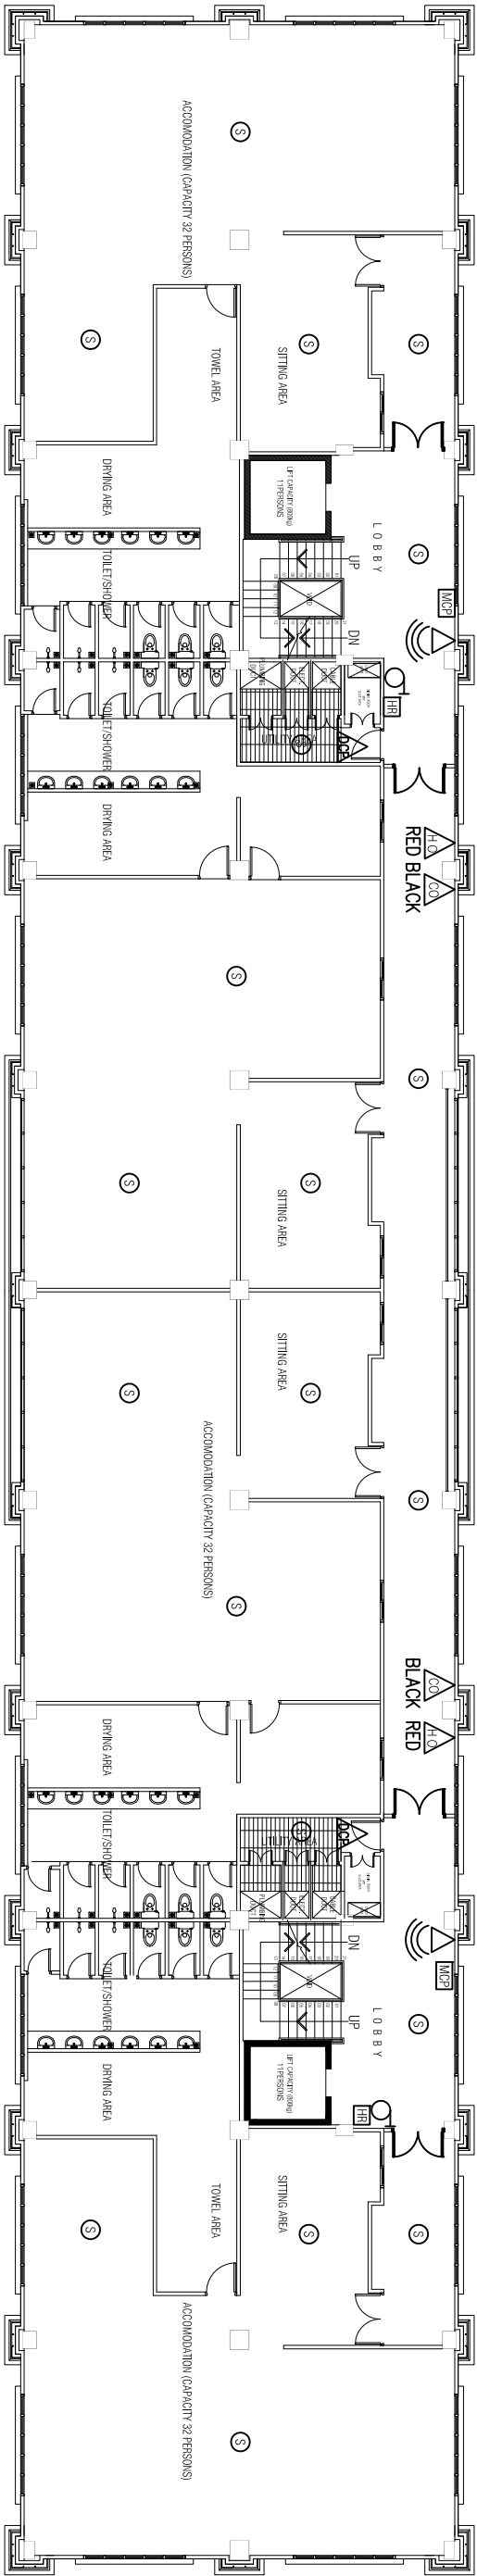

THIRD FLOOR PLAN
SCALE 1:200

LEGEND:

SYMBOL QUANTITY DESCRIPTION
2ND 3RD

26	20	SMOKE DETECTOR
02	02	HOSE REEL (30M LENGTH) W/OT AIR RELEASE VALVE ON TOP FLOOR
02	02	MANUAL CALL POINT
02	02	CO2 (2kg)
02	02	WATER
02	02	DRY CHEMICAL POWDER (8kg DOZ)
02	02	SOUNDER STROBE
02	02	DRY RISER INLET/NO WAY BREACHING INLET W/VALVE
04	04	FIRE DOOR (WIDTH 1500)

9 STOREY ACCOMMODATION BUILDING

BANDAAARA KOSHI / MALE

SHEET CONTENT:

DESIGN APPROVAL:

BRIG. GEN. AHMED SHAHID

VICE CHIEF OF DEFENCE FORCE

RECOM. APPROVAL:

CPT. AHMED SHARIM

OFFICER COMMANDING

APPROVED:

MAJ. GEN. AHMED SHIYAM

CHIEF OF DEFENCE FORCE

APPROVED DATE:

DESIGNED:

L.CPT. ALI MUTHASIM

PTE. M. SAIF ABDULLA

Architectural

WO1. AHMED SHAZEEL

Structural

CHECKED:

CPT. MOHAMED SHIFA'AU

Architectural

WO3. AMINATH ALI

Structural

Electrical & Mechanical

Communication

DRAWN:

L.CPT. ALI MUTHASIM

PTE. M. SAIF ABDULLA

DATE:


07 AUGUST 2015

11 SEPTEMBER 2016

SCALE:


SHEET NO:

1:200

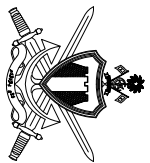


NATIONAL DEFENCE FORCE
MALDIVES
State, Republic of Maldives

The drawings, concept and design contained are the properties of Military Engineers MNDFF. Use of any kind or copy of whole or part of this drawing, concept or design or use on other projects or sites other than that specified on this drawing is strictly prohibited.

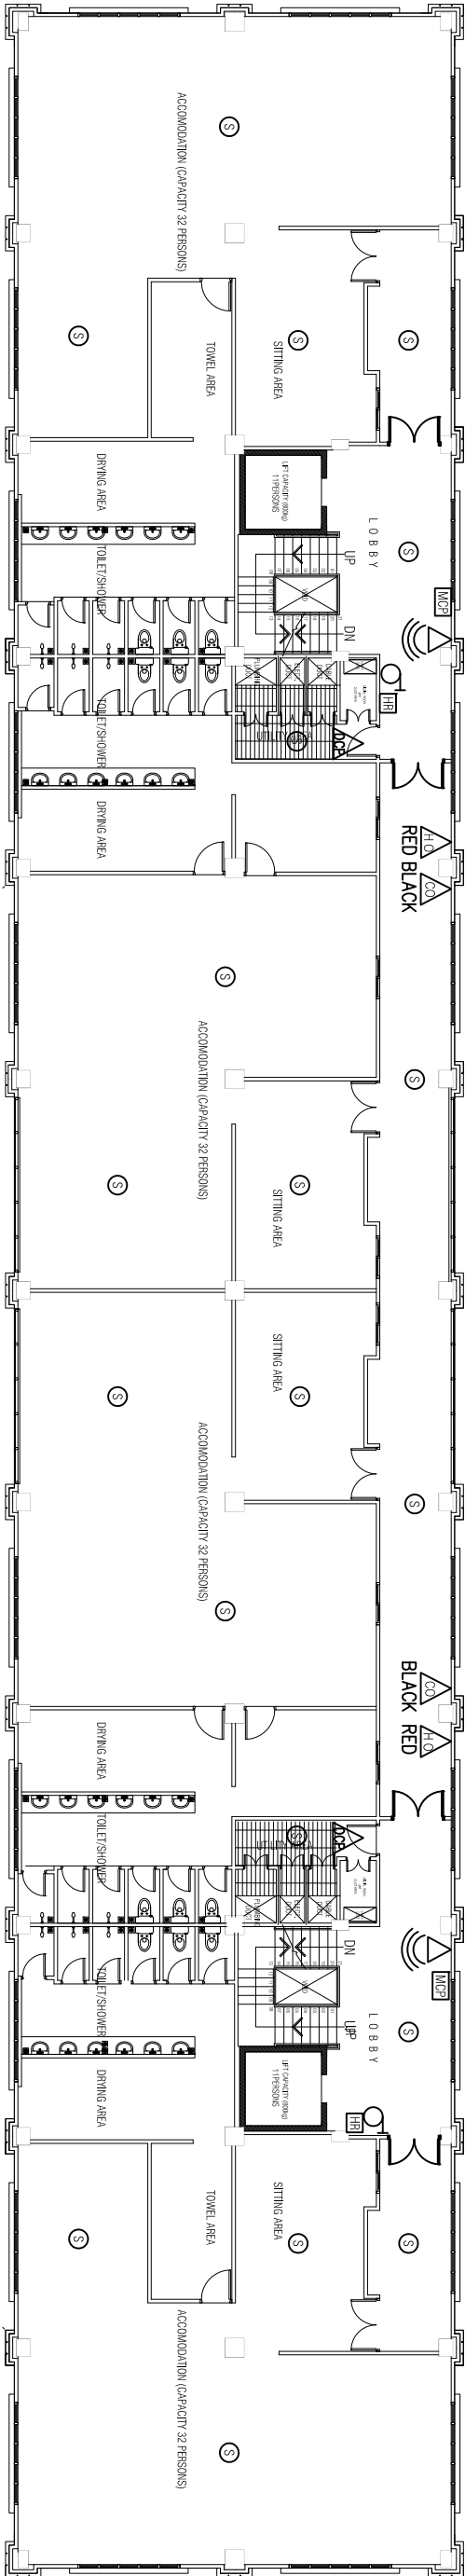

FORTH FLOOR PLAN

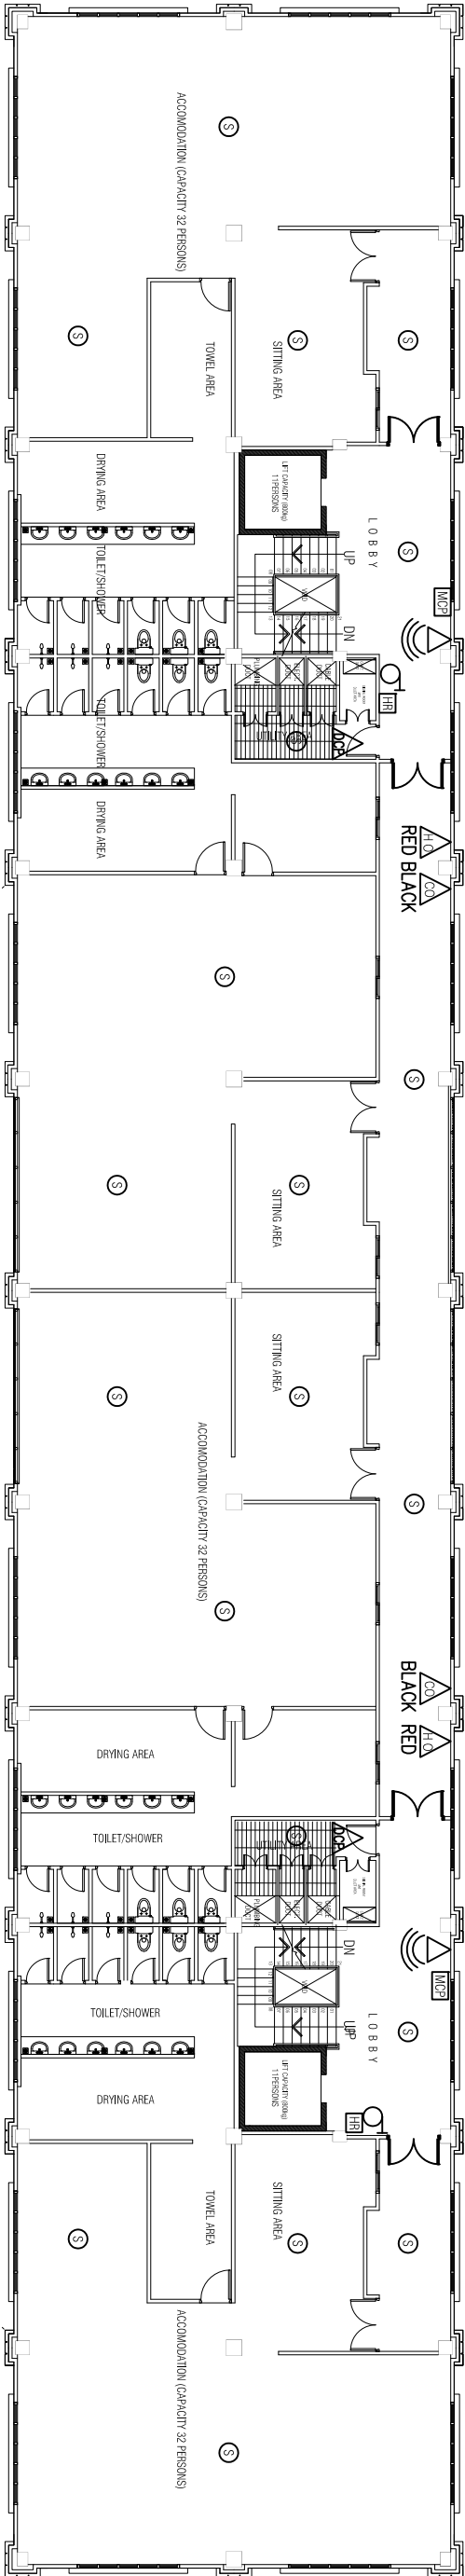

FIFTH & SIXTH FLOOR PLAN



LEGEND:

SYMBOL	QUANTITY	4TH	5TH	6TH	DESCRIPTION
③	20	20	20		SMOKE DETECTOR
③	02	02	02	02	HOSE REEL (30M LENGTH) W/ 40T BAR RELEASE VALVE ON TOP FLOOR
③	02	02	02	02	MANUAL CALL POINT
③	02	02	02	02	022 (2x0)
③	02	02	02	02	WATER
③	02	02	02	02	DRY CHEMICAL POWDER (8kg 027)
③	02	02	02	02	WATER
③	02	02	02	02	SMOKE SMOKE
③	02	02	02	02	DRY RISER INLET/NO WAY SPECTING INLET WALL/NO
③	04	04	04	04	FIRE DOOR (WIDTH 150)

9 STOREY ACCOMMODATION BUILDING

BANDAAARA KOSHI / MALE

SHEET CONTENT:

DESIGN APPROVAL:

BRIG. GEN. AHMED SHAHID

VICE CHIEF OF DEFENCE FORCE

RECOM. APPROVAL:

CPT. AHMED SHARIM

OFFICER COMMANDING

APPROVED:

MAJ. GEN. AHMED SHIYAM

CHIEF OF DEFENCE FORCE

APPROVED DATE:

DESIGNED:

L.CPL AU MUTHASIM

PTE. M. SAIF ABDULLA

Architectural

WO1. AHMED SHAZEEL

Structural

CHECKED:

CPT. MOHAMED SHIFA AU

Architectural

WO3. AMINATH AU

Structural

Electrical & Mechanical

Communication

DRAWN:

REVISION:

L.CPL AU MUTHASIM

PTE. M. SAIF ABDULLA

Architectural

PTE. HUSSAIN GASIM

PTE. YAMIN SAEED

DATE:

DATE:

07 AUGUST 2015

11 SEPTEMBER 2016

SCALE:

SHEET NO:


1:200

-




NATIONAL DEFENCE FORCE
MALDIVES
State, Republic of Maldives

The drawings, concept and design contained are the properties of Military Engineers MNDFF. Use of any kind or copy of whole or part of this drawing, concept or design or use on other projects or sites other than that specified on this drawing is strictly prohibited.

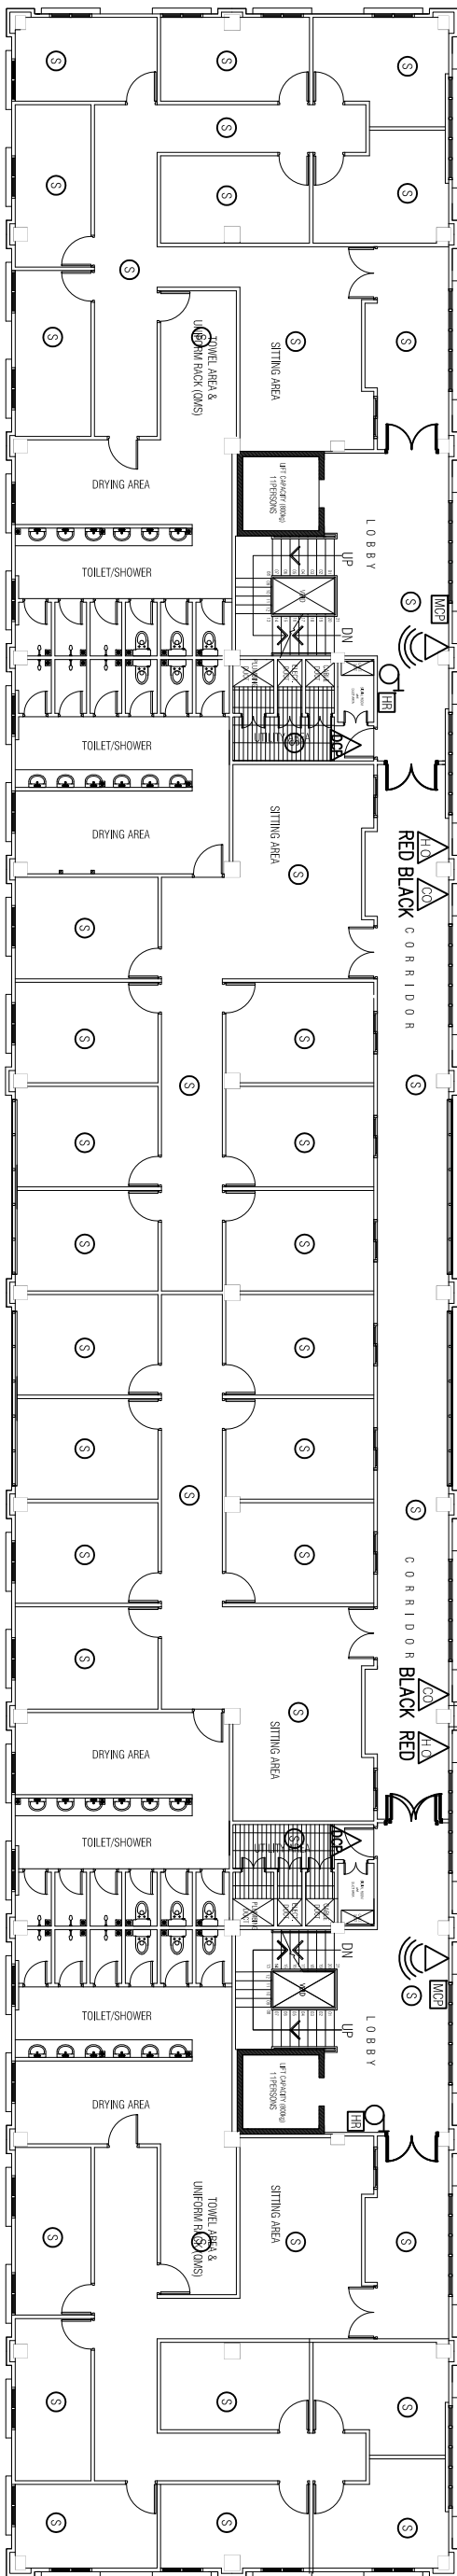

SEVENTH FLOOR PLAN

SCALE 1:200

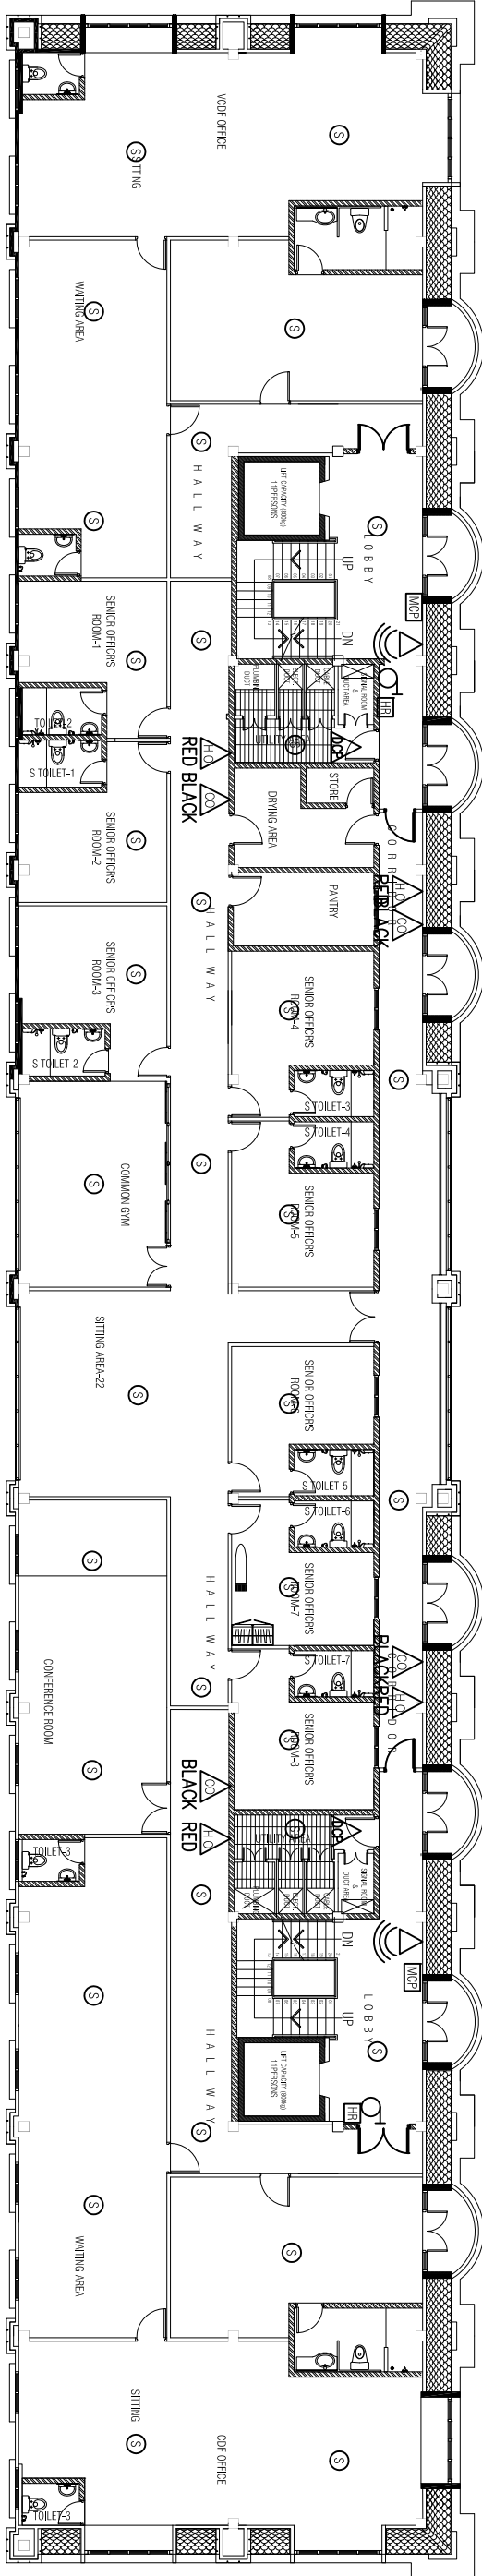

EIGHT FLOOR PLAN

SCALE 1:200

LEGEND:

SYMBOL QUANTITY DESCRIPTION

7TH 8TH

- 46

35

SMOKE DETECTOR
- 02

02

HOSE REEL (30M LENGTH)W/NOT AIR RELEASEING VALVEON TOP FLOOR
- 02

02

MANUAL DRILL POINT
- 04

04

CO2 (P90)
- 04

04

WATER
- 02

02

DRY CHEMICAL POWDER (9kg 1027)
- 02

02

SAWKER STORAGE
- 02

02

DRY RESIN INLET TWO WAY BREECHING INLET W/WALL AR
- 04

02

FIRE DOOR (WIDTH 1500)
- 00

02

FIRE DOOR (WIDTH 900)

9 STOREY ACCOMMODATION BUILDING

BANDAAARA KOSHI / MALE

SHEET CONTENT:

DESIGN APPROVAL:

BRIG. GEN. AHMED SHAHID

VICE CHIEF OF DEFENCE FORCE

RECOM. APPROVAL:

CPT. AHMED SHARIM

OFFICER COMMANDING

APPROVED:

MAJ. GEN. AHMED SHIYAM

CHIEF OF DEFENCE FORCE

APPROVED DATE:

DESIGNED:

L.CPT. AUI MUTHASIM

PTE. M. SAIF ABDULLA

Architectural

WO1. AHMED SHAZEEL

Structural

CHECKED:

CPT. MOHAMED SHIFA'AU

Architectural

WO3. AMINATH AUI

Structural

Electrical & Mechanical

Communication

DRAWN:

REVISION:

L.CPT. AUI MUTHASIM

PTE. M. SAIF ABDULLA

Architectural

PTE. HUSSAIN GASIM

PTE. YAMIN SAEED

DATE:

DATE:

07 AUGUST 2015


11 SEPTEMBER 2016

SCALE:

SHEET NO:

1:200

-

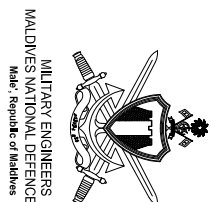

The drawings, concept and design contained are the properties of Military Engineers MNDFF. Use of any kind or copy of whole or part of this drawing, concept or design or use on other projects or sites other than that specified on this drawing is strictly prohibited.