

LEGEND

MOTOR PUMP

GATE VALVE

WATER METER


MWSC SUPPLY

GROUNDWATER SUPPLY

SEWAGE DISPOSAL

IC

INSPECTION CHAMBER

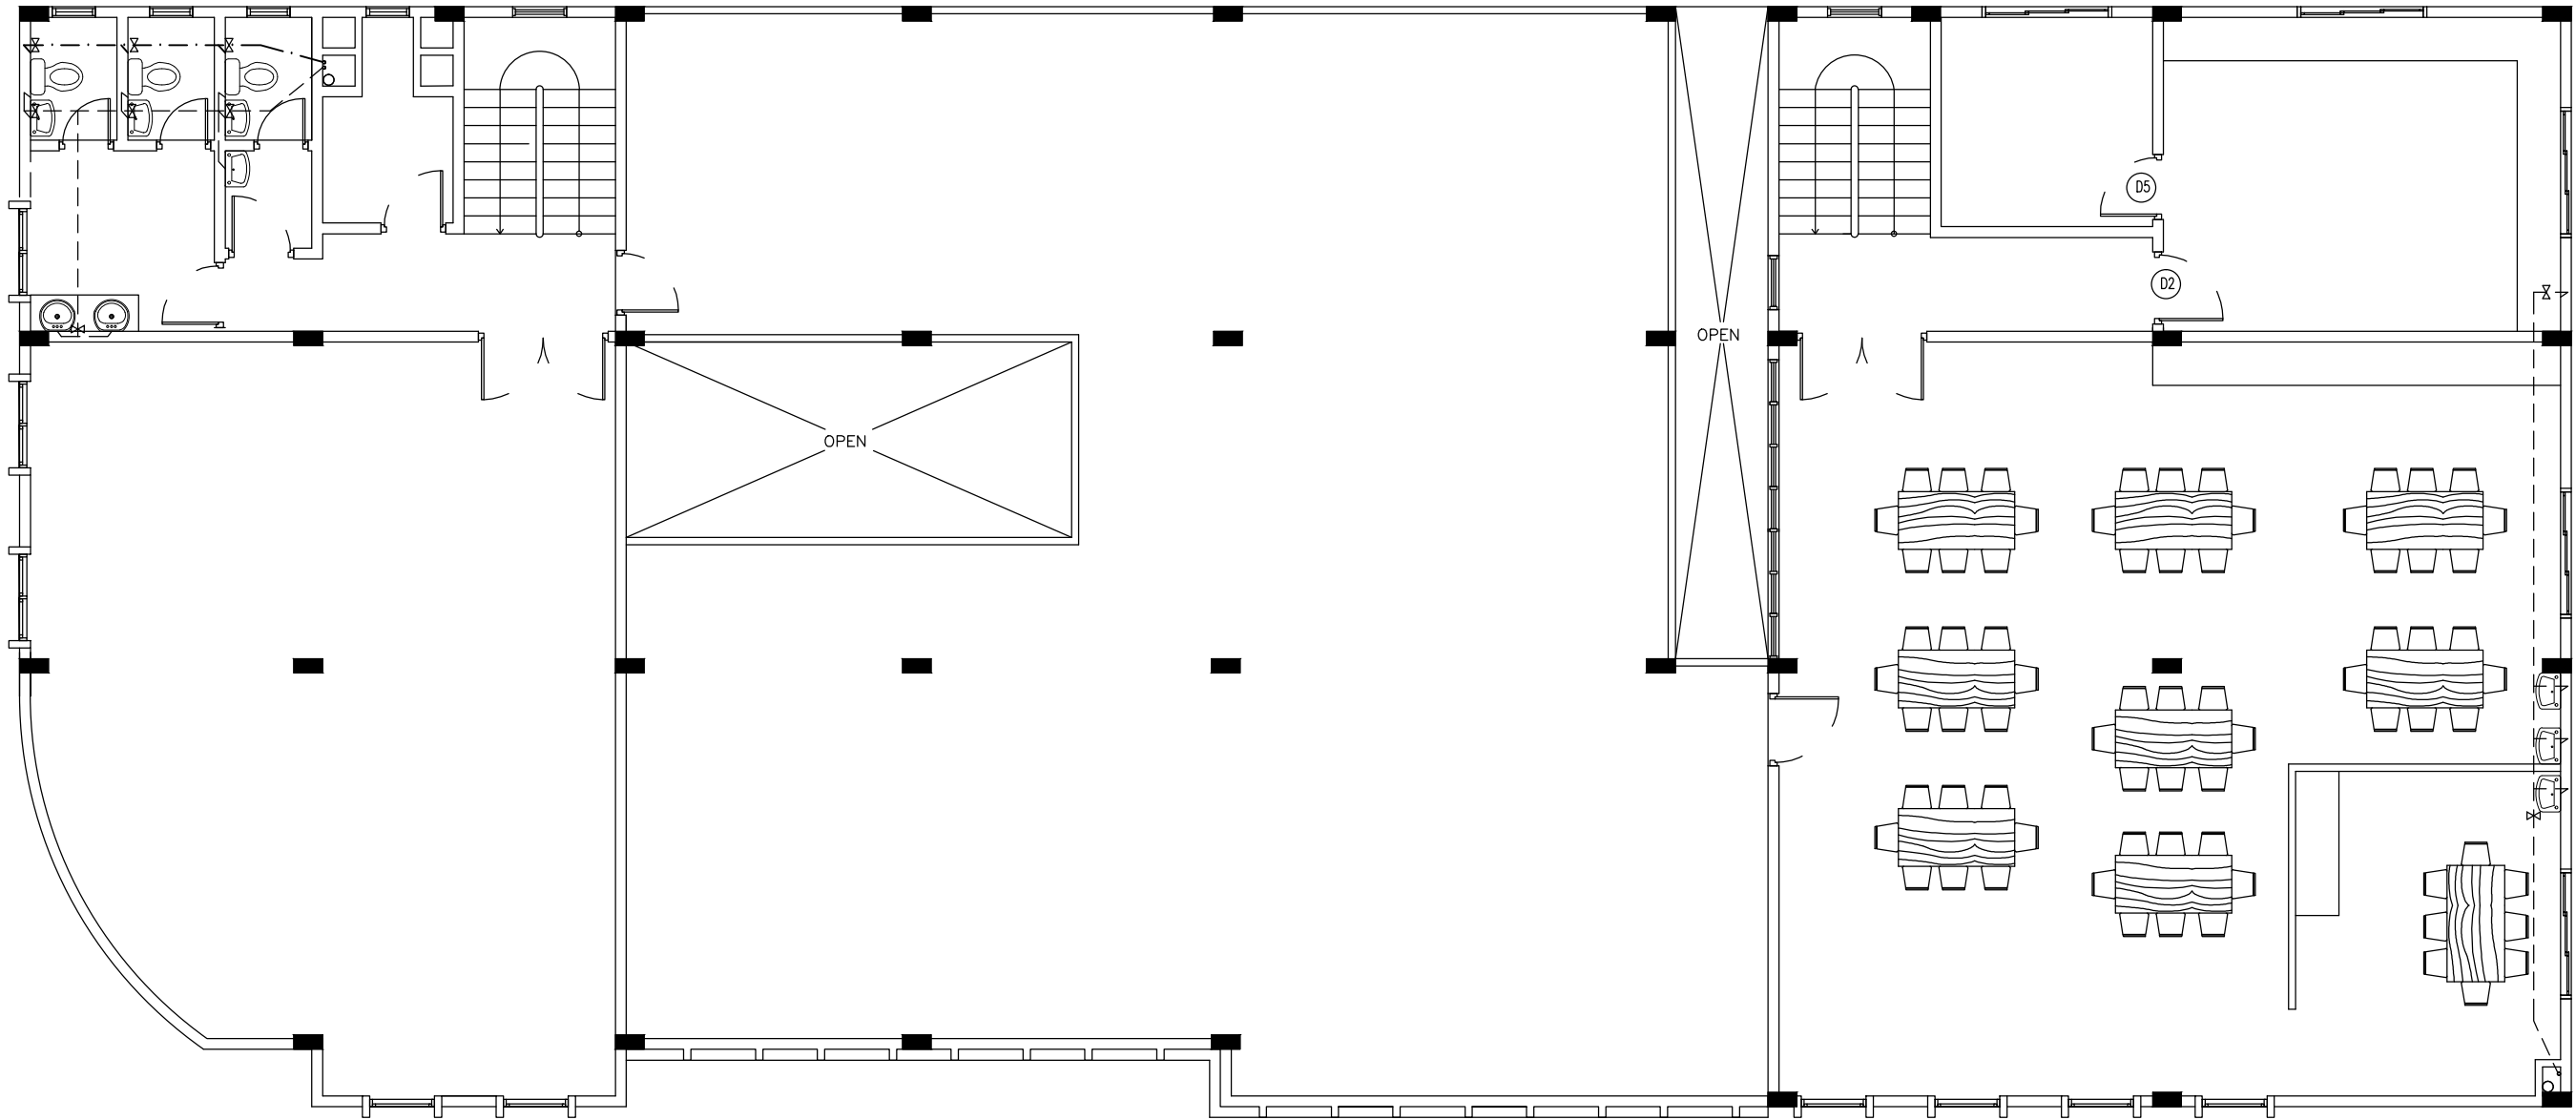

TERRACE FLOOR PLAN

SCALE 1:100

<div><div><div></div></div><div>INFRASTRUCTURE UNIT</div><div>FINANCE DEPARTMENT</div><div>MALDIVES POLICE SERVICE</div><div>MALE' REPUBLIC OF MALDIVES</div></div>	PROJECT TITLE	RECOMMENDATION APPROVED BY	DESIGN APPROVED BY	APPROVED BY	ARCHITECT / DESIGNER	DRAWN BY	DATE	DRAWING NO
	HULHUMALE' POLICE STATION NEIGHBORHOOD - 1	<div>ISMAIL NAVEEN</div> <div>CHIEF SUPERINTENDENT OF POLICE</div>	<div>AZEEM WAHEED</div> <div>CHIEF INSPECTOR OF POLICE</div>	<div>AHMED MOHAMED</div> <div>CHIEF SUPERINTENDENT OF POLICE</div>	<div>ISMAIL RAFAEU</div> <div>POLICE STAFF SERGEANT</div> <div>STRUCTURAL ENGINEER</div> <div>RAMEEZ</div> <div>ADEPT MALDIVES PVT LTD</div>	<div>ISMAIL RAFAEU</div> <div>POLICE STAFF SERGEANT</div> <div>CHECKED BY</div> <div>ABDUL WAHID MOHAMED</div> <div>ADEPT MALDIVES PVT LTD</div>	<div>15 - 02 - 2015</div> <div>REVISED DATE</div>	<div>SHEET NO</div>

The drawings, concept and design contained are the properties of Maldives Police Service. Use of any kind of copy of whole or part of this drawing, concept or design or use on other projects or sites other than that specified on this drawing is strictly prohibited.