

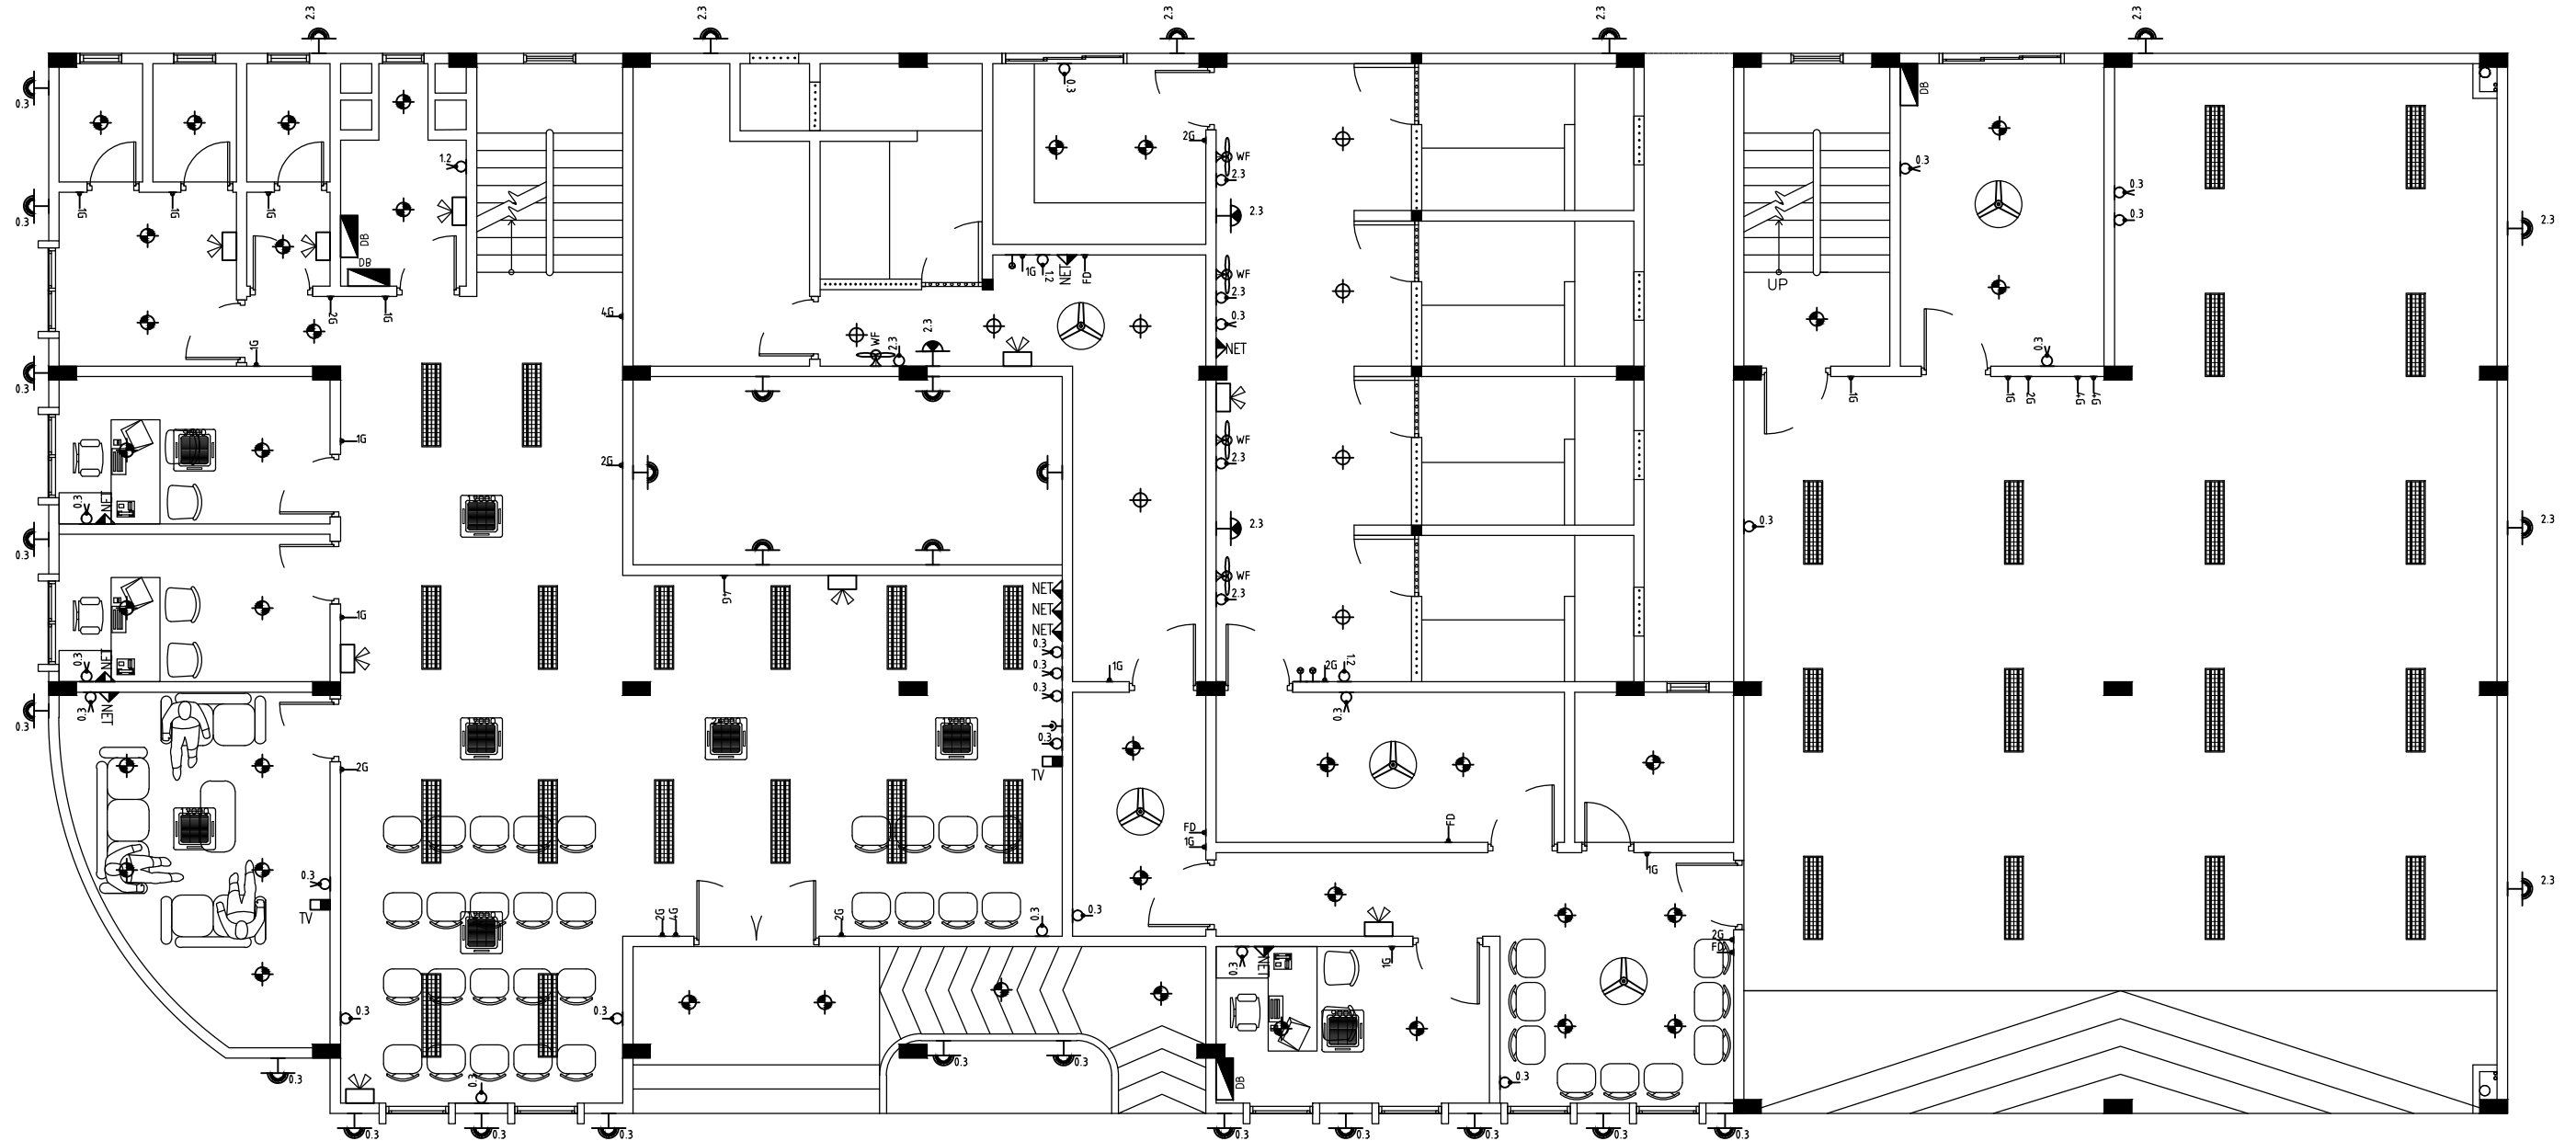
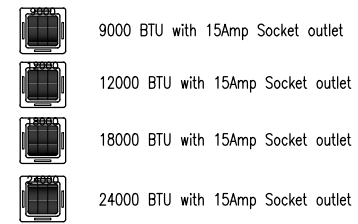
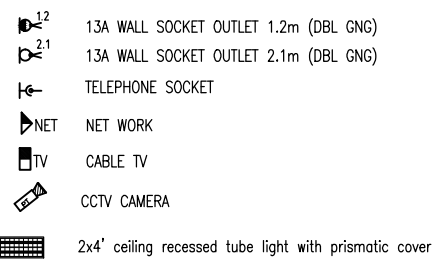


## ELECTRICAL LEGEND

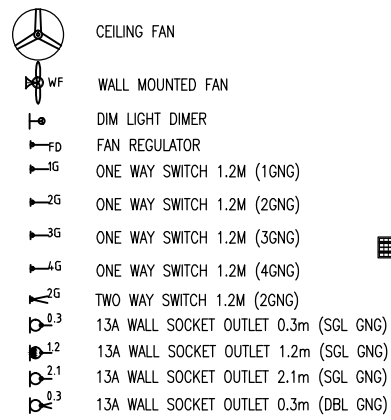

## GROUND FLOOR PLAN

SCALE 1:100

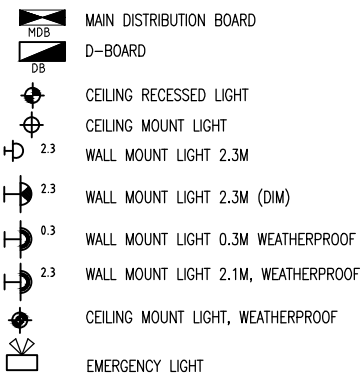

INFRASTRUCTURE UNIT  
FINANCE DEPARTMENT  
MALDIVES POLICE SERVICE  
MALE' REPUBLIC OF MALDIVES

## PROJECT TITLE

HULHUMALE' POLICE STATION  
NEIGHBORHOOD - 1

## RECOMMENDATION APPROVED BY

ISMAIL NAVEEN  
CHIEF SUPERINTENDENT OF POLICE

## DESIGN APPROVED BY

AZEEM WAHEED  
CHIEF INSPECTOR OF POLICE

## APPROVED BY

AHMED MOHAMED  
CHIEF SUPERINTENDENT OF POLICE

## ARCHITECT / DESIGNER

ISMAIL RAFAEU  
POLICE STAFF SERGEANT

## STRUCTURAL ENGINEER

RAMEEZ  
ADEPT MALDIVES PVT LTD

## DRAWN BY

ISMAIL RAFAEU  
POLICE STAFF SERGEANT

## CHECKED BY

ABDUL WAHID MOHAMED  
ADEPT MALDIVES PVT LTD

## DATE

15 - 02 - 2015

## REVISED DATE

## DRAWING NO

A 03

## SHEET NO

03/26

The drawings, concept and design contained are the properties of Maldives Police Service. Use of any kind of copy of whole or part of this drawing, concept or design or use on other projects or sites other than that specified on this drawing is strictly prohibited.