


ELECTRICAL LEGEND

- MAIN DISTRIBUTION BOARD
- D-BBOARD
- CEILING RECESSED LIGHT
- CEILING MOUNT LIGHT
- WALL MOUNT LIGHT 2.3M
- WALL MOUNT LIGHT 2.3M (DIM)
- WALL MOUNT LIGHT 0.3M WEATHERPROOF
- WALL MOUNT LIGHT 2.1M, WEATHERPROOF
- CEILING MOUNT LIGHT, WEATHERPROOF
- EMERGENCY LIGHT

- CEILING FAN
- WALL MOUNTED FAN
- DIM LIGHT DIMER
- FAN REGULATOR
- ONE WAY SWITCH 1.2M (1GNG)
- ONE WAY SWITCH 1.2M (2GNG)
- ONE WAY SWITCH 1.2M (3GNG)
- ONE WAY SWITCH 1.2M (4GNG)
- TWO WAY SWITCH 1.2M (2GNG)
- 13A WALL SOCKET OUTLET 0.3m (SGL GNG)
- 13A WALL SOCKET OUTLET 1.2m (SGL GNG)
- 13A WALL SOCKET OUTLET 2.1m (SGL GNG)
- 13A WALL SOCKET OUTLET 0.3m (DBL GNG)


- 13A WALL SOCKET OUTLET 1.2m (DBL GNG)
- 13A WALL SOCKET OUTLET 2.1m (DBL GNG)
- TELEPHONE SOCKET
- NET WORK
- CABLE TV
- CCTV CAMERA
- 2x4' ceiling recessed tube light with prismatic cover

- 9000 BTU with 15Amp Socket outlet
- 12000 BTU with 15Amp Socket outlet
- 18000 BTU with 15Amp Socket outlet
- 24000 BTU with 15Amp Socket outlet

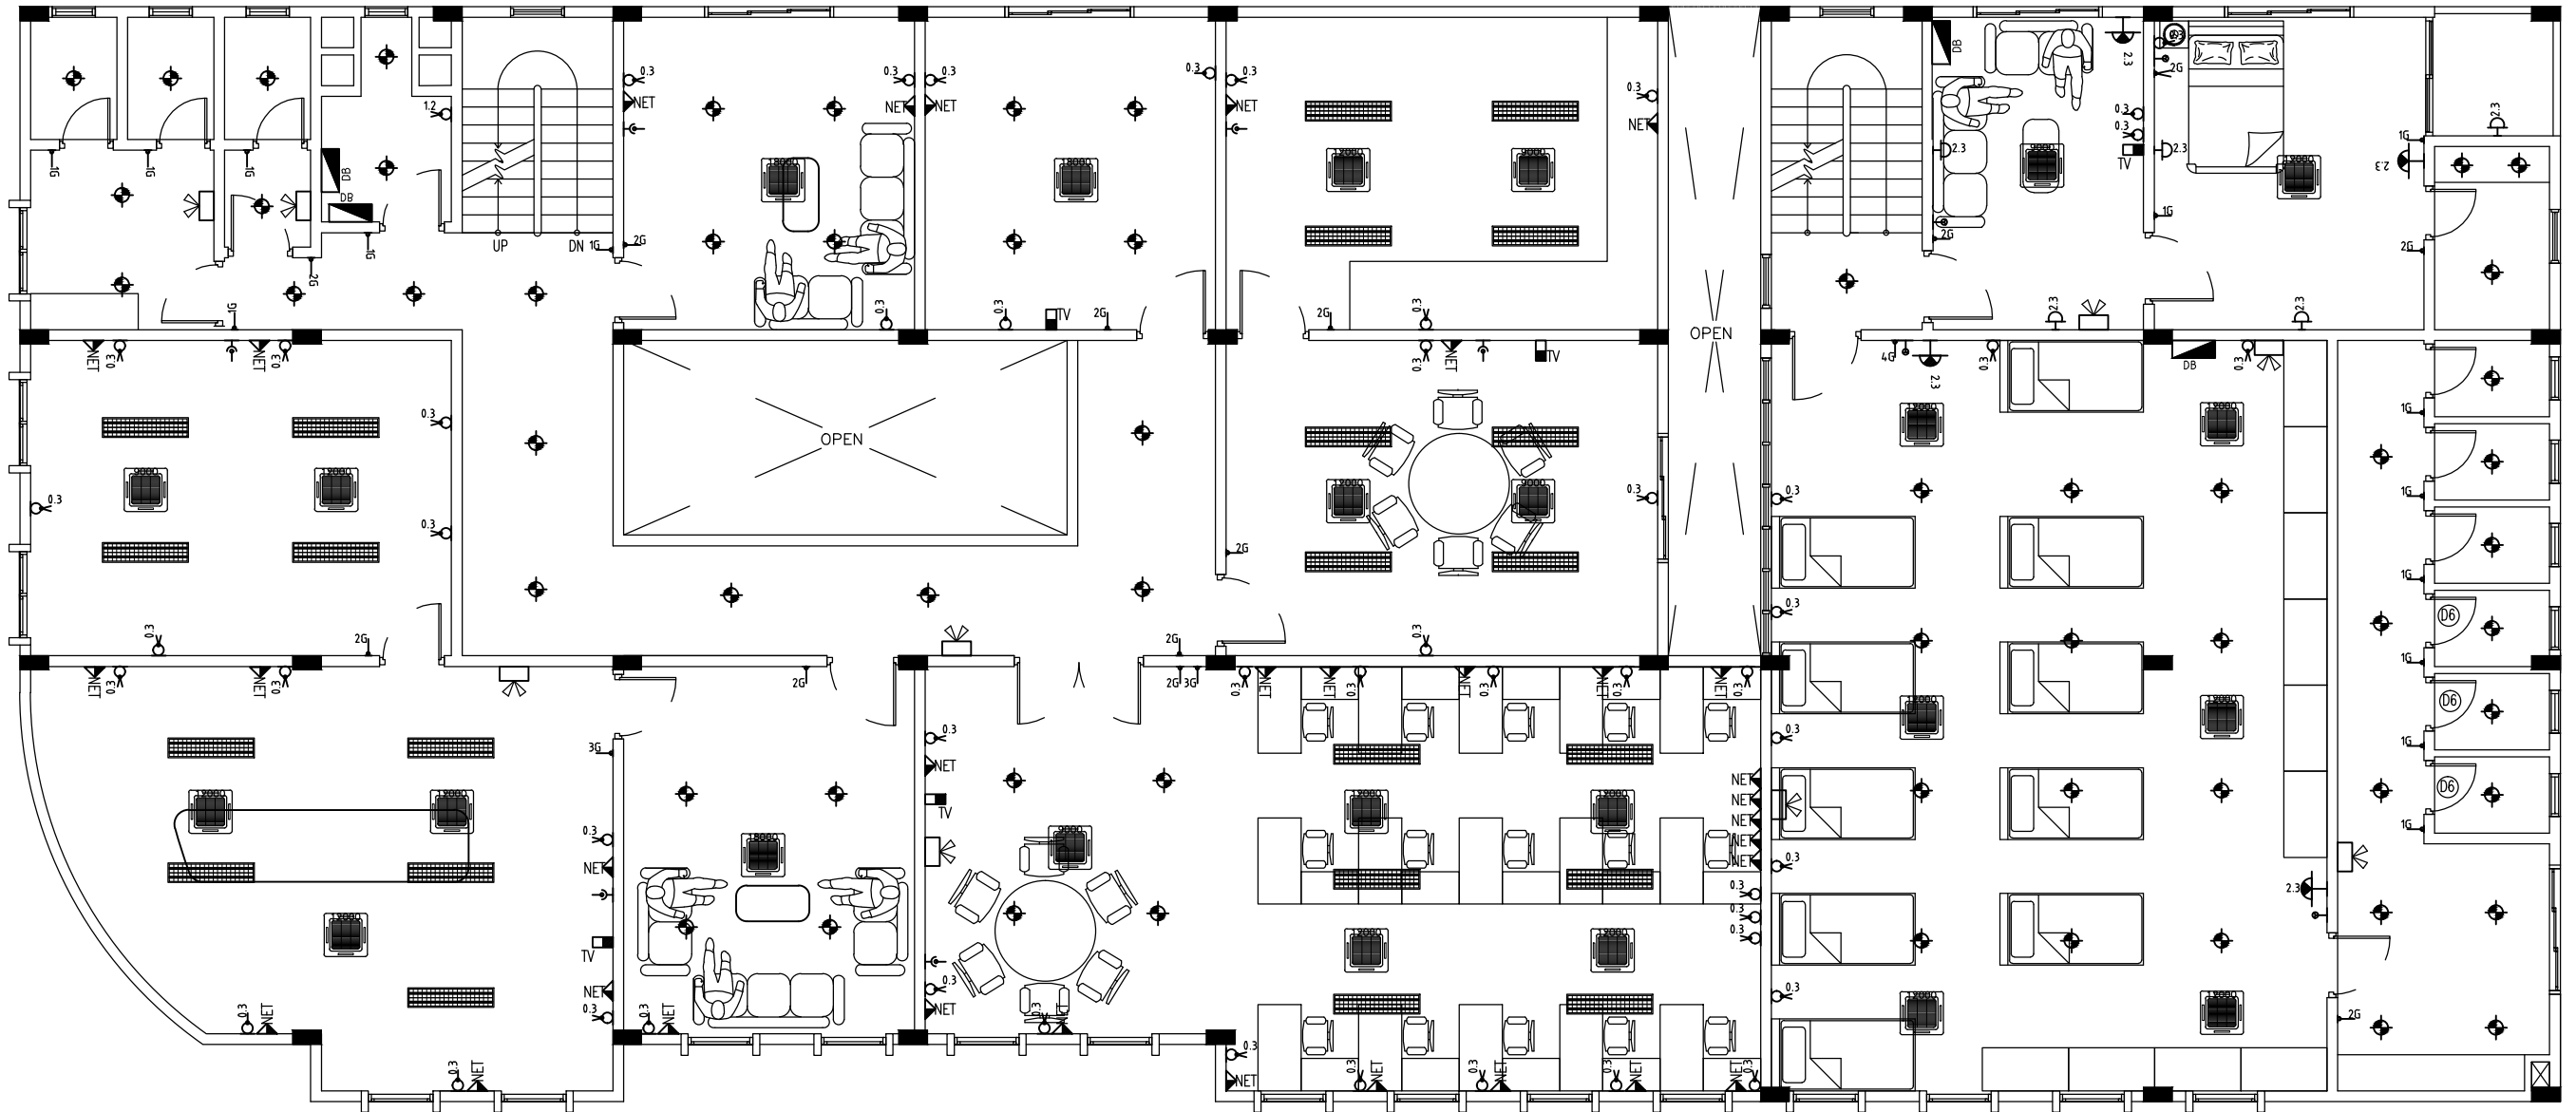

FIRST FLOOR PLAN

SCALE 1:100

| | | | | | | | | |
|--|---|---|---|--|---|---|--|---|
|  INFRASTRUCTURE UNIT FINANCE DEPARTMENT MALDIVES POLICE SERVICE MALE' REPUBLIC OF MALDIVES | PROJECT TITLE HULHUMALE' POLICE STATION NEIGHBORHOOD - 1 | RECOMMENDATION APPROVED BY ISMAIL NAVEEN CHIEF SUPERINTENDENT OF POLICE | DESIGN APPROVED BY AZEEM WAHEED CHIEF INSPECTOR OF POLICE | APPROVED BY AHMED MOHAMED CHIEF SUPERINTENDENT OF POLICE | ARCHITECT / DESIGNER ISMAIL RAFAEU POLICE STAFF SERGEANT STRUCTURAL ENGINEER RAMEEZ ADEPT MALDIVES PVT LTD | DRAWN BY ISMAIL RAFAEU POLICE STAFF SERGEANT CHECKED BY ABDUL WAHID MOHAMED ADEPT MALDIVES PVT LTD | DATE 15 - 02 - 2015 REVISED DATE | DRAWING NO A 04 SHEET NO 04/26 |
|--|---|---|---|--|---|---|--|---|

The drawings, concept and design contained are the properties of Maldives Police Service. Use of any kind of copy of whole or part of this drawing, concept or design or use on other projects or sites other than that specified on this drawing is strictly prohibited.