


ELECTRICAL LEGEND

- MAIN DISTRIBUTION BOARD
D-BBOARD
CEILING RECESSED LIGHT
CEILING MOUNT LIGHT
WALL MOUNT LIGHT 2.3M
WALL MOUNT LIGHT 2.3M (DIM)
WALL MOUNT LIGHT 0.3M WEATHERPROOF
WALL MOUNT LIGHT 2.1M, WEATHERPROOF
CEILING MOUNT LIGHT, WEATHERPROOF
EMERGENCY LIGHT

- CEILING FAN
WALL MOUNTED FAN
DIM LIGHT DIMER
FAN REGULATOR
ONE WAY SWITCH 1.2M (1GNG)
ONE WAY SWITCH 1.2M (2GNG)
ONE WAY SWITCH 1.2M (3GNG)
ONE WAY SWITCH 1.2M (4GNG)
TWO WAY SWITCH 1.2M (2GNG)
13A WALL SOCKET OUTLET 0.3m (SGL GNG)
13A WALL SOCKET OUTLET 1.2m (SGL GNG)
13A WALL SOCKET OUTLET 2.1m (SGL GNG)
13A WALL SOCKET OUTLET 0.3m (DBL GNG)


- 13A WALL SOCKET OUTLET 1.2m (DBL GNG)
13A WALL SOCKET OUTLET 2.1m (DBL GNG)
TELEPHONE SOCKET
NET WORK
CABLE TV
CCTV CAMERA
2x4' ceiling recessed tube light with prismatic cover

- 9000 BTU with 15Amp Socket outlet
12000 BTU with 15Amp Socket outlet
18000 BTU with 15Amp Socket outlet
24000 BTU with 15Amp Socket outlet

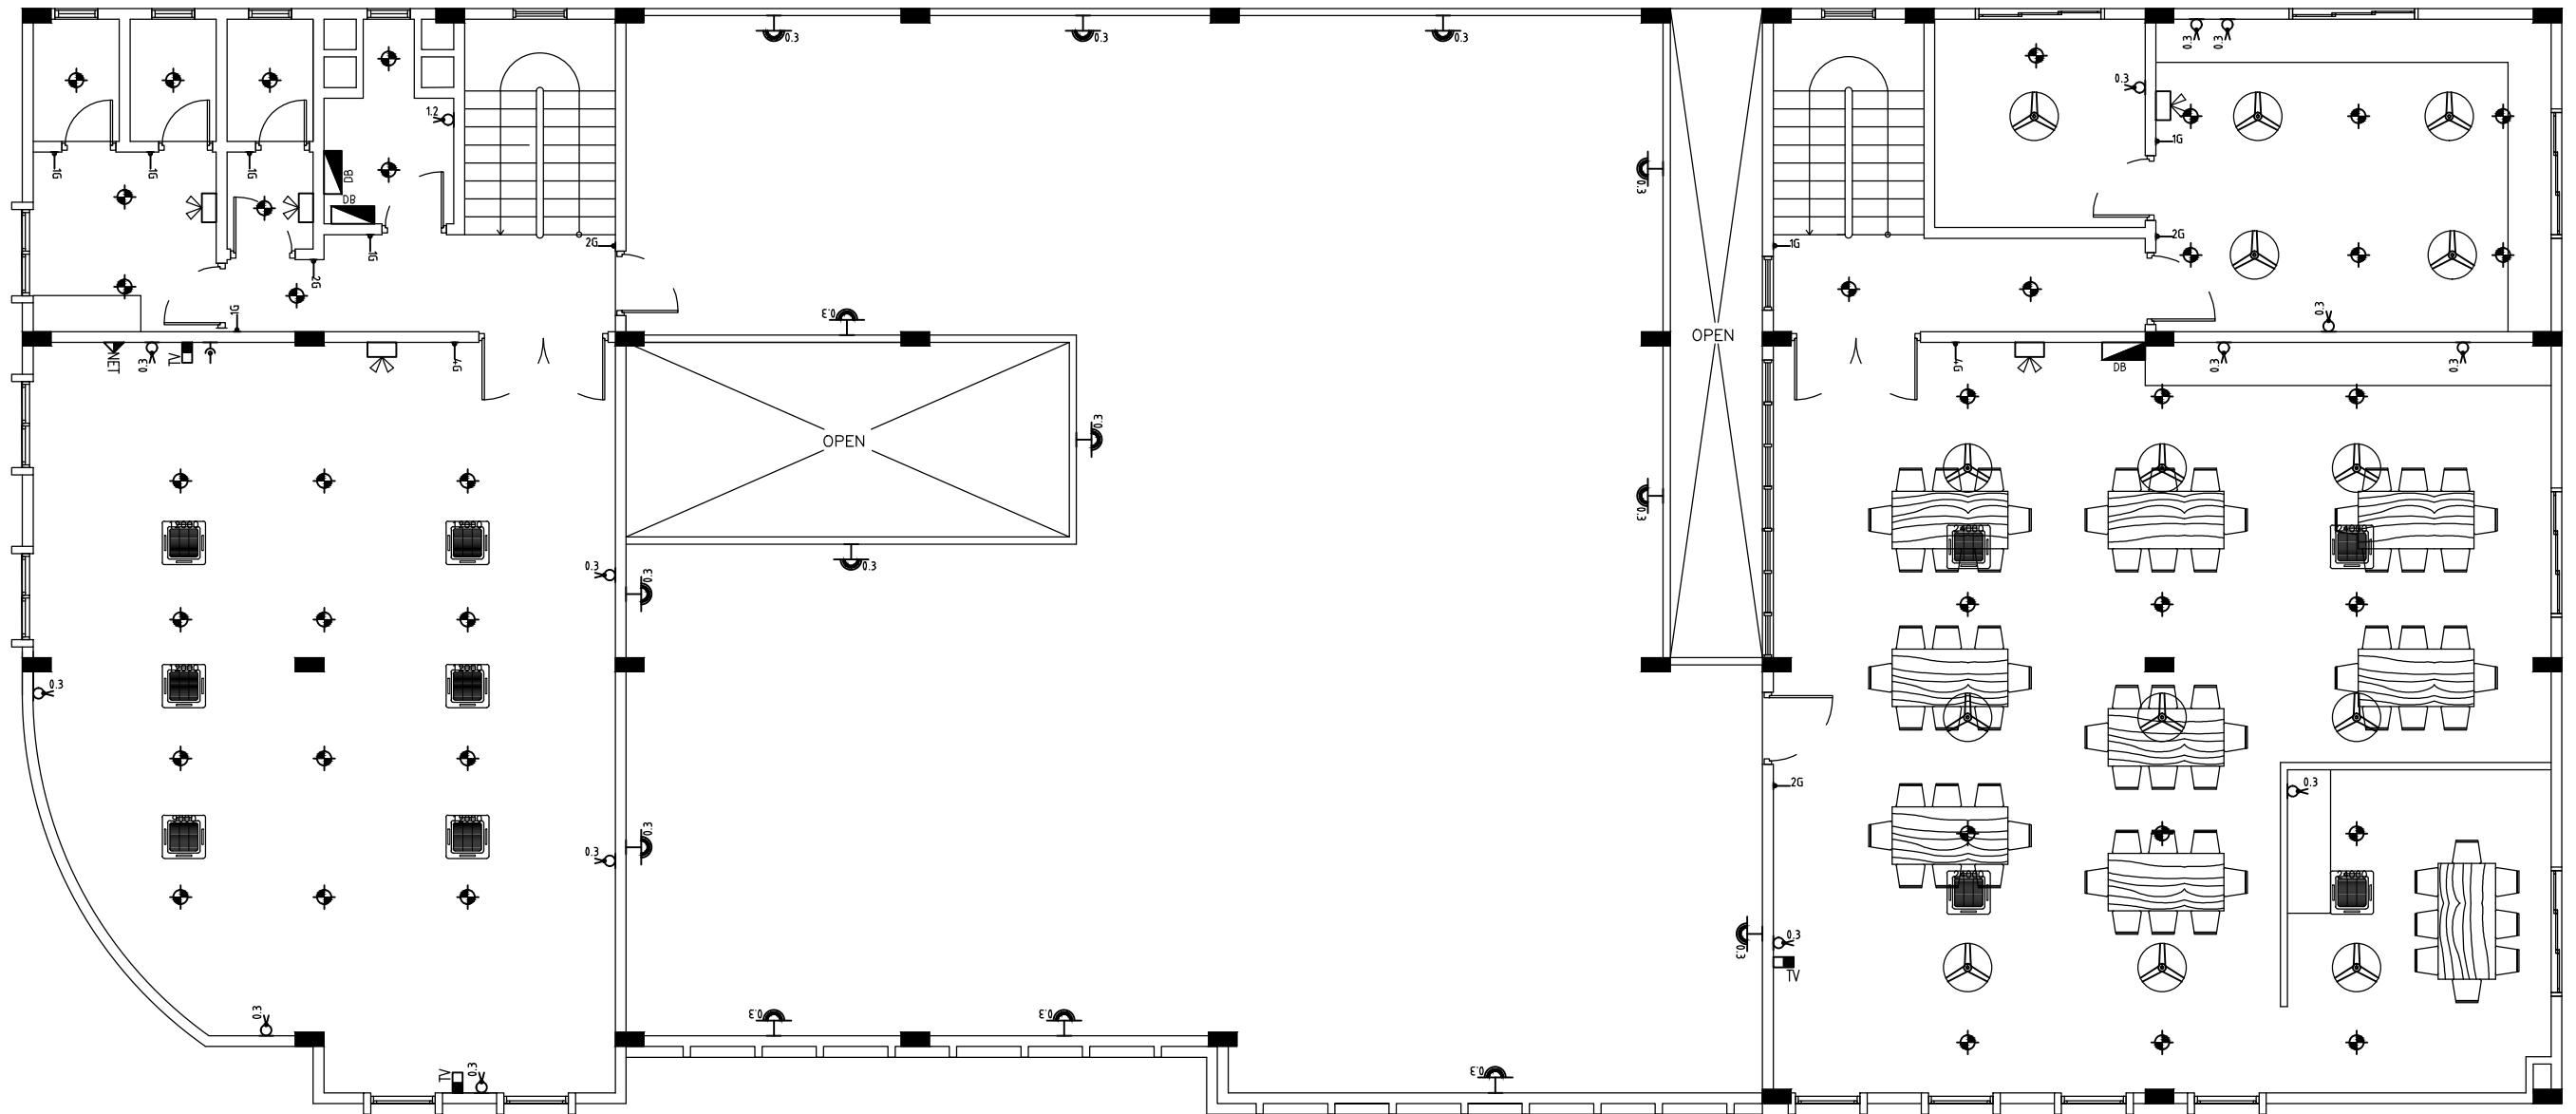

TERRACE FLOOR PLAN

SCALE 1:100

 INFRASTRUCTURE UNIT FINANCE DEPARTMENT MALDIVES POLICE SERVICE MALE' REPUBLIC OF MALDIVES	PROJECT TITLE HULHUMALE' POLICE STATION NEIGHBORHOOD - 1	RECOMMENDATION APPROVED BY ISMAIL NAVEEN CHIEF SUPERINTENDENT OF POLICE	DESIGN APPROVED BY AZEEM WAHEED CHIEF INSPECTOR OF POLICE	APPROVED BY AHMED MOHAMED CHIEF SUPERINTENDENT OF POLICE	ARCHITECT / DESIGNER ISMAIL RAFAEU POLICE STAFF SERGEANT STRUCTURAL ENGINEER RAMEEZ ADEPT MALDIVES PVT LTD	DRAWN BY ISMAIL RAFAEU POLICE STAFF SERGEANT CHECKED BY ABDUL WAHID MOHAMED ADEPT MALDIVES PVT LTD	DATE 15 - 02 - 2015 REVISED DATE	DRAWING NO A 06 SHEET NO 06/26

The drawings, concept and design contained are the properties of Maldives Police Service. Use of any kind of copy of whole or part of this drawing, concept or design or use on other projects or sites other than that specified on this drawing is strictly prohibited.