


HA. HOARAFUSHI HOSPITAL | SERVICE BUILDING

CLIENT: MINISTRY OF HEALTH


DESIGN : SURVEY , DESIGN AND DEVELOPMENT SECTION | MTCC PLC

DATE: 10 MAY 2020

LOCATION: HA.HOARAFUSHI

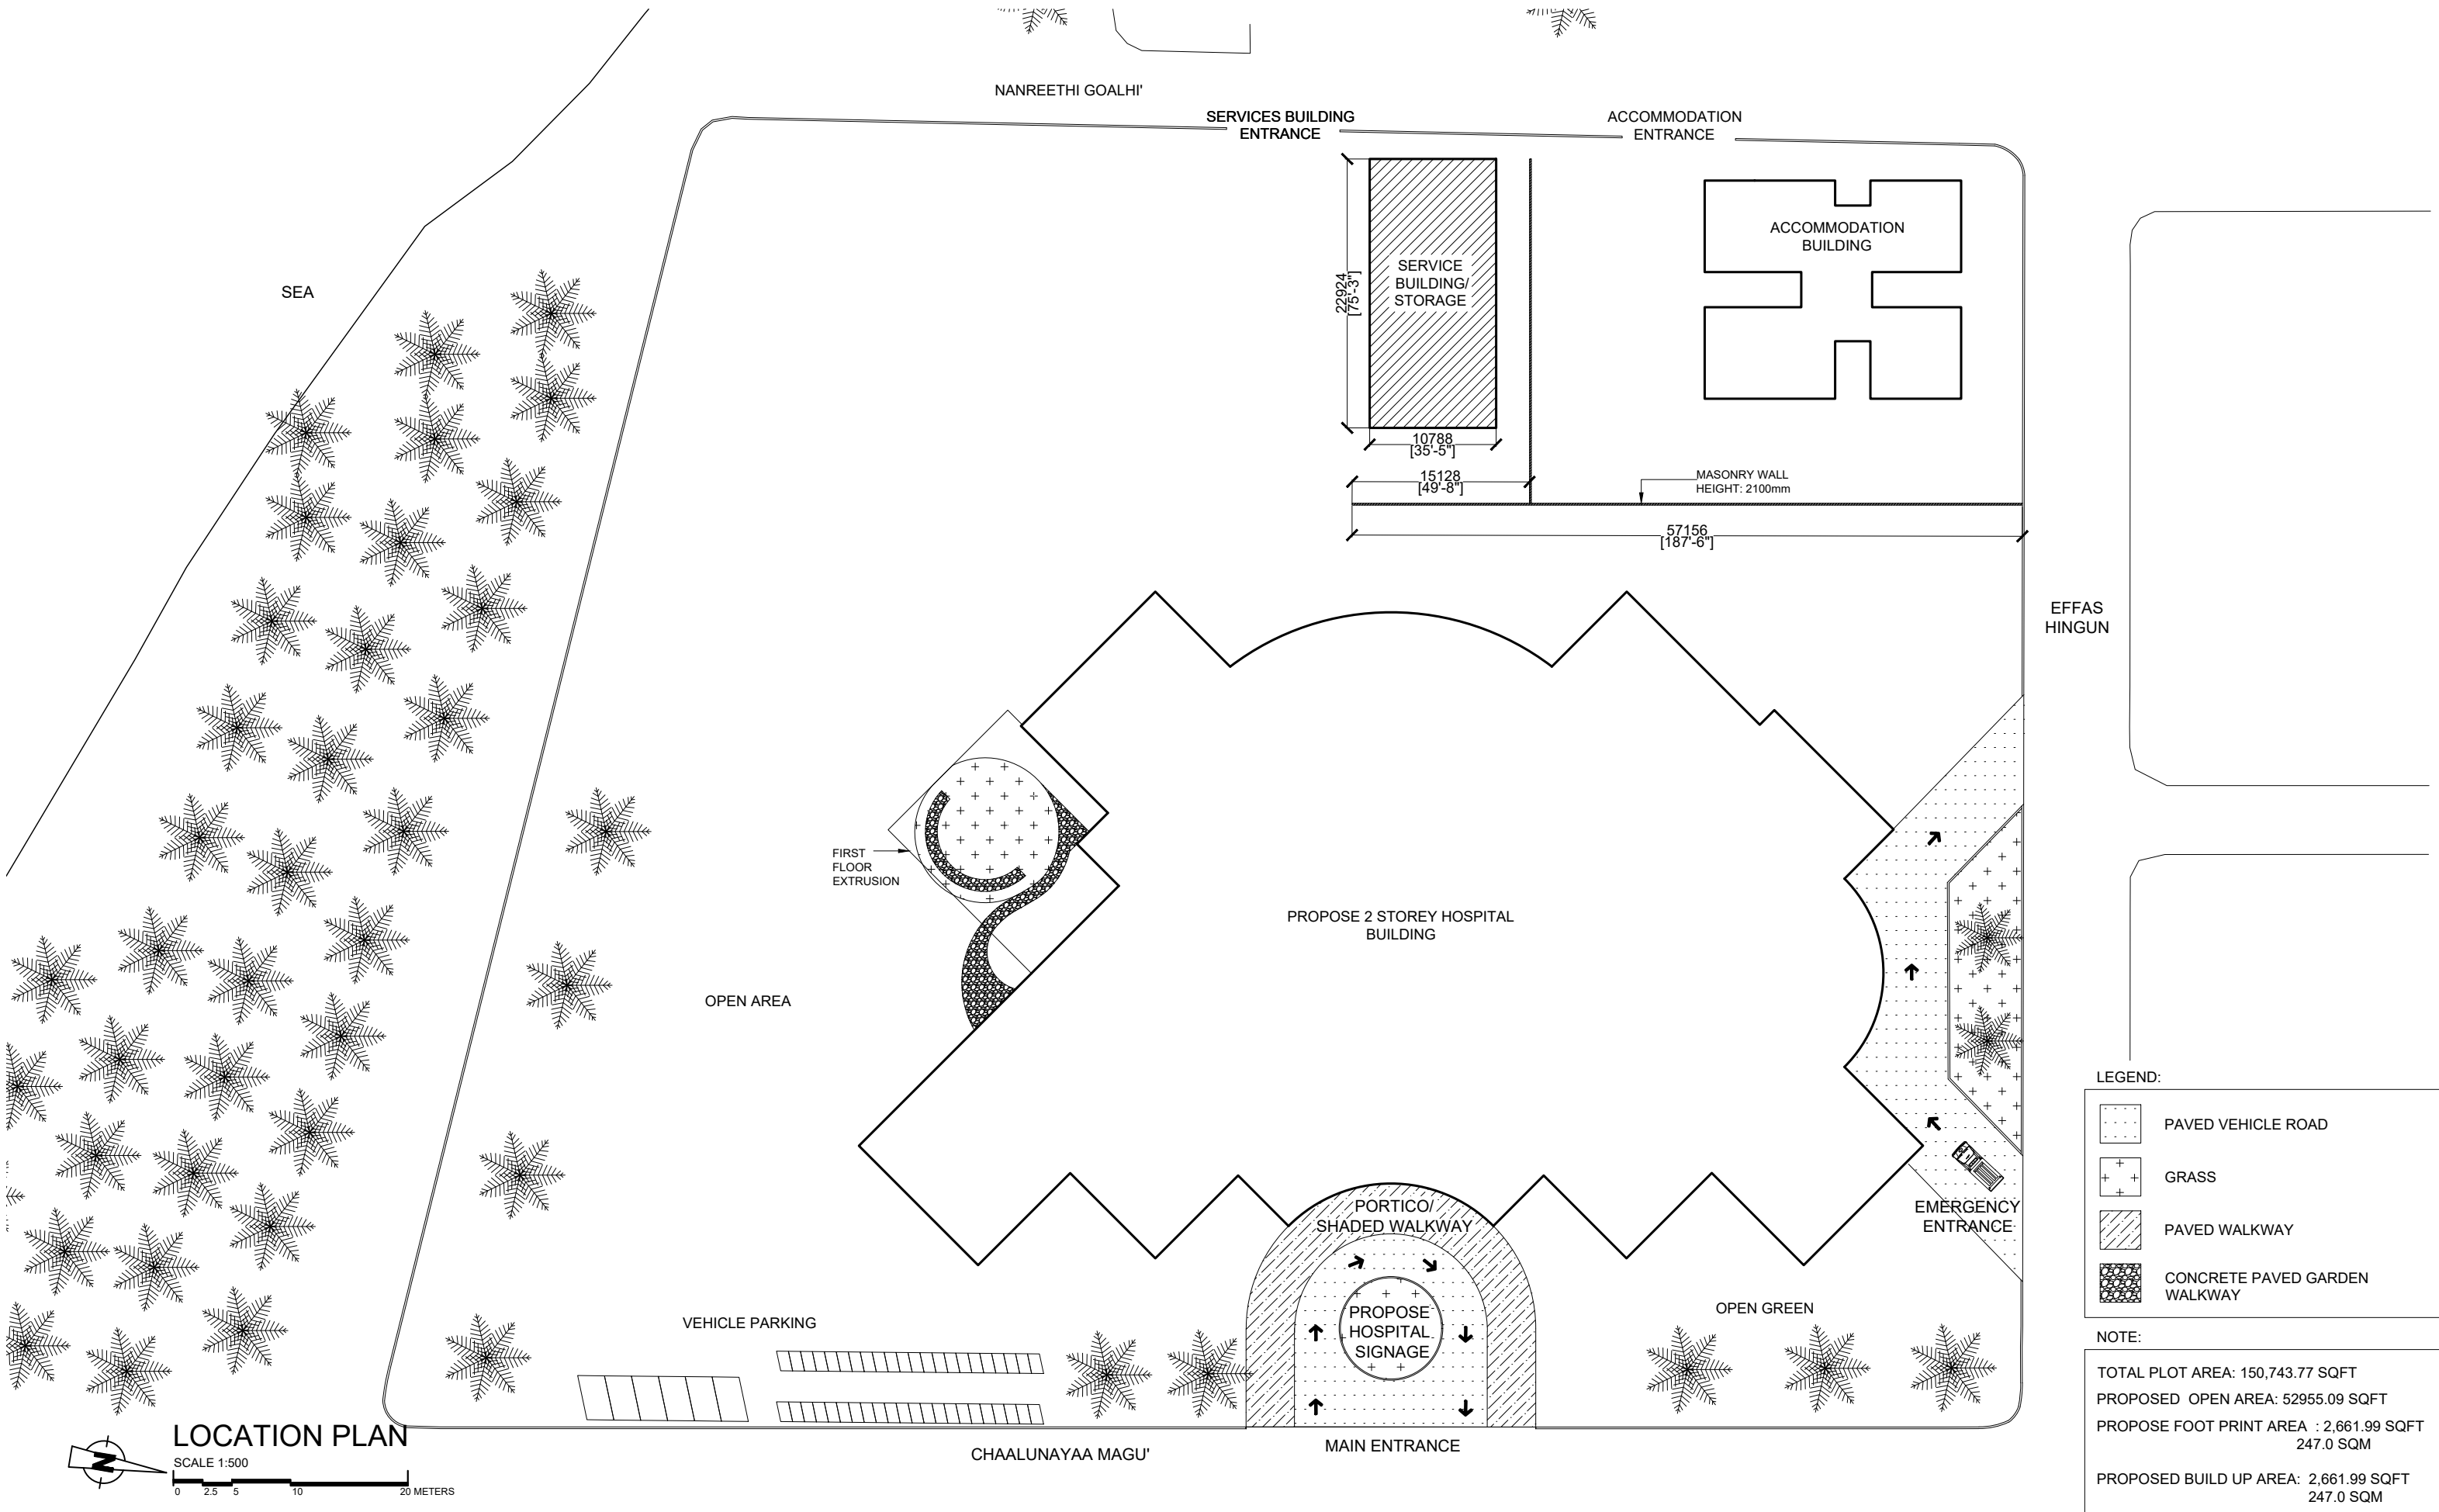

<div><div><div>MTCC</div><div>MALDIVES TRANSPORT & CONTRACTING COMPANY PLC</div><div><div>SURVEY DESIGN AND DEVELOPMENT SECTION</div><div>CONSTRUCTION AND PROJECTS MANAGEMENT DEPARTMENT</div><div>MTCC TOWER, BODU THAKURUPAANI MAGU, MALE 20181, REPUBLIC OF MALDIVES</div><div>PHONE: +(960) 332 6822 FAX: +(960) 333 2835</div><div>E-MAIL: design.development@mtcc.com.mv</div></div></div></div>	PROJECT TITLE HA. HOARAFUSHI HOSPITAL SERVICES BUILDING	CLIENT & ADDRESS MINISTRY OF HEALTH	DESIGN ARCHITECT: SURVEYING, DESIGN AND DEVELOPMENT SECTION		REV	DESCRIPTION	DATE	APPR	SHEET IDENTIFICATION NUMBER A1.01
	DRAWING TITLE AS GIVEN	PROJECT LOCATION HA. HOARAFUSHI	ENGINEER:	STRUCTURAL CHECKER: IBRAHIM THOAM					
			ARCHITECT: AMINATH ZOONA	ARCHITECTURAL CHECKER: IRFAN WAHEED	PAPER A3	SCALE AS GVN			SHEET TITLE 01
			DRAWN BY: HASSAN SHAHULAN	CHECKED BY: AMINATH SAMAHA	DATE 10-05-2020				

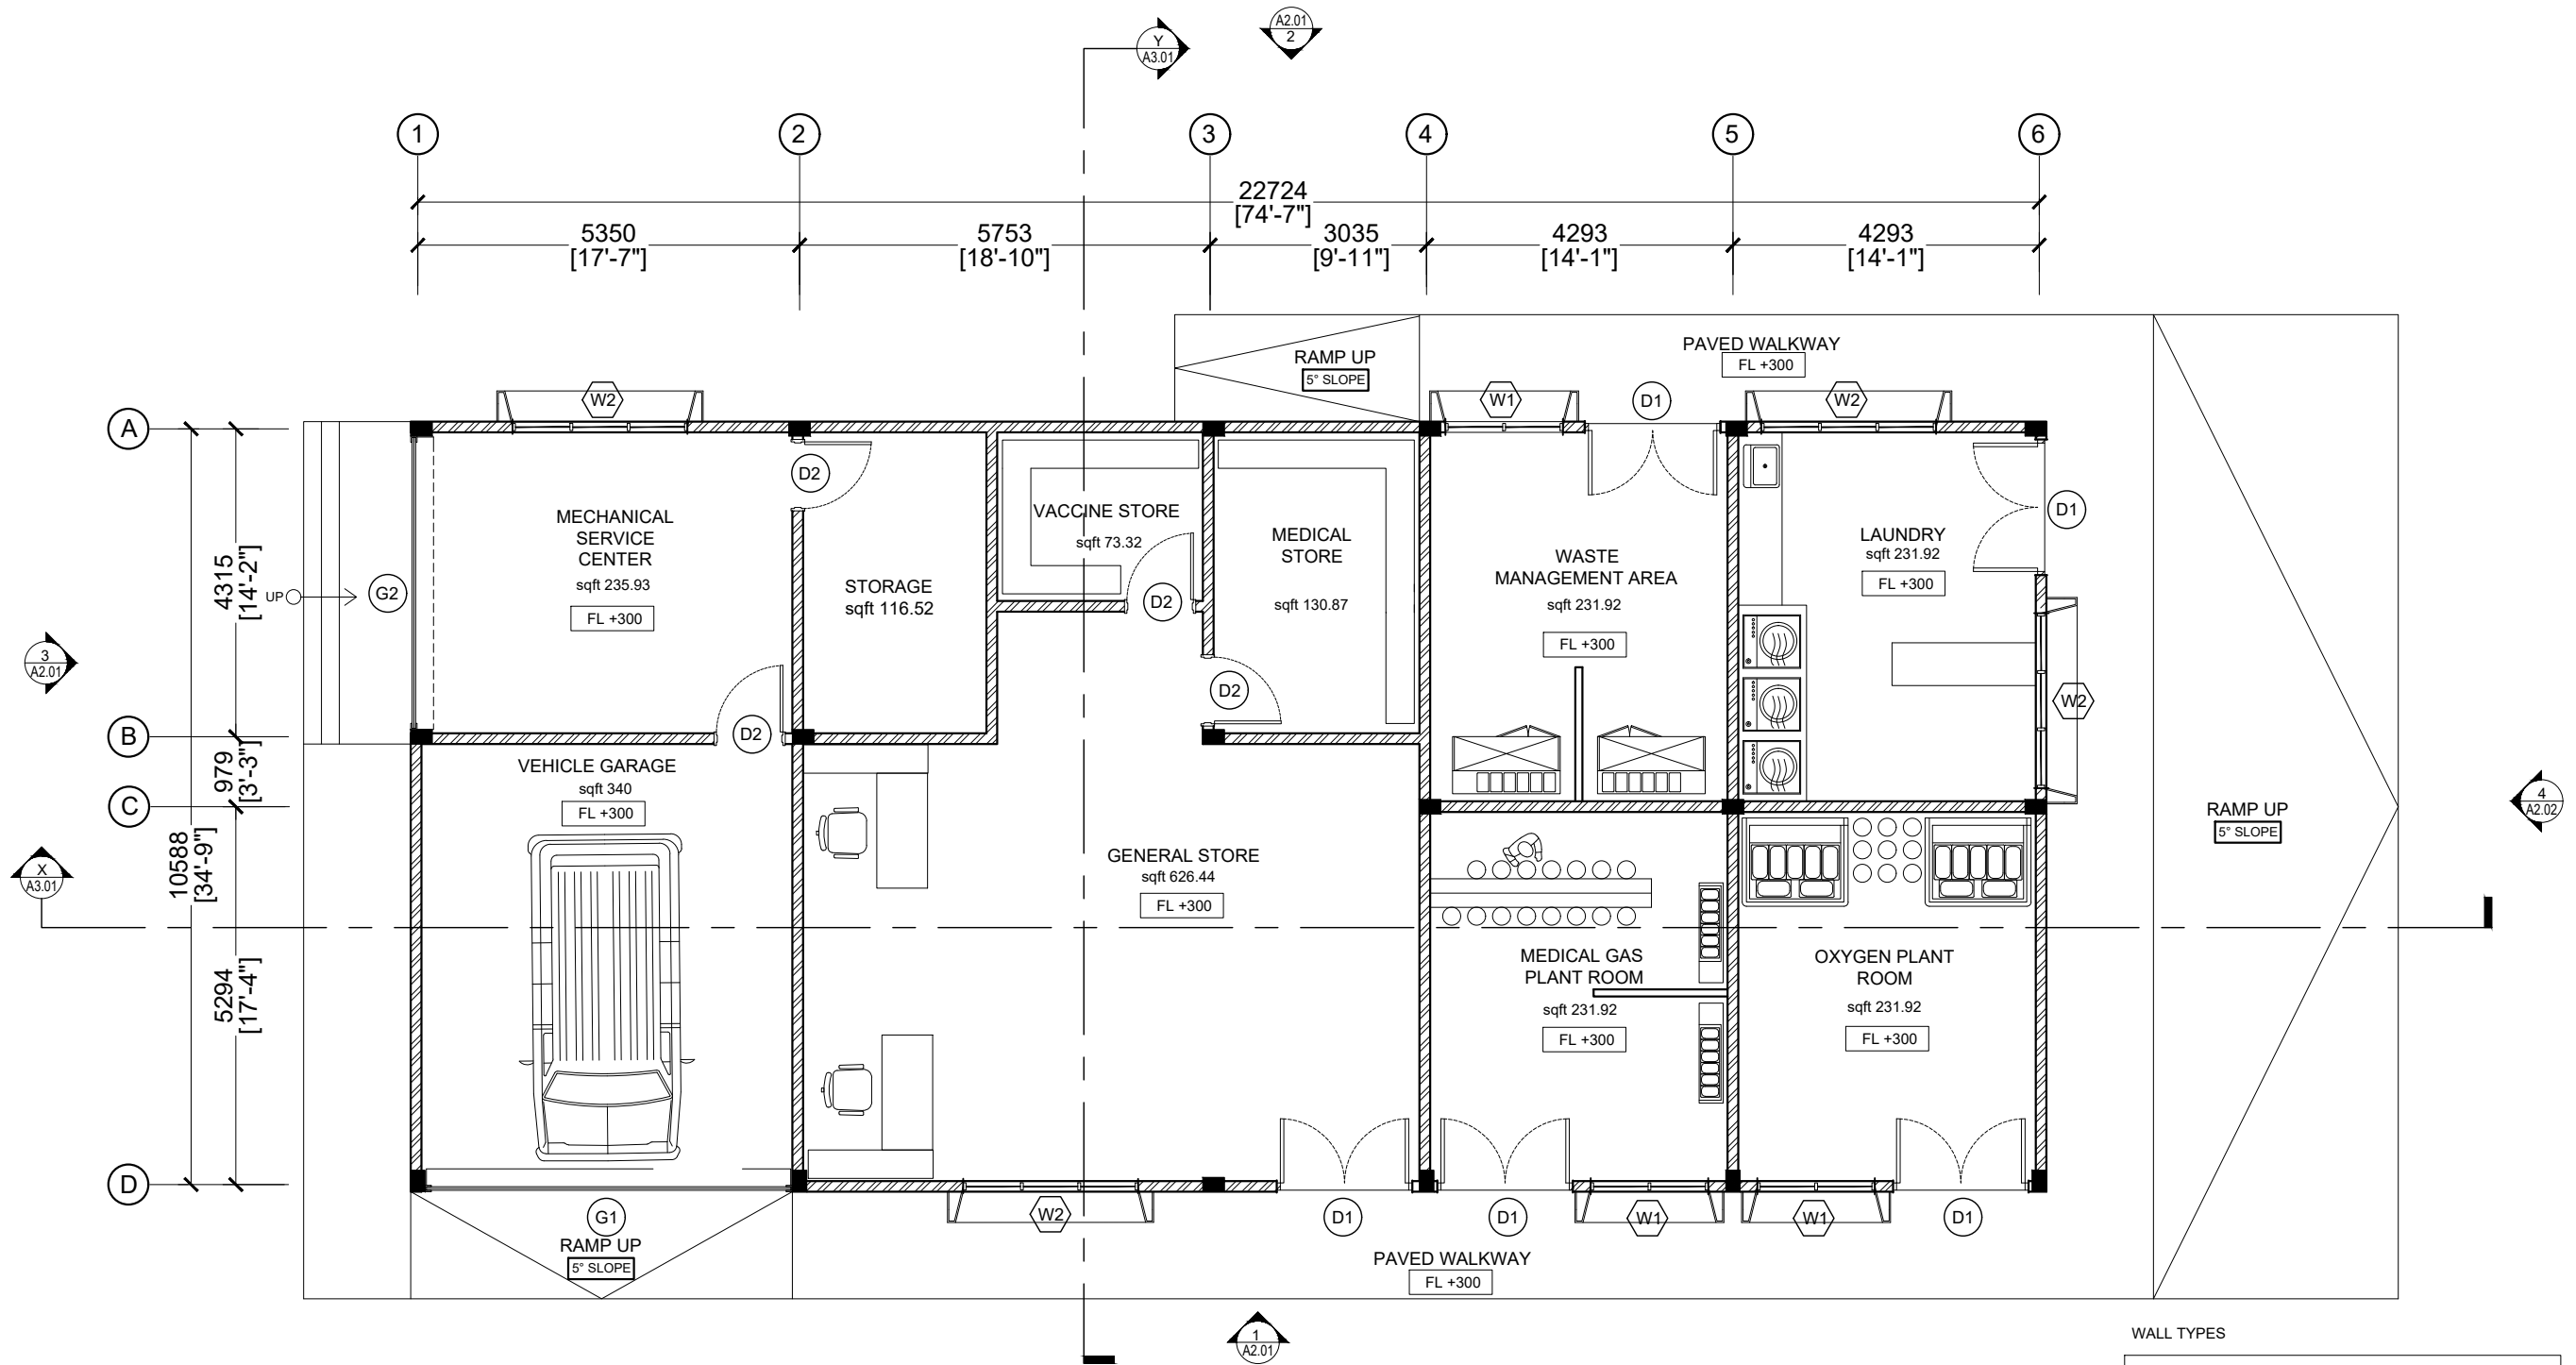

WALL TYPES	
	PROPOSED MASONRY WALLS
	PROPOSED PAINTED FINISH CEMENT DRY WALLS (COLD-FORMED STEEL STUD FRAMING)
	PROPOSED COLUMNS



GROUND FLOOR PLAN


SCALE 1:100


0 0.5 1 2 4 METERS

 MTCC MALDIVES TRANSPORT & CONTRACTING COMPANY PLC <small>SURVEY DESIGN AND DEVELOPMENT SECTION CONSTRUCTION AND PROJECTS MANAGEMENT DEPARTMENT MTCG TOWER, BOOBU THAKURUPAANU MAGU, MALE 20181, REPUBLIC OF MALDIVES. PHONE: + (960) 332 6822 FAX: + (960) 333 2835 E-MAIL: design.development@mtcc.com.mv</small>	PROJECT TITLE HA. HOARAFUSHI HOSPITAL SERVICES BUILDING	CLIENT & ADDRESS MINISTRY OF HEALTH	DESIGN ARCHITECT: SURVEYING, DESIGN AND DEVELOPMENT SECTION		REV	DESCRIPTION	DATE	APPR	SHEET IDENTIFICATION NUMBER A1.02
	DRAWING TITLE AS GIVEN	PROJECT LOCATION HA. HOARAFUSHI	ENGINEER: AMINATH ZOONA DRAWN BY: HASSAN SHAHULAN	STRUCTURAL CHECKER: IBRAHIM THOAM ARCHITECTURAL CHECKER: IRFAN WAHEED CHECKED BY: AMINATH SAMAHA PAPER A3 SCALE AS GVN DATE 10-05-2020					

COPYRIGHT All plans, sketches, drawings, graphic representations and specifications prepared by the Architect(s) & Engineer(s) are instruments of service. The copyright and ownership of both the design and these instruments of service belong to the Architect(s) & Engineer(s) and may not be used for any other project, or sold, or offered for sale by any party other than the Architect/Engineer unless the Architect/Engineer has given written consent. Copies of the documents submitted to the client prepared by the Architect/Engineer maybe used as they were intended, once, and on the same site and project.





 MTCC MALDIVES TRANSPORT & CONTRACTING COMPANY PLC <small>SURVEY DESIGN AND DEVELOPMENT SECTION CONSTRUCTION AND PROJECTS MANAGEMENT DEPARTMENT, MTCC TOWER, BODU THAKURUPPANA MAGU, MALE 20181, REPUBLIC OF MALDIVES. PHONE : +(960) 332 6822 FAX : +(960) 333 2835 E-MAIL : design.development@mtcc.com.mv</small>	PROJECT TITLE HA. HOARAFUSHI HOSPITAL SERVICES BUILDING	CLIENT & ADDRESS MINISTRY OF HEALTH	DESIGN ARCHITECT: SURVEYING, DESIGN AND DEVELOPMENT SECTION				REV	DESCRIPTION	DATE	APPR	SHEET IDENTIFICATION NUMBER A1.03 SHEET TITLE 03
	DRAWING TITLE AS GIVEN	PROJECT LOCATION HA. HOARAFUSHI	ENGINEER: IBRAHIM THOAM	ARCHITECT: AMINATH ZOONA		PAPER A3	SCALE AS GVN				
			DRAWN BY: HASSAN SHAHULAN		CHECKED BY: AMINATH SAMAHA		DATE 10-05-2020				

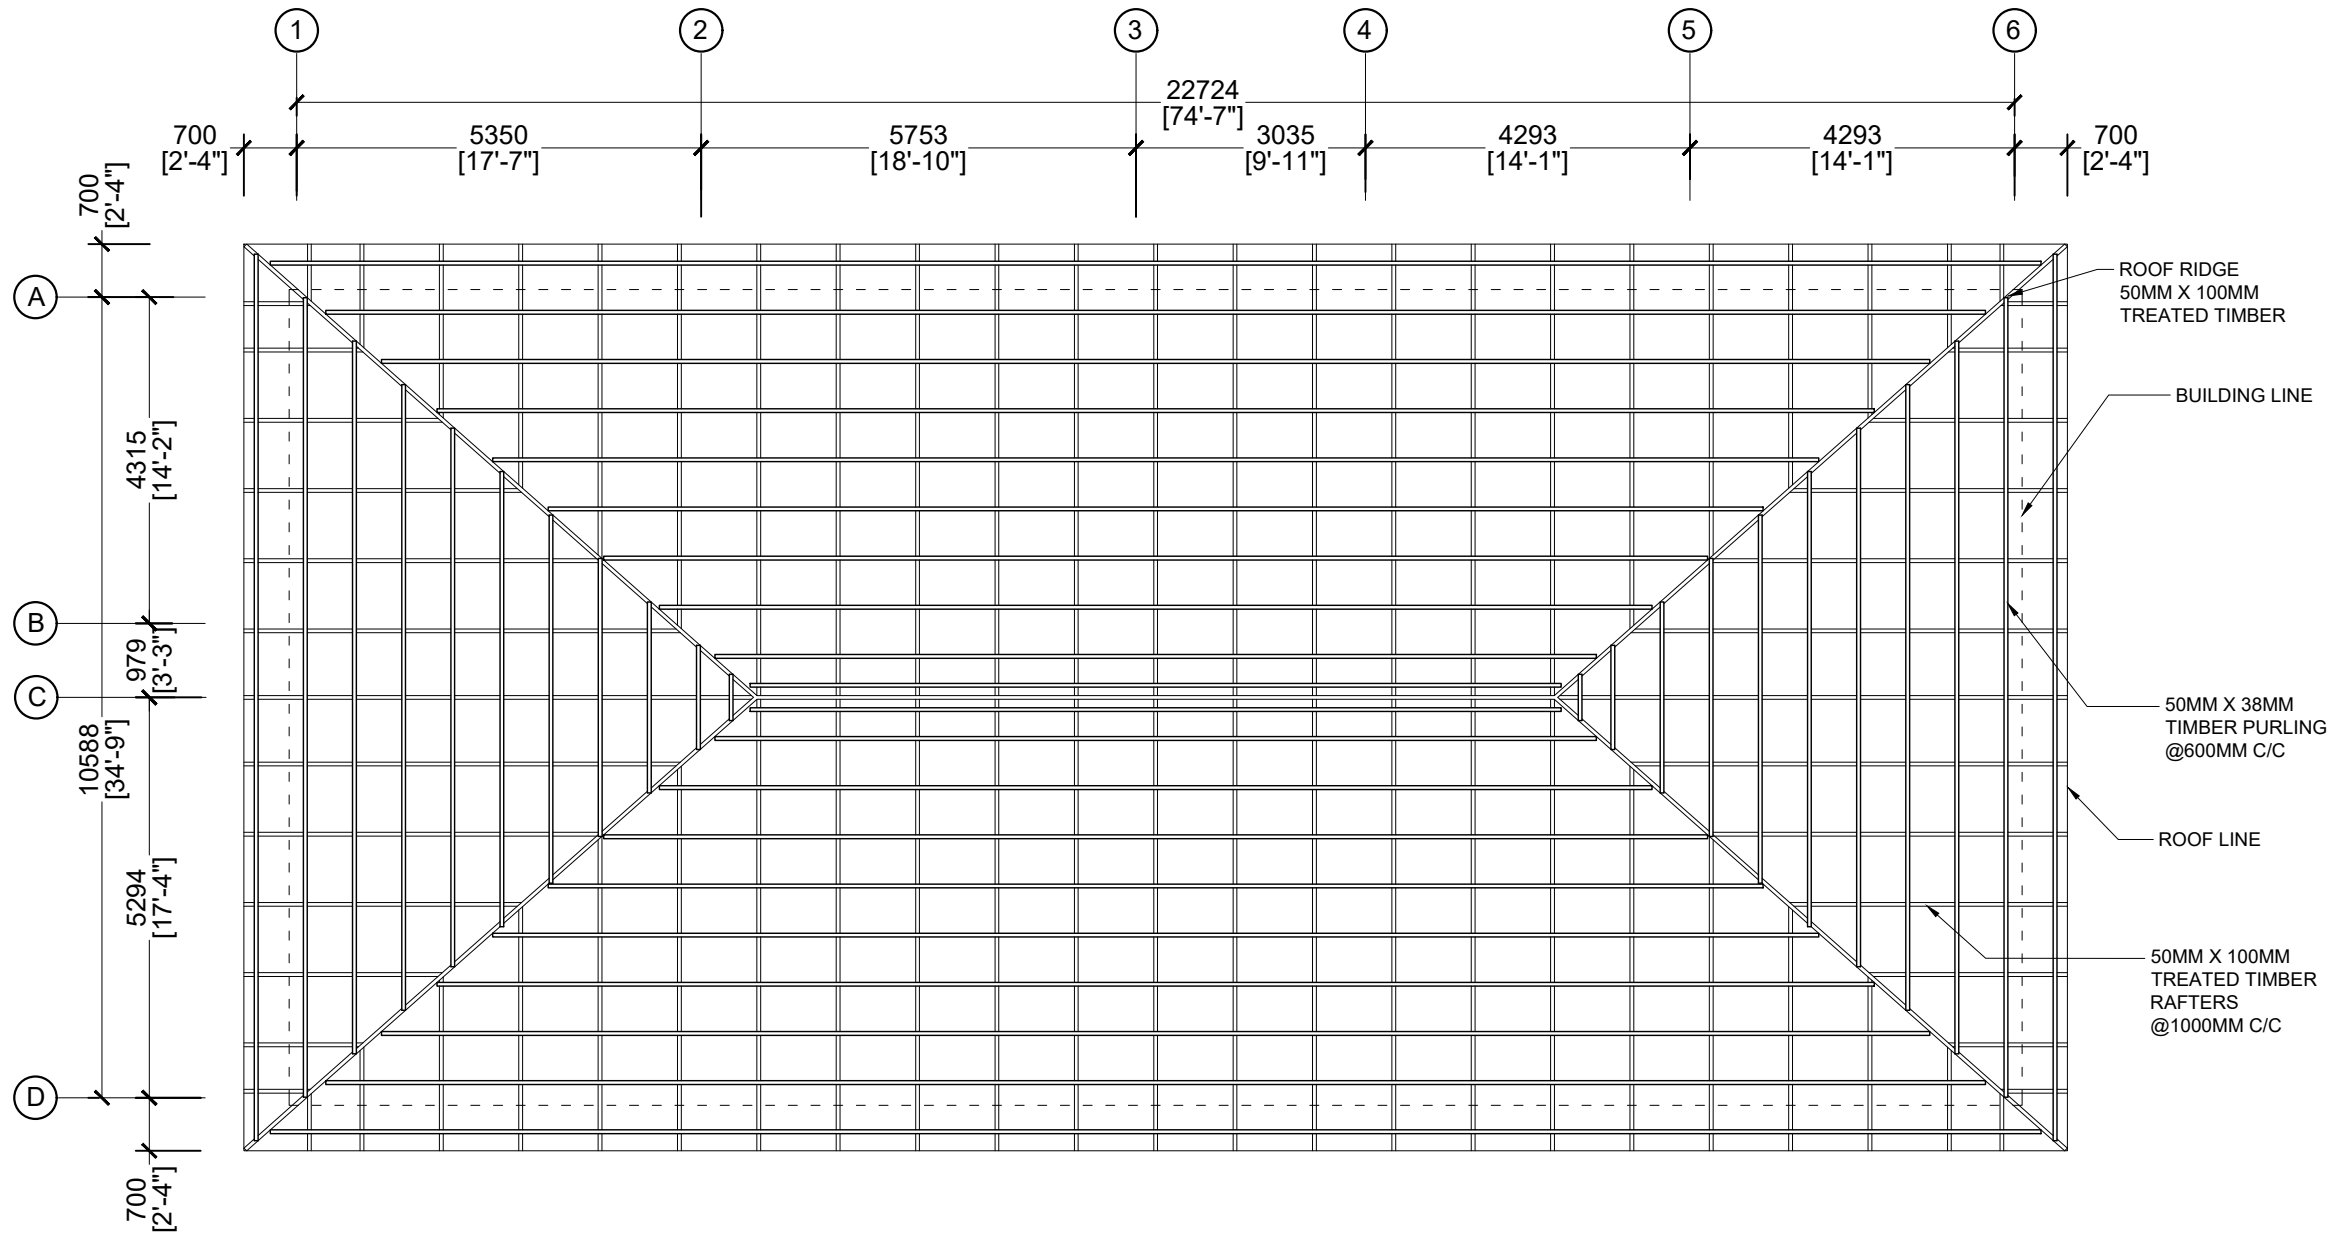


ROOF FRAMING PLAN

 SCALE 1:100





<div> MTCC MALDIVES TRANSPORT & CONTRACTING COMPANY PLC</div> <div><small>SURVEY DESIGN AND DEVELOPMENT SECTION CONSTRUCTION AND PROJECTS MANAGEMENT DEPARTMENT, MTCG TOWER, BODU THAKURUPAANU MAGU, MALE 20181, REPUBLIC OF MALDIVES. PHONE: + (960) 332 6822 FAX: + (960) 333 2835 E-MAIL: design.development@mtcc.com.mv</small></div>	PROJECT TITLE HA. HOARAFUSHI HOSPITAL SERVICES BUILDING	CLIENT & ADDRESS MINISTRY OF HEALTH	DESIGN ARCHITECT: SURVEYING, DESIGN AND DEVELOPMENT SECTION				REV	DESCRIPTION	DATE	APPR	SHEET IDENTIFICATION NUMBER A1.04 SHEET TITLE 04
	DRAWING TITLE AS GIVEN	PROJECT LOCATION HA. HOARAFUSHI	ENGINEER:	STRUCTURAL CHECKER: IBRAHIM THOAM							
			ARCHITECT: AMINATH ZOONA	ARCHITECTURAL CHECKER: IRFAN WAHEED	PAPER A3	SCALE AS GVN					
			DRAWN BY: HASSAN SHAHULAN	CHECKED BY: AMINATH SAMAHA	DATE 10-05-2020						

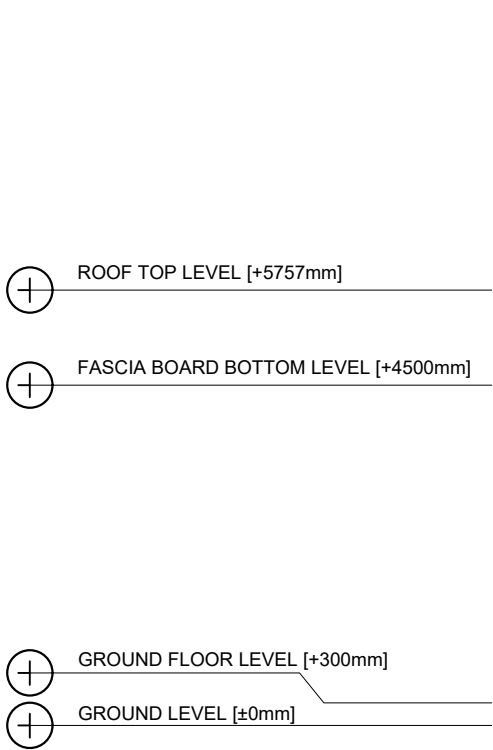

ELEVATION 1

SCALE 1:100


0 0.5 1 2 4 METERS

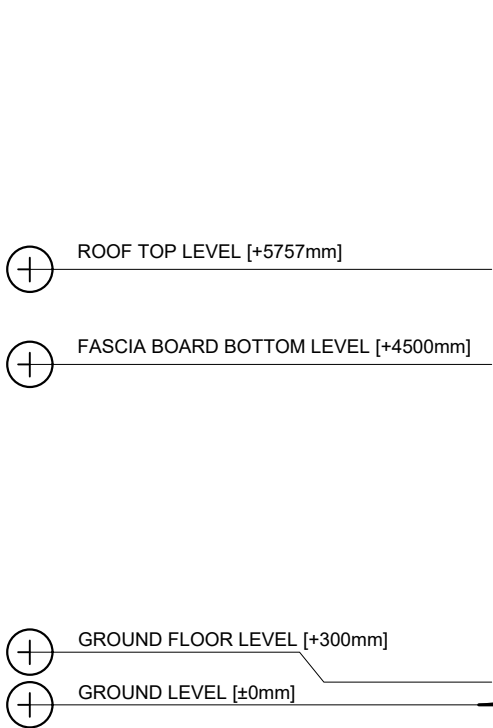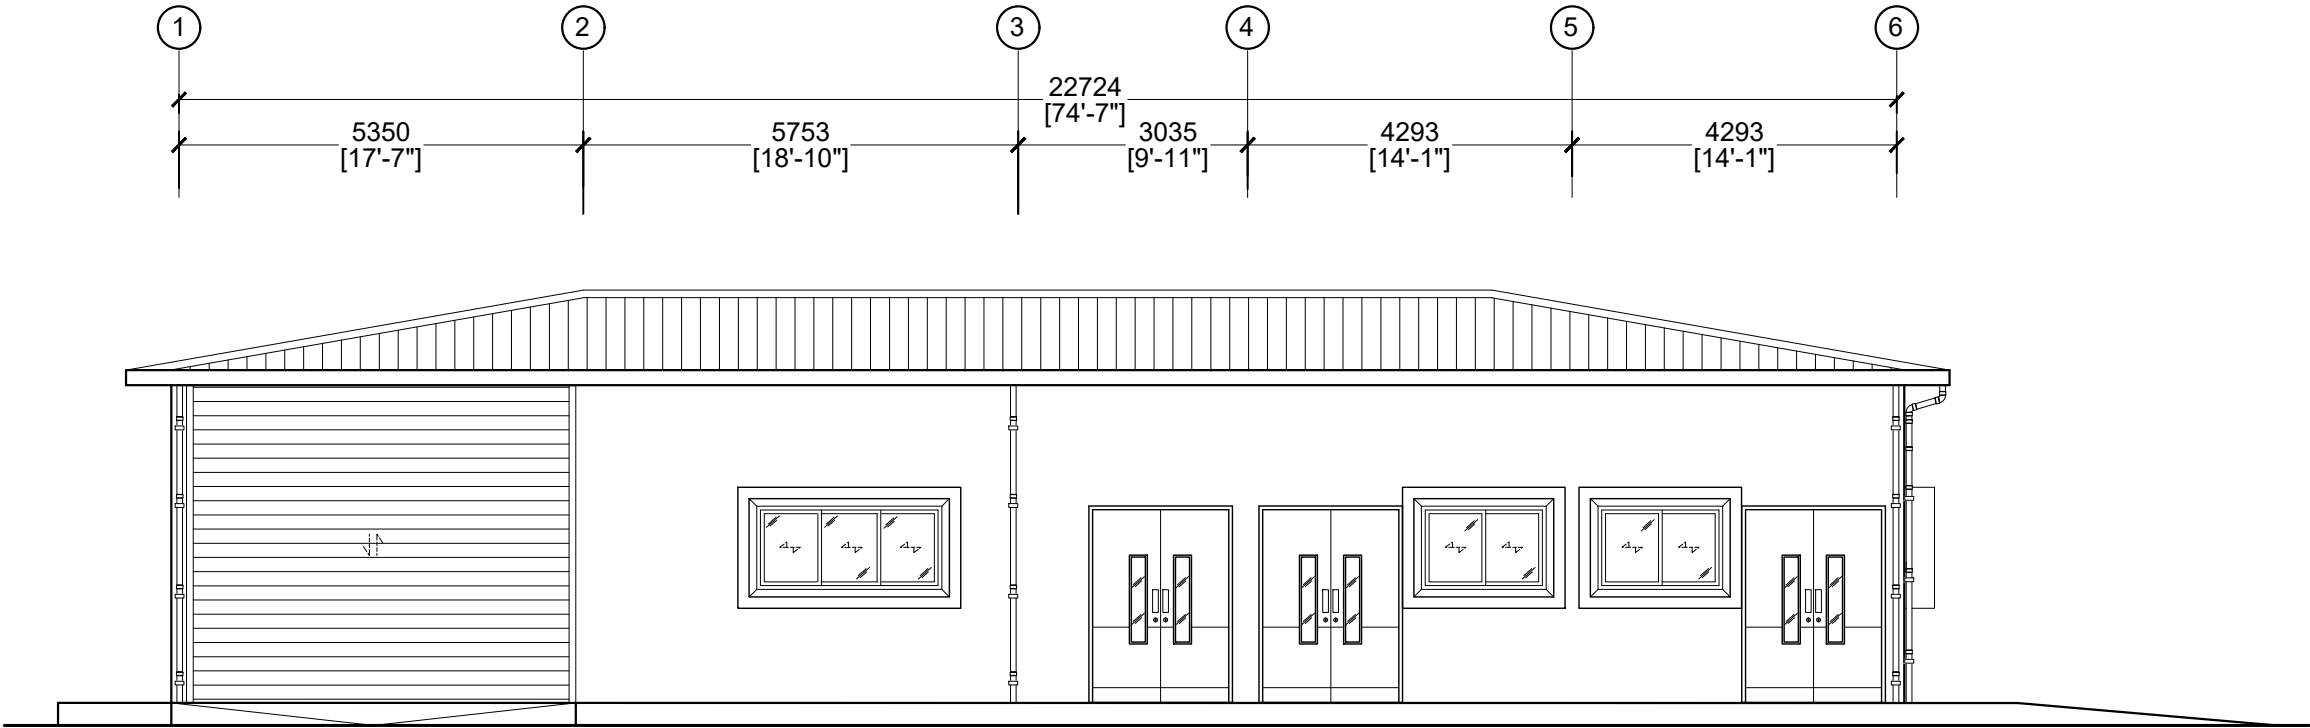


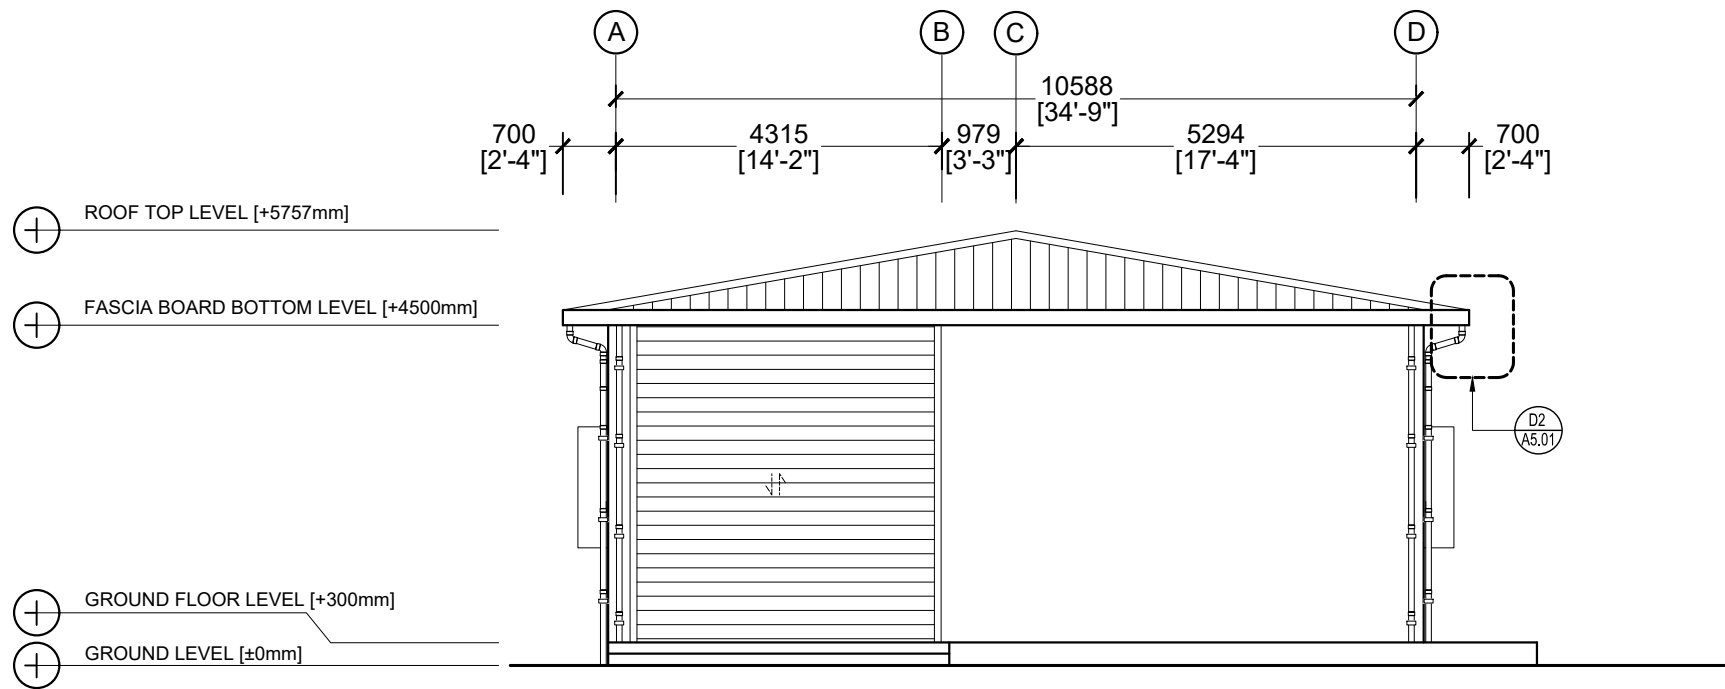
ELEVATION 2

SCALE 1:100

0 0.5 1 2 4 METERS

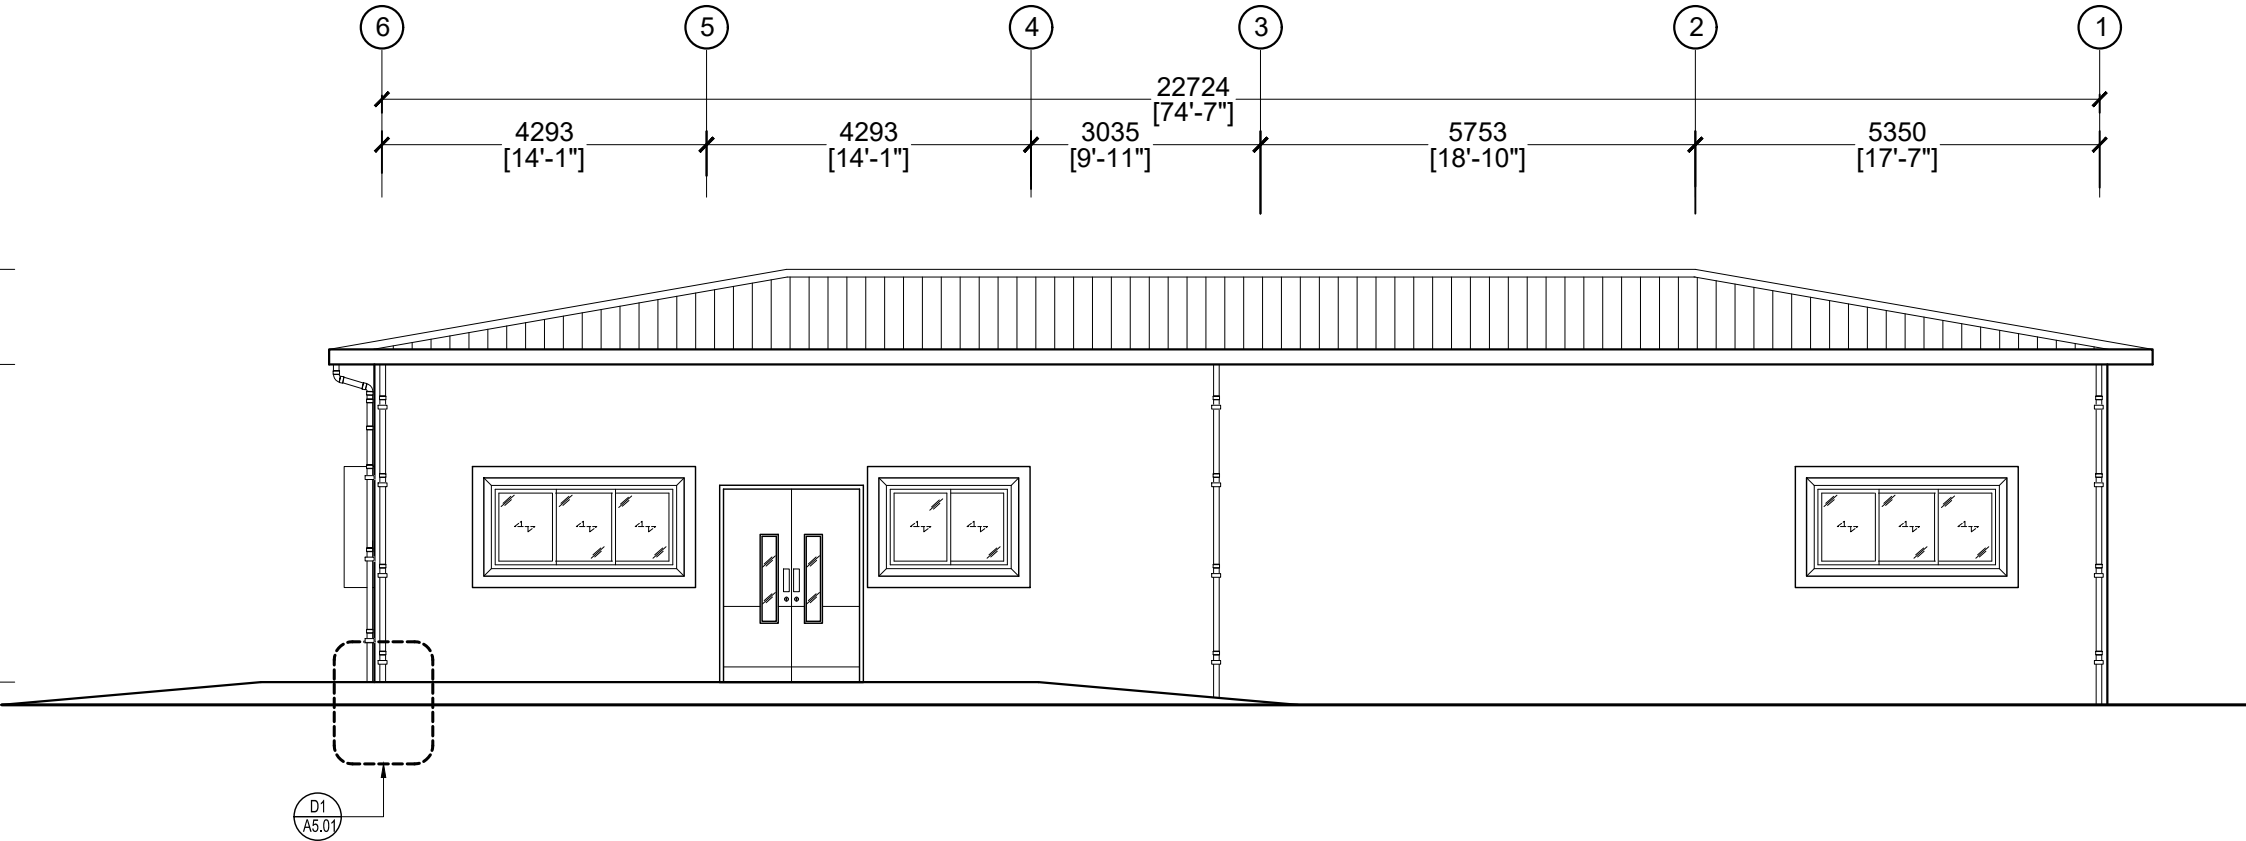


 MTCC MALDIVES TRANSPORT & CONTRACTING COMPANY PLC <small>SURVEY DESIGN AND DEVELOPMENT SECTION CONSTRUCTION AND PROJECTS MANAGEMENT DEPARTMENT MTCG TOWER, BOOJU THAKURUPAANU MAGU, MALE 20181, REPUBLIC OF MALDIVES. PHONE: + (960) 332 6822 FAX: + (960) 333 2835 E-MAIL: design.development@mtcc.com.mv</small>	PROJECT TITLE HA. HOARAFUSHI HOSPITAL SERVICES BUILDING	CLIENT & ADDRESS MINISTRY OF HEALTH	DESIGN ARCHITECT: SURVEYING, DESIGN AND DEVELOPMENT SECTION			REV	DESCRIPTION	DATE	APPR	SHEET IDENTIFICATION NUMBER A2.01 SHEET TITLE 05
	DRAWING TITLE AS GIVEN	PROJECT LOCATION HA. HOARAFUSHI	ENGINEER:	STRUCTURAL CHECKER: IBRAHIM THOAM						
			ARCHITECT: AMINATH ZOONA	ARCHITECTURAL CHECKER: IRFAN WAHEED	PAPER A3	SCALE AS GVN				
			DRAWN BY: HASSAN SHAHULAN	CHECKED BY: AMINATH SAMAHA	DATE 10-05-2020					




ELEVATION 3


SCALE 1:100
0 0.5 1 2 4 METERS

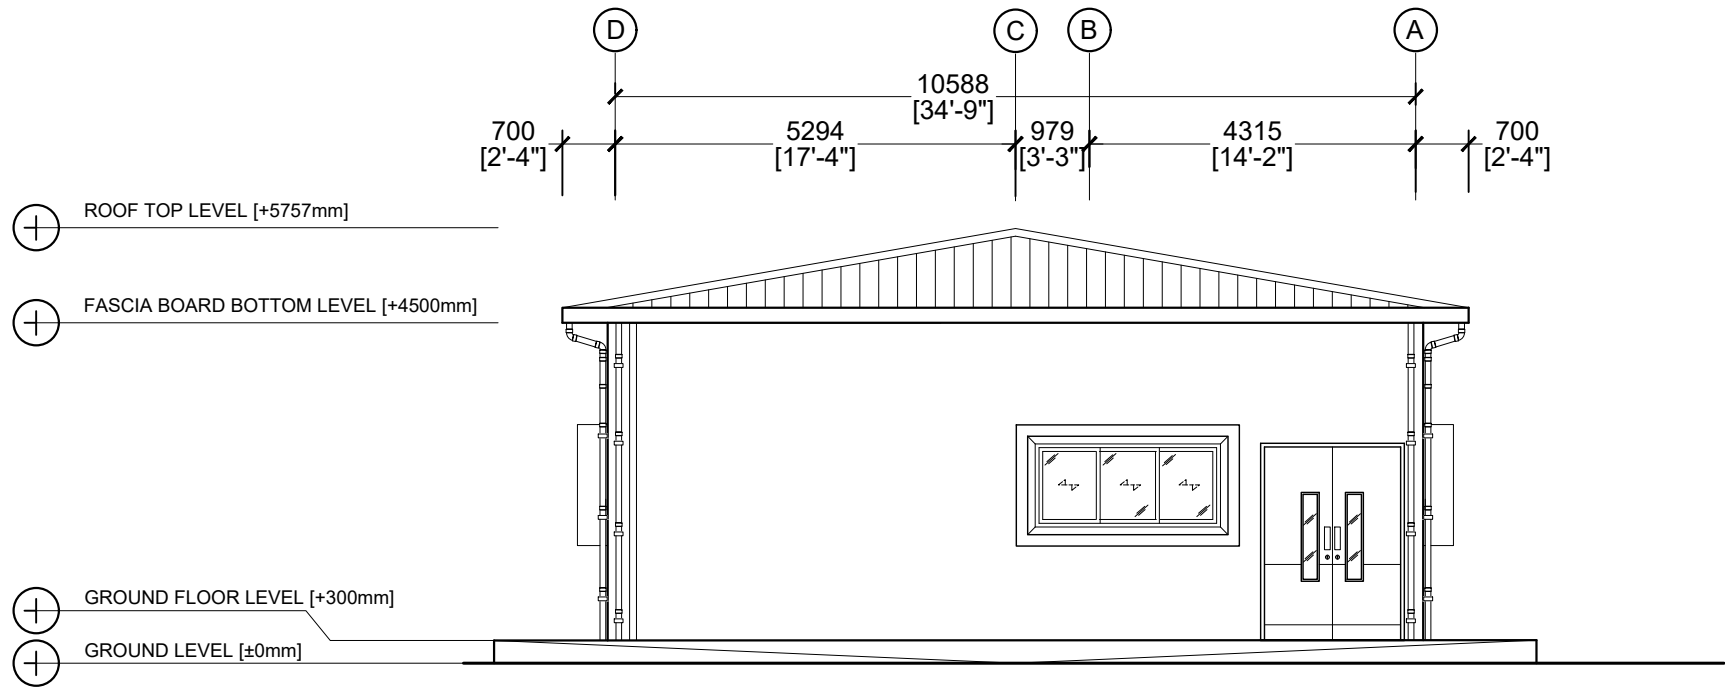

ELEVATION 4

SCALE 1:100
0 0.5 1 2 4 METERS


 MTCC MALDIVES TRANSPORT & CONTRACTING COMPANY PLC <small>SURVEY, DESIGN AND DEVELOPMENT SECTION CONSTRUCTION AND PROJECTS MANAGEMENT DEPARTMENT MTCG TOWER, BOOJU THAKURUPAANU MAGU, MALE 20181, REPUBLIC OF MALDIVES. PHONE: +(960) 332 6822 FAX: +(960) 333 2835 E-MAIL: design.development@mtcc.com.mv</small>	PROJECT TITLE HA. HOARAFUSHI HOSPITAL SERVICES BUILDING	CLIENT & ADDRESS MINISTRY OF HEALTH	DESIGN ARCHITECT: SURVEYING, DESIGN AND DEVELOPMENT SECTION	REV	DESCRIPTION	DATE	APPR	SHEET IDENTIFICATION NUMBER A2.02 SHEET TITLE 06
	DRAWING TITLE AS GIVEN	PROJECT LOCATION HA. HOARAFUSHI	ENGINEER: AMINATH ZOONA	STRUCTURAL CHECKER: IBRAHIM THOAM				
			ARCHITECT: AMINATH ZOONA	ARCHITECTURAL CHECKER: IRFAN WAHEED	PAPER A3	SCALE AS GVN		
			DRAWN BY: HASSAN SHAHULAN	CHECKED BY: AMINATH SAMAHA	DATE 10-05-2020			

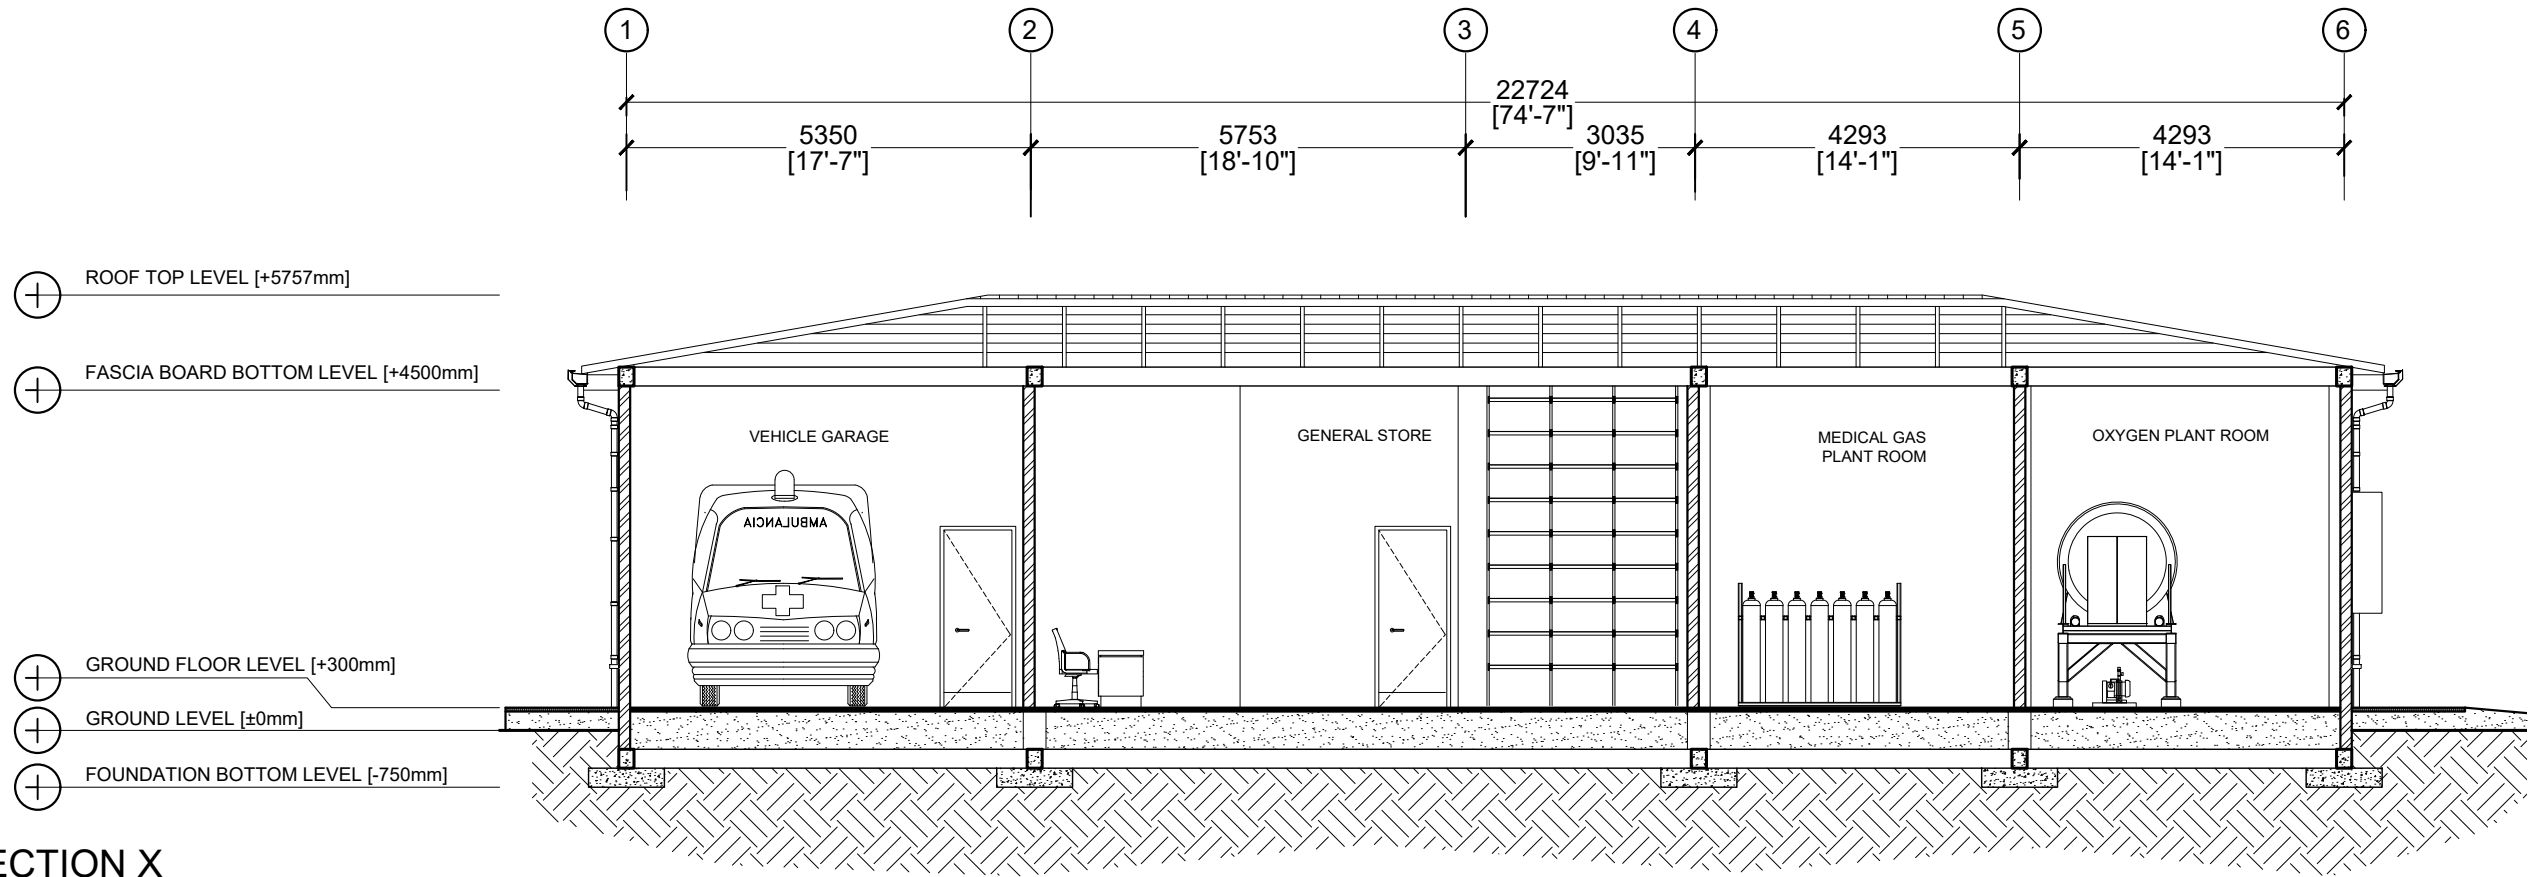

SECTION X

SCALE 1:100


0 0.5 1 2 4 METERS

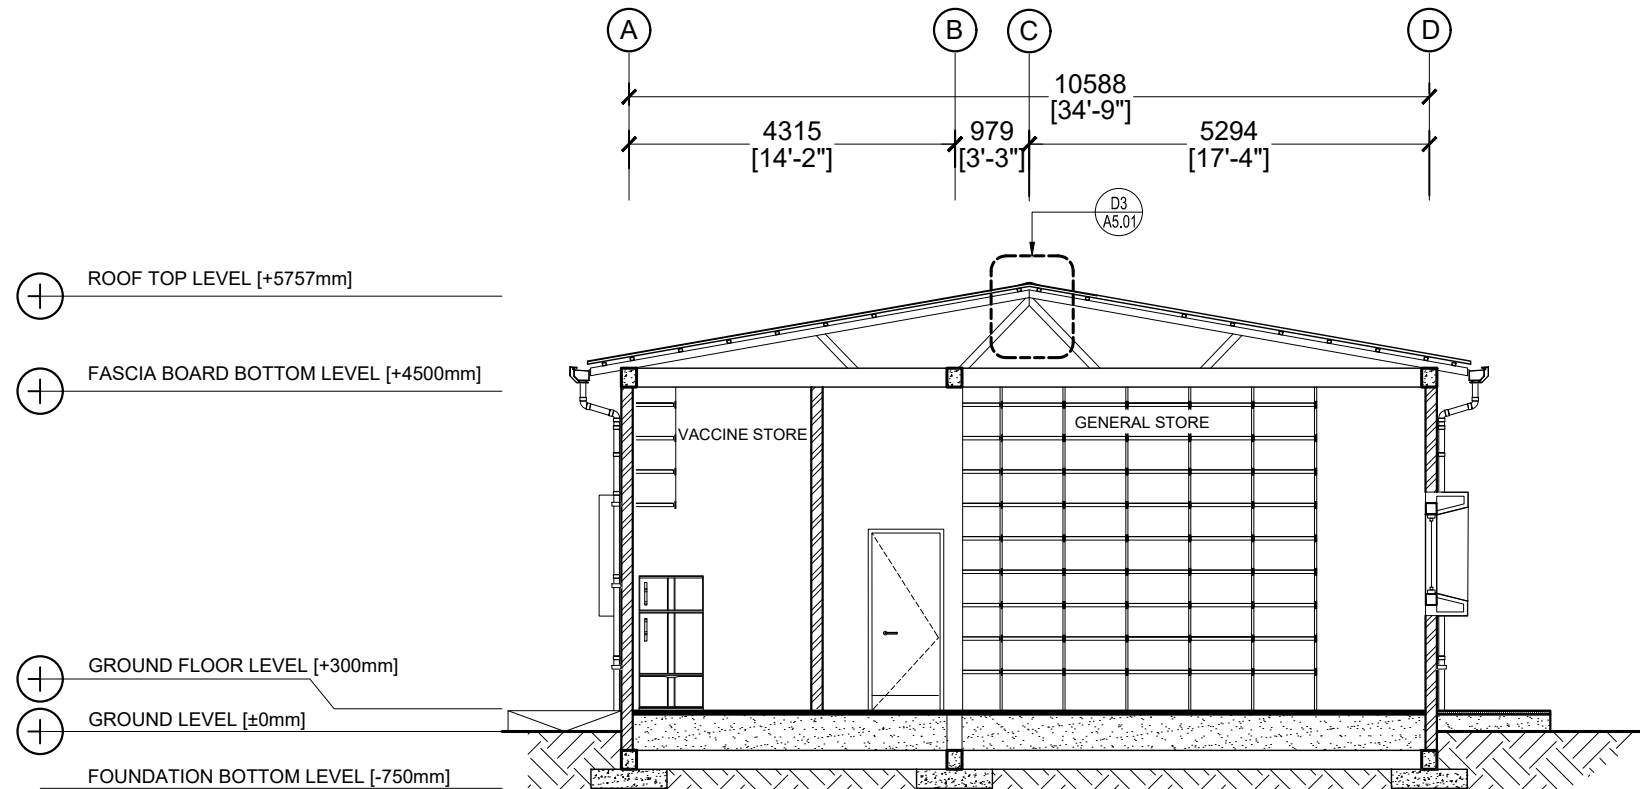






SECTION Y

SCALE 1:100

0 0.5 1 2 4 METERS

 MTCC MALDIVES TRANSPORT & CONTRACTING COMPANY PLC <small>SURVEY, DESIGN AND DEVELOPMENT SECTION CONSTRUCTION AND PROJECTS MANAGEMENT DEPARTMENT MTCG TOWER, BOOBU THAKURUPAANU MAGU, MALE 20181, REPUBLIC OF MALDIVES. PHONE: +(960) 332 6822 FAX: +(960) 333 2835 E-MAIL: design.development@mtcc.com.mv</small>	PROJECT TITLE HA. HOARAFUSHI HOSPITAL SERVICES BUILDING	CLIENT & ADDRESS MINISTRY OF HEALTH	DESIGN ARCHITECT: SURVEYING, DESIGN AND DEVELOPMENT SECTION	REV	DESCRIPTION	DATE	APPR	SHEET IDENTIFICATION NUMBER A3.01 SHEET TITLE 07
	DRAWING TITLE AS GIVEN	PROJECT LOCATION HA. HOARAFUSHI	ENGINEER: ARCHITECT: AMINATH ZOONA DRAWN BY: HASSAN SHAHULAN	STRUCTURAL CHECKER: IBRAHIM THOAM ARCHITECTURAL CHECKER: IRFAN WAHEED CHECKED BY: AMINATH SAMAHA	PAPER A3	SCALE AS GVN	DATE 10-05-2020	

 
COPYRIGHT All plans, sketches, drawings, graphic representations and specifications prepared by the Architect(s) & Engineer(s) are instruments of service. The copyright and ownership, of both the design and these instruments of service belong to the Architect(s) & Engineer(s) and may not be used for any other project, or sold, or offered for sale by any party other than the Architect/Engineer unless the Architect/Engineer has given written consent. Copies of the documents submitted to the client prepared by the Architect/Engineer maybe used as they were intended, once, and on the same site and project.

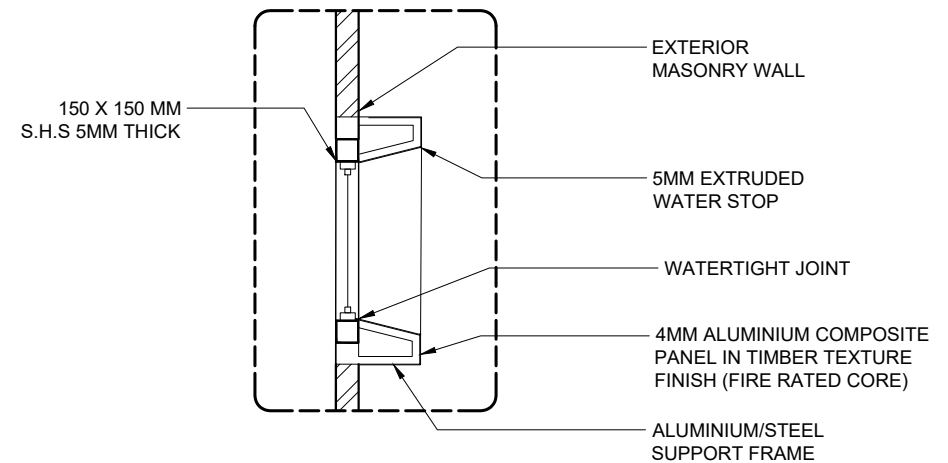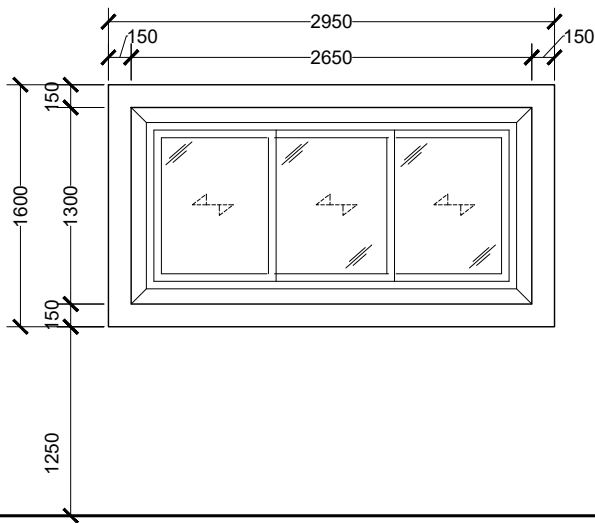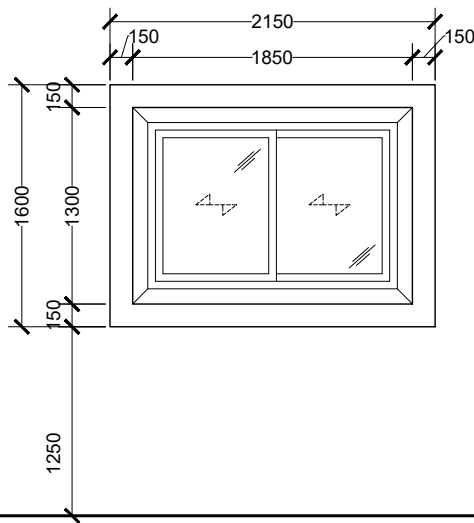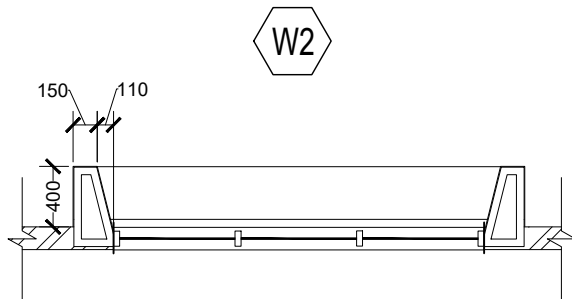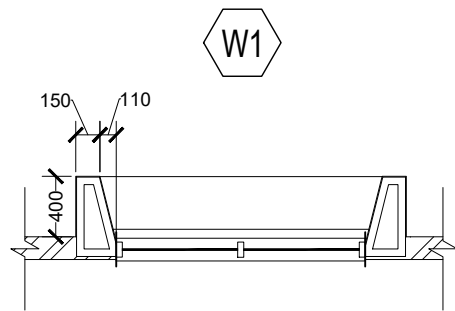


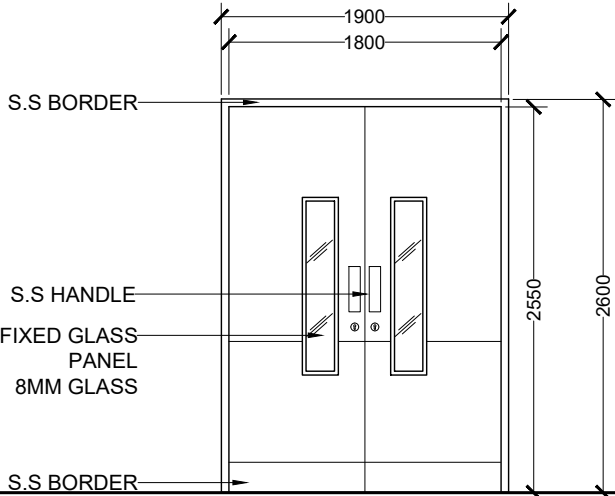
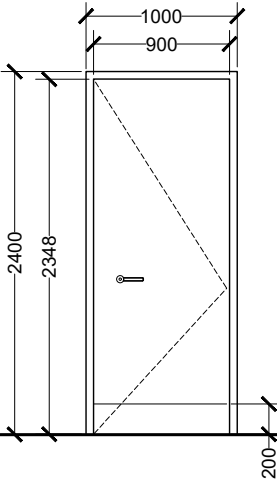
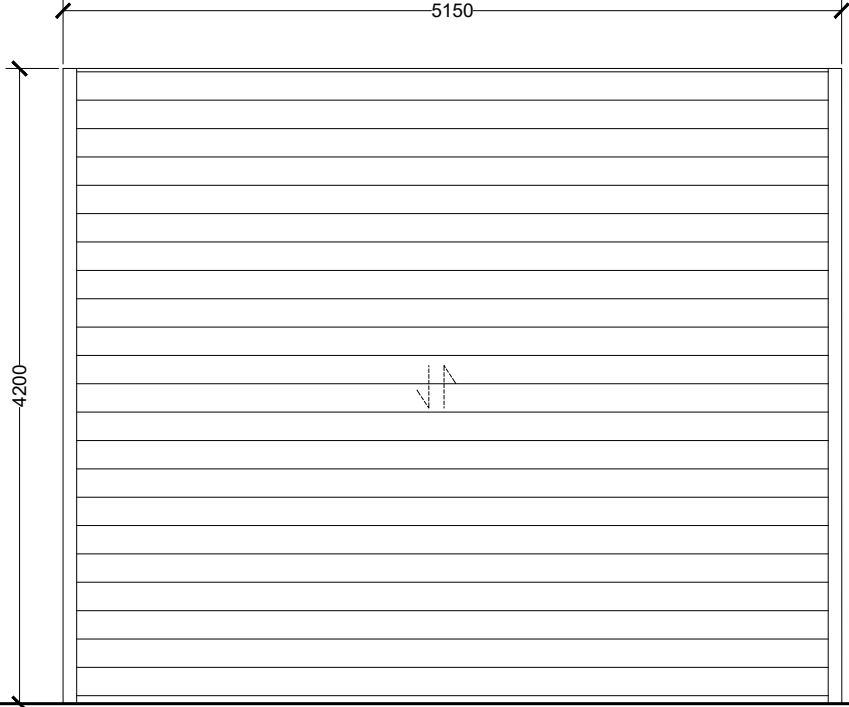
ELEVATION VIEW

TYPICAL WINDOW SECTION


WINDOW SHADING DETAIL




<div> MTCC MALDIVES TRANSPORT & CONTRACTING COMPANY PLC</div> <div><small>SURVEY DESIGN AND DEVELOPMENT SECTION CONSTRUCTION AND PROJECTS MANAGEMENT DEPARTMENT MTCC TOWER, BOOBU THAKURUPAANU MAGU, MALE 20181, REPUBLIC OF MALDIVES. PHONE: + (960) 332 6822 FAX: + (960) 333 2835 E-MAIL: design.development@mtcc.com.mv</small></div>	PROJECT TITLE HA. HOARAFUSHI HOSPITAL SERVICES BUILDING	CLIENT & ADDRESS MINISTRY OF HEALTH	DESIGN ARCHITECT: SURVEYING, DESIGN AND DEVELOPMENT SECTION				REV	DESCRIPTION	DATE	APPR	SHEET IDENTIFICATION NUMBER A5.02 SHEET TITLE 09
	DRAWING TITLE AS GIVEN	PROJECT LOCATION HA. HOARAFUSHI	ENGINEER:	STRUCTURAL CHECKER: IBRAHIM THOAM							
			ARCHITECT: AMINATH ZOONA	ARCHITECTURAL CHECKER: IRFAN WAHEED	PAPER A3	SCALE AS GVN					
			DRAWN BY: HASSAN SHAHULAN	CHECKED BY: AMINATH SAMAHA	DATE 10-05-2020						

LABEL	D1	D2	G1
			
DESCRIPTION	GRP DOOR, MAIN DOOR TYPE 3	GRP DOOR	ROLLER SHUTTER GARAGE DOOR 1
DOOR FRAME	POLISHED STAINLESS STEEL	POWDER COATED ALUMINIUM	AS PER MANUFACTURER
DOOR PANEL	GRP DOOR WITH 8mm TEMPERED GLASS	GRP DOOR PANEL,	AS PER MANUFACTURER
HARDWARE	DOOR CLOSER, SS HINGES 200mm SS BORDER AT TOP AND BOTTOM OF DOOR	DOOR CLOSER, SS HINGES 200mm SS BORDER AT BOTTOM OF DOOR	AS PER MANUFACTURER
COMMENTS	-		
LOCATION(S)	GENERAL STORE, MEDICAL GAS PLANT ROOM, OXYGEN PLANT ROOM, WASTE MANAGEMENT AREA AND LAUNDRY	MEDICAL STORE, VACCINE STORE, STORAGE	VEHICLE GARAGE
NO(S)	5	3	1

 DOOR WINDOW SCHEDULE





 MTCC MALDIVES TRANSPORT & CONTRACTING COMPANY PLC <small>SURVEY, DESIGN AND DEVELOPMENT SECTION CONSTRUCTION AND PROJECTS MANAGEMENT DEPARTMENT MTCG TOWER, BOOJU THAKURUPAANU MAGU, MALE 20181, REPUBLIC OF MALDIVES. PHONE: + (960) 332 6822 FAX: + (960) 333 2835 E-MAIL: design.development@mtcc.com.mv</small>	PROJECT TITLE HA. HOARAFUSHI HOSPITAL SERVICES BUILDING	CLIENT & ADDRESS MINISTRY OF HEALTH	DESIGN ARCHITECT: SURVEYING, DESIGN AND DEVELOPMENT SECTION		REV	DESCRIPTION	DATE	APPR	SHEET IDENTIFICATION NUMBER A6.01
	DRAWING TITLE AS GIVEN	PROJECT LOCATION HA. HOARAFUSHI	ENGINEER: AMINATH ZOONA	STRUCTURAL CHECKER: IBRAHIM THOAM					
			ARCHITECT: AMINATH ZOONA	ARCHITECTURAL CHECKER: IRFAN WAHEED	PAPER A3	SCALE AS GVN			SHEET TITLE 10
			DRAWN BY: HASSAN SHAHULAN	CHECKED BY: AMINATH SAMAHA	DATE 10-05-2020				

COPYRIGHT All plans, sketches, drawings, graphic representations and specifications prepared by the Architect(s) & Engineer(s) are instruments of service. The copyright and ownership, of both the design and these instruments of service belong to the Architect(s) & Engineer(s) and may not be used for any other project, or sold, or offered for sale by any party other than the Architect/Engineer unless the Architect/Engineer has given written consent. Copies of the documents submitted to the client prepared by the Architect/Engineer maybe used as they were intended, once, and on the same site and project.

LABEL	G2	W1	W2
▼ FFL			
DESCRIPTION	ROLLER SHUTTER GARAGE DOOR 2	SLIDING WINDOW	SLIDING DOOR
DOOR FRAME	AS PER MANUFACTURER	POWDER COATED ALUMINUM FRAME IN BLACK	POWDER COATED ALUMINUM FRAME IN BLACK
DOOR PANEL	AS PER MANUFACTURER	GLASS DOOR PANEL WITH ALUMINUM FRAME	GLASS DOOR PANEL WITH ALUMINUM FRAME
HARDWARE	AS PER MANUFACTURER	SLIDING RAILING, HANDLE AND LOCKSET	SLIDING RAILING, HANDLE AND LOCKSET
COMMENTS	-	REFLECTIVE GLASS	REFLECTIVE GLASS
LOCATION(S)	MECHANICAL SERVICE CENTER	MEDICAL GAS PLANT ROOM, WASTE MANAGEMENT, OXYGEN PLANT ROOM	SERVICE CENTER, GENERAL STORE, LAUNDRY
NO(S)	1	3	4

 DOOR WINDOW SCHEDULE



 MTCC MALDIVES TRANSPORT & CONTRACTING COMPANY PLC <small>SURVEY DESIGN AND DEVELOPMENT SECTION CONSTRUCTION AND PROJECTS MANAGEMENT DEPARTMENT MTCG TOWER, BOOJU THAKURUPAANU MAGU, MALE 20181, REPUBLIC OF MALDIVES PHONE: + (960) 332 6822 FAX: + (960) 333 2835 E-MAIL: design.development@mtcc.com.mv</small>	PROJECT TITLE HA. HOARAFUSHI HOSPITAL SERVICES BUILDING	CLIENT & ADDRESS MINISTRY OF HEALTH	DESIGN ARCHITECT: SURVEYING, DESIGN AND DEVELOPMENT SECTION		REV	DESCRIPTION	DATE	APPR	SHEET IDENTIFICATION NUMBER A6.02
	DRAWING TITLE AS GIVEN	PROJECT LOCATION HA. HOARAFUSHI	ENGINEER: AMINATH ZOONA	STRUCTURAL CHECKER: IBRAHIM THOAM					
			ARCHITECT: AMINATH ZOONA	ARCHITECTURAL CHECKER: IRFAN WAHEED	PAPER A3	SCALE AS GVN			SHEET TITLE 11
			DRAWN BY: HASSAN SHAHULAN	CHECKED BY: AMINATH SAMAHA	DATE 10-05-2020				

MTCC

MALDIVES TRANSPORT & CONTRACTING COMPANY PLC

SURVEY DESIGN AND DEVELOPMENT SECTION

CONSTRUCTION AND PROJECTS MANAGEMENT DEPARTMENT

MTCC TOWER, BOOJU THAKURUPAANU MAGU, MALE 20181, REPUBLIC OF MALDIVES

PHONE: + (960) 332 6822 FAX: + (960) 333 2835

E-MAIL: design.development@mtcc.com.mv

PROJECT TITLE

HA. HOARAFUSHI HOSPITAL SERVICES BUILDING

DRAWING TITLE

AS GIVEN

CLIENT & ADDRESS

MINISTRY OF HEALTH

PROJECT LOCATION

HA. HOARAFUSHI

DESIGN ARCHITECT:

SURVEYING, DESIGN AND DEVELOPMENT SECTION

ENGINEER:

STRUCTURAL CHECKER:

IBRAHIM THOAM

ARCHITECT:

AMINATH ZOONA

ARCHITECTURAL CHECKER:

IRFAN WAHEED

PAPER

A3

SCALE

AS GVN

DRAWN BY:

HASSAN SHAHULAN

CHECKED BY:

AMINATH SAMAHA

DATE

10-05-2020

REV

DESCRIPTION

DATE

APPR

SHEET IDENTIFICATION NUMBER


A6.03

SHEET TITLE

12


COPYRIGHT All plans, sketches, drawings, graphic representations and specifications prepared by the Architect(s) & Engineer(s) are instruments of service. The copyright and ownership of both the design and these instruments of service belong to the Architect(s) & Engineer(s) and may not be used for any other project, or sold, or offered for sale by any party other than the Architect/Engineer unless the Architect/Engineer has given written consent. Copies of the documents submitted to the client prepared by the Architect/Engineer maybe used as they were intended; once; and on the same site and project.


VENTILATION SCHEDULE

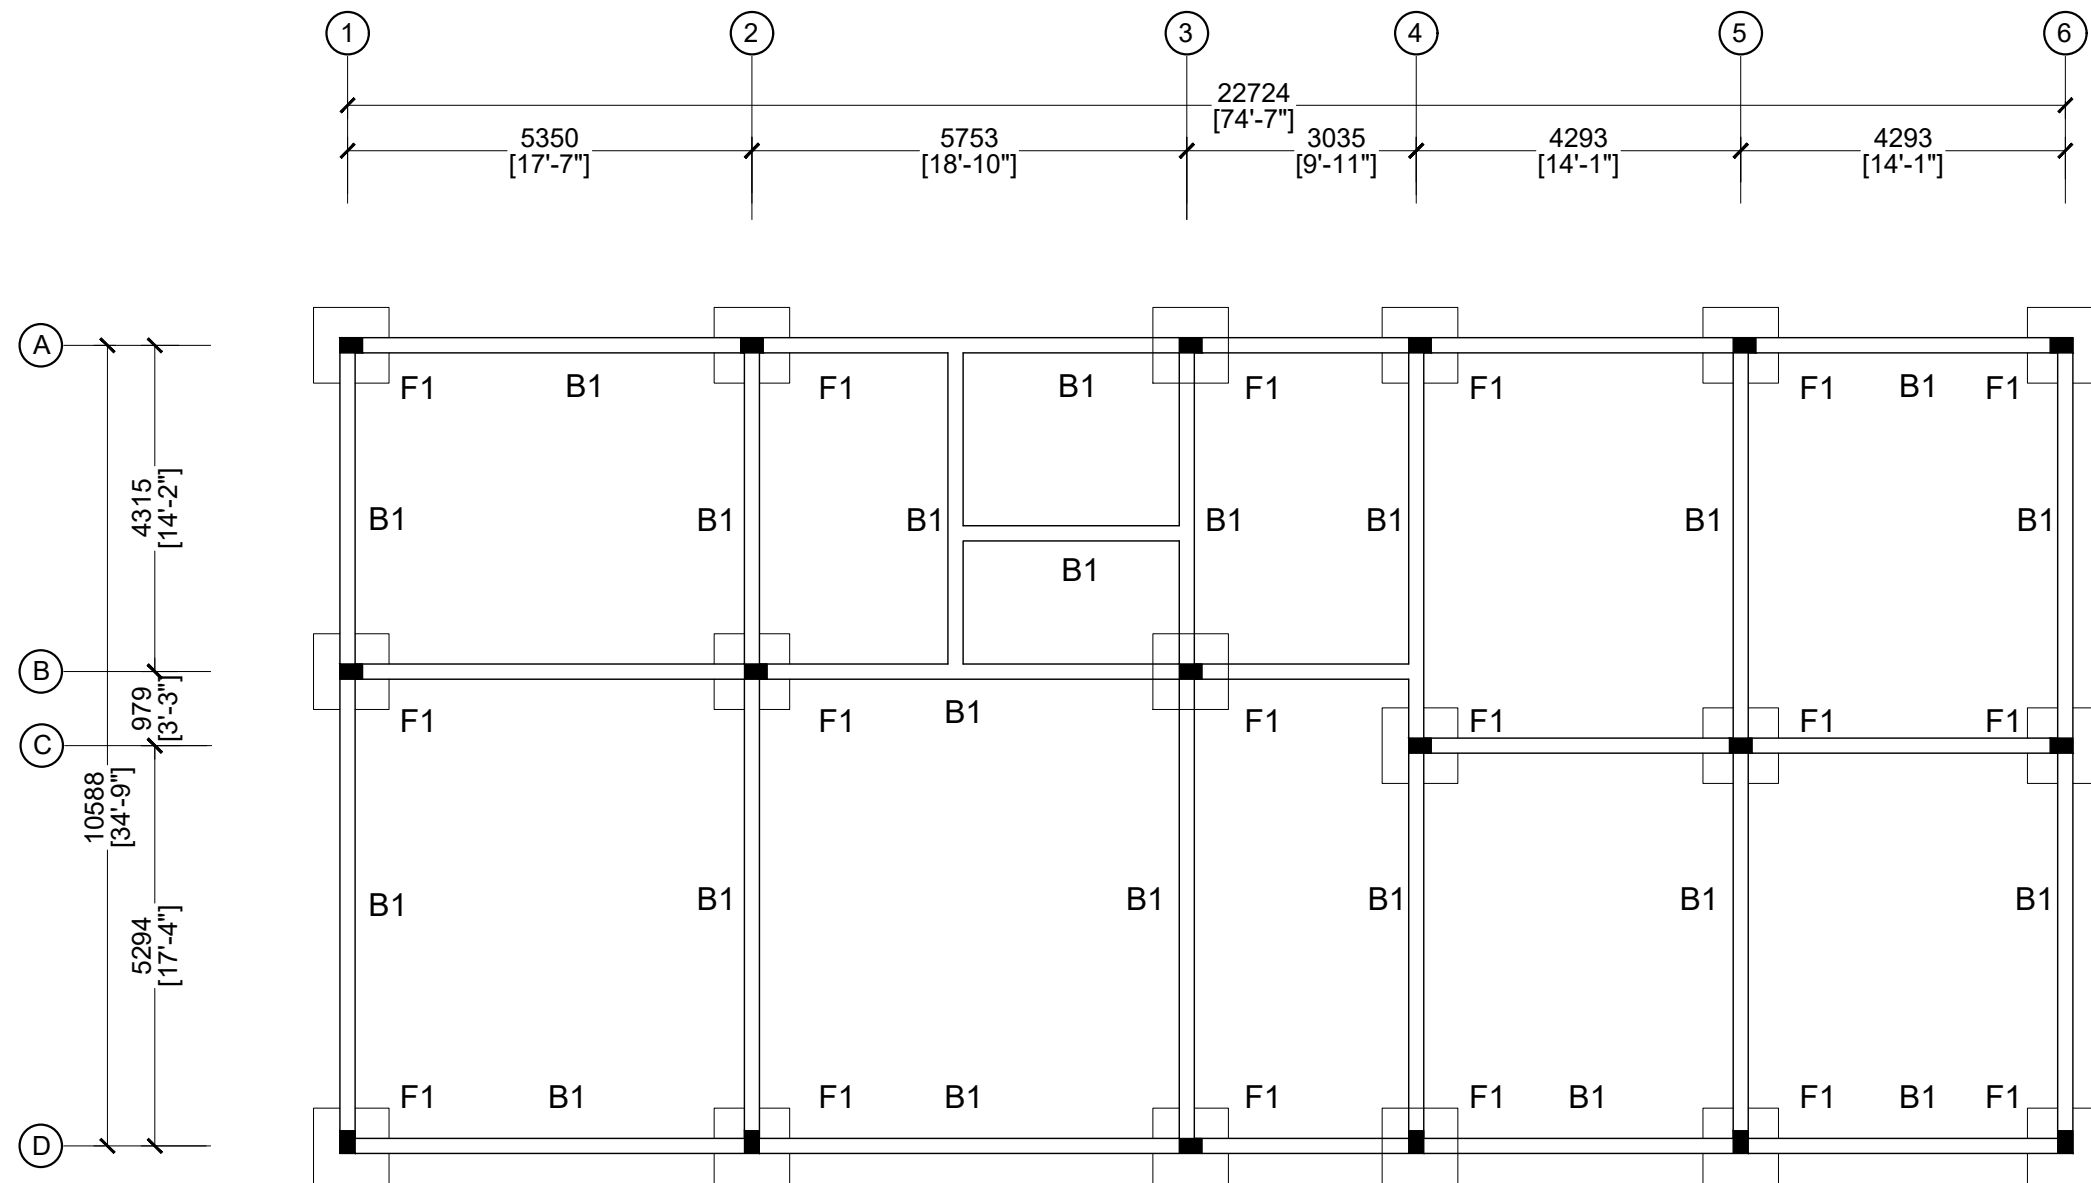


FOOTING AND TIE BEAM PLAN

 SCALE 1:100





 M T C C MALDIVES TRANSPORT & CONTRACTING COMPANY PLC <small>SURVEY DESIGN AND DEVELOPMENT SECTION CONSTRUCTION AND PROJECTS MANAGEMENT DEPARTMENT MTC TOWER, BOOJU THAKURUPAANU MAGU, MALE 20181, REPUBLIC OF MALDIVES PHONE: + (960) 332 6822 FAX: + (960) 333 2835 E-MAIL: design.development@mtrcc.com.mv</small>	PROJECT TITLE HA. HOARAFUSHI HOSPITAL SERVICES BUILDING	CLIENT & ADDRESS MINISTRY OF HEALTH	DESIGN ARCHITECT: SURVEYING, DESIGN AND DEVELOPMENT SECTION		REV	DESCRIPTION	DATE	APPR	SHEET IDENTIFICATION NUMBER S1.01 SHEET TITLE 13
	DRAWING TITLE AS GIVEN	PROJECT LOCATION HA. HOARAFUSHI	ENGINEER:	STRUCTURAL CHECKER: IBRAHIM THOAM					
			ARCHITECT: AMINATH ZOONA	ARCHITECTURAL CHECKER: IRFAN WAHEED	PAPER A3	SCALE AS GVN			
			DRAWN BY: HASSAN SHAHULAN	CHECKED BY: AMINATH SAMAHA	DATE 10-05-2020				



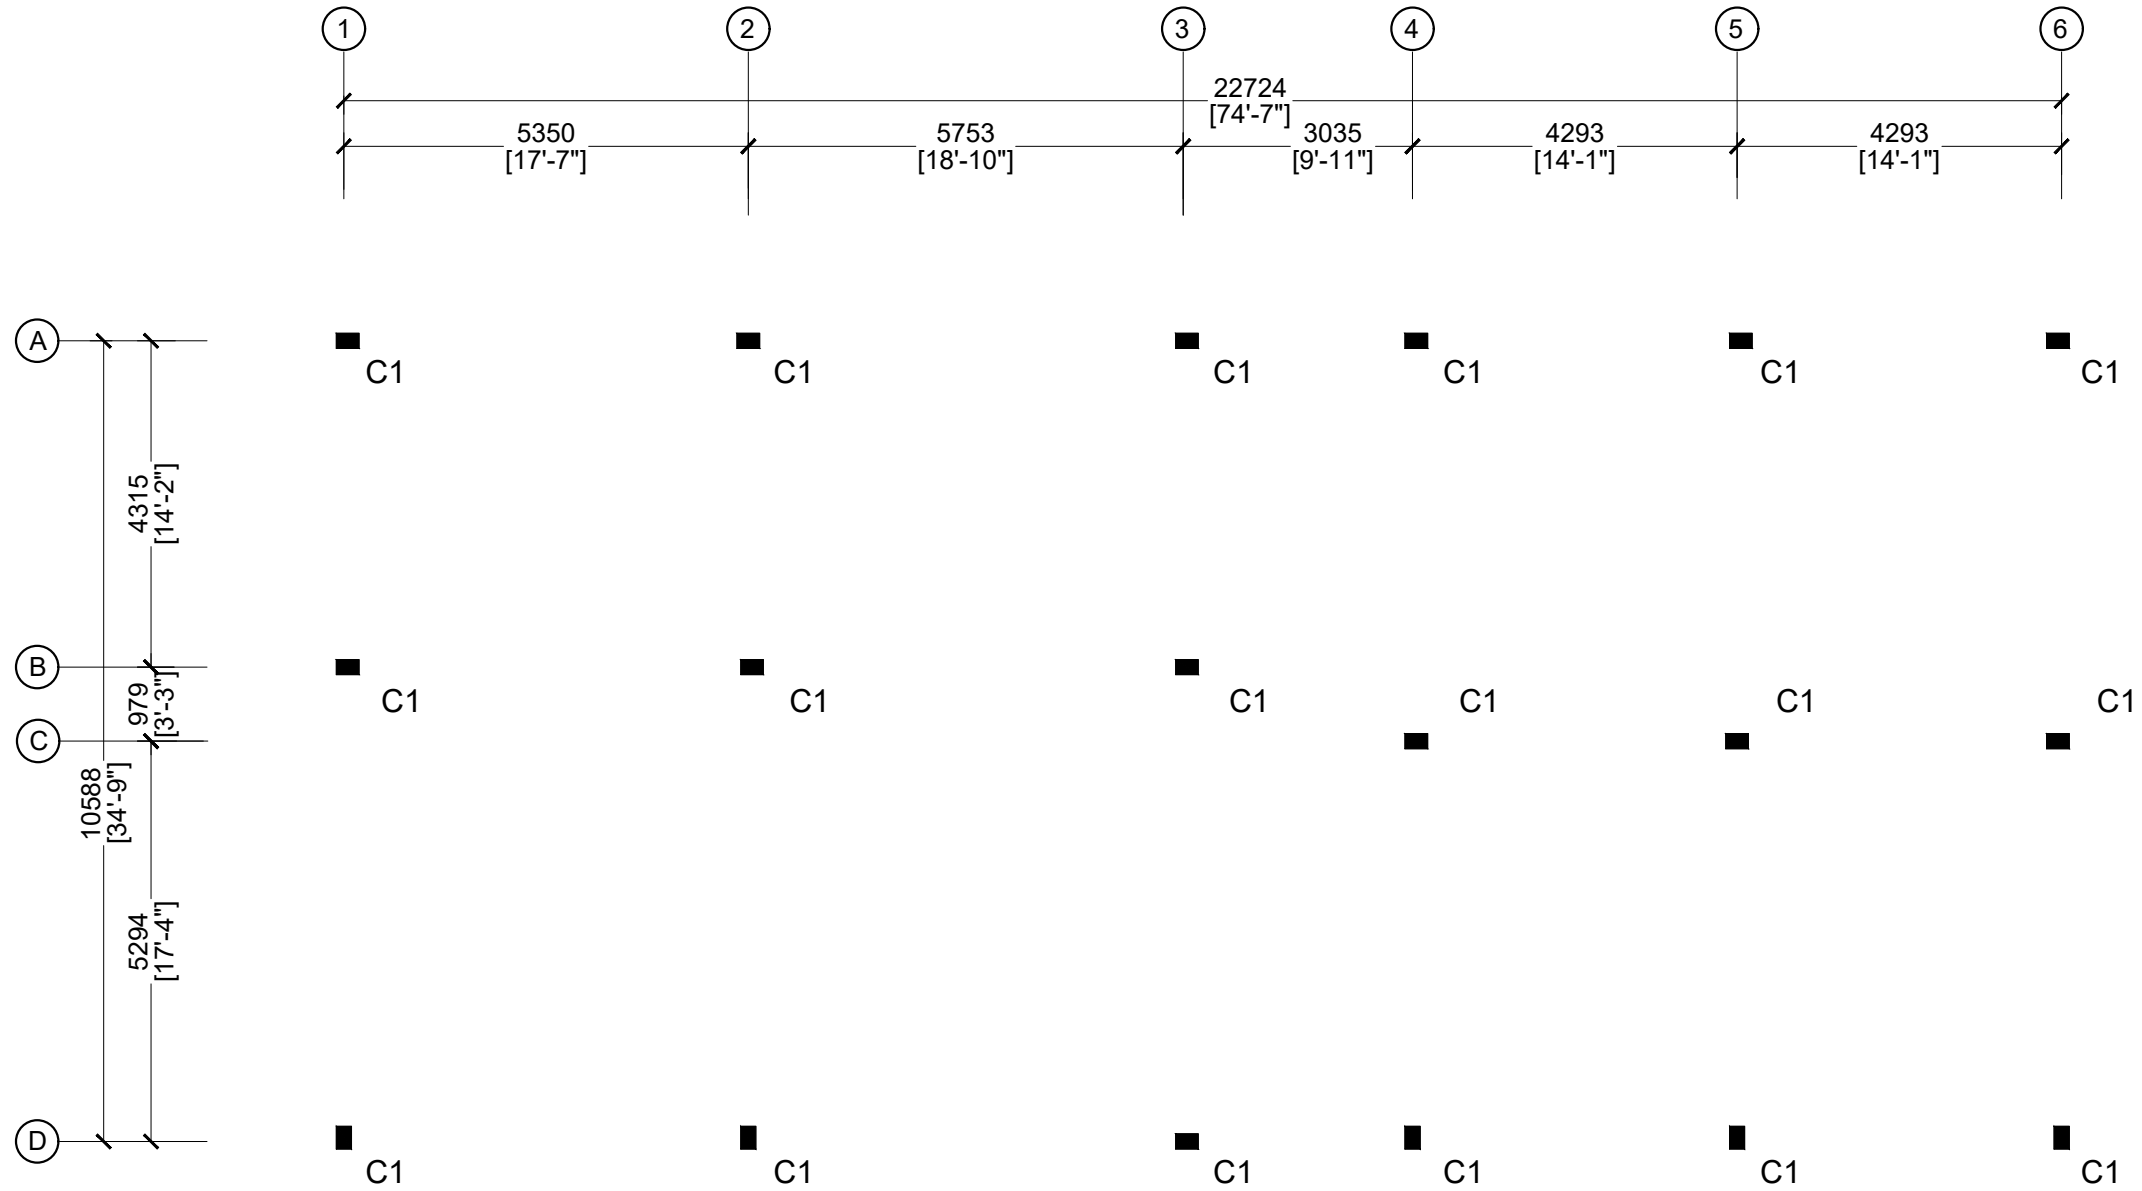


COLUMN PLAN

 SCALE 1:100





<div><p>M T C C MALDIVES TRANSPORT & CONTRACTING COMPANY PLC</p><p><small>SURVEY DESIGN AND DEVELOPMENT SECTION CONSTRUCTION AND PROJECTS MANAGEMENT DEPARTMENT MTCG TOWER, BOOBU THAKURUPAANU MAGU, MALE 20181, REPUBLIC OF MALDIVES. PHONE: + (960) 332 6822 FAX: + (960) 333 2835 E-MAIL: design.development@mtrcc.com.mv</small></p></div>	<div>PROJECT TITLE</div> <div>HA. HOARAFUSHI HOSPITAL SERVICES BUILDING</div>	<div>CLIENT & ADDRESS</div> <div>MINISTRY OF HEALTH</div>	<div>DESIGN ARCHITECT:</div> <div>SURVEYING, DESIGN AND DEVELOPMENT SECTION</div>				<div>REV</div>	<div>DESCRIPTION</div>	<div>DATE</div>	<div>APPR</div>	<div>SHEET IDENTIFICATION NUMBER</div> <div>S1.02</div> <div>SHEET TITLE</div> <div>14</div>
	<div>DRAWING TITLE</div> <div>AS GIVEN</div>		<div>ENGINEER:</div>	<div>STRUCTURAL CHECKER:</div> <div>IBRAHIM THOAM</div>							
	<div>PROJECT LOCATION</div> <div>HA. HOARAFUSHI</div>		<div>ARCHITECT:</div> <div>AMINATH ZOONA</div>	<div>ARCHITECTURAL CHECKER:</div> <div>IRFAN WAHEED</div>	<div>PAPER</div> <div>A3</div>	<div>SCALE</div> <div>AS GVN</div>					
	<div>DRAWN BY:</div> <div>HASSAN SHAHULAN</div>		<div>CHECKED BY:</div> <div>AMINATH SAMAHA</div>	<div>DATE</div> <div>10-05-2020</div>							

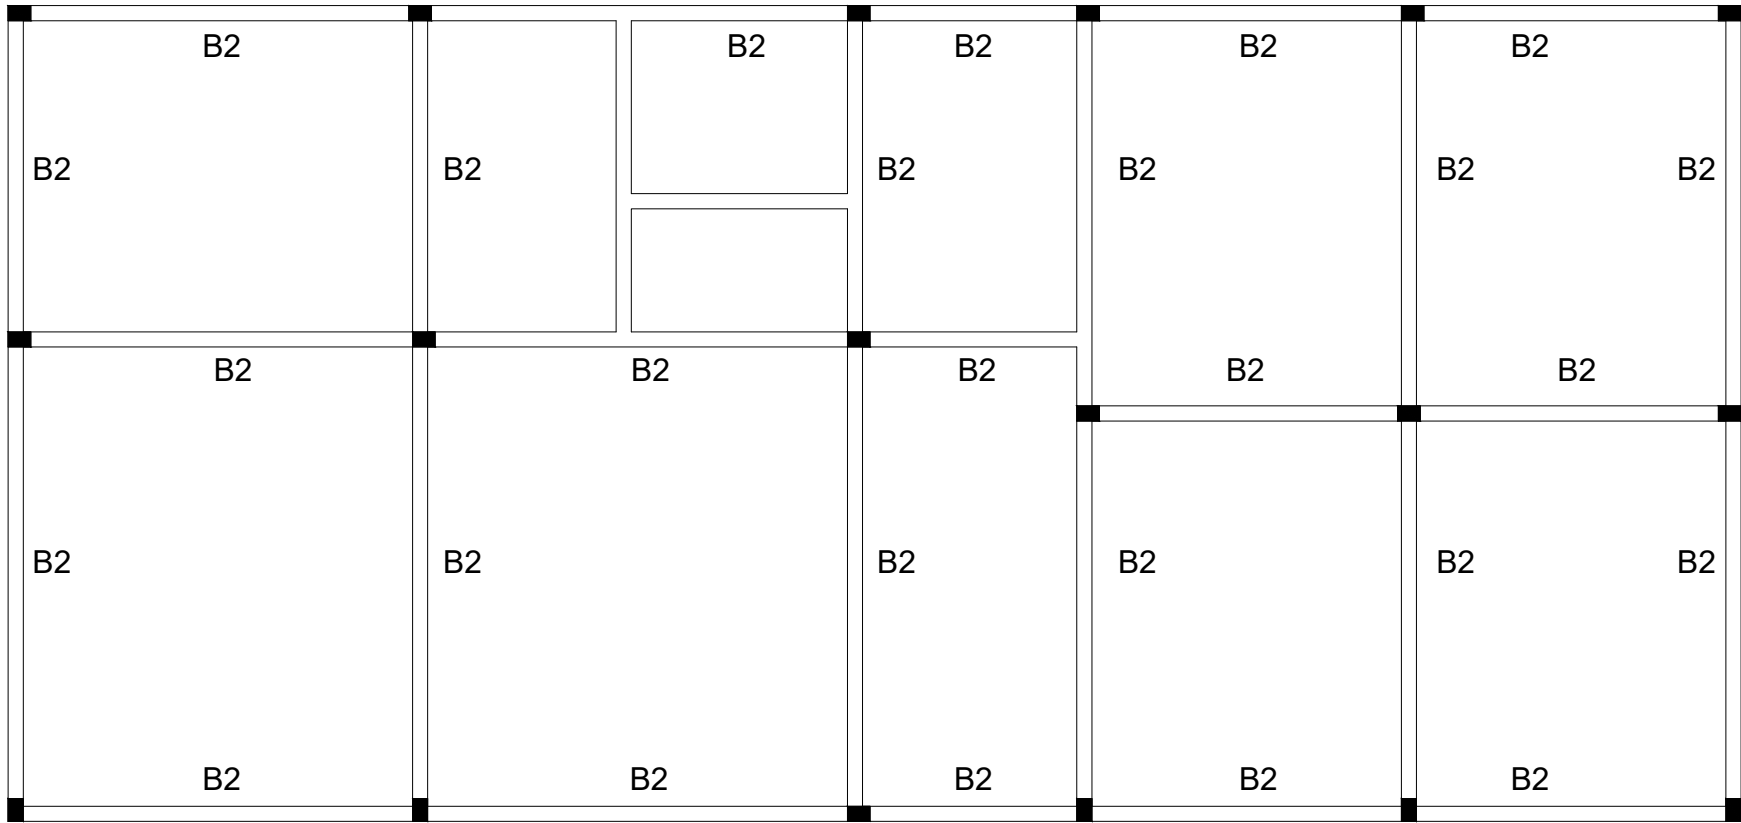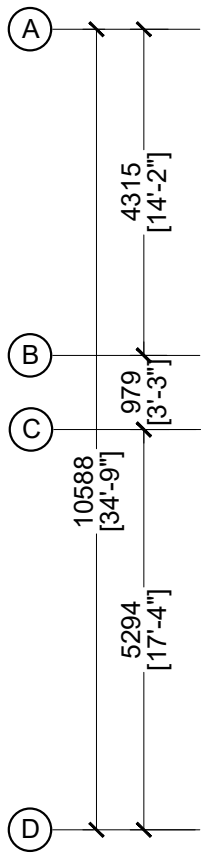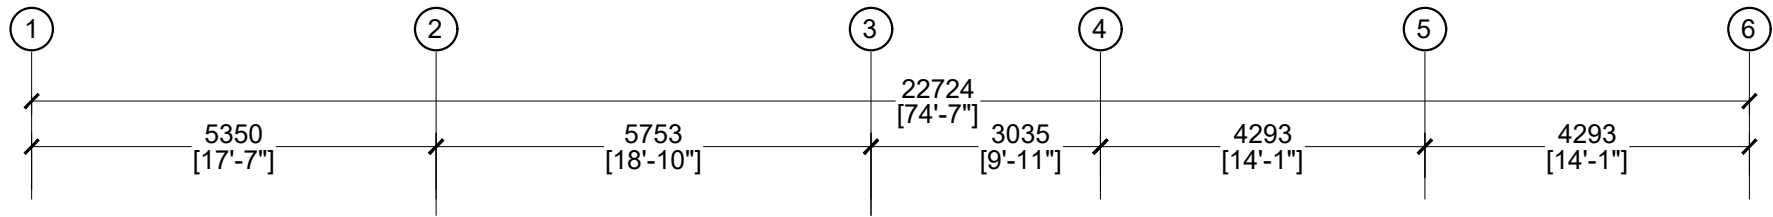

ROOF BEAM PLAN

 SCALE 1:100



 MTCC MALDIVES TRANSPORT & CONTRACTING COMPANY PLC <small>SURVEY DESIGN AND DEVELOPMENT SECTION CONSTRUCTION AND PROJECTS MANAGEMENT DEPARTMENT MTCG TOWER, BOOJU THAKURUPAANU MAGU, MALE 20181, REPUBLIC OF MALDIVES PHONE: + (960) 332 6822 FAX: + (960) 333 2835 E-MAIL: design.development@mtcc.com.mv</small>	PROJECT TITLE HA. HOARAFUSHI HOSPITAL SERVICES BUILDING	CLIENT & ADDRESS MINISTRY OF HEALTH	DESIGN ARCHITECT: SURVEYING, DESIGN AND DEVELOPMENT SECTION				REV	DESCRIPTION	DATE	APPR	SHEET IDENTIFICATION NUMBER S1.03
	DRAWING TITLE AS GIVEN	PROJECT LOCATION HA. HOARAFUSHI	ENGINEER: AMINATH ZOONA	STRUCTURAL CHECKER: IBRAHIM THOAM	ARCHITECTURAL CHECKER: IRFAN WAHEED	PAPER A3	SCALE AS GVN				
			DRAWN BY: HASSAN SHAHULAN	CHECKED BY: AMINATH SAMAHA	DATE 10-05-2020						SHEET TITLE 15



FOOTING F1




SCALE 1:100



A horizontal scale bar with vertical tick marks at 0, 0.5, 1, 2, and 4. The text '0', '0.5', '1', '2', and '4' are placed below the first five tick marks. The word 'METERS' is placed to the right of the final tick mark at 4.

- ## NOTES
- MINIMUM COVER TO REINFORCEMENT
 - FOUNDATION =50MM
 - SLAB =30MM
 - BEAMS =35MM
 - COLUMNS =40MM
 - BEAMS BEND-UP BARS =12XDIA
 - ANCHOR BARS =55XDIA
 - LAPPING BARS =45XDIA
 - MID BARS =0.85XSPAN
 - SUPPORT BARS = $\frac{1}{3}$ X SPAN

 <p>MTCC MALDIVES TRANSPORT & CONTRACTING COMPANY PLC</p> <p><small>SURVEY DESIGN AND DEVELOPMENT SECTION CONSTRUCTION AND PROJECTS MANAGEMENT DEPARTMENT MTCC TOWER, BODU THAKURUPPANA MAGU, MALE 20181, REPUBLIC OF MALDIVES. PHONE: +(960) 332 6822 FAX: +(960) 333 2835 E-MAIL: design.development@mtcc.com.mv</small></p>	PROJECT TITLE HA. HOARAFUSHI HOSPITAL SERVICES BUILDING	CLIENT & ADDRESS MINISTRY OF HEALTH	DESIGN ARCHITECT: SURVEYING, DESIGN AND DEVELOPMENT SECTION				<table border="1"> <thead> <tr> <th>REV</th> <th>DESCRIPTION</th> <th>DATE</th> <th>APPR</th> </tr> </thead> <tbody> <tr><td> </td><td> </td><td> </td><td> </td></tr> <tr><td> </td><td> </td><td> </td><td> </td></tr> <tr><td> </td><td> </td><td> </td><td> </td></tr> <tr><td> </td><td> </td><td> </td><td> </td></tr> <tr><td> </td><td> </td><td> </td><td> </td></tr> <tr><td> </td><td> </td><td> </td><td> </td></tr> <tr><td> </td><td> </td><td> </td><td> </td></tr> <tr><td> </td><td> </td><td> </td><td> </td></tr> <tr><td> </td><td> </td><td> </td><td> </td></tr> </tbody> </table>	REV	DESCRIPTION	DATE	APPR																																					SHEET IDENTIFICATION NUMBER <div>S5.01</div>
	REV	DESCRIPTION	DATE	APPR																																												
DRAWING TITLE AS GIVEN	PROJECT LOCATION HA. HOARAFUSHI	ENGINEER:	STRUCTURAL CHECKER: IBRAHIM THOAM	<table border="1"> <tr> <td>PAPER A3</td> <td>SCALE AS GVN</td> </tr> </table>	PAPER A3	SCALE AS GVN																																										
PAPER A3	SCALE AS GVN																																															
		ARCHITECT: AMINATH ZOONA	ARCHITECTURAL CHECKER: IRFAN WAHEED	<table border="1"> <tr> <td>CHECKED BY: HASSAN SHAHULAN</td> <td>DATE 10-05-2020</td> </tr> </table>	CHECKED BY: HASSAN SHAHULAN	DATE 10-05-2020	SHEET TITLE 16																																									
CHECKED BY: HASSAN SHAHULAN	DATE 10-05-2020																																															