

BUILDING SERVICES DRAWINGS OF
PROPOSED 03 STOREY BUILDING
SH. FUNADHOO 15 CLASSROOM BLOCK
For Ministry Of Education

By Epoch Associates Pvt. Ltd



EPOCH

T: +960 333 3528 **E:** info@epoch.associates **W:** www.epoch.associates
A: 3rd Floor, G.Rosary West, Husnuheena Magu, Male' Republic of Maldives

Legend

- 13A Twin Socket
- 13A Power Socket
- 15A Switched Socket @ H.L.

Distribution Board

HL. High Level

Emergency Light

Wall Mounted Speaker

Internet Switchboard

Electricity Meter

Computer Network Twin Outlet

HDMI Socket

Ceiling Mounted Exhaust Fan 90m3/hr


Wall Mounted Exhaust Fan

Main Incoming Cable For Power PVC Duct Below Ground

82Ø PVC Duct For Internet Cables Lead In Below Ground Slab

Notes: -

- All Twin Sockets At 300mm From F.F.L. Except Stated Otherwise
- All Computer, Telephone Points At 300mm From F.F.L.
- All electrical components shall be connected to respective Distribution Box in the same area as the component.
- All electrical components in common areas, corridors and staircase should be connected to Common Area DB
- Wall Speaker shall be connected to Public address system of school

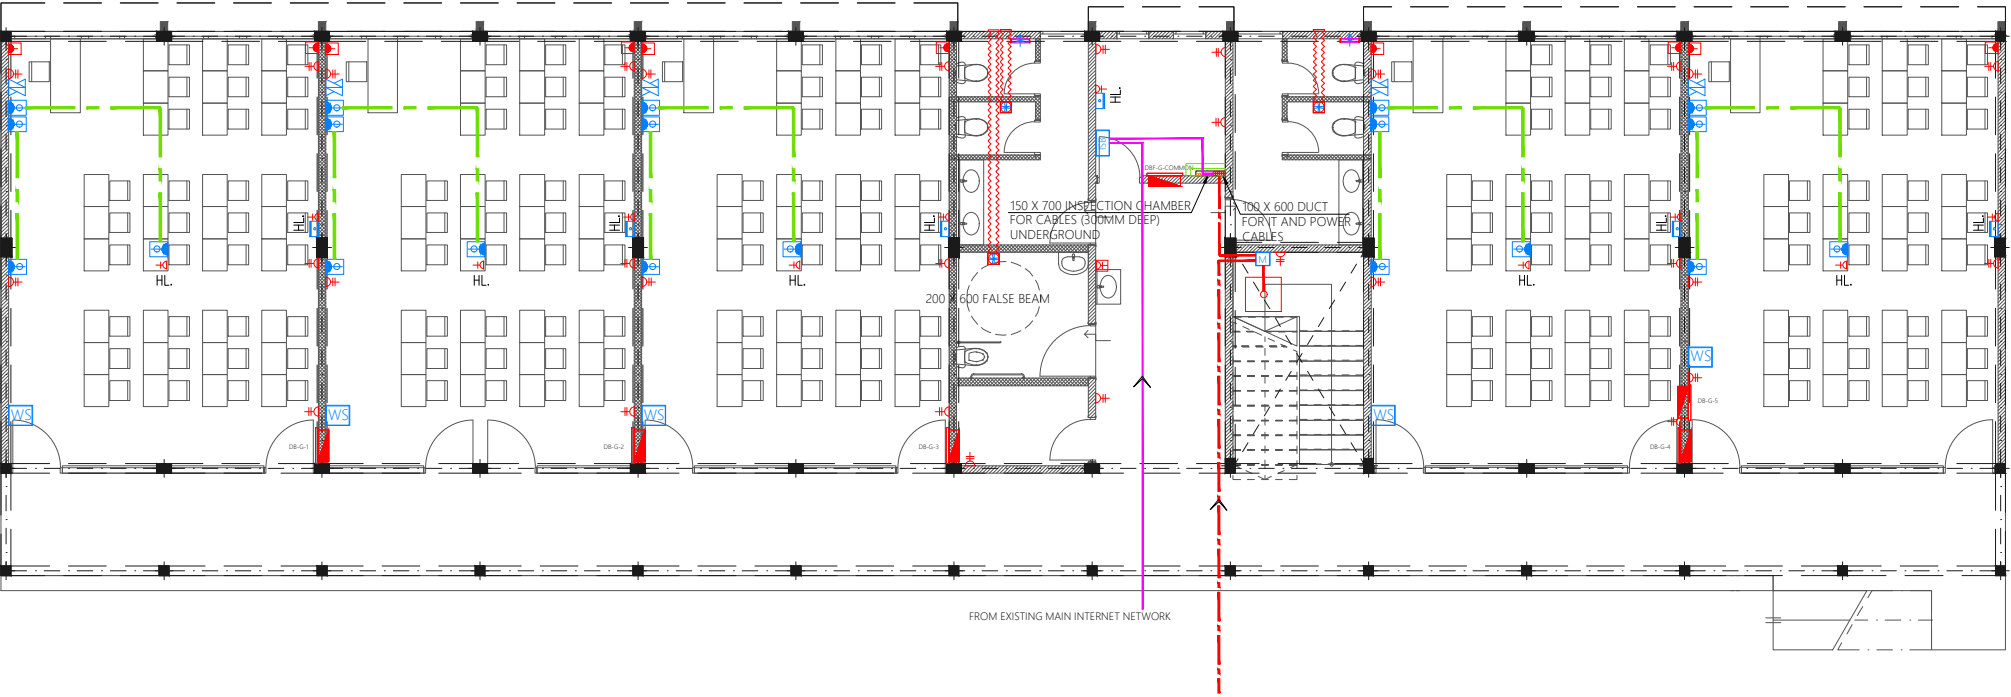

GROUND FLOOR POWER AND ACV LAYOUT
1:150

PROPOSED 03 STOREY BUILDING
Sh. Funadhoo
15 Classroom Block

Client:
Ministry Of Education

April 2021
Services By: Mohamed Rassam
Checked By:
Drawn By: Mohamed Zaidhan

EPOCH
T: +960 333 3528, E: info@epoch.associates
W: www.epoch.associates, A: G. Rosary West,
Husnuheena Magu, Male' Republic of Maldives


Rev: ---
Page: PAC-01

Legend

- 13A Twin Socket
- 13A Power Socket
- 15A Switched Socket @ H.L.
- Distribution Board
- HL. High Level
- Emergency Light
- WS Wall Mounted Speaker
- ISB Internet Switchboard
- M Electricity Meter
- Computer Network Twin Outlet
- HDMI Socket
- Ceiling Mounted Exhaust Fan 90m3/hr
- Wall Mounted Exhaust Fan

- Main Incoming Cable For Power PVC Duct Below Ground
- 82Ø PVC Duct For Internet Cables Lead In Below Ground Slab

- Notes: -
- All Twin Sockets At 300mm From F.F.L. Except Stated Otherwise
 - All Computer, Telephone Points At 300mm From F.F.L.
 - All electrical components shall be connected to respective Distribution Box in the same area as the component.
 - All electrical components in common areas, corridors and staircase should be connected to Common Area DB
 - Wall Speaker shall be connected to Public address system of school

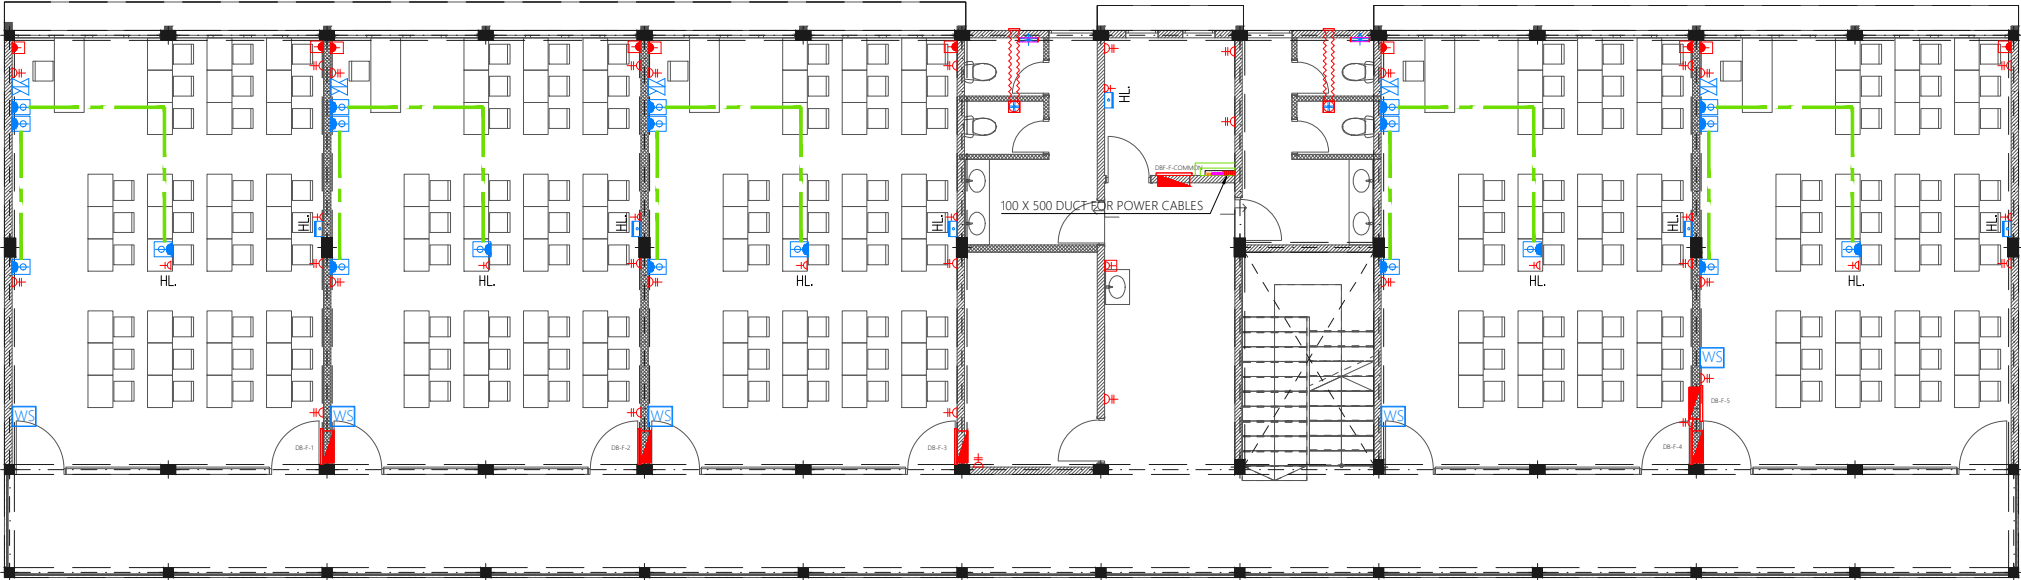

PROPOSED 03 STOREY BUILDING
Sh. Funadhoo
15 Classroom Block

Client:
Ministry Of Education

April 2021

Services By: **Mohamed Rassam**
Checked By:
Drawn By: **Mohamed Zaidhan**


EPOCH
T: +960 333 3528, E: info@epoch.associates
W: www.epoch.associates, A: G. Rosary West,
Husnuheena Magu, Male' Republic of Maldives

Rev:	Page:
---	PAC-02
---	---
---	---


Legend

- 13A Twin Socket
- 13A Power Socket
- 15A Switched Socket @ H.L.
- Distribution Board
- HL. High Level
- Emergency Light
- WS Wall Mounted Speaker
- ISB Internet Switchboard
- M Electricity Meter
- Computer Network Twin Outlet
- HDMI Socket
- Ceiling Mounted Exhaust Fan 90m3/hr
- Wall Mounted Exhaust Fan

- Main Incoming Cable For Power PVC Duct Below Ground
- 82Ø PVC Duct For Internet Cables Lead In Below Ground Slab

Notes: -

- All Twin Sockets At 300mm From F.F.L. Except Stated Otherwise
- All Computer, Telephone Points At 300mm From F.F.L.
- All electrical components shall be connected to respective Distribution Box in the same area as the component.
- All electrical components in common areas, corridors and staircase should be connected to Common Area DB
- Wall Speaker shall be connected to Public address system of school

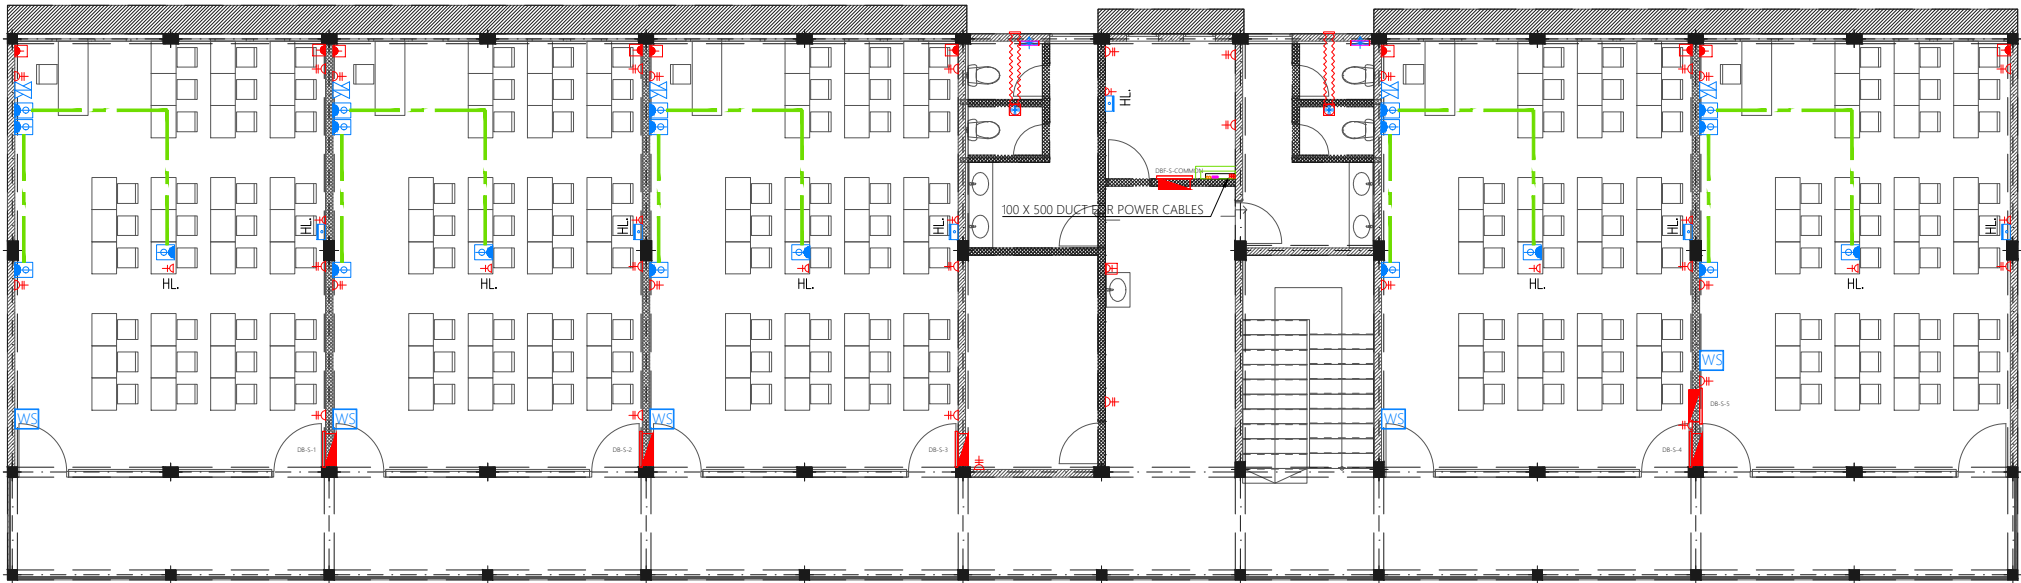

SECOND FLOOR POWER AND ACV LAYOUT
1:150

PROPOSED 03 STOREY BUILDING
Sh. Funadhoo
15 Classroom Block










Client:
Ministry Of Education


April 2021
Services By: **Mohamed Rassam**
Checked By:
Drawn By: **Mohamed Zaidhan**

EPOCH
T: +960 333 3528, E: info@epoch.associates
W: www.epoch.associates, A: G. Rosary West,
Husnuheena Magu, Male' Republic of Maldives

Rev: ---
Page: PAC-03

Legend

-  CO₂ Extinguisher (load: 2kg) In Polycarbonate Enclosure
-  H₂O Extinguisher (load: 9L) In Polycarbonate Enclosure
-  Manual Call Point (At 1200mm from F.F.L.)
-  Smoke Detector
-  Beacon
-  Sounder Bell
-  2.5mm² Fire Retardant Low Smoke (FRLS) Cables In FRLS Conduits
-  Fire Alarm Control Panel
-  Exit Sign

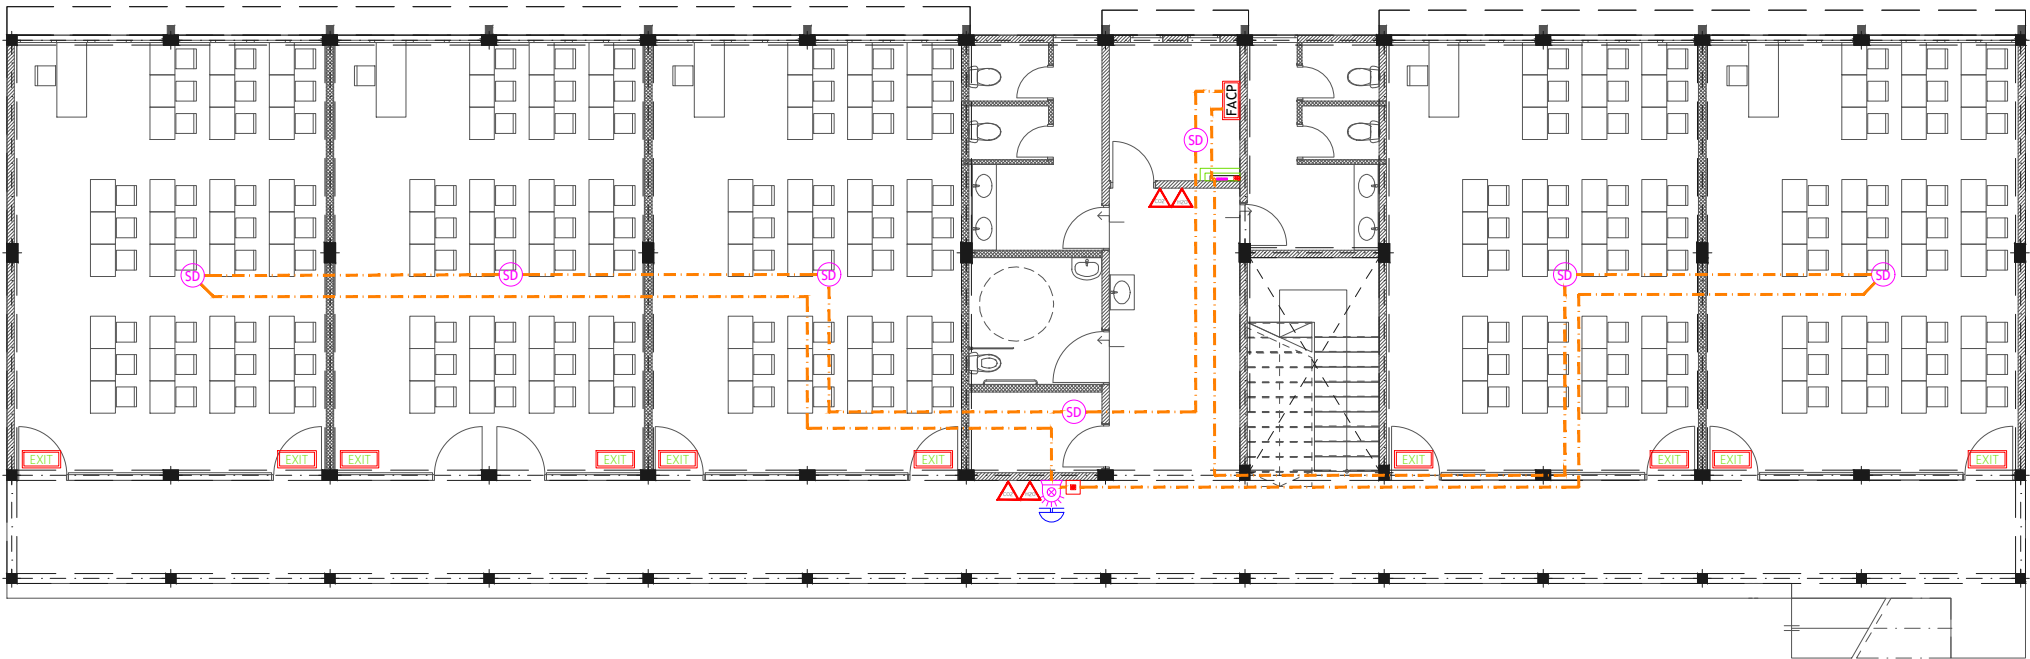

GROUND FLOOR FDP LAYOUT
1:150

PROPOSED 03 STOREY BUILDING
Sh. Funadhoo
15 Classroom Block

Client:
Ministry Of Education










April 2021


Services By: Mohamed Rassam
Checked By:
Drawn By: Mohamed Zaidhan


EPOCH
T: +960 333 3528, E: info@epoch.associates
W: www.epoch.associates, A: G. Rosary West,
Husnuheena Magu, Male' Republic of Maldives

Rev:	Page:
---	FDP -01
---	---
---	---

Legend

-  CO₂ Extinguisher (load: 2kg) In Polycarbonate Enclosure
-  H₂O Extinguisher (load: 9L) In Polycarbonate Enclosure
-  Manual Call Point (At 1200mm from F.F.L.)
-  Smoke Detector
-  Beacon
-  Sounder Bell
-  2.5mm² Fire Retardant Low Smoke (FRLS) Cables In FRLS Conduits
-  Fire Alarm Control Panel
-  Exit Sign

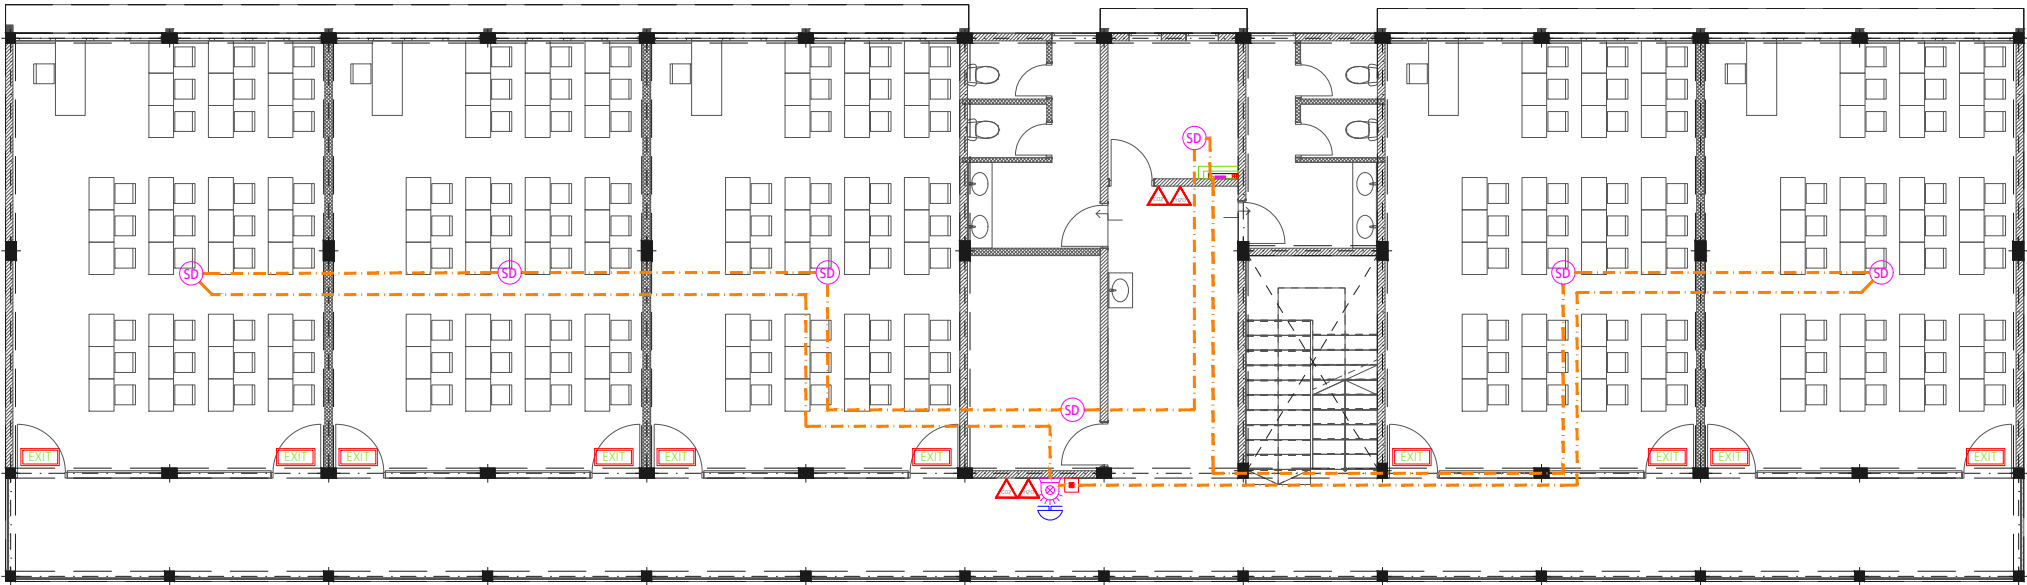

FIRST FLOOR FDP LAYOUT
1:150

PROPOSED 03 STOREY BUILDING
Sh. Funadhoo
15 Classroom Block

Client:
Ministry Of Education

April 2021










Services By: Mohamed Rassam
Checked By:
Drawn By: Mohamed Zaidhan



EPOCH

T: +960 333 3528, **E:** info@epoch.associates
W: www.epoch.associates, **A:** G.Rosary West,
Husnuheena Magu, Male' Republic of Maldives

Rev:	Page:
---	FDP -02

Legend

-  CO₂ Extinguisher (load: 2kg) In Polycarbonate Enclosure
-  H₂O Extinguisher (load: 9L) In Polycarbonate Enclosure
-  Manual Call Point (At 1200mm from F.F.L.)
-  Smoke Detector
-  Beacon
-  Sounder Bell
-  2.5mm² Fire Retardant Low Smoke (FRLS) Cables In FRLS Conduits
-  Fire Alarm Control Panel
-  Exit Sign

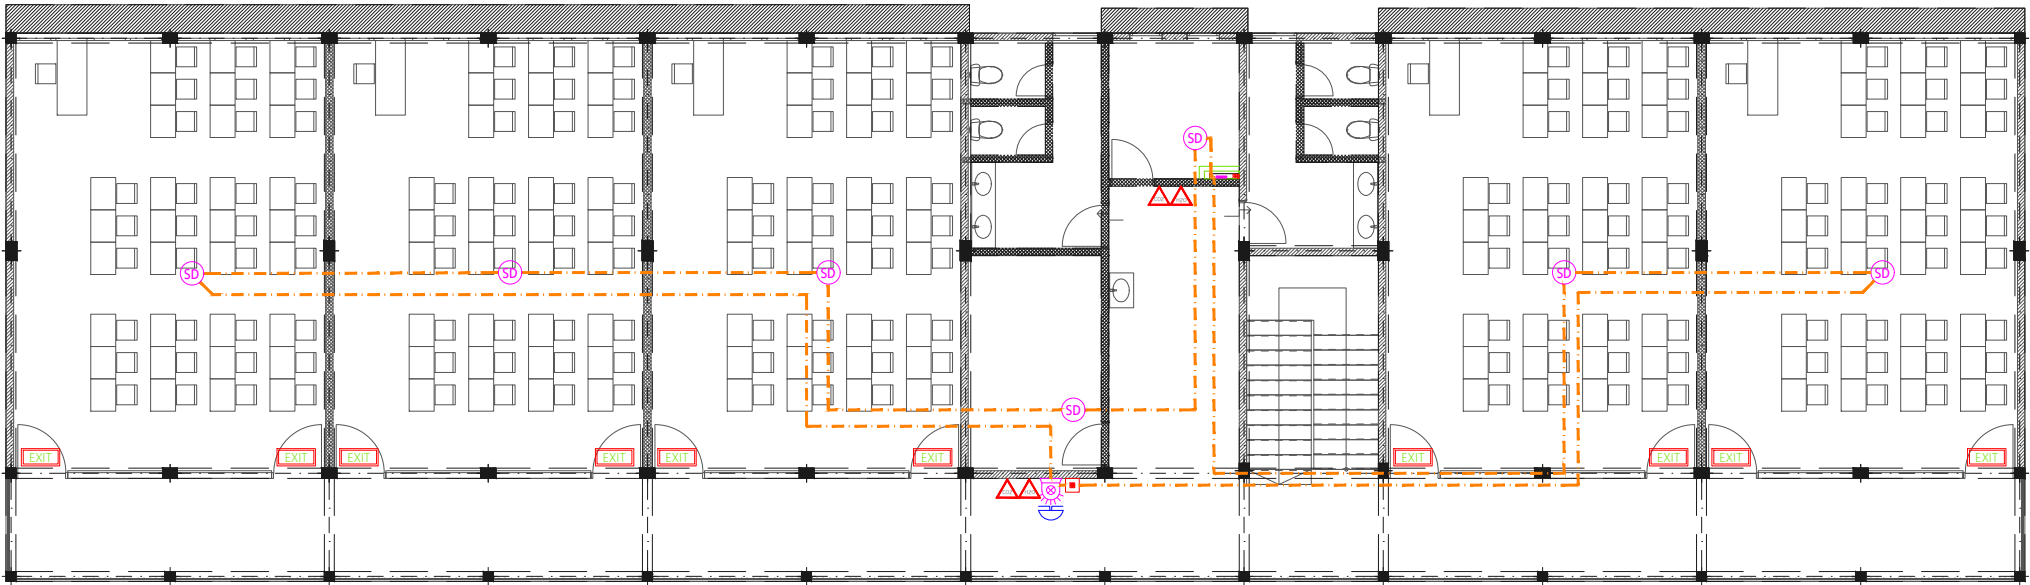

SECOND FLOOR FDP LAYOUT
1:150

PROPOSED 03 STOREY BUILDING
**Sh. Funadhoo
15 Classroom Block**

Client:
Ministry Of Education












April 2021


Services By: Mohamed Rassam
Checked By:
Drawn By: Mohamed Zaidhan


EPOCH
T: +960 333 3528, E: info@epoch.associates
W: www.epoch.associates, A: G. Rosary West,
Husnuheena Magu, Male' Republic of Maldives

Rev:	Page:
---	FDP -03

Legend

-  Ceiling Recessed Spot Light (3W)
-  Ceiling Light (12W)
-  Recessed Ceiling Light (12W)
-  Ceiling Down Light (18W) - Weather Proof
-  3 Ft Led Tube Light
-  100W, HPS, Wall Mounted Light, IP 65
-  Light and Fan Switch (1 Gang - 5 Gang)
-  Ceiling Fan Switch With Controller
-  Ceiling Mounted Exhaust Fan 90m3/hr
-  Wall Mounted Exhaust Fan
-  42" To 48" Ceiling Fan

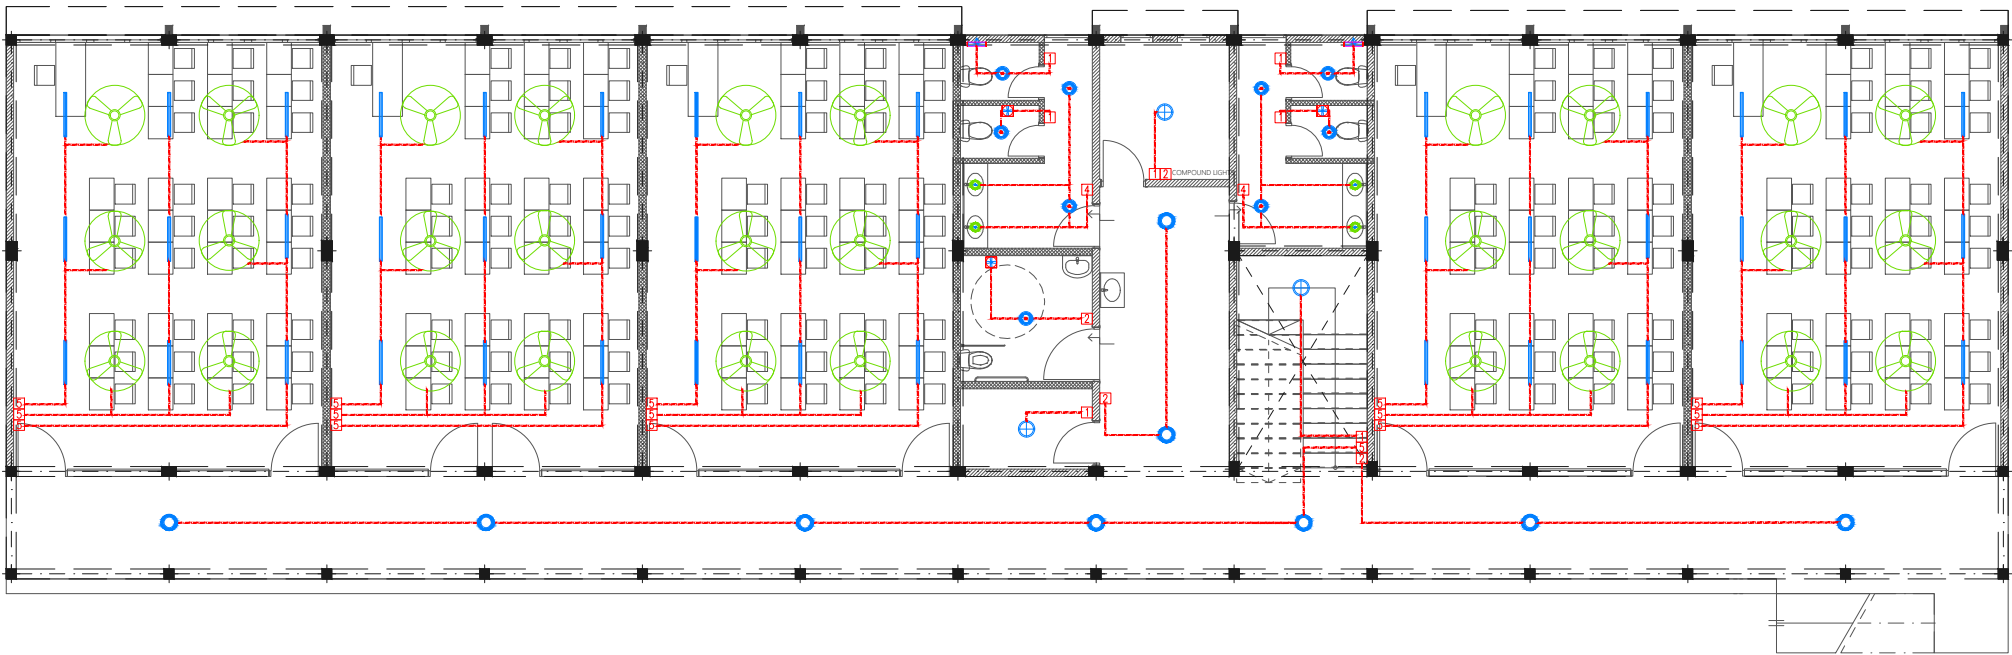

GROUND FLOOR LIGHTING LAYOUT
1:150

PROPOSED 03 STOREY BUILDING
Sh. Funadhoo
15 Classroom Block












Client:
Ministry Of Education


April 2021
Services By: Mohamed Rassam
Checked By:
Drawn By: Mohamed Zaidhan


EPOCH
T: +960 333 3528, E: info@epoch.associates
W: www.epoch.associates, A: G. Rosary West,
Husnuheena Magu, Male' Republic of Maldives

Rev:	Page:
---	EL -01
---	---
---	---

Legend

-  Ceiling Recessed Spot Light (3W)
-  Ceiling Light (12W)
-  Recessed Ceiling Light (12W)
-  Ceiling Down Light (18W) - Weather Proof
-  3 Ft Led Tube Light
-  100W, HPS, Wall Mounted Light, IP 65
-  Light and Fan Switch (1 Gang - 5 Gang)
-  Ceiling Fan Switch With Controller
-  Ceiling Mounted Exhaust Fan 90m3/hr
-  Wall Mounted Exhaust Fan
-  42" To 48" Ceiling Fan

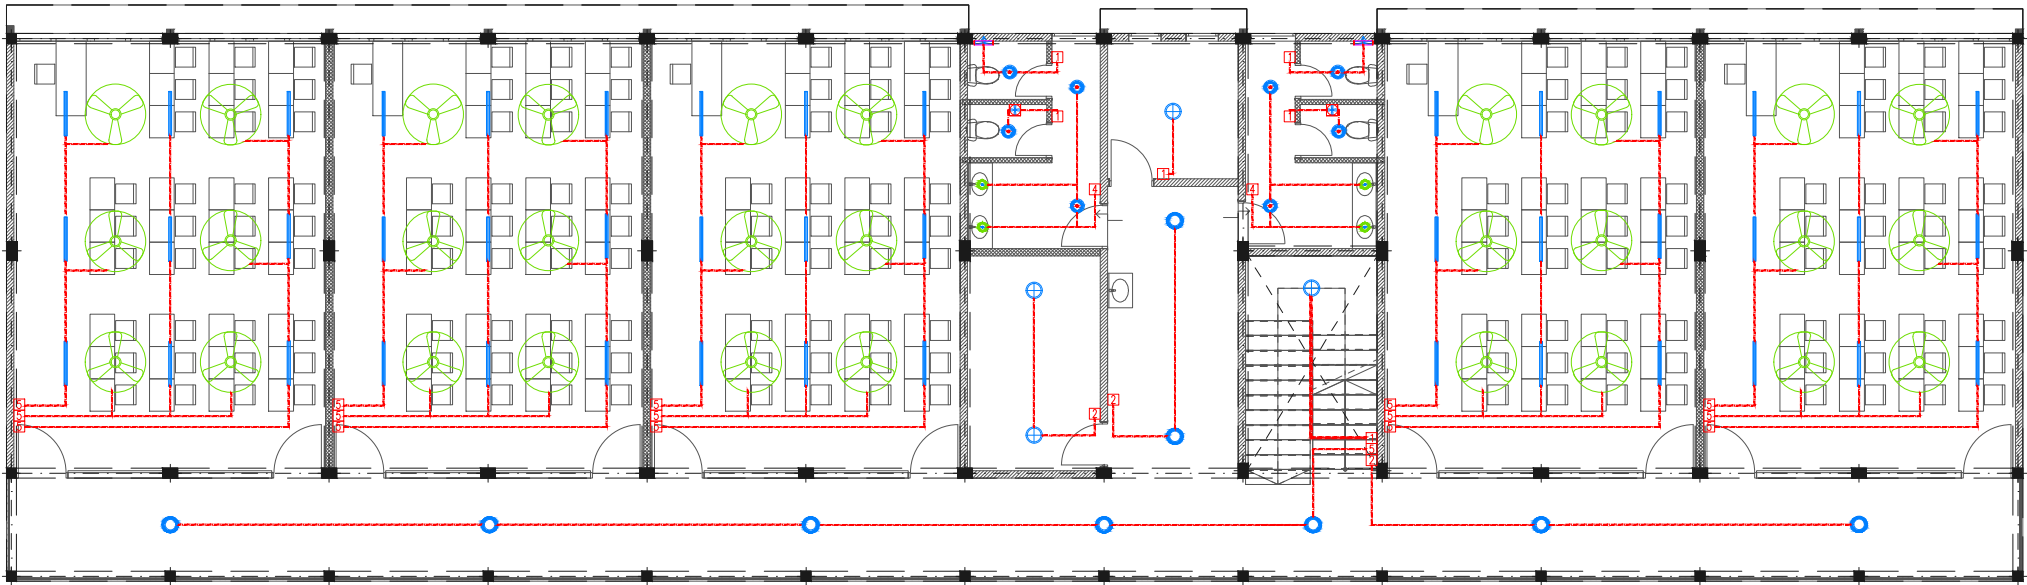

FIRST FLOOR LIGHTING LAYOUT

1:150

PROPOSED 03 STOREY BUILDING
Sh. Funadhoo
15 Classroom Block

Client:
Ministry Of Education

April 2021
Services By: Mohamed Rassam
Checked By:
Drawn By: Mohamed Zaidhan














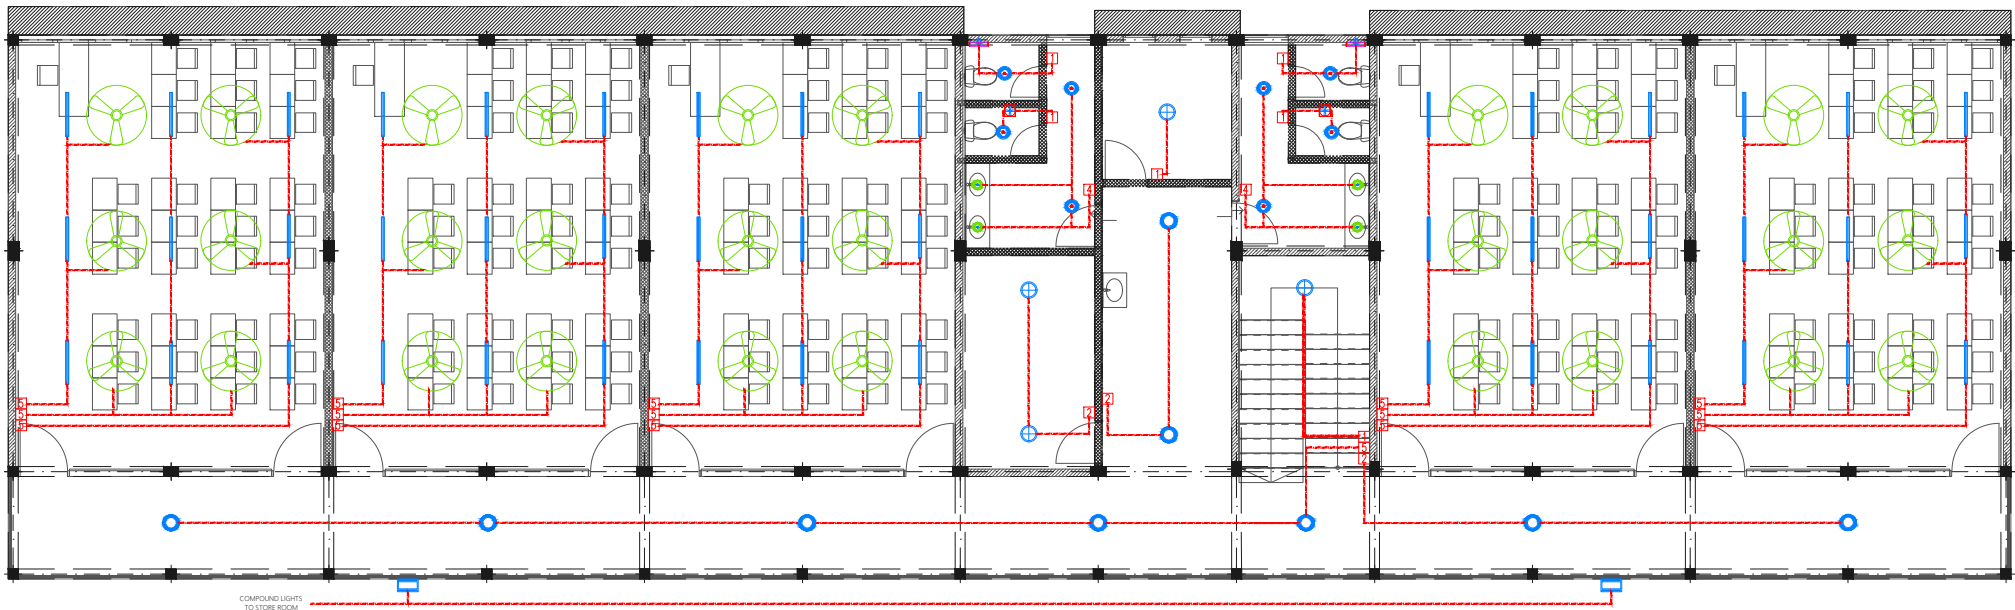
EPOCH

T: +960 333 3528, E: info@epoch.associates
W: www.epoch.associates, A: G. Rosary West,
Husnuheena Magu, Male' Republic of Maldives

Rev:	Page:
---	EL -02

Legend

-  Ceiling Recessed Spot Light (3W)
-  Ceiling Light (12W)
-  Recessed Ceiling Light (12W)
-  Ceiling Down Light (18W) - Weather Proof
-  3 Ft Led Tube Light
-  100W, HPS, Wall Mounted Light, IP 65
-  Light and Fan Switch (1 Gang - 5 Gang)
-  Ceiling Fan Switch With Controller
-  Ceiling Mounted Exhaust Fan 90m3/hr
-  Wall Mounted Exhaust Fan
-  42" To 48" Ceiling Fan



SECOND FLOOR LIGHTING LAYOUT
1:150

PROPOSED 03 STOREY BUILDING
Sh. Funadhoo
15 Classroom Block

Client:
Ministry Of Education

April 2021
Services By: Mohamed Rassam
Checked By:
Drawn By: Mohamed Zaidhan


EPOCH
T: +960 333 3528, E: info@epoch.associates
W: www.epoch.associates, A: G. Rosary West,
Husnuheena Magu, Male' Republic of Maldives


Rev:	Page:
---	EL -03
---	---
---	---

Legend

- 16Ø Cold Water Supply To Basin Faucet
- 16Ø Cold Water Supply To Bidet Shower
- 16Ø Cold Water Supply To Cistern
- Gate Valve
- Rise In Wall
- Drop In Wall
- Angle Valve with cap for Ground Water Supply
- 25Ø Cold Water Supply Pipes Running Underground
- 20Ø Cold Water Supply Pipes Running In Wall
- 20Ø Cold Water Supply Pipes Running Above False Ceiling
- 20Ø Cold Water Supply Pipes Running Underground
- 25Ø Ground Water Supply Pipes

Notes: -

- All Cold Water Pipes Should Be PVC
- All Hot Water Pipes Should Be PPR

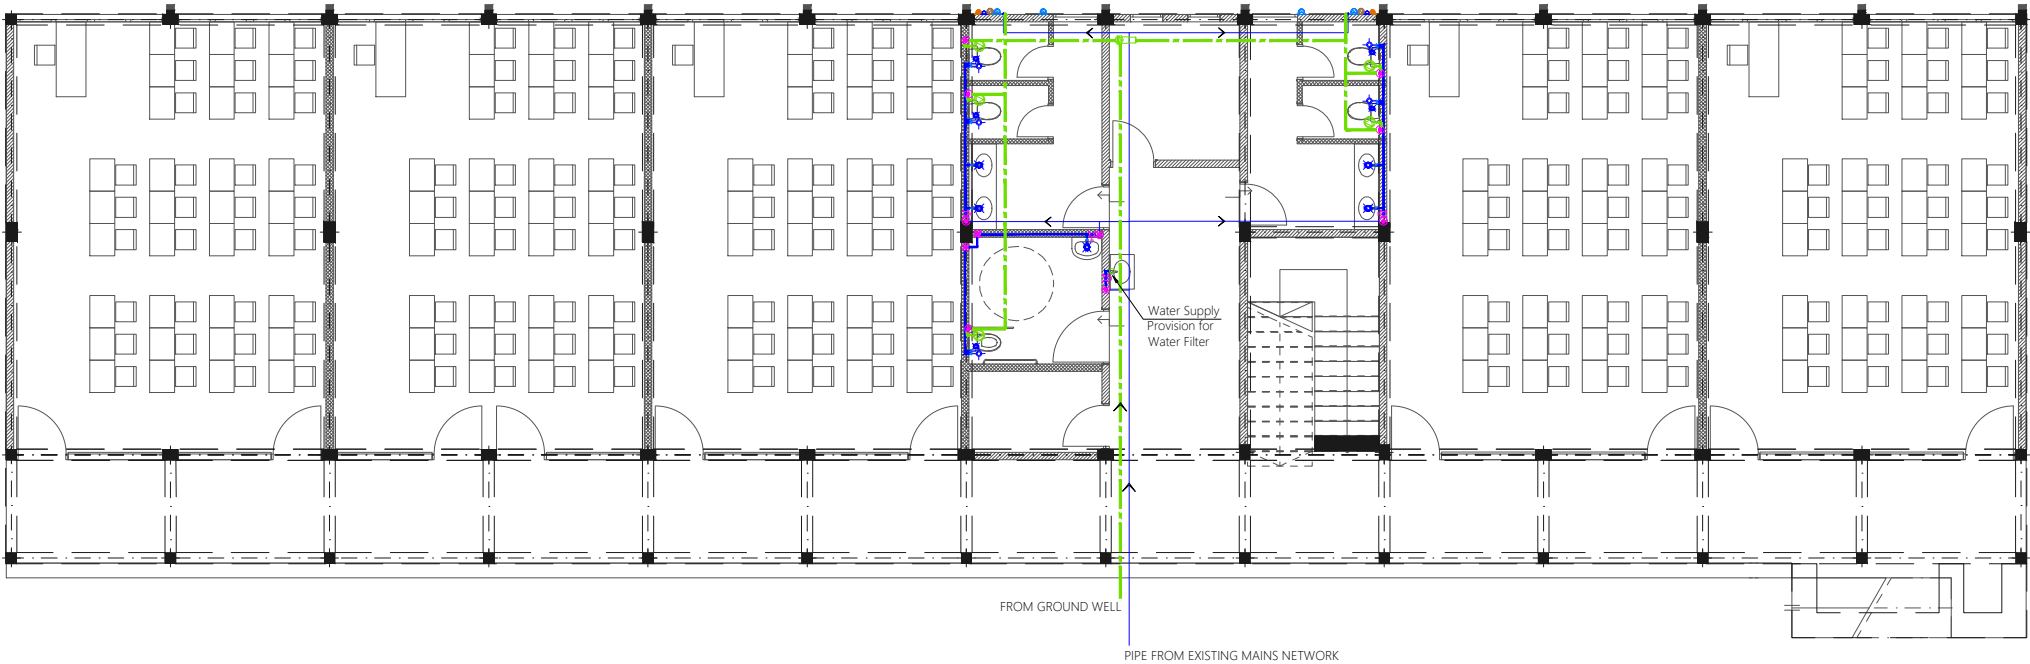

GROUND FLOOR PLUMBING LAYOUT

1:150

PROPOSED 03 STOREY BUILDING
Sh. Funadhoo
15 Classroom Block

Client:
Ministry Of Education

April 2021
Services By: **Mohamed Rassam**
Checked By:
Drawn By: **Mohamed Zaidhan**

EPOCH
T: +960 333 3528, E: info@epoch.associates
W: www.epoch.associates, A: G. Rosary West,
Husnuheena Magu, Male' Republic of Maldives


Rev:	Page:
---	PL -01
---	---
---	---

Legend

- 16Ø Cold Water Supply To Basin Faucet
- 16Ø Cold Water Supply To Bidet Shower
- 16Ø Cold Water Supply To Cistern
- Gate Valve
- Rise In Wall
- Drop In Wall
- Angle Valve with cap for Ground Water Supply
- 25Ø Cold Water Supply Pipes Running Underground
- 20Ø Cold Water Supply Pipes Running In Wall
- 20Ø Cold Water Supply Pipes Running Above False Ceiling
- 20Ø Cold Water Supply Pipes Running Underground
- 25Ø Ground Water Supply Pipes

Notes: -

- All Cold Water Pipes Should Be PVC
- All Hot Water Pipes Should Be PPR

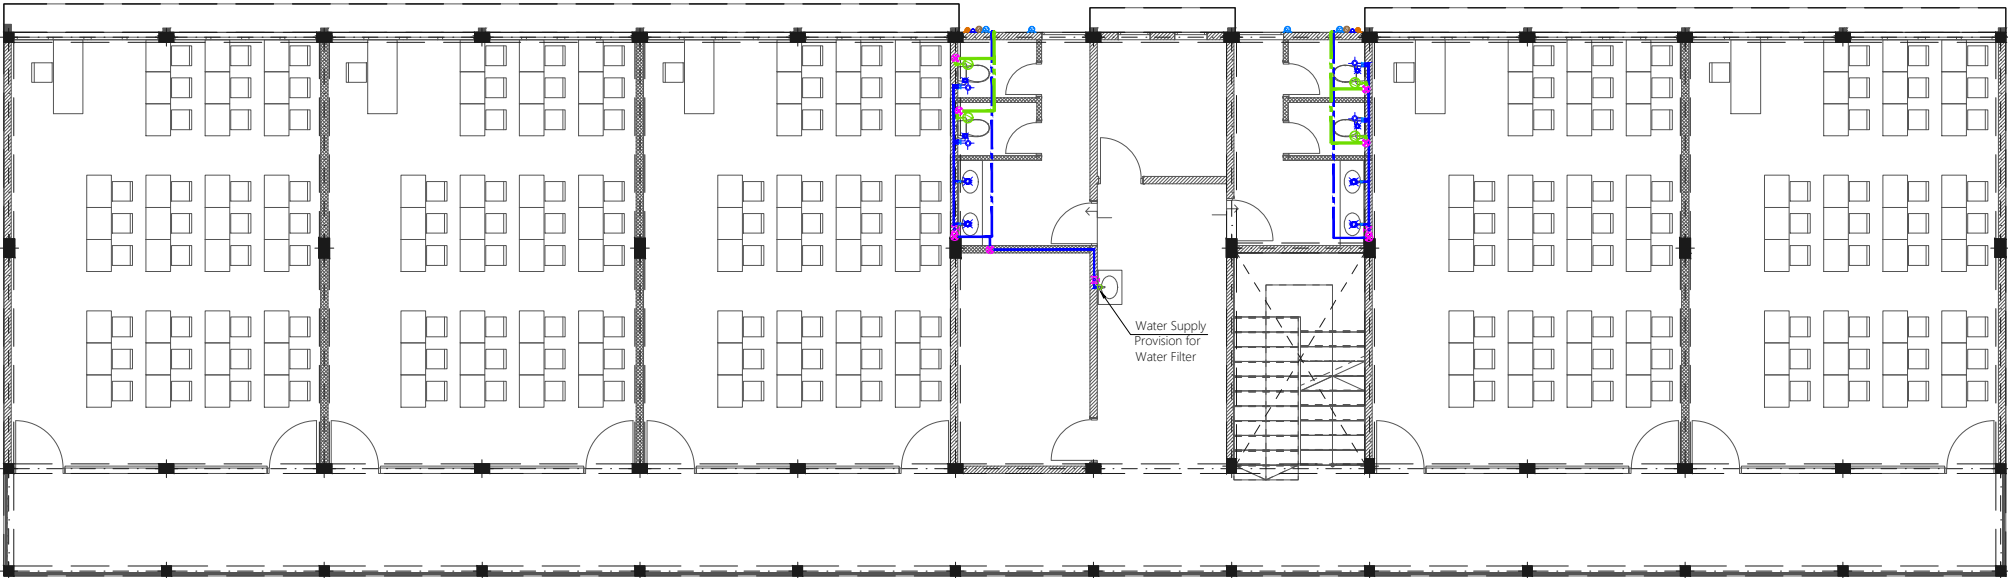

FIRST FLOOR PLUMBING LAYOUT
1:150

PROPOSED 03 STOREY BUILDING
Sh. Funadhoo
15 Classroom Block

Client:
Ministry Of Education

April 2021

Services By: Mohamed Rassam
Checked By:
Drawn By: Mohamed Zaidhan

EPOCH

T: +960 333 3528 , E: info@epoch.associates
W: www.epoch.associates, A: G. Rosary West,
Husnuheena Magu, Male' Republic of Maldives


Rev:	Page:
---	PL -02

Legend

- 16Ø Cold Water Supply To Basin Faucet
- 16Ø Cold Water Supply To Bidet Shower
- 16Ø Cold Water Supply To Cistern
- Gate Valve
- Rise In Wall
- Drop In Wall
- Angle Valve with cap for Ground Water Supply
- 25Ø Cold Water Supply Pipes Running Underground
- 20Ø Cold Water Supply Pipes Running In Wall
- 20Ø Cold Water Supply Pipes Running Above False Ceiling
- 20Ø Cold Water Supply Pipes Running Underground
- 25Ø Ground Water Supply Pipes

Notes: -

- All Cold Water Pipes Should Be PVC
- All Hot Water Pipes Should Be PPR

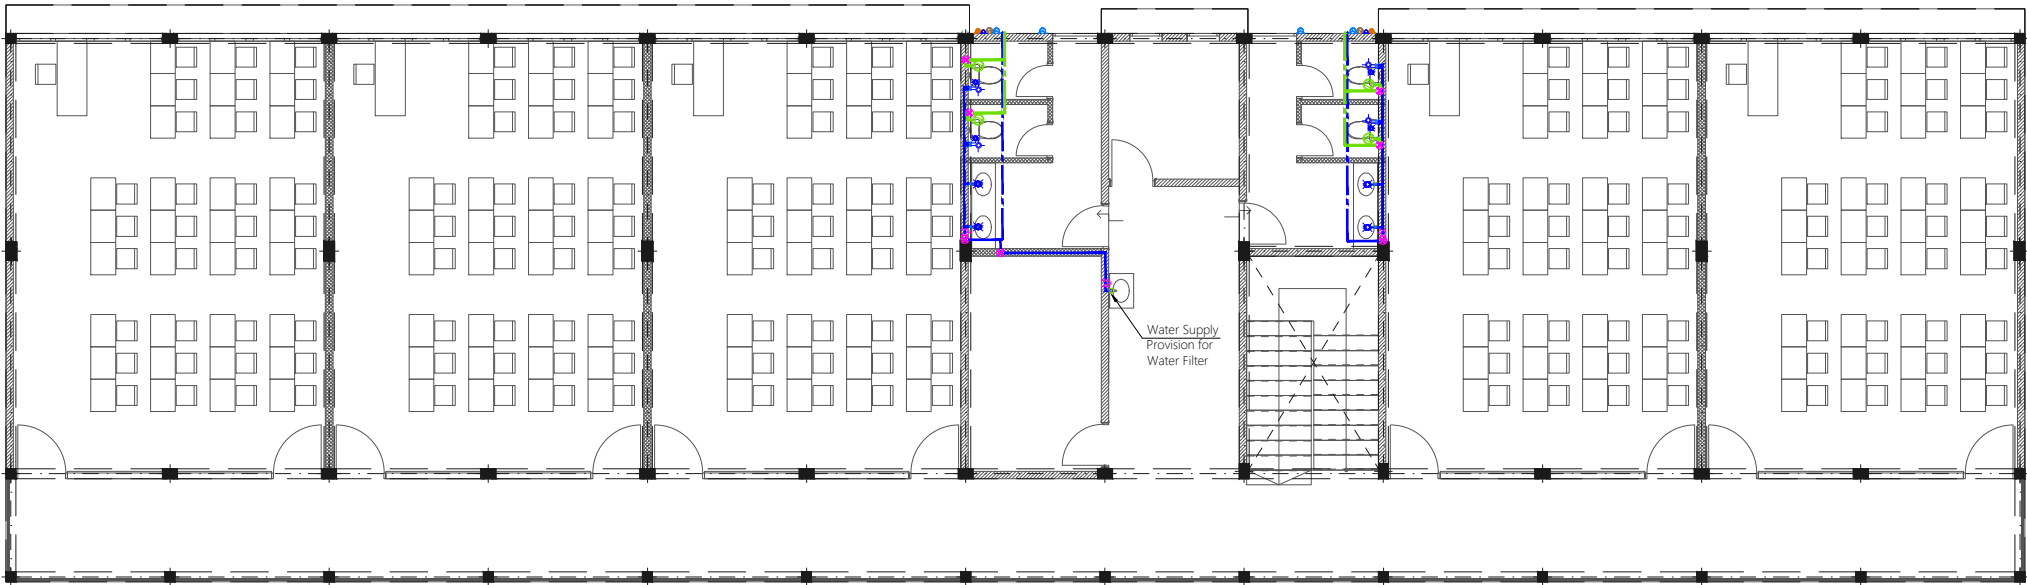

SECOND FLOOR PLUMBING LAYOUT

1:150

PROPOSED 03 STOREY BUILDING
Sh. Funadhoo
15 Classroom Block














Client:
Ministry Of Education

April 2021
Services By: **Mohamed Rassam**
Checked By:
Drawn By: **Mohamed Zaidhan**

EPOCH
T: +960 333 3528, E: info@epoch.associates
W: www.epoch.associates, A: G. Rosary West,
Husnuheena Magu, Male' Republic of Maldives


Rev:	Page:
---	PL -03

Legend

-  Floor Drain
-  Floor Gully
-  110Ø Soil Pipe (uPVC Pipe)
-  110Ø Soil Vent Pipe (uPVC Pipe)
-  82Ø Waste Pipe (uPVC Pipe)
-  82Ø Waste Vent Pipe (uPVC Pipe)
-  40Ø Waste Pipe (uPVC Pipe)
-  63Ø Manhole Vent Pipe (uPVC Pipe)
-  110Ø Rain Water Pipes (uPVC Pipe)
-  Rodding Eye
-  Bottle Trap
-  Gully Trap
-  Manhole

Notes: -

- All Drainage Pipes Should Have At A Slope Of 1/150
- All Floor Drains Should Have 'P' Traps

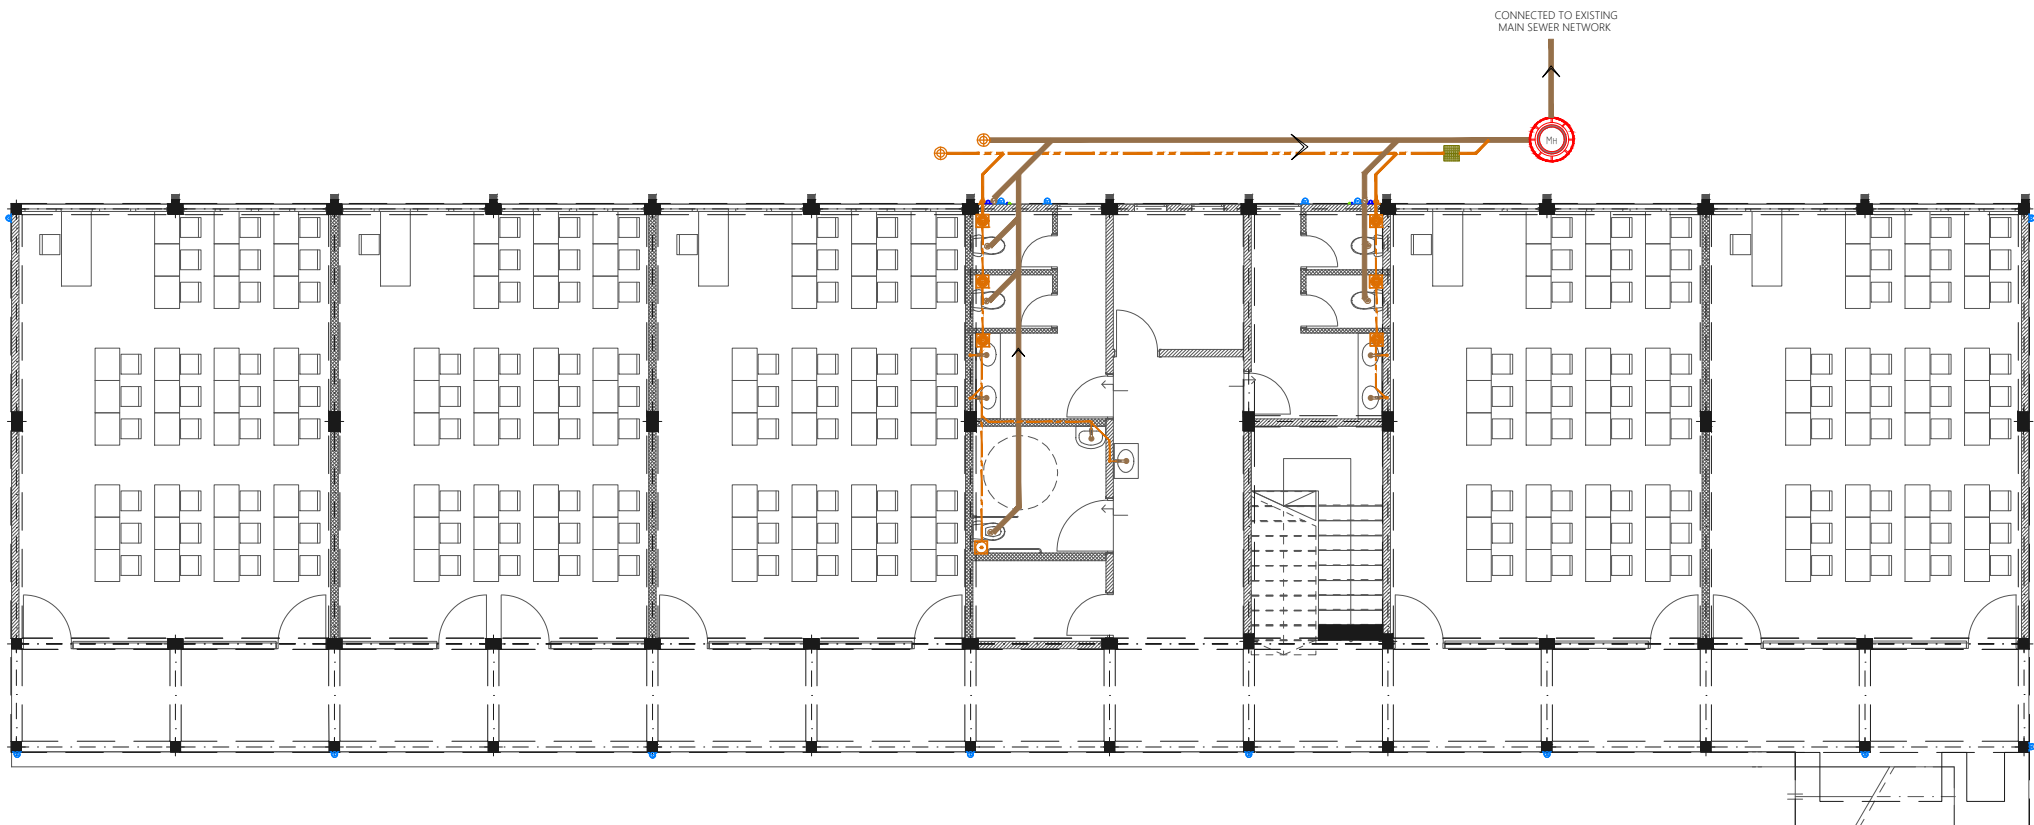

GROUND FLOOR DRAINAGE LAYOUT

1:150

PROPOSED 03 STOREY BUILDING
Sh. Funadhoo
15 Classroom Block

Client:
Ministry Of Education














April 2021

Services By: **Mohamed Rassam**
Checked By:
Drawn By: **Mohamed Zaidhan**


EPOCH
T: +960 333 3528, E: info@epoch.associates
W: www.epoch.associates, A: G. Rosary West,
Husnuheena Magu, Male' Republic of Maldives



Rev:	Page:
---	DR -01

Legend

-  Floor Drain
-  Floor Gully
-  110Ø Soil Pipe (uPVC Pipe)
-  110Ø Soil Vent Pipe (uPVC Pipe)
-  82Ø Waste Pipe (uPVC Pipe)
-  82Ø Waste Vent Pipe (uPVC Pipe)
-  40Ø Waste Pipe (uPVC Pipe)
-  63Ø Manhole Vent Pipe (uPVC Pipe)
-  110Ø Rain Water Pipes (uPVC Pipe)
-  Rodding Eye
-  Bottle Trap
-  Gully Trap
-  Manhole

Notes: -

- All Drainage Pipes Should Have At A Slope Of 1/150
- All Floor Drains Should Have 'P' Traps

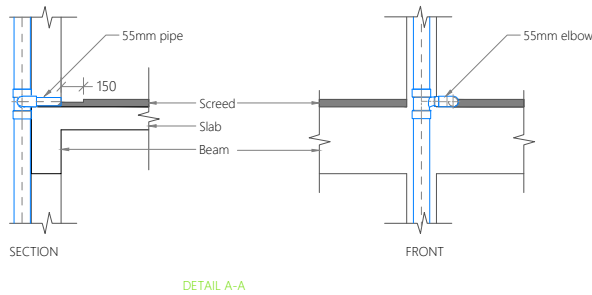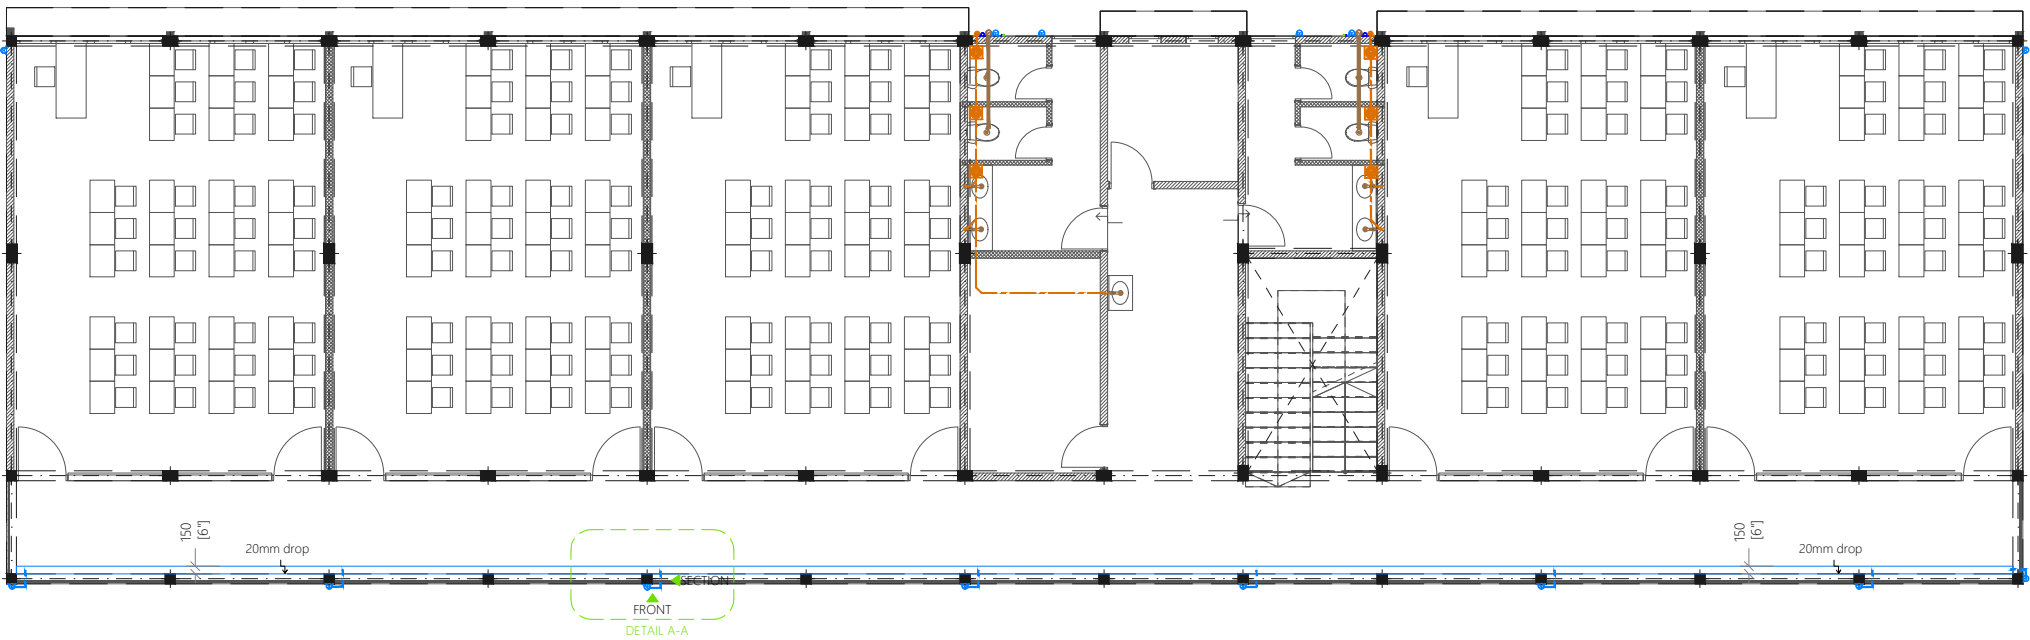

PROPOSED 03 STOREY BUILDING
Sh. Funadhoo
15 Classroom Block

Client:
Ministry Of Education














April 2021

Services By: **Mohamed Rassam**
Checked By:
Drawn By: **Mohamed Zaidhan**


EPOCH
T: +960 333 3528, E: info@epoch.associates
W: www.epoch.associates, A: G. Rosary West,
Husnuheena Magu, Male' Republic of Maldives



Rev:	Page:
---	DR -02

Legend

-  Floor Drain
-  Floor Gully
-  110Ø Soil Pipe (uPVC Pipe)
-  110Ø Soil Vent Pipe (uPVC Pipe)
-  82Ø Waste Pipe (uPVC Pipe)
-  82Ø Waste Vent Pipe (uPVC Pipe)
-  40Ø Waste Pipe (uPVC Pipe)
-  63Ø Manhole Vent Pipe (uPVC Pipe)
-  110Ø Rain Water Pipes (uPVC Pipe)
-  Rodding Eye
-  Bottle Trap
-  Gully Trap
-  Manhole

Notes: -

- All Drainage Pipes Should Have At A Slope Of 1/150
- All Floor Drains Should Have 'P' Traps

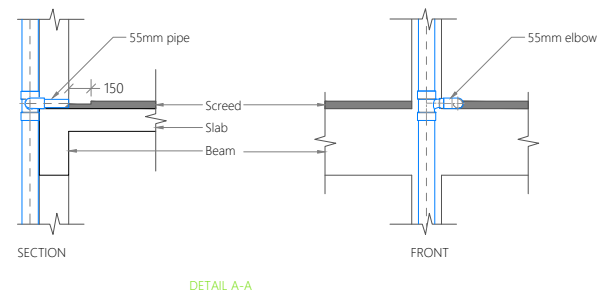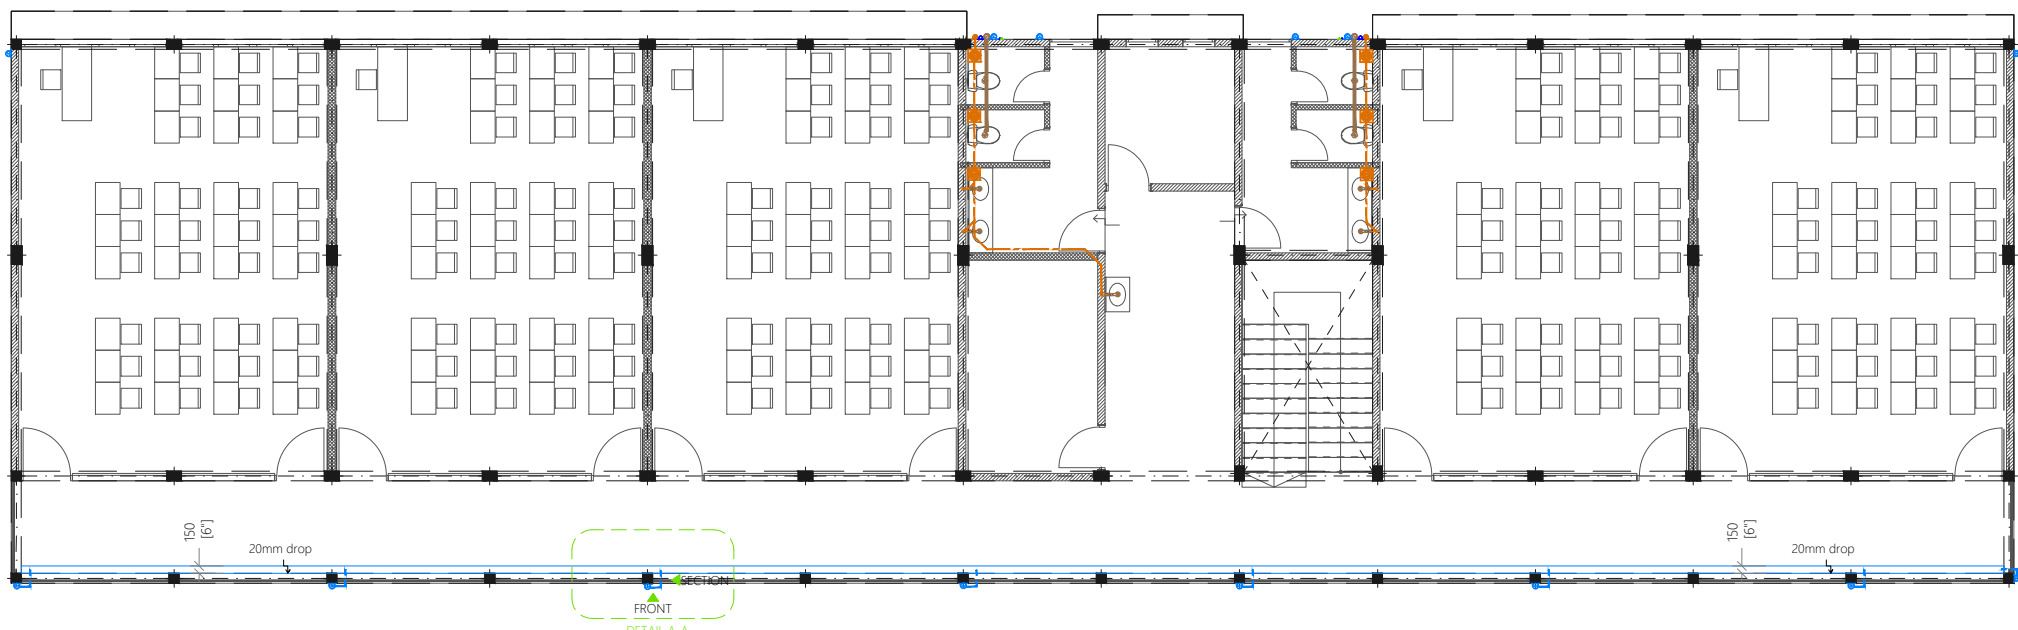

SECOND FLOOR DRAINAGE LAYOUT
1:150

PROPOSED 03 STOREY BUILDING
Sh. Funadhoo
15 Classroom Block














Client:
Ministry Of Education

April 2021
Services By: **Mohamed Rassam**
Checked By:
Drawn By: **Mohamed Zaidhan**


EPOCH
T: +960 333 3528, E: info@epoch.associates
W: www.epoch.associates, A: G. Rosary West,
Husnuheena Magu, Male' Republic of Maldives


Rev:	Page:
---	DR -03

Legend

-  Floor Drain
-  Floor Gully
-  110Ø Soil Pipe (uPVC Pipe)
-  110Ø Soil Vent Pipe (uPVC Pipe)
-  82Ø Waste Pipe (uPVC Pipe)
-  82Ø Waste Vent Pipe (uPVC Pipe)
-  40Ø Waste Pipe (uPVC Pipe)
-  63Ø Manhole Vent Pipe (uPVC Pipe)
-  110Ø Rain Water Pipes (uPVC Pipe)
-  Rodding Eye
-  Bottle Trap
-  Gully Trap
-  Manhole

Notes: -

- All Drainage Pipes Should Have At A Slope Of 1/150
- All Floor Drains Should Have 'P' Traps

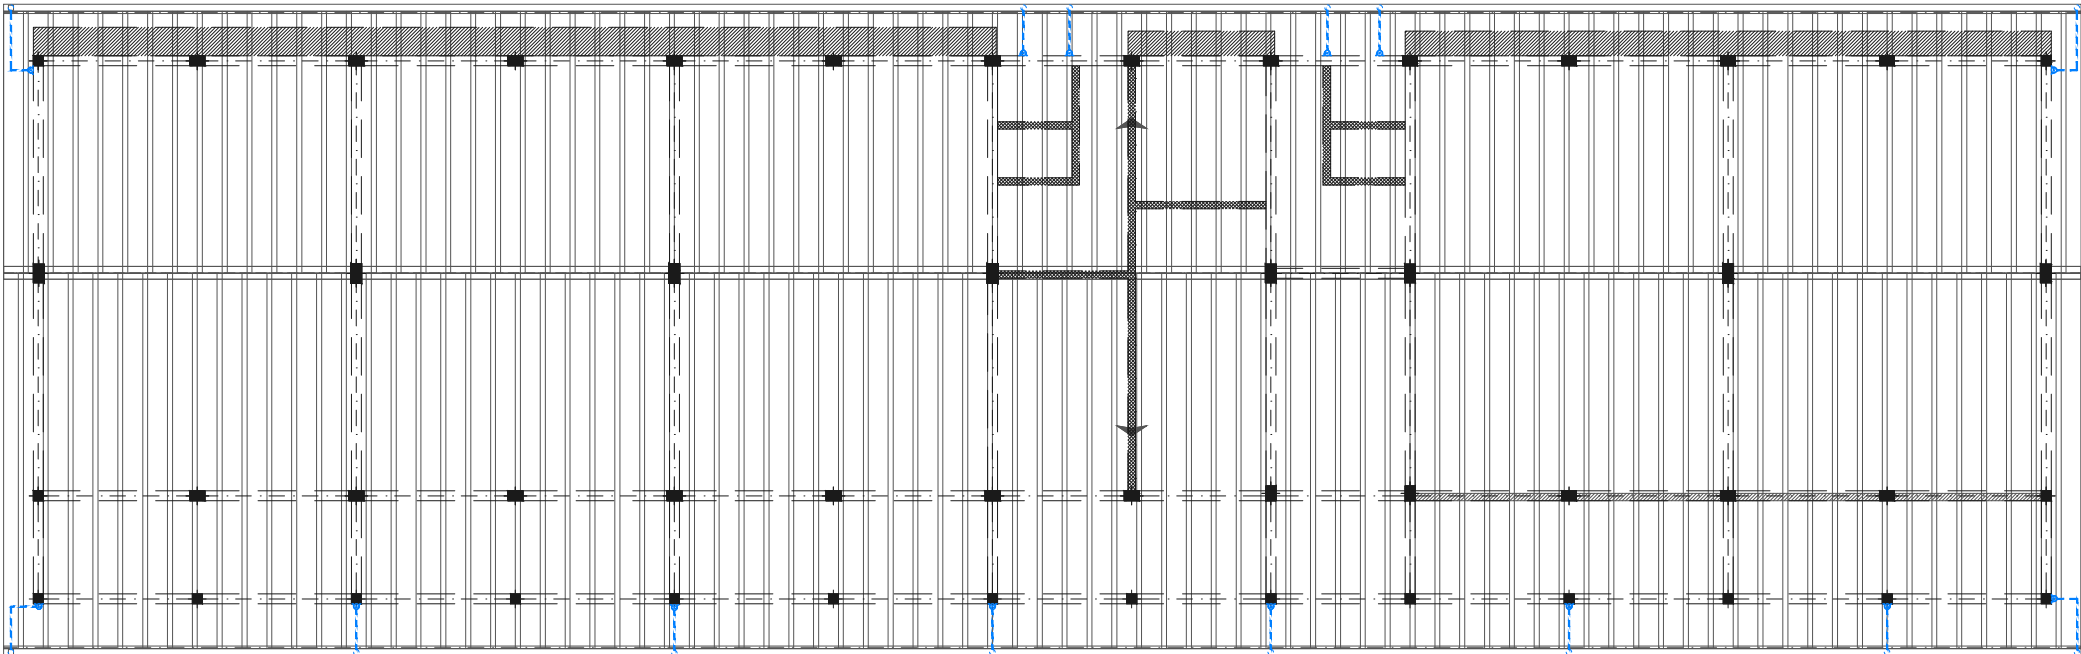

ROOF DRAINAGE LAYOUT

1:150

PROPOSED 03 STOREY BUILDING
Sh. Funadhoo
15 Classroom Block

Client:
Ministry Of Education

April 2021

Services By: **Mohamed Rassam**
Checked By:
Drawn By: **Mohamed Zaidhan**



EPOCH

T: +960 333 3528 **E:** info@epoch.associates
W: www.epoch.associates, **A:** G.Rosary West,
Husnuheenaa Magu, Male' Republic of Maldives

Rev:	Page:
---	DR -04

