




 





| HVAC SYMBOLS KEY | |
|---|--|
| SYMBOL | DESCRIPTION |
|  | 24000 BTU INDOOR UNIT (CENTRAL TYPE) |
|  | 36000 BTU INDOOR UNIT (CENTRAL TYPE) |
|  | 18000 BTU INDOOR UNIT (CENTRAL TYPE) |
|  | COPPER ANEALED HIGH PRESSURE 1.5mm THICK PIPE INLET |
|  | COPPER ANEALED HIGH PRESSURE 1.5mm THICK PIPE OUTLET |
|  | CENTRAL AC OUT DOOR UNITS |
|  | WALL MOUNTED AC INDOOR UNIT (SPLIT TYPE) |
|  | AC OUTDOOR UNIT (SPLIT TYPE) |

Note:
Decentralized Air conditioning systems split ceiling mount indoor units
Brands: Sanyo/Mitsubishi/Daikin
Models: VRV INverter
Refrigerant: R410A/R407C



GROUND FLOOR HVAC LAYOUT
SCALE 1: 100

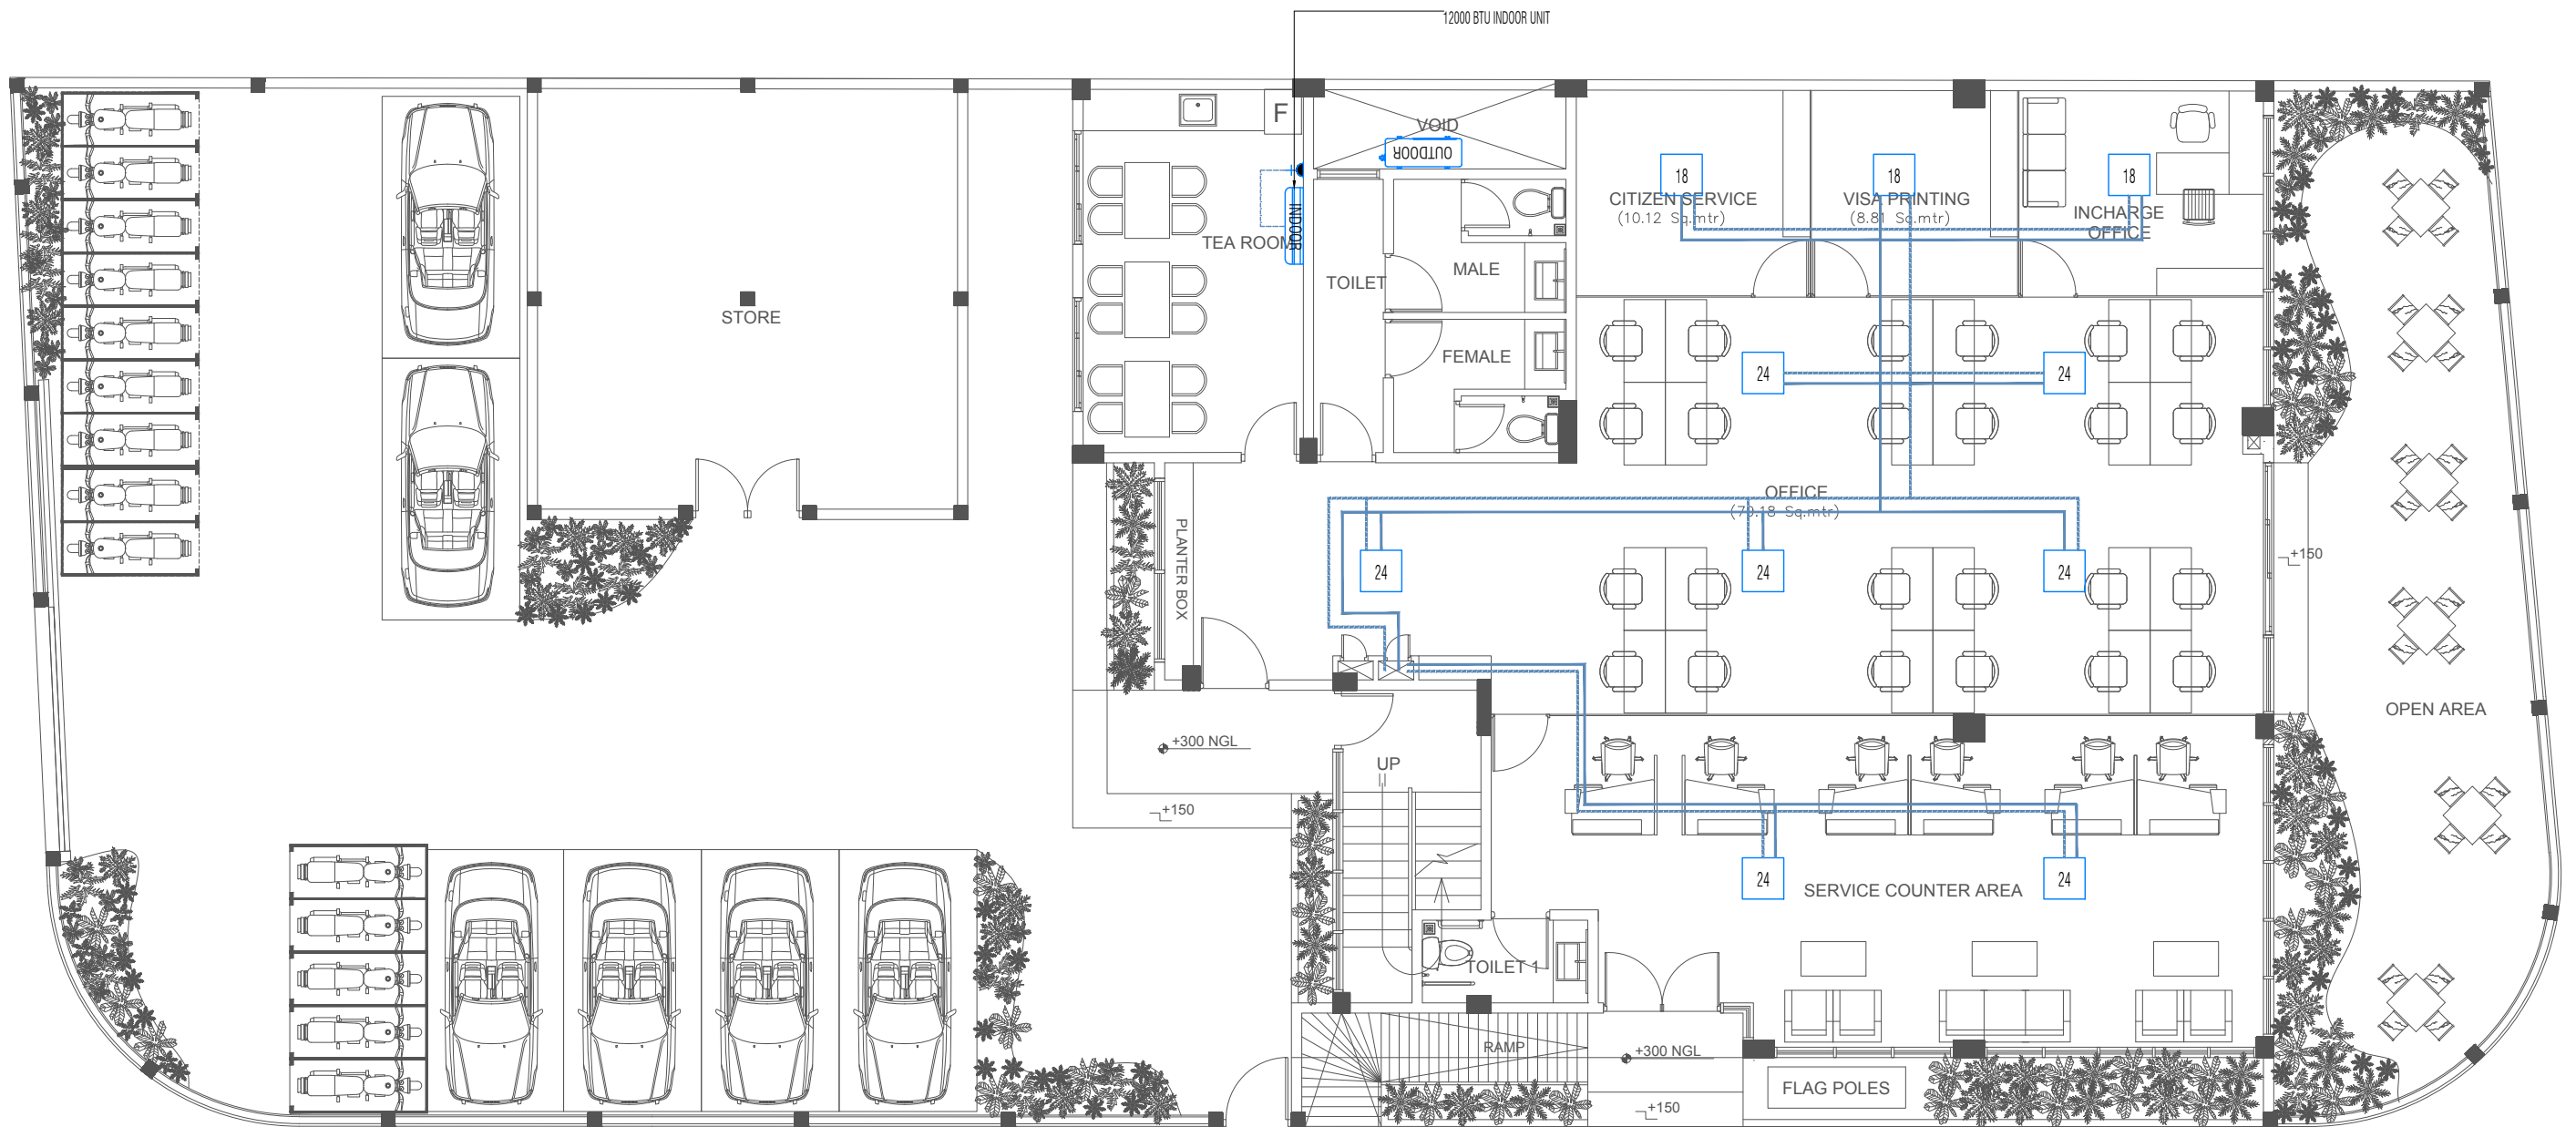PROJECT : IMMIGRATION - S.HITHADHOO

TITLE : AS GIVEN

CLIENT : MALDIVES IMMIGRATION

DRAWN BY:

ALI ZAMYR

ARCHITECT:

ALI ZAMYR

ENGINEER:

AHMED ZUHAL ZAEEM

DATE

AUGUST 2021


SCALE

AS GIVEN

PROJECT No

AM-D/2021/06

IF IN DOUBT - ASK - DO NOT SCALE

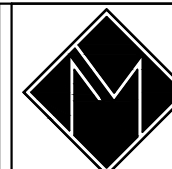


ARCHIMALDIVES
PRIVATE LIMITED


M.MISRU GANDHAKOALHIGE, 5TH FLOOR, SHAARIU VARUDHEE, MALE
TEL: (960) 7947733, (960) 7991269, Email: archimaldives@gmail.com


PAGE NO.

MEP - 01

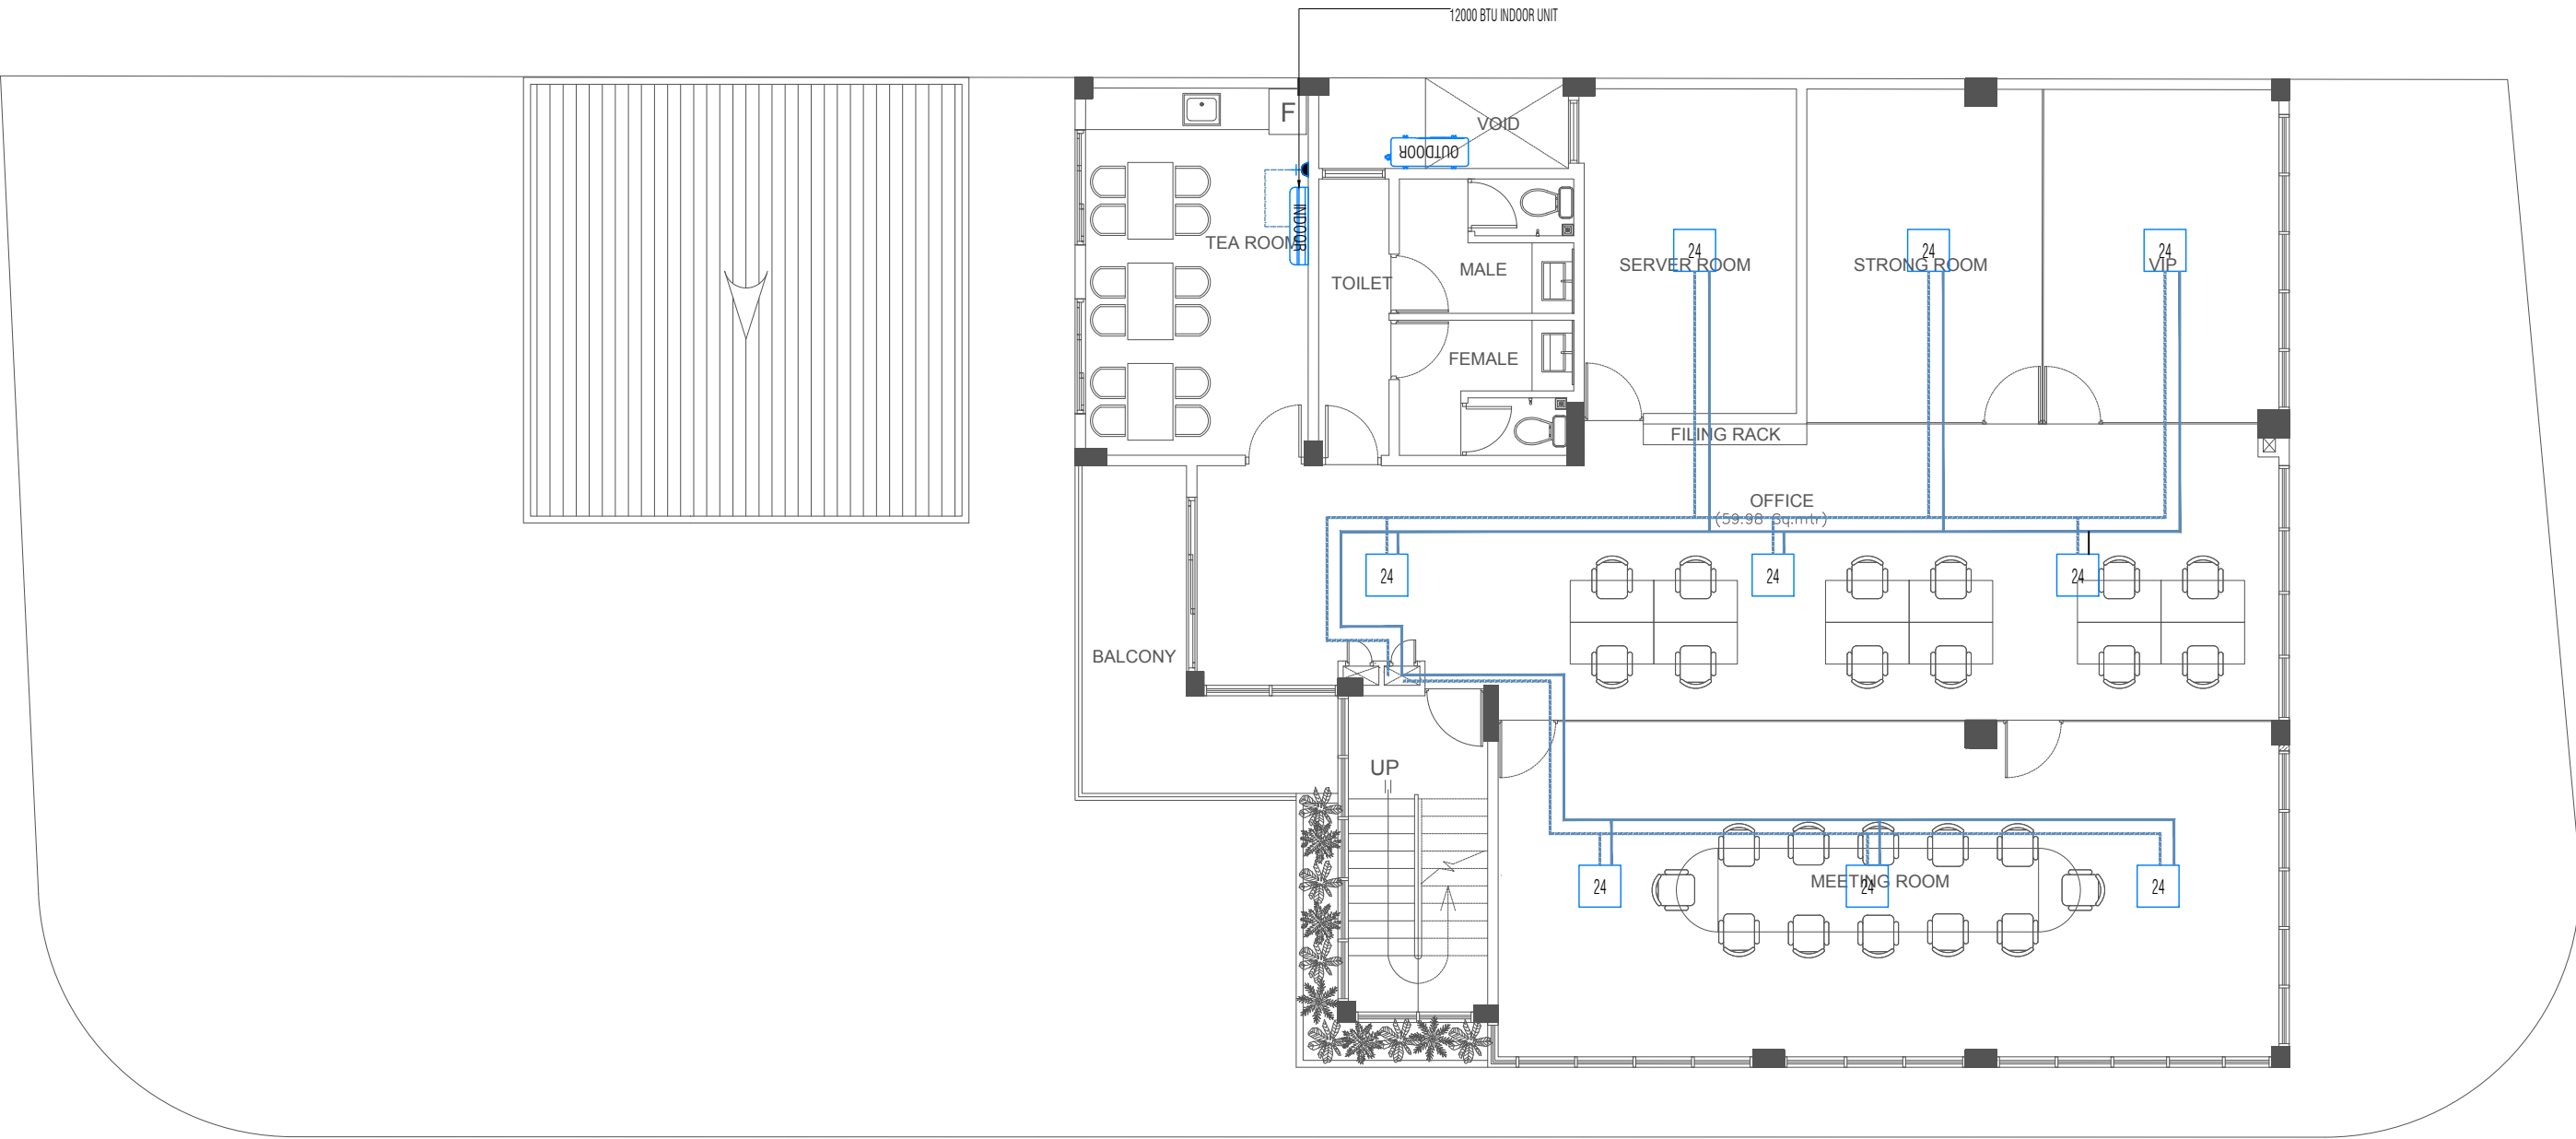


FIRST FLOOR HVAC LAYOUT
SCALE 1: 100

| | | | | | | | |
|--|-------------------------------|----------------------------------|-------------------|------------|--------------|---|----------|
| PROJECT : <u>IMMIGRATION - S.HITHADHOO</u> | TITLE : AS GIVEN | DRAWN BY: | ALI ZAMYR | DATE | AUGUST 2021 | <div><div>ARCHIMALDIVES <small>PRIVATE LIMITED</small> <small>M.MISRU GANDHAKOALHIGE, 5TH FLOOR,SHAARIU VARUDHEE, MALE</small> <small>TEL: (960) 7947733, (960) 7991269, Email: archimaldives@gmail.com</small></div></div> | PAGE NO. |
| | CLIENT : MALDIVES IMMIGRATION | ARCHITECT: | ALI ZAMYR | SCALE | AS GIVEN | | MEP - 02 |
| | | ENGINEER: | AHMED ZUHAL ZAEEM | PROJECT No | AM-D/2021/06 | | |
| | | IF IN DOUBT - ASK - DO NOT SCALE | | | | | |

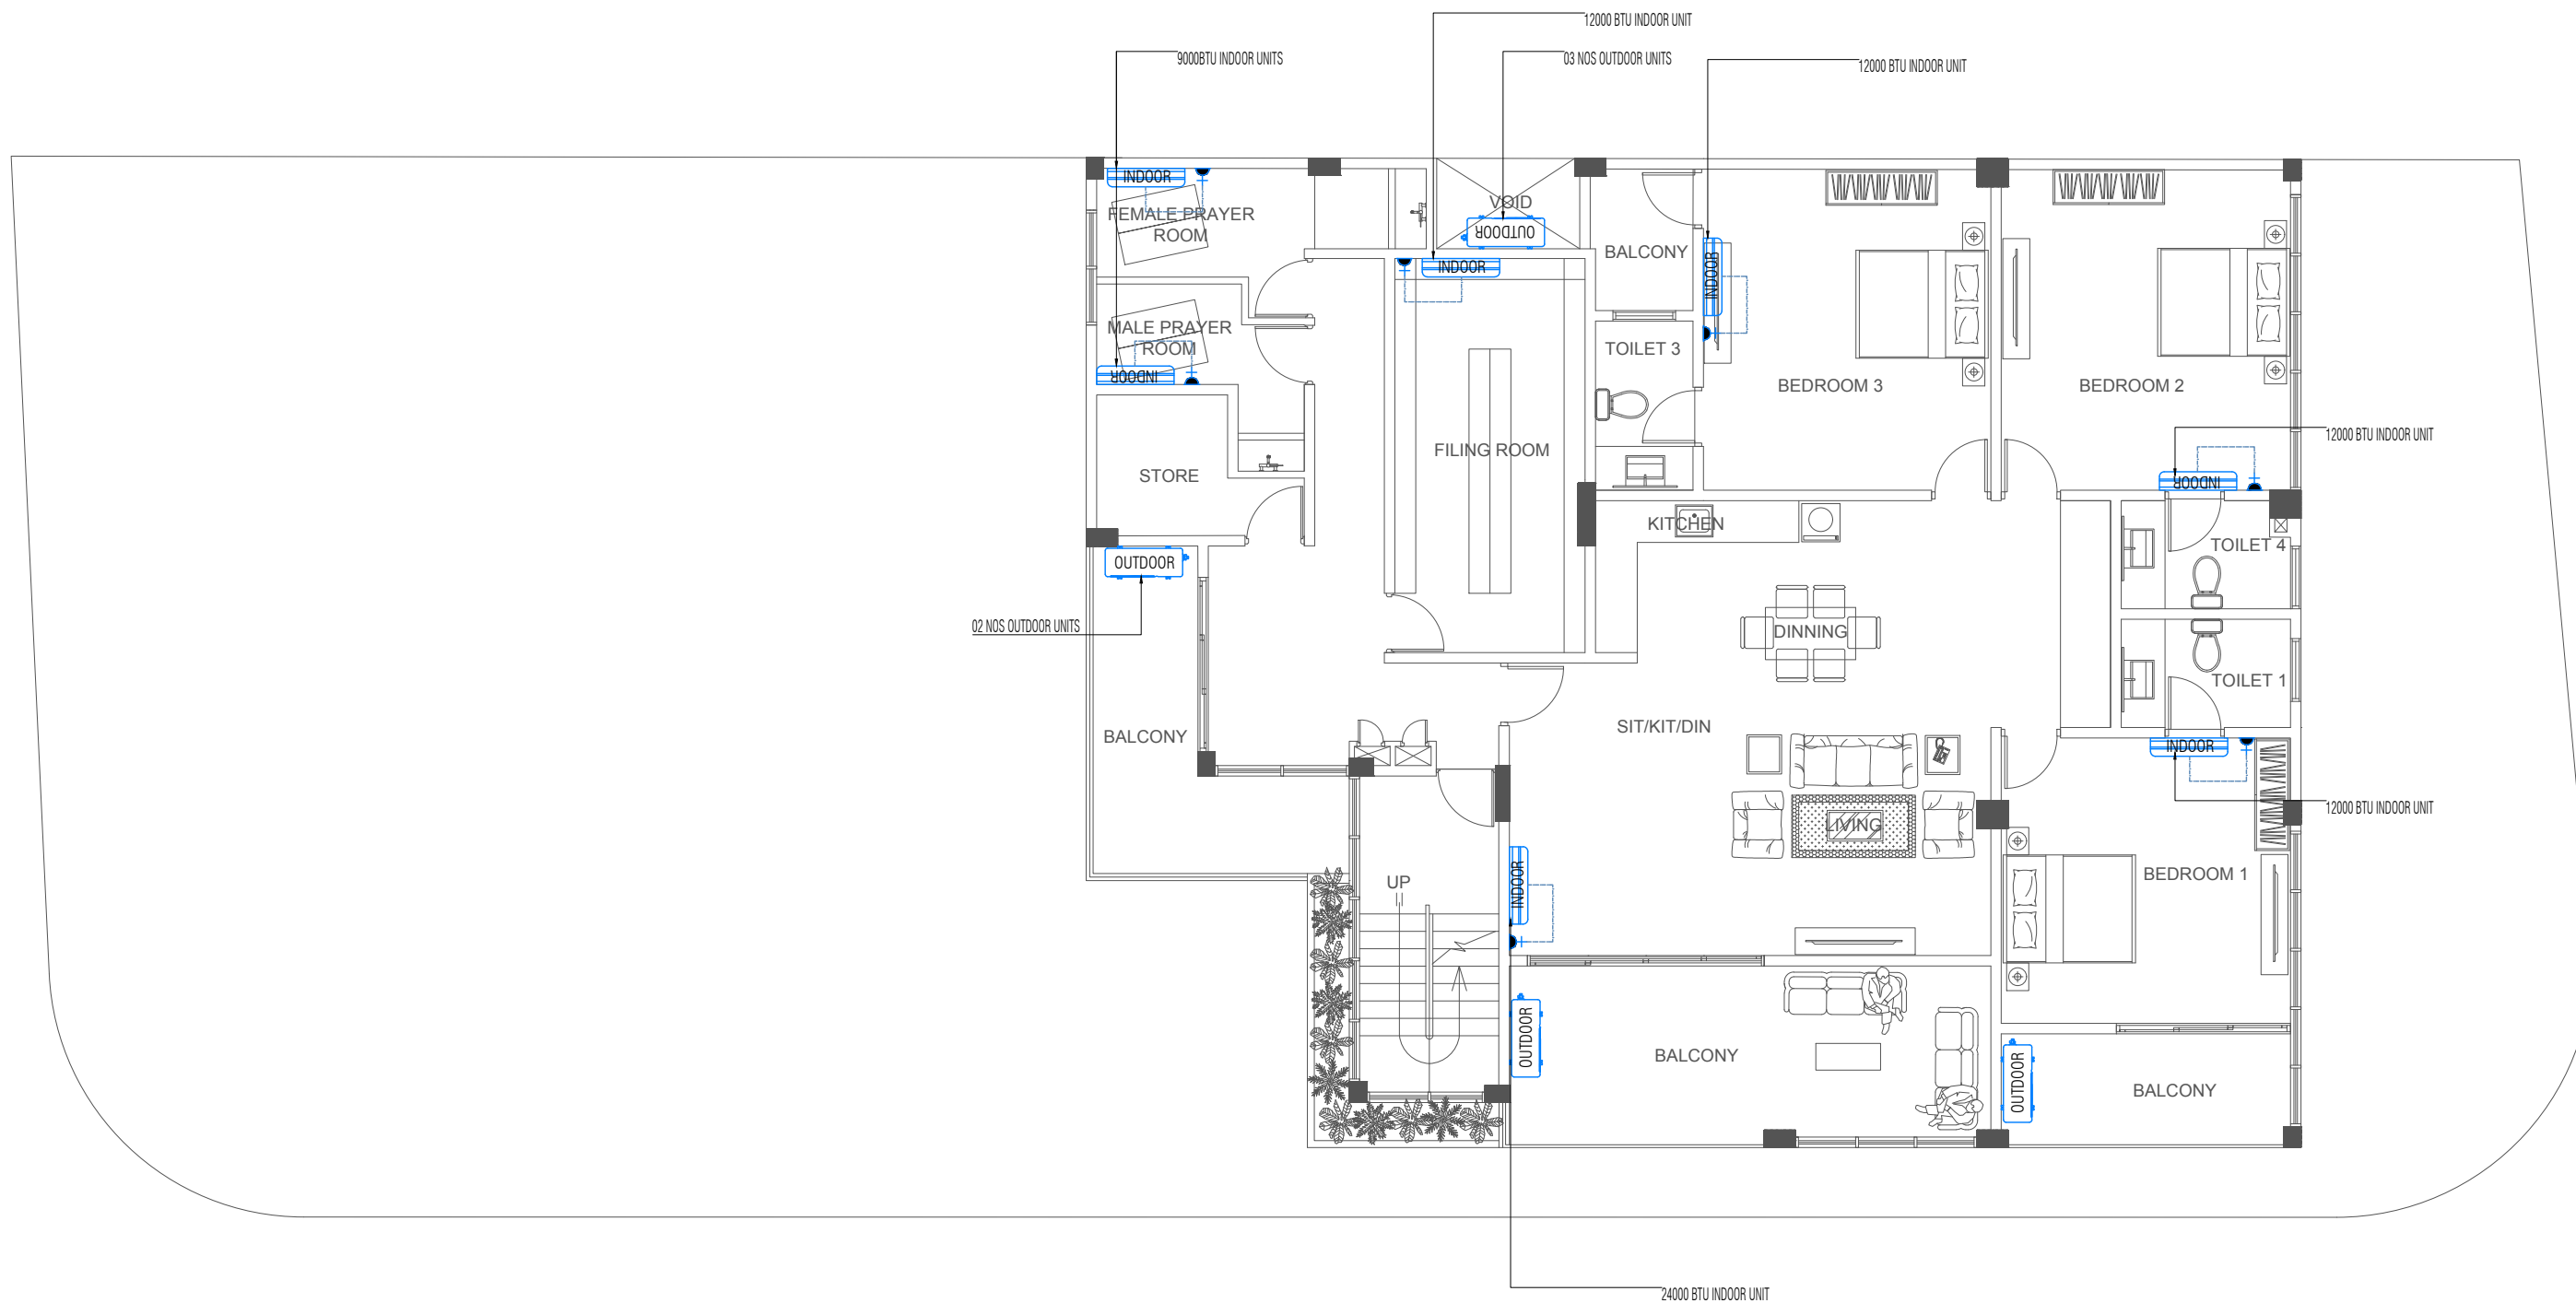

SECOND FLOOR HVAC LAYOUT
SCALE 1: 100

| | | | | | | | |
|--|-------------------------------|----------------------------------|-------------------|------------|--------------|---|----------|
| PROJECT : <u>IMMIGRATION - S.HITHADHOO</u> | TITLE : AS GIVEN | DRAWN BY: | ALI ZAMYR | DATE | AUGUST 2021 | <div><div>ARCHIMALDIVES PRIVATE LIMITED <small>M.MISRU GANDHAKOALHIGE, 5TH FLOOR, SHAARIU VARUDHEE, MALE' TEL: (960) 7947733, (960) 7991269, Email: archimaldives@gmail.com</small></div></div> | PAGE NO. |
| | CLIENT : MALDIVES IMMIGRATION | ARCHITECT: | ALI ZAMYR | SCALE | AS GIVEN | | MEP - 03 |
| | | ENGINEER: | AHMED ZUHAL ZAEEM | PROJECT No | AM-D/2021/06 | | |
| | | IF IN DOUBT - ASK - DO NOT SCALE | | | | | |








 




 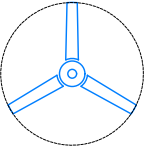


 










IMPORTANT:


- ALL TOILETS ARE PROVIDED WITH SHAVER SOCKET OUTLET
- ALL TOILETS TO BE PROVIDED WITH EXHAUST FAN AND A POWER SOCKET FOR HEATER
- ALL TOILET LIGHTS SHOULD WATER PROOF
- PROVIDE EMERGENCY LIGHTS IN ALL SITTING ROOM AREAS & LIFT / STAIR ENTRANCE
- WALL MOUNT & SLAB MOUNT LIGHTS AT STAIR VOID MUST BE MOTION SENSOR LIGHTS
- ALL BOUNDARY WALL LIGHTS TO BE SWITCHED ON FROM THE SWITCH BOX

NOTE :

MOUNTING HEIGHTS

- | | |
|---|--------|
| - 13AMP SOCKET OUTLETS AT KITCHEN : | 1200mm |
| - 13AMP SOCKET OUTLETS AT TABLES : | 0.00mm |
| - TELEPHONE SOCKET OUTLETS AT TABLES : | 0.00mm |
| - NETWORK SOCKET OUTLETS AT TABLES : | 0.00mm |
| - 15AMP SOCKET OUTLETS AT KITCHEN : | 2400mm |
| - 13AMP SOCKET OUTLETS AT BEDROOM OTHER AREAS : | 450mm |
| - 13AMP SOCKET OUTLETS AT BEDROOM SIDE TABLE : | 700mm |
| - 13AMP SOCKET OUTLETS AT OTHER AREAS : | 450mm |
| - 15AMP SOCKET OUTLETS AT OTHER AREAS: | 2400mm |
| - DOORBELLS / ENTRY PHONE: | 1200mm |
| - SWITCHES / FAN REGULATORS AT OTHER AREAS : | 1200mm |

| ELECTRICAL SYMBOLS KEY | |
|---|---|
| SYMBOL | DESCRIPTION |
|  | CEILING FAN 29" |
|  | 1 X 15 AMP SOCKET OUTLET |
|  | 1 X 13 AMP SOCKET OUTLET |
|  | 1 X 13 AMP SOCKET OUTLET (DOUBLE GANG) |
|  | 1 X 20 AMP SOCKET OUTLET (KITCHEN HOOD) |
|  | 1 X 13 AMP SHAVER SOCKET OUTLET |
|  | TELEPHONE SOCKET OUTLET |
|  | LOCAL AREA NETWORK OUTLET |
|  | CABLE TV OUTLET |
|  | LED- WATER PROOF SPOT LIGHTS LED |
|  | LED-CEILING MOUNT LIGHTS |
|  | D-BOARD |
|  | SWITCH BOX |
|  | GE LUMINATION™ LED RECESSED TROFFER LUMINAIRES |
|  | DOOR OPERATINNG SYSTEM (VIDEO/MONITOR/SPEAKER) |
|  | CCTV CAMERA |
|  | WALL MOUNTED LIGHT |
|  | WALL MOUNTED LIGHT (WATER PROOF) |
|  | EMERGENCY LIGHTS |
|  | LUMINATION™ LED LUMINAIRE - D14S - 4" SQUARE APERTURE SERIES LED DOWNLIGHTS |
|  | ONE WAY LIGHT SWITCH (SINGLE GANG) |
|  | ONE WAY LIGHT SWITCH (DOUBLE GANG) |
|  | ONE WAY LIGHT SWITCH (SINGLE GANG) |
|  | TWO WAY LIGHT SWITCH (DOUBLE GANG) |
|  | FAN REGULATOR / SWITCH |
|  | WIRING CIRCUIT |

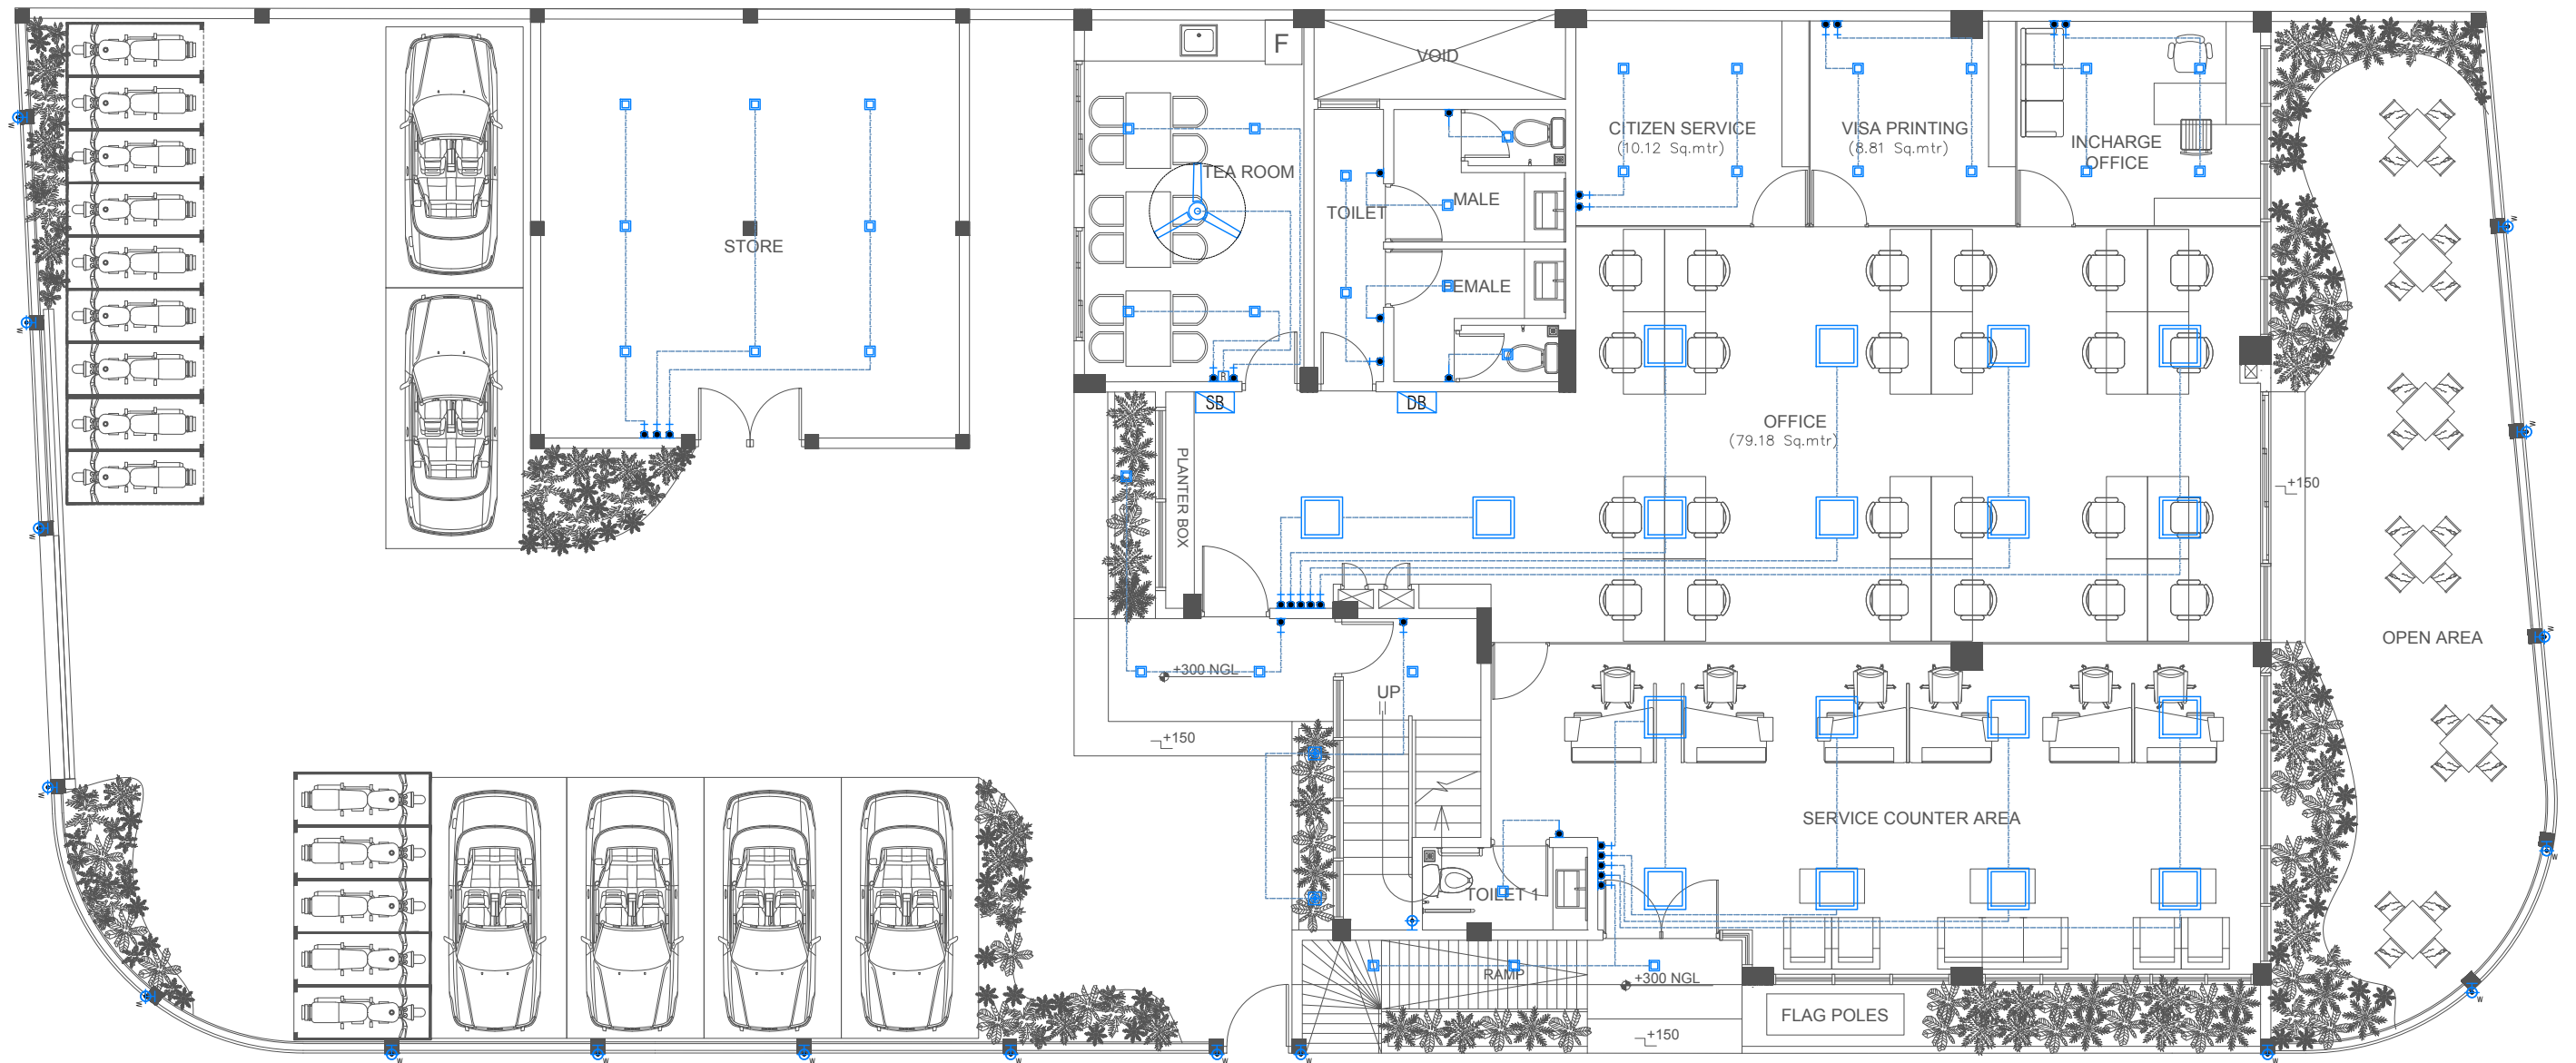

GROUND FLOOR ELECTRICAL LAYOUT
SCALE 1: 100

PROJECT : IMMIGRATION - S.HITHADHOO

TITLE : AS GIVEN

CLIENT : MALDIVES IMMIGRATION

DRAWN BY:

ALI ZAMYR

ARCHITECT:

ALI ZAMYR

ENGINEER:

AHMED ZUHAL ZAEEM

DATE

AUGUST 2021


SCALE

AS GIVEN

PROJECT No

AM-D/2021/06

IF IN DOUBT - ASK - DO NOT SCALE

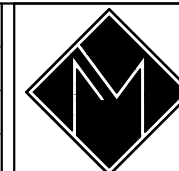


ARCHIMALDIVES
PRIVATE LIMITED


M.MISRU GANDHAKOALHIGE, 5TH FLOOR, SHAARIU VARUDHEE, MALE
TEL: (960) 7947733, (960) 7991269, Email: archimaldives@gmail.com


PAGE NO.

MEP - 05

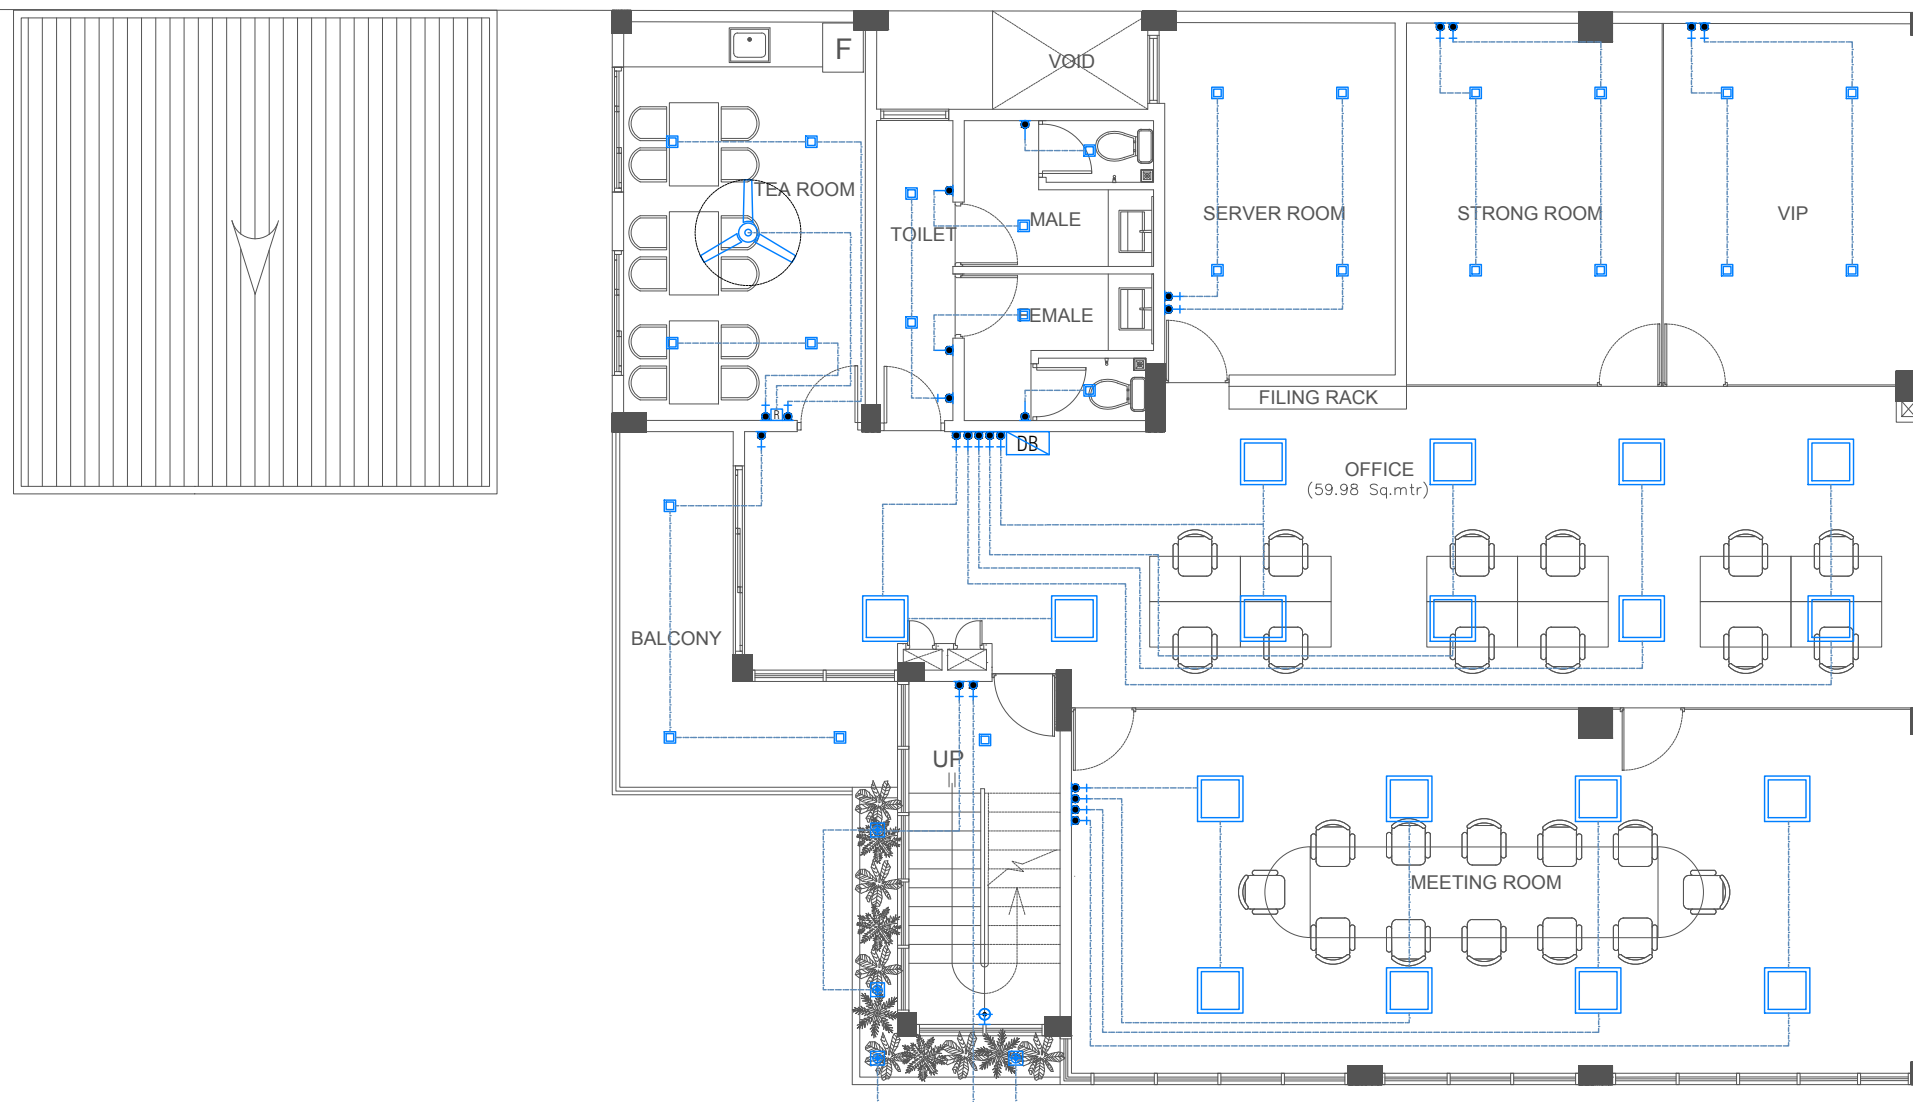


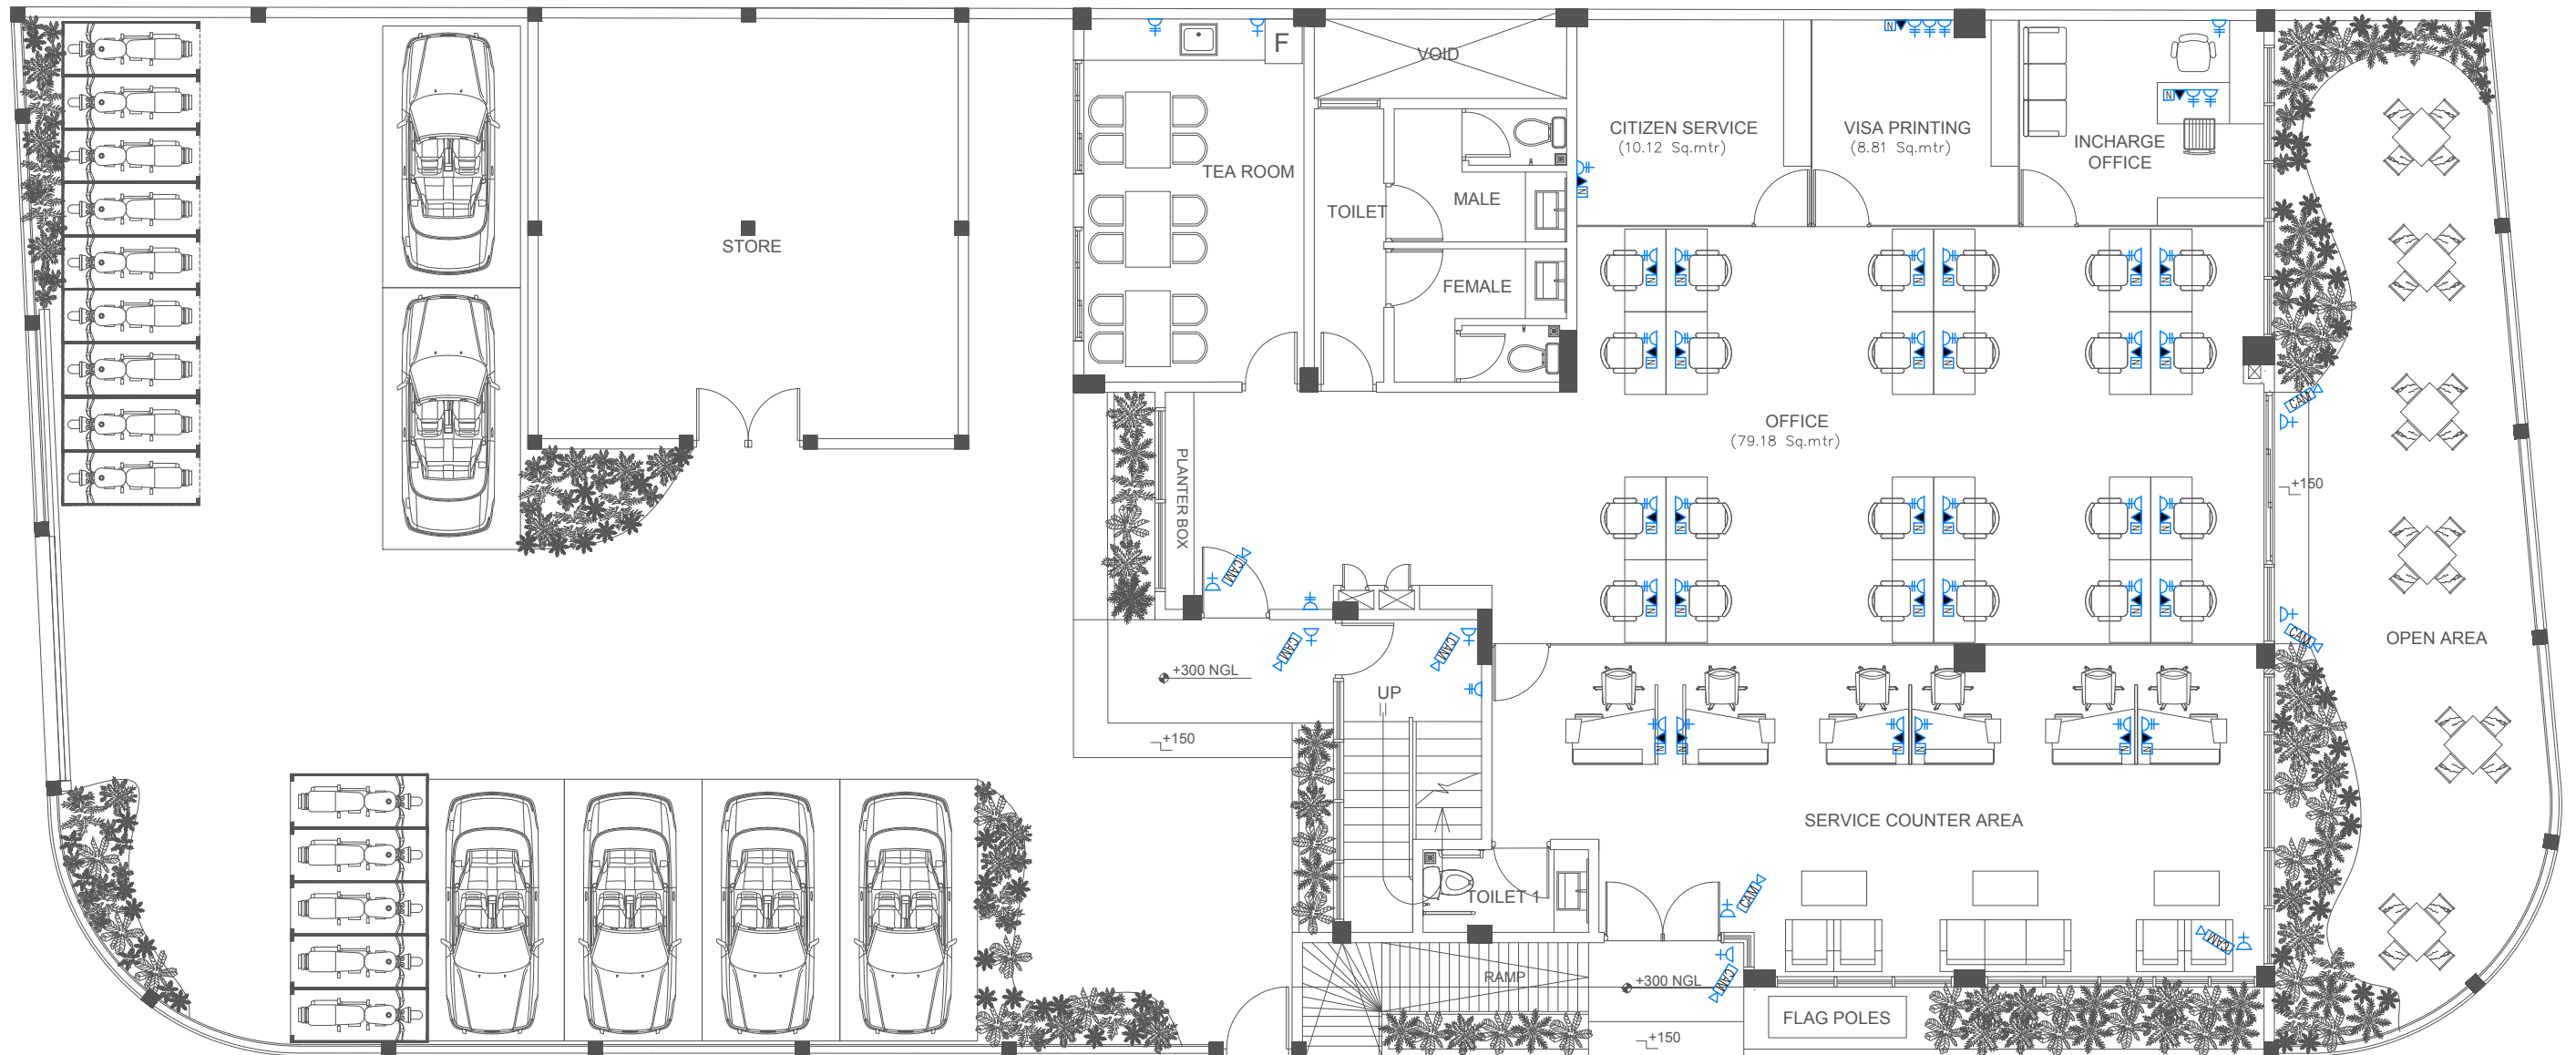
FIRST FLOOR ELECTRICAL LAYOUT
SCALE 1: 100

| | | | | | | | |
|--|-------------------------------|----------------------------------|-------------------|------------|--------------|---|----------|
| PROJECT : <u>IMMIGRATION - S.HITHADHOO</u> | TITLE : AS GIVEN | DRAWN BY: | ALI ZAMYR | DATE | AUGUST 2021 | <div><div>ARCHIMALDIVES PRIVATE LIMITED</div><div>M.MISRU GANDHAKOALHIGE, 5TH FLOOR, SHAARIU VARUDHEE, MALE* TEL: (960) 7947733, (960) 7991269, Email: archimaldives@gmail.com</div></div> | PAGE NO. |
| | CLIENT : MALDIVES IMMIGRATION | ARCHITECT: | ALI ZAMYR | SCALE | AS GIVEN | | MEP - 06 |
| | | ENGINEER: | AHMED ZUHAL ZAEEM | PROJECT No | AM-D/2021/06 | | |
| | | IF IN DOUBT - ASK - DO NOT SCALE | | | | | |

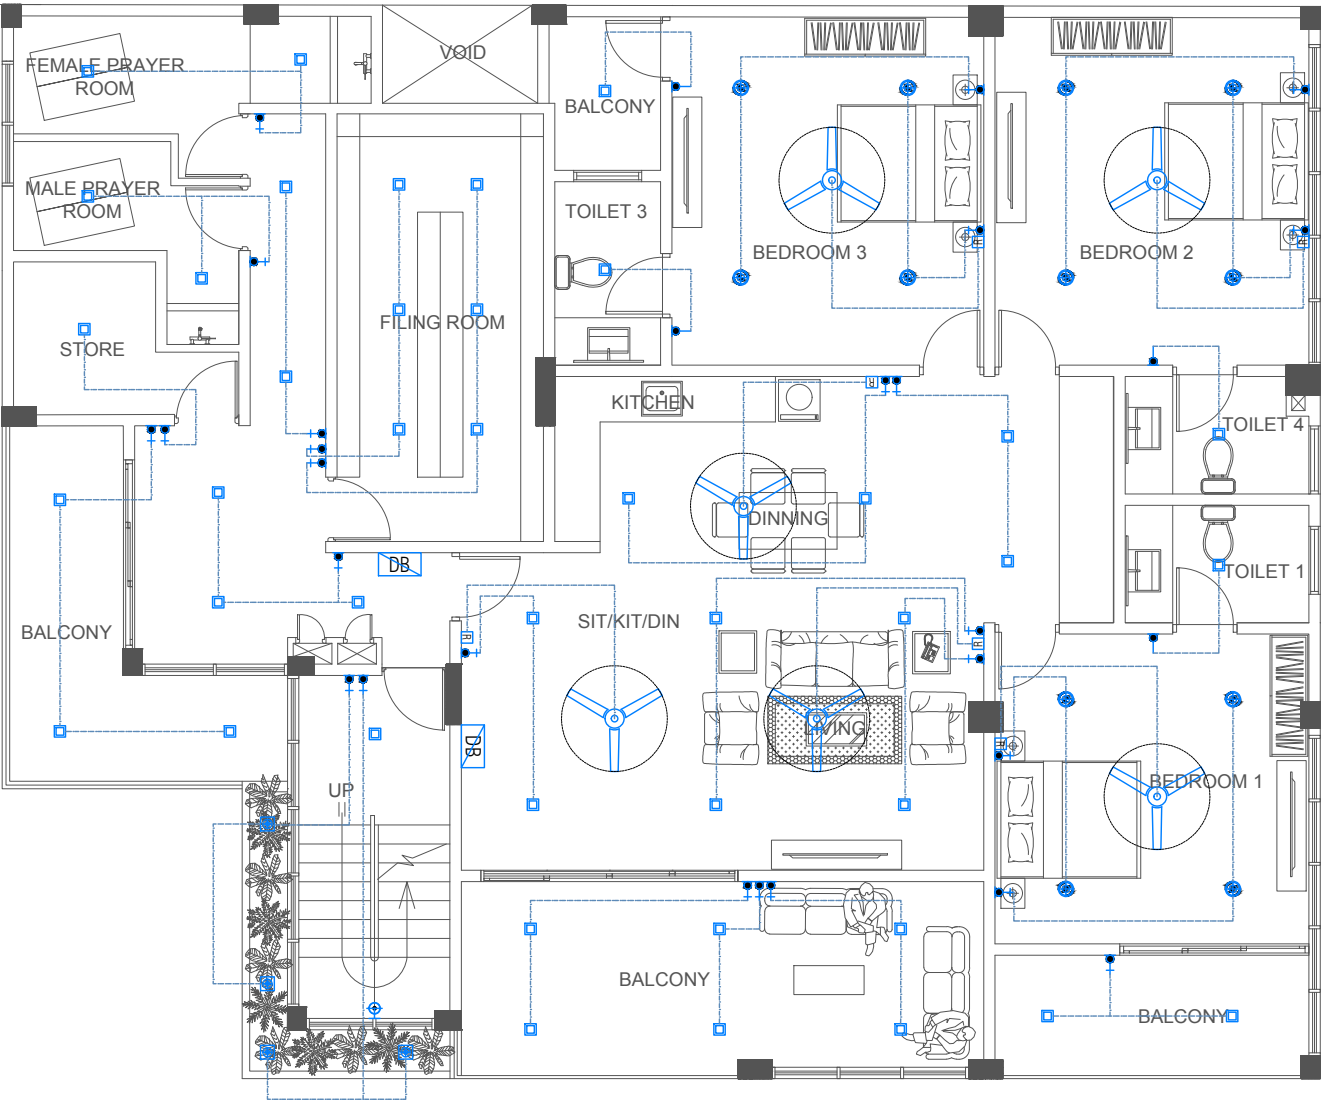

SECOND FLOOR ELECTRICAL LAYOUT
SCALE 1: 100

| | | | | | | | |
|--|-------------------------------|----------------------------------|-------------------|------------|--------------|--|----------|
| PROJECT : <u>IMMIGRATION - S.HITHADHOO</u> | TITLE : AS GIVEN | DRAWN BY: | ALI ZAMYR | DATE | AUGUST 2021 | <div><div>ARCHIMALDIVES PRIVATE LIMITED</div><div>M.MISRU GANDHAKOALHIGE, 5TH FLOOR.SHAARIU VARUDHEE, MALE' TEL: (960) 7947733, (960) 7991269, Email: archimaldives@gmail.com</div></div> | PAGE NO. |
| | CLIENT : MALDIVES IMMIGRATION | ARCHITECT: | ALI ZAMYR | SCALE | AS GIVEN | | MEP - 07 |
| | | ENGINEER: | AHMED ZUHAL ZAEEM | PROJECT No | AM-D/2021/06 | | |
| | | IF IN DOUBT - ASK - DO NOT SCALE | | | | | |



GROUND FLOOR POWER LAYOUT

SCALE 1: 100

PROJECT : IMMIGRATION - S.HITHADHOO

TITLE : AS GIVEN

CLIENT : MALDIVES IMMIGRATION

DRAWN BY:

ALI ZAMYR

ARCHITECT:

ALI ZAMYR

ENGINEER:

AHMED ZUHAL ZAEEM

DATE

AUGUST 2021


SCALE

AS GIVEN

PROJECT No

AM-D/2021/06

IF IN DOUBT - ASK - DO NOT SCALE

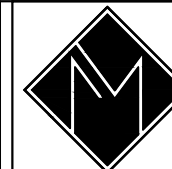








 



 











 
 
 
ARCHIMALDIVES
PRIVATE LIMITED

M.MISRU GANDHAKOALHIGE, 5TH FLOOR, SHAARIU VARUDHEE, MALE
TEL: (960) 7947733, (960) 7991269, Email: archimaldives@gmail.com

PAGE NO.


MEP - 09

FIRE PROTECTION SYMBOLS KEY:


| SYMBOLS | DESCRIPTION | SYMBOLS | DESCRIPTION |
|---|---|---|--|
|  | HEAT DETECTOR (RATE OF RISE) |  | ADDRESSABLE FIRE ALARM CONTROL PANEL |
|  | SMOKE DETECTOR (FIXED AT 80 DEGREES) |  | 1 WAY BREECHING WET RISER OUTLET |
|  | EXTINGUISHER (2KG CO2) |  | 4 WAY BREECHING WET RISER OUTLET |
|  | EXTINGUISHER (9LTR H2O) |  | FIRE BLANKET |
|  | EXTINGUISHER (6LTR WET CHEMICAL) |  | EXIT SIGN |
|  | EXTINGUISHER (2KG DRY CHEMICAL) |  | BALL VALVE |
|  | ELECTRONIC LOOP FIRE ALARM SOUNDER (85dB-100dB) + STROBE |  | BUTTERFLY VALVE |
|  | MANUAL CALL POINT |  | NON-RETURN VALVE |
|  | HOSE REEL WITH VALVE AND CABINET |  | PRESSURE REGULATING VALVE |
|  | FIRE RATED DOORS (MINIMUM 1-2 HOURS) |  | WET RISER PIPE (SCH 40) 100mm DIAMETER) |
|  | FIRE RESISTANCE CABLE (1.5 - 2.5 DIAMETER) |  | HOSE PIPE (SCH 40) 50mm DIAMETER) |
| | |  | FIRE RESISTANCE CABLE (1.5 - 2.5 DIAMETER) |
|  | DUTY FP FIRE PUMP SHALL BE VERTICAL TURBINE TYPE PUMP, ELECTRICAL MOTOR DRIVEN COMPLETE WITH DISCHARGE GAGE AUTOMATIC AIR RELEASE VALLVE, RELIEF VALVE, CAPACITY : 1500L/Min @ 7BAR POWER SUPPLY : 380 V, 3Ø, 50Hz | | |
|  | JOCKEY FP JOCKEY PUMP SHALL BE VERTICAL FOR SUBMERSIBLE TYPE PUMP, ELECTRIC MOTOR DRIVEN CAPACITY : 30L/Min @ 7BAR POWER SUPPLY : 4HP. 230 V, 50Hz | | |
|  | STAND BY FP JOCKEY PUMP SHALL BE VERTICAL TURBINE TYPE PUMP, DIESEL MOTOR DRIVEN COMPLETE WITH DISCHARGE GAGE AUTOMATIC AIR RELEASE VALVE, RELIEF VALVE, FLOW METER, AND AUTOMATIC CONTROLLER, CAPACITY : 1500L/Min @ 7BAR POWER SUPPLY : 380 V, 3Ø, 50Hz | | |


GENERAL NOTES

- ALL MATERIALS AND WORKMANSHIP SHALL BE ACCORDING TO MNDF REGULATIONS.
- USE FIRE RESISTANT CABLE ALARM SYSTEM.
- USE 4" DIAMETER SCHEDULE 40 PIPE FOR WET RISER SYSTEM (GALVANIZES ON BOTH SIDES).
- LENGTH OF HOSE REEL - 30m
- STANDBY PUMP SHALL BE OPERATED BY DIESEL OR PETROL.
- EXIT SIGNS MUST BE CLEAR, VISIBLE AND HAVE ELECTRICAL CONNECTIONS+EMERGENCY BATTERIES.
- ALL EXTINGUISHERS MUST BE IN ENCLOSED CABINETS.

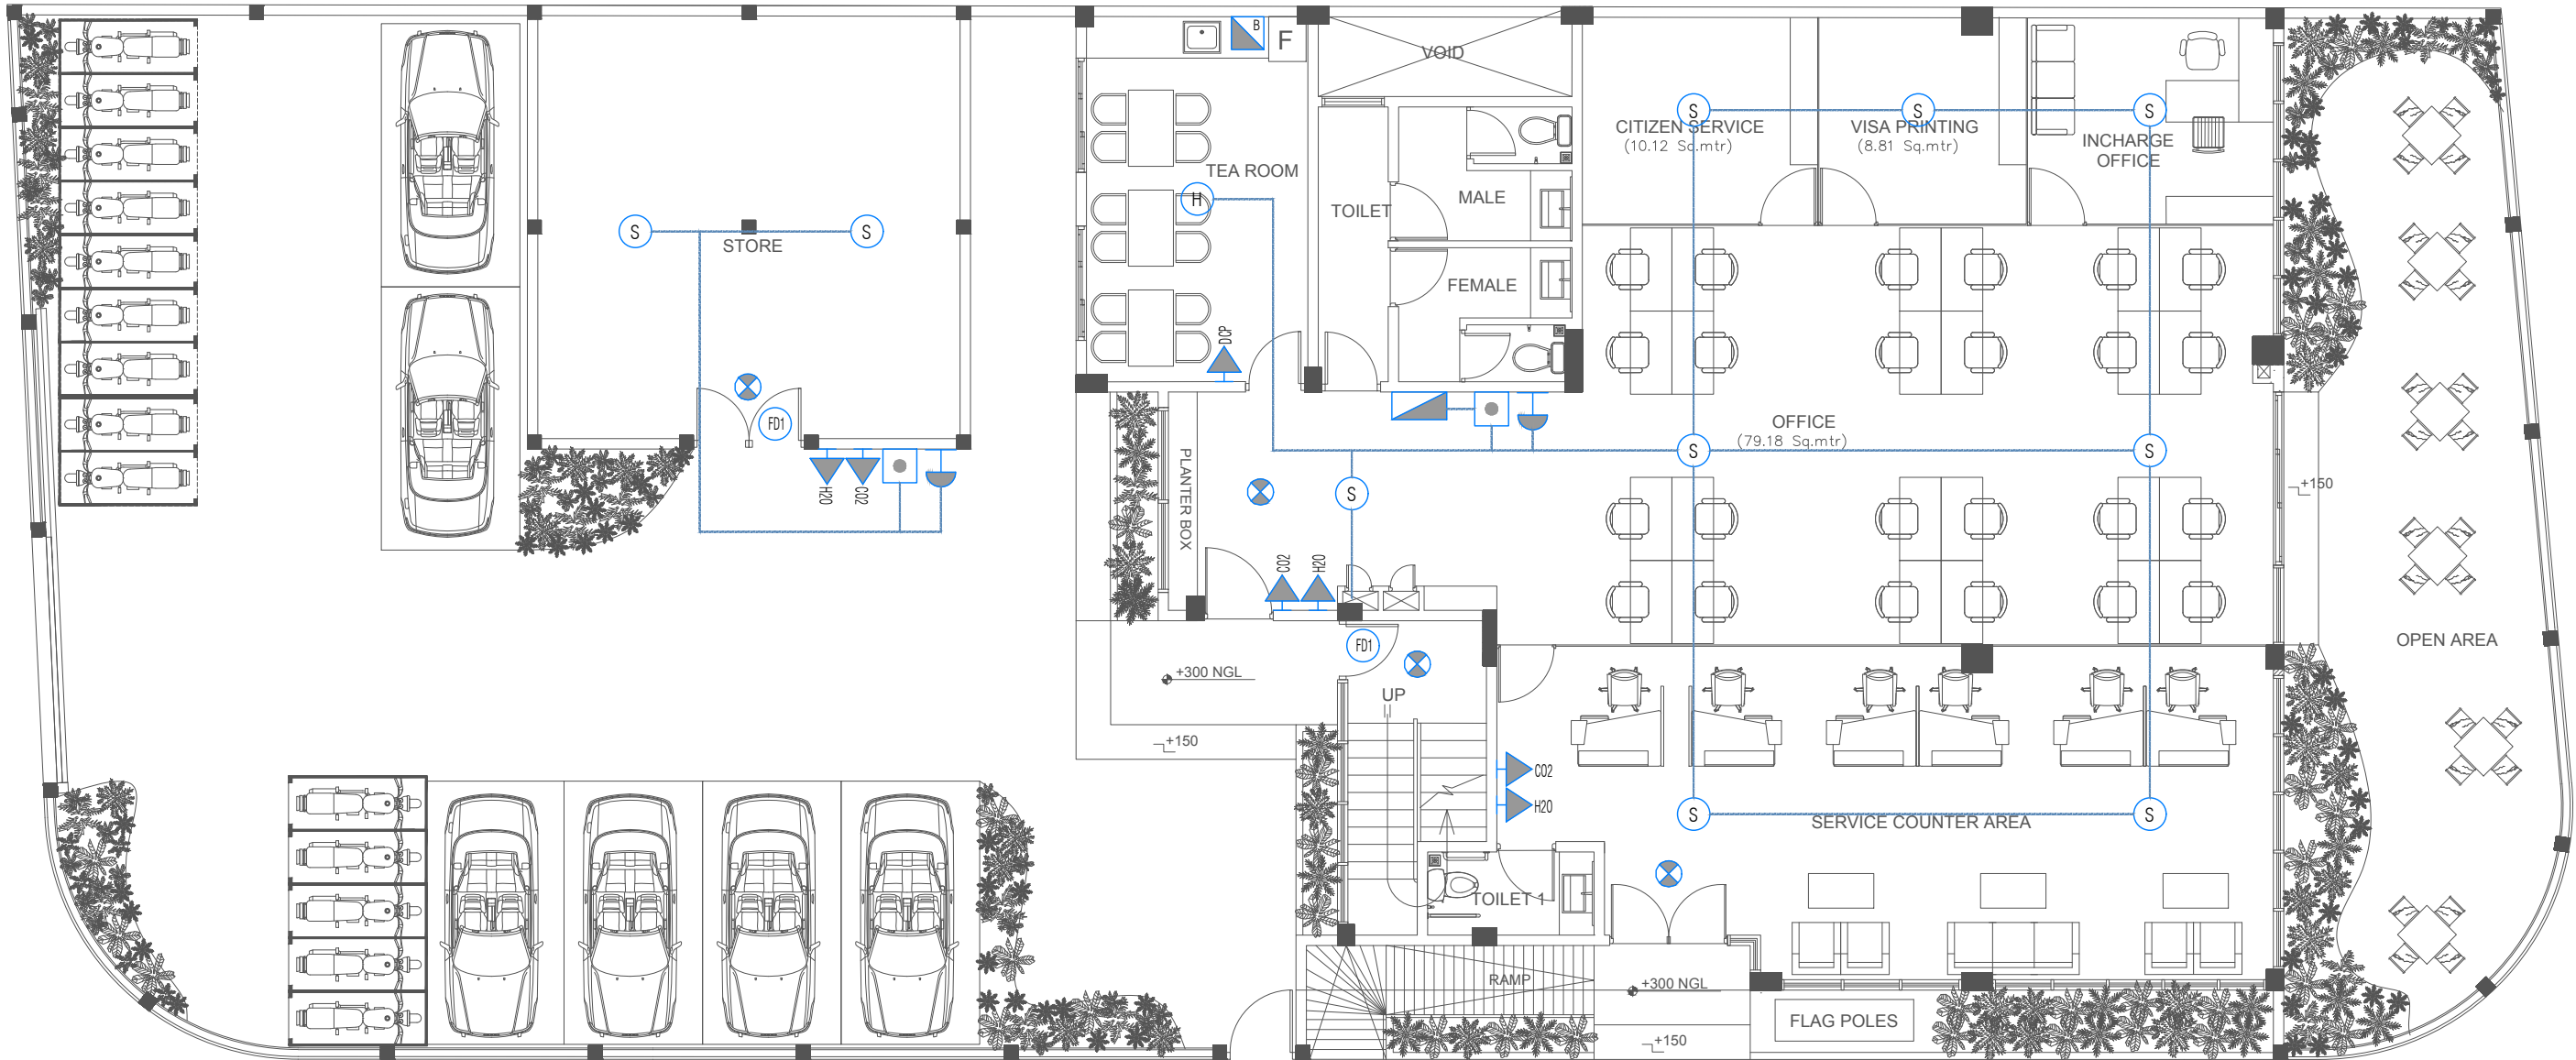


GROUND FLOOR FIRE PROTECTION LAYOUT
SCALE 1: 100

| | | | | | | | |
|--|-------------------------------|------------|----------------------------------|------------|--------------|--|----------|
| PROJECT : <u>IMMIGRATION - S.HITHADHOO</u> | TITLE : AS GIVEN | DRAWN BY: | ALI ZAMYR | DATE | AUGUST 2021 | <div>ARCHIMALDIVES PRIVATE LIMITED <small>M.MISRU GANDHAKOALHIGE, 5TH FLOOR, SHAARIU VARUDHEE, MALE' TEL: (960) 7947733, (960) 7991269, Email: archimaldives@gmail.com</small></div> | PAGE NO. |
| | CLIENT : MALDIVES IMMIGRATION | ARCHITECT: | ALI ZAMYR | SCALE | AS GIVEN | | MEP - 13 |
| | | ENGINEER: | AHMED ZUHAL ZAEEM | PROJECT No | AM-D/2021/06 | | |
| | | | IF IN DOUBT - ASK - DO NOT SCALE | | | | |

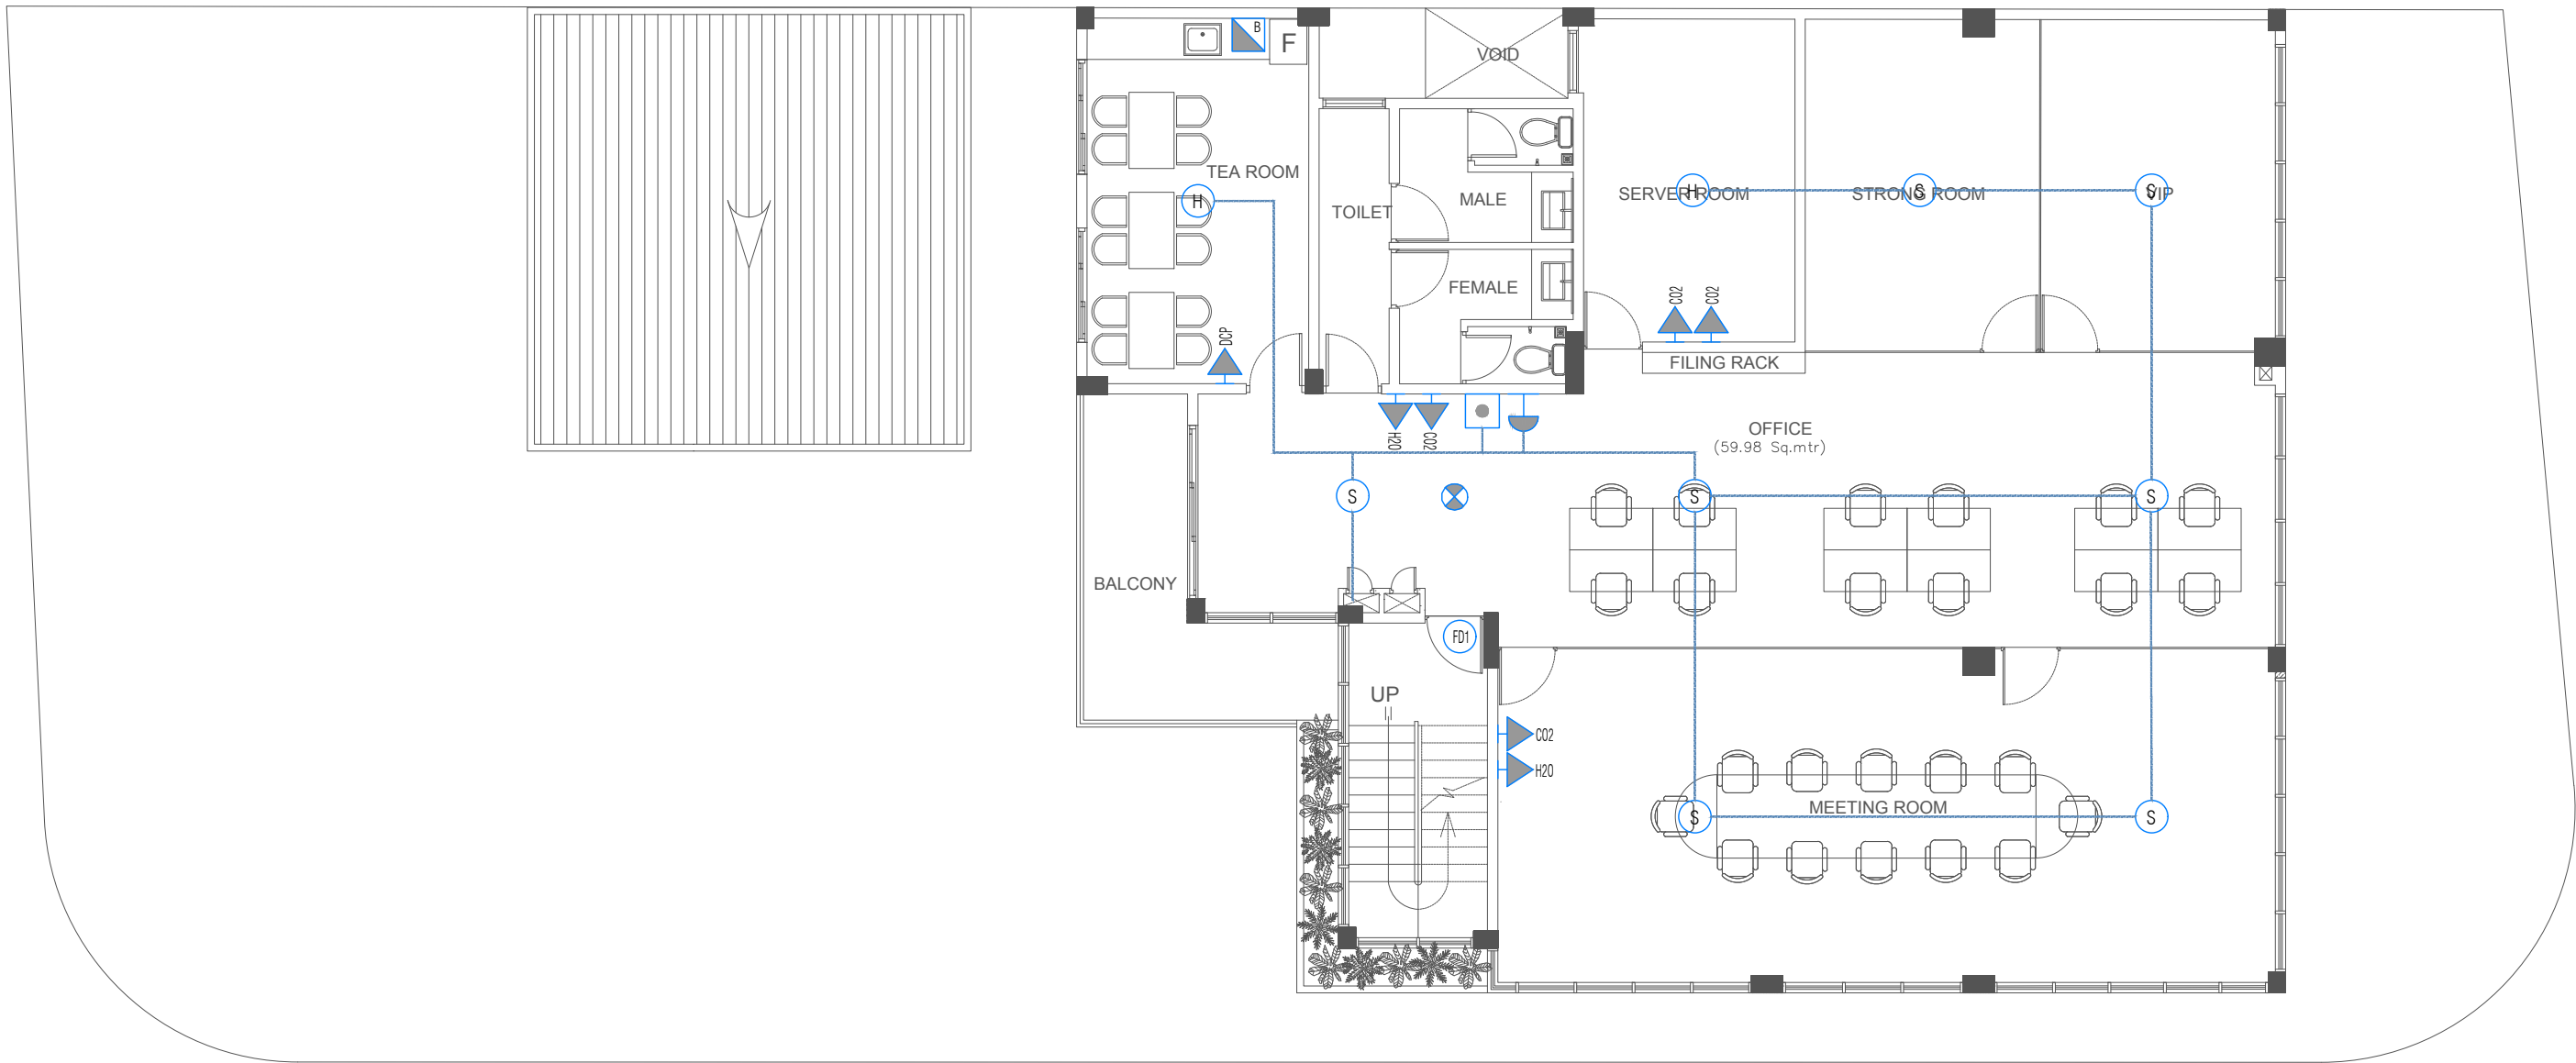


FIRST FLOOR FIRE PROTECTION LAYOUT
SCALE 1: 100


| | | | | | | | |
|--|-------------------------------|----------------------------------|-------------------|------------|--------------|--|----------|
| PROJECT : <u>IMMIGRATION - S.HITHADHOO</u> | TITLE : AS GIVEN | DRAWN BY: | ALI ZAMYR | DATE | AUGUST 2021 | <div><div>ARCHIMALDIVES PRIVATE LIMITED</div><div>M.MISRU GANDHAKOALHIGE, 5TH FLOOR, SHAARIU VARUDHEE, MALE TEL: (960) 7947733, (960) 7991269, Email: archimaldives@gmail.com</div></div> | PAGE NO. |
| | CLIENT : MALDIVES IMMIGRATION | ARCHITECT: | ALI ZAMYR | SCALE | AS GIVEN | | |
| | | ENGINEER: | AHMED ZUHAL ZAEEM | PROJECT No | AM-D/2021/06 | | |
| | | IF IN DOUBT - ASK - DO NOT SCALE | | | | | |
| MEP - 14 | | | | | | | |




ARCHIMALDIVES
 PRIVATE LIMITED
 M.MISRU GANDHAKOALHIGE, 5TH FLOOR,SHAARIU VARUDHEE, MALE
 TEL: (960) 7947733, (960) 7991269, Email: archimaldives@gmail.com

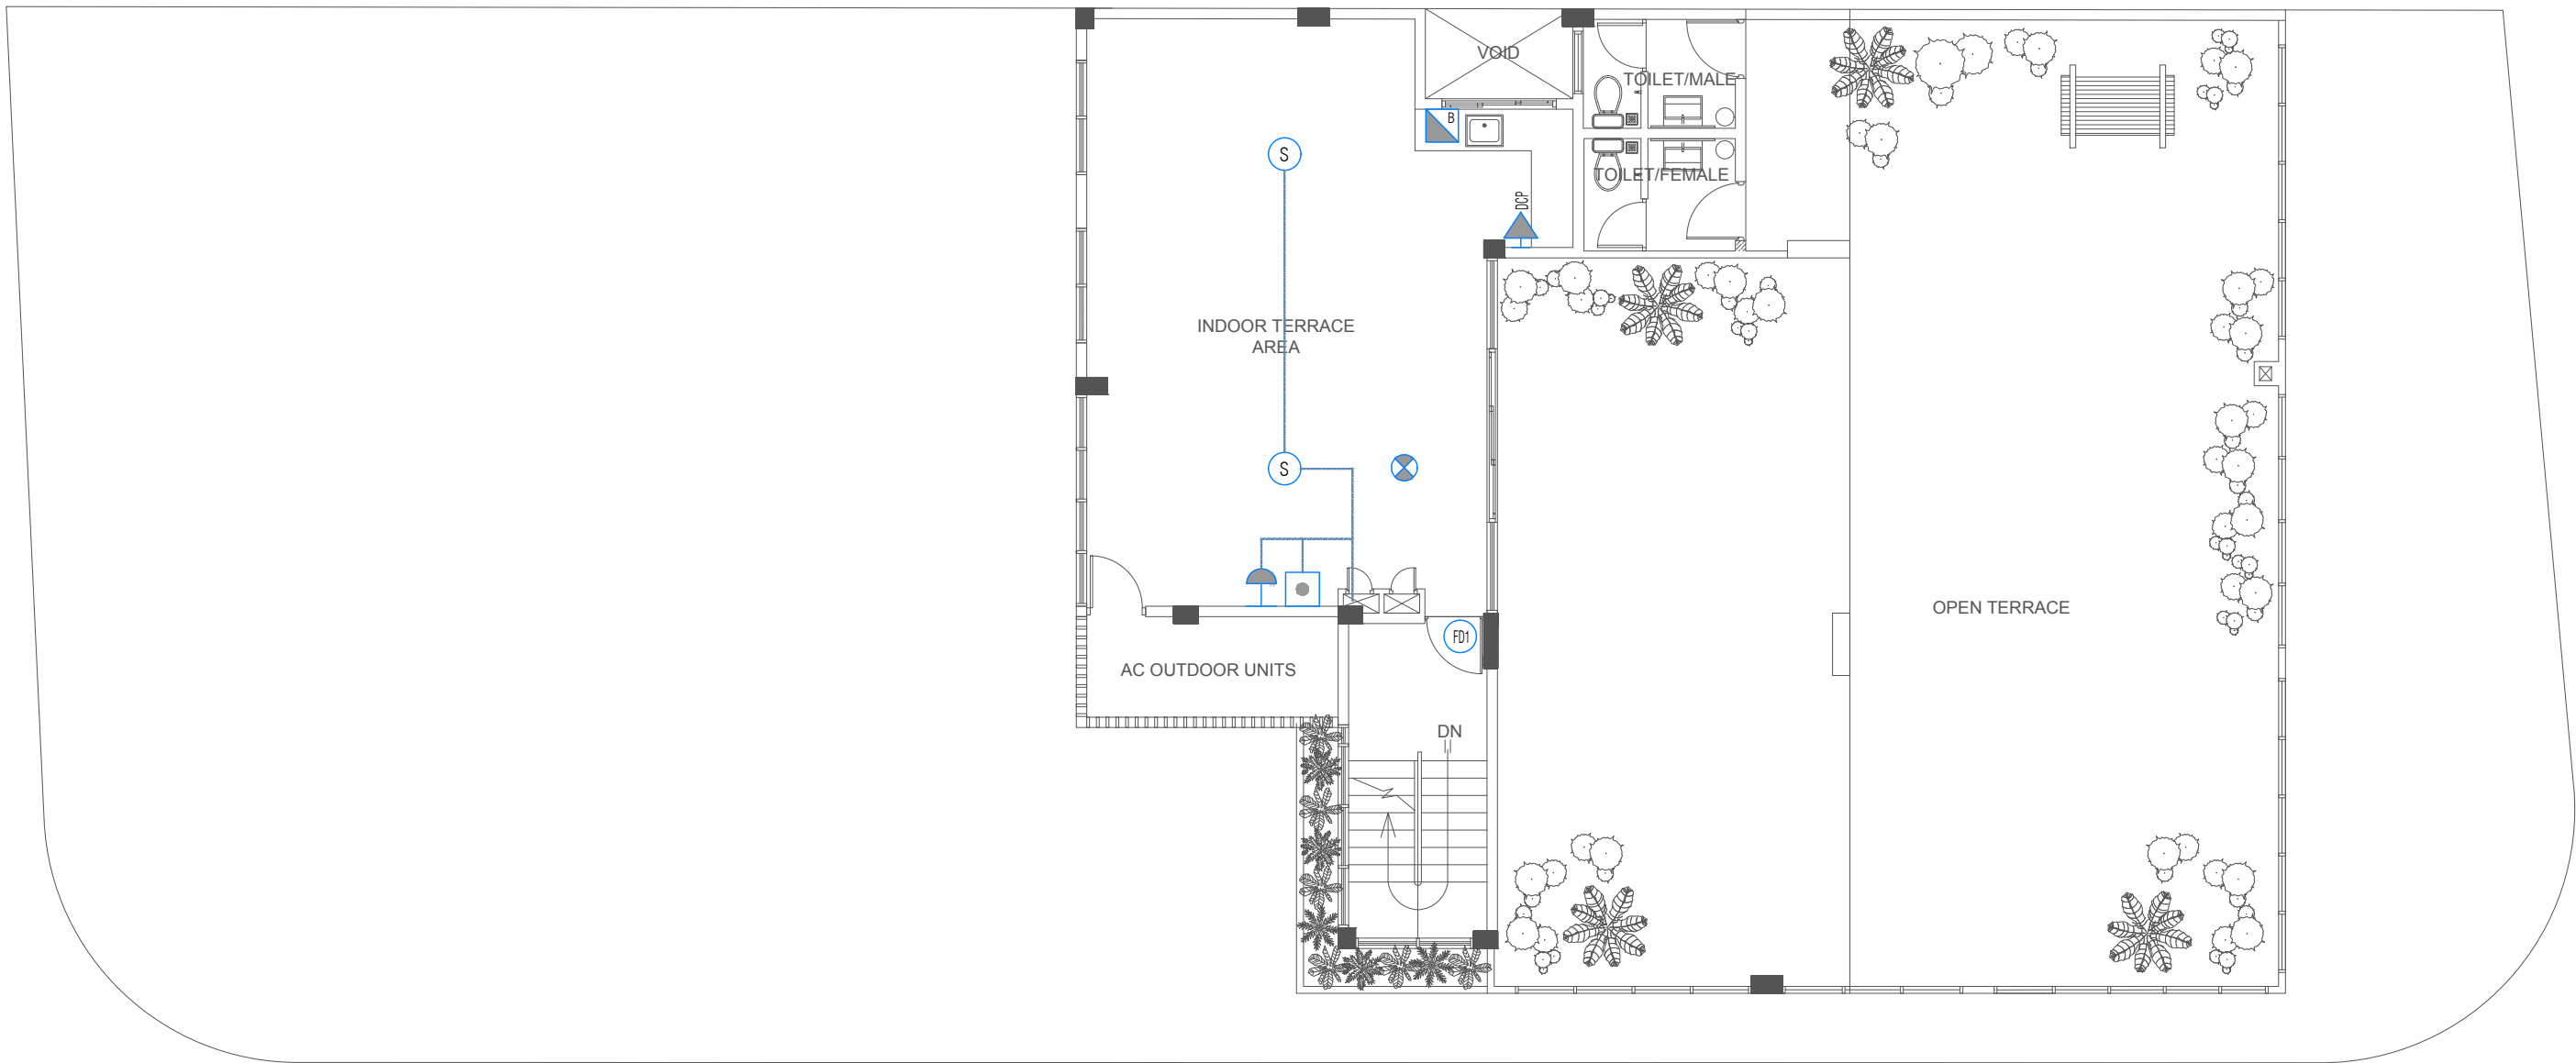



















TERRACE FLOOR FIRE PROTECTION LAYOUT
SCALE 1: 100

| | | | | | | | |
|--|-------------------------------|----------------------------------|-------------------|------------|--------------|--|----------|
| PROJECT : <u>IMMIGRATION - S.HITHADHOO</u> | TITLE : AS GIVEN | DRAWN BY: | ALI ZAMYR | DATE | AUGUST 2021 | <div><div>ARCHIMALDIVES PRIVATE LIMITED</div><div>M.MISRU GANDHAKOALHIGE, 5TH FLOOR,SHAARIU VARUDHEE, MALE' TEL: (960) 7947733, (960) 7991269, Email: archimaldives@gmail.com</div></div> | PAGE NO. |
| | CLIENT : MALDIVES IMMIGRATION | ARCHITECT: | ALI ZAMYR | SCALE | AS GIVEN | | MEP - 16 |
| | | ENGINEER: | AHMED ZUHAL ZAEEM | PROJECT No | AM-D/2021/06 | | |
| | | IF IN DOUBT - ASK - DO NOT SCALE | | | | | |

GENERAL NOTES

1. ALL PLUMBING WORKS INCLUDED HEREIN SHALL BE EXECUTED
ACCORDING TO THE PROVISIONS OF THE PLUMBING CODE.
THE LOCAL BUILDING CODE AND THE RULES
AND REGULATIONS ENFORCED IN THE LOCALITY.
2. COORDINATE THE DRAWINGS WITH OTHER RELATED DRAWINGS AND
SPECIFICATIONS. THE ARCHITECT/ENGINEER SHALL BE NOTIFIED
IMMEDIATELY OF ANY DISCREPANCY FOUND THEREIN.
3. ALL PIPES SHALL BE INSTALLED AS INDICATED ON PLANS. ANY
RELATIONS REQUIRED FOR PROPER EXECUTION OF OTHER TRADES
SHALL BE WITH PRIOR APPROVAL OF THE ARCHITECT OR ENGINEER.
4. PROPOSED SANITARY UTILITIES SHALL CONFORM TO THE ACTUAL
LOCATION, DEPTH AND INVERT ELEVATION OF ALL EXISTING PIPES
AND STRUCTURES AS VERIFIED BY THE CONTRACTOR.
5. ALL SLOPES FOR SEWER HORIZONTAL BRANCHES SHALL MAINTAIN
2% MINIMUM UNLESS OTHERWISE SPECIFIED.
6. SIZE OF WATER SUPPLY PIPES TO FIXTURES SHALL BE IN
ACCORDANCE WITH THE MANUFACTURER'S INSTRUCTIONS.
7. THE CONTRACTOR SHALL VERIFY ALL EXISTING UTILITIES AT THE SITE
AND COORDINATE THE WORKS WITH THE SEWER LINE EFFLUENT,
DISPOSAL POINT AND WATER LINE SERVICE CONNECTING POINT.
8. SANITARY INSTALLATIONS SHALL NOT IMPAIR THE STRENGTH OF ANY
STRUCTURAL MEMBER, COORDINATE W/ STRUCTURAL PLANS
AND DETAILS.
9. MATERIAL USED IN INSTALLATIONS SHALL BE OF APPROVED BRAND,
FREE FROM ANY DEFECTS & PASSED THE QUALITY SET FORTH BY
THE BUREAU OF STANDARDS.
10. CONNECT ALL INSTALLATIONS TO THE MAIN SEWER LINE.

PLUMBING SYMBOLS KEY:

| SYMBOLS | DESCRIPTION | SYMBOLS | DESCRIPTION |
|---|------------------------------|---|---------------------------------|
|  | Ø 4" PVC WASTE WATER PIPE |  | FAUCET OUTLET (FRESH WATER) |
|  | Ø 2" PVC WASTE WATER PIPE |  | FAUCET OUTLET (GROUND WATER) |
|  | Ø 1" PVC FRESH WATER PIPE |  | FAUCET INLET (WASTE WATER) |
|  | Ø 1/2" PVC FRESH WATER PIPE |  | WATER PUMP |
|  | Ø 1" PVC GROUND WATER PIPE |  | BOOSTER PUMP |
|  | Ø 1/2" PVC GROUND WATER PIPE |  | 600x600mm INSPECTION CHAMBER |
|  | STOP/GATE VALVE |  | Ø 600mm MWSC INSPECTION CHAMBER |
|  | WATER METER |  | 4" FLOOR DRAIN |
|  | PVC REDUCER |  | "S" PVC AIR TRAP |


NOTE:

- * ALL THE CONNECTION SHOULD BE DONE THROUGH

* THIS DRAWING IS ONLY FOR PLUMBING USE

* ALL OUTLETS ARE FAUCET SOCKETS

* PROVIDE PROVISION FOR PLUMBING DUCTS AS PER THE DRAWINGS
MEASUREMENTS TO BE TAKEN AT SITE
11. CLEANOUT TO GRADE, PVC CLEANOUT
12. MINIMUM EARTH COVER OF 300MM SHALL BE OBSERVED FOR ALL
SANITARY AND COLD WATER PIPES.
13. CONNECT ALL SANITARY INSTALLATIONS W/ THE APPROPRIATE
FITTINGS USING PROPER PROCEDURES. SEE MANUFACTURERS
STANDARDS.
14. CONDUCT PROPER ROUGHING-IN AND/OR WATER TEST PRIOR
TO POURING TO ENSURE AGAINST LEAKAGES.
15. ALL PLUMBING FIXTURES SHALL BE AS PER ARCHITECT'S
SPECIFICATIONS.
16. ALL SANITARY INSTALLATIONS AS INDICATED HEREIN SHALL BE
DONE AS PER PLANS & SPECIFICATIONS NO ALTERATIONS SHALL
BE DONE W/ OUT THE APPROVAL OFTHE DESIGNER. CONSULT THE
DESIGNER AND FOR HIS REPRESENTATIVE ON THIS REGARD.

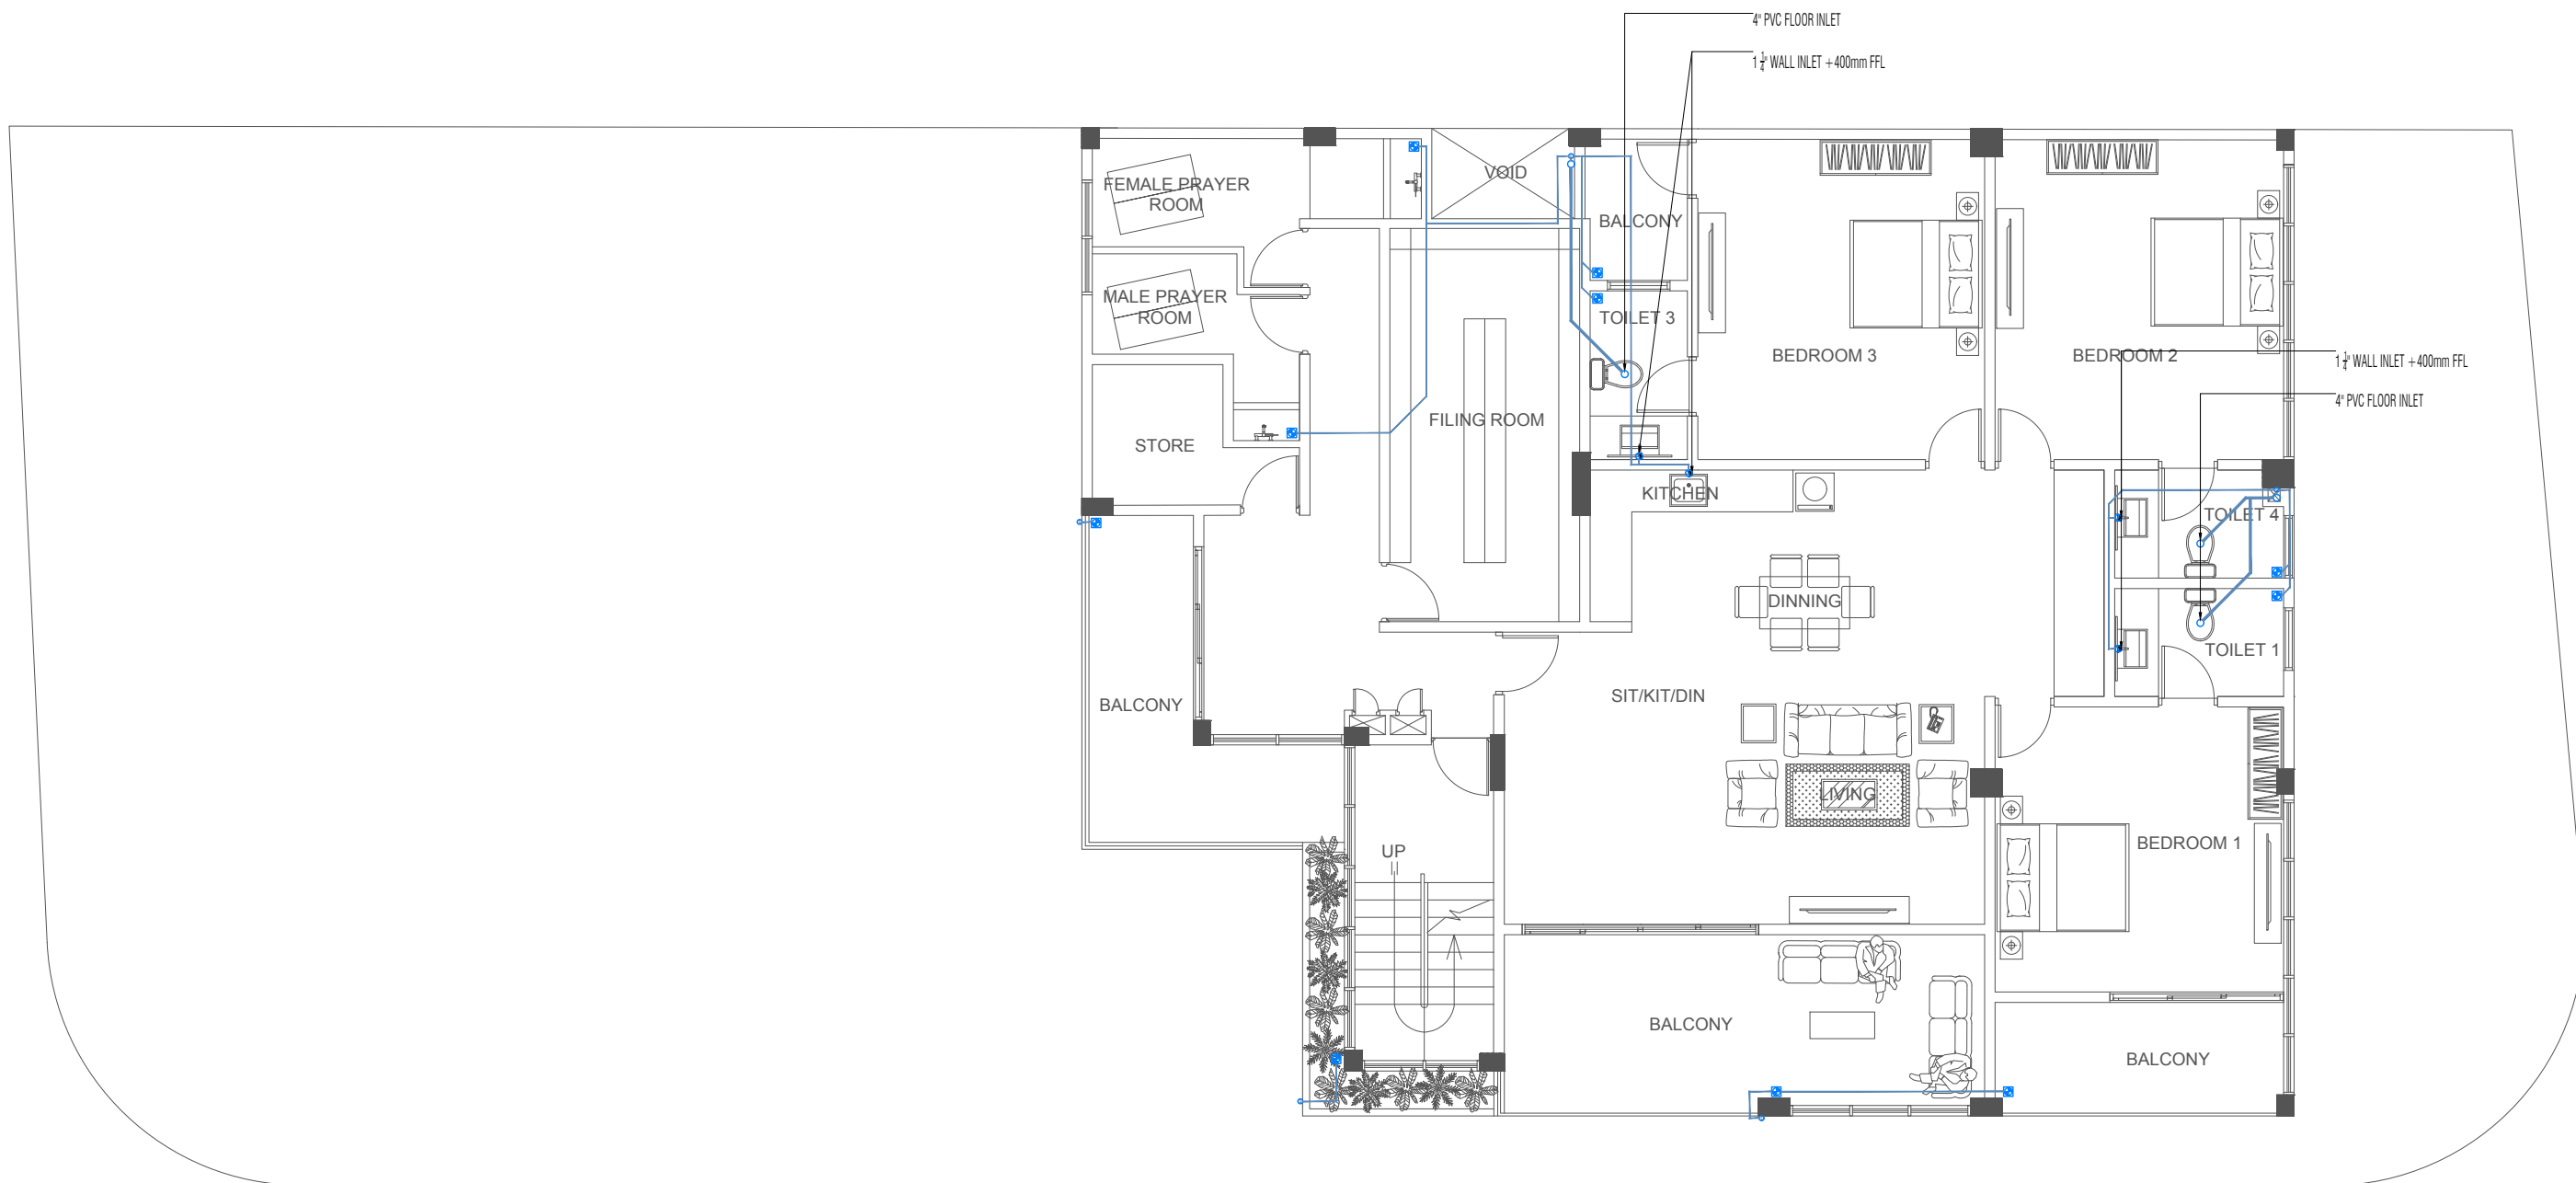

SECOND FLOOR WASTE DISPOSAL LAYOUT
SCALE 1: 100

PROJECT : IMMIGRATION - S.HITHADHOO

TITLE : AS GIVEN

CLIENT : MALDIVES IMMIGRATION

DRAWN BY:

ALI ZAMYR

ARCHITECT:

ALI ZAMYR

ENGINEER:

AHMED ZUHAL ZAEEM

DATE

AUGUST 2021


SCALE

AS GIVEN

PROJECT No

AM-D/2021/06

IF IN DOUBT - ASK - DO NOT SCALE

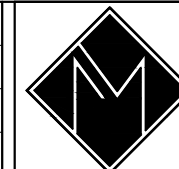


ARCHIMALDIVES
PRIVATE LIMITED

M.MISRU GANDHAKOALHIGE, 5TH FLOOR, SHAARIU VARUDHEE, MALE
TEL: (960) 7947733, (960) 7991269, Email: archimaldives@gmail.com

PAGE NO.

MEP - 19

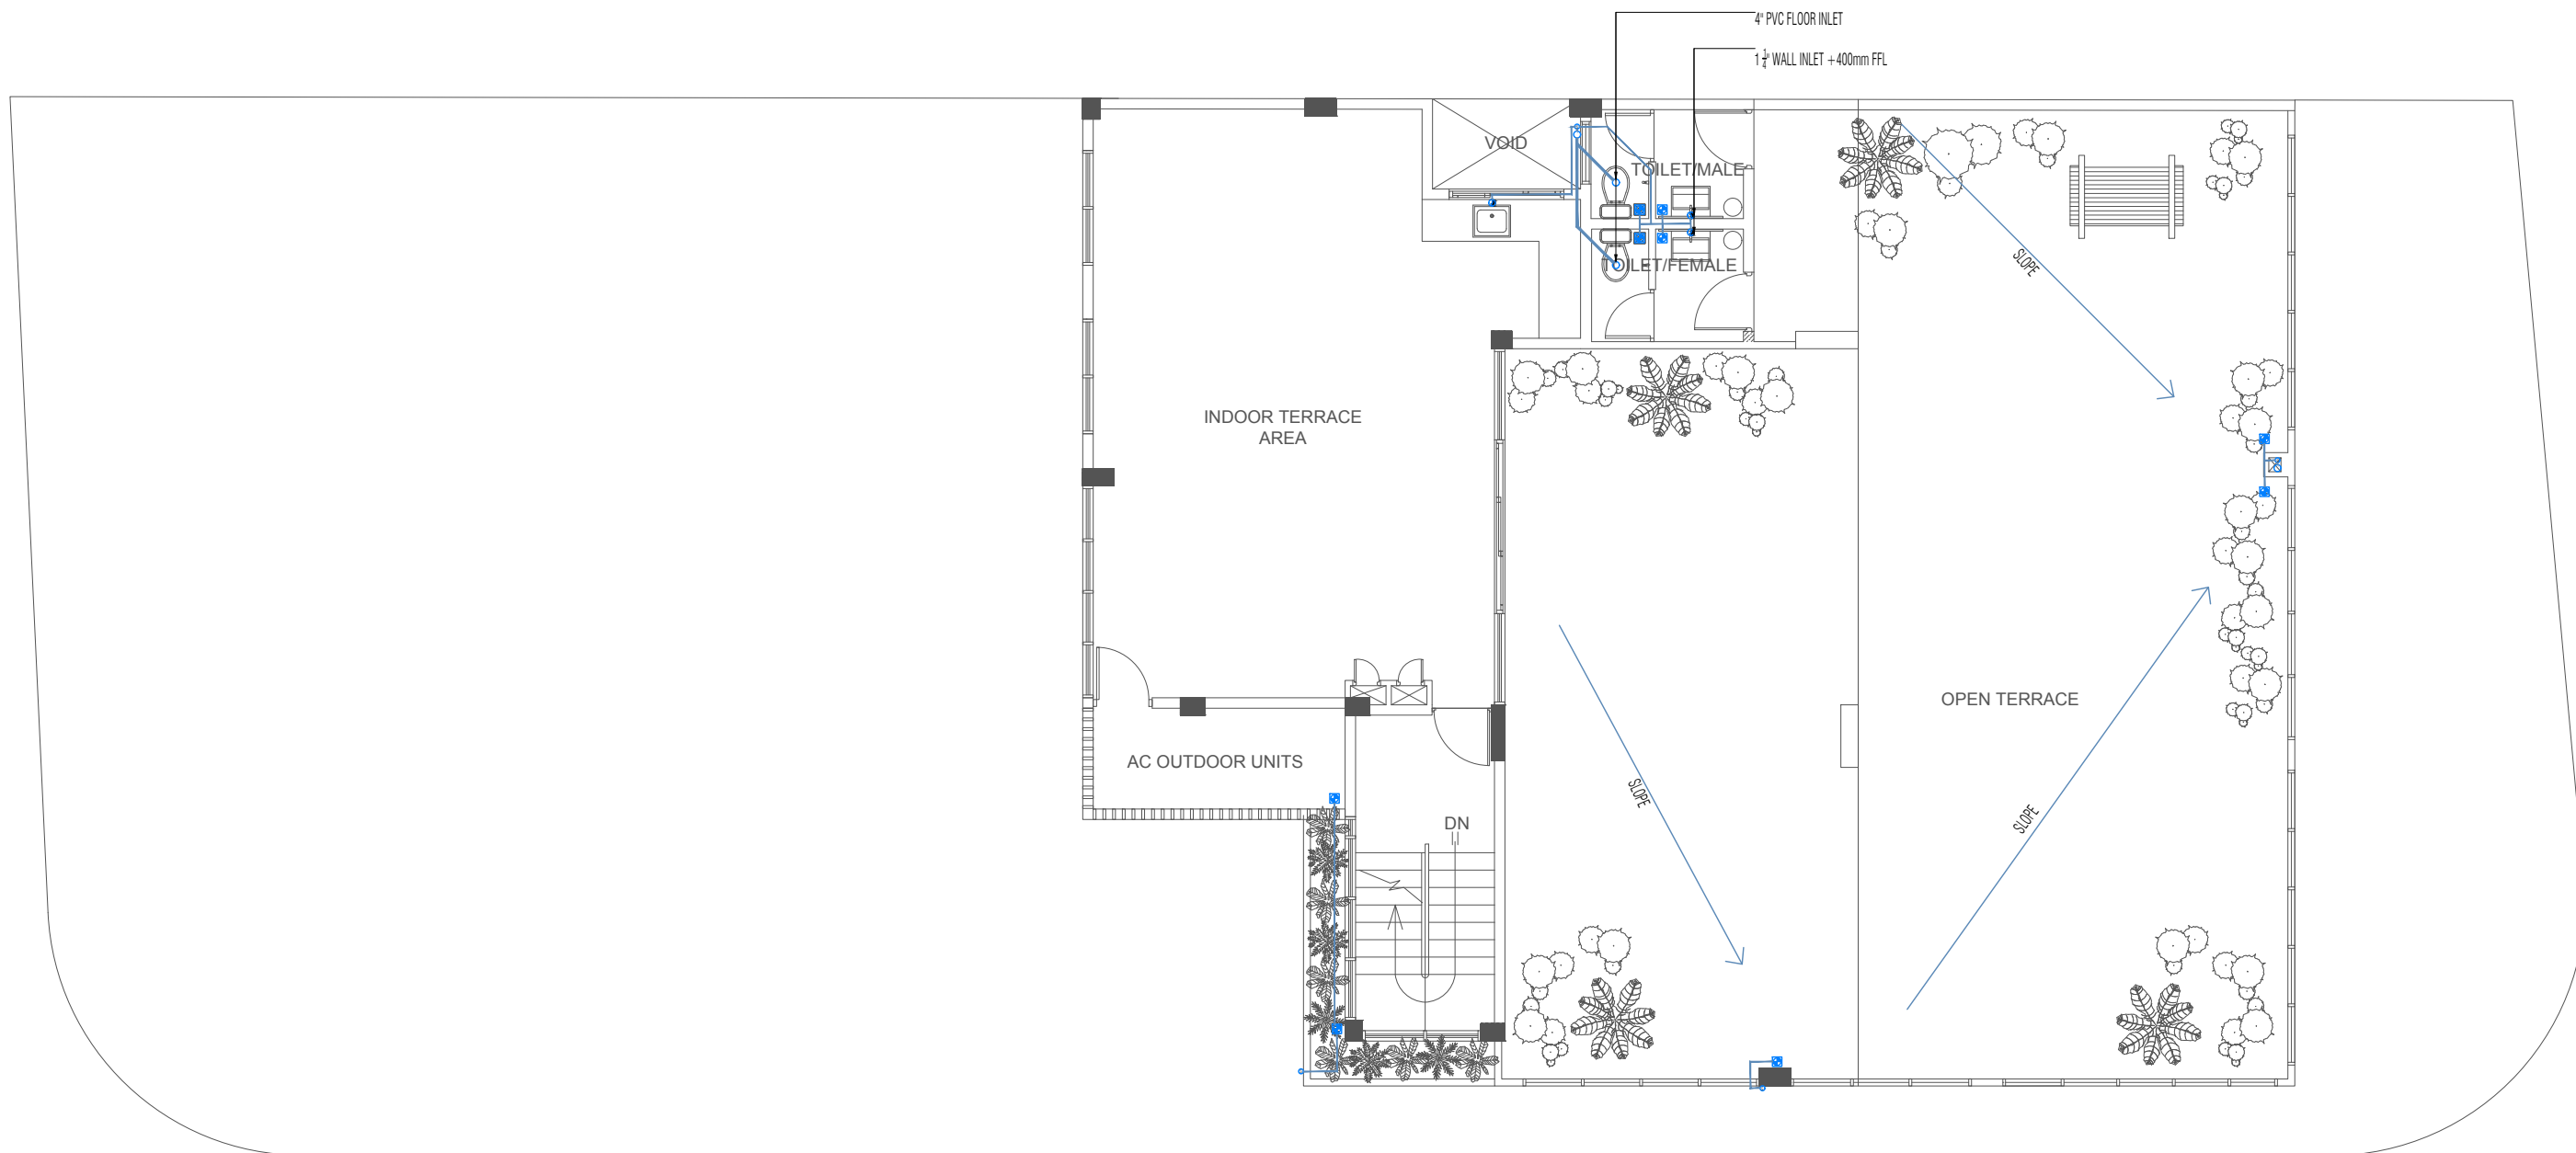

TERRACE FLOOR WASTE DISPOSAL LAYOUT
SCALE 1: 100

PROJECT : IMMIGRATION - S.HITHADHOO

TITLE : AS GIVEN

CLIENT : MALDIVES IMMIGRATION

DRAWN BY:

ALI ZAMYR

ARCHITECT:

ALI ZAMYR

ENGINEER:

AHMED ZUHAL ZAEEM

DATE

AUGUST 2021


SCALE

AS GIVEN

PROJECT No

AM-D/2021/06

IF IN DOUBT - ASK - DO NOT SCALE

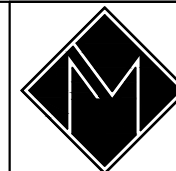


ARCHIMALDIVES
PRIVATE LIMITED

M.MISRU GANDHAKOALHIGE, 5TH FLOOR, SHAARIU VARUDHEE, MALE
TEL: (960) 7947733, (960) 7991269, Email: archimaldives@gmail.com

PAGE NO.

MEP - 20

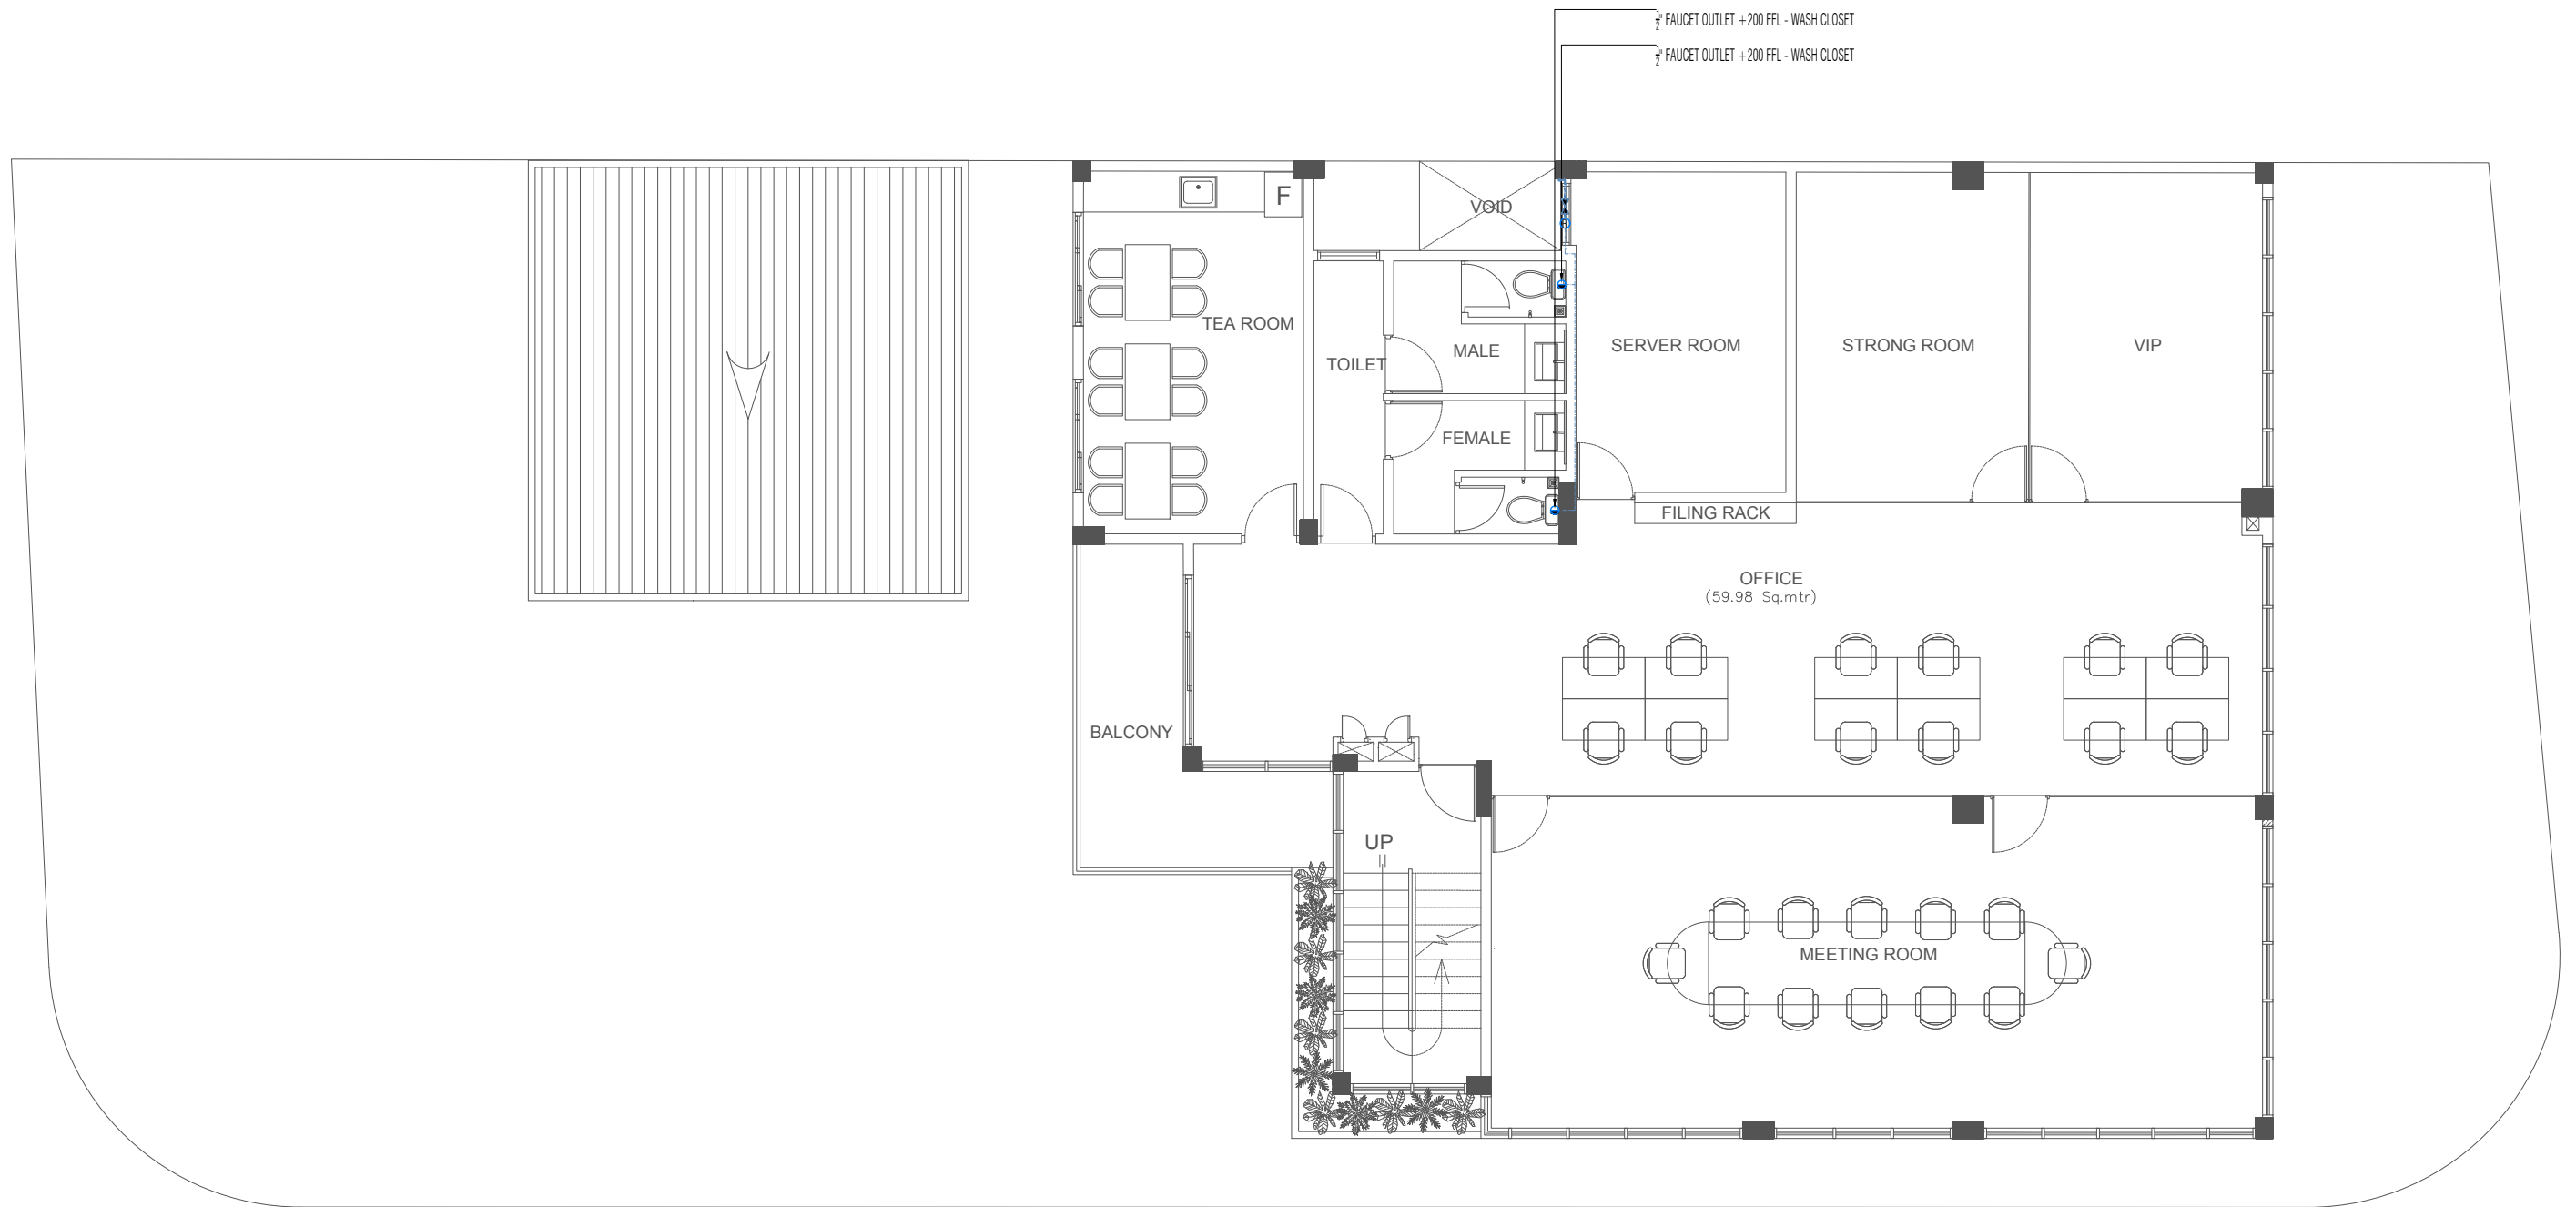

FIRST FLOOR GROUND WATER SUPPLY LAYOUT
SCALE 1: 100

PROJECT : IMMIGRATION - S.HITHADHOO

TITLE : AS GIVEN

CLIENT : MALDIVES IMMIGRATION

DRAWN BY:

ALI ZAMYR

ARCHITECT:

ALI ZAMYR

ENGINEER:

AHMED ZUHAL ZAEEM

DATE

AUGUST 2021


SCALE

AS GIVEN

PROJECT No

AM-D/2021/06

IF IN DOUBT - ASK - DO NOT SCALE

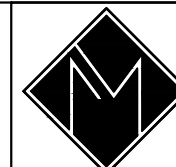


ARCHIMALDIVES
 PRIVATE LIMITED

M.MISRU GANDHAKOALHIGE, 5TH FLOOR, SHAARIU VARUDHEE, MALE
 TEL: (960) 7947733, (960) 7991269, Email: archimaldives@gmail.com

PAGE NO.

MEP - 22

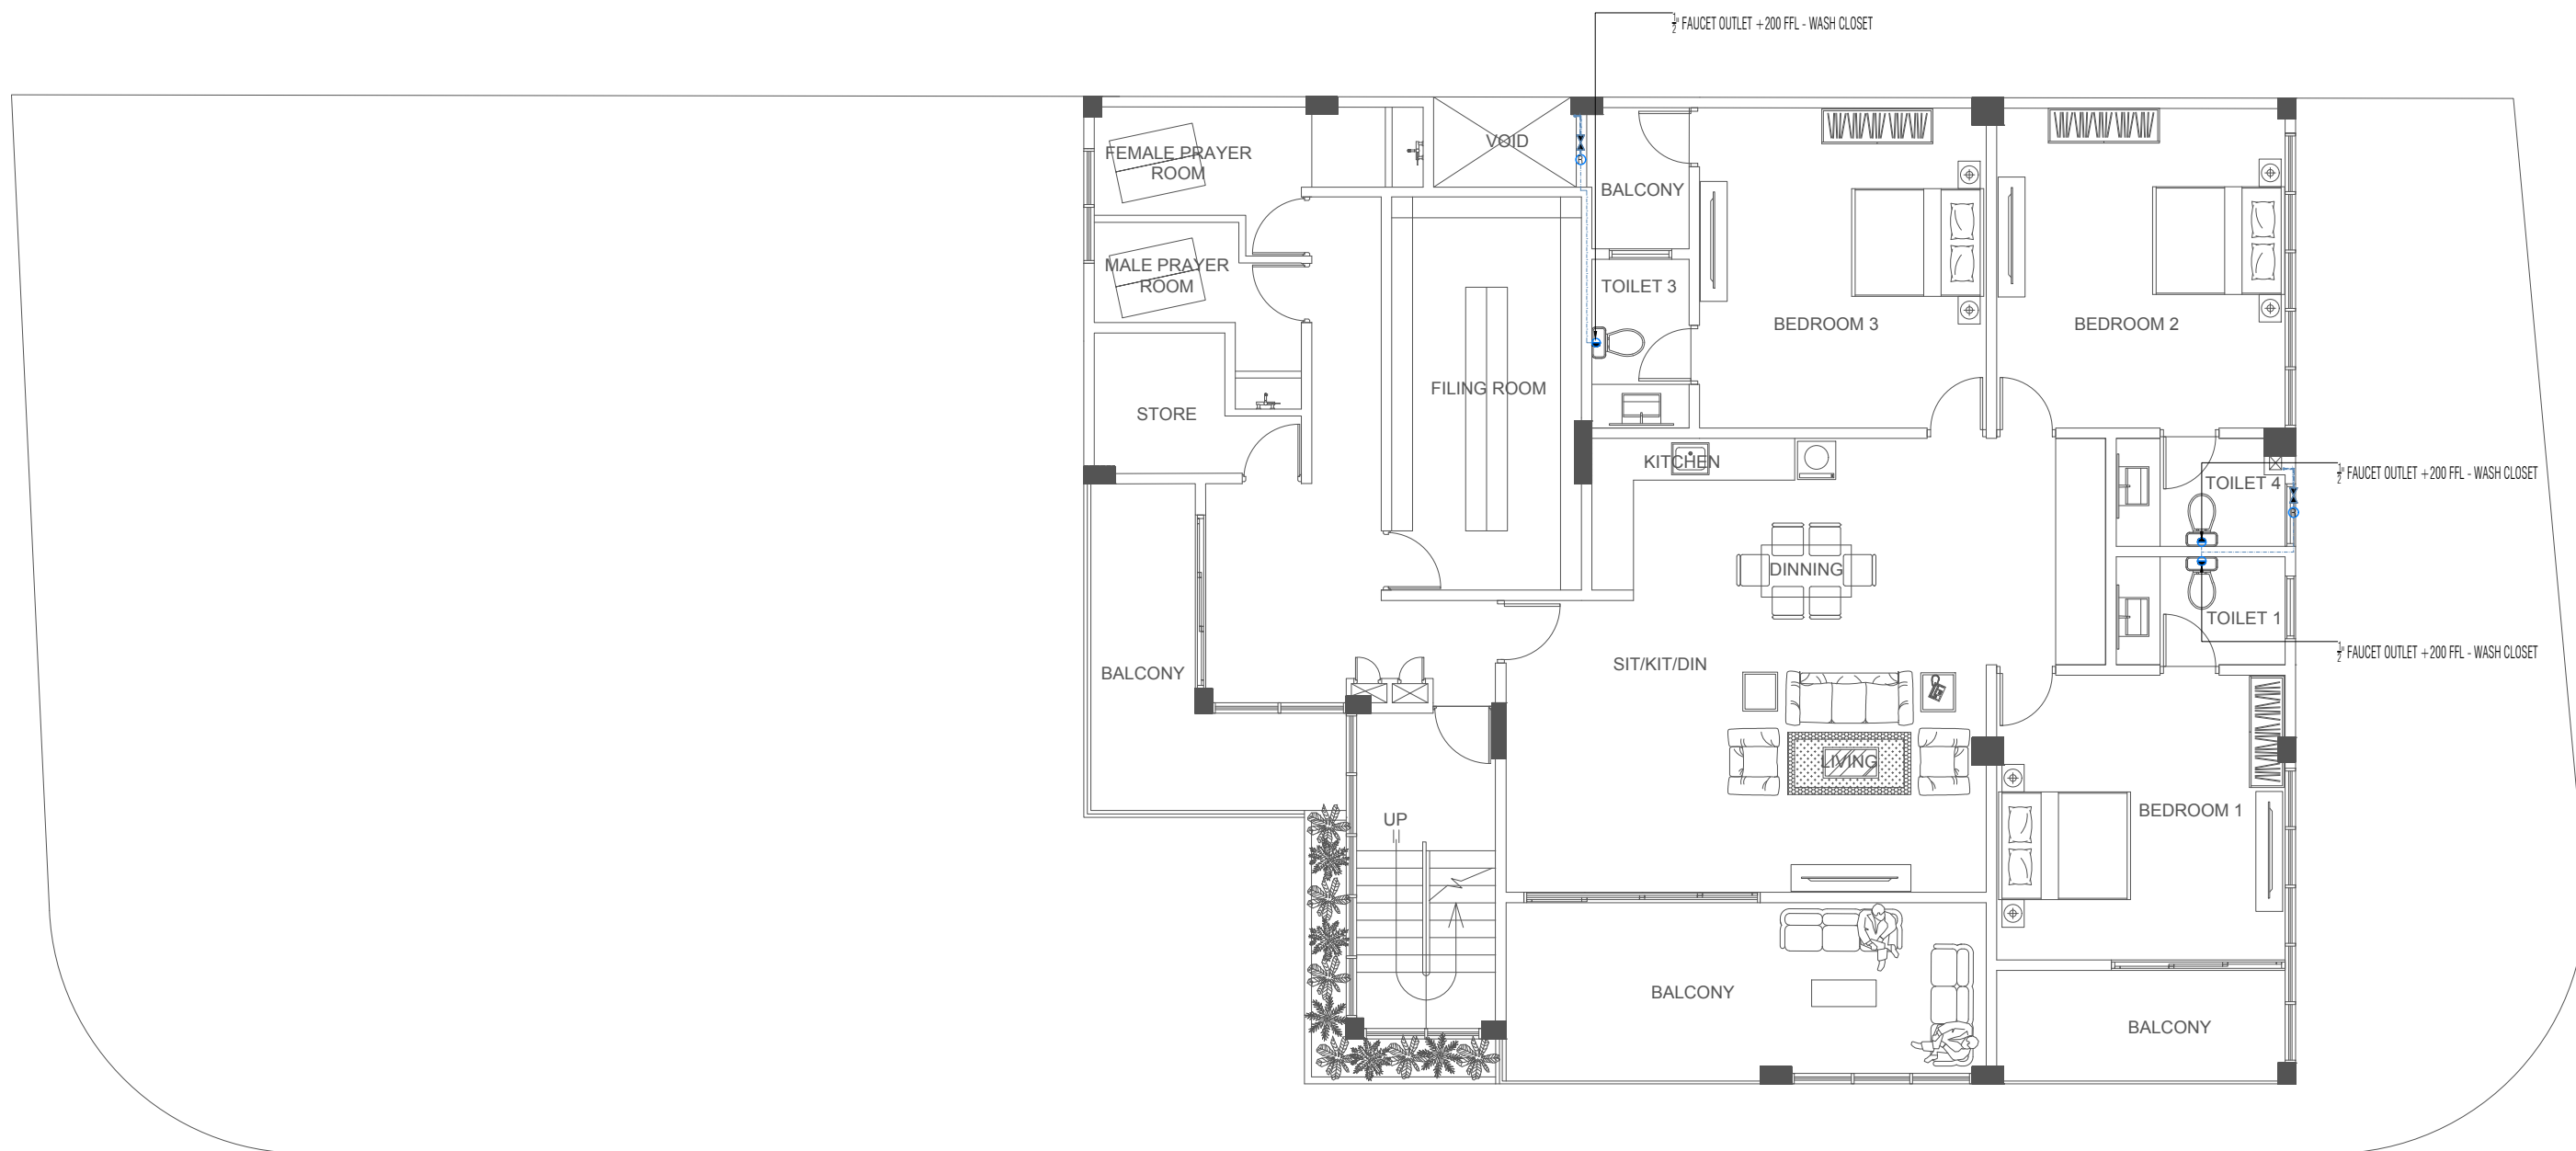

SECOND FLOOR GROUND WATER SUPPLY LAYOUT
SCALE 1: 100

PROJECT : IMMIGRATION - S.HITHADHOO

TITLE : AS GIVEN

CLIENT : MALDIVES IMMIGRATION

DRAWN BY:

ALI ZAMYR

ARCHITECT:

ALI ZAMYR

ENGINEER:

AHMED ZUHAL ZAEEM

DATE

AUGUST 2021


SCALE

AS GIVEN

PROJECT No

AM-D/2021/06

IF IN DOUBT - ASK - DO NOT SCALE

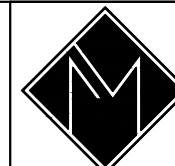


ARCHIMALDIVES
PRIVATE LIMITED


M.MISRU GANDHAKOALHIGE, 5TH FLOOR, SHAARIU VARUDHEE, MALE
TEL: (960) 7947733, (960) 7991269, Email: archimaldives@gmail.com


PAGE NO.

MEP - 23

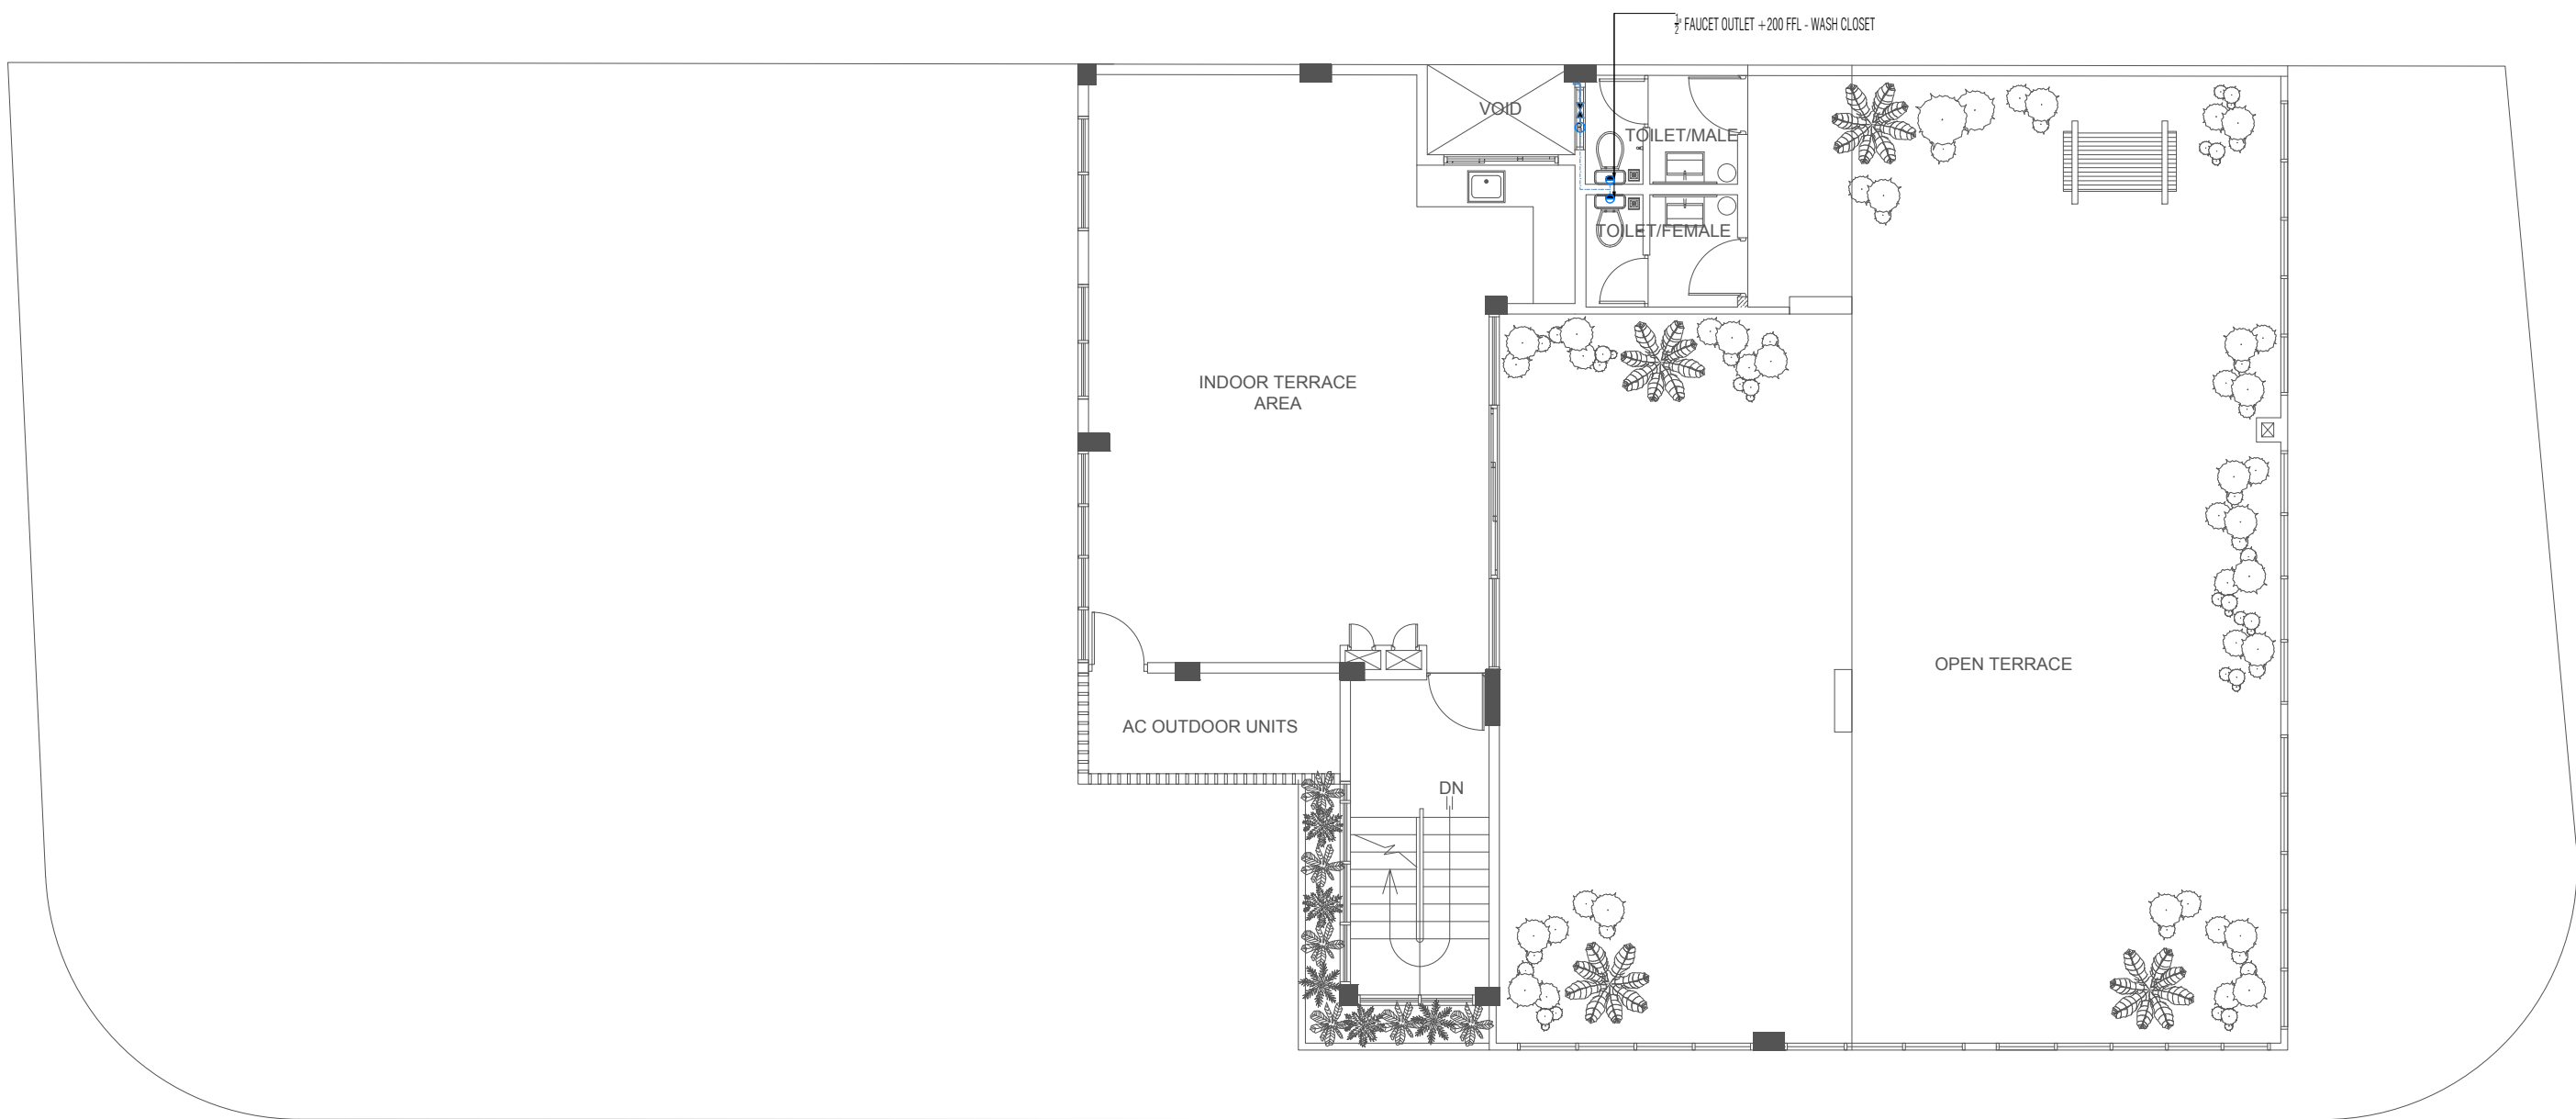

TERRACE FLOOR GROUND WATER SUPPLY LAYOUT
 SCALE 1: 100

| | | | | | | | |
|--|-------------------------------|----------------------------------|-------------------|------------|--------------|---|----------|
| PROJECT : <u>IMMIGRATION - S.HITHADHOO</u> | TITLE : AS GIVEN | DRAWN BY: | ALI ZAMYR | DATE | AUGUST 2021 | <div><div>ARCHIMALDIVES PRIVATE LIMITED</div><div>M.MISRU GANDHAKOALHIGE, 5TH FLOOR, SHAARIU VARUDHEE, MALE' TEL: (960) 7947733, (960) 7991269, Email: archimaldives@gmail.com</div></div> | PAGE NO. |
| | CLIENT : MALDIVES IMMIGRATION | ARCHITECT: | ALI ZAMYR | SCALE | AS GIVEN | | MEP - 24 |
| | | ENGINEER: | AHMED ZUHAL ZAEEM | PROJECT No | AM-D/2021/06 | | |
| | | IF IN DOUBT - ASK - DO NOT SCALE | | | | | |

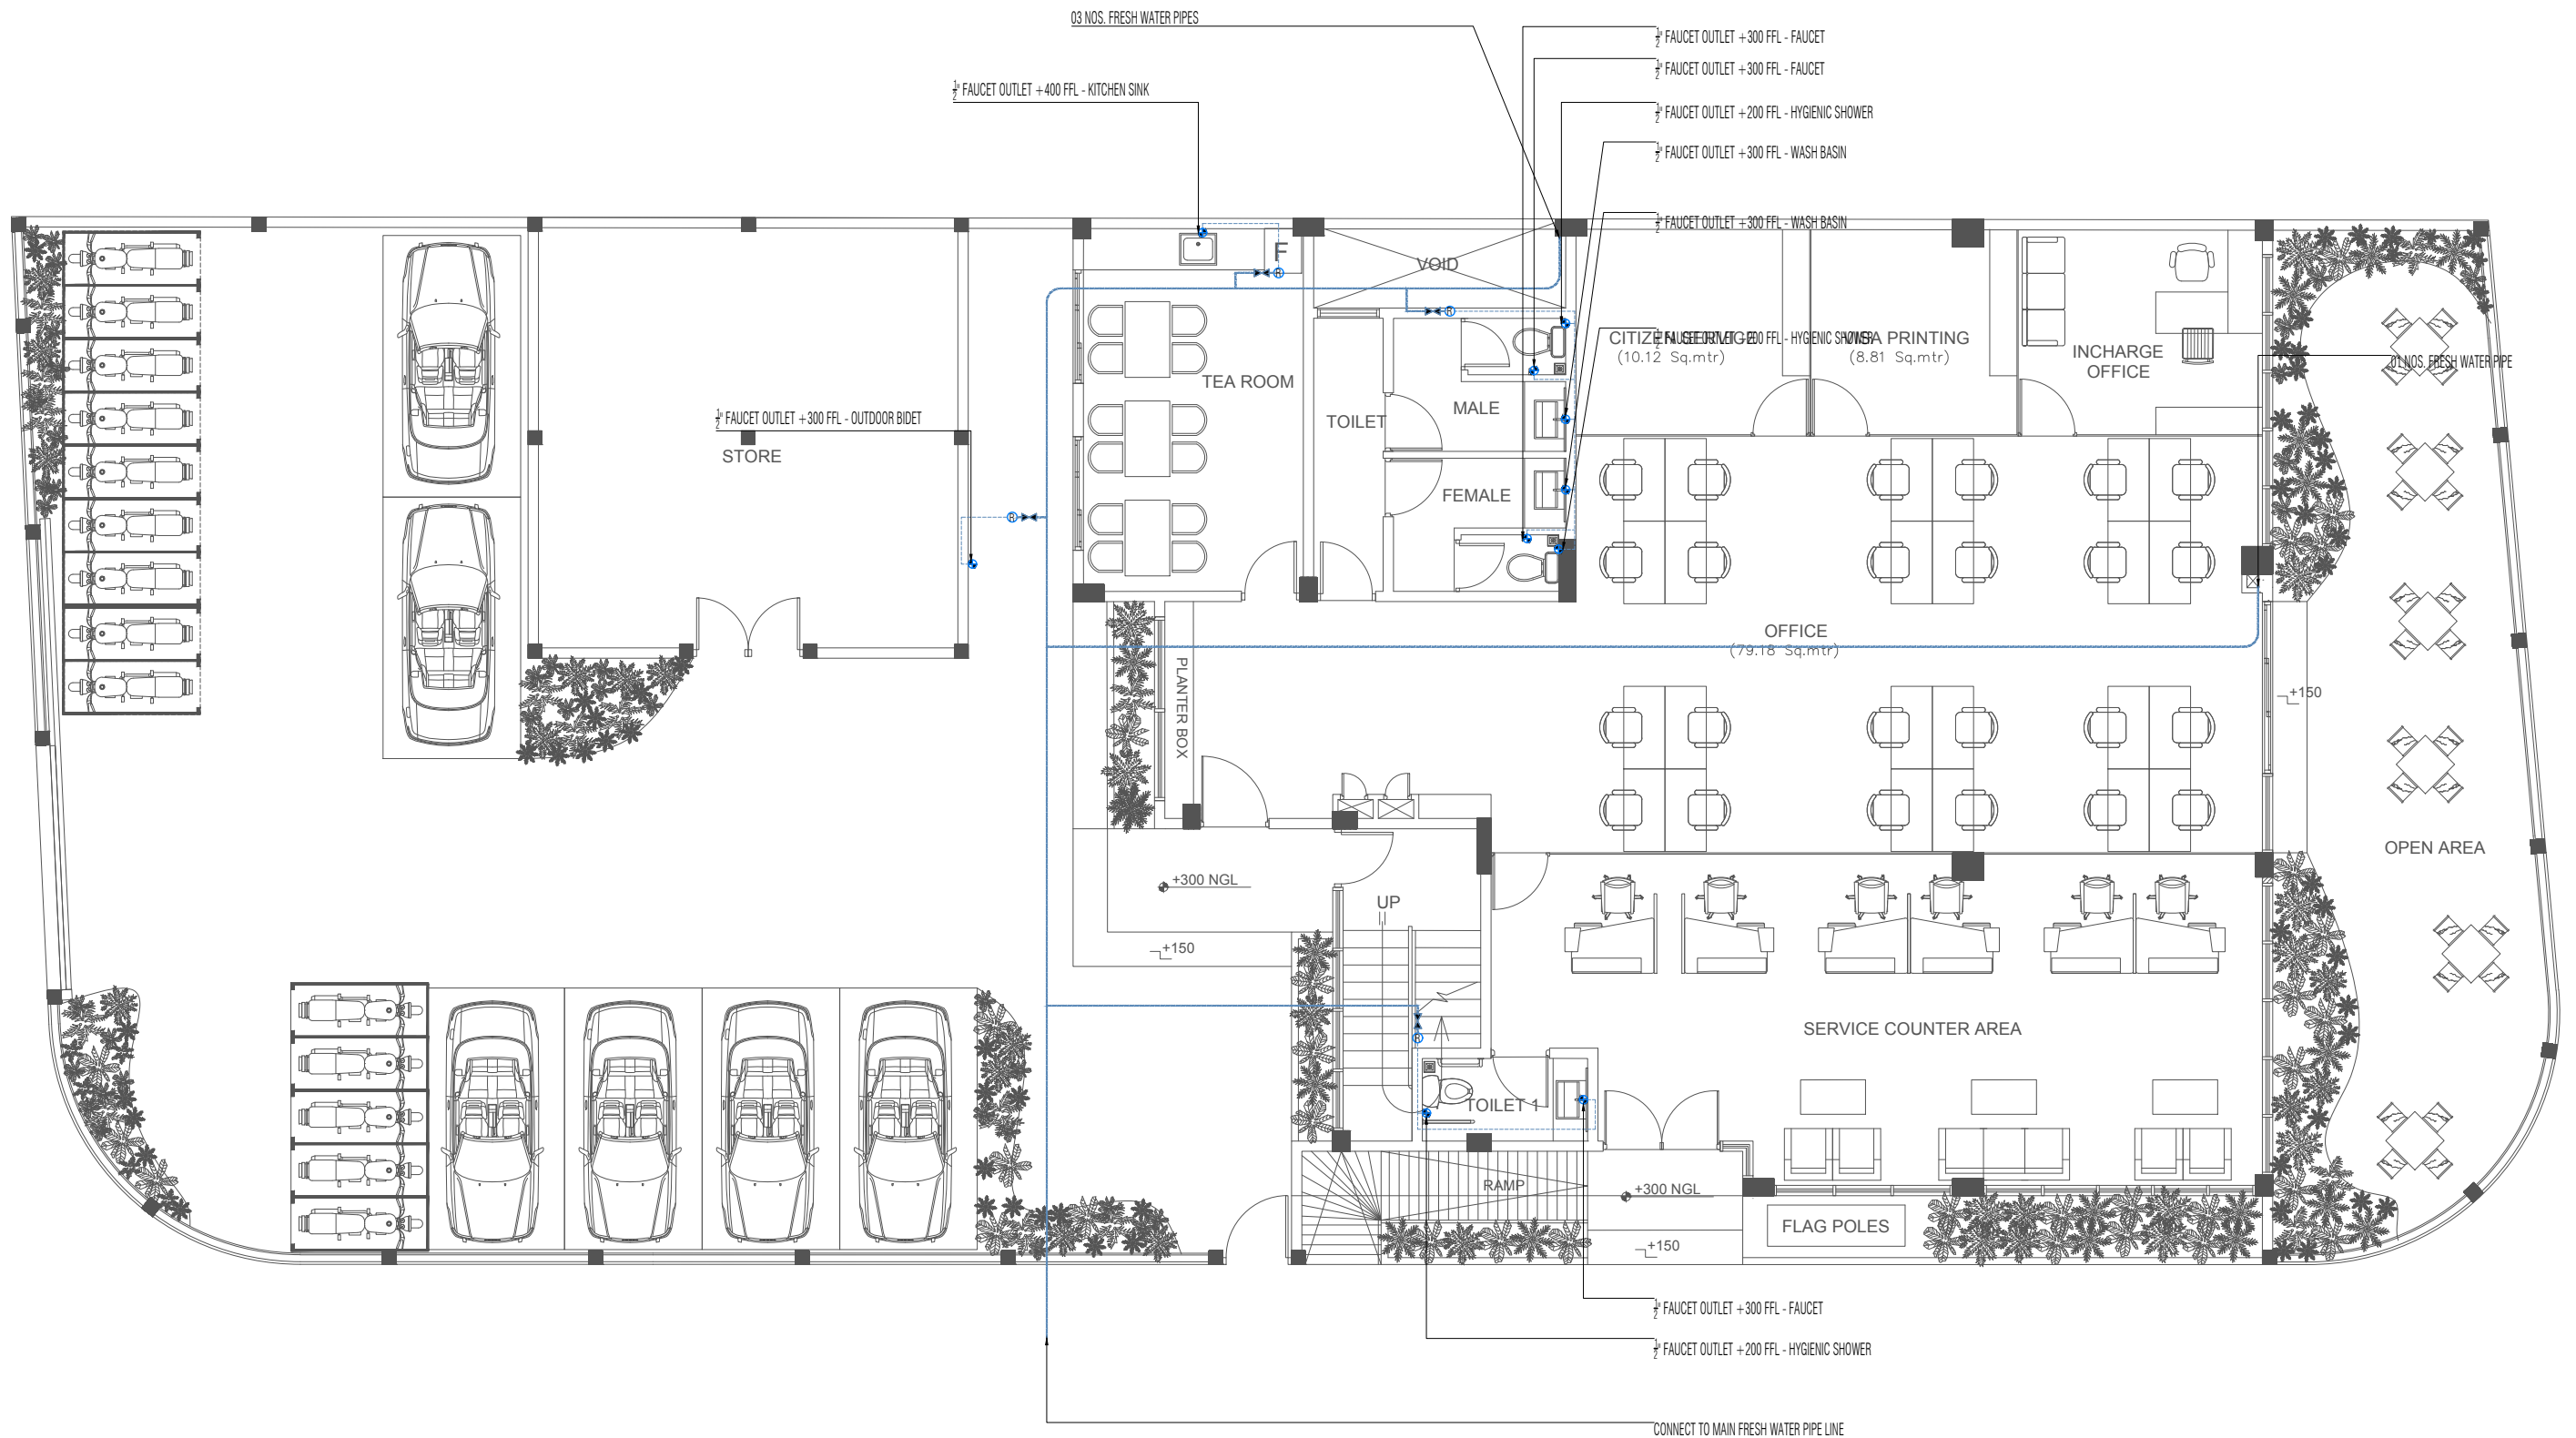

GROUND FLOOR FRESH WATER SUPPLY LAYOUT

SCALE 1: 100

PROJECT : IMMIGRATION - S.HITHADHOO

TITLE : AS GIVEN

CLIENT : MALDIVES IMMIGRATION

DRAWN BY:

ALI ZAMYR

ARCHITECT:

ALI ZAMYR

ENGINEER:

AHMED ZUHAL ZAEEM

DATE

AUGUST 2021


SCALE

AS GIVEN

PROJECT No

AM-D/2021/06

IF IN DOUBT - ASK - DO NOT SCALE

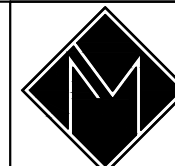


ARCHIMALDIVES
PRIVATE LIMITED

M.MISRU GANDHAKOALHIGE, 5TH FLOOR, SHAARIU VARUDHEE, MALE
TEL: (960) 7947733, (960) 7991269, Email: archimaldives@gmail.com

PAGE NO.

MEP - 25

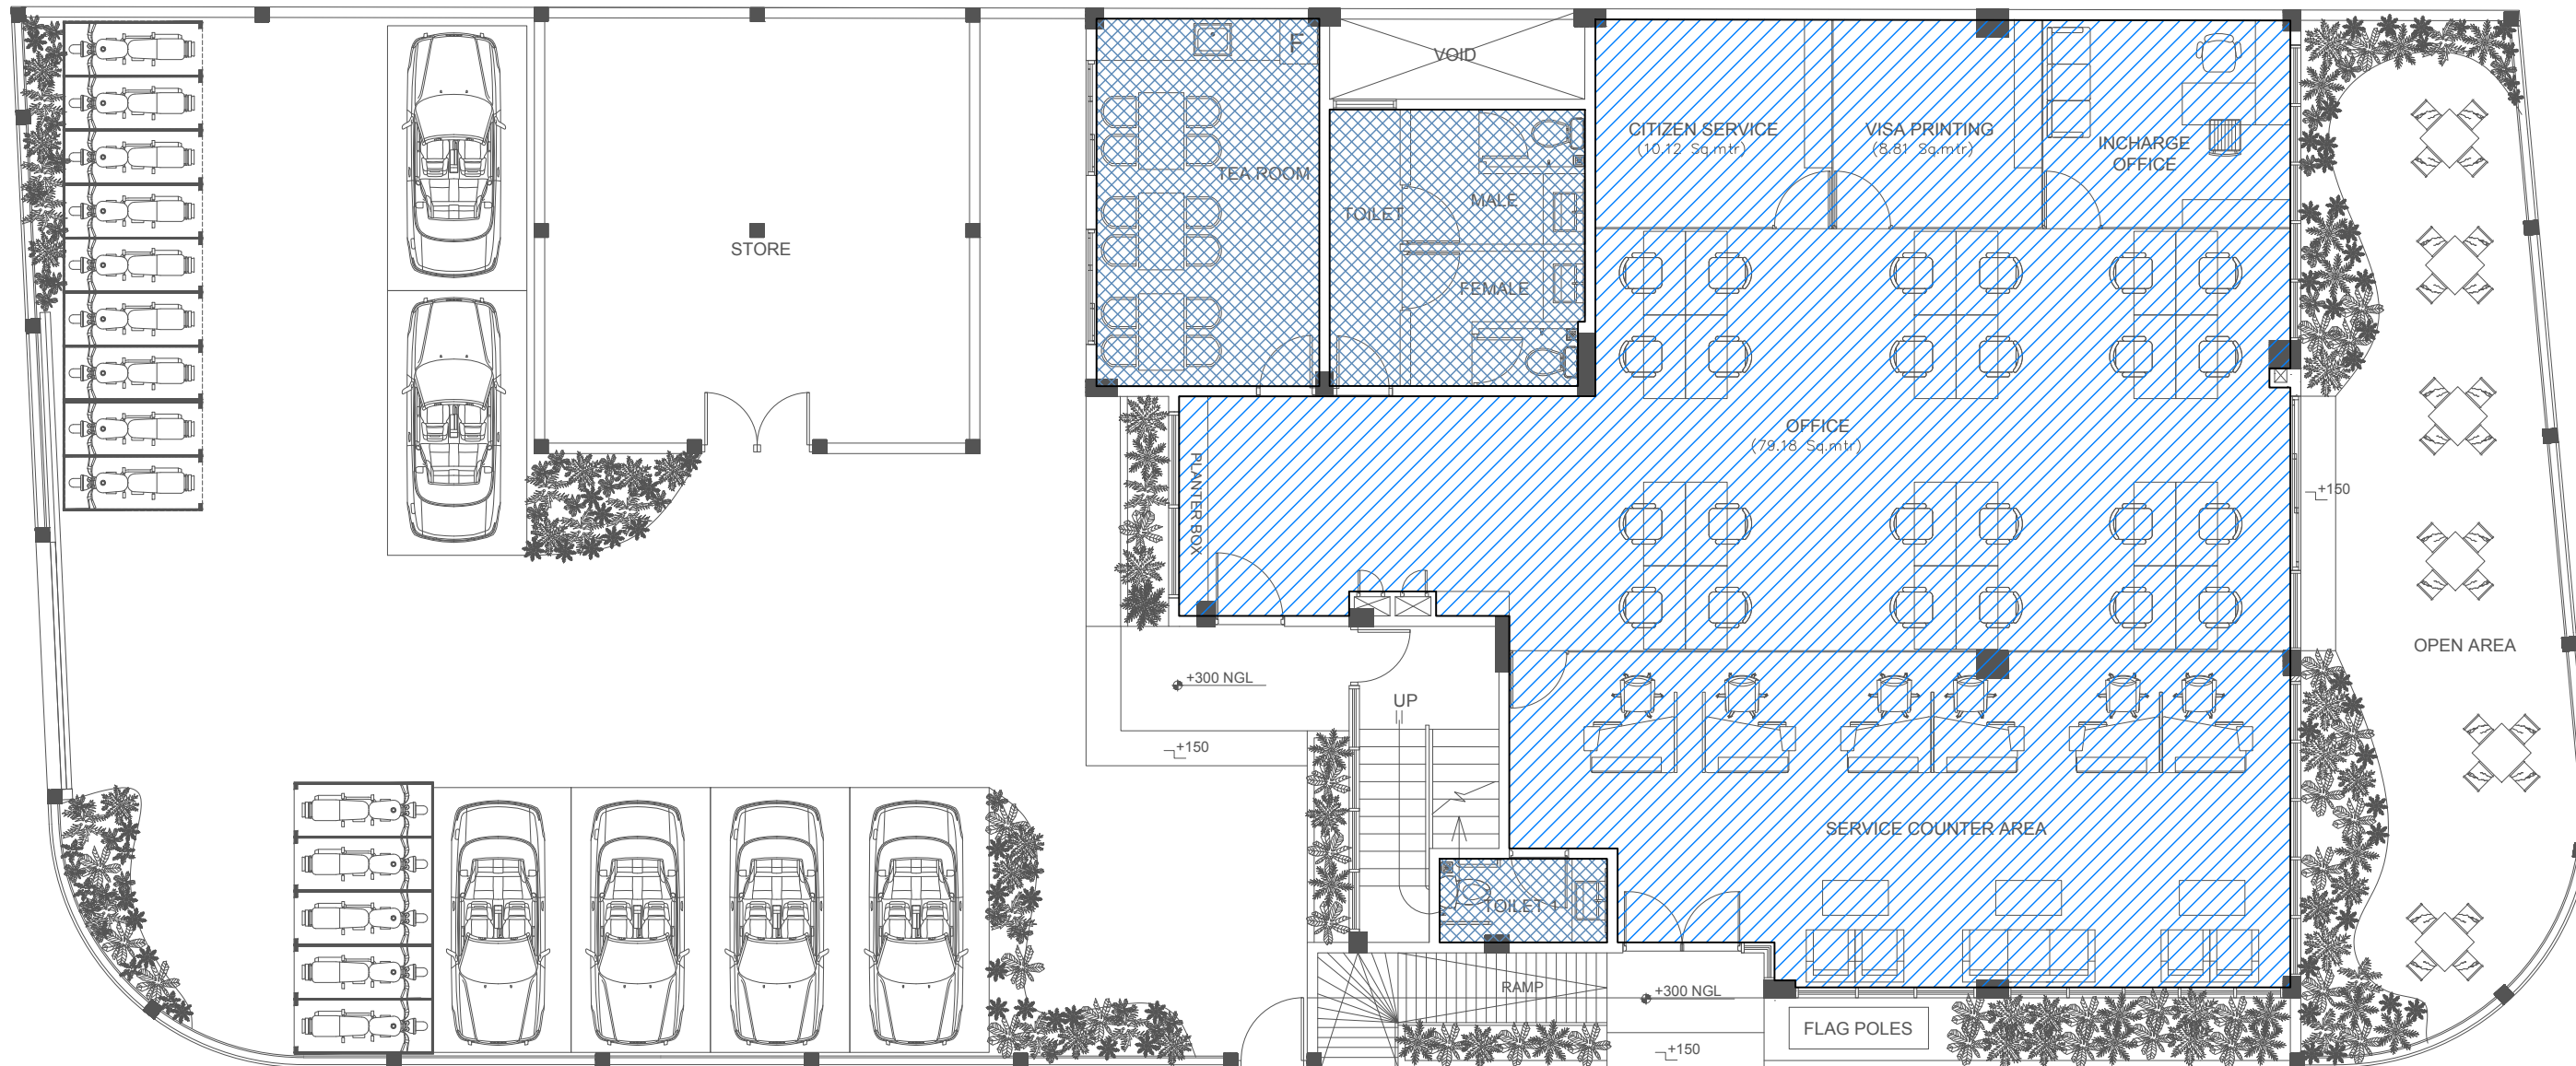

LEGENDS:



BORL CEILING



CEMENT BOARD CEILING



EXPOSED SLAB

GROUND FLOOR REFLECTED CEILING LAYOUT

SCALE 1: 100

PROJECT : IMMIGRATION - S.HITHADHOO

TITLE : AS GIVEN

CLIENT : MALDIVES IMMIGRATION

DRAWN BY:

ALI ZAMYR

ARCHITECT:

ALI ZAMYR

ENGINEER:

AHMED ZUHAL ZAEEM

DATE

AUGUST 2021


SCALE

AS GIVEN

PROJECT No

AM-D/2021/06

IF IN DOUBT - ASK - DO NOT SCALE

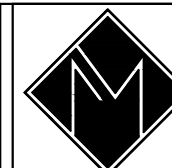


ARCHIMALDIVES
PRIVATE LIMITED

M.MISRU GANDHAKOALHIGE, 5TH FLOOR, SHAARIU VARUDHEE, MALE
TEL: (960) 7947733, (960) 7991269, Email: archimaldives@gmail.com

PAGE NO.

MEP - 29

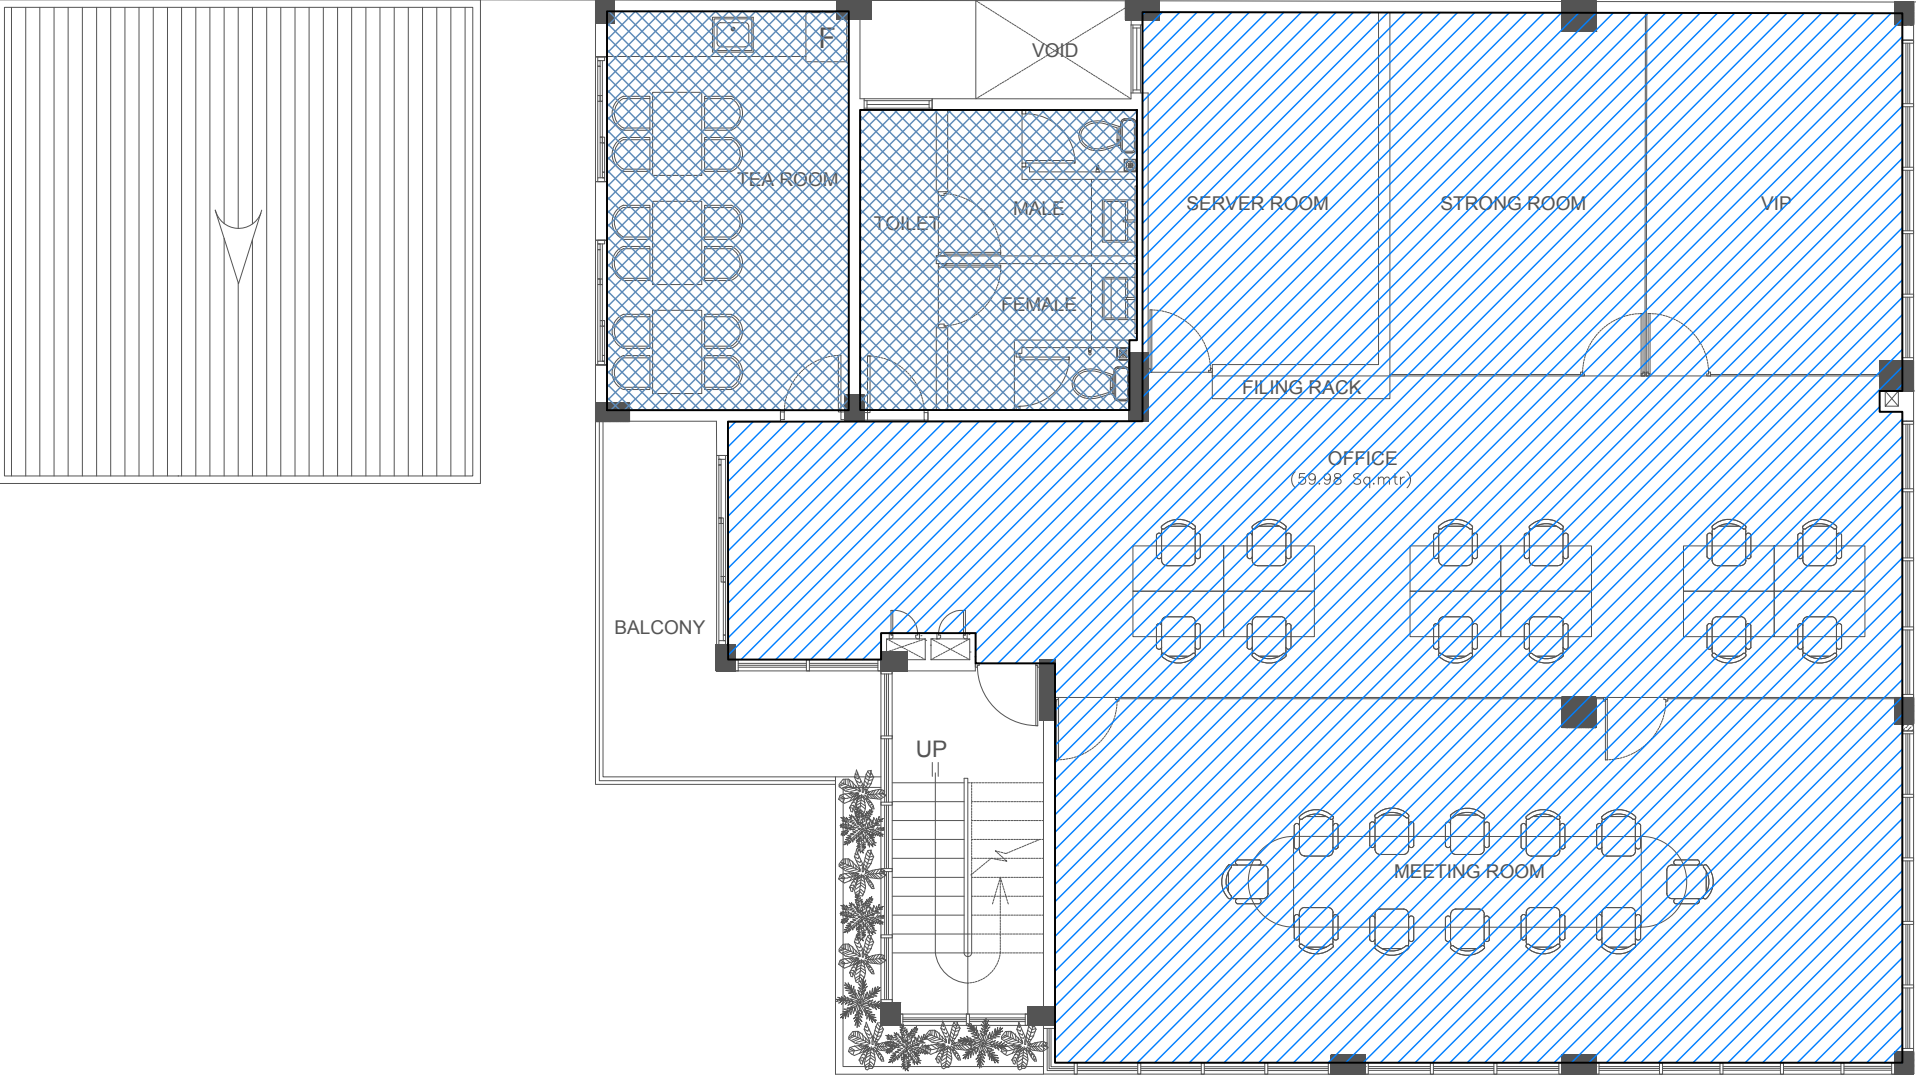

LEGENDS:



BORAL CEILING



CEMENT BOARD CEILING



EXPOSED SLAB

FIRST FLOOR REFLECTED CEILING LAYOUT
SCALE 1: 100

| | | |
|-----------|----------|----------------------|
| PROJECT : | TITLE : | AS GIVEN |
| | CLIENT : | MALDIVES IMMIGRATION |

| | |
|-----------|----------------------------------|
| DRAWN BY: | ALI ZAMYR |
| | ARCHITECT: |
| ENGINEER: | AHMED ZUHAL ZAEEM |
| | IF IN DOUBT - ASK - DO NOT SCALE |


| | |
|------------|--------------|
| DATE | AUGUST 2021 |
| SCALE | AS GIVEN |
| PROJECT No | AM-D/2021/06 |



ARCHIMALDIVES
PRIVATE LIMITED

M.MISRU GANDHAKOALHIGE, 5TH FLOOR,SHAARIU VARUDHEE, MALE'
TEL: (960) 7947733, (960) 7991269, Email: archimaldives@gmail.com

| |
|----------|
| PAGE NO. |
| MEP - 30 |

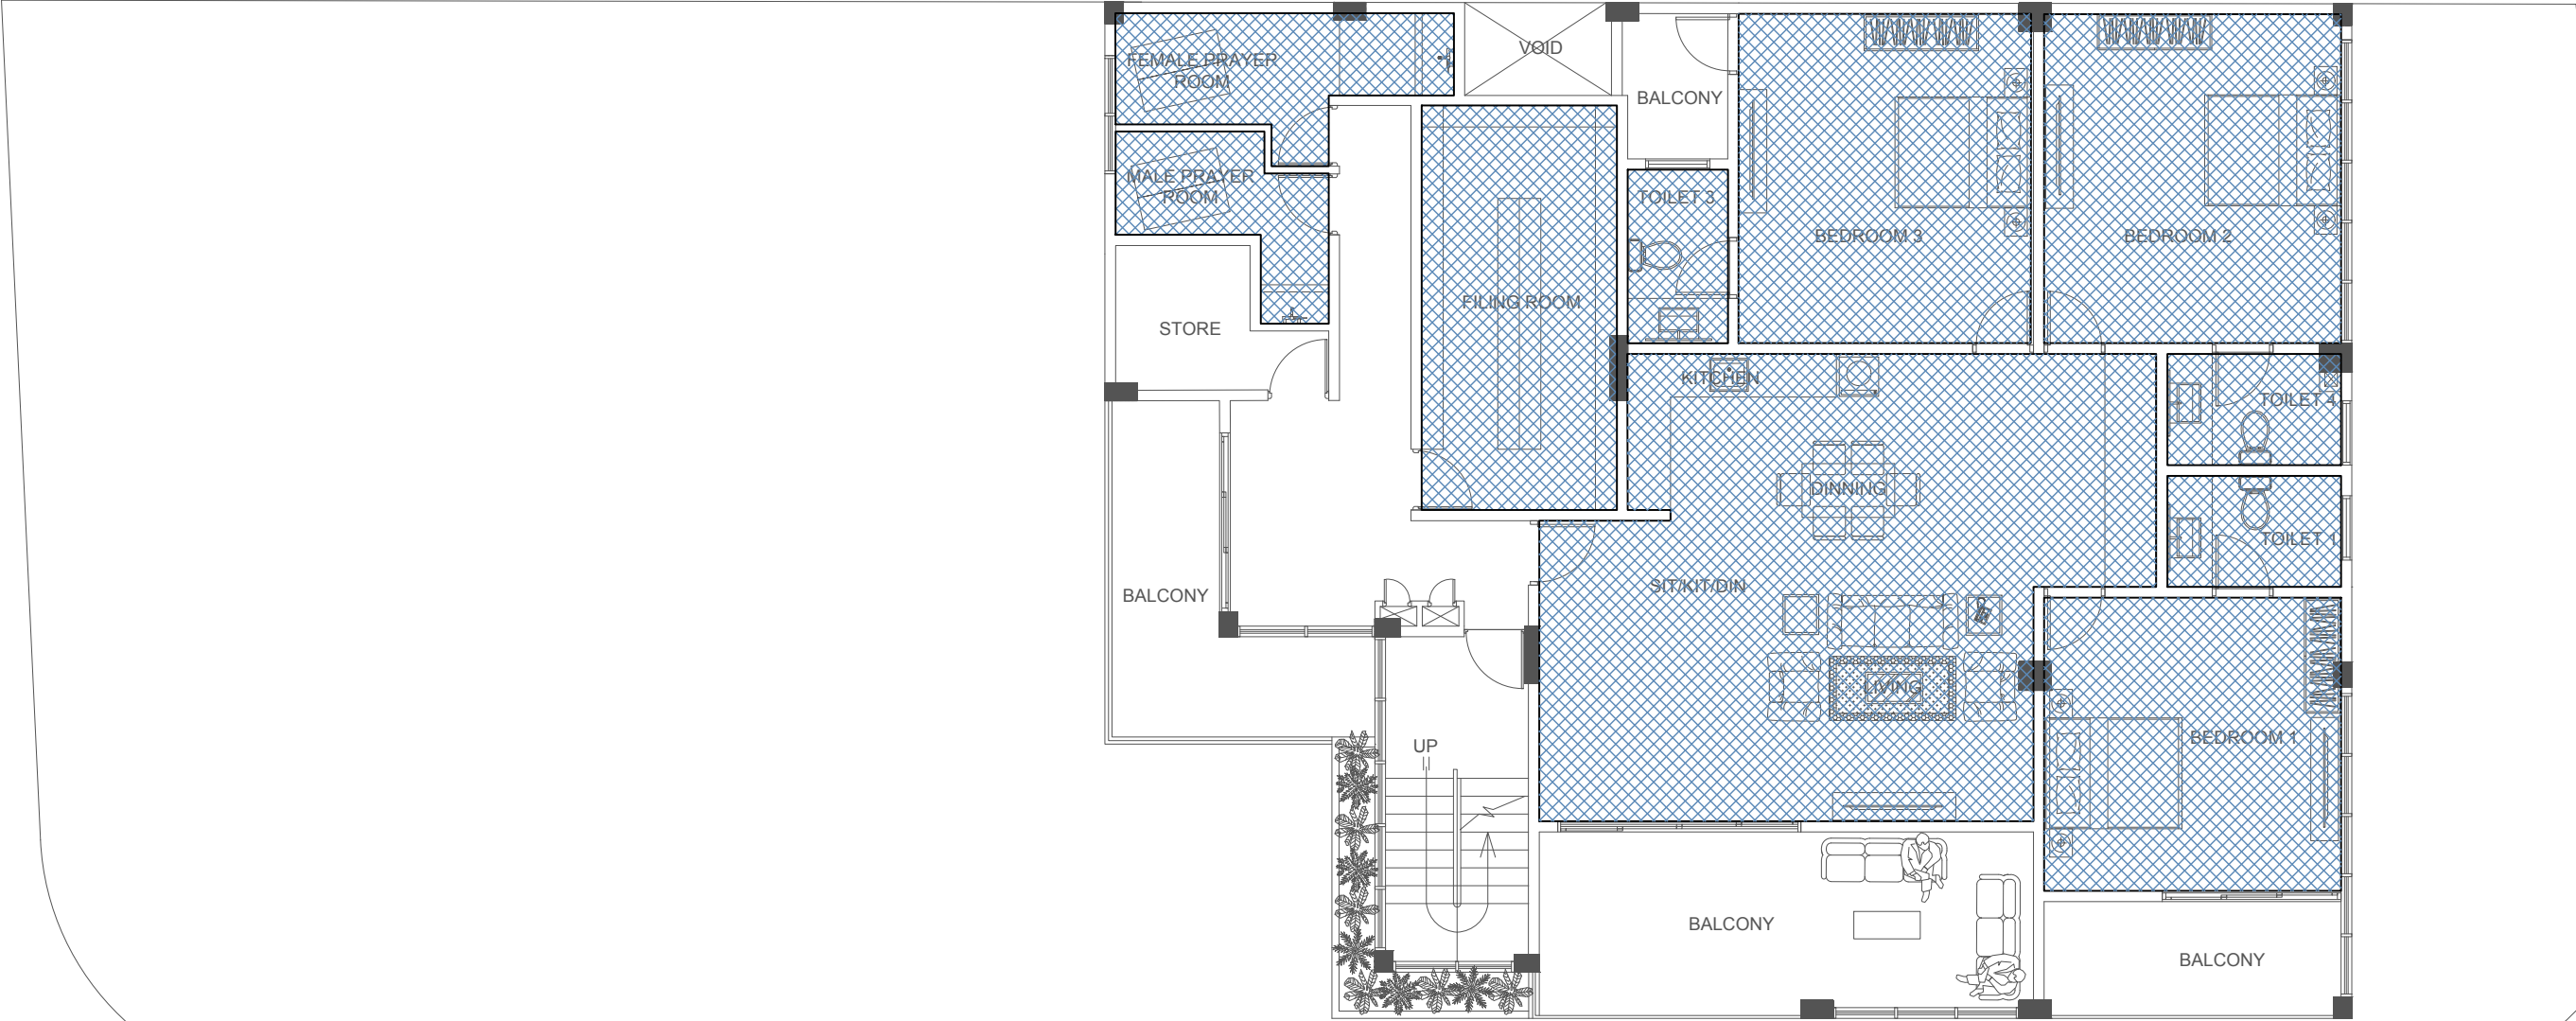

LEGENDS:



BORAL CEILING



CEMENT BOARD CEILING



EXPOSED SLAB

SECOND FLOOR REFLECTED CEILING LAYOUT
SCALE 1: 100

| | |
|-----------|----------------------------------|
| PROJECT : | <u>IMMIGRATION - S.HITHADHOO</u> |
|-----------|----------------------------------|

| | |
|----------|----------------------|
| TITLE : | AS GIVEN |
| CLIENT : | MALDIVES IMMIGRATION |

| | | | |
|----------------------------------|-------------------|------------|--------------|
| DRAWN BY: | ALI ZAMYR | DATE | AUGUST 2021 |
| ARCHITECT: | ALI ZAMYR | SCALE | AS GIVEN |
| ENGINEER: | AHMED ZUHAL ZAEEM | PROJECT No | AM-D/2021/06 |
| IF IN DOUBT - ASK - DO NOT SCALE | | | |



ARCHIMALDIVES
PRIVATE LIMITED

M.MISRU GANDHAKOALHIGE, 5TH FLOOR, SHAARIU VARUDHEE, MALE
TEL: (960) 7947733, (960) 7991269, Email: archimaldives@gmail.com

| |
|----------|
| PAGE NO. |
| MEP - 31 |

