



# PROPOSED SINGLE STOREY COUNCIL OFFICE FOR NOOMARAA ISLAND, SHAVIYANI ATOLL

CLIENT:  
OFFICE FOR PROGRAMMES AND PROJECTS  
REPUBLIC OF MALDIVES

Design by:

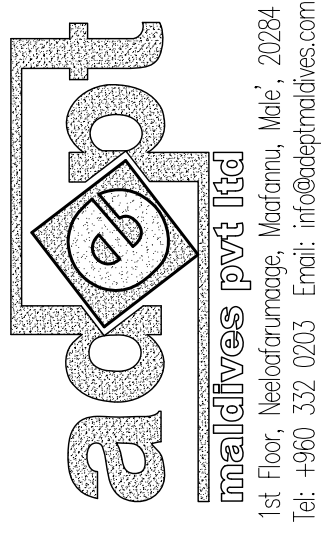

NOVEMBER 2013

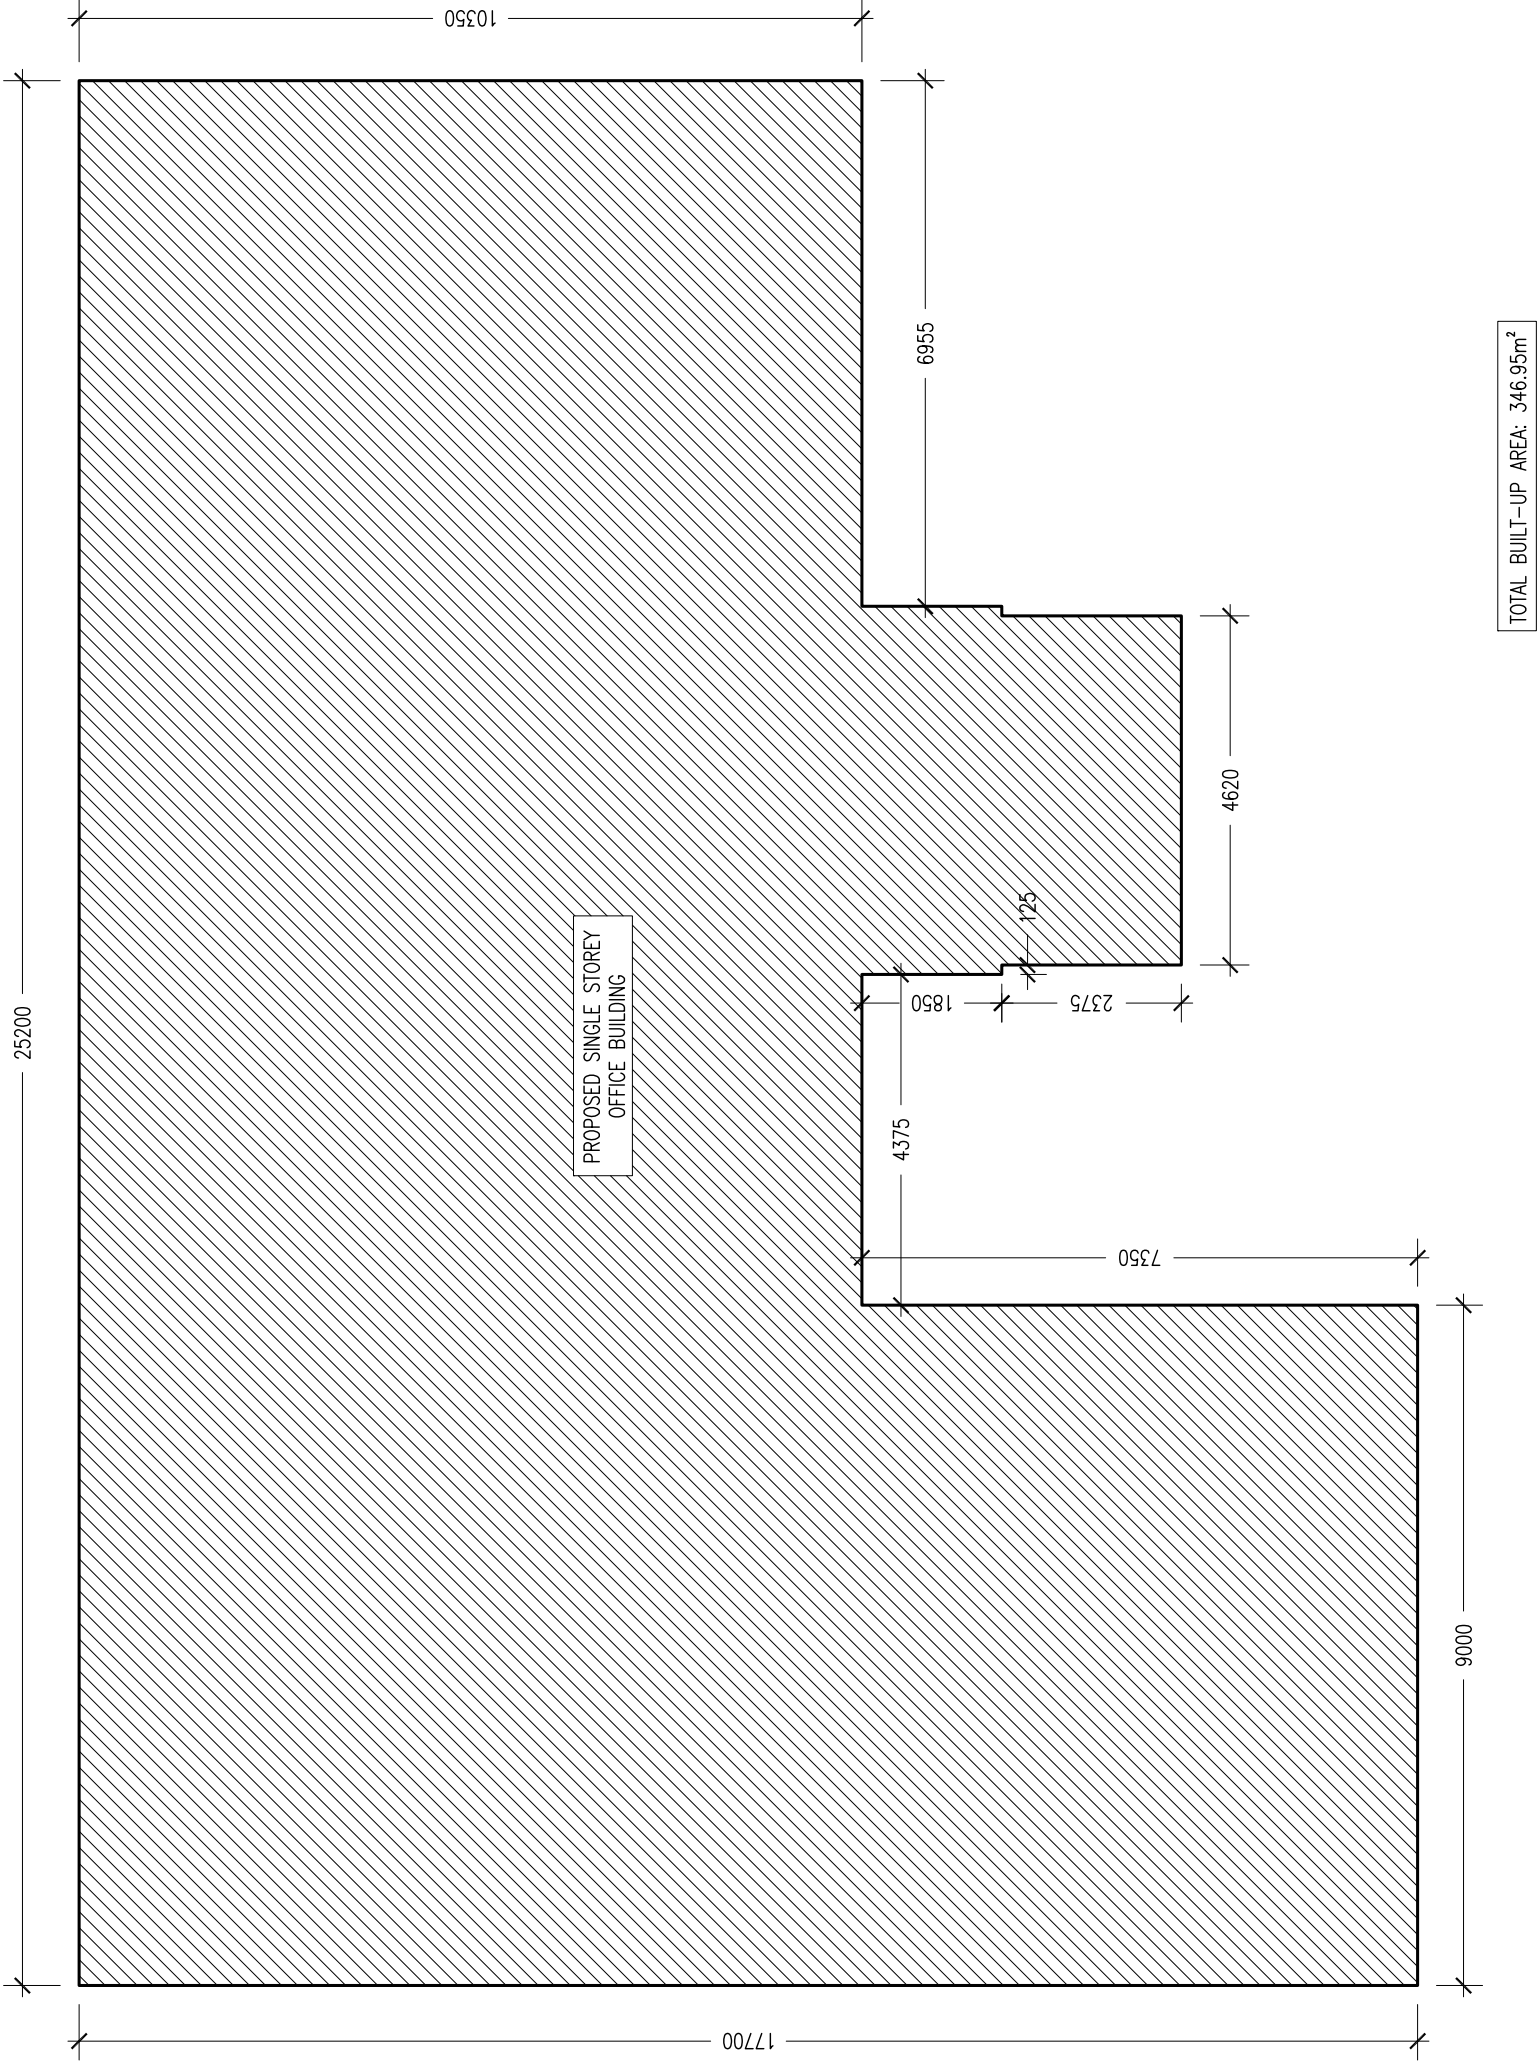

SITE PLAN

SCALE 1:100

CONTRACTORS MUST CHECK ALL DIMENSIONS ON SITE BEFORE STARTING ANY WORK OR SHOP DRAWINGS. FIGURED DIMENSIONS TO TAKE PRECEDENCE OVER SCALE READINGS.  
DO NOT SCALE DRAWINGS. IN CASE DOUBT, PLEASE ASK.



REVISION:

ARCHITECT:	ABDUL WAHID MOHAMED
ENGINEER:	ABDULLA RAMEEZ
SERVICES ENG.:	MOHAMED NASHEED
ESTIMATOR:	HASSAN NIHAD
DRAWN BY:	ABDUL WAHID MOAHEMD

ARCHITECTURAL DEEIGN | STRUCTURAL DESIGN | COASTAL DESIGN | LAND SURVEYING | PROJECT MANAGEMENT | URBAN PLANNING | MANAGEMENT CONSULTANCY


PROJECT:	COUNCIL IDHARAA FOR SH. NOONARAA ISLAND		
LOCATION:	SHAVYANI ATOLL, REPUBLIC OF MALDIVES		
DWG TITLE:	AS GIVEN		
CLIENT:	OFFICE FOR PROGRAMMES AND PROJECTS (OPP)		
SCALE:	AS GIVEN	DIMENSION: mm	DATE: 01st AUGUST 2013

A-01

DWG NO.:


PROJECT NO: AM-2013-00

CONCEPT AND DESIGN IN THIS DRAWING ARE THE PROPERTIES OF ADEPT MALDIVES PRIVATE LIMITED. UNAUTHORISED USE OR REPRODUCTION OF WHOLE OR PART OF THE CONCEPT, DESIGN OR DRAWINGS TO USE IN ANY OTHER PROJECTS OR SITES OTHER THAN SPECIFIED ON THIS DRAWING IS PROHIBITED.

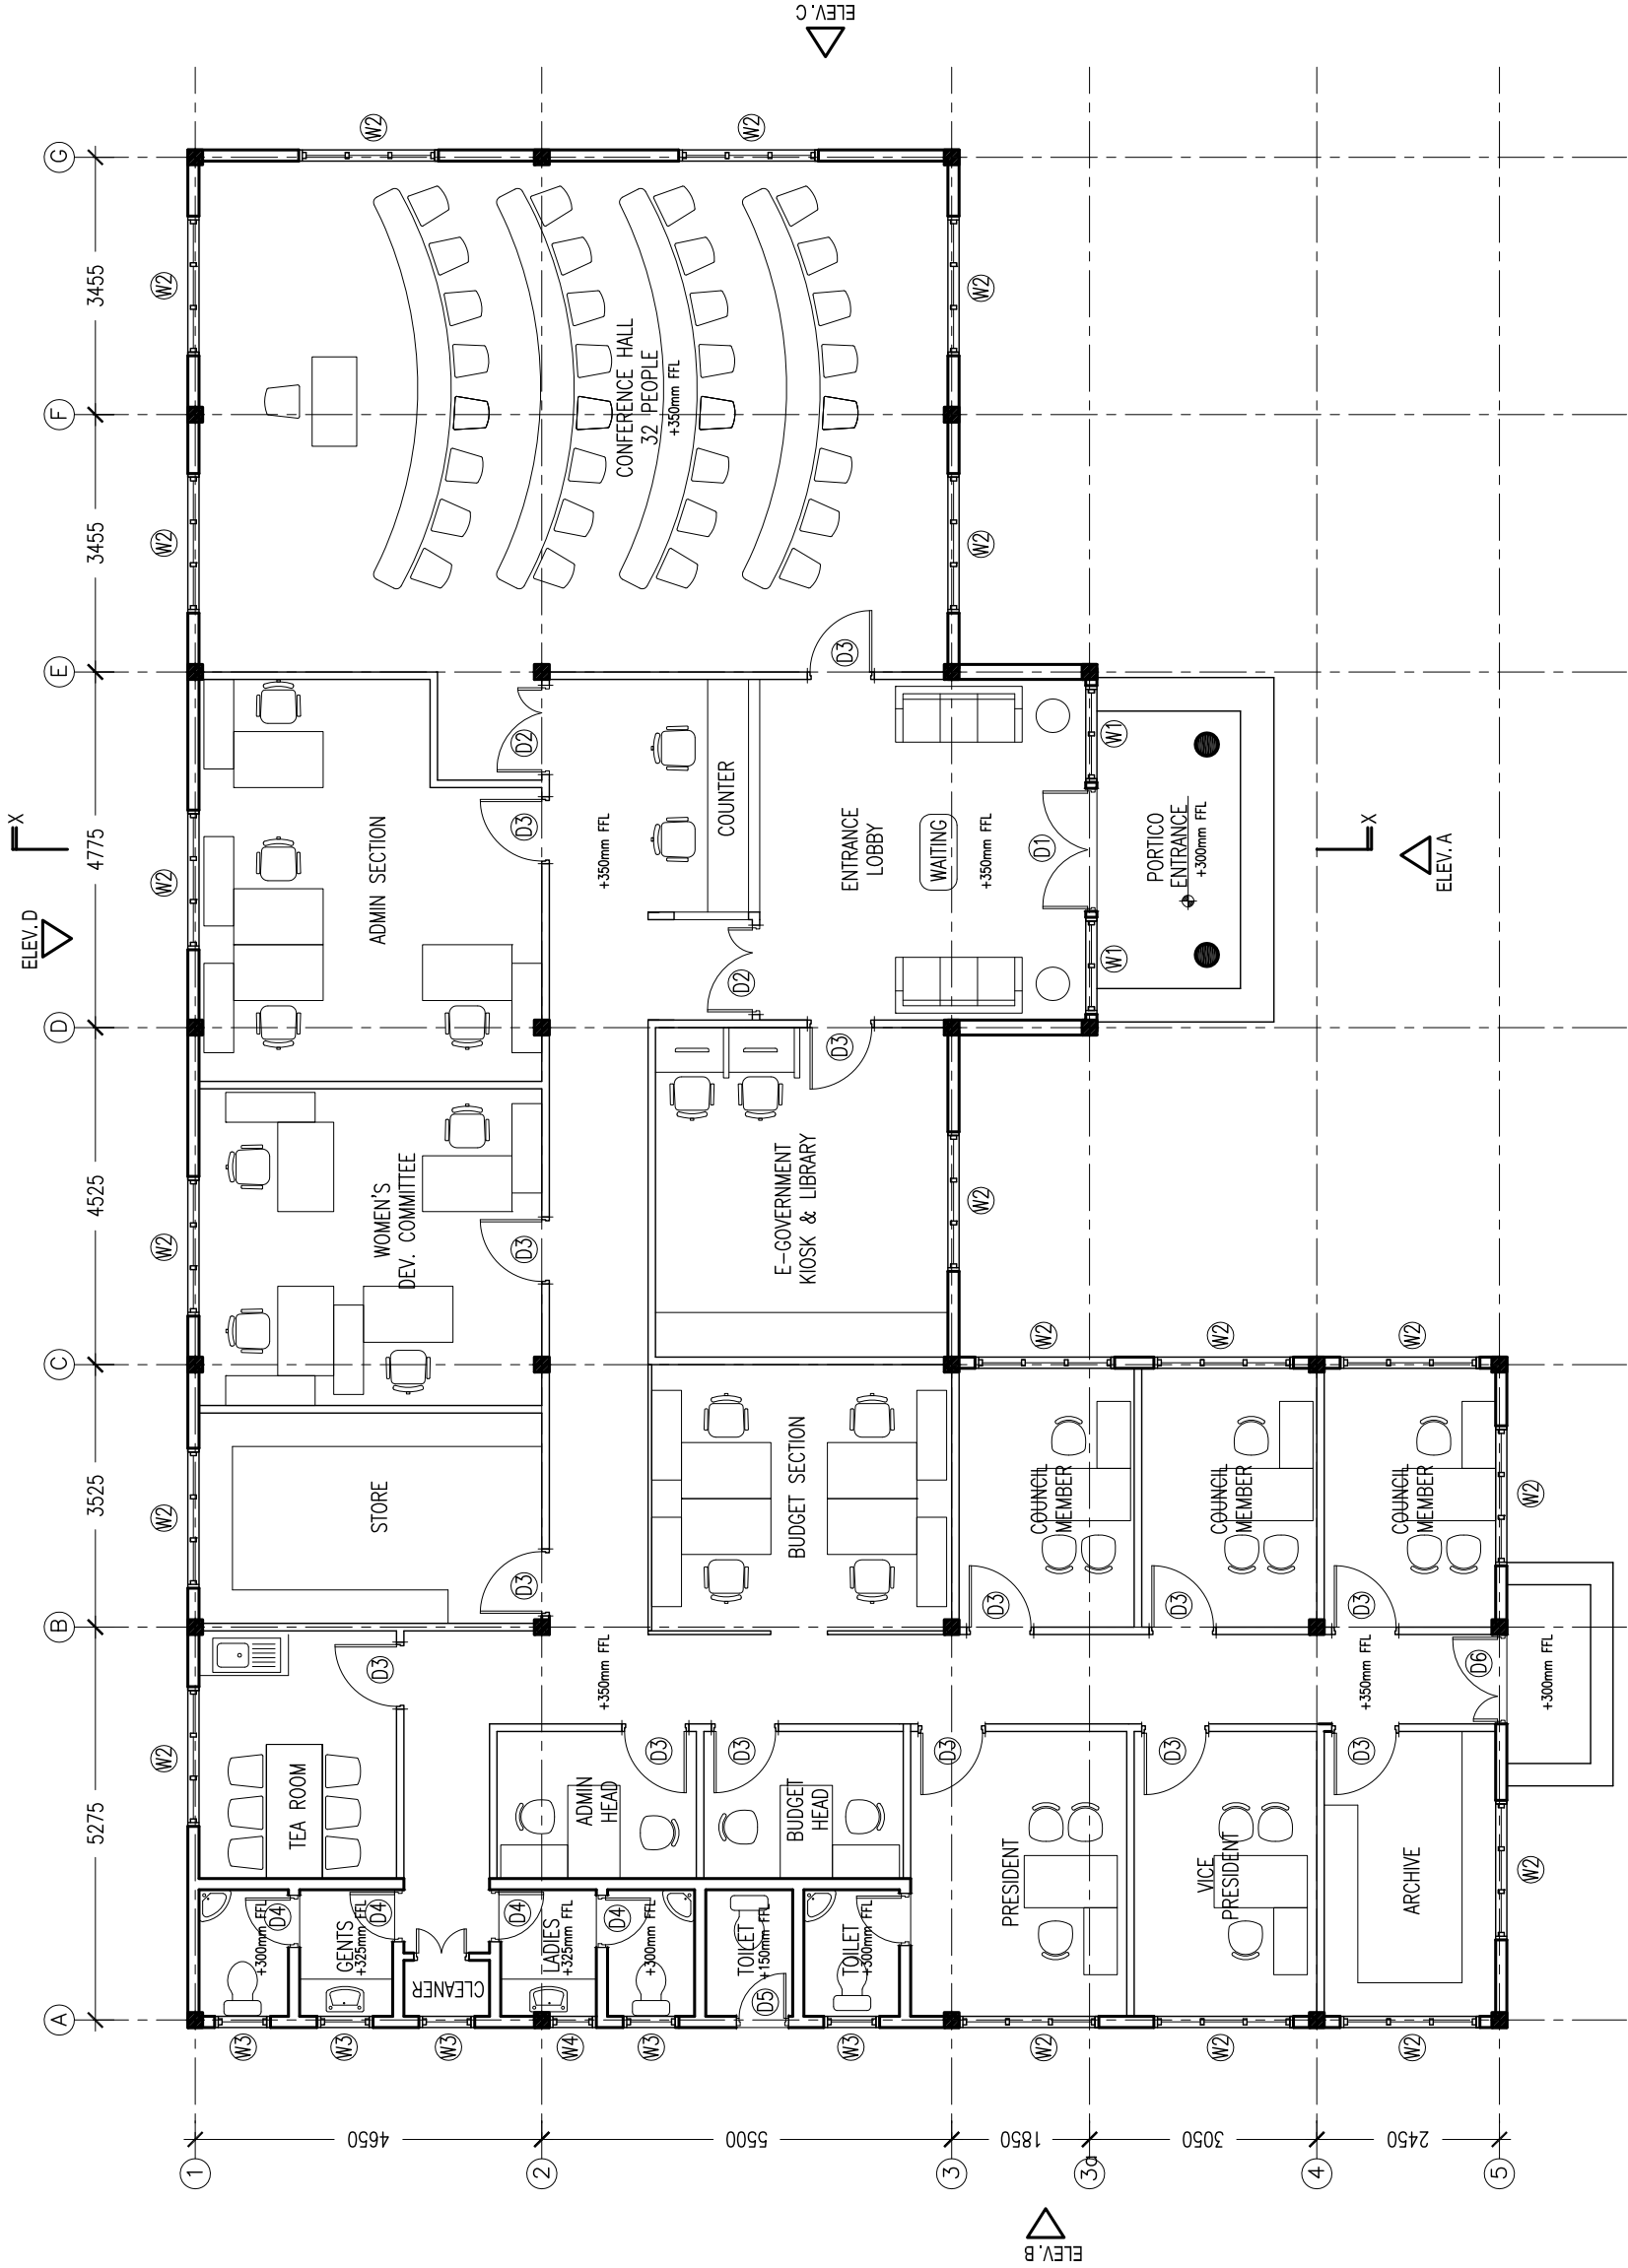

FLOOR PLAN  
SCALE 1:100

CONTRACTORS MUST CHECK ALL DIMENSIONS ON SITE BEFORE STARTING ANY WORK OR SHOP DRAWINGS. FIGURED DIMENSIONS TO TAKE PRECEDENCE OVER SCALE READINGS.  
DO NOT SCALE DRAWINGS. IN CASE DOUBT, PLEASE ASK.

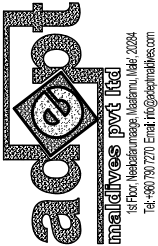

REVISION:

ARCHITECT:	ABDUL WAHID MOHAMED
ENGINEER:	ABDULLA RAMEEZ
SERVICES ENG.:	MOHAMED NASHEED
ESTIMATOR:	HASSAN NIHAD
DRAWN BY:	ABDUL WAHID MOAHEMD


CONCEPT AND DESIGN IN THIS DRAWING ARE THE PROPERTIES OF ADEPT MALDIVES PRIVATE LIMITED. UNAUTHORISED USE OR REPRODUCTION OF WHOLE OR PART OF THE CONCEPT, DESIGN OR DRAWINGS TO USE IN ANY OTHER PROJECTS OR SITES OTHER THAN SPECIFIED ON THIS DRAWING IS PROHIBITED.

PROJECT:	COUNCIL IDHAARAA FOR SH. NOONARAA ISLAND
LOCATION:	SHAVIYANI ATOLL, REPUBLIC OF MALDIVES
DWG TITLE.:	AS GIVEN
CLIENT:	OFFICE FOR PROGRAMMES AND PROJECTS (OPP)
SCALE:	AS GIVEN
DIMENSION:	mm
DATE:	01st AUGUST 2013

A-02

DWG NO.:

PROJECT NO: AM-2013-00

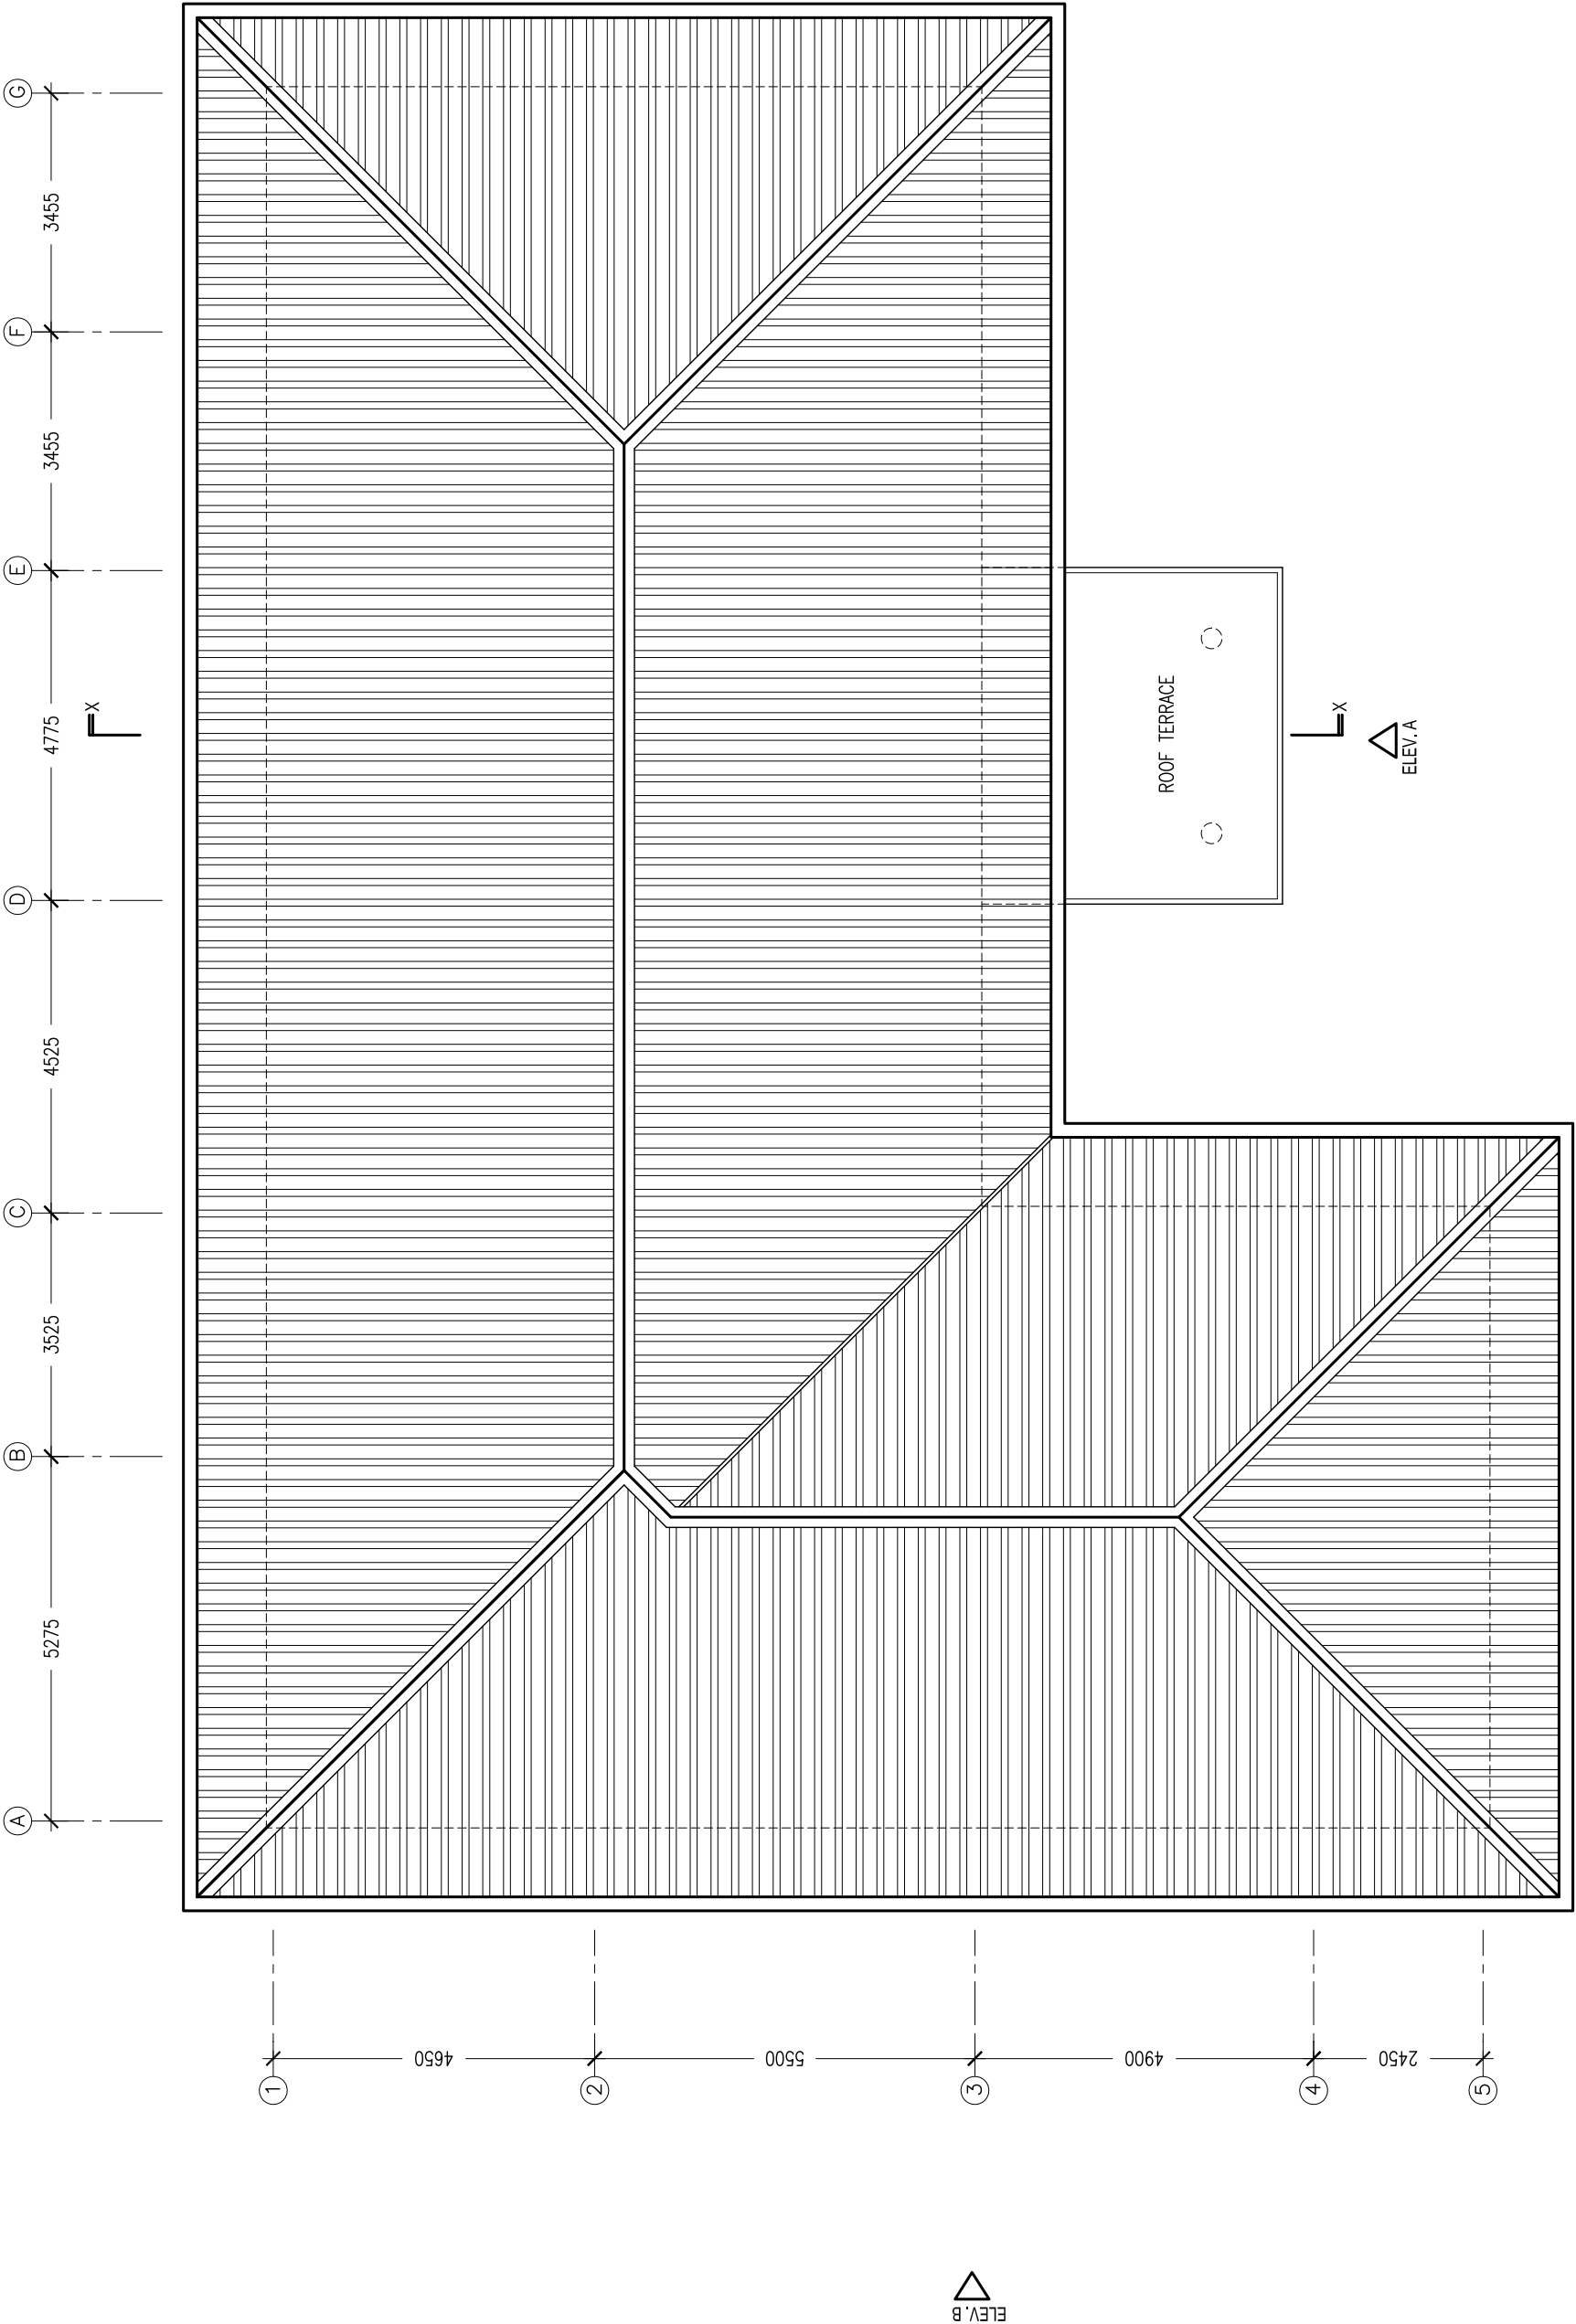

ROOF PLAN  
SCALE 1:100

CONTRACTORS MUST CHECK ALL DIMENSIONS ON SITE BEFORE STARTING ANY WORK OR SHOP DRAWINGS. FIGURED DIMENSIONS TO TAKE PRECEDENCE OVER SCALE READINGS.  
DO NOT SCALE DRAWINGS. IN CASE DOUBT, PLEASE ASK.




REVISION:

ARCHITECT:	ABDUL WAHID MOHAMED
ENGINEER:	ABDULLA RAMEEZ
SERVICES ENG.:	MOHAMED NASHEED
ESTIMATOR:	HASSAN NIHAD
DRAWN BY:	ABDUL WAHID MOAHEMD
CONCEPT AND DESIGN IN THIS DRAWING ARE THE PROPERTIES OF ADEPT MALDIVES PRIVATE LIMITED. UNAUTHORISED USE OR REPRODUCTION OF WHOLE OR PART OF THE CONCEPT, DESIGN OR DRAWINGS TO USE IN ANY OTHER PROJECTS OR SITES OTHER THAN SPECIFIED ON THIS DRAWING IS PROHIBITED.	


PROJECT:	COUNCIL IDHAARAA FOR SH. NOONARAA ISLAND				
LOCATION:	SHAVIVANI ATOLL, REPUBLIC OF MALDIVES				
DWG TITLE:	AS GIVEN				
CLIENT:	OFFICE FOR PROGRAMMES AND PROJECTS (OPP)				
SCALE:	AS GIVEN	DIMENSION:	mm	DATE:	01st AUGUST 2013
PROJECT NO: AM-2013-00					
DWG NO.: <b>A-03</b>					

USED USE OR REPRODUCTION OF WHOLE OR PART OF THE CONCEPT DESIGN OR DRAWINGS TO USE IN ANY OTHER PROJECTS OR SITES OTHER THAN SPECIFIED ON THIS DRAWING IS PROHIBITED.

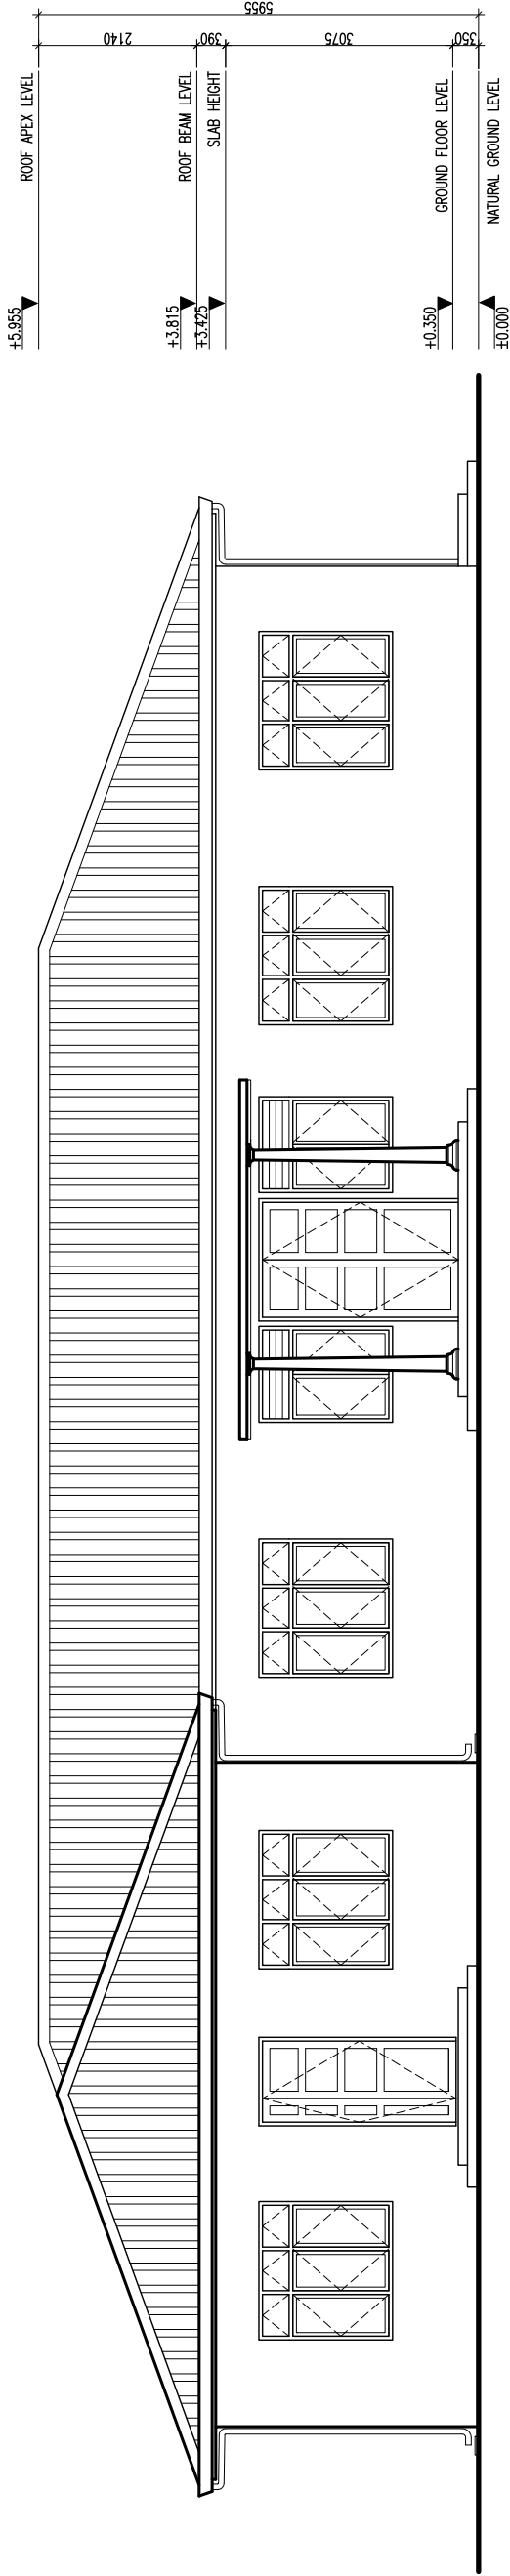

ELEVATION - A

SCALE 1:100

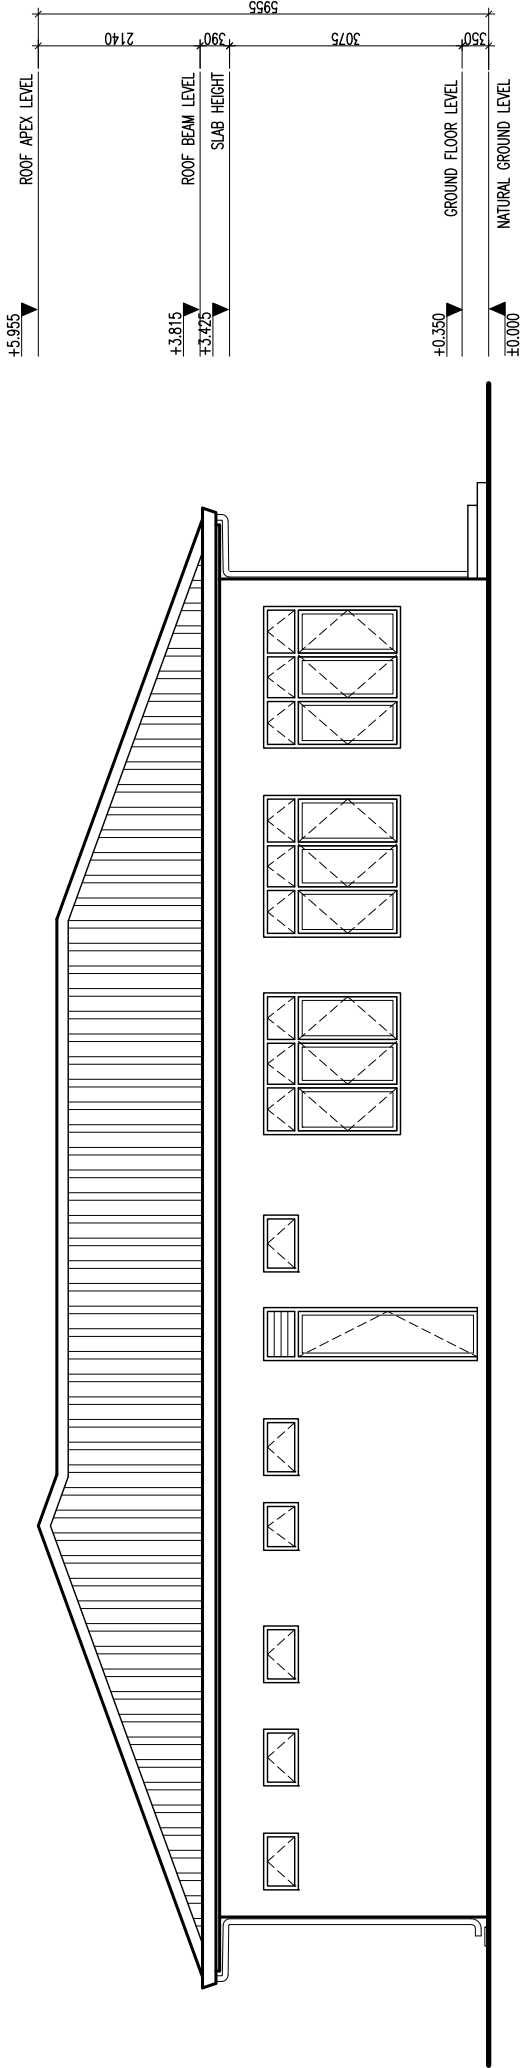

ELEVATION - B

SCALE 1:100

CONTRACTORS MUST CHECK ALL DIMENSIONS ON SITE BEFORE STARTING ANY WORK OR SHOP DRAWINGS. FIGURED DIMENSIONS TO TAKE PRECEDENCE OVER SCALE READINGS. DO NOT SCALE DRAWINGS. IN CASE DOUBT, PLEASE ASK.



REVISION:


ARCHITECT:	ABDUL WAHID MOHAMED
ENGINEER:	ABDULLA RAMEEZ
SERVICES ENG.:	MOHAMED NASHEED
ESTIMATOR:	HASSAN NIHAD
DRAWN BY:	ABDUL WAHID MOHAHEMD

ARCHITECTURAL DESIGN | STRUCTURAL DESIGN | COASTAL DESIGN | COST ESTIMATION | LAND SURVEYING | PROJECT MANAGEMENT | URBAN PLANNING | MANAGEMENT CONSULTANCY

PROJECT:	COUNCIL IDHAARAA FOR SH. NOONARAA ISLAND
LOCATION:	SHAVIYANI ATOLL, REPUBLIC OF MALDIVES
DWG TITLE.:	AS GIVEN
CLIENT:	OFFICE FOR PROGRAMMES AND PROJECTS (OPP)
SCALE:	AS GIVEN
DIMENSION:	mm
DATE:	01st AUGUST 2013


A-04

DWG NO.:
PROJECT NO: AM-2013-00

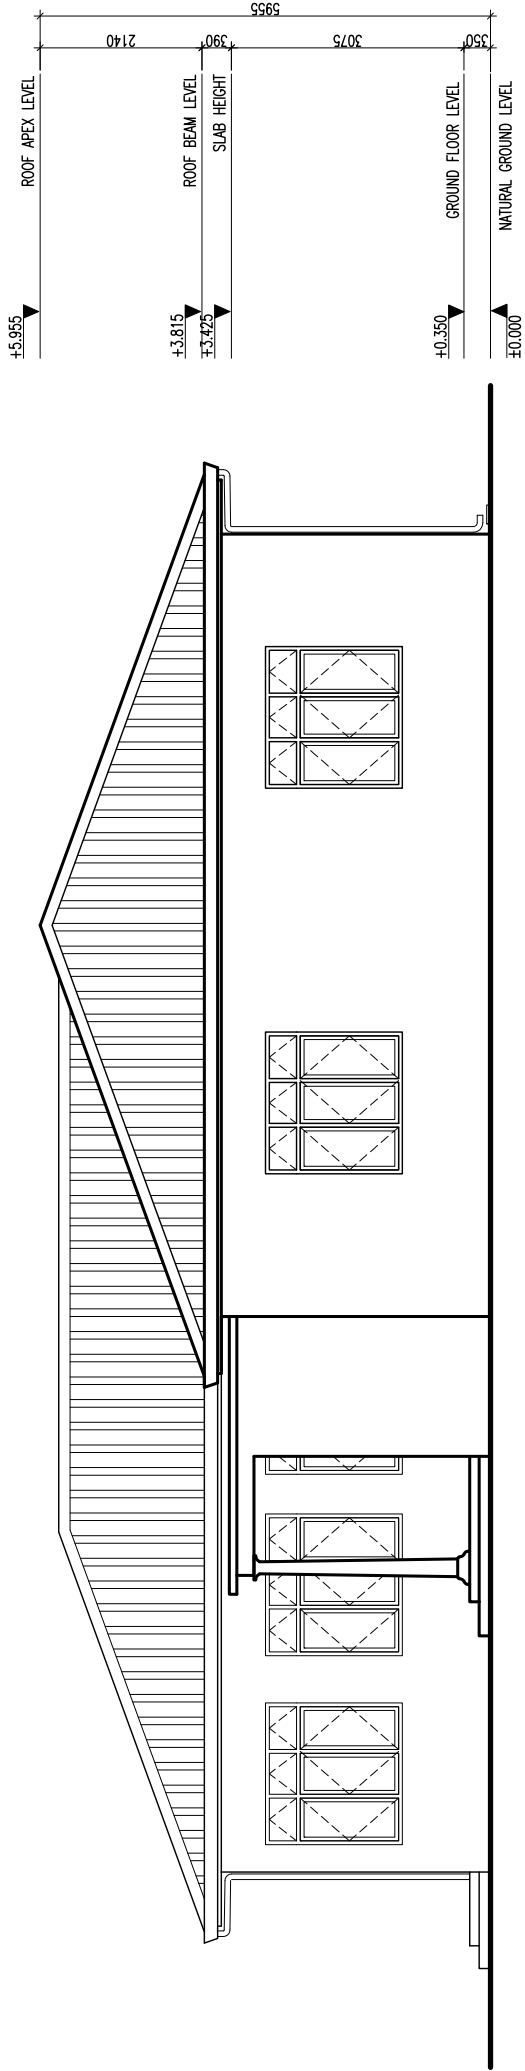

ELEVATION - C

SCALE 1:100

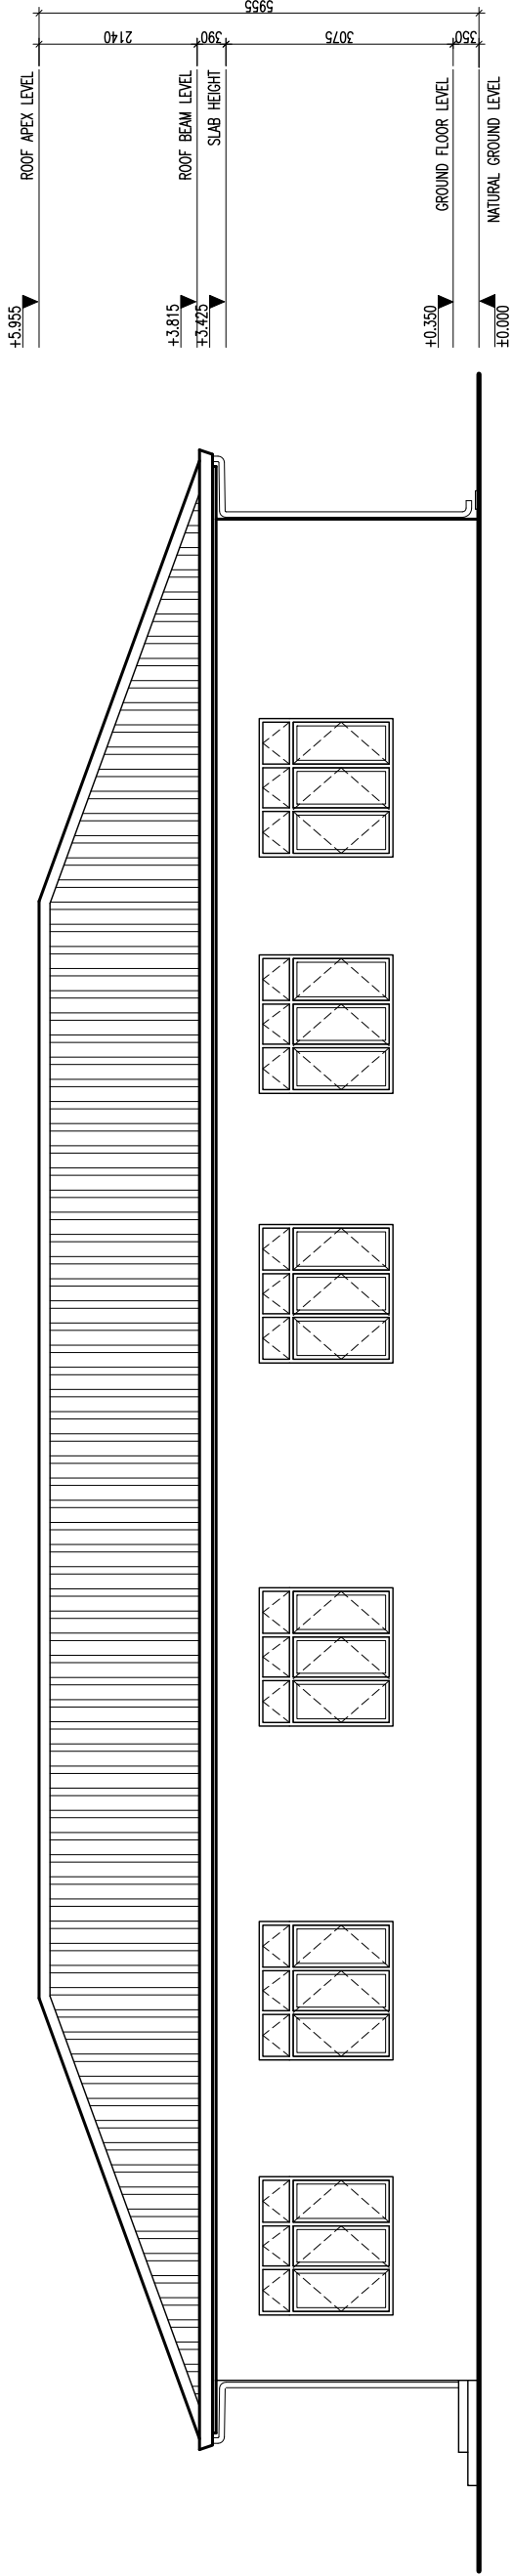

ELEVATION - D

SCALE 1:100

CONTRACTORS MUST CHECK ALL DIMENSIONS ON SITE BEFORE STARTING ANY WORK OR SHOP DRAWINGS. FIGURED DIMENSIONS TO TAKE PRECEDENCE OVER SCALE READINGS. DO NOT SCALE DRAWINGS, IN CASE DOUBT, PLEASE ASK.




REVISION:	ARCHITECT:	ABDUL WAHID MOHAMED
	ENGINEER:	ABDULLA RAMEEZ
	SERVICES ENG.:	MOHAMED NASHEED
	ESTIMATOR:	HASSAN NIHAD
	DRAWN BY:	ABDUL WAHID MOAHEMD
CONCEPT AND DESIGN IN THIS DRAWING ARE THE PROPERTIES OF ADEPT MALDIVES PRIVATE LIMITED. UNAUTHORISED USE OR REPRODUCTION OF WHOLE OR PART OF THE CONCEPT, DESIGN OR DRAWINGS TO USE IN ANY OTHER PROJECTS OR SITES OTHER THAN SPECIFIED ON THIS DRAWING IS PROHIBITED.		

PROJECT:	COUNCIL IDHAARAA FOR SH. NOONARAA ISLAND
LOCATION:	SHAVIYANI ATOLL, REPUBLIC OF MALDIVES
DWG TITLE.:	AS GIVEN
CLIENT:	OFFICE FOR PROGRAMMES AND PROJECTS (OPP)
SCALE:	AS GIVEN
DIMENSION:	mm
DATE:	01st AUGUST 2013
DWG NO.:	PROJECT NO: AM-2013-00

A-05

CONTRACTORS MUST CHECK ALL DIMENSIONS ON SITE BEFORE STARTING ANY WORK OR SHOP DRAWINGS. FIGURED DIMENSIONS TO TAKE PRECEDENCE OVER SCALE READINGS. DO NOT SCALE DRAWINGS. IN CASE DOUBT, PLEASE ASK.

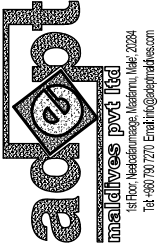

ARCHITECTURAL DESIGN | STRUCTURAL DESIGN | COASTAL DESIGN | COST ESTIMATION | LAND SURVEYING | PROJECT MANAGEMENT | URBAN PLANNING | MANAGEMENT CONSULTANCY


REVISION:

ARCHITECT:	ABDUL WAHID MOHAMED
ENGINEER:	ABDULLA RAMEEZ
SERVICES ENG.:	MOHAMED NASHEED
ESTIMATOR:	HASSAN NIHAD
DRAWN BY:	ABDUL WAHID MOAHEND

CONCEPT AND DESIGN IN THIS DRAWING ARE THE PROPERTIES OF ADEPT MALDIVES PRIVATE LIMITED. UNAUTHORISED USE OR REPRODUCTION OF WHOLE OR PART OF THE CONCEPT, DESIGN OR DRAWINGS TO USE IN ANY OTHER PROJECTS OR SITES OTHER THAN SPECIFIED ON THIS DRAWING IS PROHIBITED.









PROJECT:	COUNCIL IDHAARAA FOR SH. NOONARAA ISLAND		
LOCATION:	SHAVIYANI ATOLL, REPUBLIC OF MALDIVES		
DWG TITLE:	AS GIVEN		
CLIENT:	OFFICE FOR PROGRAMMES AND PROJECTS (OPP)		
SCALE:	AS GIVEN	DIMENSION: mm	DATE: 01st AUGUST 2013
PROJECT NO: AM-2013-00			
DWG NO.:			

A-06

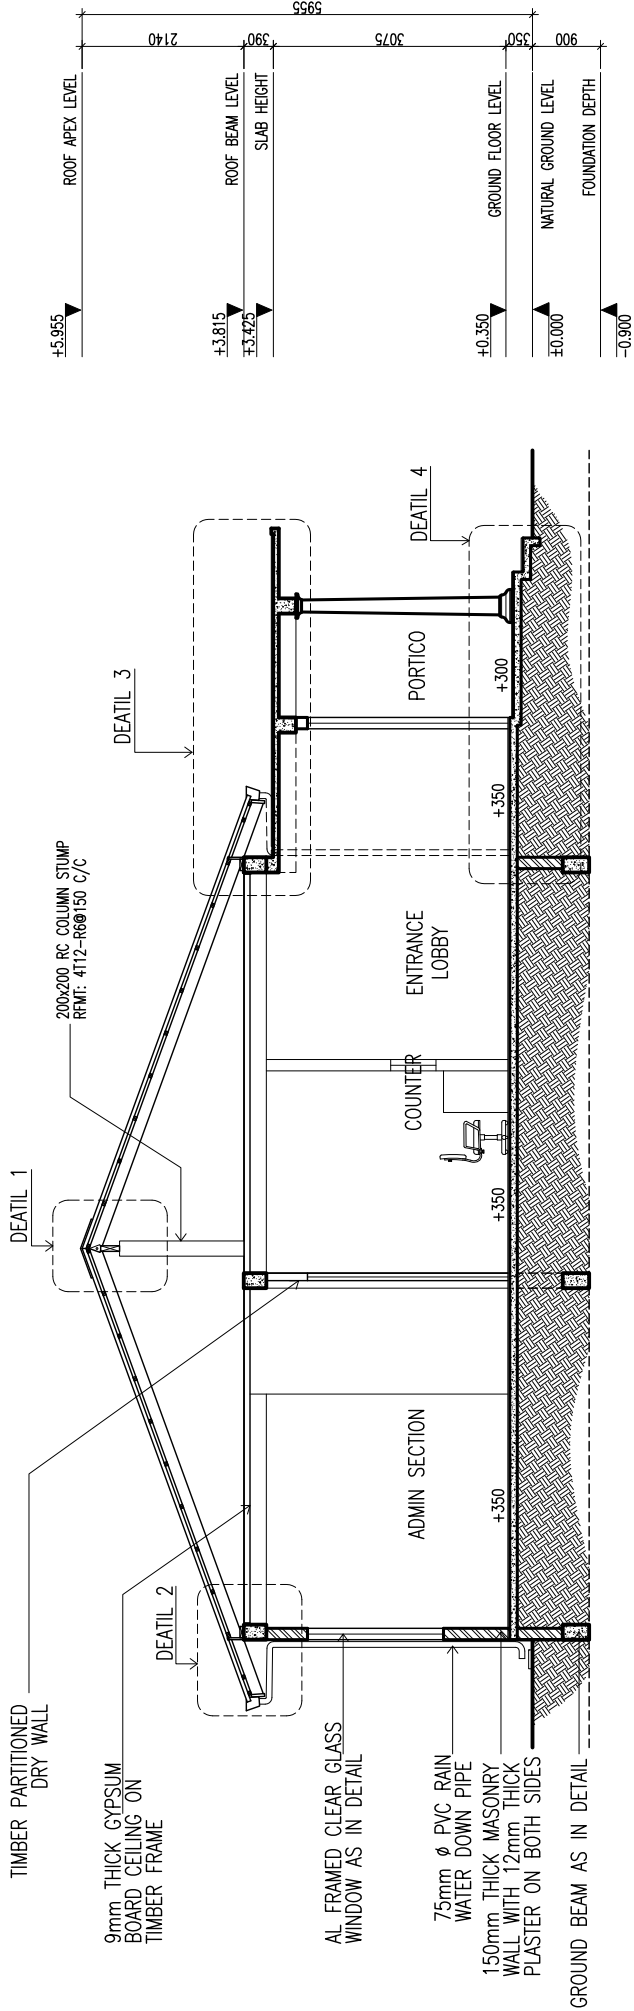

## SECTION X-X

SCALE 1:100

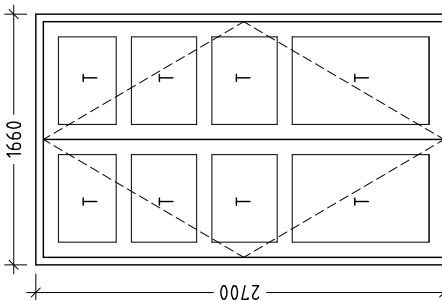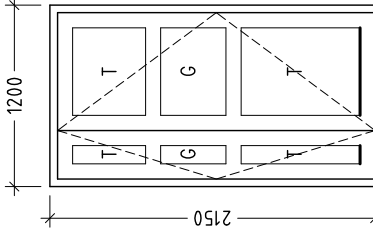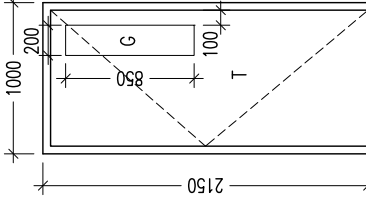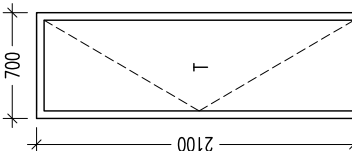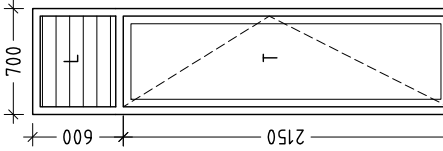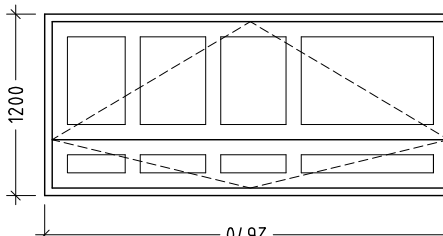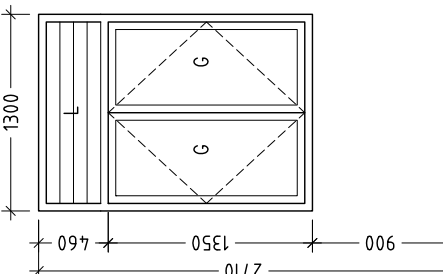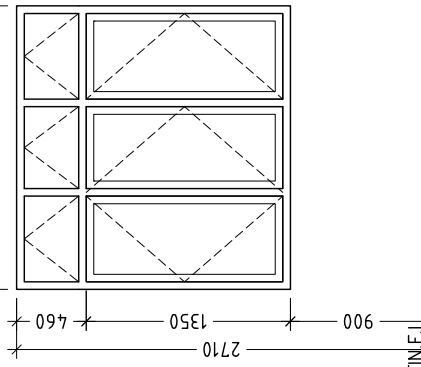															
FIN.F.L				FIN.F.L				FIN.F.L				FIN.F.L			
DOOR NO.	D1	AREA	QTY	DOOR NO.	D2	AREA	QTY	DOOR NO.	D3	AREA	QTY	DOOR NO.	D4	AREA	QTY
DOOR FRAME	Timber framed Door	4.48	-	DOOR FRAME	Timber framed Door	2.58	-	DOOR FRAME	Timber framed Door	2.15	-	DOOR FRAME	Timber framed Door	1.23	-
REMARKS	Treated timber panel			REMARKS	Clear glass fixed at mid of door panel			REMARKS	-			REMARKS	-		
															
FIN.F.L				FIN.F.L				FIN.F.L				FIN.F.L			
DOOR NO.	D5	AREA	QTY	DOOR NO.	D6	AREA	QTY	DOOR NO.	W1	AREA	QTY	DOOR NO.	W2	AREA	QTY
DOOR FRAME	Timber framed Door	1.95	-	DOOR FRAME	Aluminium frame	3.2	-	DOOR FRAME	Aluminium frame	2.35	-	DOOR FRAME	Aluminium frame	3.39	-
REMARKS	-			REMARKS	-			REMARKS	-			REMARKS	-		

GENERAL NOTES

Dimensions shown on drawings indicate effective openings of frame. All wooden frame depths are 75mm. Wooden door panel thickness = 35mm.

External units must comply the following weather conditions: –Wind pressure: 200Kg/sqm. –Water tightness: 25Kg/sqm.

All external frames/ wall joints must be sealed with silicon sealant and wedges trimmed with 12x12mm H/W beading fixed to frames by brass nails.

All hardwood shall be provided for the performance of all functions of the units.

Hinges shall conform to Door size more than 700Wx2100H WD: 125mmx2 sets SD: 150mmx3 sets Door size less than 700Wx2100H WD: 100mmx2 sets SD: 150mmx3 sets locks shall be cylindrical w/master keysets. Door knobs shall be 900mm above finished floor level.

Door swings are indicated on the floor plans.


All elevations shown from outside and window swings DEFINED on the schedule.

LEGEND:  
FG: 6mm thk. fixed glazing  
G: 6mm thk. clear glazing  
L: aluminium louvers  
T: Treated Timber

DOOR/WINDOW SCHEDULE

SCALE 1:50

CONTRACTORS MUST CHECK ALL DIMENSIONS ON SITE BEFORE STARTING ANY WORK OR SHOP DRAWINGS. FIGURED DIMENSIONS TO TAKE PRECEDENCE OVER SCALE READINGS. DO NOT SCALE DRAWINGS. IN CASE DOUBT, PLEASE ASK.



adept maldives pvt ltd  
1st Floor, Nalanda, Maldives, 11447, 2024  
Tel: +967 787 7270 Email: hq@adeptmal.com

ARCHITECTURAL DESIGN | STRUCTURAL DESIGN | COASTAL DESIGN | PROJECT MANAGEMENT | URBAN PLANNING | MANAGEMENT CONSULTANCY

REVISION:

ARCHITECT: ABDUL WAHID MOHAMED

ENGINEER: ABDULLA RAMEEZ

SERVICES ENG.: MOHAMED NASHEED

ESTIMATOR: HASSAN NIHAD

DRAWN BY: ABDUL WAHID MOAHEMD

CONCEPT AND DESIGN IN THIS DRAWING ARE THE PROPERTIES OF ADEPT MALDIVES PRIVATE LIMITED. UNAUTHORISED USE OR REPRODUCTION OF WHOLE OR PART OF THE CONCEPT, DESIGN OR DRAWINGS TO USE IN ANY OTHER PROJECTS OR SITES OTHER THAN SPECIFIED ON THIS DRAWING IS PROHIBITED.

PROJECT: COUNCIL IDHAARAA FOR SH. NOONARAA ISLAND

LOCATION: SHAVIYANI ATOLL, REPUBLIC OF MALDIVES

DWG TITLE.: AS GIVEN

CLIENT: OFFICE FOR PROGRAMMES AND PROJECTS (OPF)

SCALE: AS GIVEN

DIMENSION: mm

DATE: 01st AUGUST 2013

DWG NO.:

PROJECT NO: AM-2013-00

A-07



<div>GENERAL NOTES</div> <div>Dimensions shown on drawings indicate effective openings of frame. All wooden frame depths are 75mm. Wooden door panel thickness = 35mm.</div> <div>External units must comply the following weather conditions: –Wind pressure: 200Kg/sqm. –Water tightness: 25Kg/sqm.</div> <div>All external frames/ wall joints must be sealed with silicon sealant and wedges trimmed with 12x12mm H/W beading fixed to frames by brass nails.</div> <div>All harwood shall be provided for the performance of all functions of the units.</div> <div>Hinges shall conform to Door size more than 700Wx2100H WD: 125mmx2 sets SD: 150mmx3 sets Door size less than 700Wx2100H WD: 100mmx2 sets SD: 150mmx3 sets locks shall be cylindrical w/master keysets. Door knobs shall be 900mm above finished floor level.</div> <div>Door swings are indicated on the floor plans.</div> <div>All elevations shown from outside and window swings DEFINED on the schedule.</div>	<div>LEGEND:</div> <div>FG: 6mm thk. fixed glazing</div> <div>G: 6mm thk. clear glazing</div> <div>L: aluminium louvers</div> <div>T: Treated Timber</div>
--	--

<div><div><div><div><div><div></div></div></div><div><div><div><span></span></div><div><span></span></div></div></div><div><div><div><span></span></div><div><span></span></div></div></div><div><div><div><span></span></div></div></div></div><div><div>2710</div><div>2250</div><div>460</div></div><div><div>750</div><div>600</div></div></div></div>	<div><div><div><div><div></div></div></div><div><div><div><span></span></div><div><span></span></div></div></div><div><div><div><span></span></div><div><span></span></div></div></div><div><div><div><span></span></div></div></div></div><div><div>2710</div><div>2250</div><div>460</div></div><div><div>W3</div><div>W4</div></div></div>
--	---


DOOR/WINDOW SCHEDULE

SCALE 1:50


SPACE	FLOOR FINISH	SKIRTING / DADO	WALL FINISH	CEILING FINISH
PORTICO	600x600 NON SLIP CERAMIC FLOOR TILES	100x600mm APPROVED TILE SKIRTING	EMULSION PAINT AFTER 2 COATS OF WALL SEALER	SMOOTHED SLAB SOFFIT WITH APPROVED EMULSION PAINT
ENTRANCE LOBBY	600x600 NON SLIP CERAMIC FLOOR TILES	100x600mm APPROVED TILE SKIRTING	EMULSION PAINT AFTER 2 COATS OF WALL SEALER	6mm THICK PLYWOOD CEILING WITH TIMBER EDGE BEADING
CONFERENCE HALL	600x600 NON SLIP CERAMIC FLOOR TILES	100x600mm APPROVED TILE SKIRTING	EMULSION PAINT AFTER 2 COATS OF WALL SEALER	6mm THICK PLYWOOD CEILING WITH TIMBER EDGE BEADING
BUDGET/ADMIN/E-GOV. KIOSK /LIBRARY/WOMEN'S COMM.	300x300 NON SLIP CERAMIC FLOOR TILES	100x300mm APPROVED TILE SKIRTING	EMULSION PAINT AFTER 2 COATS OF WALL SEALER	6mm THICK PLYWOOD CEILING WITH TIMBER EDGE BEADING
COUNCIL MEMBER'S ROOMS/ADMIN & BUDGET HEAD	600x600 NON SLIP CERAMIC FLOOR TILES	100x300mm APPROVED TILE SKIRTING	EMULSION PAINT AFTER 2 COATS OF WALL SEALER	6mm THICK PLYWOOD CEILING WITH TIMBER EDGE BEADING
STORE/ TEA ROOM/CLEANER/ARCHIVE	300x300 NON SLIP CERAMIC FLOOR TILES	100x300mm APPROVED TILE SKIRTING	EMULSION PAINT AFTER 2 COATS OF WALL SEALER	6mm THICK PLYWOOD CEILING WITH TIMBER EDGE BEADING
ALL TOILETS	200x200 NON SLIP CERAMIC FLOOR TILES	200x300 CERAMIC WALL TILES UPTO 2m HIGH	EMULSION PAINT AFTER 2 COATS OF WALL SEALER	4mm THICK CEMENT BOARD WITH TIMBER EDGE BEADING

SCHEDULE OF GENERAL FINISHES




<div>CONTRACTORS MUST CHECK ALL DIMENSIONS ON SITE BEFORE STARTING ANY WORK OR SHOP DRAWINGS. FIGURED DIMENSIONS TO TAKE PRECEDENCE OVER SCALE READINGS. DO NOT SCALE DRAWINGS. IN CASE DOUBT, PLEASE ASK.</div>	<div>REVISION:</div>				ARCHITECT: ABDUL WAHID MOHAMED										
					ENGINEER: ABDULLA RAMEEZ										
					SERVICES ENG.: MOHAMED NASHEED										
					ESTIMATOR: HASSAN NIHAD										
					DRAWN BY: ABDUL WAHID MOAHEMD										
<div>adept adeptmaldives pvt ltd 14100 Headlamps, Vademulhi Islet, 2024 Ttd +961 /91 /701 Email info@adeptmaldives.com</div>								PROJECT: COUNCIL IDHAARAA FOR SH. NOONARAA ISLAND		<div>A-08</div>					
								LOCATION: SHAYYANI ATOLL, REPUBLIC OF MALDIVES							
								DWG TITLE.: AS GIVEN							
								CLIENT: OFFICE FOR PROGRAMMES AND PROJECTS (OPP)							
								SCALE: AS GIVEN				DIMENSION: mm		DATE: 01st AUGUST 2013	
								PROJECT NC: AM-2013-00							
CONCEPT AND DESIGN IN THIS DRAWING ARE THE PROPERTIES OF ADEPT MALDIVES PRIVATE LIMITED. UNAUTHORISED USE OR REPRODUCTION OF WHOLE OR PART OF THE CONCEPT, DESIGN OR DRAWINGS TO USE IN ANY OTHER PROJECTS OR SITES OTHER THAN SPECIFIED ON THIS DRAWING IS PROHIBITED.															

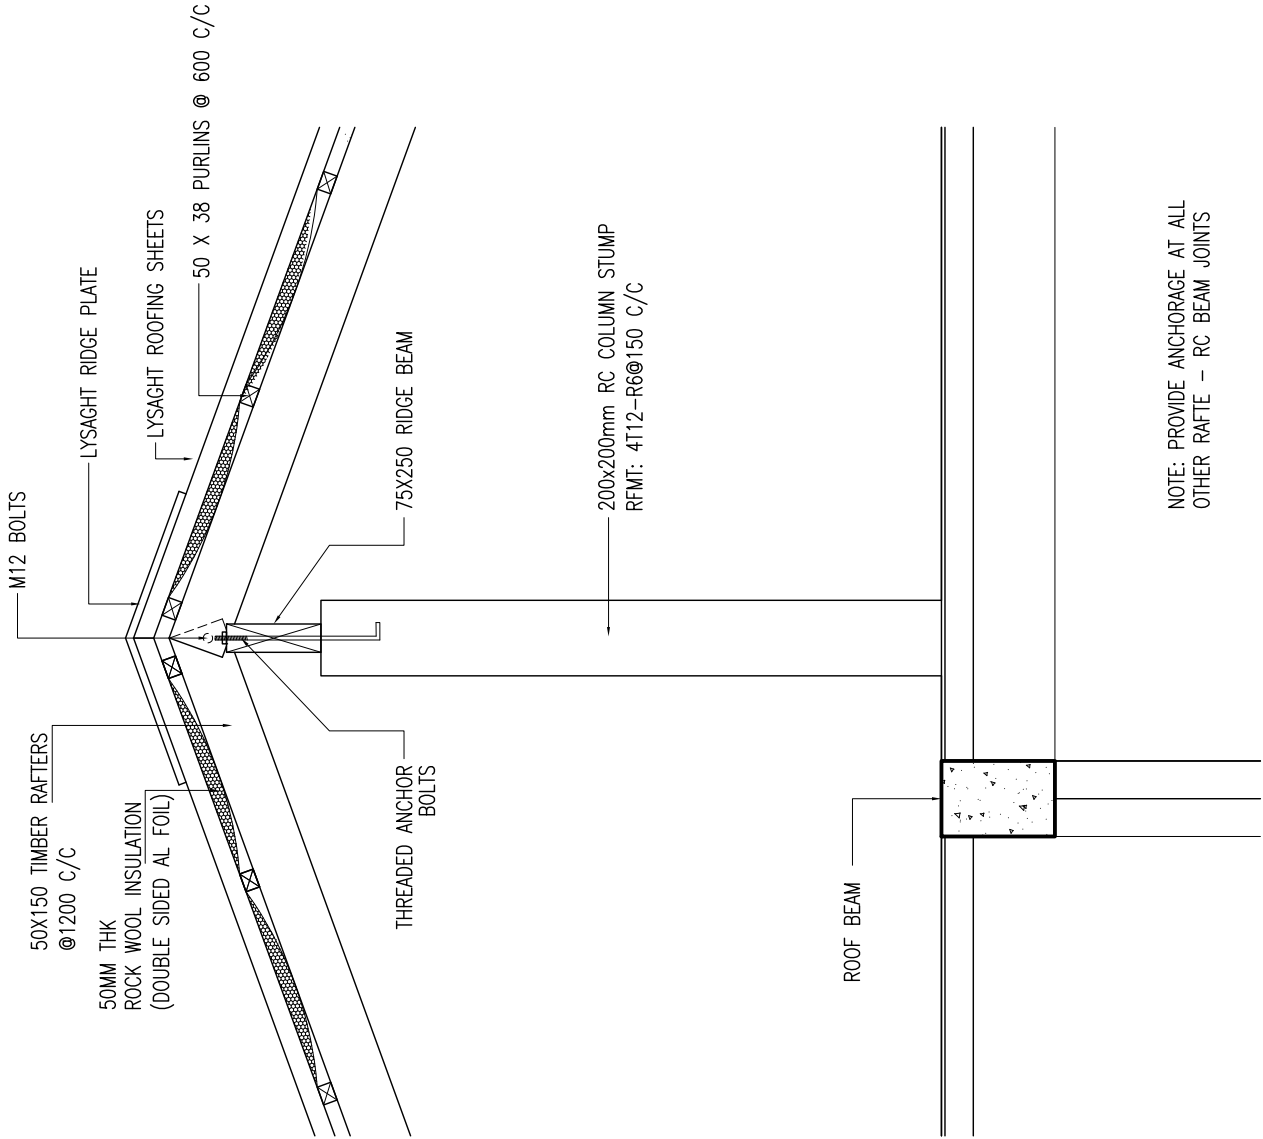

DETAIL -1  
SCALE 1:20

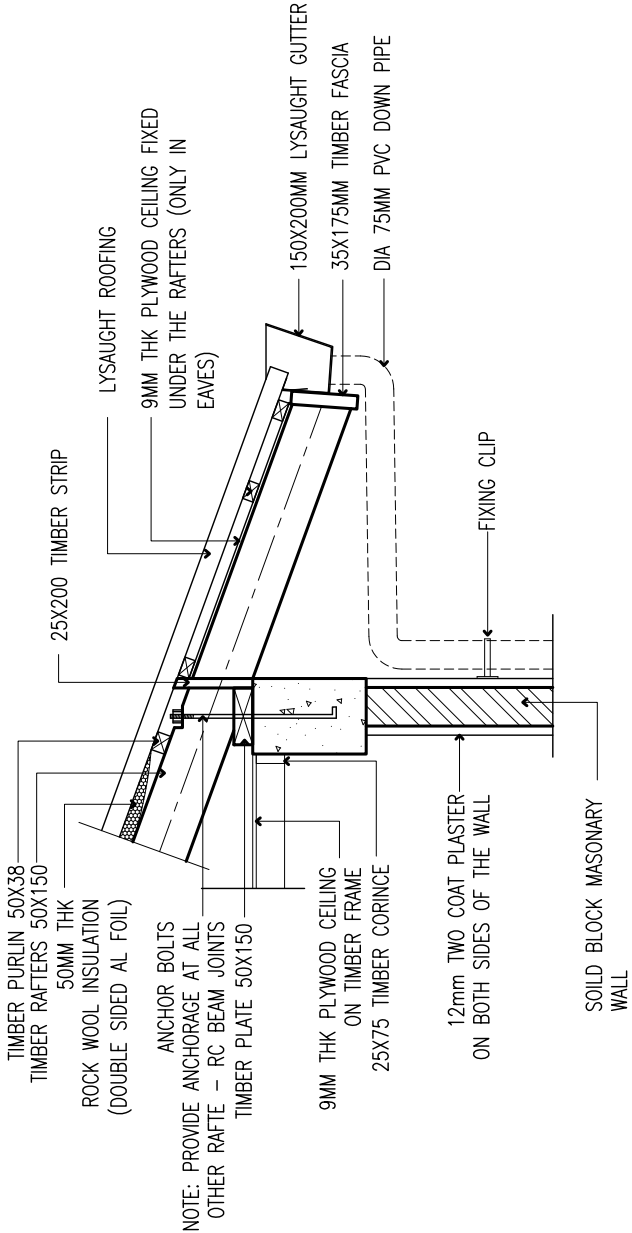

DETAIL -2  
SCALE 1:20

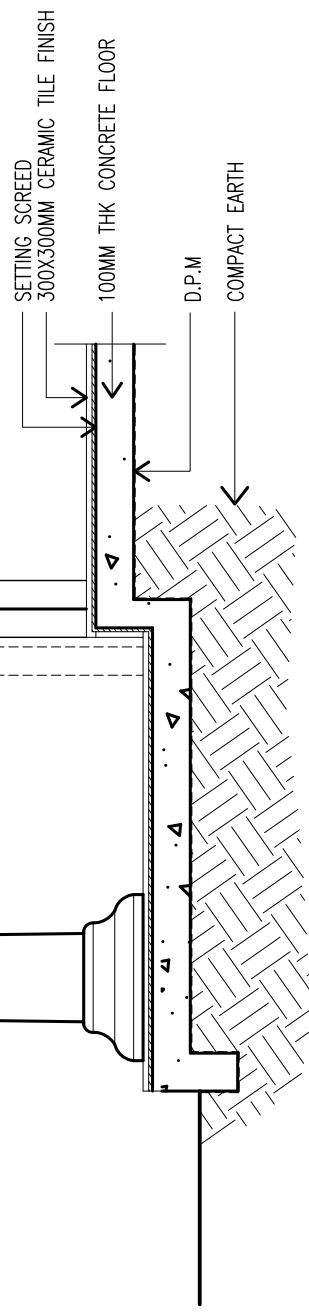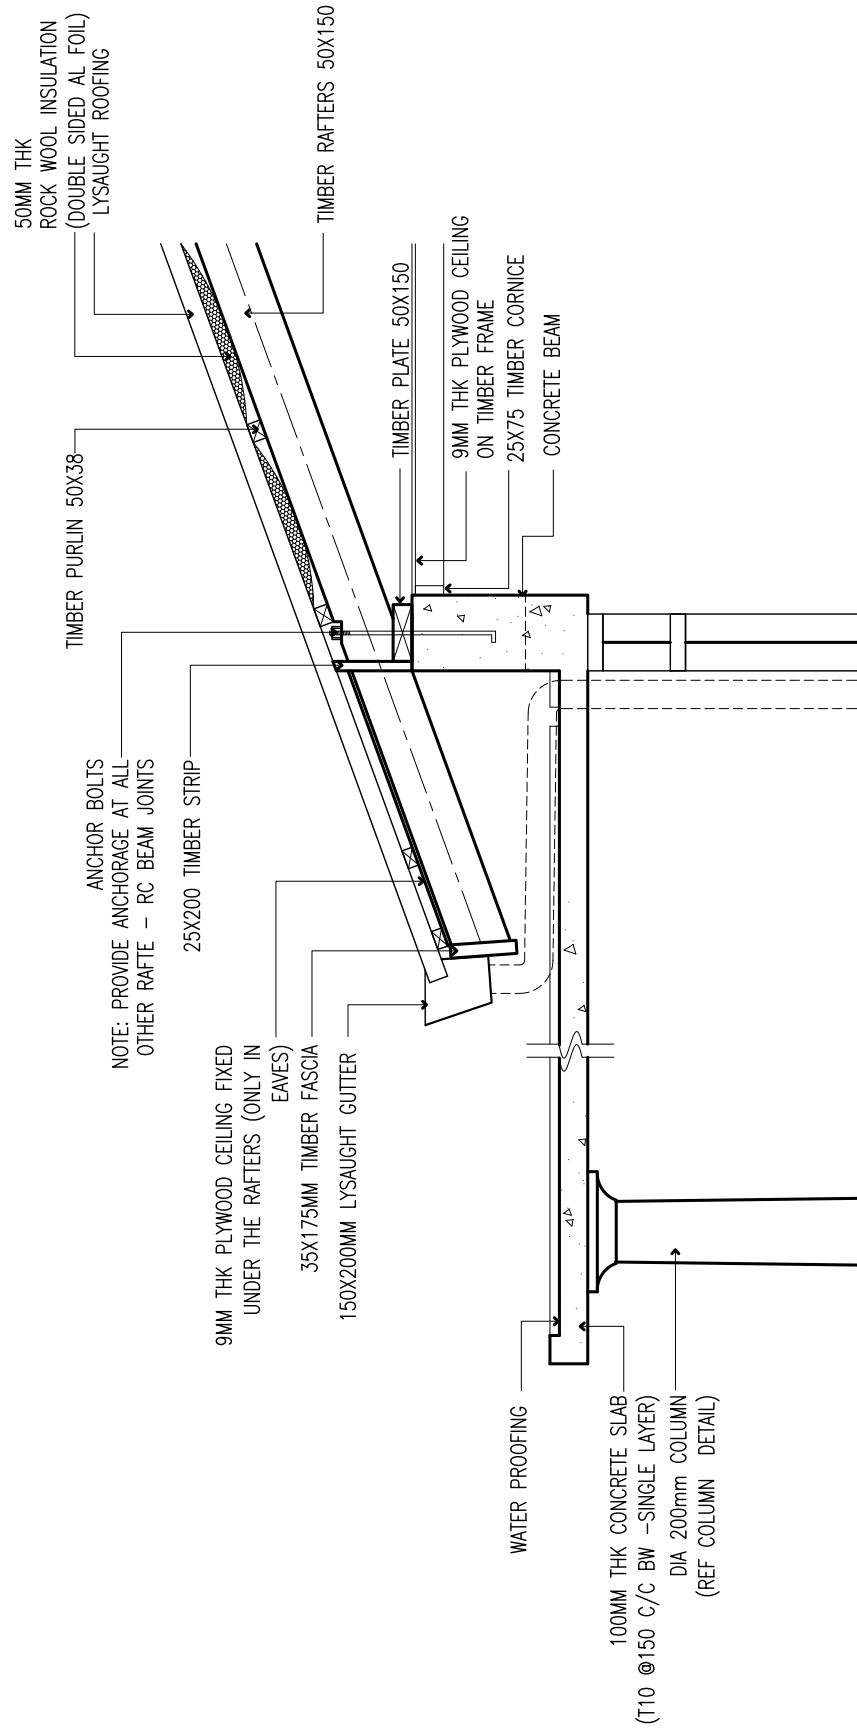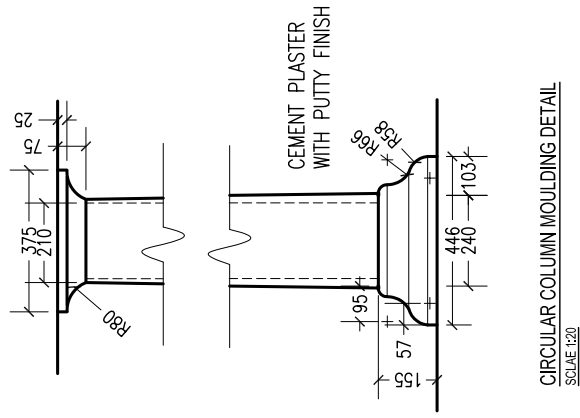

CONTRACTORS MUST CHECK ALL DIMENSIONS ON SITE BEFORE STARTING ANY WORK OR SHOP DRAWINGS. FIGURED DIMENSIONS TO TAKE PRECEDENCE OVER SCALE READINGS.  
DO NOT SCALE DRAWINGS. IN CASE DOUBT, PLEASE ASK.




REVISION:

ARCHITECT:	ABDUL WAHID MOHAMED
ENGINEER:	ABDULLA RAMEEZ
SERVICES ENG.:	MOHAMED NASHEED
ESTIMATOR:	HASSAN MIHAD
DRAWN BY:	ABDUL WAHID MOAHMED
CONCEPT AND DESIGN IN THIS DRAWING ARE THE PROPERTIES OF ADEPT MALDIVES PRIVATE LIMITED. UNAUTHORISED USE OR REPRODUCTION OF WHOLE OR PART OF THE CONCEPT, DESIGN OR DRAWINGS TO USE IN ANY OTHER PROJECTS OR SITES OTHER THAN SPECIFIED ON THIS DRAWING IS PROHIBITED.	


PROJECT:	COUNCIL IDHARAA FOR SH. NOONARAA ISLAND		
LOCATION:	SHAYYANI ATOLL, REPUBLIC OF MALDIVES		
DWG TITLE.:	AS GIVEN		
CLIENT:	OFFICE FOR PROGRAMMES AND PROJECTS (OPP)		
SCALE:	AS GIVEN	DIMENSION: mm	DATE: 01st AUGUST 2013

A-11

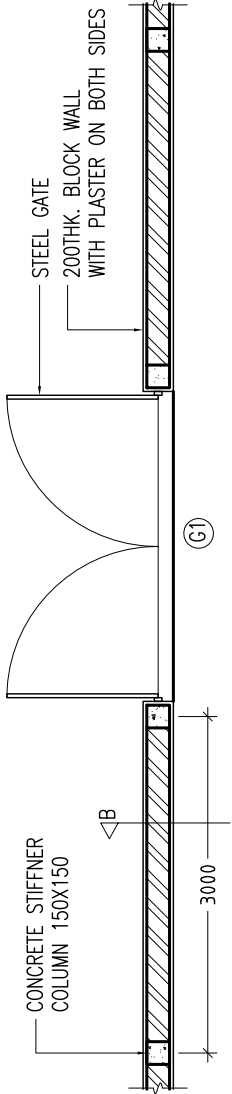


BOUNDARY WALL / ENTRANCE GATE DETAIL  
(PLAN)

SCALE 1:50

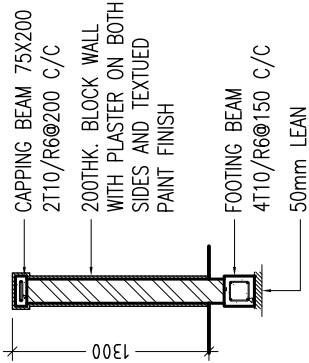


BOUNDARY WALL DETAIL (  
SECTION-B)

SCALE 1:50

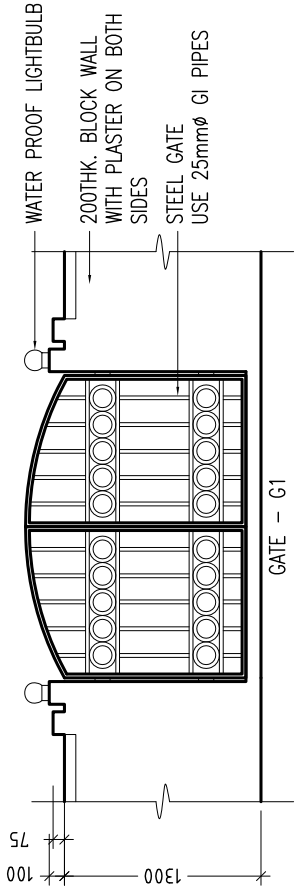

ENTRANCE GATE DETAIL  
(ELEVATION)

SCALE 1:50

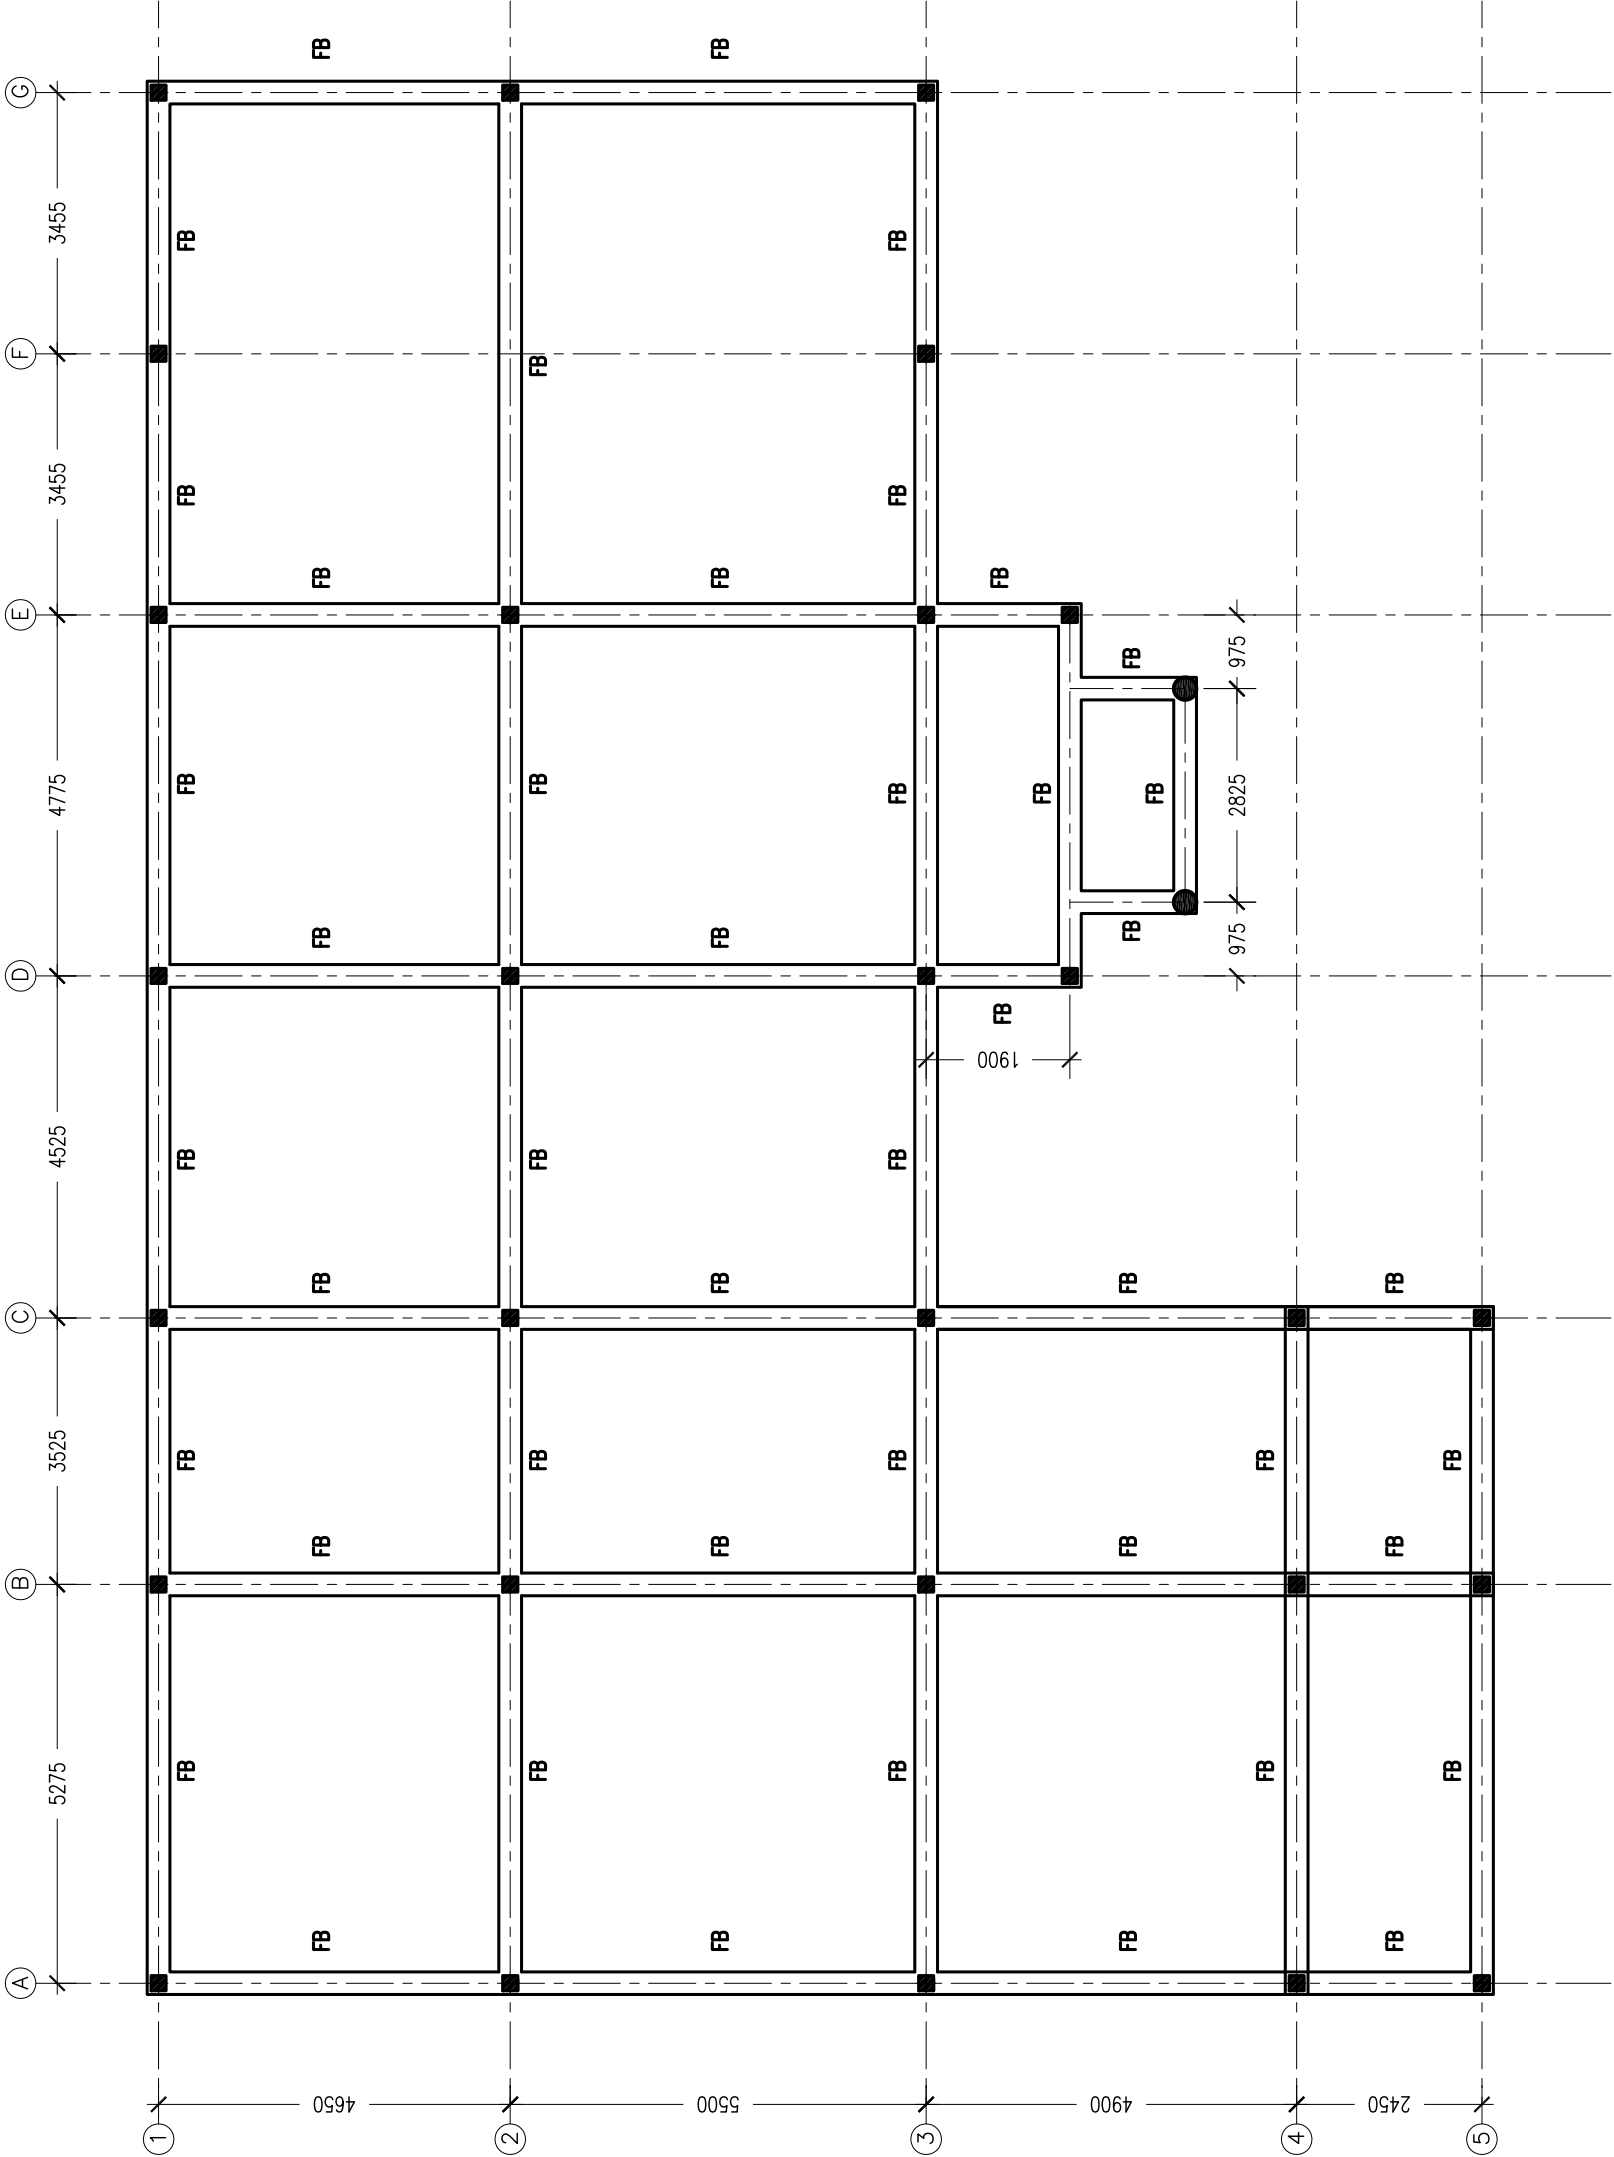

NOTE:  
1. PROVIDE 200x200 RC WALL BEAM BELOW ALL WALLS WHERE THERE IS NO FOUNDATION BEAM (RFMT: 4T12-R6@150 C/C)  
2. ALL RECTANGULAR COLUMNS ARE 'C1' COLUMNS AND ALL CIRCULAR COLUMNS ARE 'C2' COLUMNS

FOUNDATION BEAM PLAN  
SCALE 1:100

CONTRACTORS MUST CHECK ALL DIMENSIONS ON SITE BEFORE STARTING ANY WORK OR SHOP DRAWINGS. FIGURED DIMENSIONS TO TAKE PRECEDENCE OVER SCALE READINGS.  
DO NOT SCALE DRAWINGS. IN CASE DOUBT, PLEASE ASK.




REVISION:

ARCHITECT:	ABDUL WAHID MOHAMED
ENGINEER:	ABDULLA RAMEEZ
SERVICES ENG.:	MOHAMED NASHEED
ESTIMATOR:	HASSAN NIHAD
DRAWN BY:	ABDUL WAHID MOAHEMD


PROJECT:	COUNCIL IDHAARAA FOR SH. NOONARAA ISLAND
LOCATION:	SHAVIYANI ATOLL, REPUBLIC OF MALDIVES
DWG TITLE.:	AS GIVEN
CLIENT:	OFFICE FOR PROGRAMMES AND PROJECTS (OPP)
SCALE:	AS GIVEN
DIMENSION:	mm
DATE:	01st AUGUST 2013


S-01


DWG NO.:
PROJECT NO: AM-2013-00

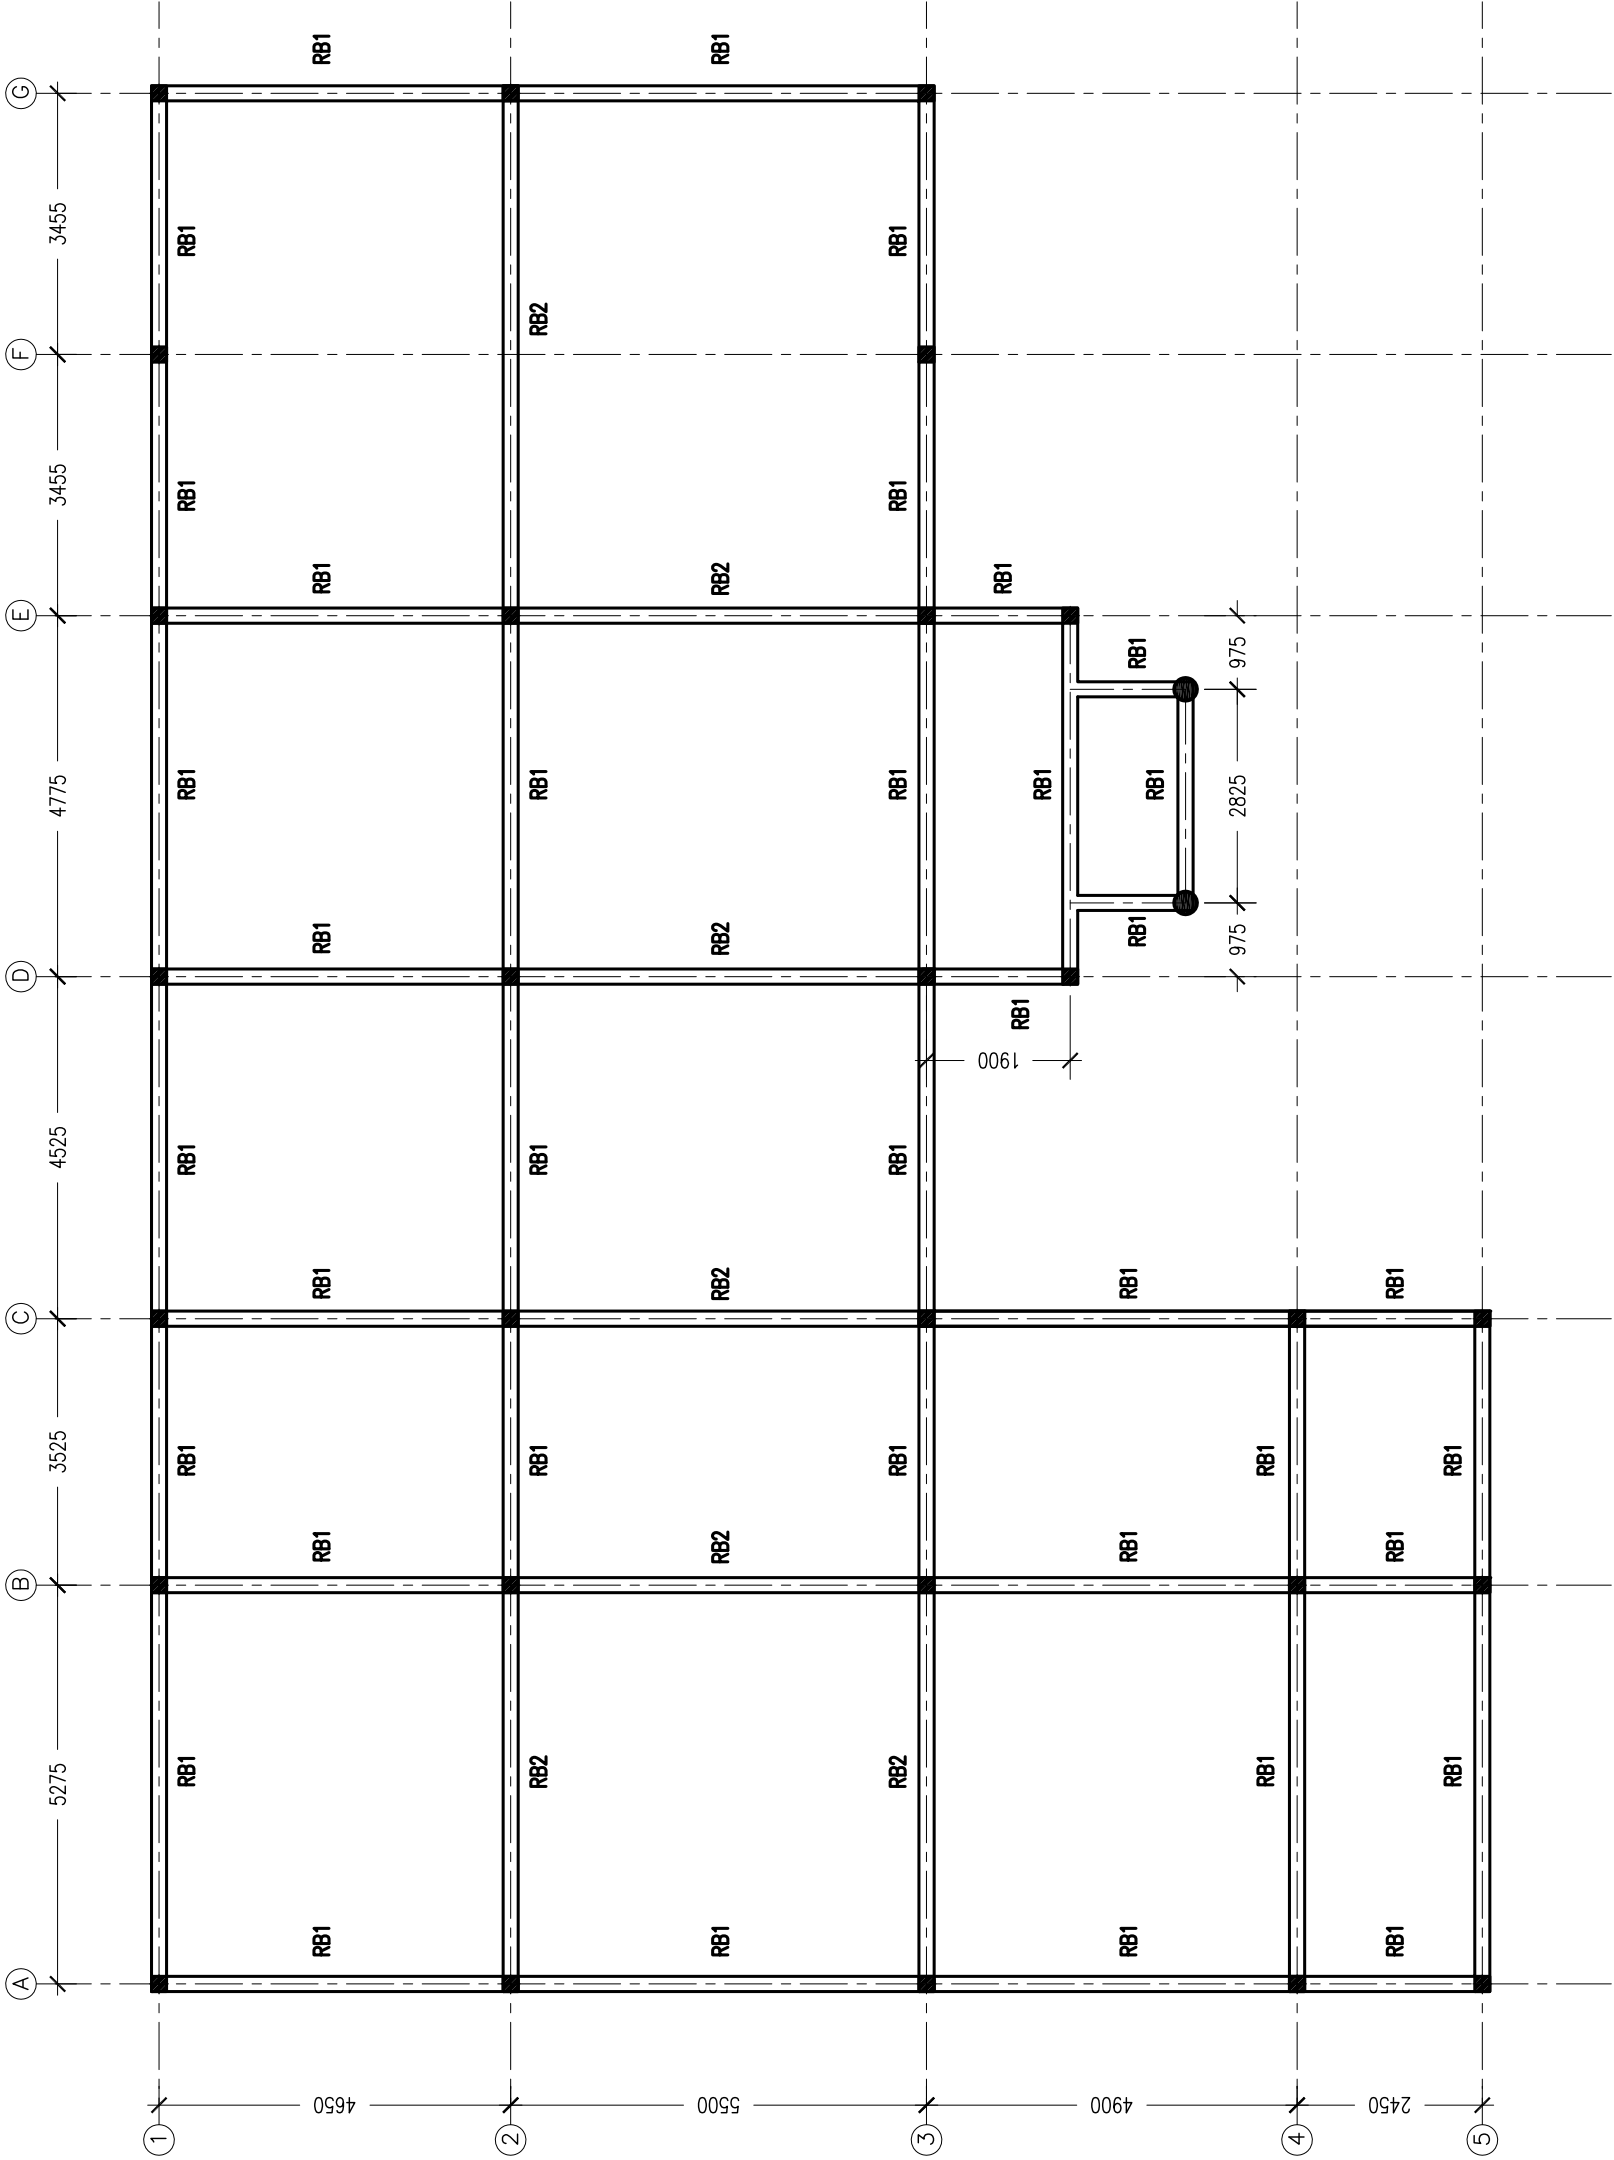

ROOF BEAM PLAN

SCALE 1:100

CONTRACTORS MUST CHECK ALL DIMENSIONS ON SITE BEFORE STARTING ANY WORK OR SHOP DRAWINGS. FIGURED DIMENSIONS TO TAKE PRECEDENCE OVER SCALE READINGS. DO NOT SCALE DRAWINGS. IN CASE DOUBT, PLEASE ASK.

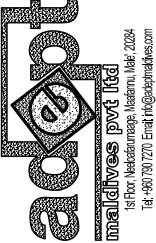

REVISION:	

ARCHITECT:	ABDUL WAHID MOHAMED
ENGINEER:	ABDULLA RAMEEZ
SERVICES ENG.:	MOHAMED NASHEED
ESTIMATOR:	HASSAN NIHAD
DRAWN BY:	ABDUL WAHID MOAHEMID

ARCHITECTURAL DESIGN | STRUCTURAL DESIGN | COASTAL DESIGN | COST ESTIMATION | LAND SURVEYING | PROJECT MANAGEMENT | URBAN PLANNING | MANAGEMENT CONSULTANCY

PROJECT:	COUNCIL IDHAARAA FOR SH. NOONARAA ISLAND		
LOCATION:	SHAVIYANI ATOLL, REPUBLIC OF MALDIVES		
DWG TITLE.:	AS GIVEN		
CLIENT:	OFFICE FOR PROGRAMMES AND PROJECTS (OPP)		
SCALE:	AS GIVEN	DIMENSION: mm	DATE: 01st AUGUST 2013

DWG NO.:


PROJECT NO: AH-2013-00

S-02

DWG NO.:

PROJECT NO: AM-2013-00

CONCEPT AND DESIGN IN THIS DRAWING ARE THE PROPERTIES OF ADEPT MALDIVES PRIVATE LIMITED. UNAUTHORISED USE OR REPRODUCTION OF WHOLE OR PART OF THE CONCEPT, DESIGN OR DRAWINGS TO USE IN ANY OTHER PROJECTS OR SITES OTHER THAN SPECIFIED ON THIS DRAWING IS PROHIBITED.

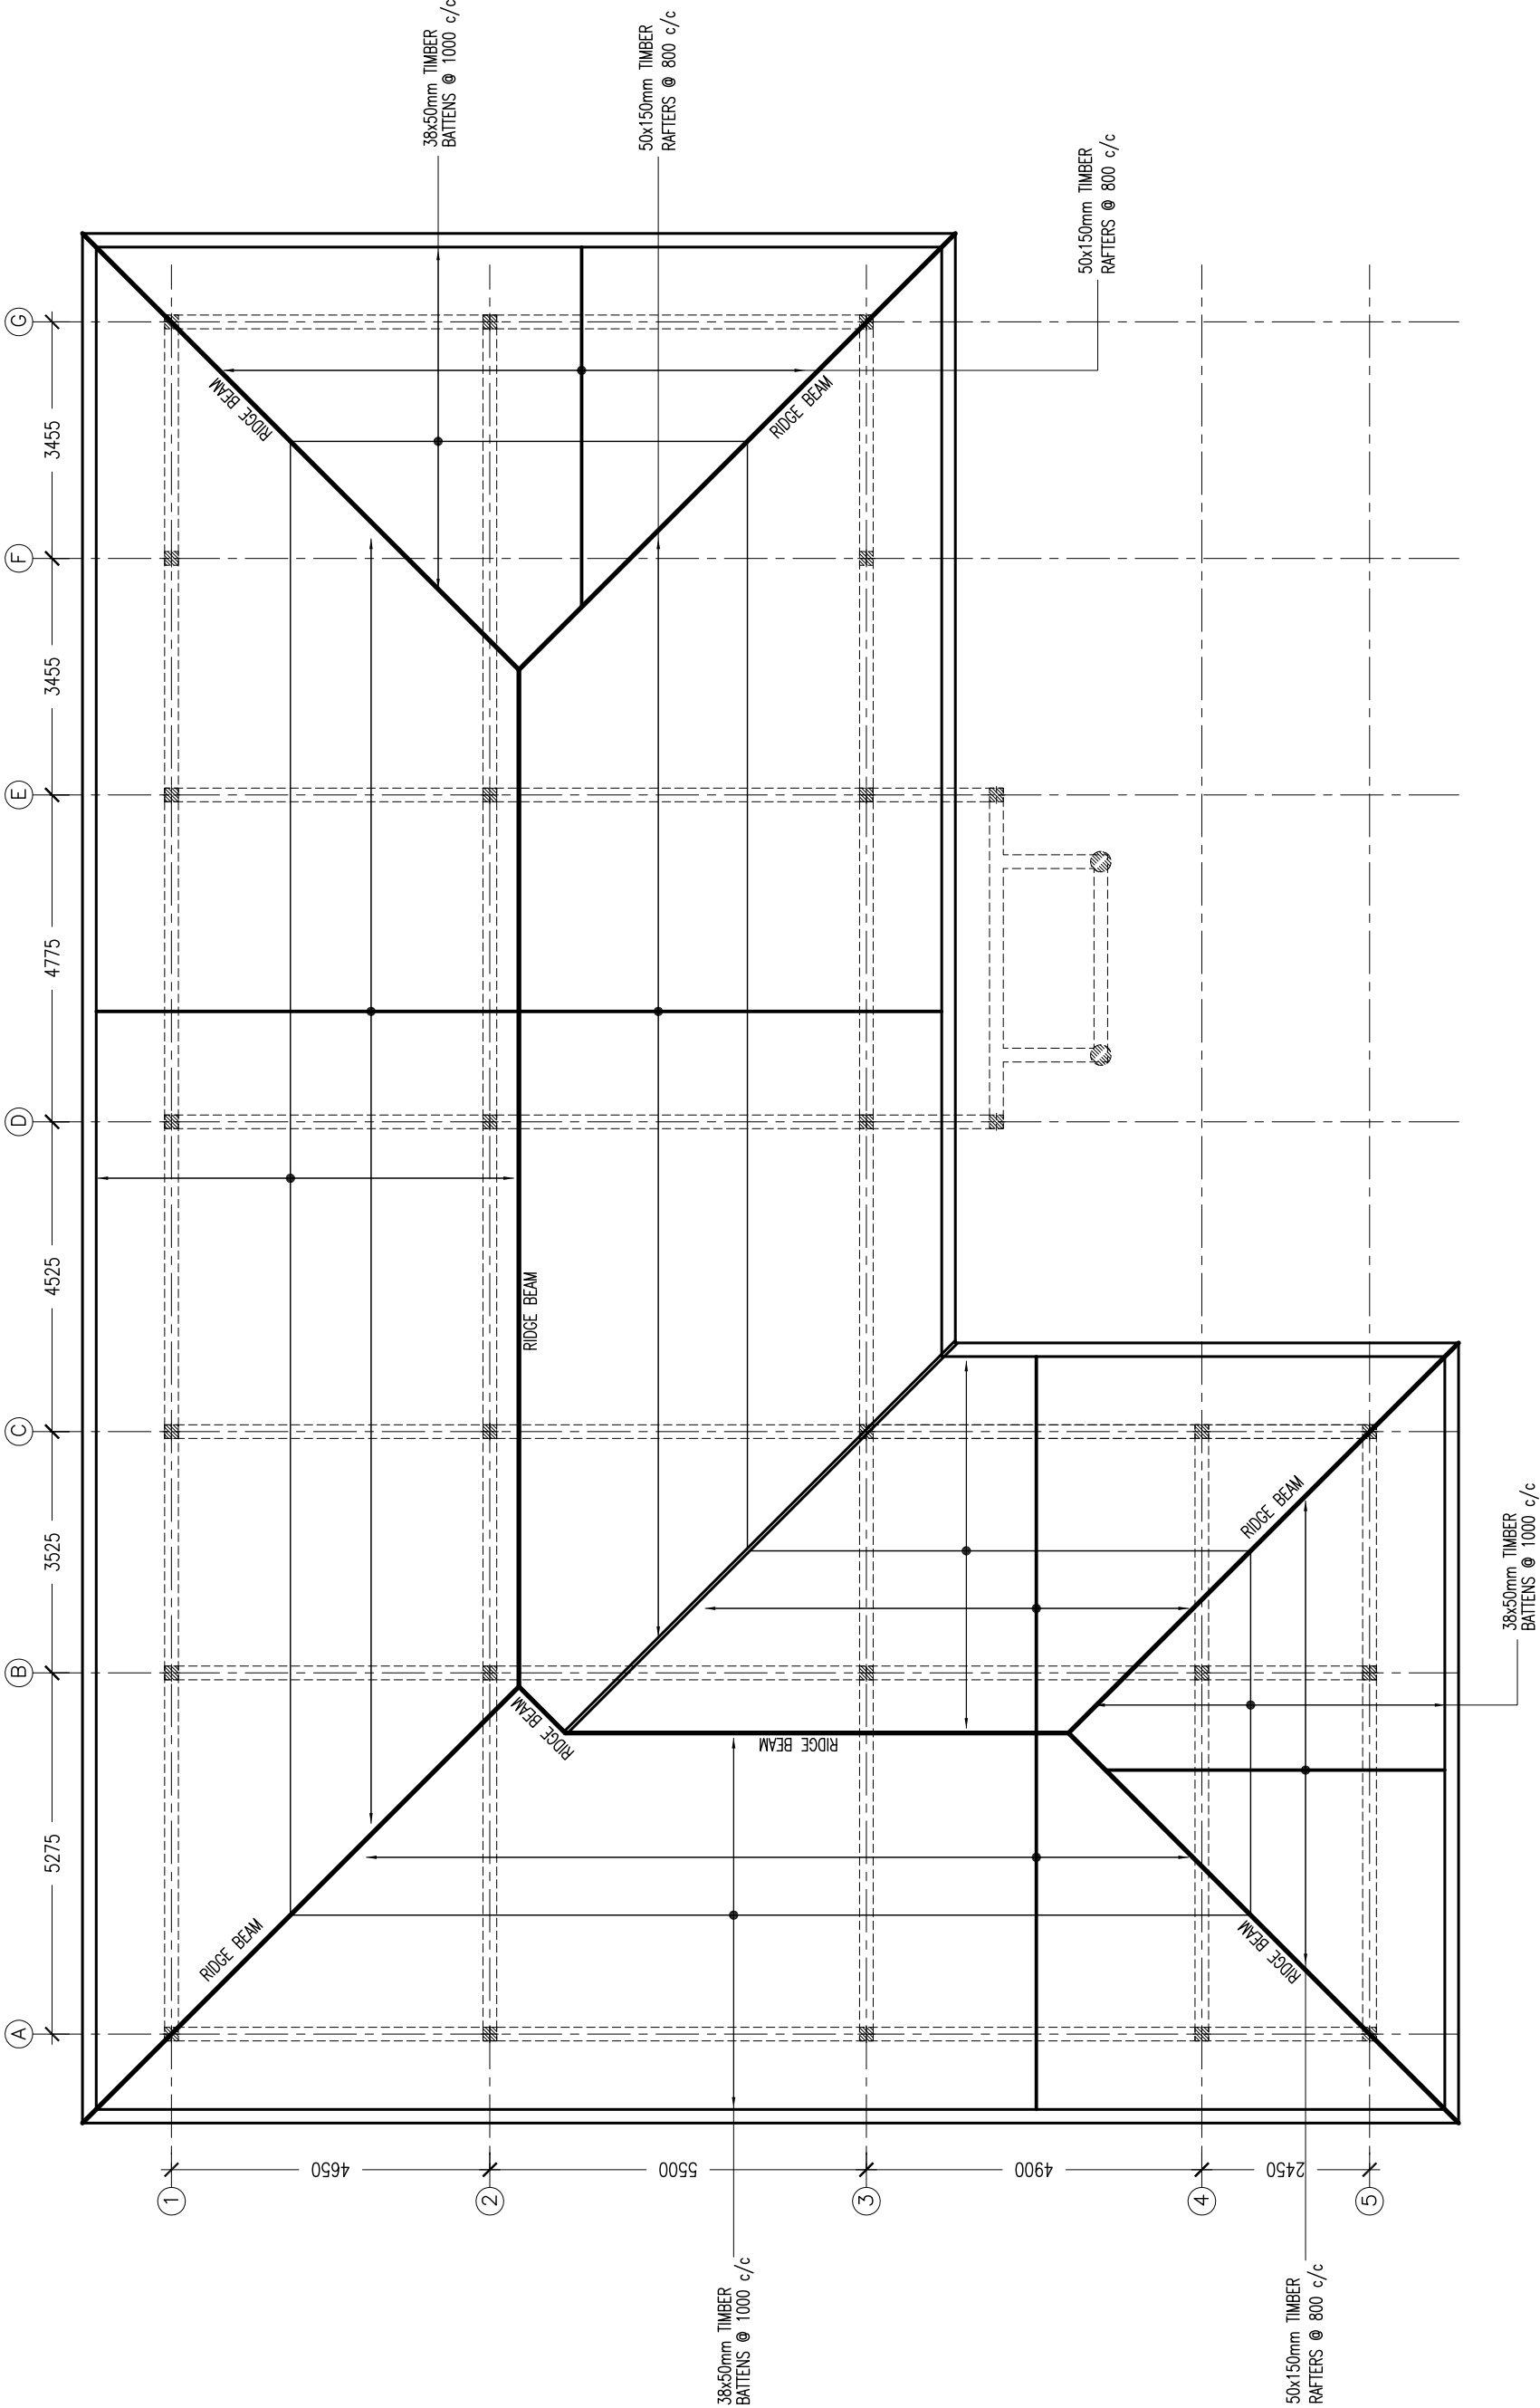

ROOF STRUCTURE PLAN

SCALE 1:100

<div>CONTRACTORS MUST CHECK ALL DIMENSIONS ON SITE BEFORE STARTING ANY WORK OR SHOP DRAWINGS. FIGURED DIMENSIONS TO TAKE PRECEDENCE OVER SCALE READINGS. DO NOT SCALE DRAWINGS. IN CASE DOUBT, PLEASE ASK.</div>	REVISION:		ARCHITECT:	ABDUL WAHID MOHAMED	PROJECT:	COUNCIL IDHAARAA FOR SH. NOONARAA ISLAND	<div>S-03</div> <div>DWG NO.:</div> <div>PROJECT NO: AM-2013-00</div>	
			ENGINEER:	ABDULLA RAMEEZ	LOCATION:	SHAVIYANI ATOLL, REPUBLIC OF MALDIVES		
			SERVICES ENG.:	MOHAMED NASHEED	DWG TITLE:	AS GIVEN		
			ESTIMATOR:	HASSAN NIHAD	CLIENT:	OFFICE FOR PROGRAMMES AND PROJECTS (OPP)		
			DRAWN BY:	ABDUL WAHID MOAHEMD	SCALE:	AS GIVEN		DIMENSION: mm
ARCHITECTURAL DESIGN   STRUCTURAL DESIGN   COASTAL DESIGN   COST ESTIMATION   LAND SURVEYING   PROJECT MANAGEMENT   URBAN PLANNING   MANAGEMENT CONSULTANCY								CONCEPT AND DESIGN IN THIS DRAWING ARE THE PROPERTIES OF ADEPT MALDIVES PRIVATE LIMITED. UNAUTHORISED USE OR REPRODUCTION OF WHOLE OR PART OF THE CONCEPT, DESIGN OR DRAWINGS TO USE IN ANY OTHER PROJECTS OR SITES OTHER THAN SPECIFIED ON THIS DRAWING IS PROHIBITED.

adept

maldives pvt ltd


1st Floor, Neebaram Nagar, Maamuri, Male, 2024

Tel: +960 701 7070 Email: info@adeptmaldives.com

adeptmaldives pvt ltd



CONTRACTORS MUST CHECK ALL DIMENSIONS ON SITE BEFORE STARTING ANY WORK OR SHOP DRAWINGS. FIGURED DIMENSIONS TO TAKE PRECEDENCE OVER SCALE READINGS.  
DO NOT SCALE DRAWINGS. IN CASE DOUBT, PLEASE ASK.

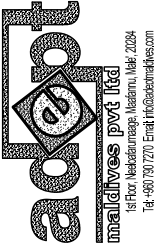

REVISION:

ARCHITECT:	ABDUL WAHID MOHAMED
ENGINEER:	ABDULLA RAMEEZ
SERVICES ENG.:	MOHAMED NASHEED
ESTIMATOR:	HASSAN NIHAD
DRAWN BY:	ABDUL WAHID MOAHEMD

PROJECT: COUNCIL IDHAARAA FOR SH. NOONARAA ISLAND		
LOCATION: SHAVIVANI ATOLL, REPUBLIC OF MALDIVES		
DWG TITLE.: AS GIVEN		
CLIENT: OFFICE FOR PROGRAMMES AND PROJECTS (OPP)		
SCALE: AS GIVEN	DIMENSION: mm	DATE: 01st AUGUST 2013

DWG NO.:


S-04

PROJECT NO: AM-2015-00

S-04

DWG NO.:


ARCHITECTURAL DESIGN | STRUCTURAL DESIGN | COASTAL DESIGN | LAND SURVEYING | PROJECT MANAGEMENT | URBAN PLANNING | MANAGEMENT CONSULTANCY  
CONCEPT AND DESIGN IN THIS DRAWING ARE THE PROPERTIES OF ADEPT MALDIVES PRIVATE LIMITED. UNAUTHORISED USE OR REPRODUCTION OF WHOLE OR PART OF THE CONCEPT, DESIGN OR DRAWINGS TO USE IN ANY OTHER PROJECTS OR SITES OTHER THAN SPECIFIED ON THIS DRAWING IS PROHIBITED.

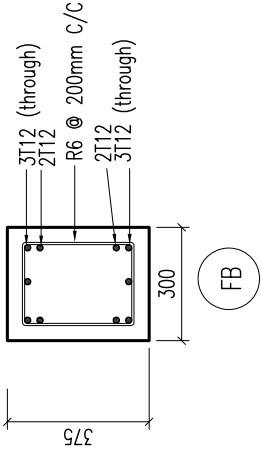

FOUNDATION DEPTH = 900mm

## BEAM DETAILS


Scale 1:20

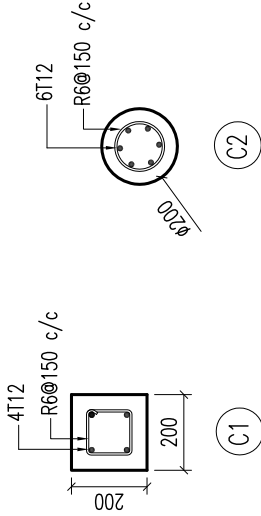

## COLUMN DETAILS

Scale 1:20



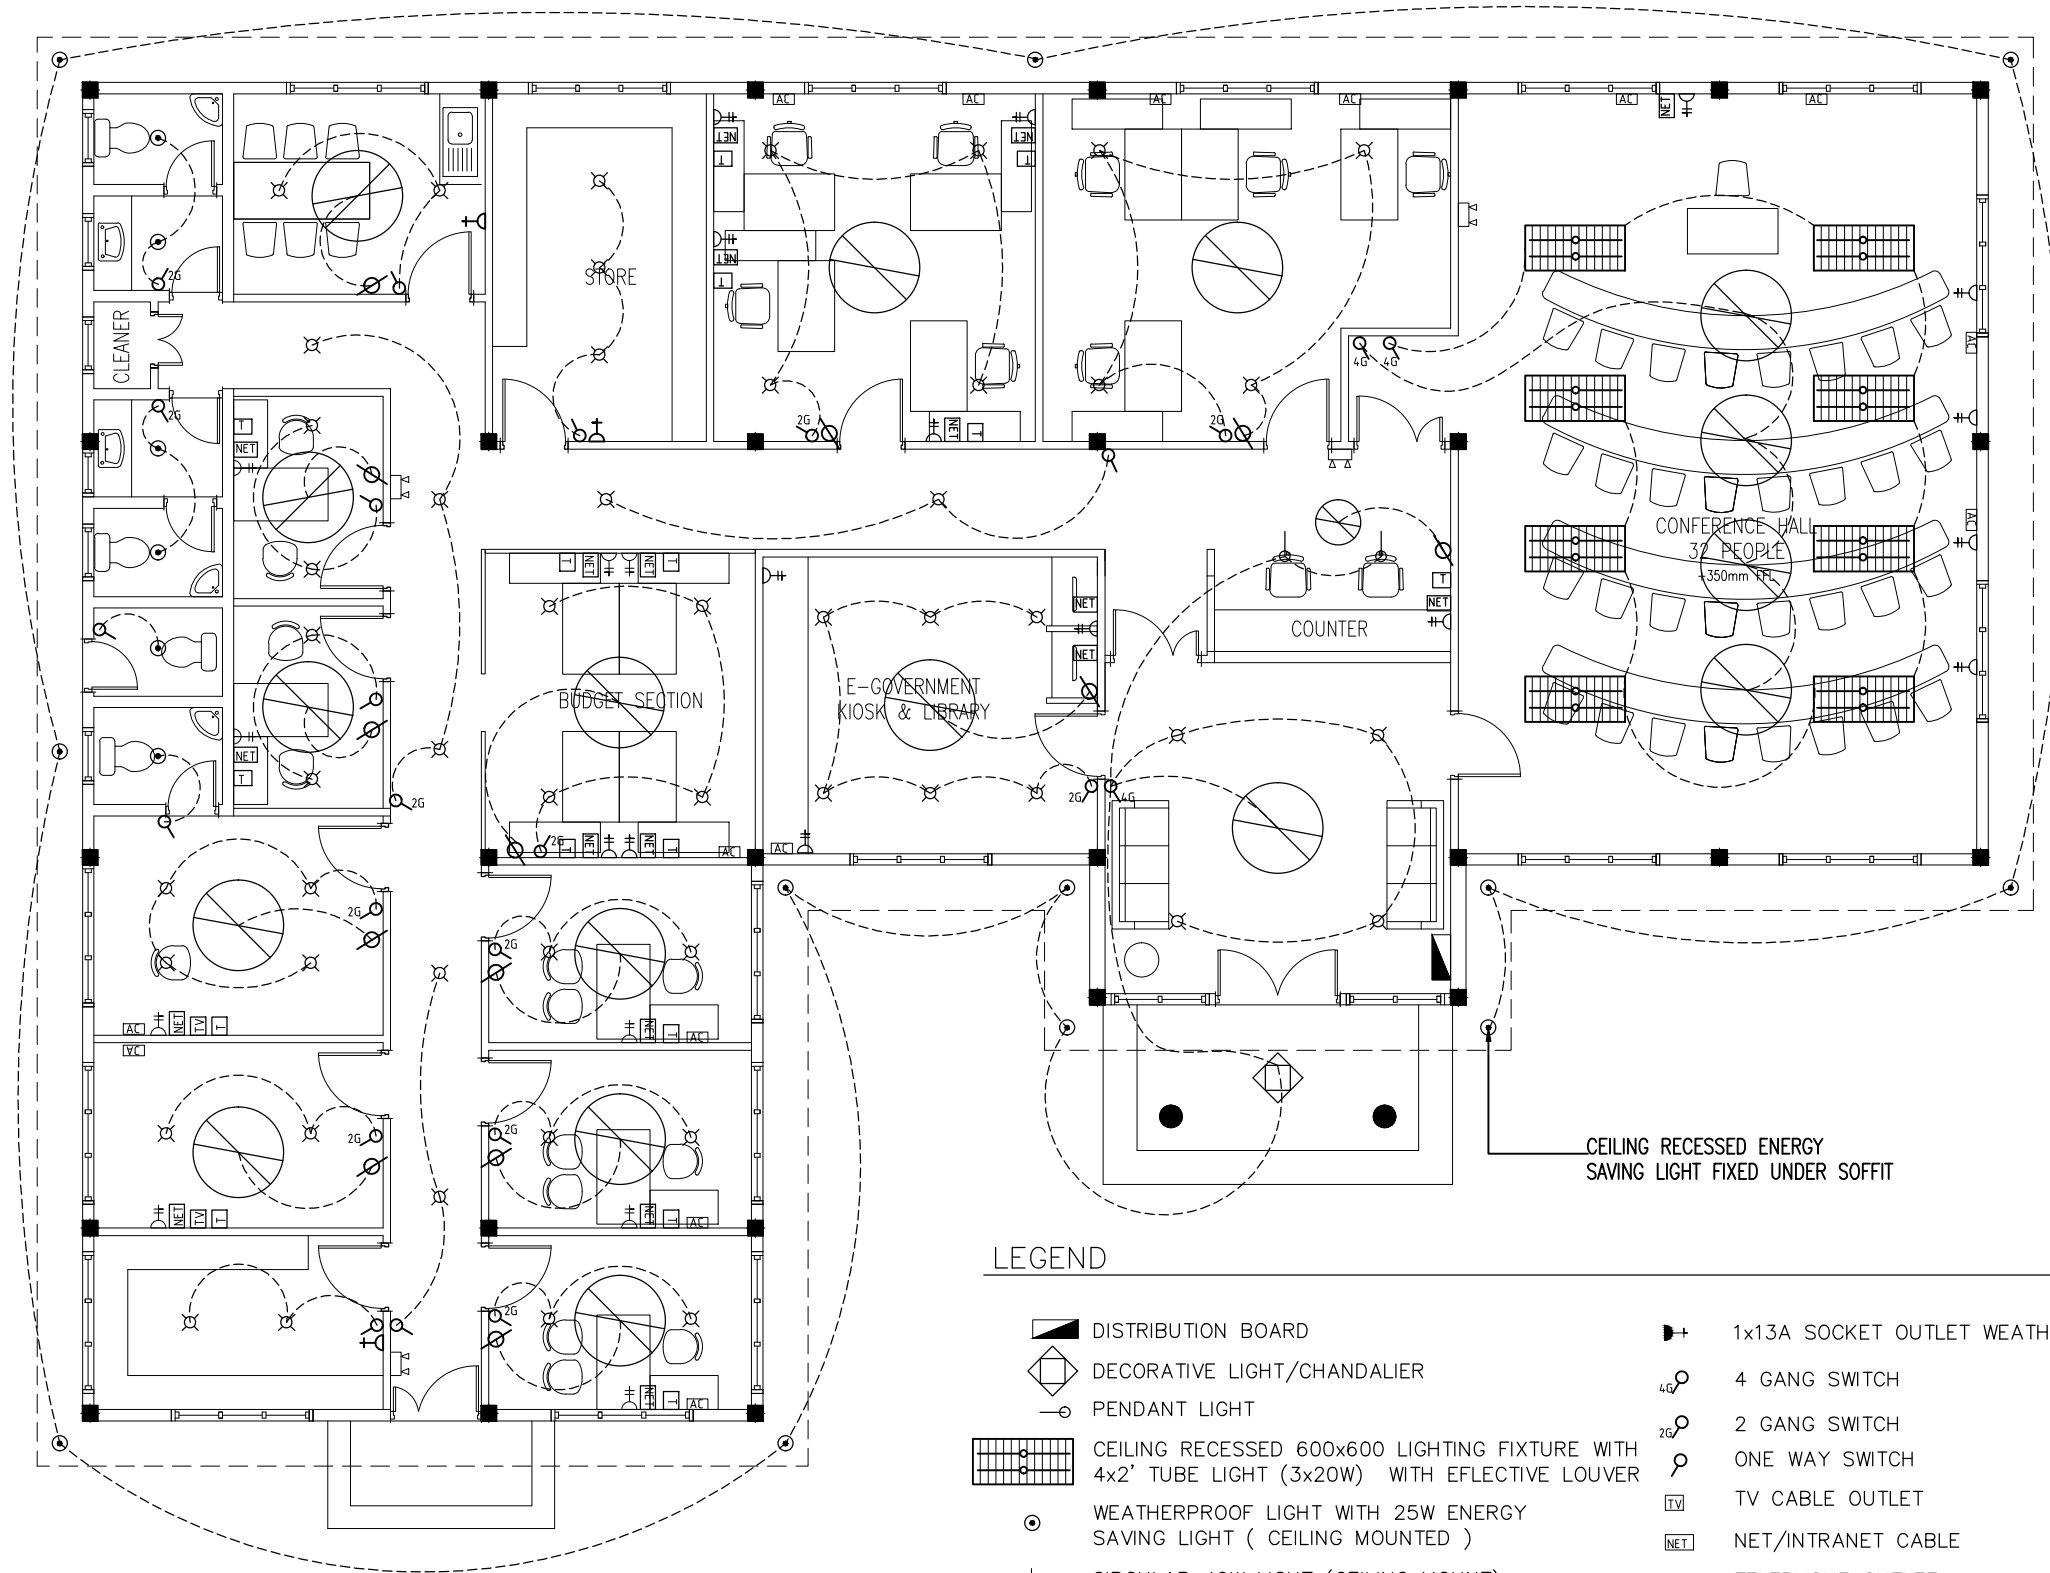

ELECTRICAL PLAN  
SCALE 1:100

LEGEND

- |  |  |  |                                   |
|--|--|--|-----------------------------------|
|  | DISTRIBUTION BOARD   |  | 1x13A SOCKET OUTLET WEATHER PROOF |
|  | DECORATIVE LIGHT/CHANDALIER  |  | 4 GANG SWITCH                     |
|  | PENDANT LIGHT  |  | 2 GANG SWITCH                     |
|  | CEILING RECESSED 600x600 LIGHTING FIXTURE WITH 4x2' TUBE LIGHT (3x20W) WITH EFLECTIVE LOUVER |  | ONE WAY SWITCH                    |
|  | WEATHERPROOF LIGHT WITH 25W ENERGY SAVING LIGHT ( CEILING MOUNTED )                          |  | TV CABLE OUTLET                   |
|  | CIRCULAR 40W LIGHT (CEILING MOUNT)   |  | NET/INTRANET CABLE                |
|  | NON MAINTAINED (WALL MOUNTED ) EMERGENCY LIGHT WITH 2-HR. BATTERY PACK                       |  | TELEPHONE OUTLET                  |
|  | 2x13A SOCKET OUTLET  |  | CEILING FAN (1.2M DIAMETER)       |
|  |  |  | FAN REGULATOR                     |

CONTRACTORS MUST CHECK ALL DIMENSIONS ON SITE BEFORE STARTING ANY WORK OR SHOP DRAWINGS, FIGURED DIMENSIONS TO TAKE PRECEDENCE OVER SCALE READINGS.  
DO NOT SCALE DRAWINGS, IN CASE DOUBT, PLEASE ASK.



REVISION:


ARCHITECT: ABDUL WAHID MOHAMED

ENGINEER: ABDULLA RAMEEZ

SERVICES ENG.: MOHAMED FALAAH

ESTIMATOR: HASSAN NIHAD

DRAWN BY: ABDUL WAHID MOAHEMD

PROJECT: COUNCIL IDHAARAA FOR SH. NOONARAA ISLAND

LOCATION: SHAVIYANI ATOLL, REPUBLIC OF MALDIVES

DWG TITLE.: AS GIVEN

CLIENT: OFFICE FOR PROGRAMMES AND PROJECTS (OPP)

SCALE: AS GIVEN

DIMENSION: mm

DATE: 01st AUGUST 2013

E-01

DWG NO.:

PROJECT NO: AM-2013-00



