

## DRAINAGE LAYOUT


SCALE 1:100

|                                      |                               |                             |
|--------------------------------------|-------------------------------|-----------------------------|
| PROJECT: BROOD STOCK                 | ARCHITECTURAL DESIGN          | STRUCTURAL DESIGN           |
| CLIENT: MINISTRY OF FISHERIES & AGRI | DESIGNED BY: - HUSSAIN ZIYATH | DESIGNED BY: - ADAM SAANEEZ |
| DATE: APRIL 2018                     |                               |                             |
| DO NOT SCALE THE DRAWING             |                               |                             |


DWG NO:


M&E-01/05

CHARRETTE  
STUDIO

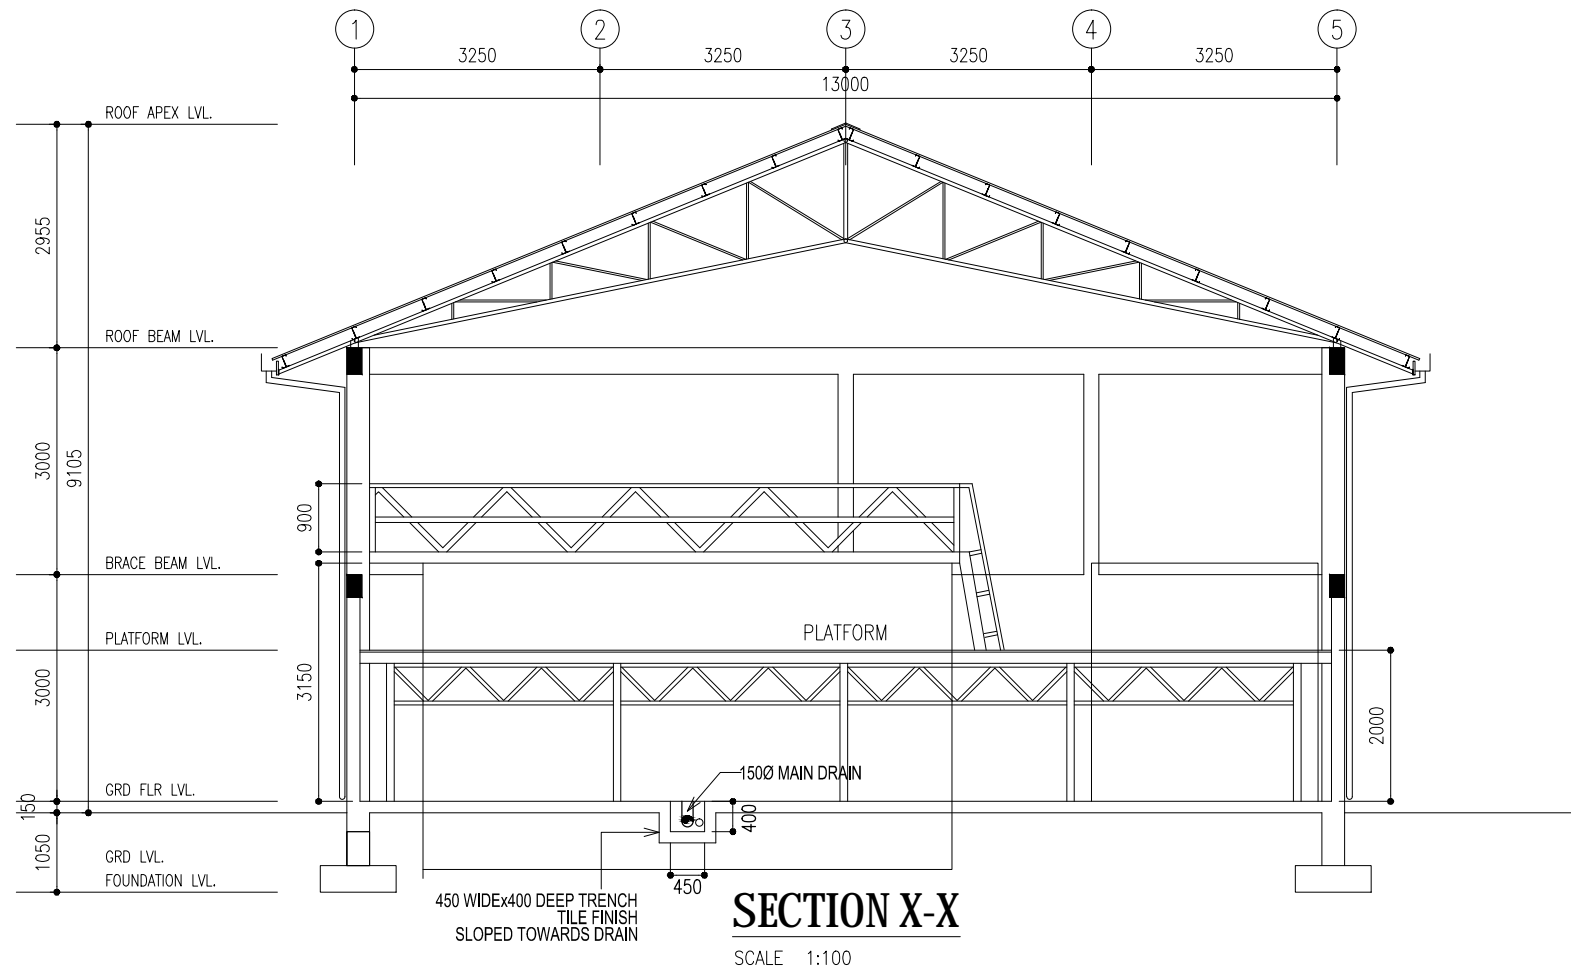

**DRAINAGE LAYOUT**  
SCALE 1:100


|                                      |  |                               |                             |                                 |   |
|--------------------------------------|--|-------------------------------|-----------------------------|---------------------------------|---|
| PROJECT: BROOD STOCK                 |  | ARCHITECTURAL DESIGN          | STRUCTURAL DESIGN           | DWG NO:<br><b>M&amp;E-02/05</b> |  |
| CLIENT: MINISTRY OF FISHERIES & AGRI |  | DESIGNED BY: - HUSSAIN ZIYATH | DESIGNED BY: - ADAM SAANEEZ |                                 |   |
| DATE: APRIL 2018                     |  |                               |                             |                                 |   |
| DO NOT SCALE THE DRAWING             |  |                               |                             |                                 |   |

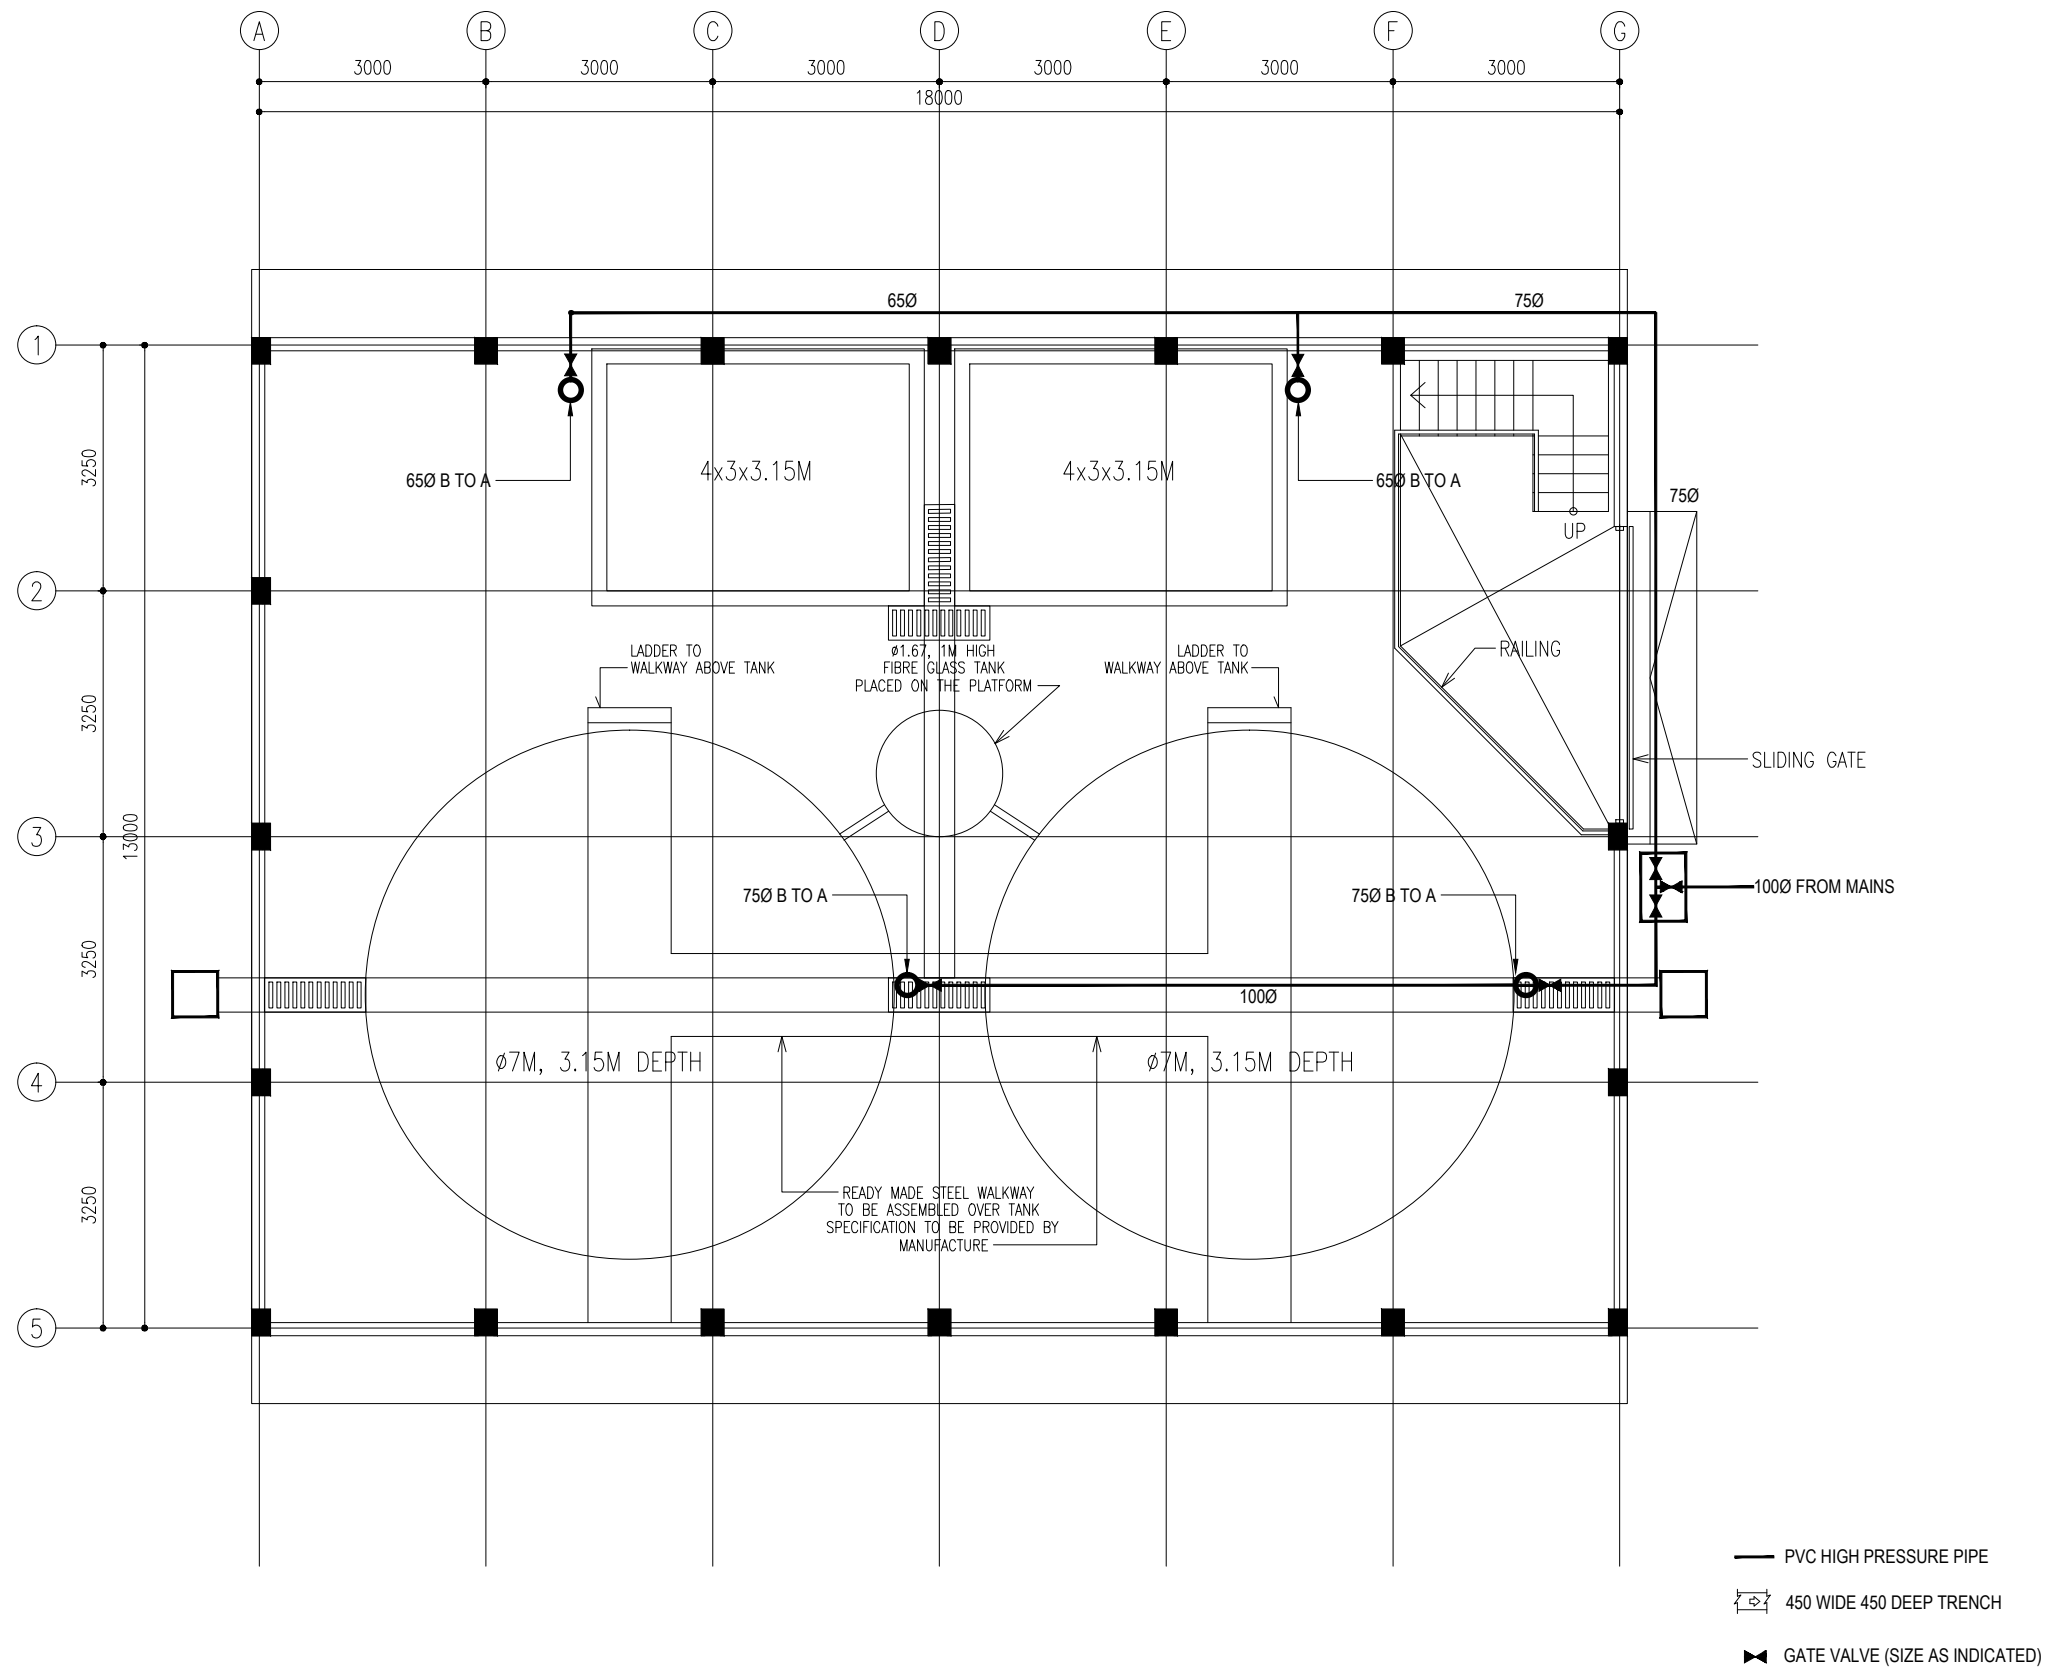

## WATER SUPPLY LAYOUT

SCALE 1:100

|                                      |                               |                             |           |
|--------------------------------------|-------------------------------|-----------------------------|-----------|
| PROJECT: BROOD STOCK                 | ARCHITECTURAL DESIGN          | STRUCTURAL DESIGN           | DWG NO:   |
| CLIENT: MINISTRY OF FISHERIES & AGRI | DESIGNED BY: - HUSSAIN ZIYATH | DESIGNED BY: - ADAM SAANEEZ | M&E-03/05 |
| DATE: APRIL 2018                     |                               |                             |           |
| DO NOT SCALE THE DRAWING             |                               |                             |           |

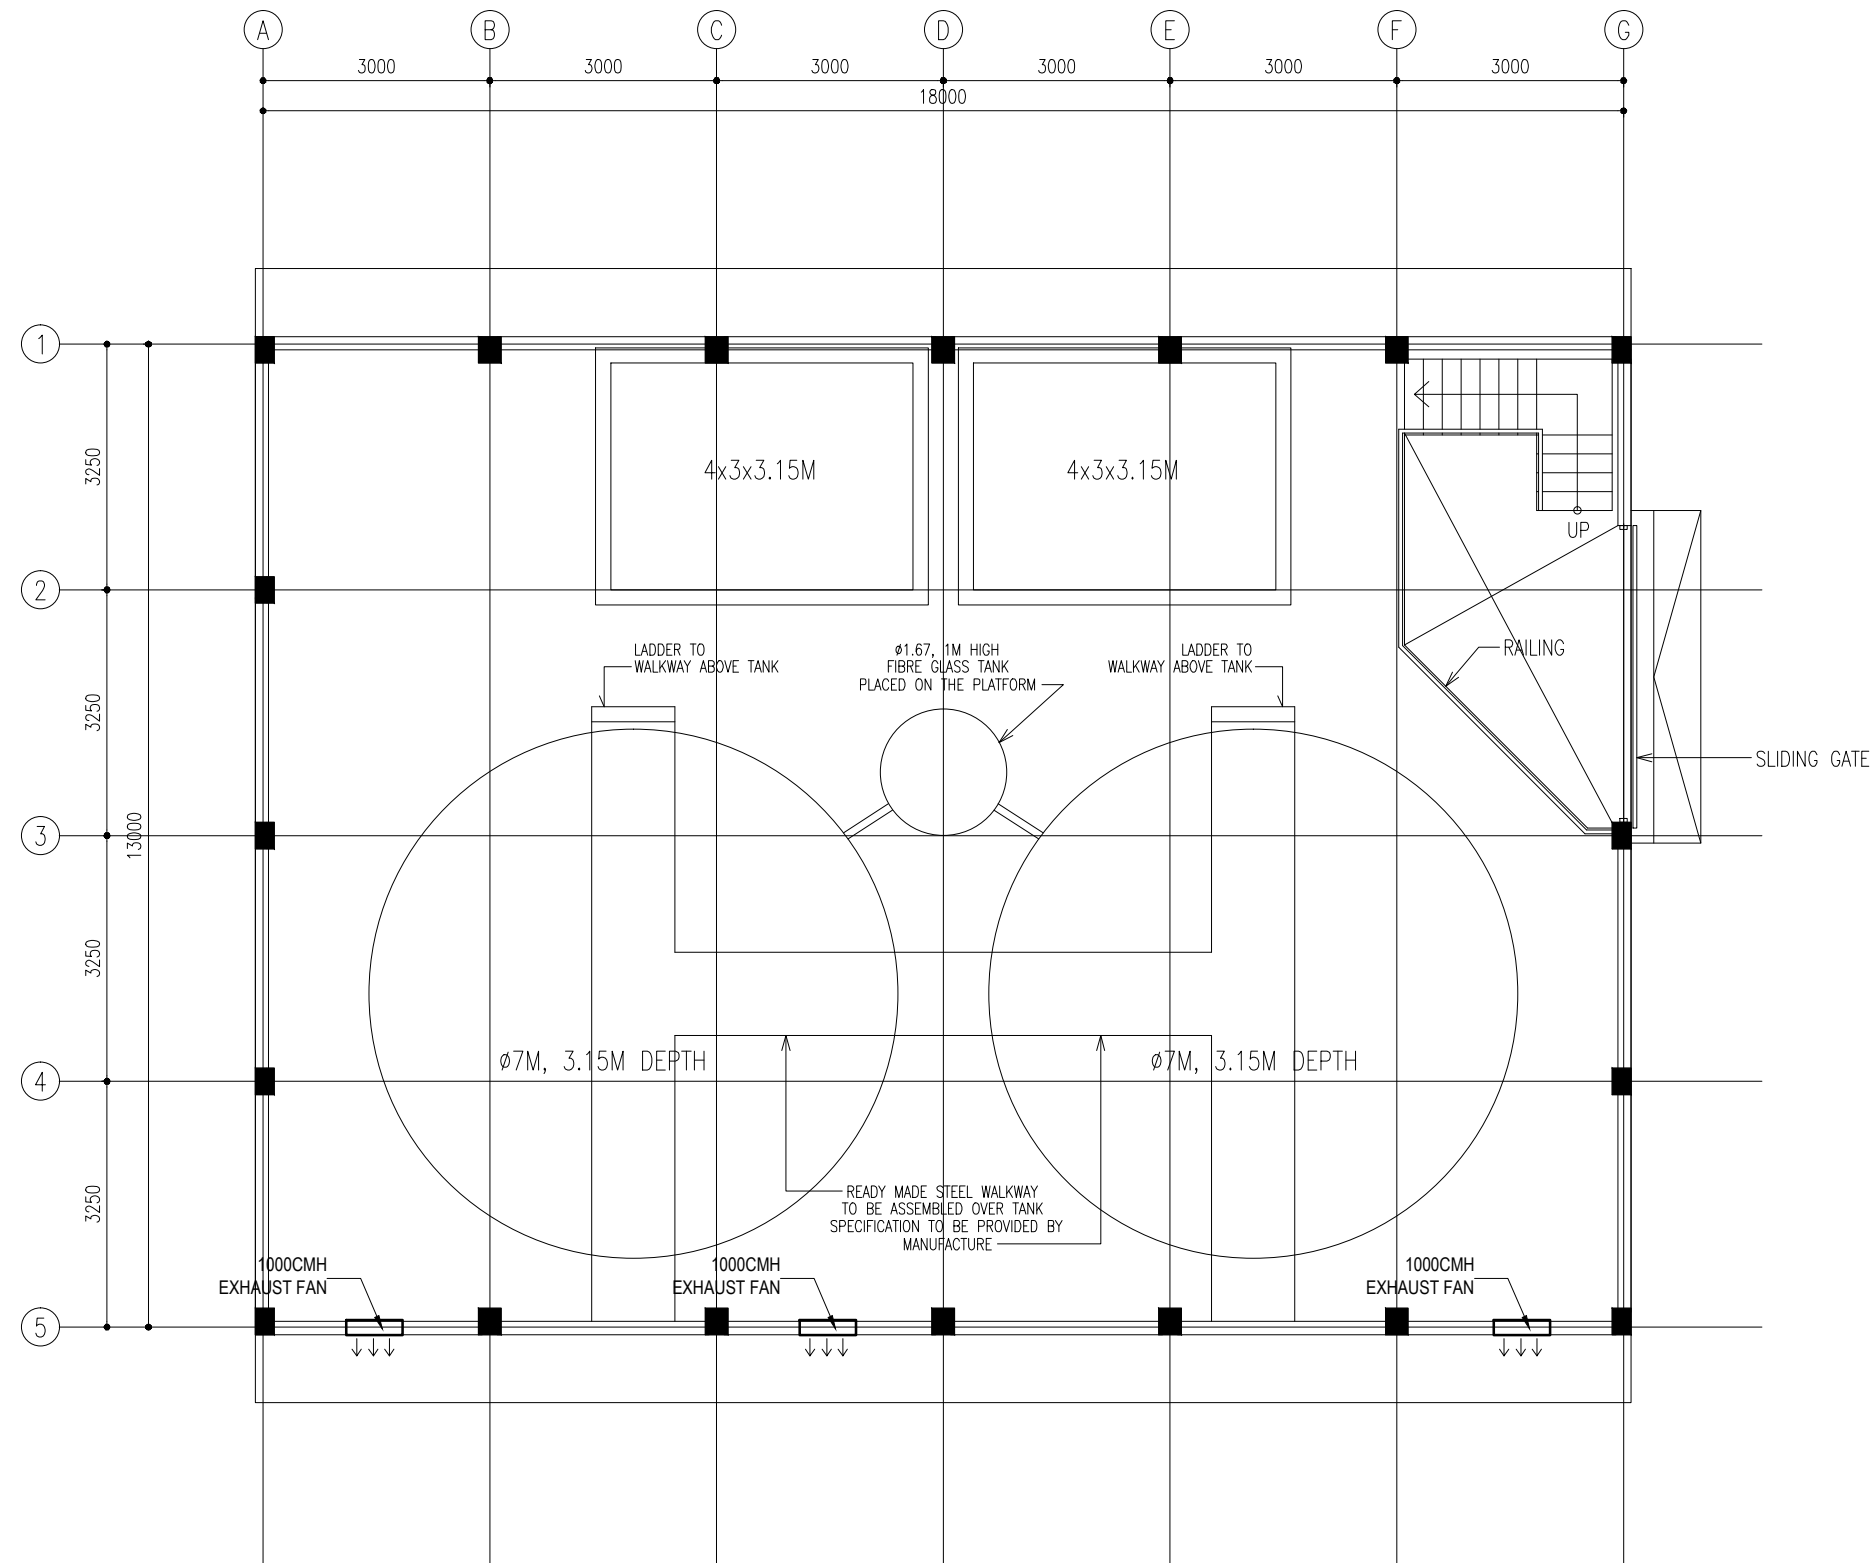

## ACMV SYSTEMS LAYOUT

SCALE 1:100

PROJECT: BROOD STOCK

CLIENT: MINISTRY OF FISHERIES & AGRI

DATE: APRIL 2018

DO NOT SCALE THE DRAWING

ARCHITECTURAL DESIGN

DESIGNED BY: - HUSSAIN ZIYATH


STRUCTURAL DESIGN

DESIGNED BY: - ADAM SAANEEZ

DWG NO:

M&E-04/05

**CHARRETTE**  
STUDIO

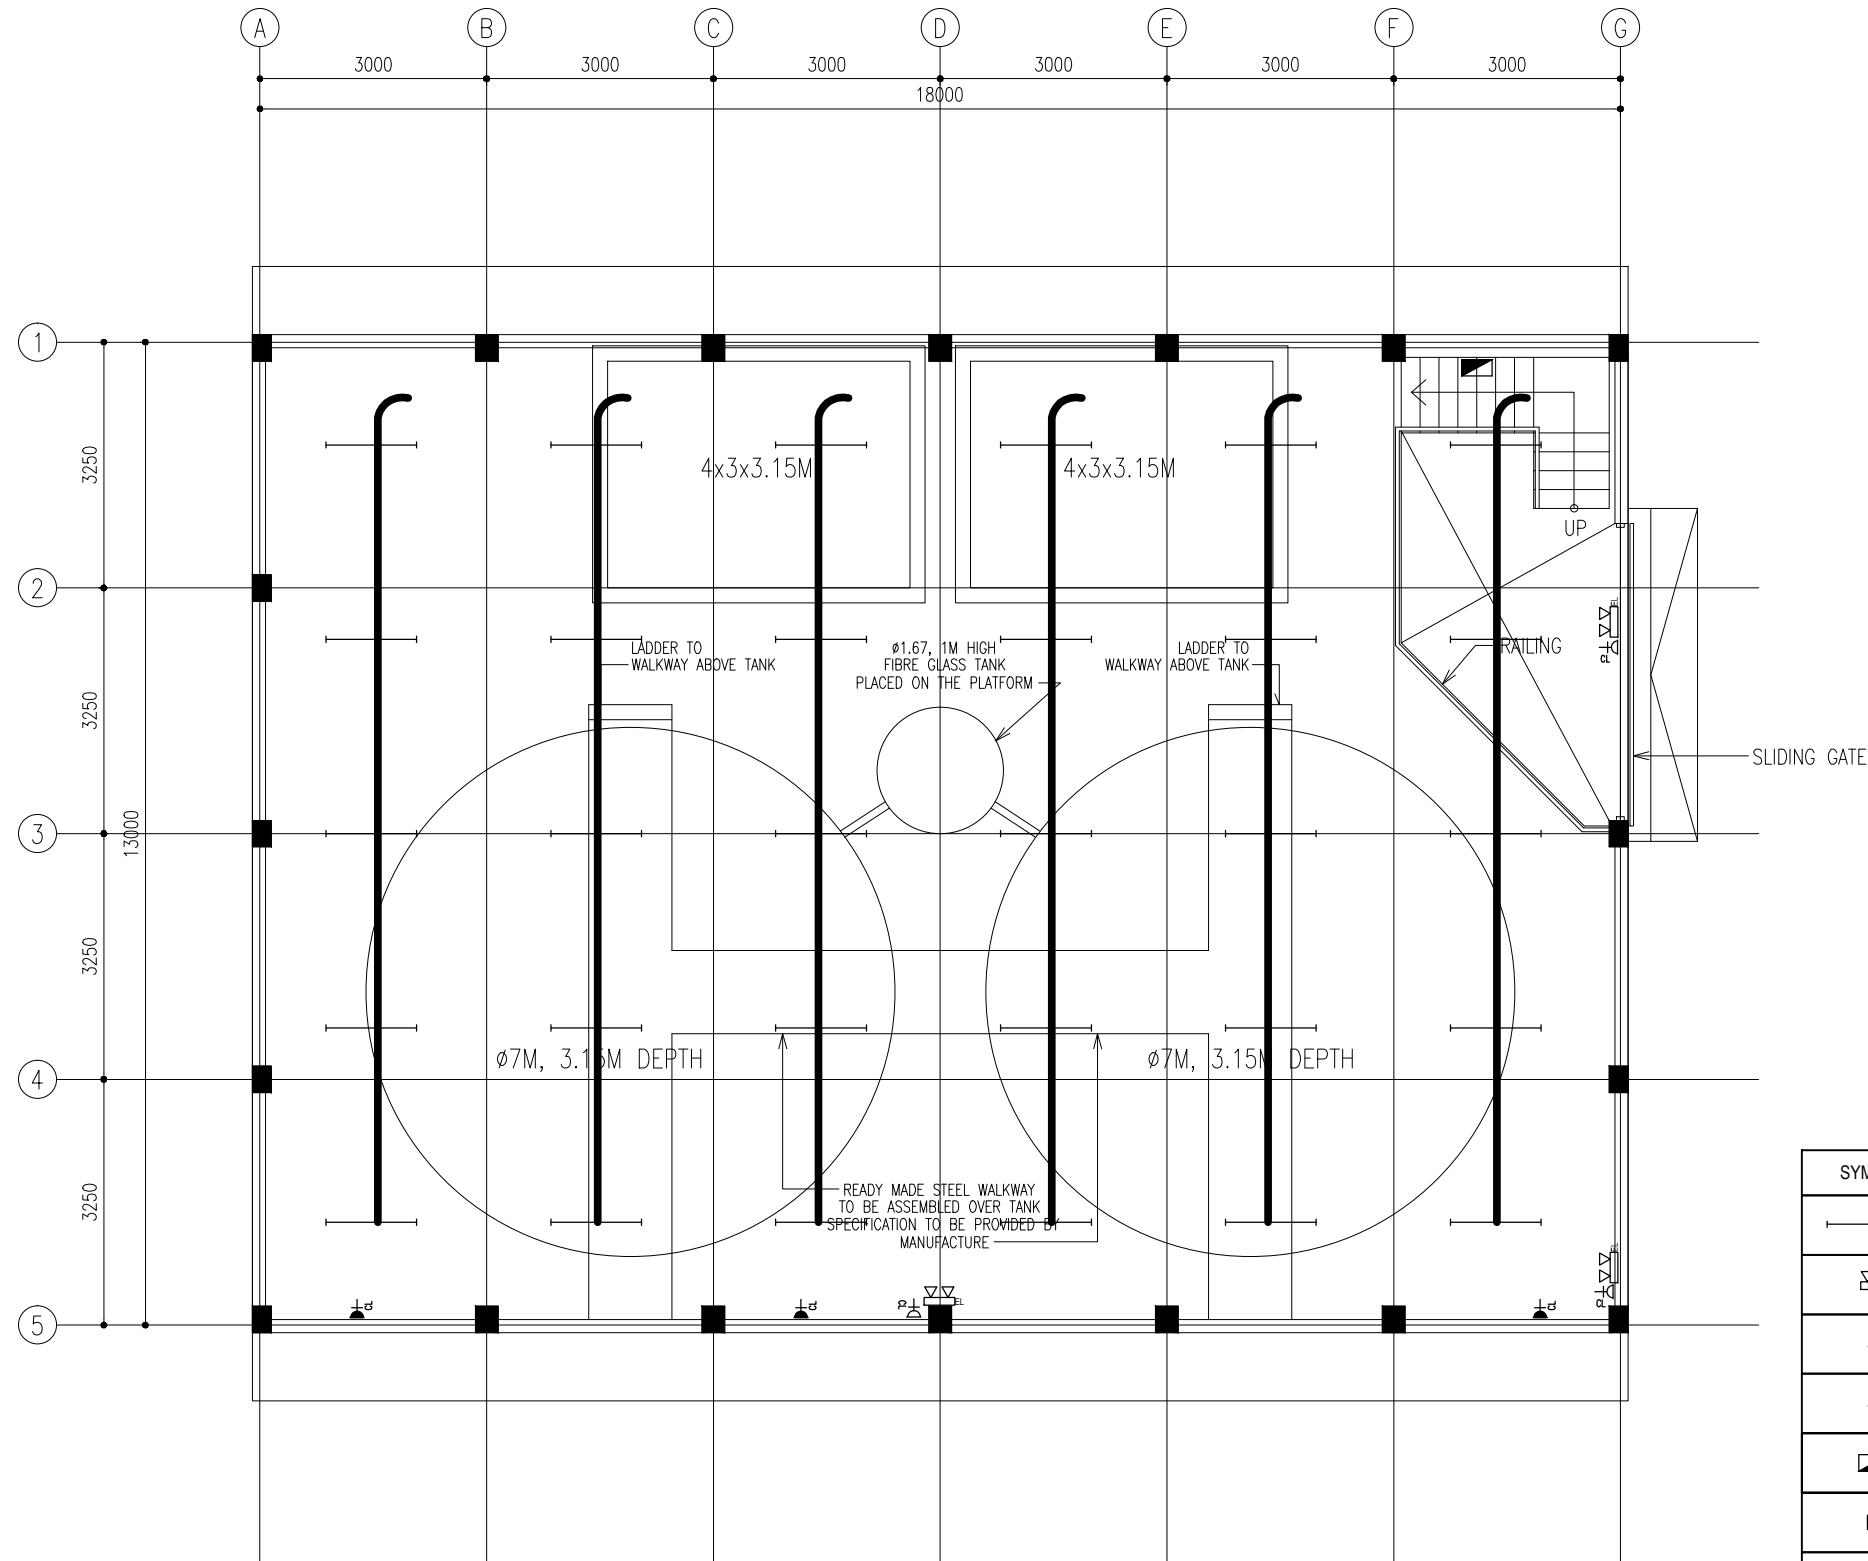

| SYMBOL | DESCRIPTION   |
|--------|---|
|        | 2X36W FLUORESCENT LAMP IN PENDANT MOUNT LUMINAIRE WITH DIFFUSER                   |
|        | EMERGENCY LIGHT WITH 2-HR BATTERY PACK  |
|        | 1GANG 1 WAY SWITCH  |
|        | 2GANG 1 WAY SWITCH  |
|        | DISTRIBUTION BOARD  |
|        | 2 GANG13A SOCKET OUTLET AT 1200mm ABOVE FINISHED FLOOR LEVEL (WEATHER PROOF TYPE) |
|        | 1 GANG15A SOCKET OUTLET AT CEILING LEVEL  |
|        | 1 GANG13A SOCKET OUTLET AT CEILING LEVEL  |

ELECTRICAL SYSTEMS LAYOUT

SCALE 1:100

PROJECT: BROOD STOCK  
CLIENT: MINISTRY OF FISHERIES & AGRI  
DATE: APRIL 2018  
DO NOT SCALE THE DRAWING

ARCHITECTURAL DESIGN  
DESIGNED BY: - HUSSAIN ZIYATH

STRUCTURAL DESIGN  
DESIGNED BY: - ADAM SAANEEZ

DWG NO:

M&E-05/05

CHARRETTE  
STUDIO