



Island Expert

PRIVATE LIMITED  
Rep of Maldives, Male'  
H. Maaram Building, 3 Floor  
2nd Floor  
www.island-expert.com

Description	Date

Project Manager

Mr. Anon Songpanya

Structure Engineers


Electrical Engineers

Mr. Pongsaree Dongnunungkun

Cooperate Design

Miss. Darawan Jaturavitkul

Project Name

Housing Project Maldive

Drawing Title


Miss. Angkana Marknokon

Drawing No.

Checker.

Approved.

16/09/2014

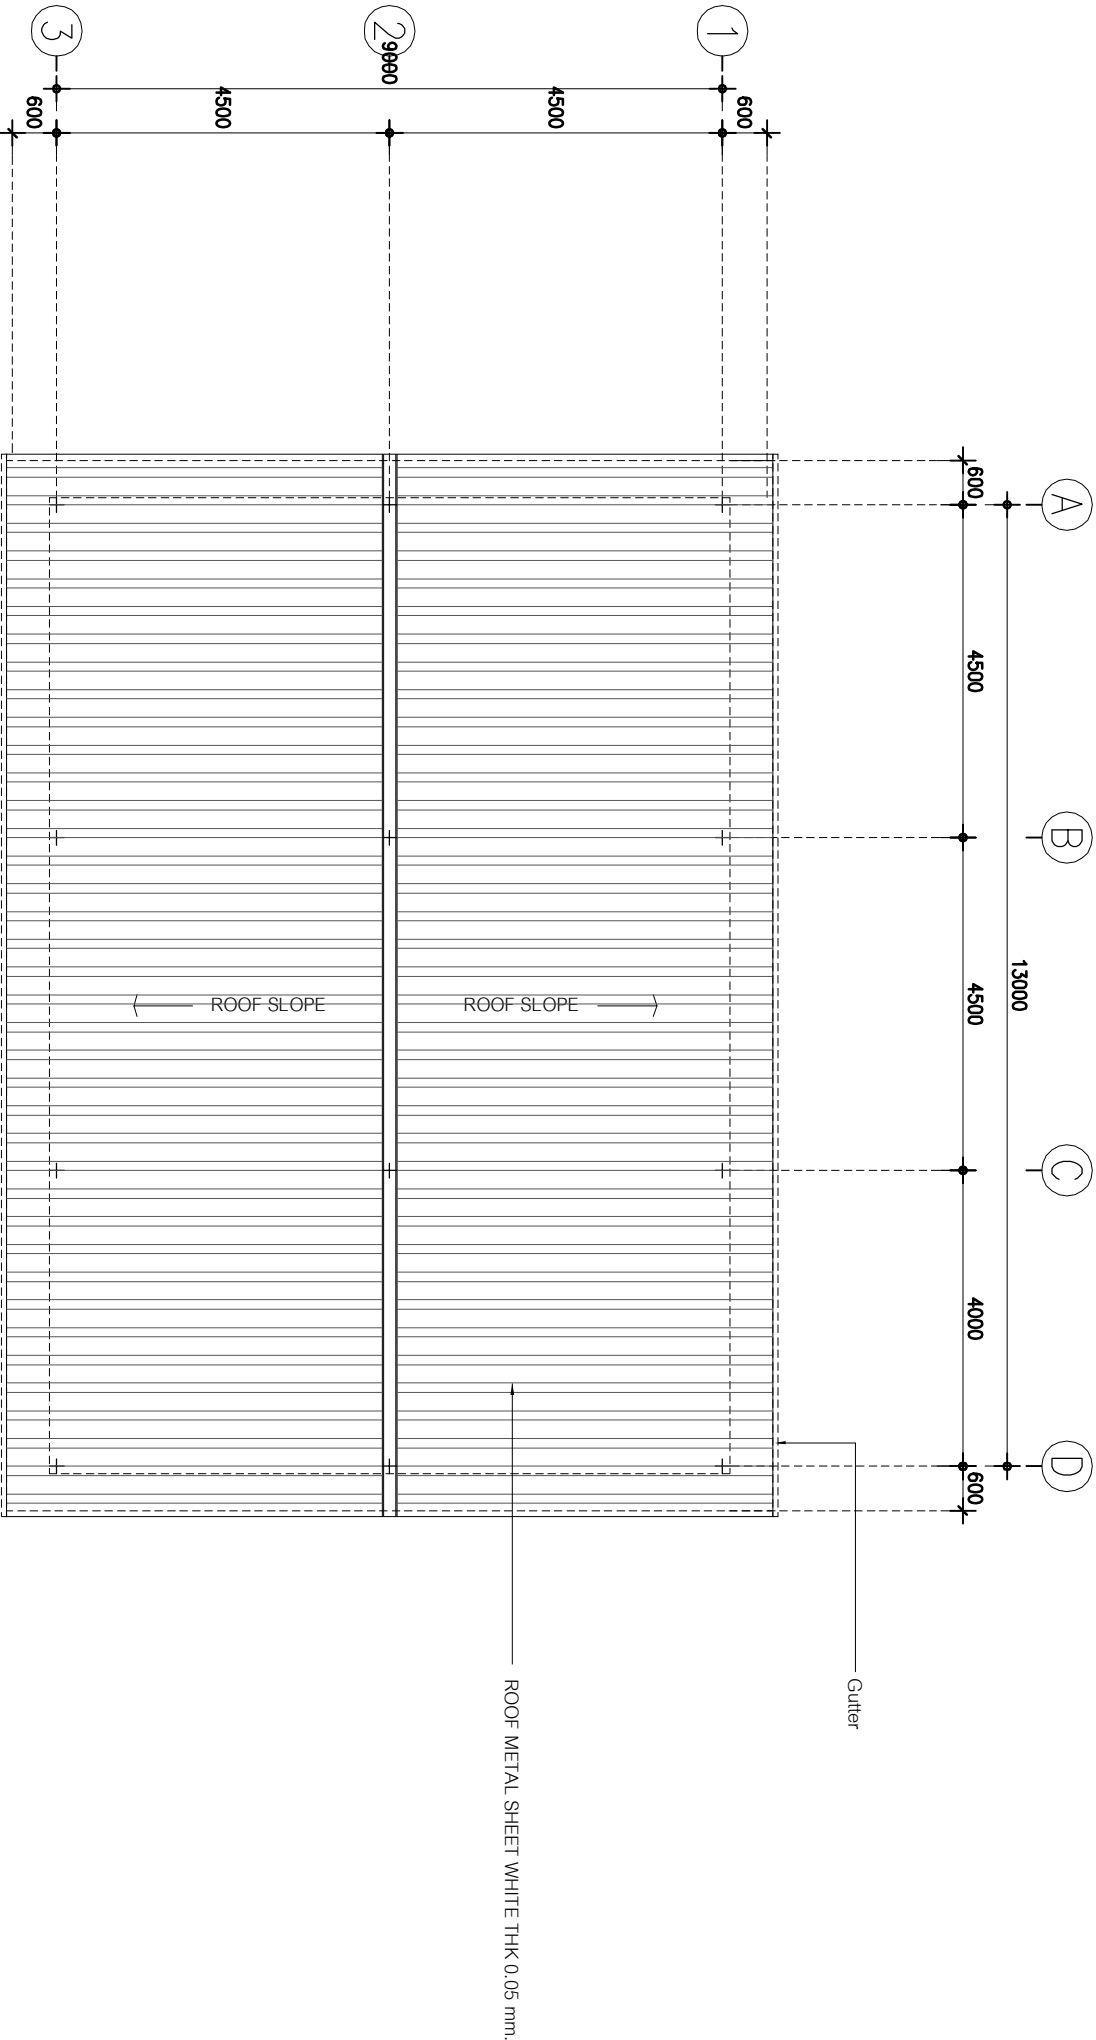

ROOF PLAN

SCALE

1 : 100

