




FENCE ELEVATION
SCALE 1: 50

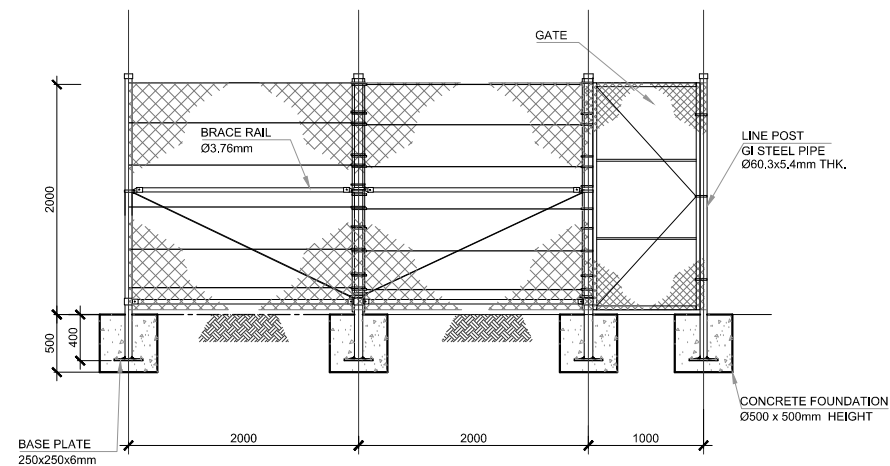


FRONT ELEVATION
SCALE 1: 50

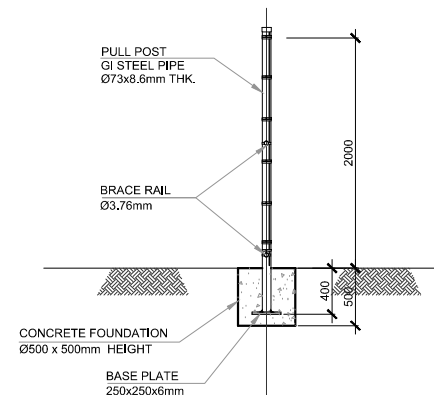


SECTIONAL VIEW
SCALE 1: 50

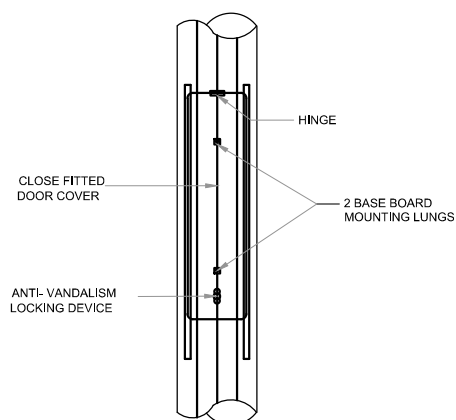


HINGED SERVICE DOOR
SCALE 1: 25

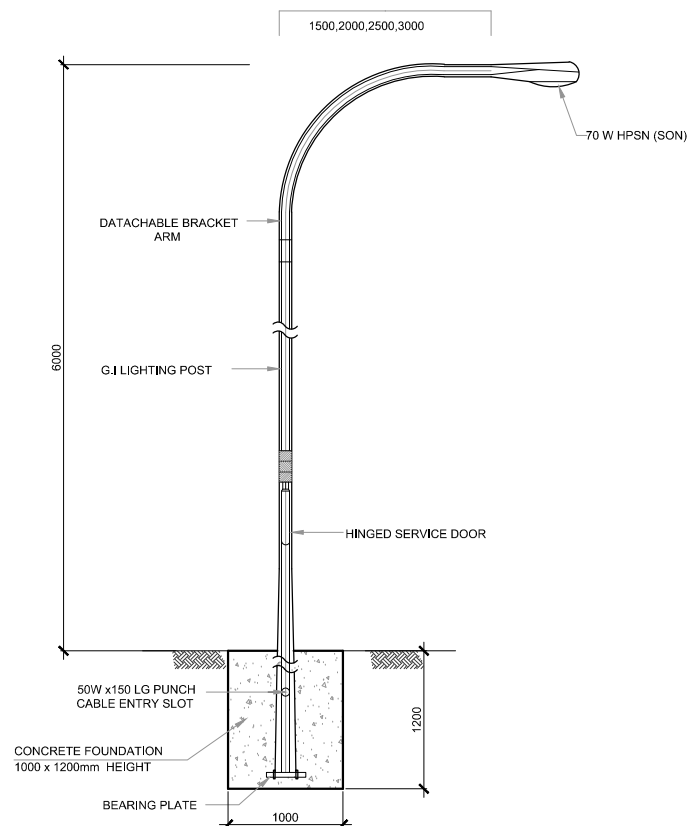


**PLANTER TYPE
COMPOUND LIGHTING**
SCALE 1: 50

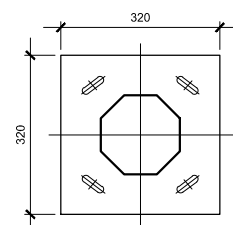

BASE FLANGE
SCALE 1: 25

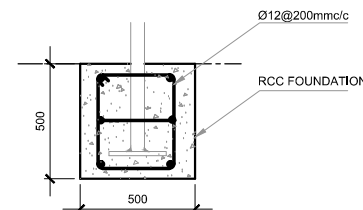

FOUNDATION
SCALE 1: 25

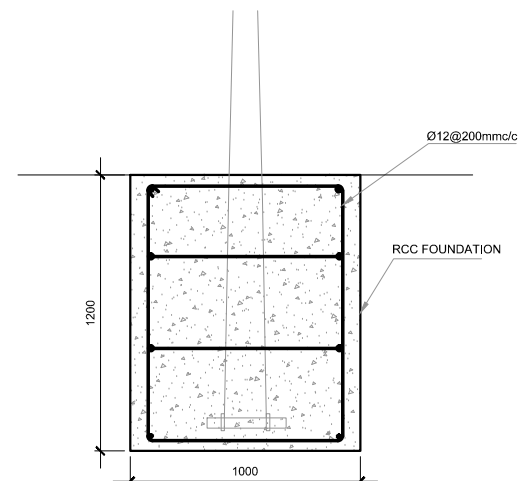

FOUNDATION COMPOUND LIGHT
SCALE 1: 25

NOTES:-

1. ALL DIMENSIONS SHOWN ARE IN MILLIMETERS (MM), UNLESS OTHERWISE SHOWN
2. ALL LEVELS SHOWN ARE IN METERS. ALL LEVELS SHOWN ARE FROM MEAN SEA LEVEL
3. THIS DRAWING TO BE READ IN CONJUNCTION WITH ALL OTHER RELEVANT DRAWINGS, GENERAL NOTES AND SPECIFICATIONS.

REFERENCE DRAWINGS

SL.No	DRAWING No.	DESCRIPTION

0	15-09-15	DETAILED DESIGN SUBMISSION	JP	SS	MA
REV.	DATE	DESCRIPTION	DRAWN	CHKD.	APPRD.

REVISION

CLIENT	MINISTRY OF ENVIRONMENT & ENERGY REPUBLIC OF MALDIVES
CONSULTANT:	استشاري مكتب الحبشي للاستشارات الهندسية Al-Habshi Consultants Office Tel.: 2430103 / 2433131 - Fax : 2431136 P.O.Box 27154 Safat 13132 - Kuwait

PROJECT:
Provision of Water Supply Facilities in 04 islands and Sewerage Facilities in 05 islands - GDH.Gadhdhoo Island - Republic of Maldives

DRAWING TITTLE:
FENCE DETAILS
COMPACT SEWAGE TREATMENT PLANT

DESIGNED	DRAWN	CHECKED	APPROVED	SCALE	DATE
SK	JP	SS	MA	AS SHOWN	15.09.15
PROJECT No.	SHEET No.	DRAWING No.			
K-619	1 OF 1	GG-SW -122			
REV. No.	0				