

LEGEND:

SYMBOL	QUANTITY	DESCRIPTION
▷PH	04 44	TELEPHONE OUTLET
▷	06 00	SINGLE CABLE NETWORK OUTLET
▷▷	11 48	DUAL CABLE NETWORK OUTLET
+	00 03	WIFI AP
●	12 03	CCTV POINT
⊕	06 10	PA SYSTEM
▬	01 04	NETWORK RACK
■	00 01	DOOR ACCESS CONTROL SYSTEM

9 STOREY ACCOMMODATION BUILDING

BANDAARA KOSHI / MALE'

SHEET CONTENT:

RECOM. APPROVAL:

CPT. AHMED SHARIM
OFFICER COMMANDING

DESIGN APPROVAL:

BRIG.GEN.AHMED SHAHID
VICE CHIEF OF DEFENCE FORCE

APPROVED:

MAJ.GEN. AHMED SHIYAM
CHIEF OF DEFENCE FORCE

APPROVED DATE:

DESIGNED:

PTE MOHAMED SAIF
L.CPL ALI MUTHASIM
Architectural

WO1 AHMED SHAZEEL
Structural

CHECKED:

CPT MOHAMED SHIFAAU
Architectural

WO3 AIMINATH ALI
Structural

Electrical & Mechanical Communication

DRAWN:

PTE MOHAMED SAIF
L.CPL ALI MUTHASIM

07/08/2016

REVISION:

PTE YAMIN SAEED
PTE HUSSAIN QASIM

25/01/2017

SCALE:


1:200

SHEET NO:




MILITARY ENGINEERS
MALDIVES NATIONAL DEFENCE FORCE
Male', Republic of Maldives

The drawings, concept and design contained are the properties of Military Engineers MNDF . Use of any kind or copy of whole or part of this drawing, concept or design or use on other projects or sites other than that specified on this drawing is strictly prohibited.

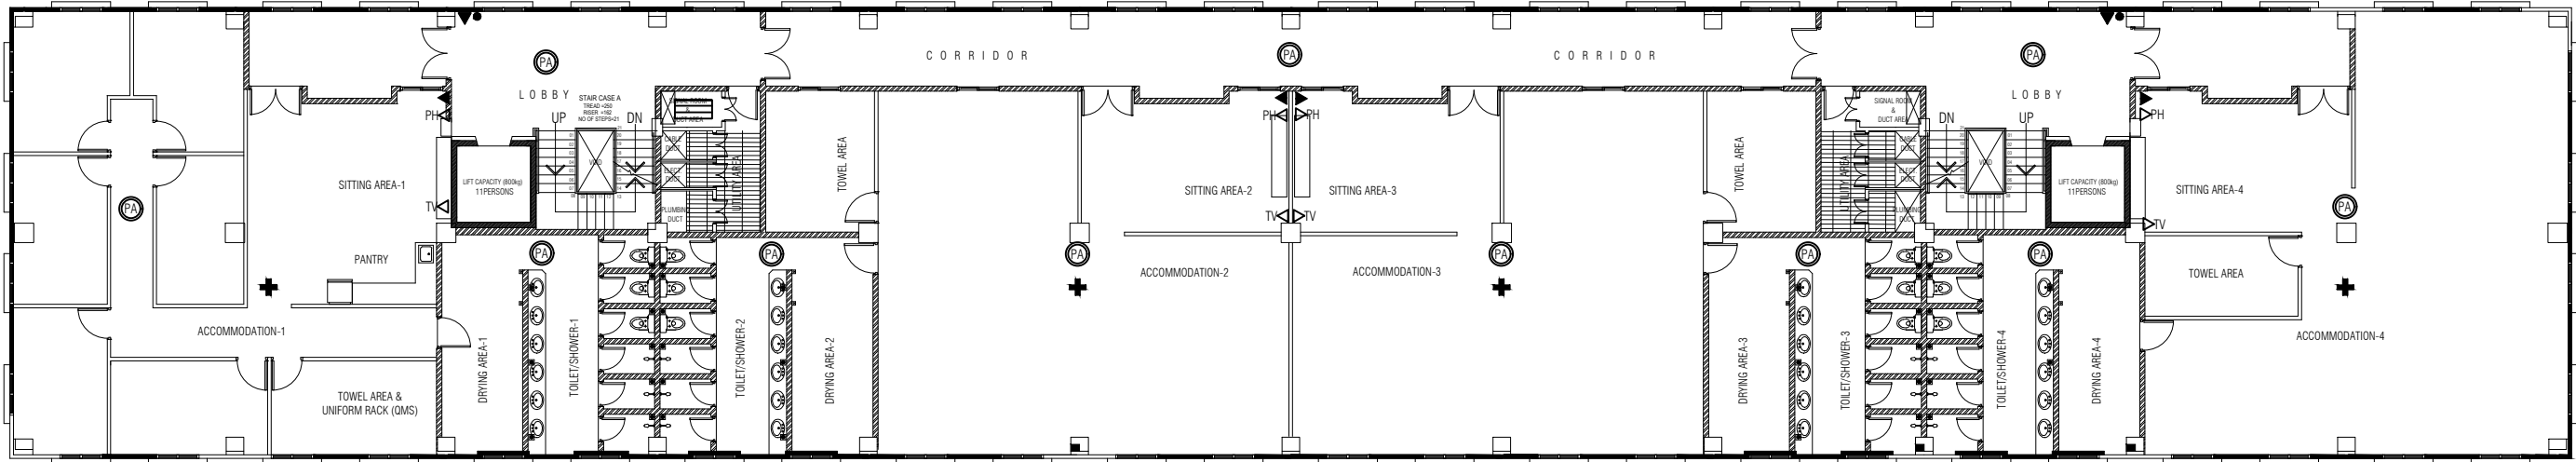

SECOND FLOOR
COMMUNICATION LAYOUT
SCALE 1:200

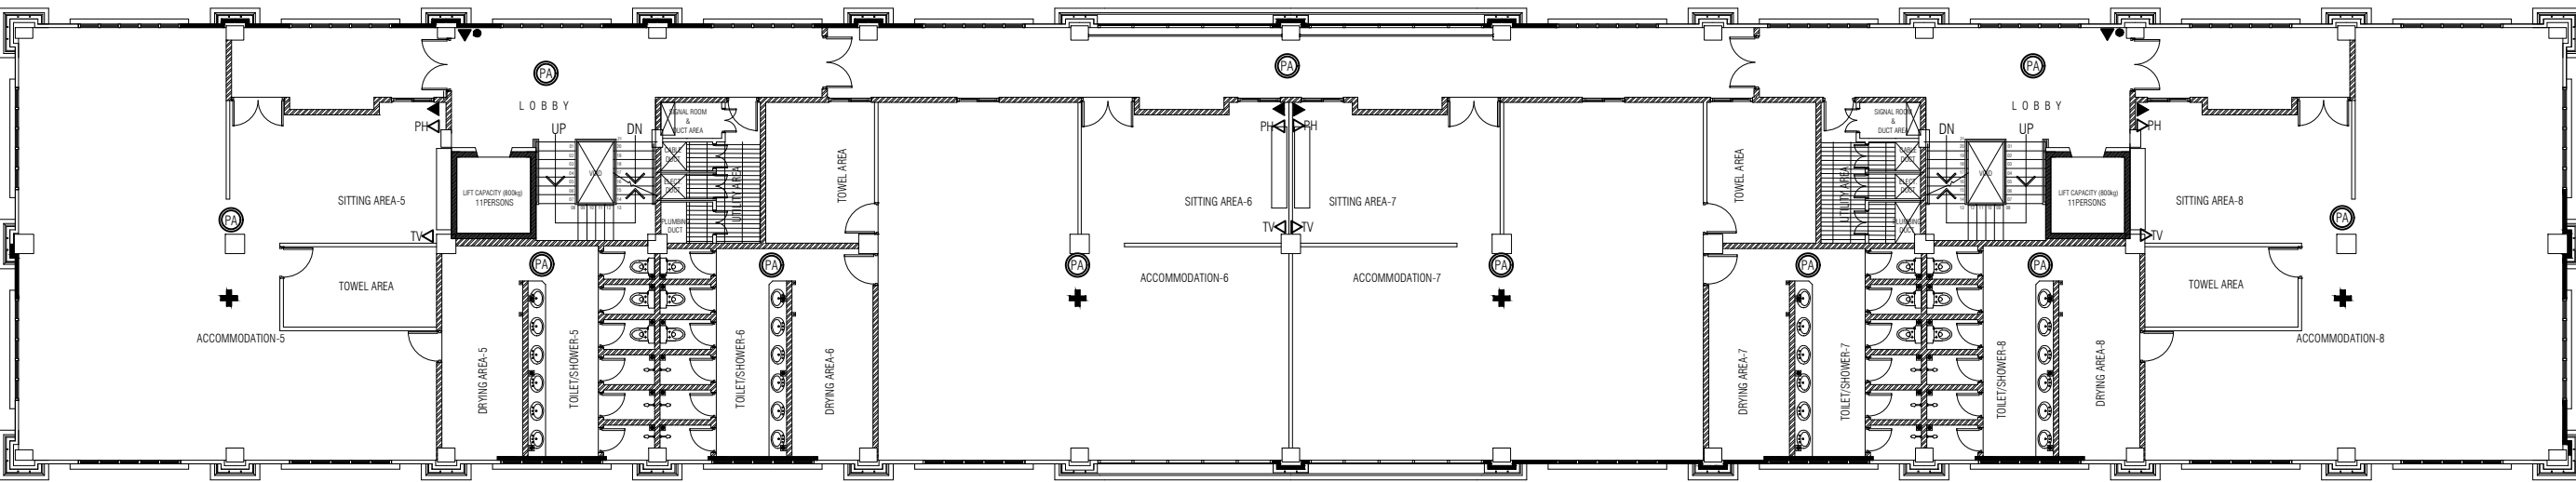

THIRD FLOOR
COMMUNICATION LAYOUT
SCALE 1:200

LEGEND:

SYMBOL	QUANTITY	DESCRIPTION
TV	04	CATV OUTLET
PH	04	TELEPHONE OUTLET
▽	06	DUAL CABLE NETWORK OUTLET
+	04	WIFI AP
●	02	CCTV POINT
⊙	11	PA SYSTEM
▮	01	NETWORK RACK

9 STOREY ACCOMMODATION BUILDING

BANDAARA KOSHI / MALE'

SHEET CONTENT:

RECOM. APPROVAL:

CPT. AHMED SHARIM
OFFICER COMMANDING

DESIGN APPROVAL:

BRIG.GEN.AHMED SHAHID
VICE CHIEF OF DEFENCE FORCE

APPROVED:

MAJ.GEN. AHMED SHIYAM
CHIEF OF DEFENCE FORCE

APPROVED DATE:

DESIGNED:

PTE MOHAMED SAIF
L.CPL ALI MUTHASIM
Architectural

WO1 AHMED SHAZEEL
Structural

CHECKED:

CPT MOHAMED SHIFAAU
Architectural

WO3 AIMINATH ALI
Structural

Electrical & Mechanical Communication

DRAWN:

PTE MOHAMED SAIF
L.CPL ALI MUTHASIM

07/08/2016

REVISION:

PTE YAMIN SAEED
PTE HUSSAIN QASIM

25/01/2017

SCALE:


1:200

SHEET NO:




MILITARY ENGINEERS
MALDIVES NATIONAL DEFENCE FORCE
Male', Republic of Maldives

The drawings, concept and design contained are the properties of Military Engineers MNDF . Use of any kind or copy of whole or part of this drawing, concept or design or use on other projects or sites other than that specified on this drawing is strictly prohibited.

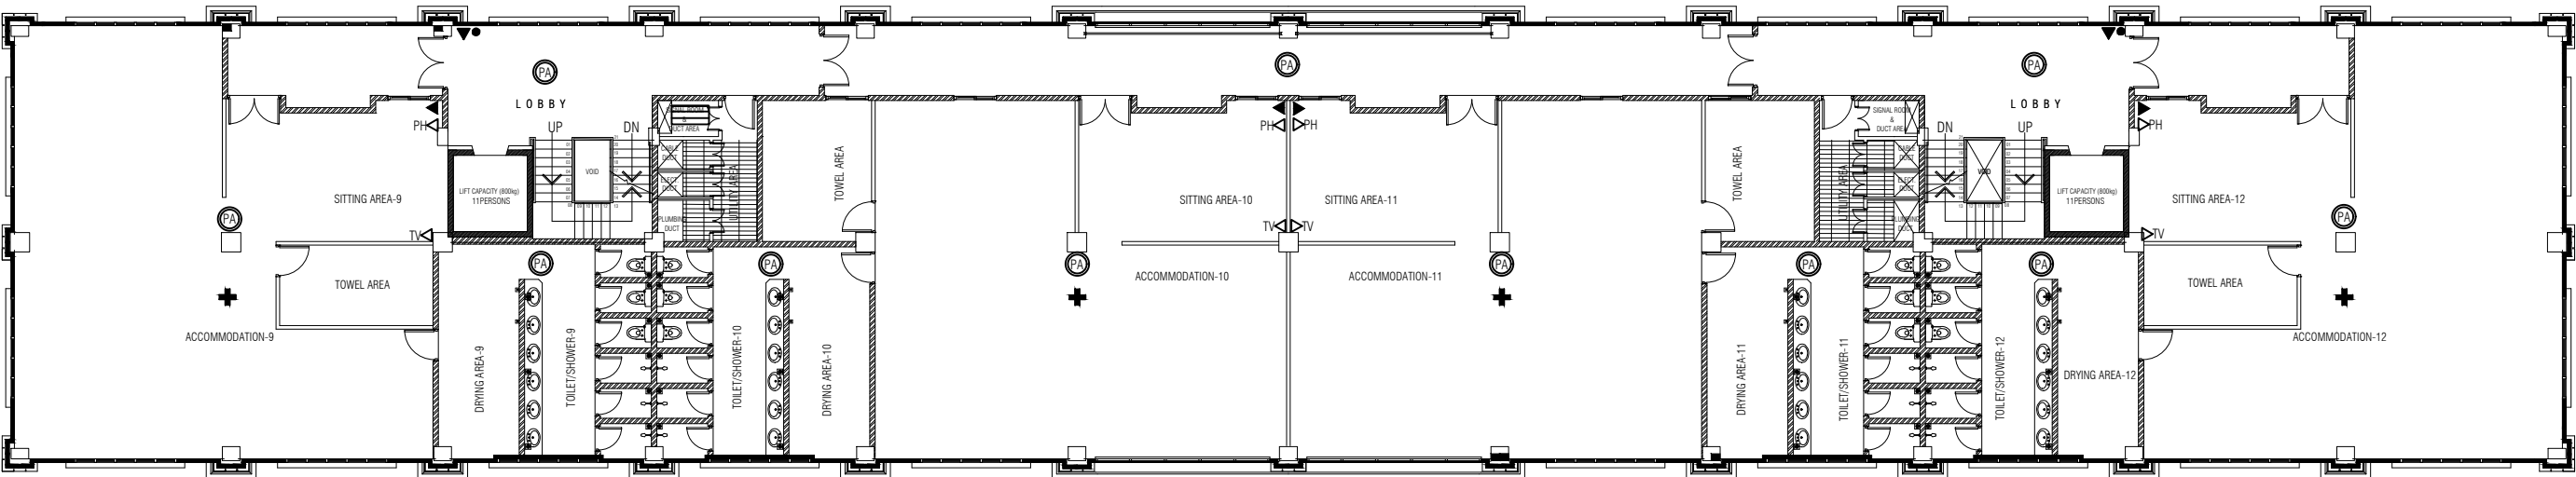

FOURTH FLOOR
COMMUNICATION LAYOUT
SCALE 1:200

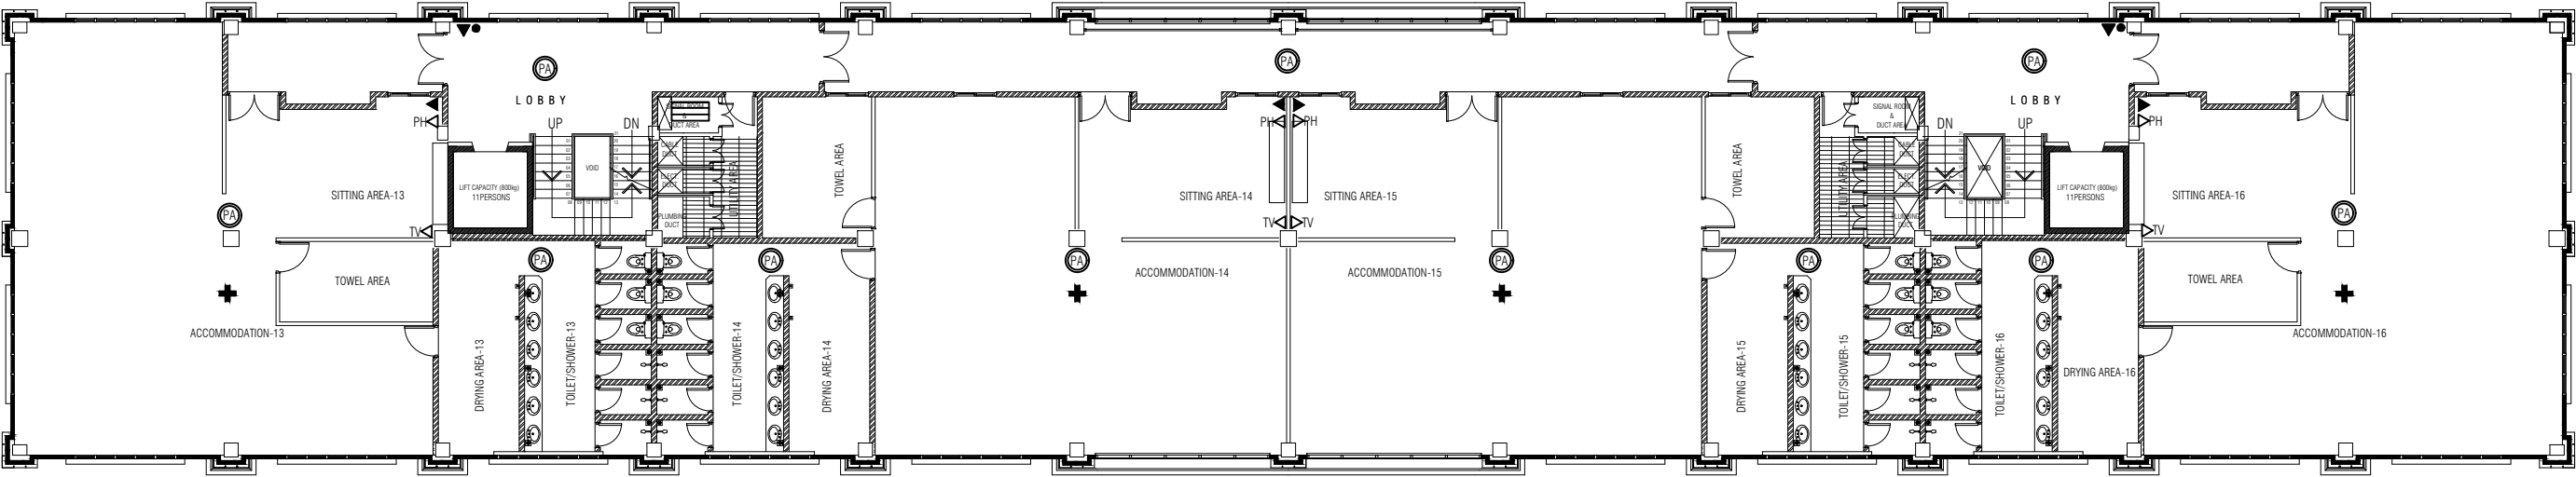

FIFTH & SIXTH FLOOR
COMMUNICATION LAYOUT
SCALE 1:200

LEGEND:

SYMBOL	QUANTITY			DESCRIPTION
	4TH	5TH	6TH	
TV	04	04	04	CATV OUTLET
PH	04	04	04	TELEPHONE OUTLET
▼	06	06	06	DUAL CABLE NETWORK OUTLET
+	04	04	04	WIFI AP
●	02	02	02	CCTV POINT
⊙	11	11	17	PA SYSTEM
▮	01	00	01	NETWORK RACK

9 STOREY ACCOMMODATION BUILDING

BANDAARA KOSHI / MALE'

SHEET CONTENT:

RECOM. APPROVAL:

CPT. AHMED SHARIM
OFFICER COMMANDING

DESIGN APPROVAL:

BRIG.GEN.AHMED SHAHID
VICE CHIEF OF DEFENCE FORCE

APPROVED:

MAJ.GEN. AHMED SHIYAM
CHIEF OF DEFENCE FORCE

APPROVED DATE:

DESIGNED:

PTE MOHAMED SAIF
L.CPL ALI MUTHASIM
Architectural

WO1 AHMED SHAZEEL
Structural

CHECKED:

CPT MOHAMED SHIFAAU
Architectural

WO3 AIMINATH ALI
Structural

Electrical & Mechanical Communication

DRAWN:

PTE MOHAMED SAIF
L.CPL ALI MUTHASIM

07/08/2016

REVISION:

PTE YAMIN SAEED
PTE HUSSAIN QASIM

25/01/2017

SCALE:


1:200

SHEET NO:




MILITARY ENGINEERS
MALDIVES NATIONAL DEFENCE FORCE
Male', Republic of Maldives

The drawings, concept and design contained are the properties of Military Engineers MNDF . Use of any kind or copy of whole or part of this drawing, concept or design or use on other projects or sites other than that specified on this drawing is strictly prohibited.

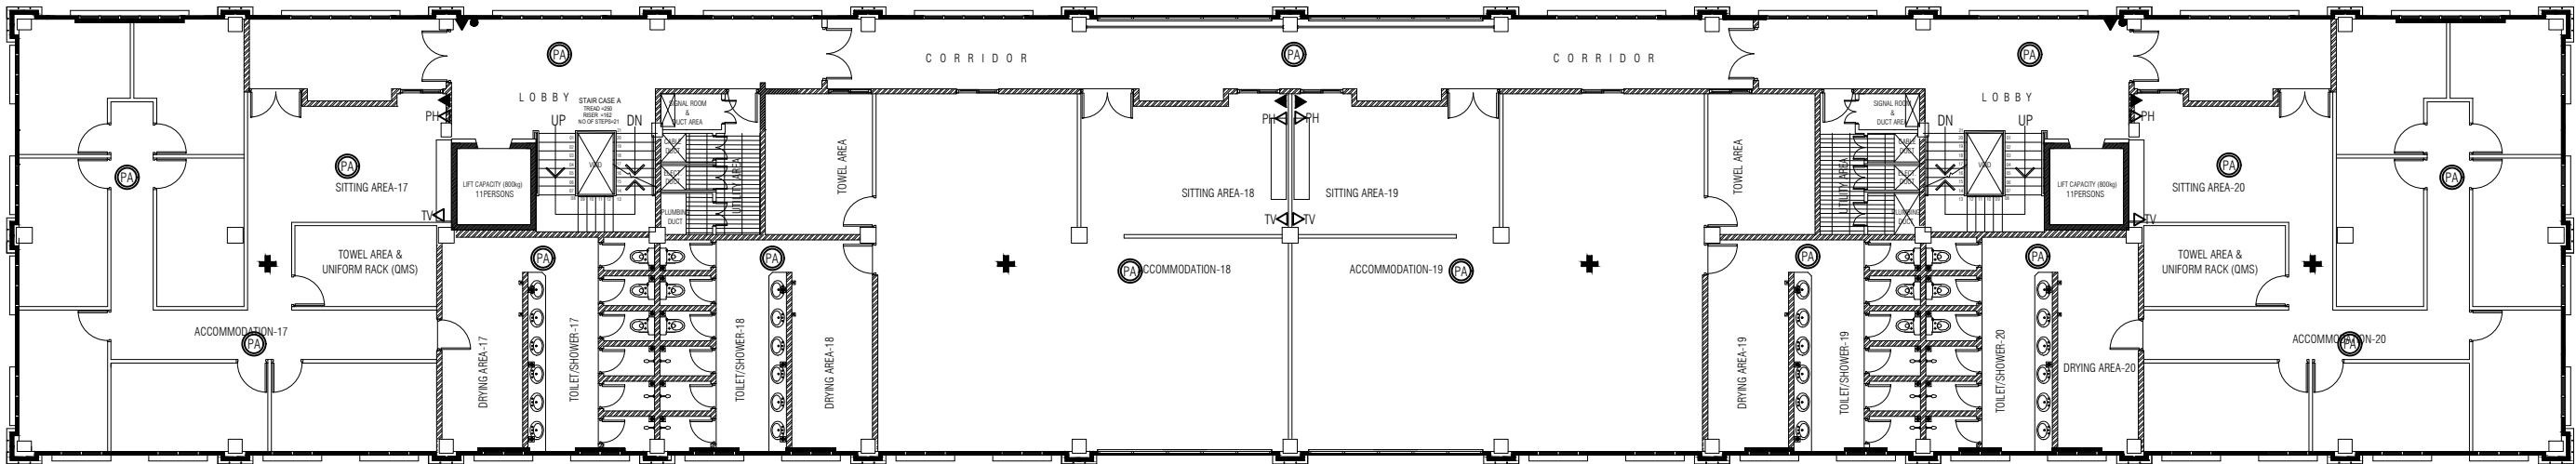



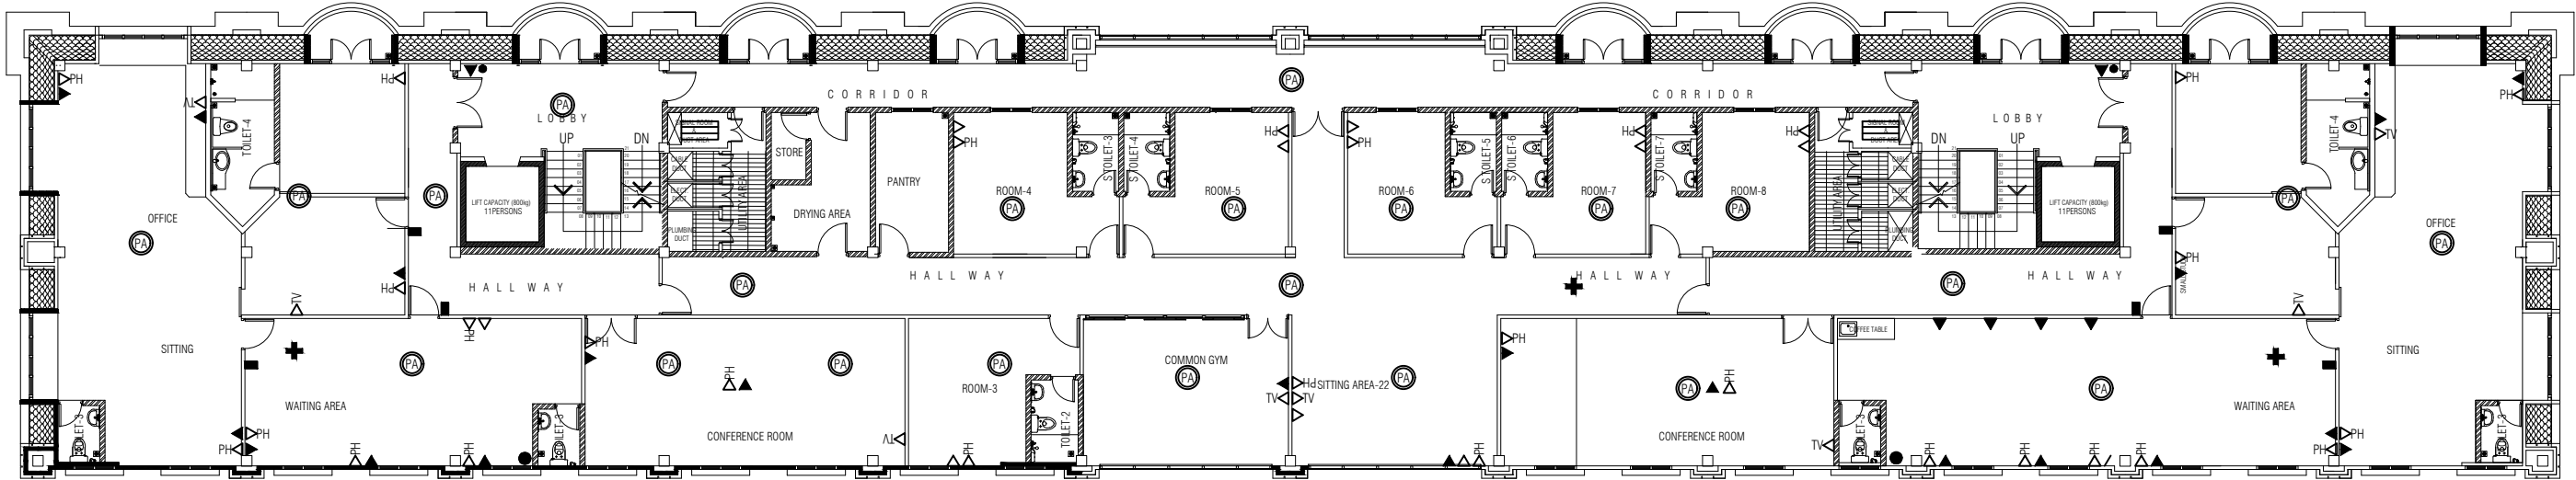






SEVENTH FLOOR
COMMUNICATION LAYOUT
SCALE 1:200



EIGHTH FLOOR
COMMUNICATION LAYOUT
SCALE 1:200

LEGEND:

SYMBOL	QUANTITY	DESCRIPTION
	7TH	8TH
	04	08 CATV OUTLET
	04	30 TELEPHONE OUTLET
	00	07 SINGLE CABLE NETWORK OUTLET
	08	27 DUAL CABLE NETWORK OUTLET
	04	04 WIFI AP
	02	04 CCTV POINT
	15	24 PA SYSTEM
	00	06 DOOR ACCESS CONTROL SYSTEM
	00	02 NETWORK RACK

9 STOREY ACCOMMODATION BUILDING

BANDAARA KOSHI / MALE'

SHEET CONTENT:

RECOM. APPROVAL:

CPT. AHMED SHARIM
OFFICER COMMANDING

DESIGN APPROVAL:

BRIG.GEN.AHMED SHAHID
VICE CHIEF OF DEFENCE FORCE

APPROVED:

MAJ.GEN. AHMED SHIYAM
CHIEF OF DEFENCE FORCE

APPROVED DATE:

DESIGNED:

PTE MOHAMED SAIF
L.CPL ALI MUTHASIM
Architectural

WO1 AHMED SHAZEEL
Structural

CHECKED:

CPT MOHAMED SHIFAAU
Architectural

WO3 AIMINATH ALI
Structural

Electrical & Mechanical Communication

DRAWN:

PTE MOHAMED SAIF
L.CPL ALI MUTHASIM

07/08/2016

REVISION:

PTE YAMIN SAEED
PTE HUSSAIN QASIM

25/01/2017

SCALE:


1:200

SHEET NO:



MILITARY ENGINEERS
MALDIVES NATIONAL DEFENCE FORCE
Male', Republic of Maldives

The drawings, concept and design contained are the properties of Military Engineers MNDF . Use of any kind or copy of whole or part of this drawing, concept or design or use on other projects or sites other than that specified on this drawing is strictly prohibited.

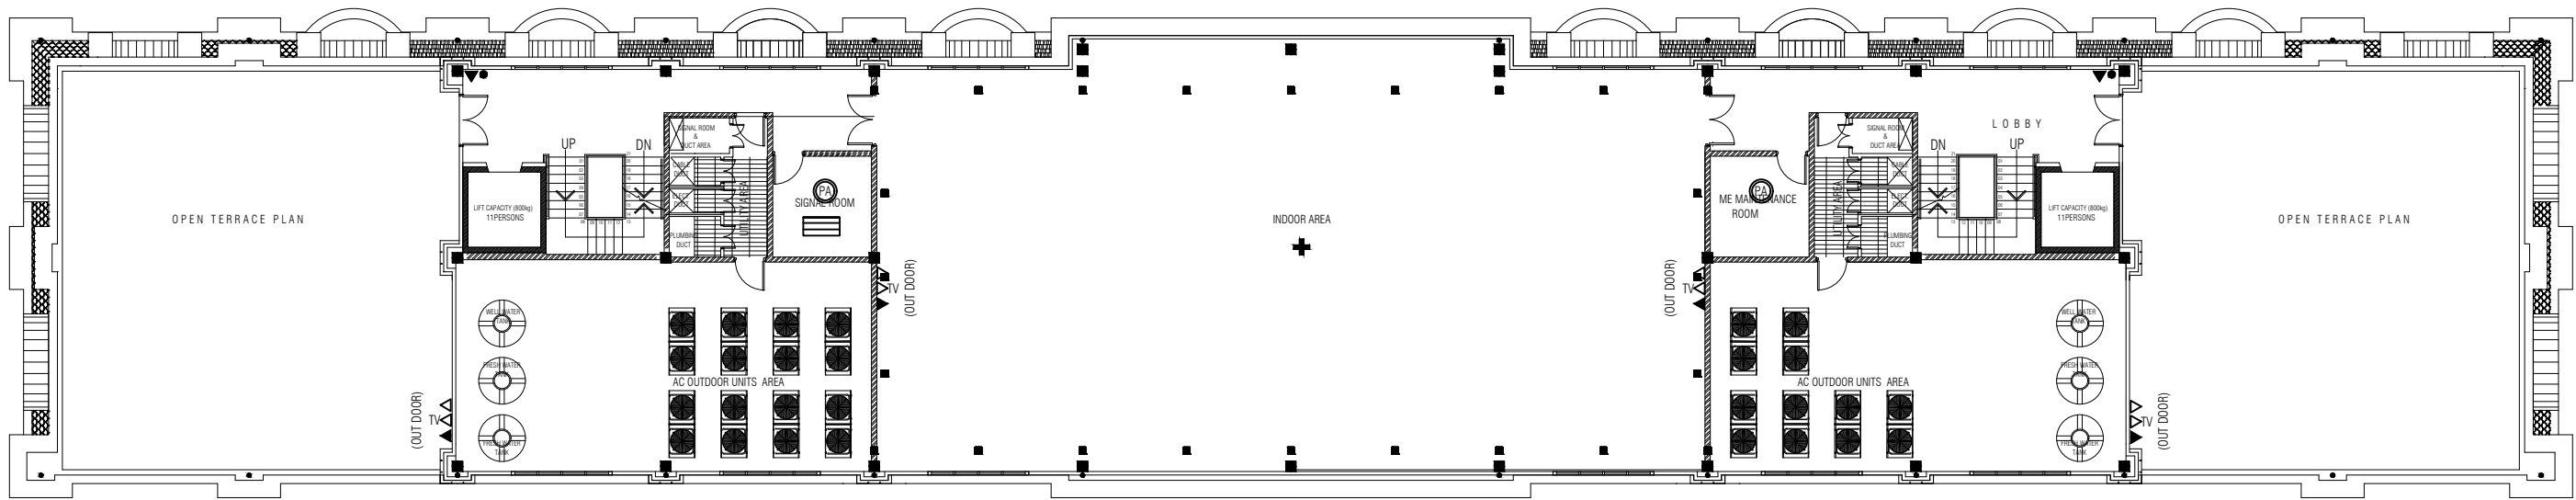

TERRACE FLOOR
COMMUNICATION LAYOUT
SCALE 1:200

LEGEND:

SYMBOL	QUANTITY	DESCRIPTION
▷TV	04	CATV OUTLET
▷	04	SINGLE CABLE NETWORK OUTLET
▷	06	DUAL CABLE NETWORK OUTLET
+	01	WIFI AP
●	02	CCTV POINT
⊙	02	PA SYSTEM
≡	01	NETWORK RACK

9 STOREY ACCOMMODATION BUILDING

BANDAARA KOSHI / MALE'

SHEET CONTENT:

RECOM. APPROVAL:

CPT. AHMED SHARIM
OFFICER COMMANDING

DESIGN APPROVAL:

BRIG.GEN.AHMED SHAHID
VICE CHIEF OF DEFENCE FORCE

APPROVED:

MAJ.GEN. AHMED SHIYAM
CHIEF OF DEFENCE FORCE

APPROVED DATE:

DESIGNED:

PTE MOHAMED SAIF
L.CPL ALI MUTHASIM
Architectural

WO1 AHMED SHAZEEL
Structural

CHECKED:

CPT MOHAMED SHIFAAU
Architectural

WO3 AIMINATH ALI
Structural

Electrical & Mechanical

Communication

DRAWN:

PTE MOHAMED SAIF
L.CPL ALI MUTHASIM

07/08/2016

SCALE:

1:200

REVISION:

PTE YAMIN SAEED
PTE HUSSAIN QASIM

25/01/2017

SHEET NO:



MILITARY ENGINEERS
MALDIVES NATIONAL DEFENCE FORCE
Male', Republic of Maldives

The drawings, concept and design contained are the properties of Military Engineers MNDf . Use of any kind or copy of whole or part of this drawing, concept or design or use on other projects or sites other than that specified on this drawing is strictly prohibited.