

PROPOSED SINGLE STOREY MOSQUE(500)

MALDIVES

ARCHITECTURAL DRAWINGS

28.02.2021

SIARCH
P R I V A T E L I M I T E D
LONUZIYAARAIY MAGU,MALE',20075,MALDIVES
EMAIL: I N F O @ S I A R C H . D E S I G N
H T T P / / : W W W . S I A R C H . D E S I G N

PROPOSED SINGLE STOREY MOSQUE ,MALDIVES

DRAWING INDEX

PROJECT CODE: COM-32

CLIENT: MINISTRY OF ISLAMIC AFFAIRS

BUILDING: MOSQUE 500

BUILDING CODE: MOS500

DWG FILE NAME: COM-32_MOSQUE500

				DRAWING TITLE				
BLDN.CODE.	DISC.	NO.	PDF FILE NAME	PRIMARY	SECONDARY	SCALE	FORMAT	DATE
ARCHITECTURAL								
MOS	AR	00	COM-32_AR00_A	DRAWING REGISTER		NTS	A3	28TH FEBRUARY 2020
MOS	AR	01	COM-32_AR01_A	LOCATION PLAN		1:200	A3	28TH FEBRUARY 2020
MOS	AR	02	COM-32_AR02_A	FOOT PRINT ORIENTATION		1:200	A3	28TH FEBRUARY 2020
MOS	AR	03	COM-32_AR03_A	LANDSCAPE PLAN		1:100	A2	28TH FEBRUARY 2020
MOS	AR	04	COM-32_AR04_A	FLOOR PLAN		1:100	A2	28TH FEBRUARY 2020
MOS	AR	05	COM-32_AR05_A	ROOF PLAN		1:100	A2	28TH FEBRUARY 2020
MOS	AR	06	COM-32_AR06_A	ELEVATIONS-E1, E2		1:100	A2	28TH FEBRUARY 2020
MOS	AR	07	COM-32_AR07_A	ELEVATIONS-E3, E4		1:100	A2	28TH FEBRUARY 2020
MOS	AR	08	COM-32_AR08_A	SECTIONS X-X , Y-Y		1:100	A2	28TH FEBRUARY 2020
MOS	AR	09	COM-32_AR09_A	MINERAT DETAILS 1		1:100	A3	28TH FEBRUARY 2020
MOS	AR	10	COM-32_AR10_A	MINERAT DETAILS 2		1:100	A3	28TH FEBRUARY 2020
MOS	AR	11	COM-32_AR11_A	DOOM DETAILS		1:50	A3	28TH FEBRUARY 2020
MOS	AR	12	COM-32_AR12_A	ARCHITECTURAL DETAILS 1		1:20	A3	28TH FEBRUARY 2020
MOS	AR	13	COM-32_AR13_A	MIMBAR DETAILS		1:20	A3	28TH FEBRUARY 2020
MOS	AR	14	COM-32_AR14_A	RAMP DETAILS		1:50	A3	28TH FEBRUARY 2020
MOS	AR	15	COM-32_AR15_A	ABLUTION PLAN		1:50	A3	28TH FEBRUARY 2020
MOS	AR	16	COM-32_AR16_A	ABLUTION SECTION		1:50	A3	28TH FEBRUARY 2020
MOS	AR	17	COM-32_AR17_A	ABLUTION DETAIL 1		1:10	A3	28TH FEBRUARY 2020
MOS	AR	18	COM-32_AR18_A	ABLUTION DETAIL 2		1:10	A3	28TH FEBRUARY 2020
MOS	AR	19	COM-32_AR19_A	DOOR AND WINDOW SCHEDULE 01		1:50	A3	28TH FEBRUARY 2020
MOS	AR	20	COM-32_AR20_A	DOOR AND WINDOW SCHEDULE 02		1:50	A3	28TH FEBRUARY 2020
MOS	AR	21	COM-32_AR21_A	ARC DETAILS 1		1:20	A3	28TH FEBRUARY 2020
MOS	AR	22	COM-32_AR22_A	ARC DETAILS 2		1:20	A3	28TH FEBRUARY 2020
STRUCTURAL								
MOS	ST	01	COM-32_ST01_A	FOUNDATION PLAN AND DETAILS	STRUCTURAL DETAILS	1:100 / 1:20	A2	28TH FEBRUARY 2020
MOS	ST	02	COM-32_ST02_A	COLUMN PLAN AND DETAILS	STRUCTURAL DETAILS	1:100 / 1:20	A2	28TH FEBRUARY 2020
MOS	ST	03	COM-32_ST03_A	BEAM AND SLAB PLAN DETAILS	STRUCTURAL DETAILS	1:100	A2	28TH FEBRUARY 2020
MOS	ST	04	COM-32_ST04_A	ROOF BEAM AND SLAB PLAN, DETAILS	STRUCTURAL DETAILS	1:100 / 1:20	A2	28TH FEBRUARY 2020
MOS	ST	05	COM-32_ST05_A	MINERAT DETAILS	STRUCTURAL DETAILS	1:50 / 1:20	A3	28TH FEBRUARY 2020
MEP								
MOS	MEP	01	COM-32_AC01_A	AC LAYOUT		1:100	A2	28TH FEBRUARY 2020
MOS	MEP	02	COM-32_LT01_A	LIGHTING LAYOUT		1:100	A2	28TH FEBRUARY 2020
MOS	MEP	03	COM-32_P001_A	POWER LAYOUT		1:100	A2	28TH FEBRUARY 2020


CLIENT:
MINISTRY OF ISLAMIC AFFAIRS

DESIGN AND CONSULTANCY:

SIARCH

P R I V A T E L I M I T E D
LONUZHARAIY MAGU,MALE',20075,MALDIVES
EMAIL: TN.F.O@SIARCH.DESIGN
HTTP://WWW.SIARCH.DESIGN

KEY PLAN:

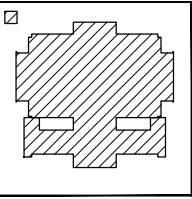

WARNING:

- This drawing shall not be used for construction unless certified.

- Contractor to verify all dimensions of existing works on site before commencing any work or preparing shop drawings.

- Do not scale drawings, use written dimensions only.

- This drawing is to be read in conjunction with the specifications and conditions of contract.

- This drawing and design is copyright and no portion may be reproduced without the permission of the Consultant

REVISIONS

NO	DESCRIPTION	DATE

PROJECT:

500 PAX
MOSQUE DESIGN

PHASE:

☐ CONCEPT DESIGN

☐ DESIGN DEVELOPMENT

☒ TENDER DOCUMENT

☐ FOR CONSTRUCTION

☐ AS BUILD DRAWINGS


DESIGNATION	NAME	SIGNATURE
PROJECT MANAGER	SIARCH PVT LTD	
STR. ENGINEER	HUSSAIN SHIHAN	
CHIEF ARCHITECT	MOHAMMED SHAMIN	
CHECKED	MOHAMED SIRAJ	
DRAWN	YASHIKA	

DWG. NAME:

ARCHITECTURAL


DRAWING INDEX

CODE	DATE	DWG. NO:
COM-32	28-02-21	AR00
FORMAT	A1 A2 A3	
SCALE	- - 1:100	ISSUE A
PDF FILE NAME:	COM-32_AR00_A	

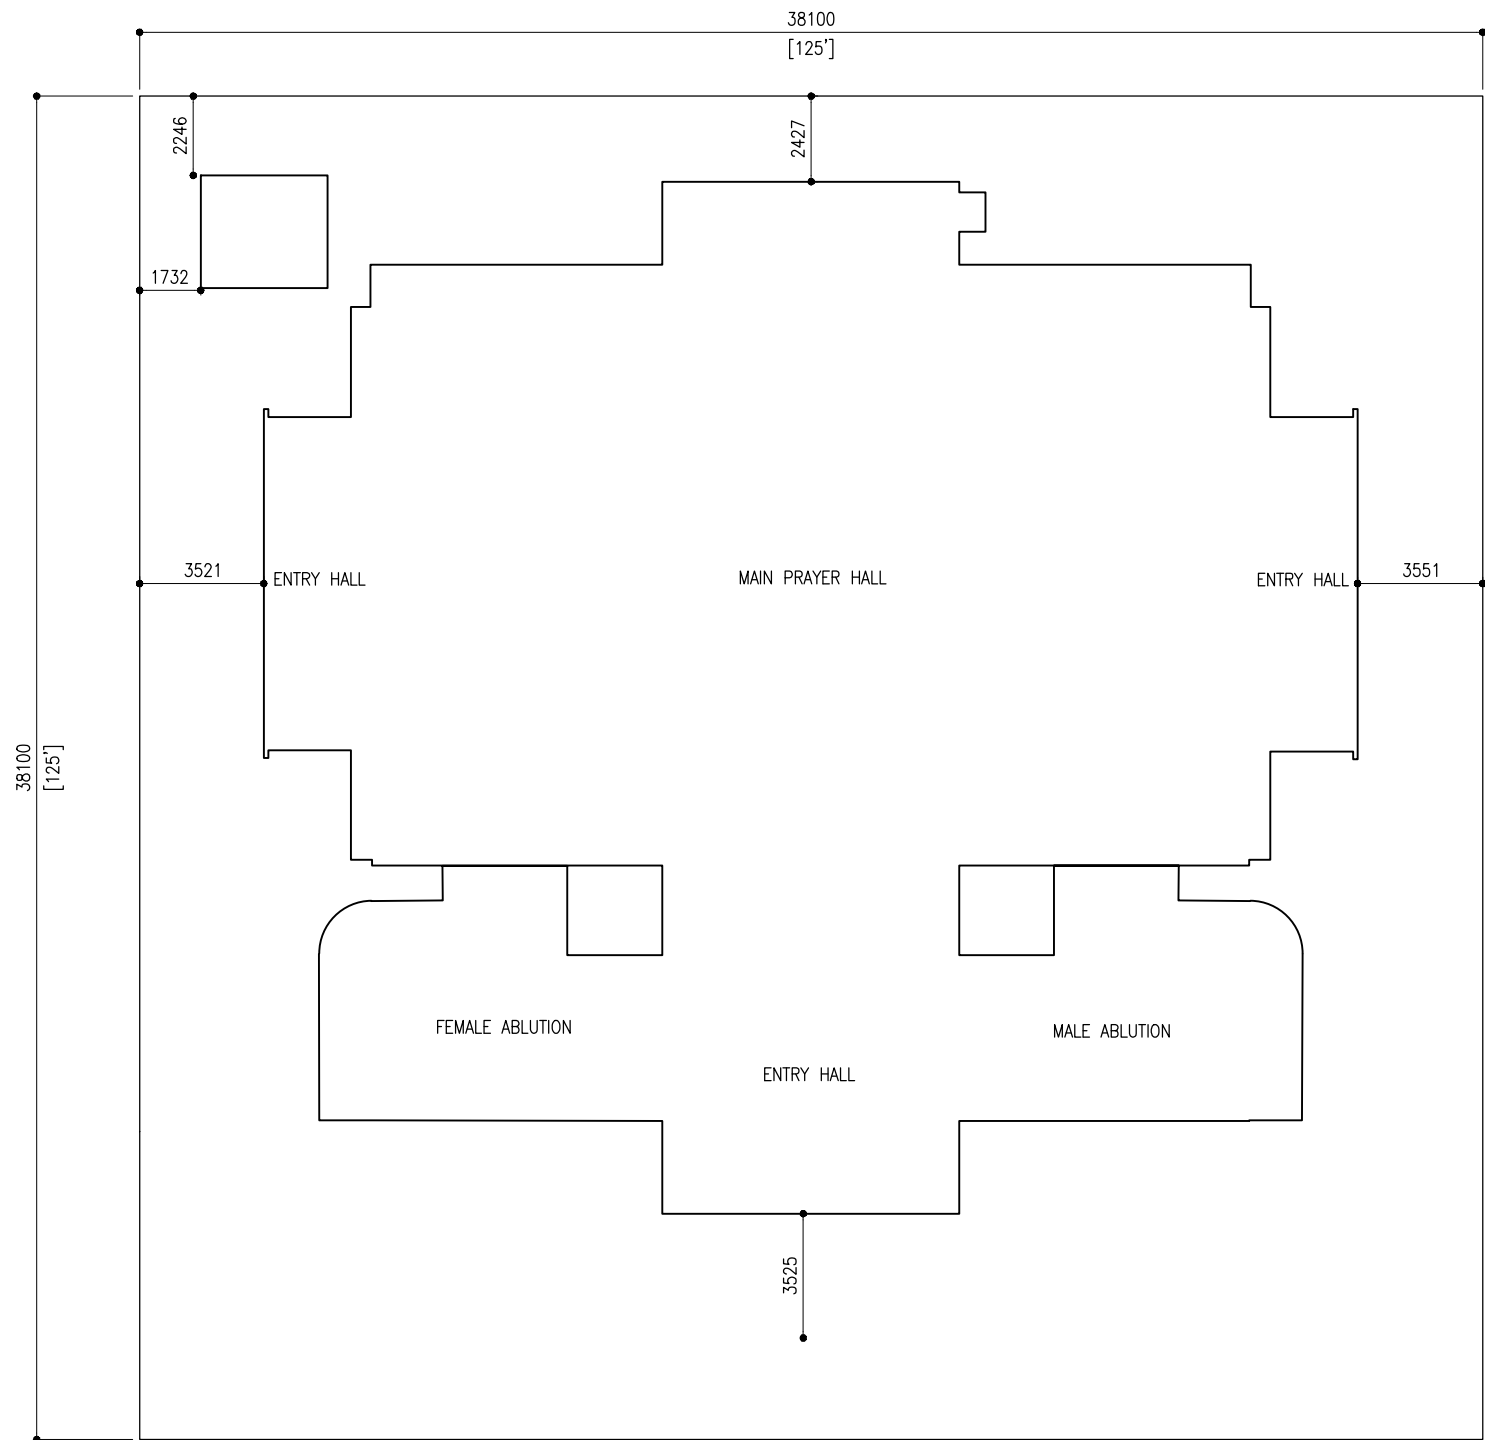

LOCATION PLAN

 SCALE 1:200



CLIENT:
MINISTRY OF ISLAMIC AFFAIRS

DESIGN AND CONSULTANCY:
SIARCH
PRIVATE LIMITED
LONZUYAARAY MAGU, MALE, 20075, MALDIVES
EMAIL: T.N.F.O@SIARCH.DESIGN
HTTP://WWW.SIARCH.DESIGN

KEY PLAN:

WARNING:

- This drawing shall not be used for construction unless certified.
- Contractor to verify all dimensions of existing works on site before commencing any work or preparing shop drawings.
- Do not scale drawings, use written dimensions only.
- This drawing is to be read in conjunction with the specifications and conditions of contract.
- This drawing and design is copyright and no portion may be reproduced without the permission of the Consultant

REVISIONS		
NO	DESCRIPTION	DATE

PROJECT:

500 PAX
MOSQUE DESIGN

PHASE:

- ☐ CONCEPT DESIGN
- ☐ DESIGN DEVELOPMENT
- ☒ TENDER DOCUMENT
- ☐ FOR CONSTRUCTION
- ☐ AS BUILD DRAWINGS


DESIGNATION	NAME	SIGNATURE
PROJECT MANAGER	SIARCH PVT. LTD	
STR. ENGINEER	HUSSAIN SHIHAN	
CHIEF ARCHITECT	MOHAMMED SHAMIN	
CHECKED	MOHAMMED SIRAJ	
DRAWN	YASHIKA	

DWG. NAME:

ARCHITECTURAL


LOCATION PLAN

CODE	DATE	DWG. NO:
COM-32	28-02-21	AR01
FORMAT	A2 A3	
SCALE	- - 1:200	ISSUE A
PDF FILE NAME: COM-32_AR01_A		

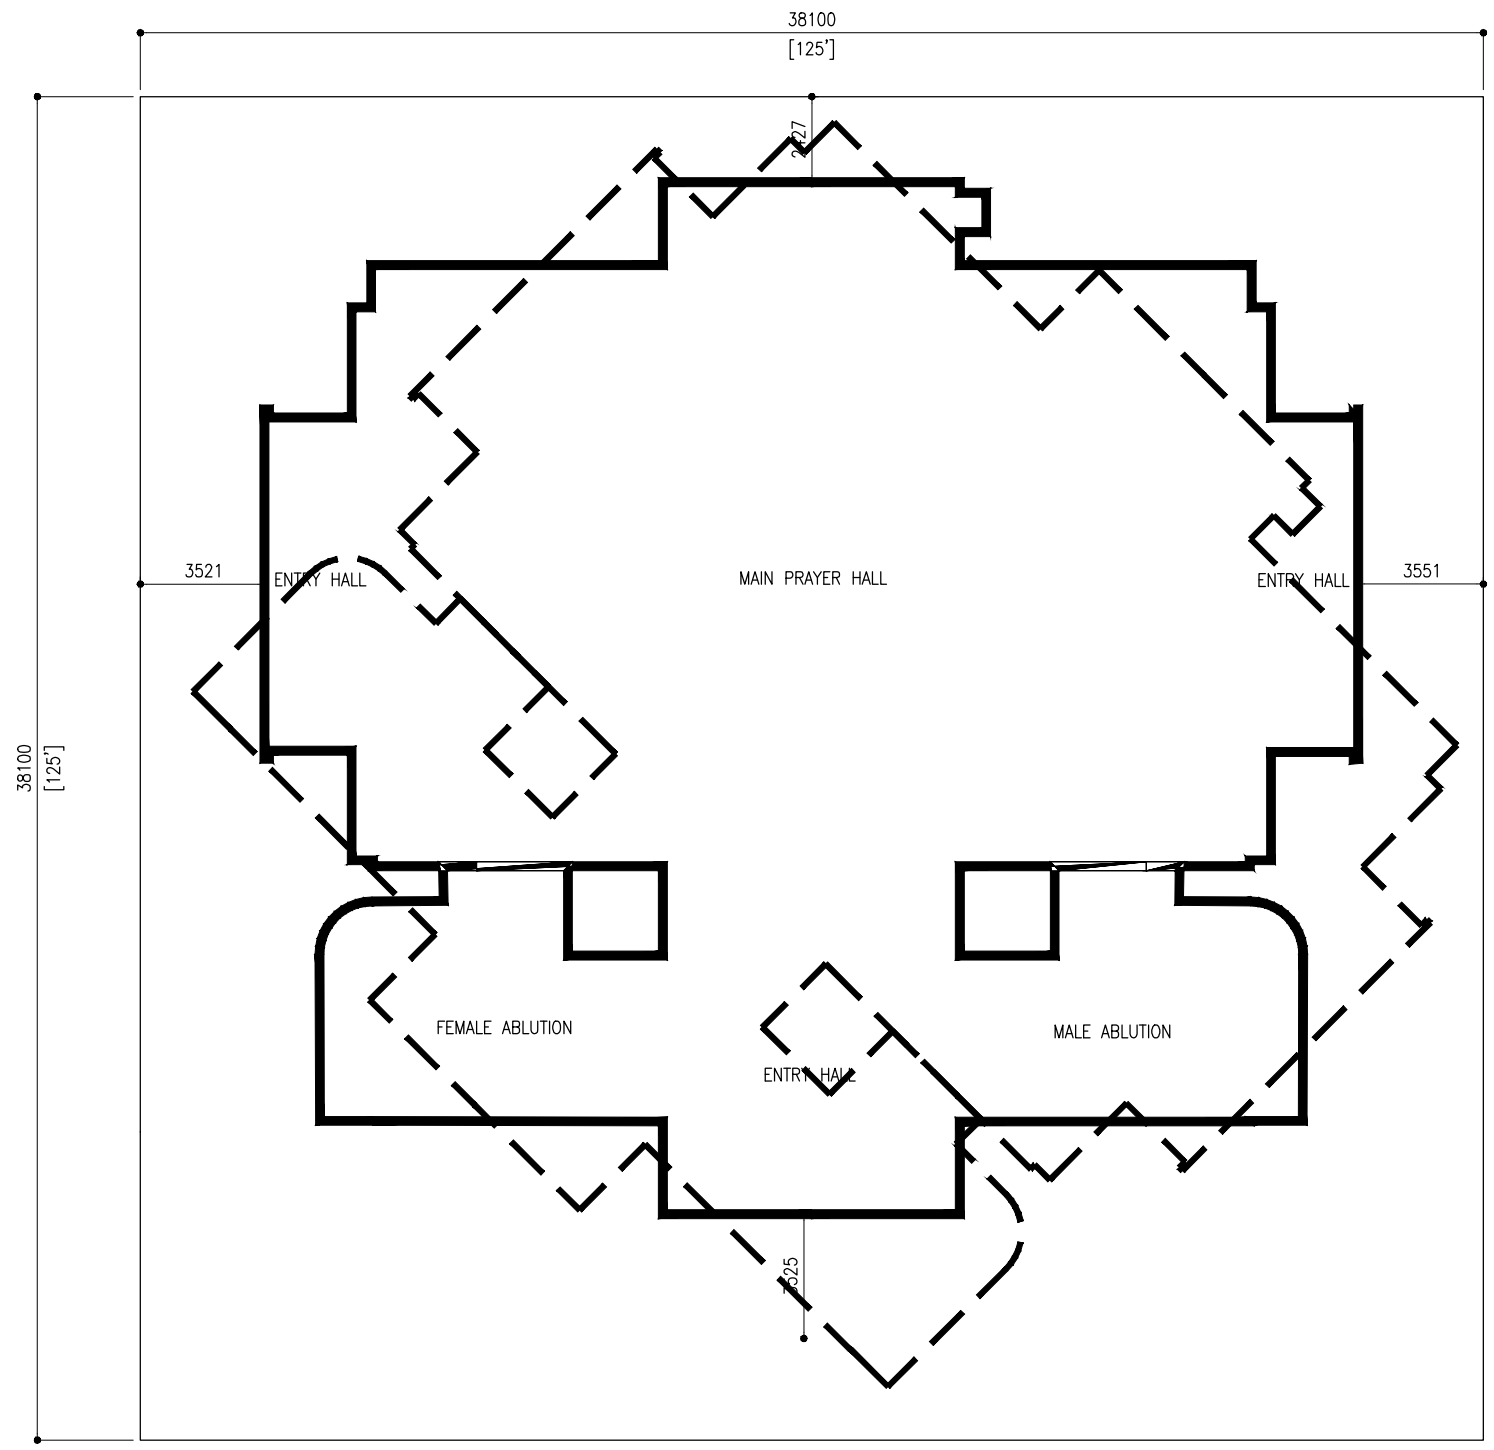

FOOT PRINT ORIENTATION

 SCALE 1:200



CLIENT:
MINISTRY OF ISLAMIC AFFAIRS

DESIGN AND CONSULTANCY:
SIARCH
PRIVATE LIMITED
LONUZIYAARAY MAGU, MALE, 20075, MALDIVES
EMAIL: T.N.F.O@SIARCH.DESIGN
HTTP://WWW.SIARCH.DESIGN

KEY PLAN:

WARNING:

- This drawing shall not be used for construction unless certified.
- Contractor to verify all dimensions of existing works on site before commencing any work or preparing shop drawings.
- Do not scale drawings, use written dimensions only.
- This drawing is to be read in conjunction with the specifications and conditions of contract.
- This drawing and design is copyright and no portion may be reproduced without the permission of the Consultant

REVISIONS

NO	DESCRIPTION	DATE

PROJECT:

500 PAX
MOSQUE DESIGN

PHASE:

- ☐ CONCEPT DESIGN
- ☐ DESIGN DEVELOPMENT
- ☒ TENDER DOCUMENT
- ☐ FOR CONSTRUCTION
- ☐ AS BUILD DRAWINGS

DESIGNATION	NAME	SIGNATURE
PROJECT MANAGER	SIARCH PVT. LTD	
STR. ENGINEER	HUSSAIN SHIHAN	
CHIEF ARCHITECT	MOHAMMED SHAMIN	
CHECKED	MOHAMMED SIRAJ	
DRAWN	YASHIKA	

DWG. NAME:


ARCHITECTURAL

FOOT PRINT ORIENTATION

CODE	DATE	DWG. NO:
COM-32	28-02-21	AR02
FORMAT	A2 A3	
SCALE	- - 1:200	ISSUE A

PDF FILE NAME: COM-32_AR02_A

[illegible]

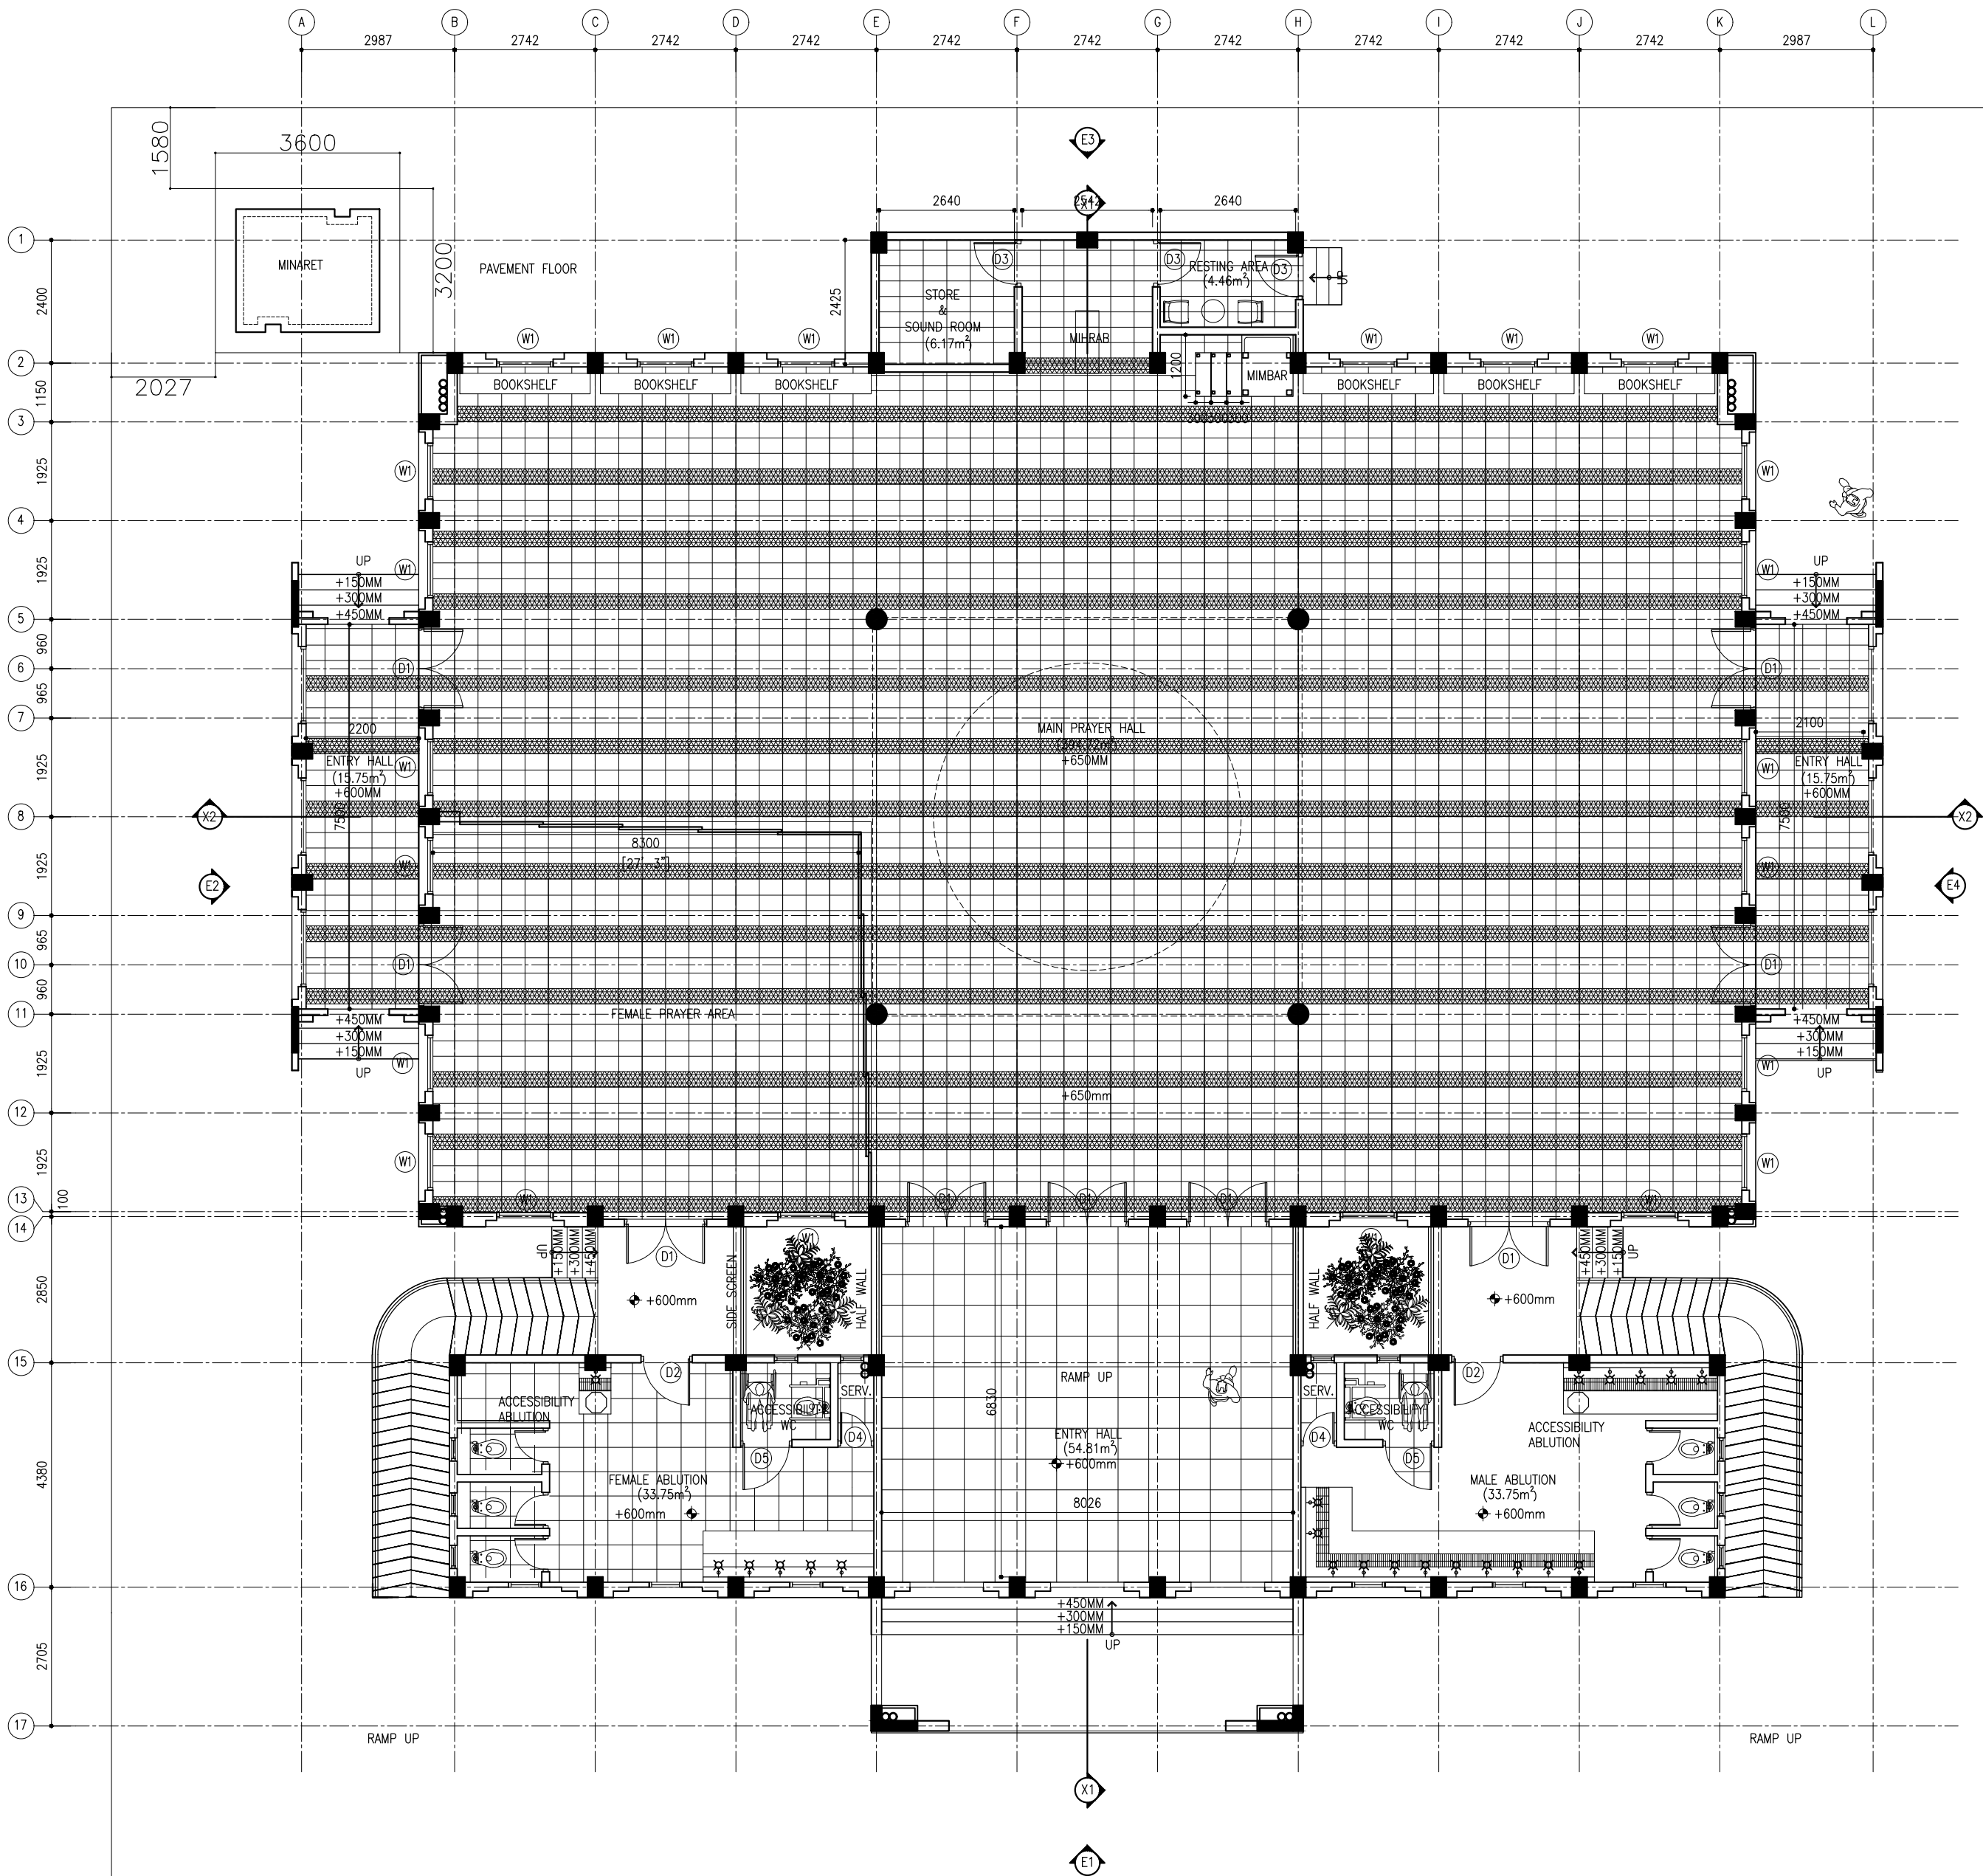

- A 600X600MM POLISHED CERAMIC TILES
B 1200MM HIGH WALL TILES
C EMULSION PAINT FINISH
D ENAMEL PAINT FINISH
E VARNISH FINISH
F EXPOSED FINISH
G ROUGH CONCRETE FINISH
H T&G CEILING

SURFACE	GENERAL	FLOOR	WALL	CEILING	REMARKS
MOSQUE		A	D	H	
EXTERIOR			D	D	

SURFACE FINISHES SCHEDULE

FLOOR PLAN

SCALE 1:100
0m 5m

CLIENT:
MINISTRY OF ISLAMIC AFFAIRS

DESIGN AND CONSULTANCY:
SIARCH
PRIVATE LIMITED
SUZUKUMANI, MAGUWALLE, 2021, MALAYSIA
EMAIL: INFO@SIARCH.DESIGN
HTTP://WWW.SIARCH.DESIGN

KEY PLAN:

WARNING:
- This drawing shall not be used for construction unless certified.
- Contractor to verify all dimensions of existing works on site before commencing any work or preparing shop drawings.
- Do not scale drawings, use written dimensions only.
- This drawing is to be read in conjunction with the specifications and conditions of contract.
- This drawing and design is copyright and no portion may be reproduced without the permission of the Consultant

REVISIONS
NO DESCRIPTION DATE

PROJECT:
500 PAX MOSQUE DESIGN


PHASE:
○ CONCEPT DESIGN
○ DESIGN DEVELOPMENT
● TENDER DOCUMENT
○ FOR CONSTRUCTION
○ AS BUILD DRAWINGS

DESIGNATION NAME SIGNATURE
PROJECT MANAGER SIARCH PVT LTD
STR. ENGINEER HUSSAIN SHAWH
CHIEF ARCHITECT MOHAMED SRAI
CHECKED MOHAMED SRAI
DRAWN YASHIKA


DWG. NAME:
ARCHITECTURAL





FLOOR PLAN

CODE DATE DWG. NO:
COM-32 27-02-2021 AR04
FORMAT A1 A2 A3
SCALE 1:100
ISSUE A
PDF FILE NAME: COM-32_AR04_A

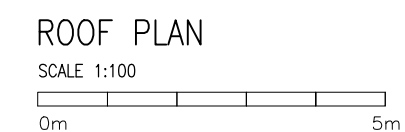


CODE COM-32	DATE 27-02-2021			DWG. NO: AR05
FORMAT	A1	A2	A3	
SCALE	-	1:100	-	
ISSUE A				
PDF FILE NAME: COM-32_AR05_A				

 [illegible]

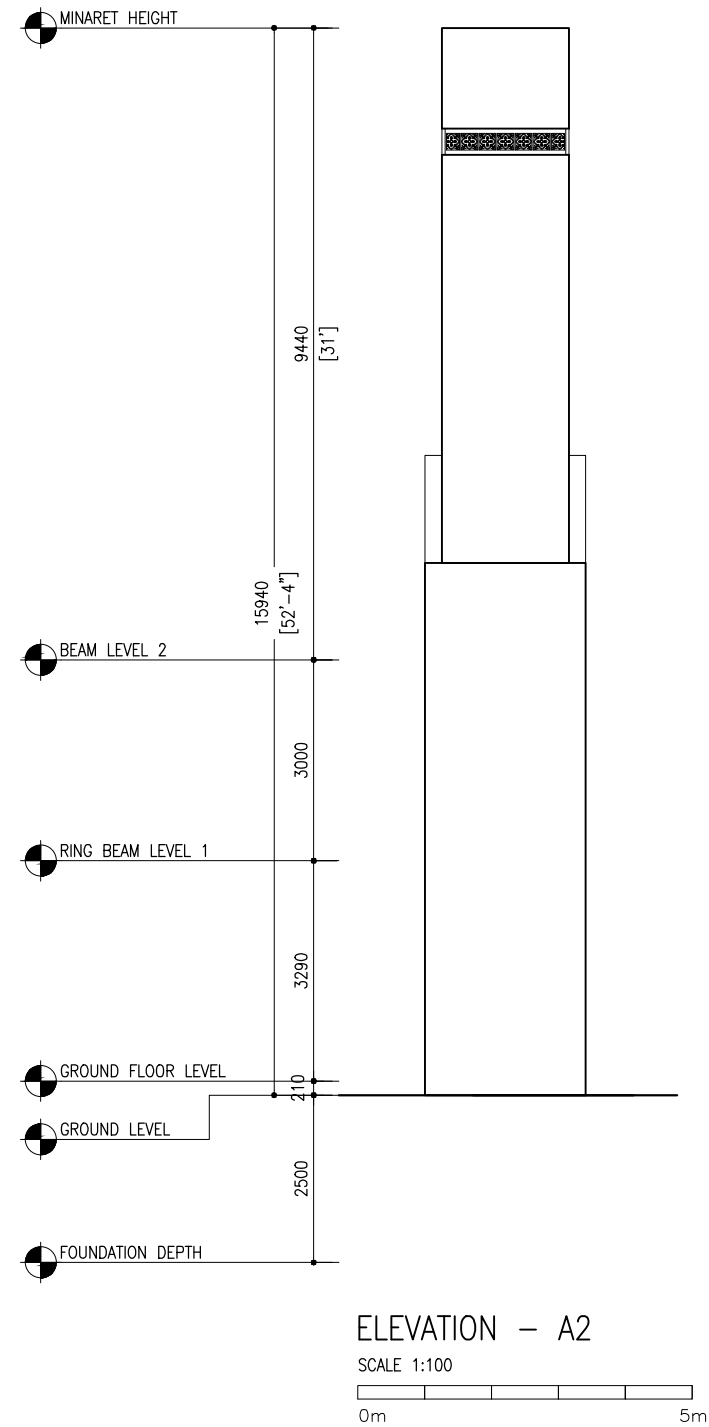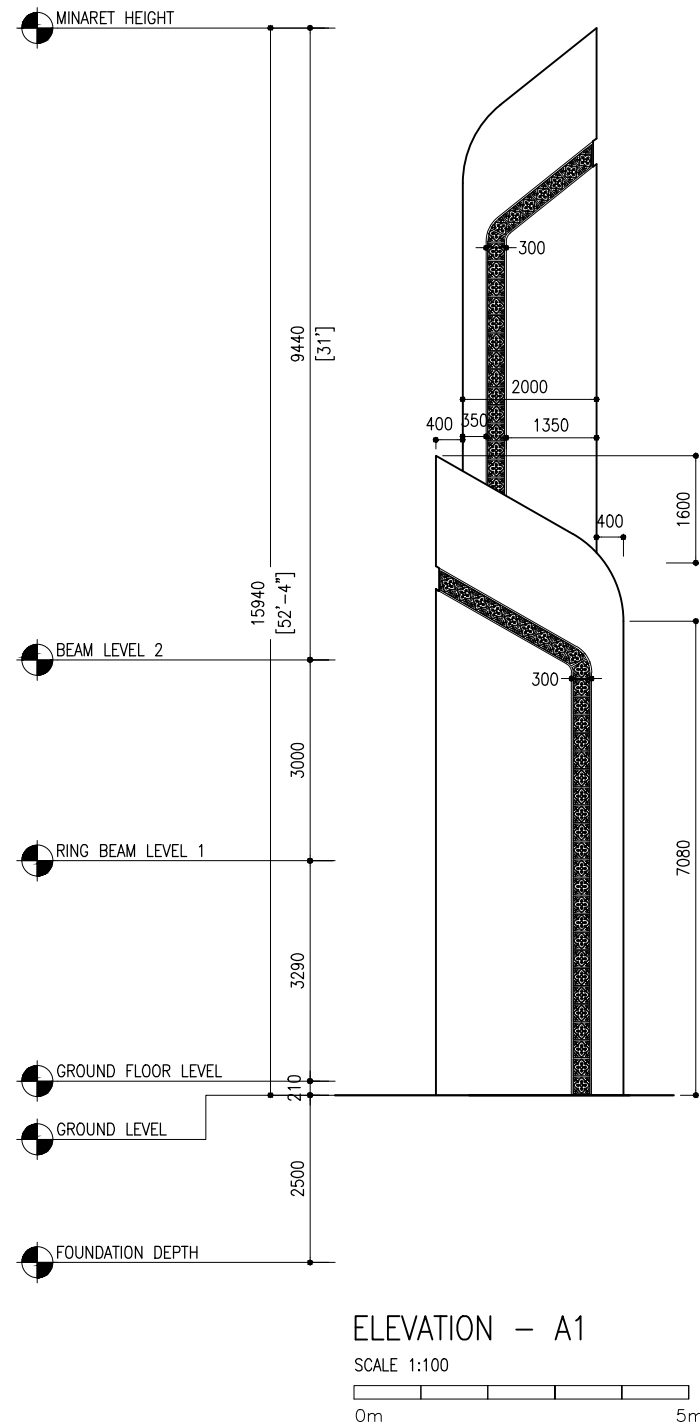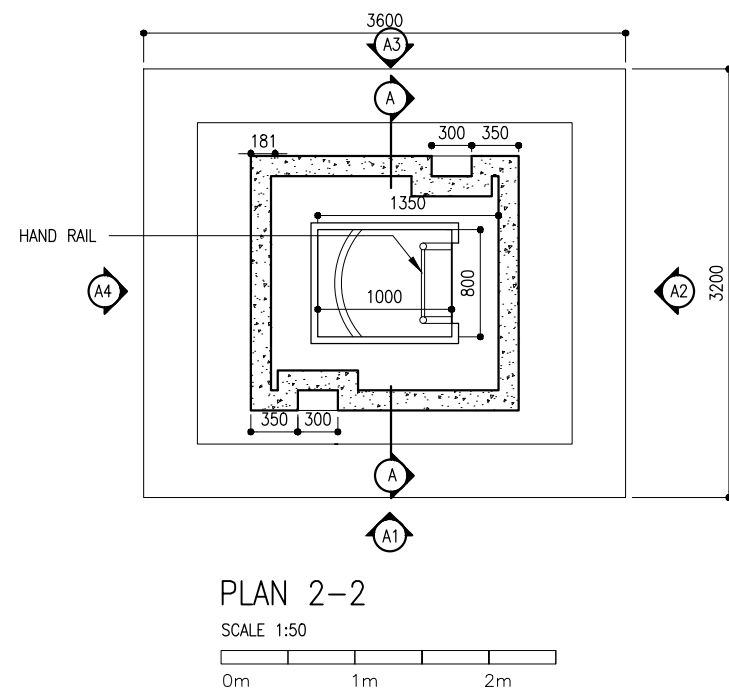
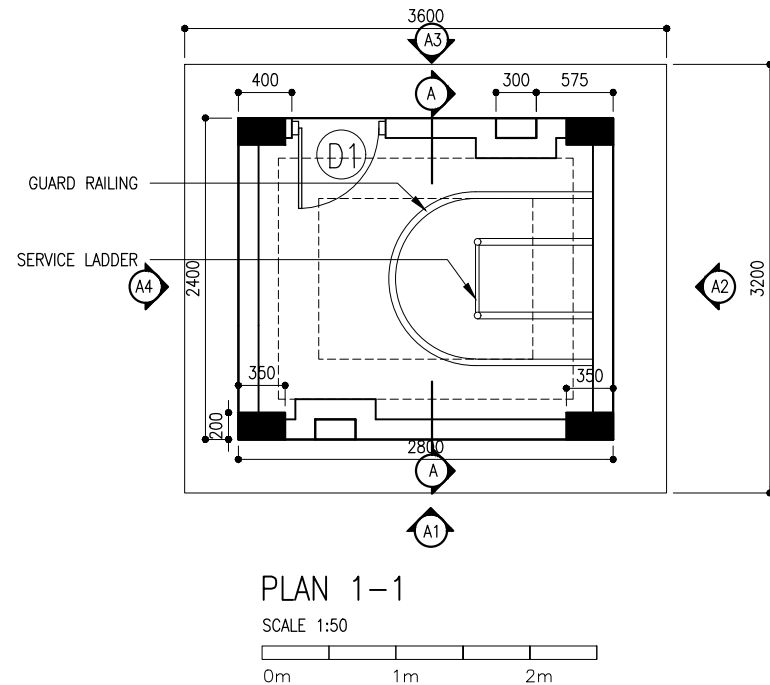


CLIENT: MINISTRY OF ISLAMIC AFFAIRS		
DESIGN AND CONSULTANCY: SIARCH PRIVATE LIMITED LONUZHAARAY MAGU, MALE' 20075, MALDIVES EMAIL: INFO@SIARCH.DESIGN HTTP://WWW.SIARCH.DESIGN		
KEY PLAN: 		
WARNING: <ul style="list-style-type: none">- This drawing shall not be used for construction unless certified.- Contractor to verify all dimensions of existing works on site before commencing any work or preparing shop drawings.- Do not scale drawings, use written dimensions only.- This drawing is to be read in conjunction with the specifications and conditions of contract.- This drawing and design is copyright and no portion may be reproduced without the permission of the Consultant		
REVISIONS		
NO	DESCRIPTION	DATE
PROJECT: 500 PAX MOSQUE DESIGN		
PHASE: <input type="radio"/> CONCEPT DESIGN <input type="radio"/> DESIGN DEVELOPMENT <input checked="" type="radio"/> TENDER DOCUMENT <input type="radio"/> FOR CONSTRUCTION <input type="radio"/> AS BUILD DRAWINGS		
DESIGNATION	NAME	SIGNATURE
PROJECT MANAGER	SIARCH PVT LTD	
STR. ENGINEER	HUSSAIN SHIHAN	
CHIEF ARCHITECT	MOHAMMED SHAMIN	
CHECKED	MOHAMMED SIRAJ	
DRAWN	YASHIKA	
DWG. NAME: ARCHITECTURAL		
MINARET DETAILS 1		
CODE COM-32	DATE 28-02-21	DWG. NO: AR09
FORMAT	A2 A3	
SCALE	- 1:100	ISSUE A
PDF FILE NAME: COM-32_AR09_A		

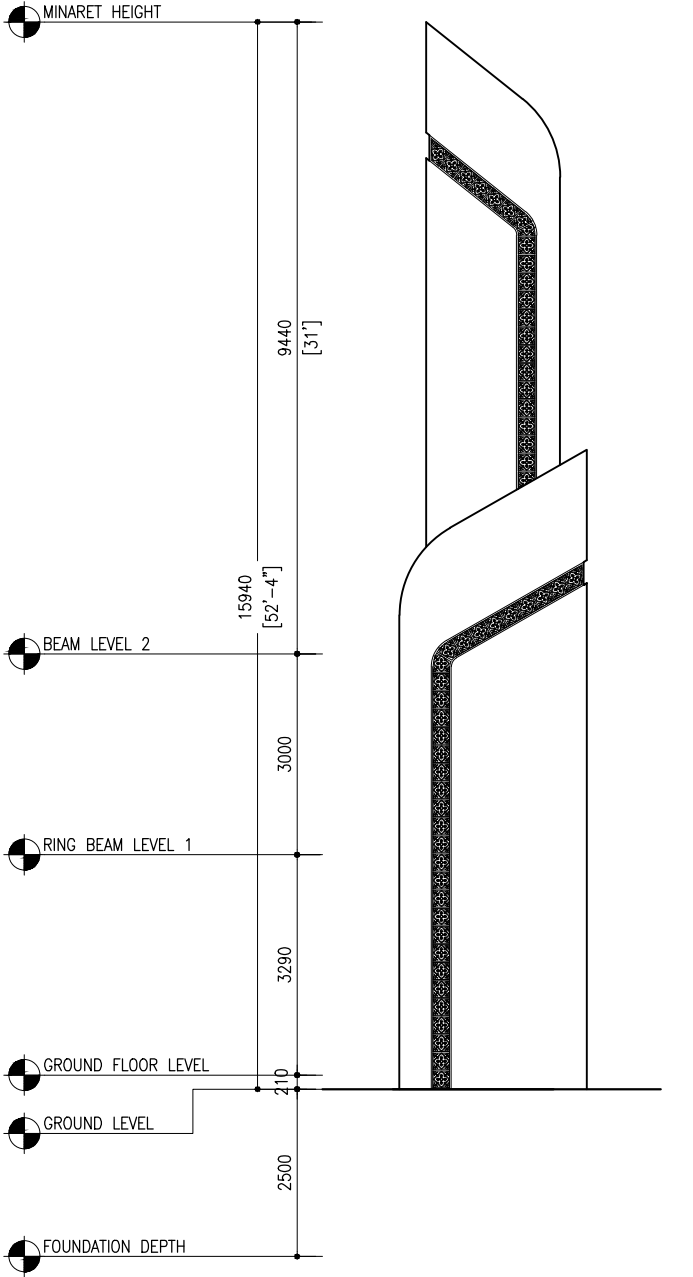



ELEVATION – A3

 SCALE 1:100

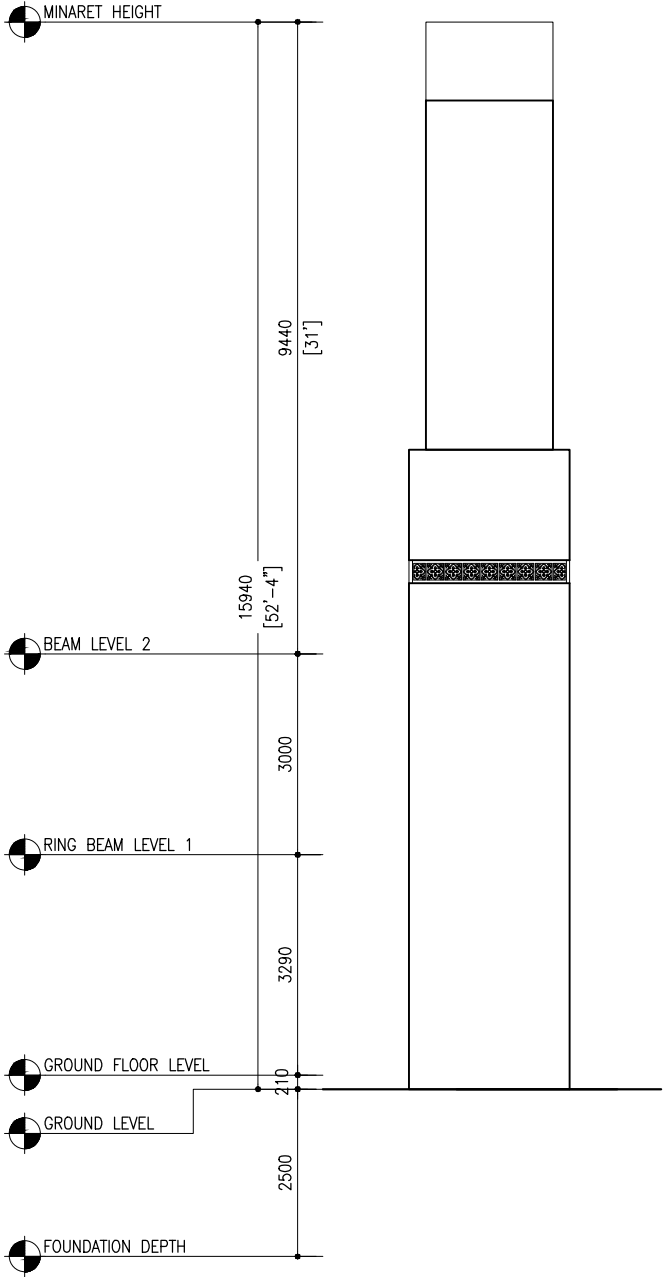


ELEVATION – A4

 SCALE 1:100

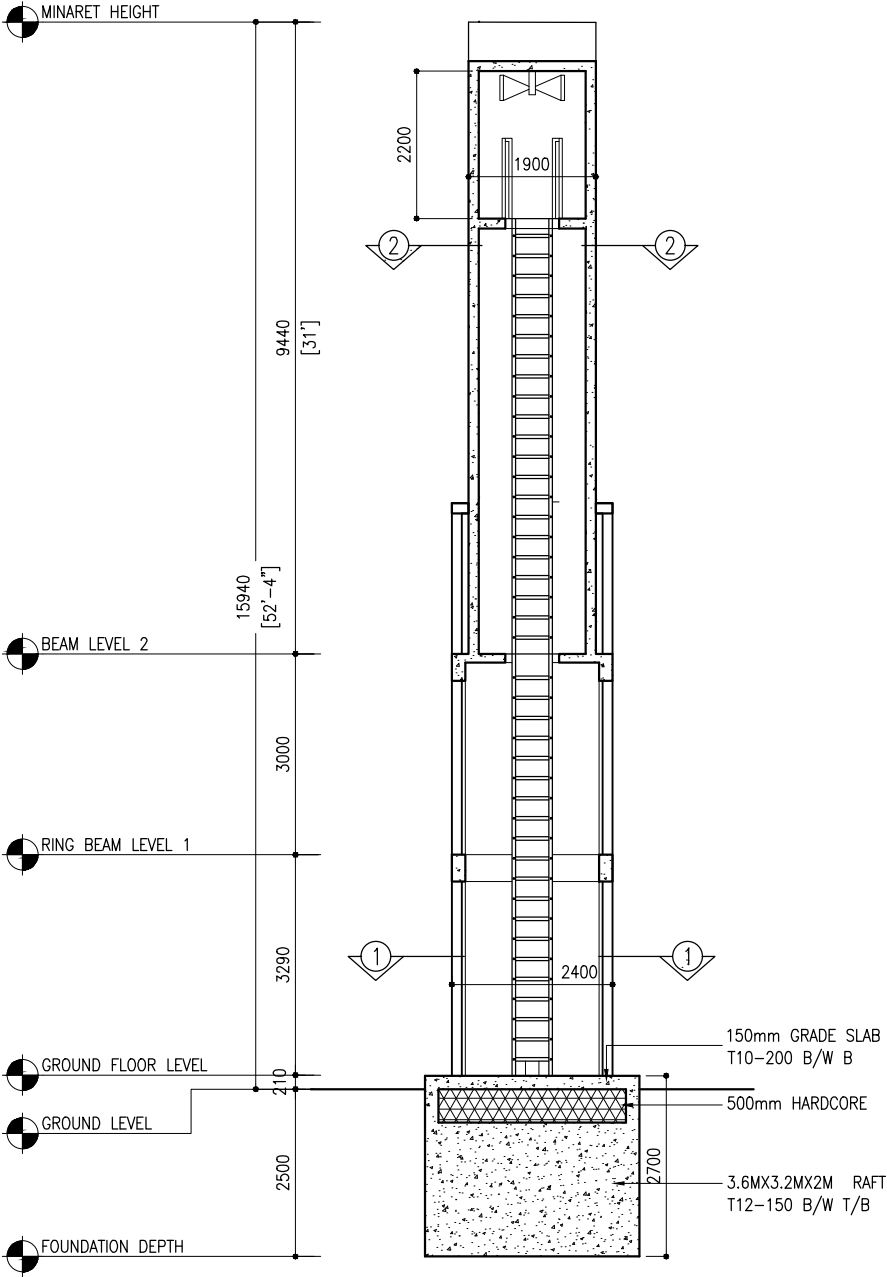

SECTION A-A

 SCALE 1:100



CLIENT:
MINISTRY OF ISLAMIC AFFAIRS

DESIGN AND CONSULTANCY:
SIARCH
PRIVATE LIMITED
LONUZHYARAIY MAGU, MALE' 20075, MALDIVES
EMAIL: INFO@SIARCH.DESIGN
HTTP://WWW.SIARCH.DESIGN

KEY PLAN:

WARNING:

- This drawing shall not be used for construction unless certified.
- Contractor to verify all dimensions of existing works on site before commencing any work or preparing shop drawings.
- Do not scale drawings, use written dimensions only.
- This drawing is to be read in conjunction with the specifications and conditions of contract.
- This drawing and design is copyright and no portion may be reproduced without the permission of the Consultant

REVISIONS

NO	DESCRIPTION	DATE

PROJECT:

500 PAX
MOSQUE DESIGN

PHASE:

- ☐ CONCEPT DESIGN
- ☐ DESIGN DEVELOPMENT
- ☒ TENDER DOCUMENT
- ☐ FOR CONSTRUCTION
- ☐ AS BUILD DRAWINGS

DESIGNATION	NAME	SIGNATURE
PROJECT MANAGER	SIARCH PVT LTD	
STR. ENGINEER	HUSSAIN SHIHAN	
CHIEF ARCHITECT	MOHAMMED SHAMIN	
CHECKED	MOHAMED SIRAJ	
DRAWN	YASHIKA	



DWG. NAME:

ARCHITECTURAL

MINARET DETAILS 2

CODE	DATE	DWG. NO:
COM-32	28-02-21	AR10
FORMAT	A2 A3	
SCALE	- 1:100	ISSUE A

  PDF FILE NAME: COM-32_AR10_A




CODE COM-32	DATE 28-02-21		DWG. NO: AR11
FORMAT	A2	A3	
SCALE	-	1:50	
ISSUE A			
PDF FILE NAME: COM-32_AR11_A			

DESIGNATION	NAME	SIGNATURE
PROJECT MANAGER	SARCH PVT LTD	
STR. ENGINEER	HUSSAIN SHIHAN	
CHIEF ARCHITECT	MOHAMMED SHAMIN	
CHECKED	MOHAMMED SIRAJ	
DRAWN	YASHIKA	




IMAGE REF.

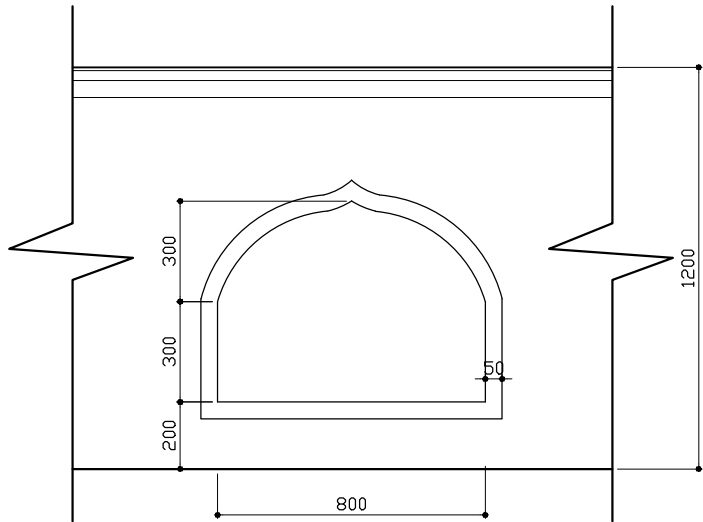


BOUNDARY WALL DETAIL

SCALE 1:20

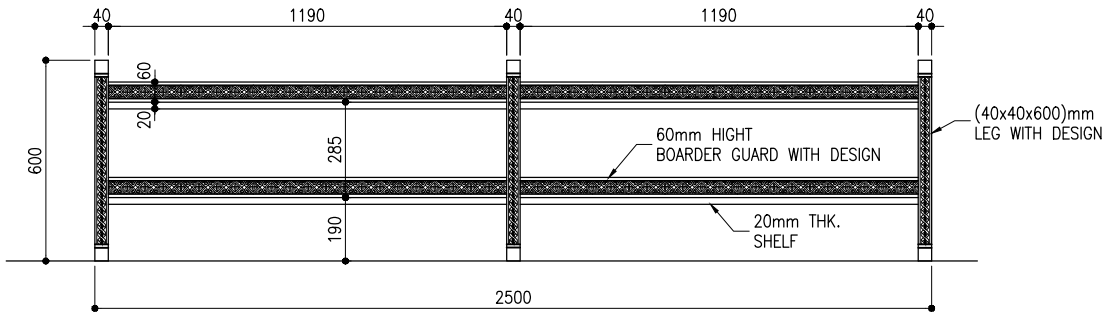


BOOKSHELF FRONT ELEVATION

SCALE 1:20

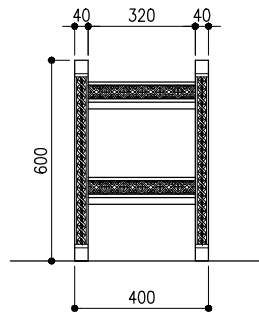

BOOKSHELF SIDE ELEVATION

SCALE 1:20

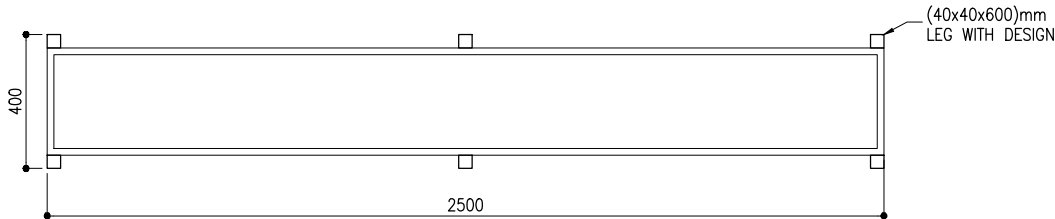


BOOKSHELF PLAN

SCALE 1:20


BOOKSHELF DETAILS

SCALE 1:20


CLIENT: MINISTRY OF ISLAMIC AFFAIRS		
DESIGN AND CONSULTANCY: SIARCH PRIVATE LIMITED LONUZHAARAY MAGU, MALE' 20075, MALDIVES EMAIL: INFO@SIARCH.DESIGN HTTP://WWW.SIARCH.DESIGN		
KEY PLAN: 		
WARNING: <ul style="list-style-type: none">- This drawing shall not be used for construction unless certified.- Contractor to verify all dimensions of existing works on site before commencing any work or preparing shop drawings.- Do not scale drawings, use written dimensions only.- This drawing is to be read in conjunction with the specifications and conditions of contract.- This drawing and design is copyright and no portion may be reproduced without the permission of the Consultant		
REVISIONS		
NO	DESCRIPTION	DATE
PROJECT: 500 PAX MOSQUE DESIGN		
PHASE: <input type="radio"/> CONCEPT DESIGN <input type="radio"/> DESIGN DEVELOPMENT <input checked="" type="radio"/> TENDER DOCUMENT <input type="radio"/> FOR CONSTRUCTION <input type="radio"/> AS BUILD DRAWINGS		
DESIGNATION	NAME	SIGNATURE
PROJECT MANAGER	SIARCH PVT LTD	
STR. ENGINEER	HUSSAIN SHIHAN	
CHIEF ARCHITECT	MOHAMMED SHAMIN	
CHECKED	MOHAMMED SIRAJ	
DRAWN	YASHIKA	
DWG. NAME: ARCHITECTURAL		
ARCHITECTURAL DETAILS 1		
CODE COM-32	DATE 28-02-21	DWG. NO: AR12
FORMAT	A2 A3	
SCALE	- 1:20	ISSUE A
PDF FILE NAME: COM-32_AR12_A		

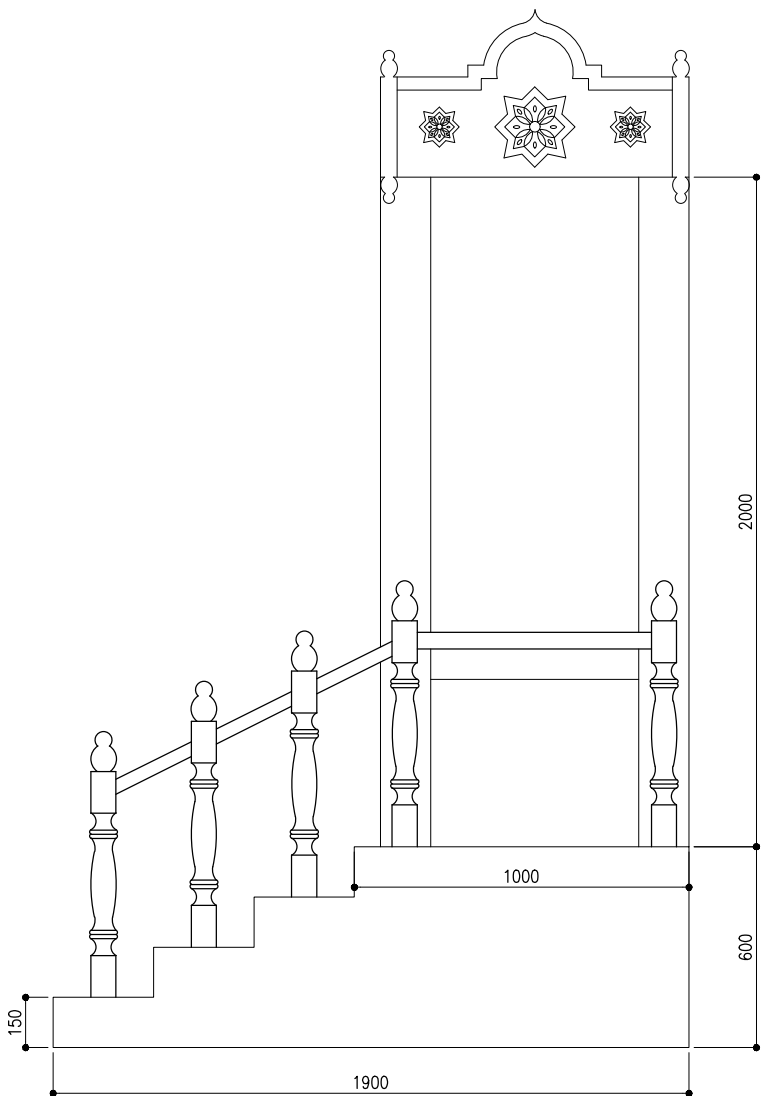

ELEVATION Y1
SCALE 1:20

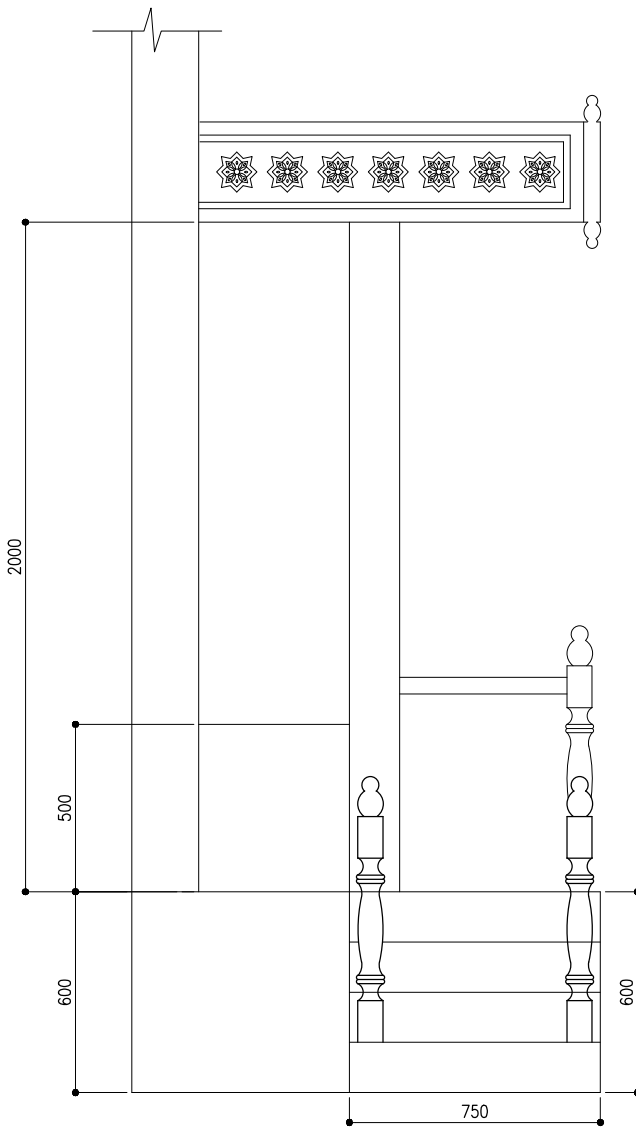


ELEVATION Y2
SCALE 1:20

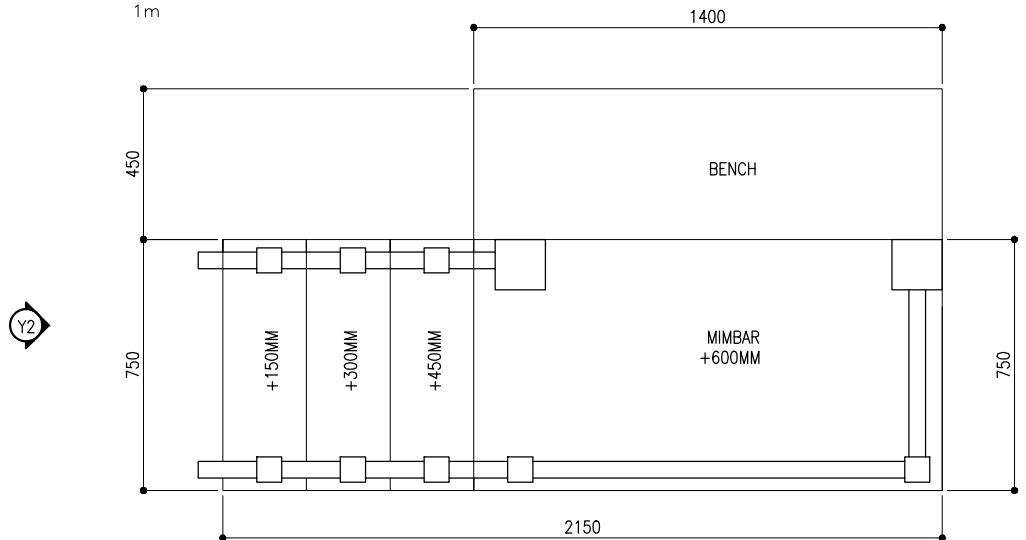

MIMBAR PLAN

 SCALE 1:20



CLIENT:
MINISTRY OF ISLAMIC AFFAIRS

DESIGN AND CONSULTANCY:
SIARCH
PRIVATE LIMITED
LONUZIMARAIY MAGU, MALE'20075, MALDIVES
EMAIL: INFO@SIARCH.DESIGN
HTTP://WWW.SIARCH.DESIGN

KEY PLAN:

WARNING:

- This drawing shall not be used for construction unless certified.
- Contractor to verify all dimensions of existing works on site before commencing any work or preparing shop drawings.
- Do not scale drawings, use written dimensions only.
- This drawing is to be read in conjunction with the specifications and conditions of contract.
- This drawing and design is copyright and no portion may be reproduced without the permission of the Consultant

REVISIONS		
NO	DESCRIPTION	DATE

PROJECT:

500 PAX
MOSQUE DESIGN

PHASE:
☐ CONCEPT DESIGN
☐ DESIGN DEVELOPMENT
☒ TENDER DOCUMENT
☐ FOR CONSTRUCTION
☐ AS BUILD DRAWINGS

DESIGNATION	NAME	SIGNATURE
PROJECT MANAGER	SIARCH PVT LTD	
STR. ENGINEER	HUSSAIN SHIHAN	
CHIEF ARCHITECT	MOHAMMED SHAMIN	
CHECKED	MOHAMED SIRAJ	
DRAWN	YASHIKA	


DWG. NAME:

ARCHITECTURAL

MIMBAR DETAILS



CODE COM-32	DATE 28-02-21	DWG. NO. AR13
FORMAT	A2 A3	
SCALE	- 1:20	ISSUE A

PDF FILE NAME: COM-32_AR13_A

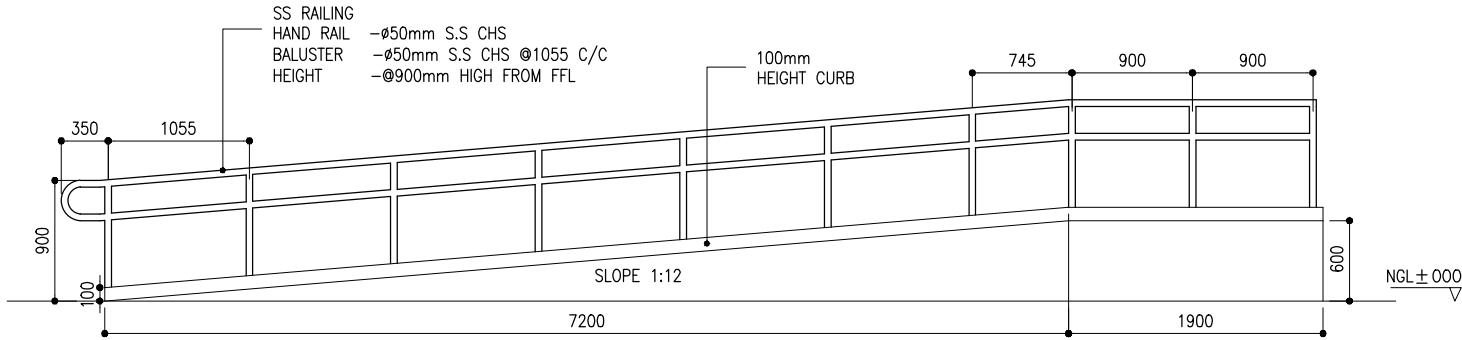


RAMP ELEVATION R1

 SCALE 1:50

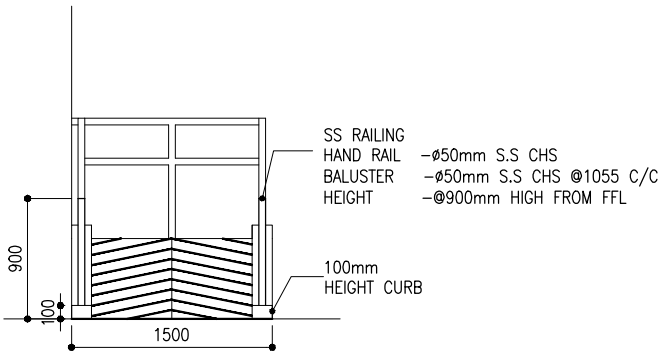


RAMP ELEVATION R2

SCALE 1:50

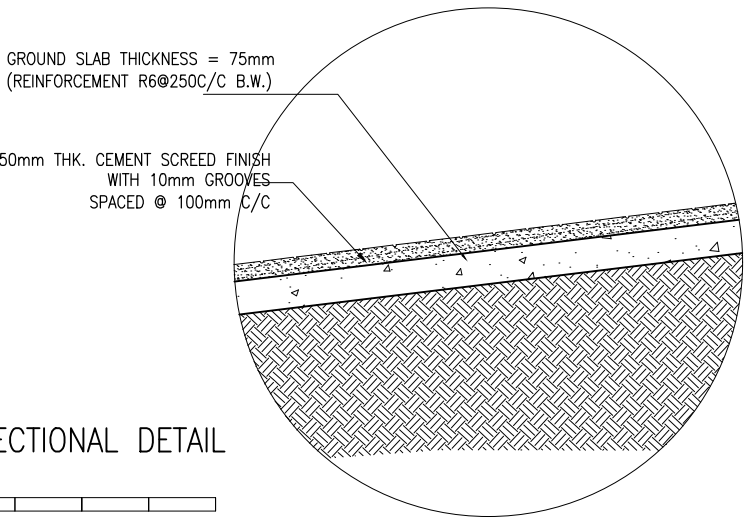


RAMP SECTIONAL DETAIL

SCALE 1:20

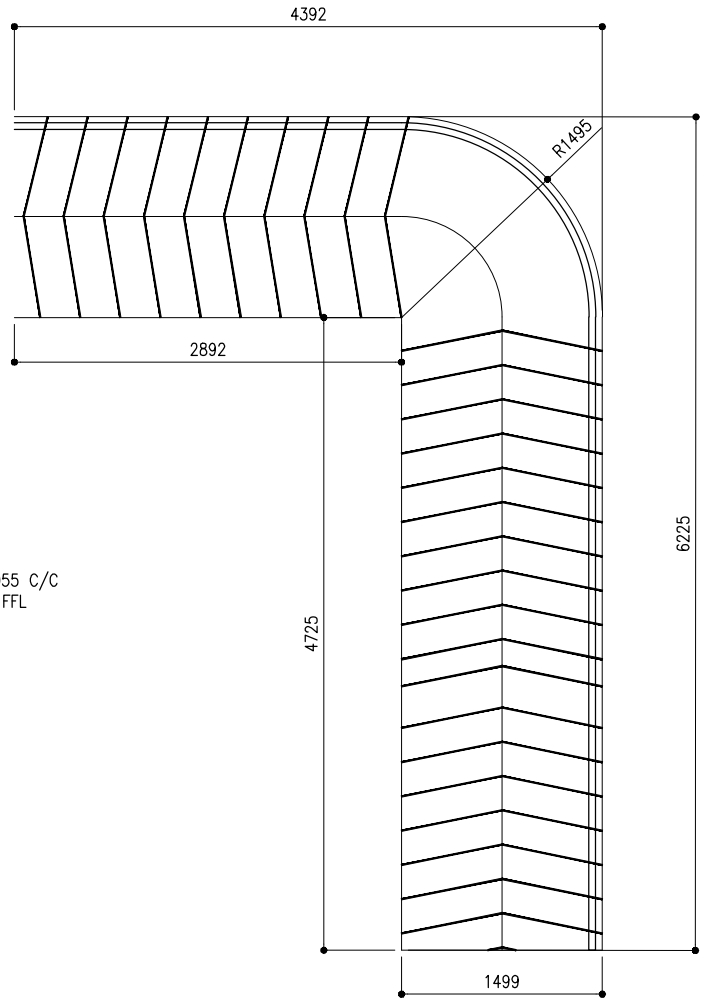

RAMP PLAN

 
SCALE 1:50



CLIENT:
MINISTRY OF ISLAMIC AFFAIRS

DESIGN AND CONSULTANCY:
SIARCH
PRIVATE LIMITED
LONUZHAARAY MAGU, MALE' 20075, MALDIVES
EMAIL: INFO@SIARCH.DESIGN
HTTP://WWW.SIARCH.DESIGN

KEY PLAN:

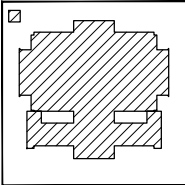

WARNING:

- This drawing shall not be used for construction unless certified.
- Contractor to verify all dimensions of existing works on site before commencing any work or preparing shop drawings.
- Do not scale drawings, use written dimensions only.
- This drawing is to be read in conjunction with the specifications and conditions of contract.
- This drawing and design is copyright and no portion may be reproduced without the permission of the Consultant

REVISIONS		
NO	DESCRIPTION	DATE

PROJECT:

500 PAX
MOSQUE DESIGN

- PHASE:
- ☐ CONCEPT DESIGN
 - ☐ DESIGN DEVELOPMENT
 - ☒ TENDER DOCUMENT
 - ☐ FOR CONSTRUCTION
 - ☐ AS BUILD DRAWINGS



DESIGNATION	NAME	SIGNATURE
PROJECT MANAGER	SIARCH PVT LTD	
STR. ENGINEER	HUSSAIN SHIHAN	
CHIEF ARCHITECT	MOHAMMED SHAMIN	
CHECKED	MOHAMED SIRAJ	
DRAWN	YASHIKA	

DWG. NAME:

ARCHITECTURAL

RAMP DETAILS

CODE COM-32	DATE 28-02-21	DWG. NO: AR14
FORMAT	A2 A3 1/20	ISSUE A
SCALE	-	1/20
PDF FILE NAME: COM-32_AR14_A		

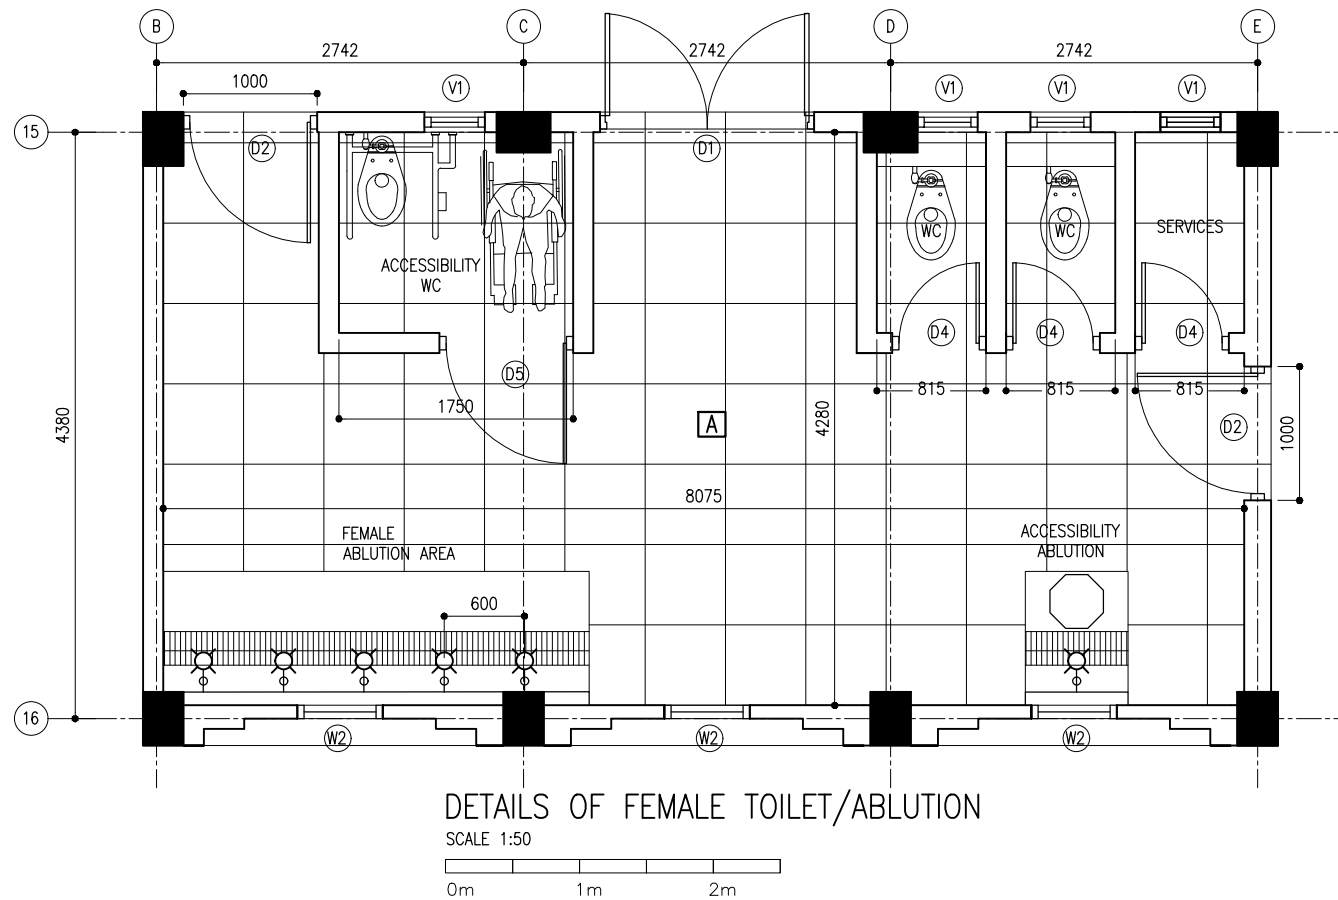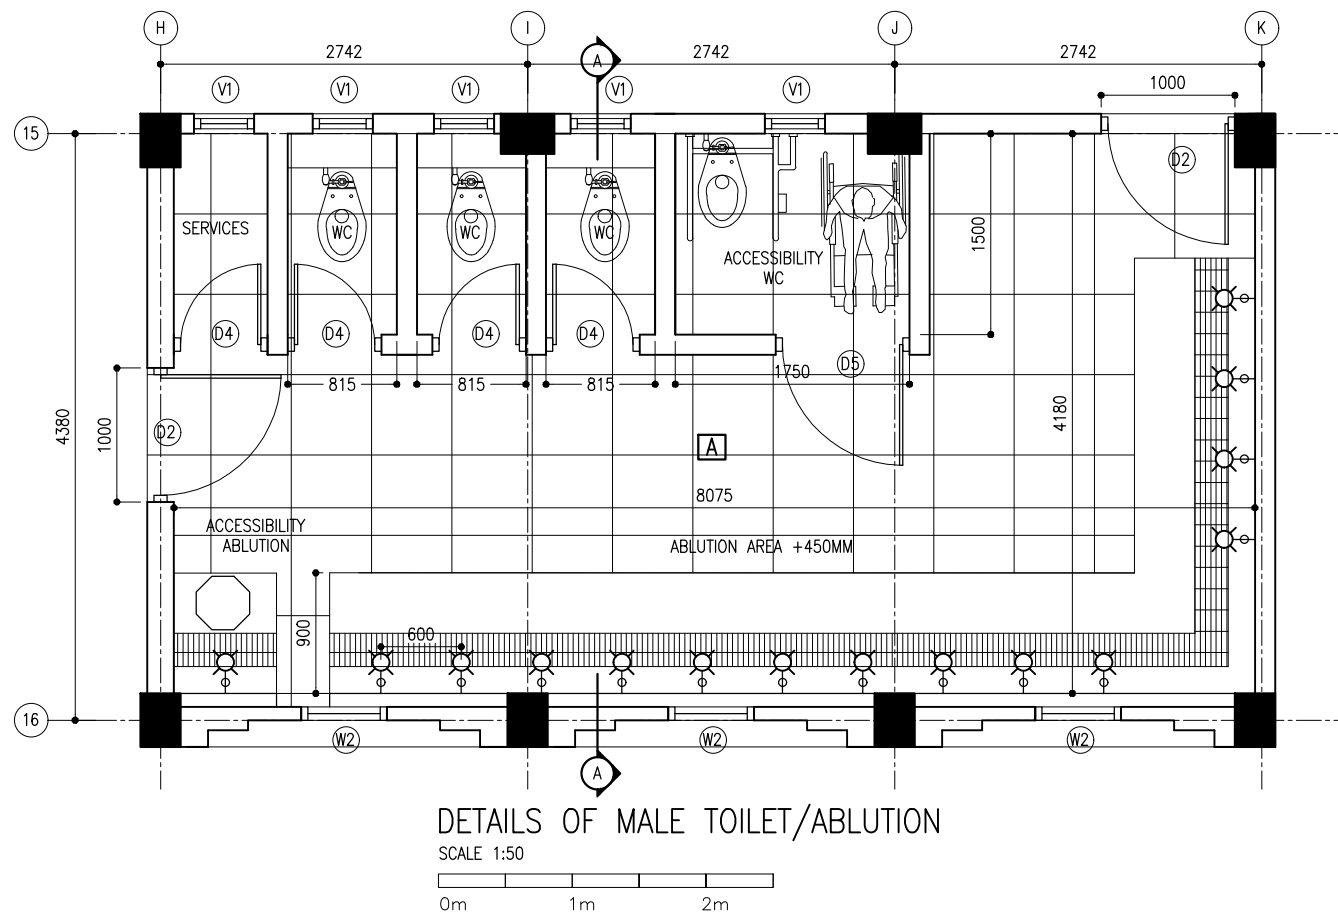


- A 600X600MM NON-SLIP CERAMIC TILES
B 1200MM HIGH WALL TILES
C EMULSION PAINT FINISH
D ENAMEL PAINT FINISH
E VARNISH FINISH
F EXPOSED FINISH
G ROUGH CONCRETE FINISH

SURFACE	GENERAL	FLOOR	WALL	CEILING	REMARKS
ABLUTION AREA		A	B	D	
DOOR/WINDOWS			D	D	
EXTERIOR	D		D		


SURFACE FINISHES SCHEDULE

CLIENT: MINISTRY OF ISLAMIC AFFAIRS		
DESIGN AND CONSULTANCY: SIARCH PRIVATE LIMITED LONUZHAARAY MAGU, MALE'20075, MALDIVES EMAIL: INFO@SIARCH.DESIGN HTTP://WWW.SIARCH.DESIGN		
KEY PLAN: 		
WARNING: <ul style="list-style-type: none">- This drawing shall not be used for construction unless certified.- Contractor to verify all dimensions of existing works on site before commencing any work or preparing shop drawings.- Do not scale drawings, use written dimensions only.- This drawing is to be read in conjunction with the specifications and conditions of contract.- This drawing and design is copyright and no portion may be reproduced without the permission of the Consultant		
REVISIONS		
NO	DESCRIPTION	DATE
PROJECT: 500 PAX MOSQUE DESIGN		
PHASE: <input type="radio"/> CONCEPT DESIGN <input type="radio"/> DESIGN DEVELOPMENT <input checked="" type="radio"/> TENDER DOCUMENT <input type="radio"/> FOR CONSTRUCTION <input type="radio"/> AS BUILD DRAWINGS		
DESIGNATION	NAME	SIGNATURE
PROJECT MANAGER	SIARCH PVT LTD	
STR. ENGINEER	HUSSAIN SHIHAN	
CHIEF ARCHITECT	MOHAMMED SHAMIN	
CHECKED	MOHAMED SIRAJ	
DRAWN	YASHIKA	
DWG. NAME: ARCHITECTURAL		
ABLUTION PLANS		
CODE COM-32	DATE 28-02-21	DWG. NO. AR15
FORMAT	A2 A3	
SCALE	- 1:50	ISSUE A
PDF FILE NAME: COM-32_AR15_A		

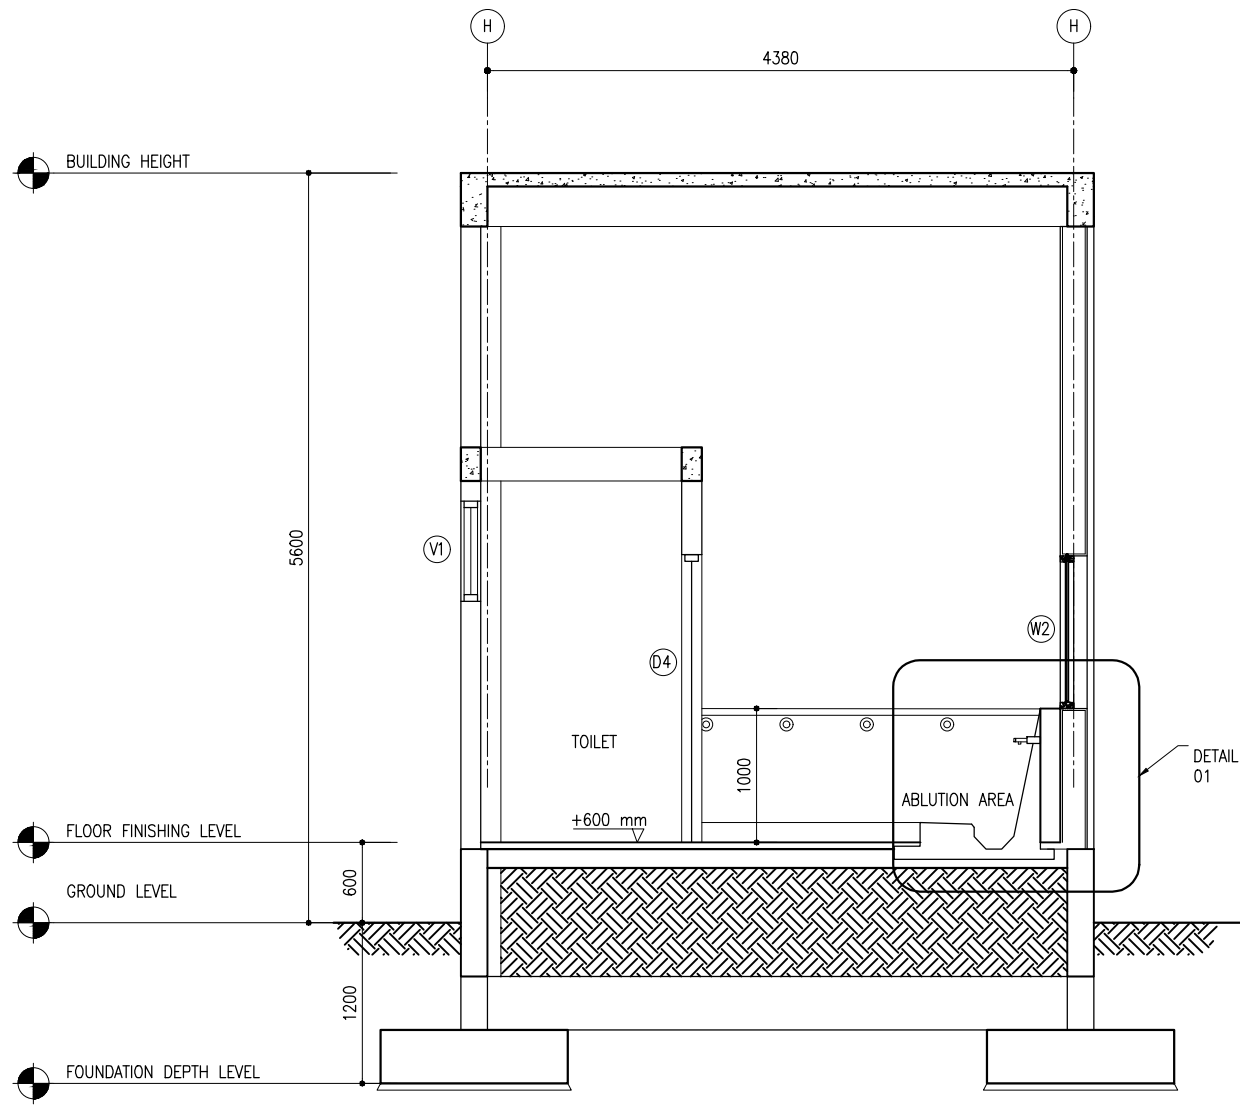

SECTION A-A

 SCALE 1:50



CLIENT:

MINISTRY OF ISLAMIC AFFAIRS

DESIGN AND CONSULTANCY:

SIARCH

PRIVATE LIMITED

LONUZHAARAY MAGU, MALE'20075, MALDIVES

EMAIL: INFO@SIARCH.DESIGN

HTTP://WWW.SIARCH.DESIGN

KEY PLAN:

WARNING:

- This drawing shall not be used for construction unless certified.

- Contractor to verify all dimensions of existing works on site before commencing any work or preparing shop drawings.

- Do not scale drawings, use written dimensions only.

- This drawing is to be read in conjunction with the specifications and conditions of contract.

- This drawing and design is copyright and no portion may be reproduced without the permission of the Consultant

REVISIONS

NO	DESCRIPTION	DATE

PROJECT:

500 PAX
MOSQUE DESIGN

PHASE:

○ CONCEPT DESIGN

○ DESIGN DEVELOPMENT

● TENDER DOCUMENT

○ FOR CONSTRUCTION

○ AS BUILD DRAWINGS

DESIGNATION	NAME	SIGNATURE
PROJECT MANAGER	SIARCH PVT LTD	
STR. ENGINEER	HUSSAIN SHIHAN	
CHIEF ARCHITECT	MOHAMMED SHAMIN	
CHECKED	MOHAMMED SIRAJ	
DRAWN	YASHIKA	


DWG. NAME:

ARCHITECTURAL

SECTION A-A

CODE	DATE	DWG. NO:
COM-32	28-02-21	AR16
FORMAT	A2 A3	
SCALE	- 1:50	ISSUE A

PDF FILE NAME: COM-32_AR16_A

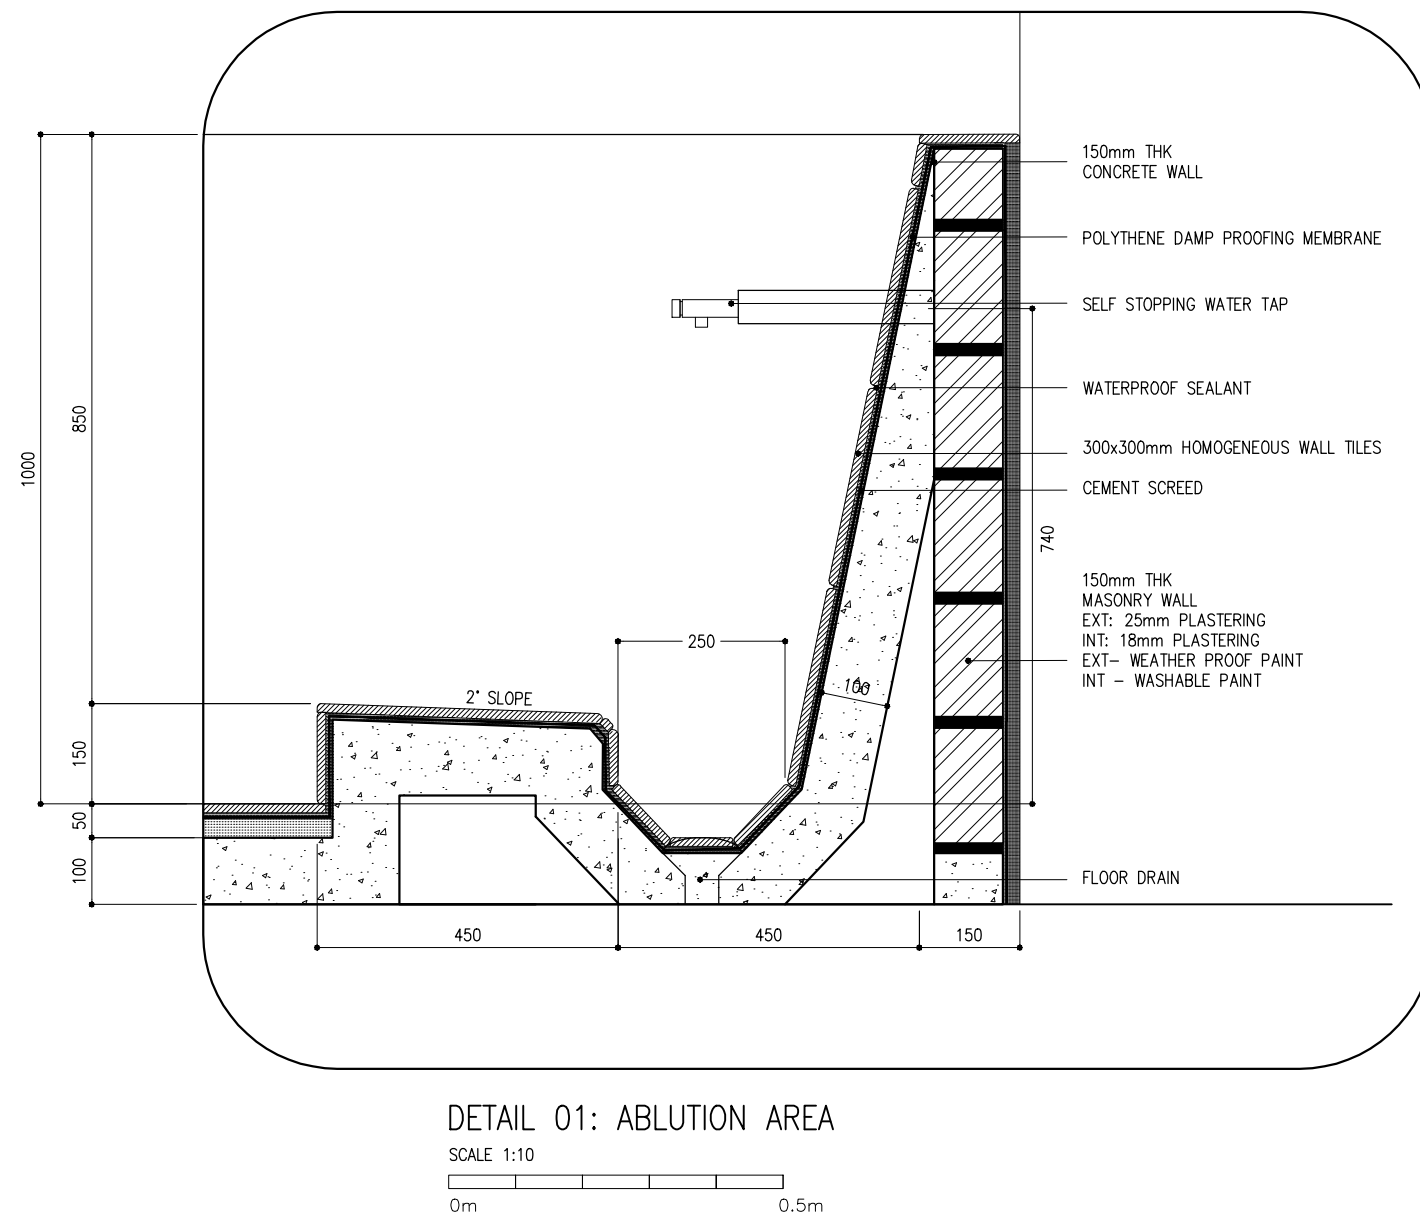

CLIENT:

MINISTRY OF ISLAMIC AFFAIRS

DESIGN AND CONSULTANCY:

SIARCH

PRIVATE LIMITED

LONUZHAARAY MAGU, MALE'20075, MALDIVES

EMAIL: INFO@SIARCH.DESIGN

HTTP://WWW.SIARCH.DESIGN

KEY PLAN:

WARNING:

- This drawing shall not be used for construction unless certified.

- Contractor to verify all dimensions of existing works on site before commencing any work or preparing shop drawings.

- Do not scale drawings, use written dimensions only.

- This drawing is to be read in conjunction with the specifications and conditions of contract.

- This drawing and design is copyright and no portion may be reproduced without the permission of the Consultant

REVISIONS

NO	DESCRIPTION	DATE

PROJECT:

500 PAX MOSQUE DESIGN

PHASE:

☐ CONCEPT DESIGN

☐ DESIGN DEVELOPMENT

☒ TENDER DOCUMENT

☐ FOR CONSTRUCTION

☐ AS BUILD DRAWINGS

DESIGNATION	NAME	SIGNATURE
PROJECT MANAGER	SIARCH PVT LTD	
STR. ENGINEER	HUSSAIN SHIHAN	
CHIEF ARCHITECT	MOHAMMED SHAMIN	
CHECKED	MOHAMMED SIRAJ	
DRAWN	YASHIKA	


DWG. NAME:

ARCHITECTURAL

ABLUTION DETAILS 1

CODE	DATE	DWG. NO:
COM-32	28-02-21	AR17
FORMAT	A2 A3	
SCALE	- 1:10	ISSUE A

 PDF FILE NAME: COM-32_AR17_A



CODE COM-32	DATE 28-02-21		DWG. NO: AR18
FORMAT	A2	A3	
SCALE	-	1:10	
ISSUE A			
PDF FILE NAME: COM-32_AR18_A			

W4	TOTAL = 02 nos.
	G.A. = - m ²

Technical drawing of a wall section showing a row of 10 rectangular panels. The total width is 7450 and the total height is 1050. Each panel is 740 wide and 1150 high. The panels are filled with diagonal hatching.

DOME
2
POWDER COATED ALUMINUM
POWDER COATED ALUMINUM WITH 6mm FLOAT GLASS
BRUSHED METAL (SILVER) TOP & BOTTOM, LOCK x1
WHITE FINISH
FIXED GLASS

- WARNING:**
- This drawing shall not be used for construction unless certified.
 - Contractor to verify all dimensions of existing works on site before commencing any work or preparing shop drawings.
 - Do not scale drawings, use written dimensions only.
 - This drawing is to be read in conjunction with the specifications and conditions of contract.
 - This drawing and design is copyright and no portion may be reproduced without the permission of the Consultant

[illegible]

PROJECT:

500 PAX
MOSQUE DESIGN

PHASE:

- ☐ CONCEPT DESIGN
- ☐ DESIGN DEVELOPMENT
- ☒ TENDER DOCUMENT
- ☐ FOR CONSTRUCTION
- ☐ AS BUILD DRAWINGS


DESIGNATION	NAME	SIGNATURE
PROJECT MANAGER	SIARCH PVT LTD	
STR. ENGINEER	HUSSAIN SHIHAN	
CHIEF ARCHITECT	MOHAMMED SHAMIN	
CHECKED	MOHAMED SIRAJ	
DRAWN	YASHIKA	

DWG. NAME:

ARCHITECTURAL



DOOR & WINDOW
SCHEDULE 02

CODE COM-32	DATE 28-02-21		DWG. NO: AR20
FORMAT	A2	A3	
SCALE	-	1:50	
ISSUE A			
PDF FILE NAME: COM-32_AR20_A			

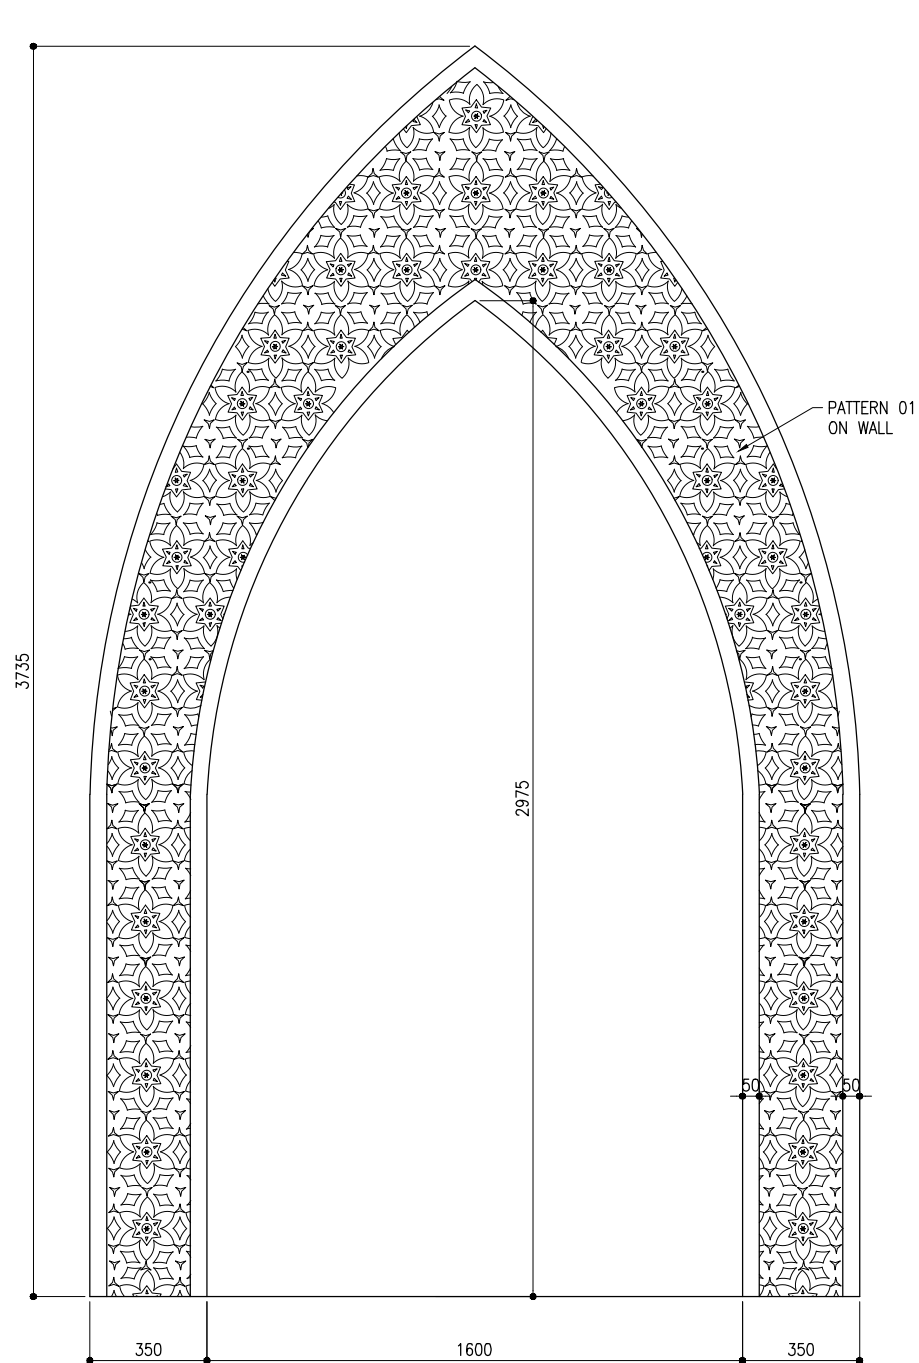


ARC -1 DETAILS

 SCALE 1:20

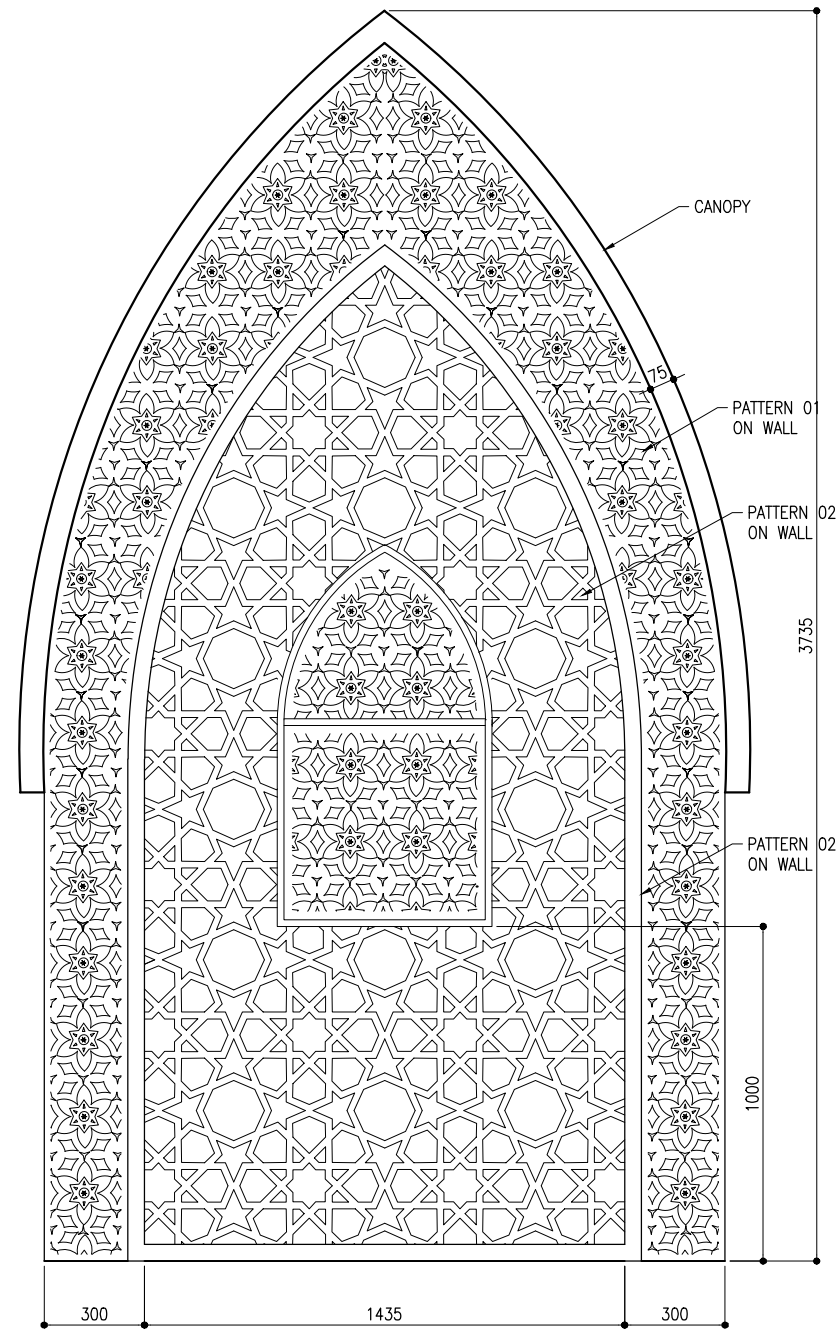


ARC -2 DETAILS

 SCALE 1:20



CLIENT: MINISTRY OF ISLAMIC AFFAIRS		
DESIGN AND CONSULTANCY: SIARCH PRIVATE LIMITED LONUZHAARAY MAGU, MALE' 20075, MALDIVES EMAIL: INFO@SIARCH.DESIGN HTTP://WWW.SIARCH.DESIGN		
KEY PLAN: 		
WARNING: <ul style="list-style-type: none">- This drawing shall not be used for construction unless certified.- Contractor to verify all dimensions of existing works on site before commencing any work or preparing shop drawings.- Do not scale drawings, use written dimensions only.- This drawing is to be read in conjunction with the specifications and conditions of contract.- This drawing and design is copyright and no portion may be reproduced without the permission of the Consultant		
REVISIONS		
NO	DESCRIPTION	DATE
PROJECT: 500 PAX MOSQUE DESIGN		
PHASE: <input type="radio"/> CONCEPT DESIGN <input type="radio"/> DESIGN DEVELOPMENT <input type="radio"/> TENDER DOCUMENT <input type="radio"/> FOR CONSTRUCTION <input type="radio"/> AS BUILD DRAWINGS		
DESIGNATION	NAME	SIGNATURE
PROJECT MANAGER		
STR. ENGINEER		
CHIEF ARCHITECT		
CHECKED		
DRAWN		
DWG. NAME: ARCHITECTURAL		
ARC DETAILS 1		
CODE COM-32	DATE 28-02-21	DWG. NO: AR21
FORMAT	A2 A3	
SCALE	- 1:20	ISSUE A
PDF FILE NAME: COM-32_AR21_A		

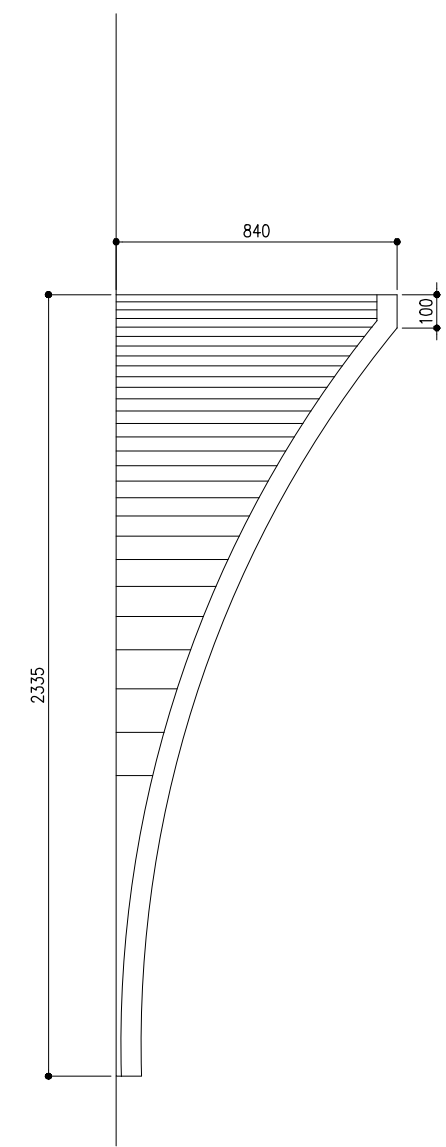

CANOPY DETAILS
SCALE 1:20
0m 1m

CLIENT:

MINISTRY OF ISLAMIC AFFAIRS

DESIGN AND CONSULTANCY:

SIARCH

PRIVATE LIMITED

LONUZHAARAY MAGU,MALE'20075,MALDIVES

EMAIL: INFO@SIARCH.DESIGN

HTTP://WWW.SIARCH.DESIGN

KEY PLAN:

WARNING:

- This drawing shall not be used for construction unless certified.

- Contractor to verify all dimensions of existing works on site before commencing any work or preparing shop drawings.

- Do not scale drawings, use written dimensions only.

- This drawing is to be read in conjunction with the specifications and conditions of contract.

- This drawing and design is copyright and no portion may be reproduced without the permission of the Consultant

REVISIONS

NO	DESCRIPTION	DATE

PROJECT:

500 PAX
MOSQUE DESIGN

PHASE:

☐ CONCEPT DESIGN

☐ DESIGN DEVELOPMENT

☐ TENDER DOCUMENT

☐ FOR CONSTRUCTION

☐ AS BUILD DRAWINGS

DESIGNATION	NAME	SIGNATURE
PROJECT MANAGER		
STR. ENGINEER		
CHIEF ARCHITECT		
CHECKED		
DRAWN		

DWG. NAME:

ARCHITECTURAL

ARC DETAILS 2

CODE	DATE	DWG. NO:
COM-32	28-02-21	AR22
FORMAT	A2 A3	
SCALE	- 1:20	ISSUE A

PDF FILE NAME: COM-32_AR22_A