


PROPOSED SINGLE STOREY COUNCIL
OFFICE FOR
MADUVVARI, MEEU ATOLL

CLIENT:
OFFICE FOR PROGRAMMES AND PROJECTS
REPUBLIC OF MALDIVES

Design by:

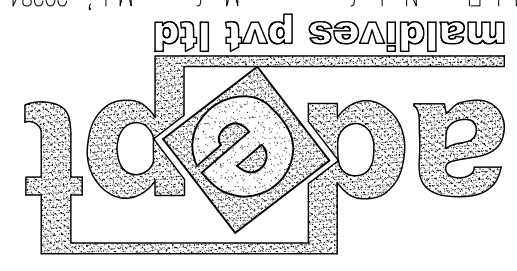

1st Floor, Neelofarunmaga, Maafanu, Male, 20284
Tel: +960 332 0203 Email: info@adeptmaldives.com

DECEMBER 2013

CONTRACTORS MUST CHECK ALL
DIMENSIONS ON SITE BEFORE
STARTING ANY WORK OR SHOP DRAWINGS.
FIGURED DIMENSIONS TO TAKE
PRECEDENCE OVER SCALE READINGS.
DO NOT SCALE DRAWINGS, IN CASE DOUBT,
PLEASE ASK.

adept

maldives pvt ltd

1st Floor, Neebalarunage, Madamru, Male', 20284
Tel: +960 790 7270 Email: info@adeptmaldives.com

REVISION:


ARCHITECT:	ABDUL WAHID MOAHMED
ENGINEER:	HASSAN NIHAD
SERVICES ENG.:	-
ESTIMATOR:	HASSAN NIHAD
DRAWN BY:	ABDUL WAHID MOAHMED

PROJECT:	COULC OFFICE FOR M. MADUVVARI ISLAND
LOCATION:	MEE MU ATOLL, REPUBLIC OF MALDIVES
DWG TITLE.:	AS GIVEN
CLIENT:	OFFICE FOR PROGRAMMES AND PROJECTS (OPP)
SCALE:	AS GIVEN
DIMENSION:	mm
DATE:	07th DECEMBER 2013
PROJECT NO.:	AM-2013-00
DWG NO.:	A-01

ARCHITECTURAL DESIGN (STRUCTURAL DESIGN) CONSULTANT'S DESIGN (CONCEPT DESIGN) OF WHOLE OR PART OF THE CONCEPT, DESIGN OR DRAWINGS TO USE IN ANY OTHER PROJECTS OR SITES OTHER THAN SPECIFIED ON THIS DRAWING IS PROHIBITED.

SITE PLAN

SCALE 1:100

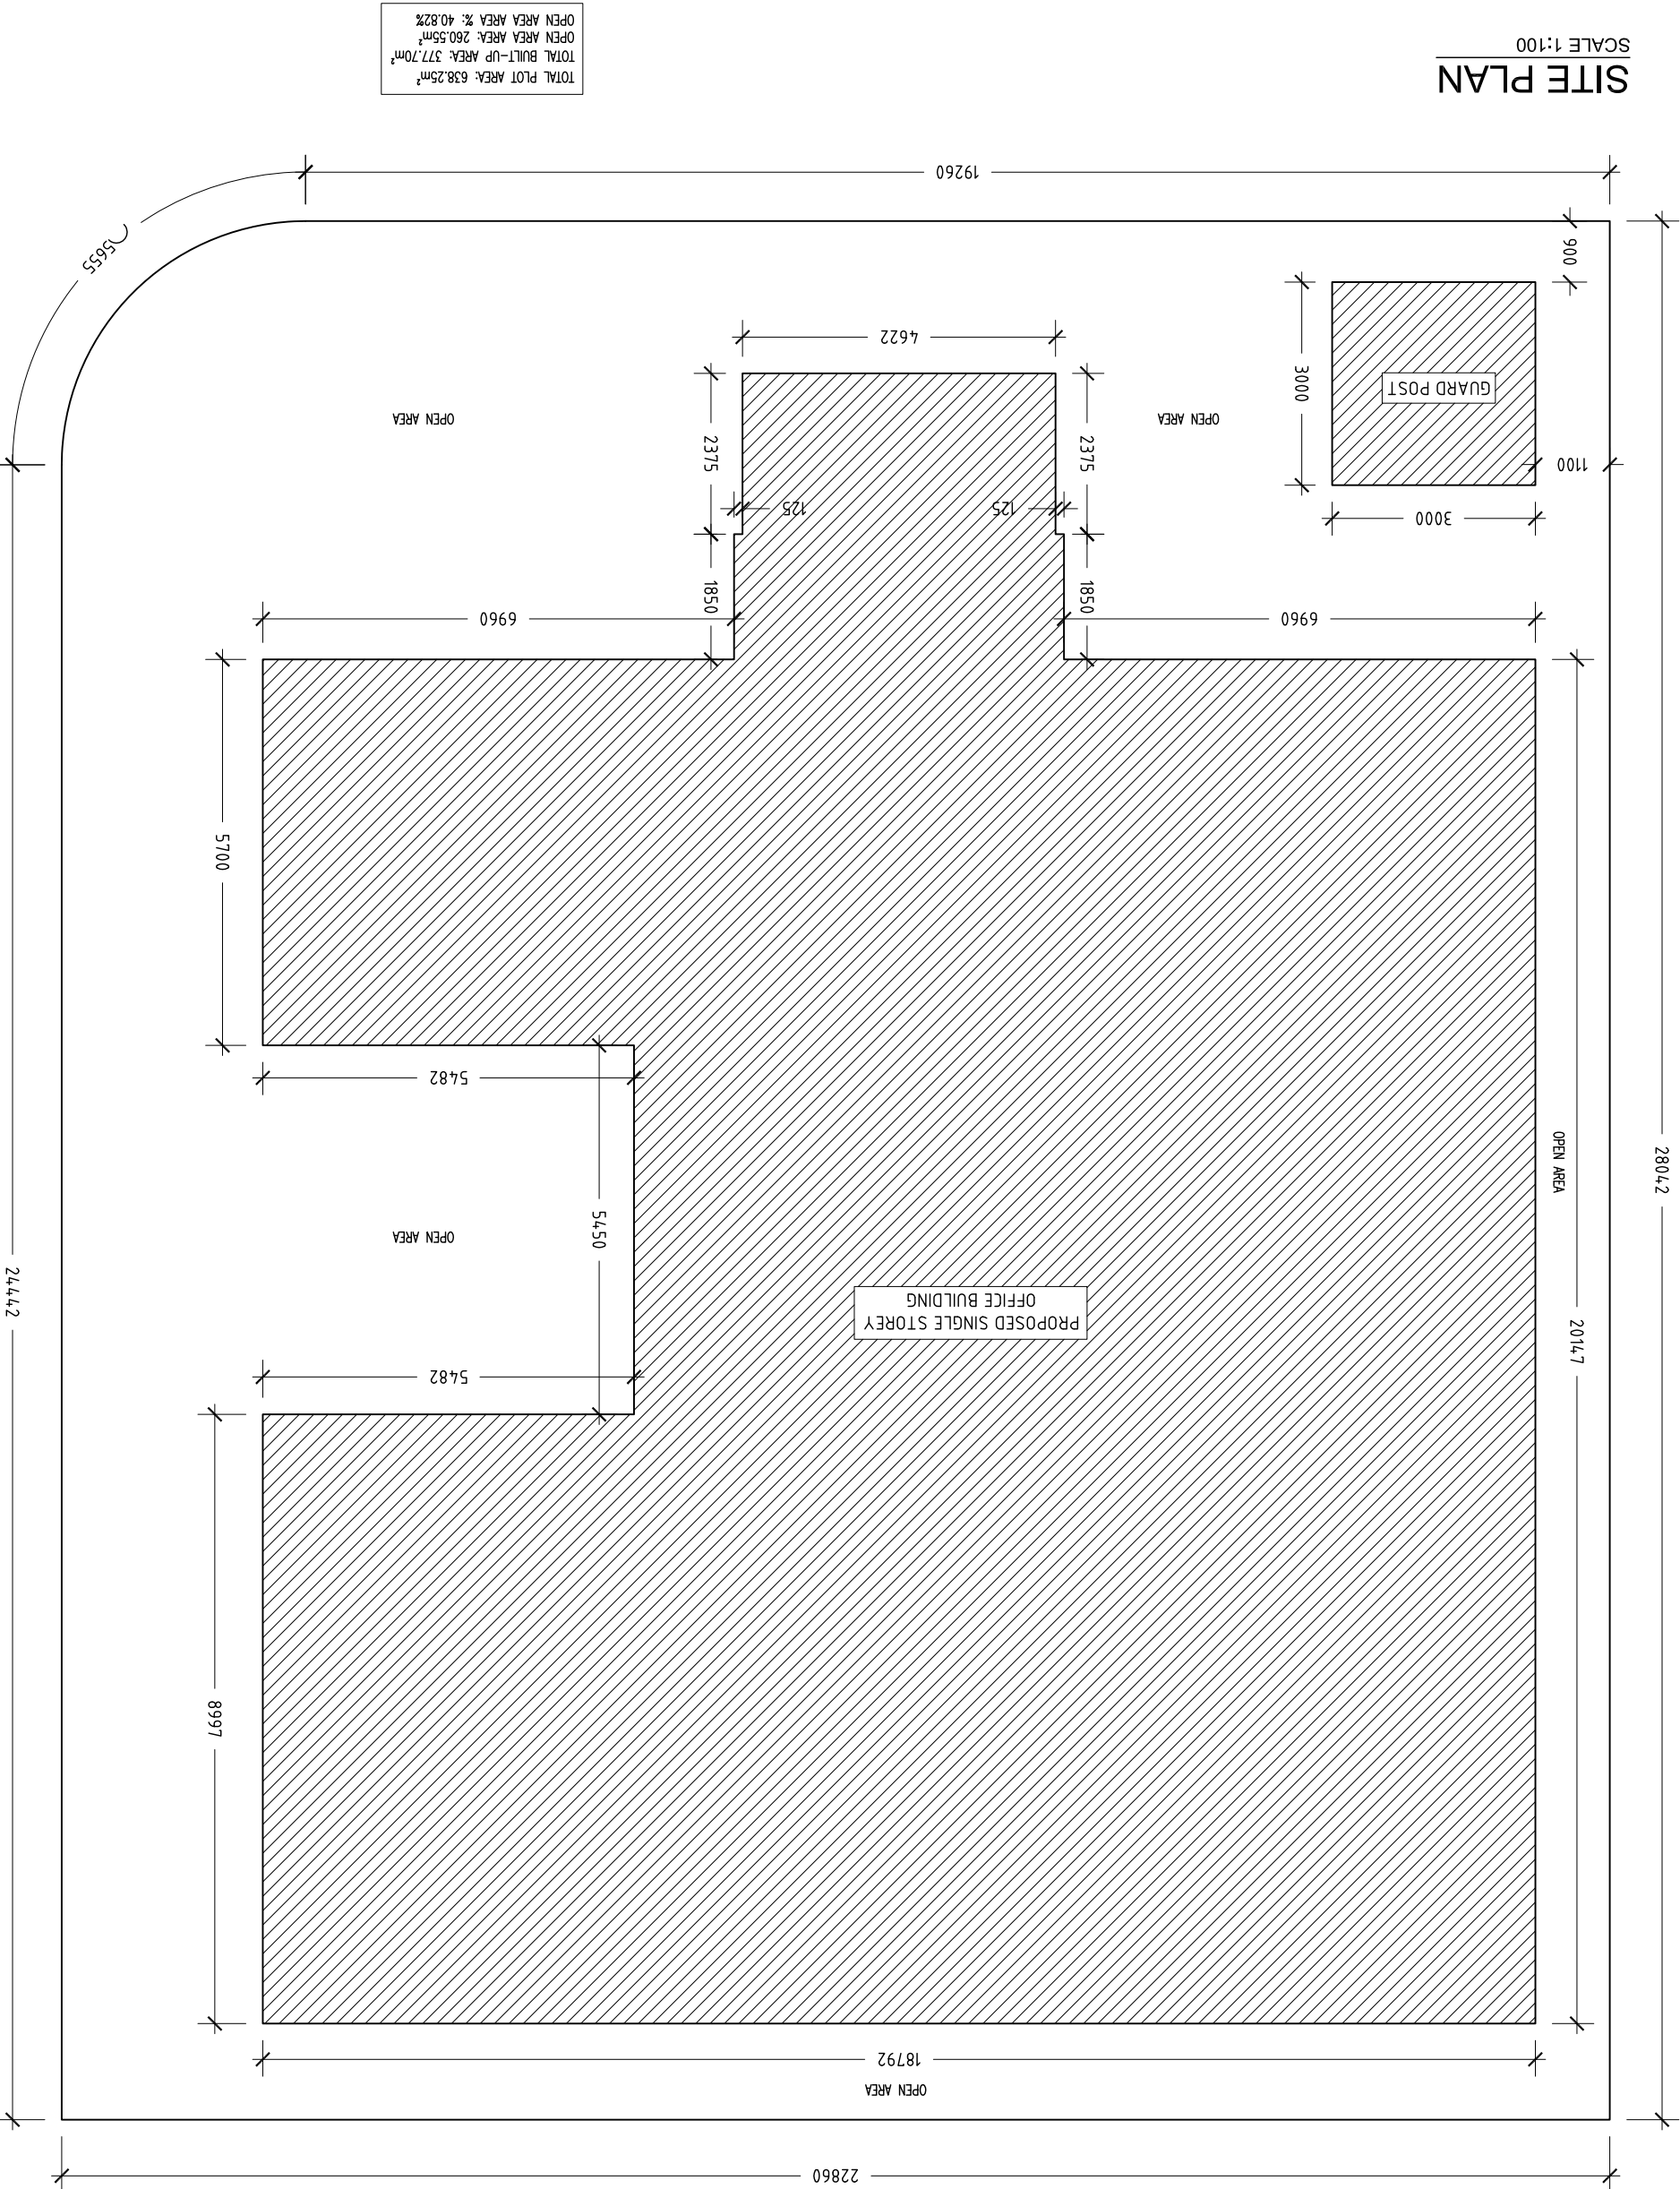

CONTRACTORS MUST CHECK ALL
DIMENSIONS ON SITE BEFORE
STARTING ANY WORK OR SHOP DRAWINGS.
FIGURED DIMENSIONS TO TAKE
PRECEDENCE OVER SCALE READINGS.
DO NOT SCALE DRAWINGS. IN CASE DOUBT,
PLEASE ASK.

ARCHITECTURAL DESIGN (STRUCTURAL DESIGN) CONSULTANT (COST ESTIMATING) AND SURVEYING PROJECTS
1st Floor, Neelekkanth Nagar, Madhavu, Male; 20284
Tel: +960 790 7270 Email: info@adepthmaldives.com




REVISION:

ARCHITECT:	ABDUL WAHID MOAHMED
ENGINEER:	HASSAN NIHAD
SERVICES ENG.:	-
ESTIMATOR:	HASSAN NIHAD
DRAWN BY:	ABDUL WAHID MOAHMED

PROJECT:	COULC OFFICE FOR M. MADUVVARI ISLAND
LOCATION:	MEEMU ATOLL, REPUBLIC OF MALDIVES
DWG TITLE:	AS GIVEN
CLIENT:	OFFICE FOR PROGRAMMES AND PROJECTS (OPP)
SCALE:	AS GIVEN
DIMENSION:	mm
DATE:	07th DECEMBER 2013
PROJECT NO:	AM-2013-00
DWG NO.:	A-02

FLOOR PLAN

SCALE 1:100

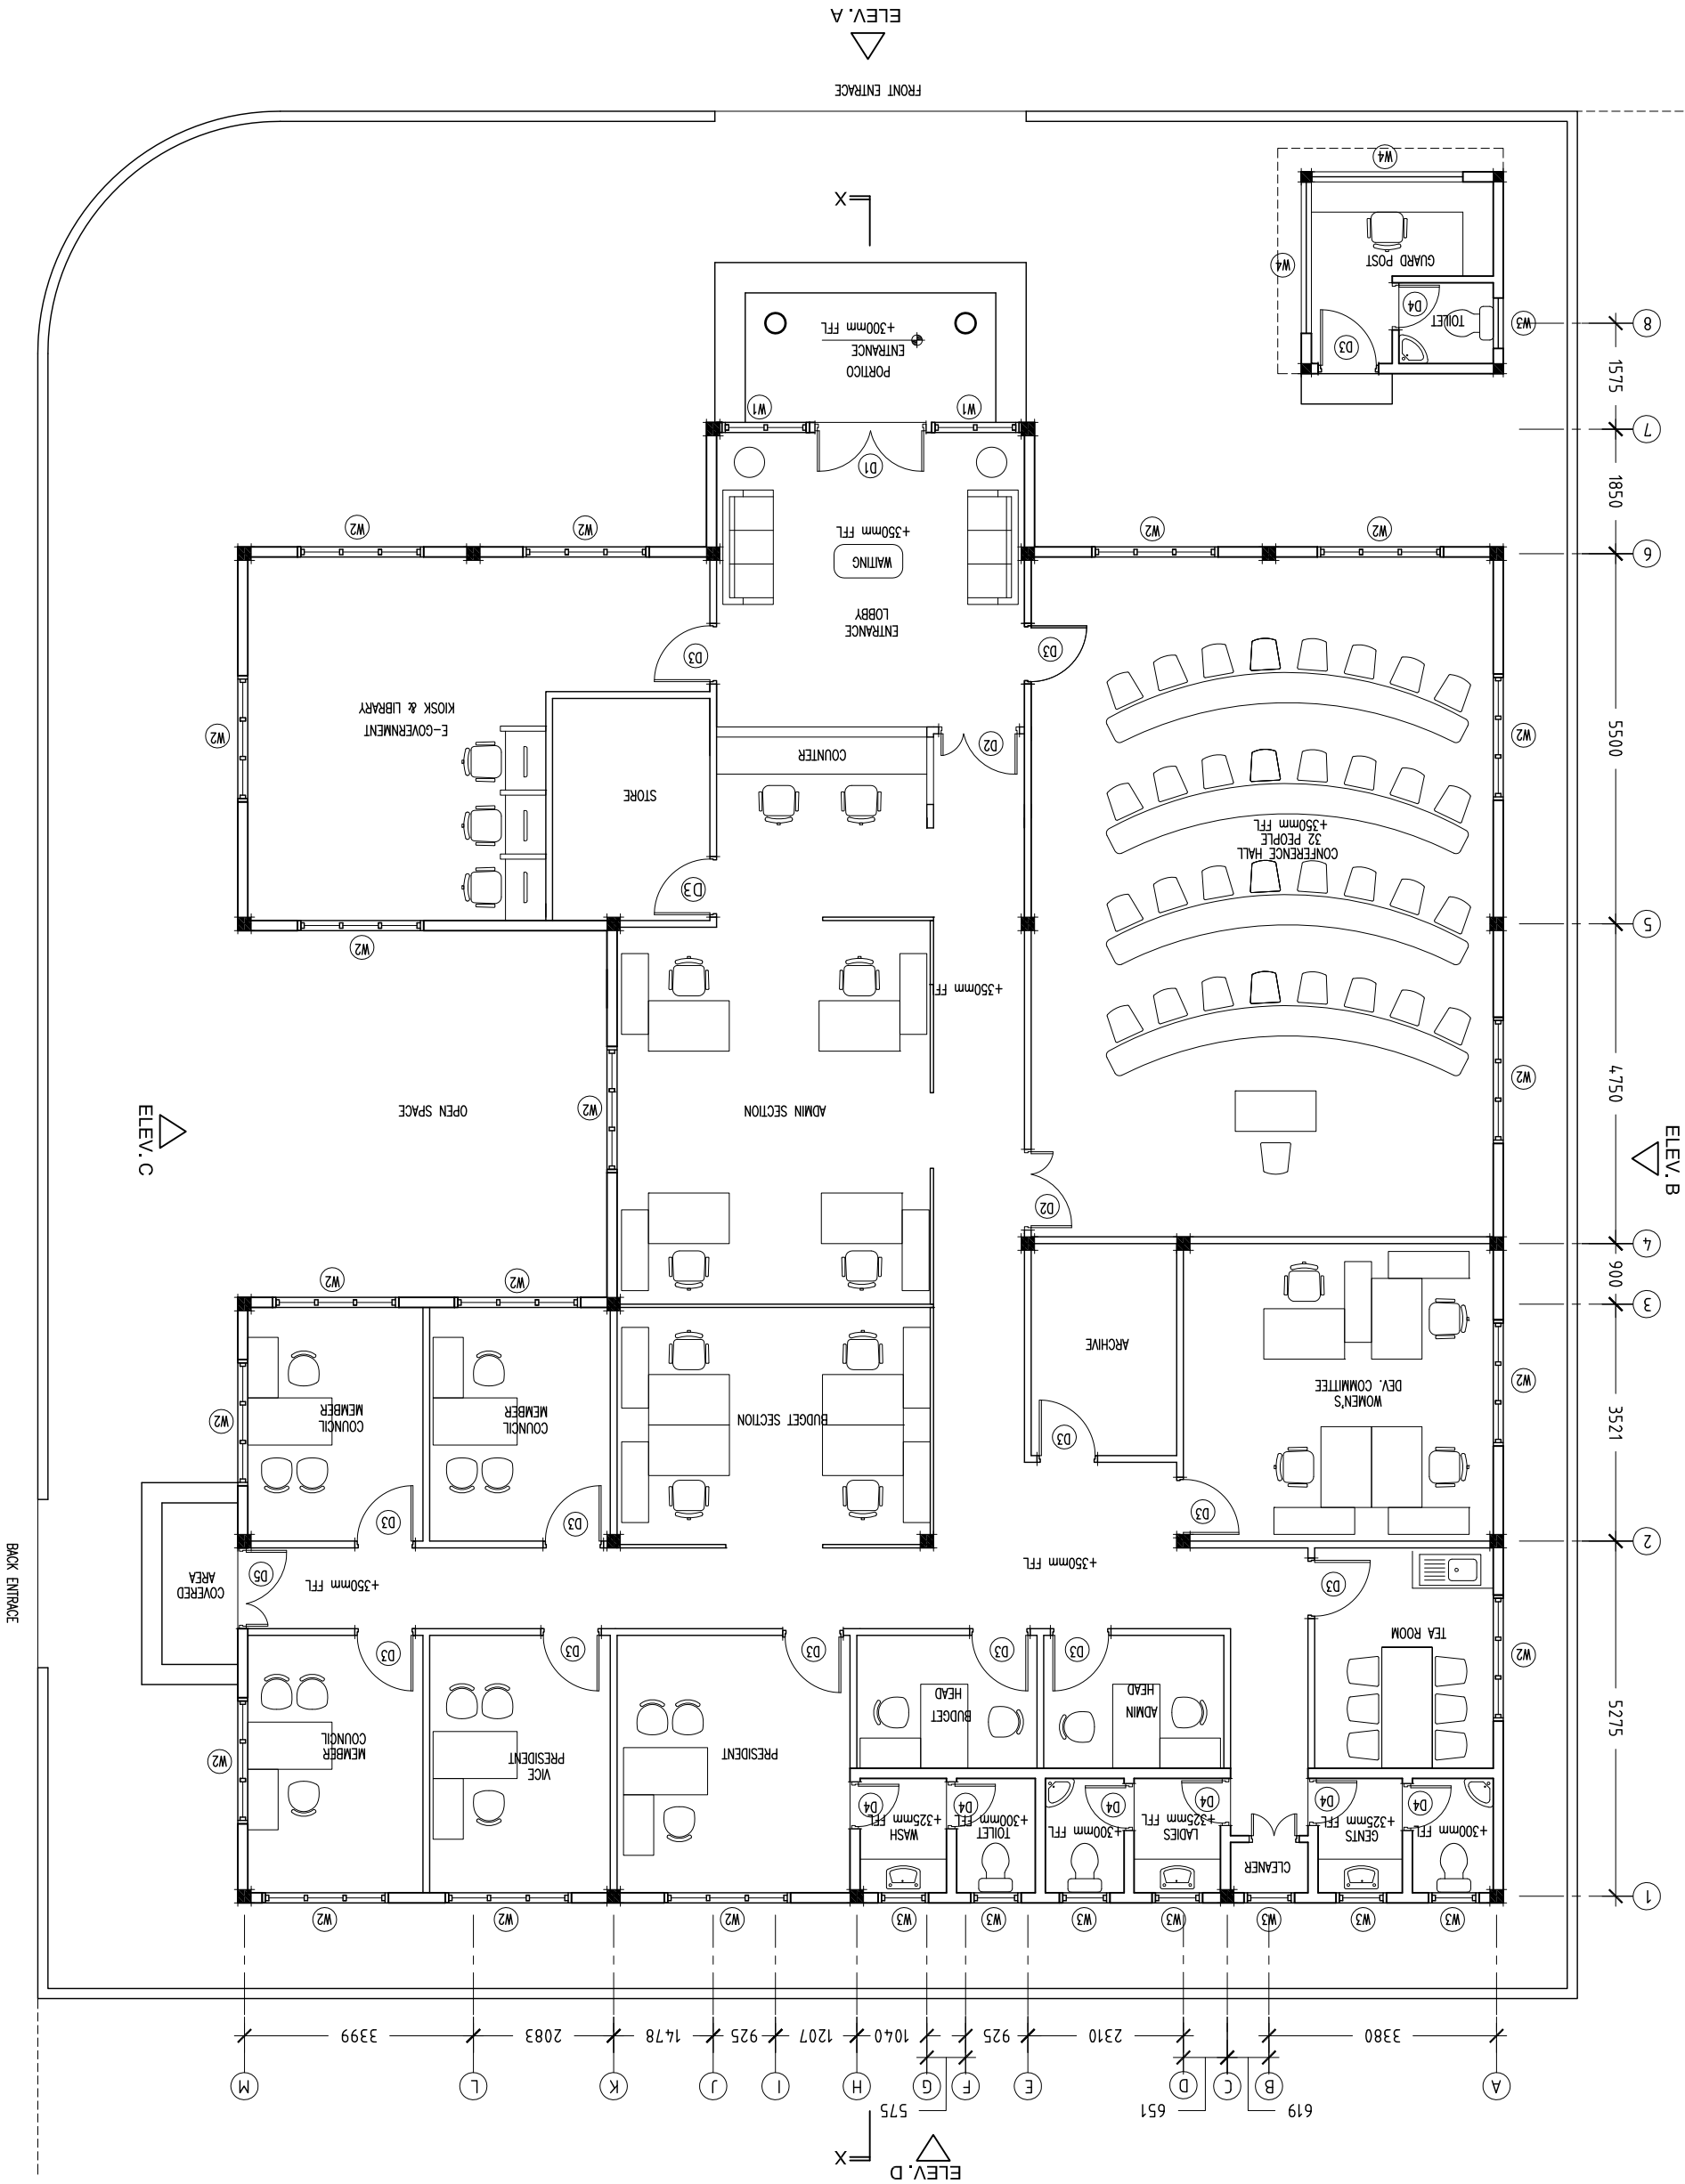

CONTRACTORS MUST CHECK ALL
DIMENSIONS ON SITE BEFORE
STARTING ANY WORK OR SHOP DRAWINGS.
FIGURED DIMENSIONS TO TAKE
PRECEDENCE OVER SCALE READINGS.
DO NOT SCALE DRAWINGS. IN CASE DOUBT,
PLEASE ASK.




REVISION:	
ARCHITECT:	ABDUL WAHID MOAHMED
ENGINEER:	HASSAN NIHAD
SERVICES ENG.:	-
ESTIMATOR:	HASSAN NIHAD
DRAWN BY:	ABDUL WAHID MOAHMED

PROJECT:	COUGL OFFICE FOR M. MADUVVARI ISLAND
LOCATION:	MEEMU ATOLL, REPUBLIC OF MALDIVES
DWG TITLE:	AS GIVEN
CLIENT:	OFFICE FOR PROGRAMMES AND PROJECTS (OPP)
SCALE:	AS GIVEN
DIMENSION:	mm
DATE:	07th DECEMBER 2013
PROJECT NO:	AM-2013-00
DWG NO.:	A-03

FLOOR PLAN

SCALE 1:100


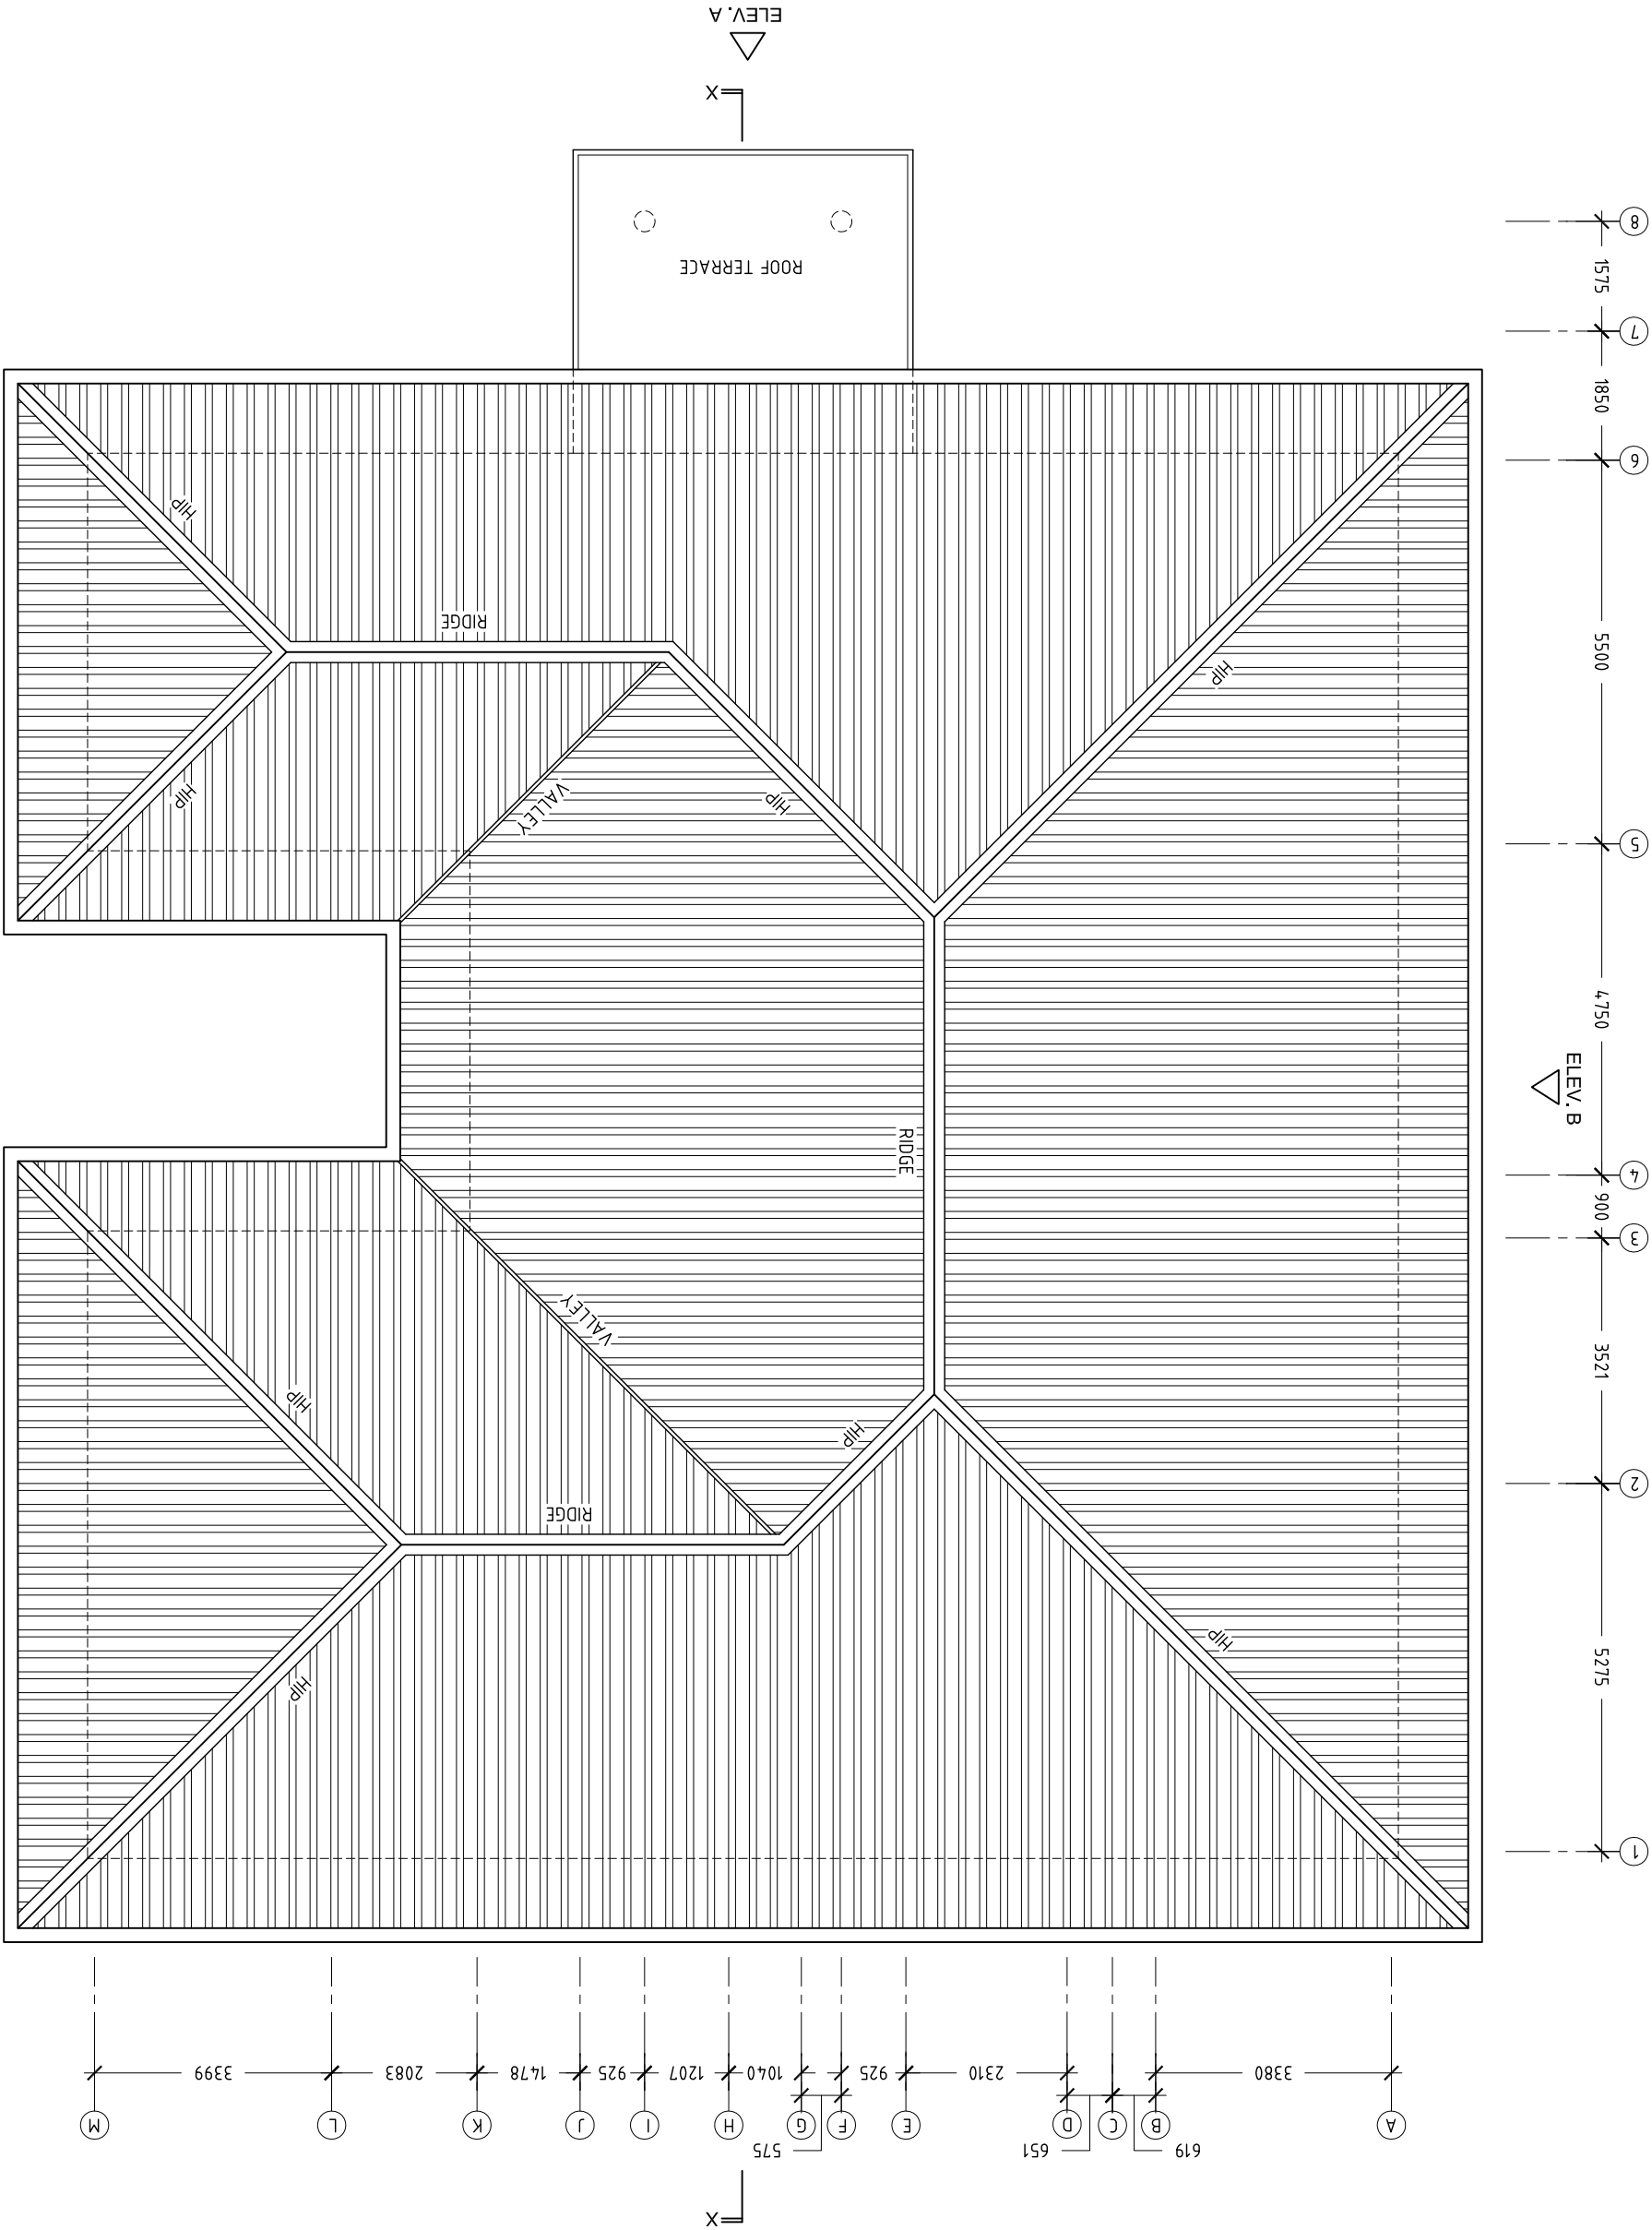


CONTRACTORS MUST CHECK ALL
DIMENSIONS ON SITE BEFORE
STARTING ANY WORK OR SHOP DRAWINGS.
FIGURED DIMENSIONS TO TAKE
PRECEDENCE OVER SCALE READINGS.
DO NOT SCALE DRAWINGS, IN CASE DOUBT,
PLEASE ASK.



ARCHITECTURAL DESIGN (STRUCTURAL DESIGN) CONSULTANT AND SURVEYING PROJECT MANAGEMENT (NEW MALDIVES) PRIVATE LIMITED, UNAUTHORISED USE OR REPRODUCTION OF WHOLE OR PART OF THE CONCEPT, DESIGN OR DRAWINGS TO USE IN ANY OTHER PROJECTS OR SITES OTHER THAN SPECIFIED ON THIS DRAWING IS PROHIBITED.

REVISION:	ARCHITECT: ABDUL WAHID MOAHEMD	ENGINEER: HASSAN NIHAD	SERVICES ENG.: -	ESTIMATOR: HASSAN NIHAD	DRAWN BY: ABDUL WAHID MOAHEMD
PROJECT: COULI OFFICE FOR M. MADUVVARI ISLAND	LOCATION: MEEMU ATOLL, REPUBLIC OF MALDIVES	DWG TITLE.: AS GIVEN	CLIENT: OFFICE FOR PROGRAMMES AND PROJECTS (OPP)	SCALE: AS GIVEN	DIMENSION: mm
PROJECT NO.: AM-2013-00	DWG NO.: A-04	DATE: 07th DECEMBER 2013	CONCEPT AND DESIGN IN THIS DRAWING ARE THE PROPERTIES OF ADEPT MALDIVES PRIVATE LIMITED. UNAUTHORISED USE OR REPRODUCTION OF WHOLE OR PART OF THE CONCEPT, DESIGN OR DRAWINGS TO USE IN ANY OTHER PROJECTS OR SITES OTHER THAN SPECIFIED ON THIS DRAWING IS PROHIBITED.		

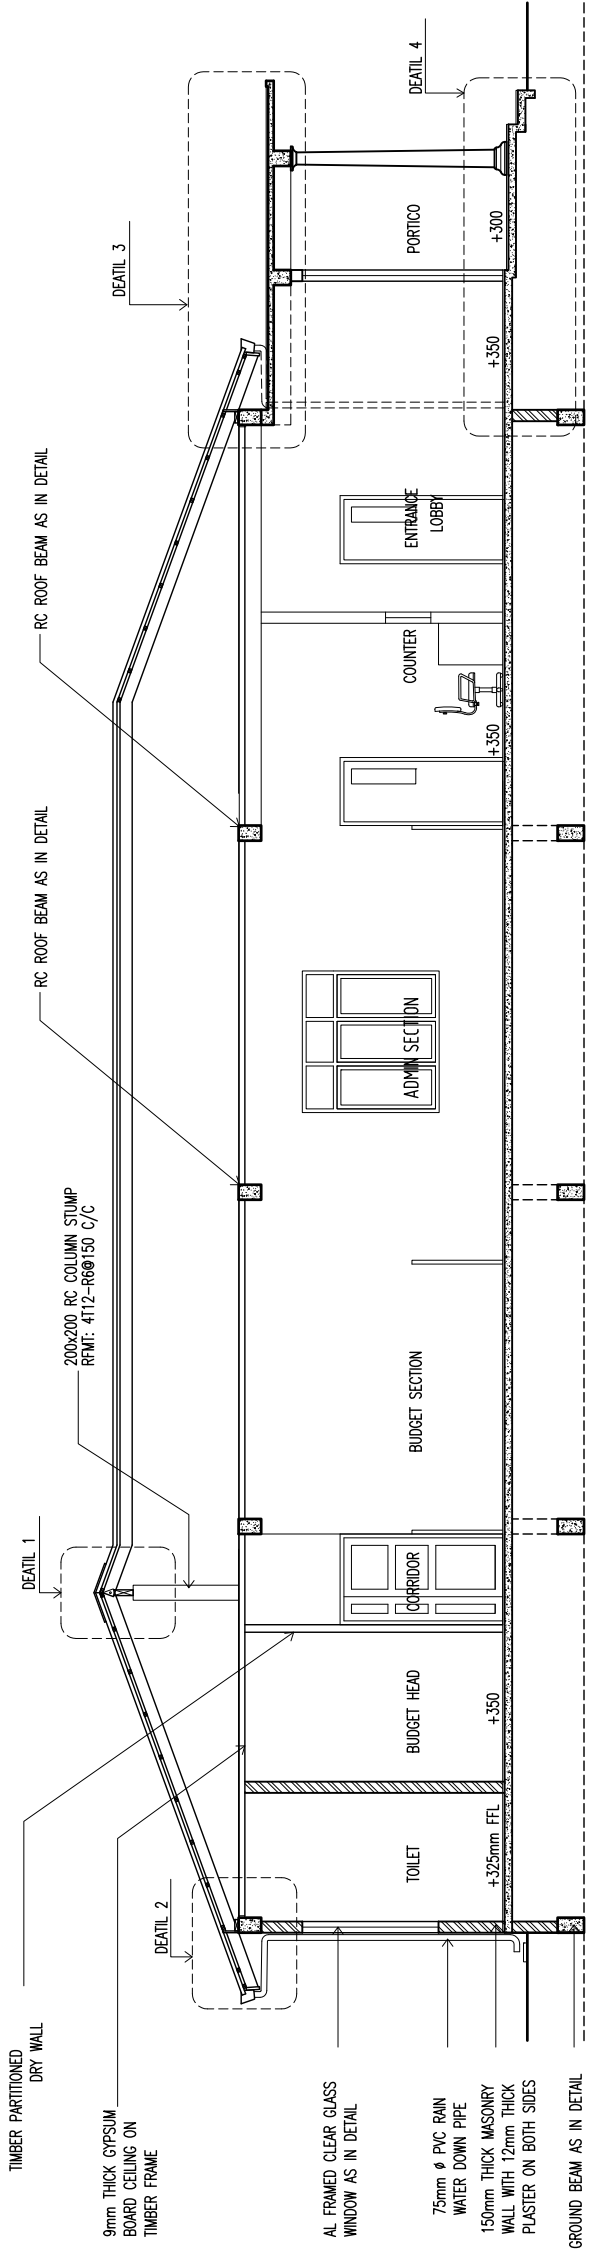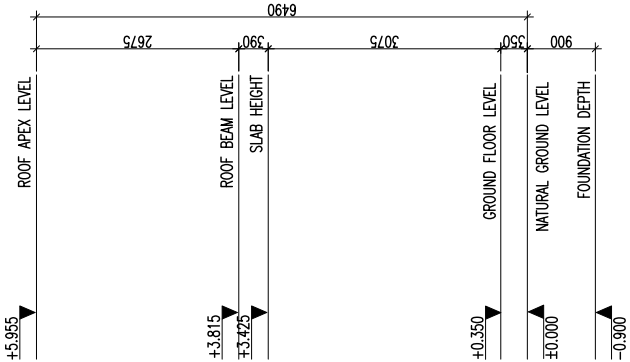

SECTION X-X
SCALE 1:100

CONTRACTORS MUST CHECK ALL
DIMENSIONS ON SITE BEFORE
STARTING ANY WORK OR SHOP DRAWINGS,
PRECEDENCE OVER SCALE READINGS.
DO NOT SCALE DRAWINGS, IN CASE DOUBT,
PLEASE ASK.

adept

maldives pvt ltd

1st Floor, Neebharunage, Meemnu, Male', 2024
Tel: +960 790 7270 Email: info@adeptmaldives.com


CONCEPT AND DESIGN OF ADEPT MALDIVES PRIVATE LIMITED, UNAUTHORISED USE OR REPRODUCTION OF WHOLE OR PART OF THE CONCEPT, DESIGN OR DRAWINGS TO USE IN ANY OTHER PROJECTS OR SITES OTHER THAN SPECIFIED ON THIS DRAWING IS PROHIBITED.

REVISION:	ARCHITECT: ABDUL WAHID MOAHMED
	ENGINEER: HASSAN NIHAD
	SERVICES ENG.: -
	ESTIMATOR: HASSAN NIHAD
	DRAWN BY: ABDUL WAHID MOAHMED


PROJECT:	COUGL OFFICE FOR M. MADUVARISLAND
LOCATION:	MEEMU ATOLL, REPUBLIC OF MALDIVES
DWG TITLE:	AS GIVEN
CLIENT:	OFFICE FOR PROGRAMMES AND PROJECTS (OPP)
SCALE:	AS GIVEN
DIMENSION:	mm
DATE:	07th DECEMBER 2013
PROJECT NO:	AM-2013-00
DWG NO.:	


A-06

ELEVATION - D
SCALE 1:100

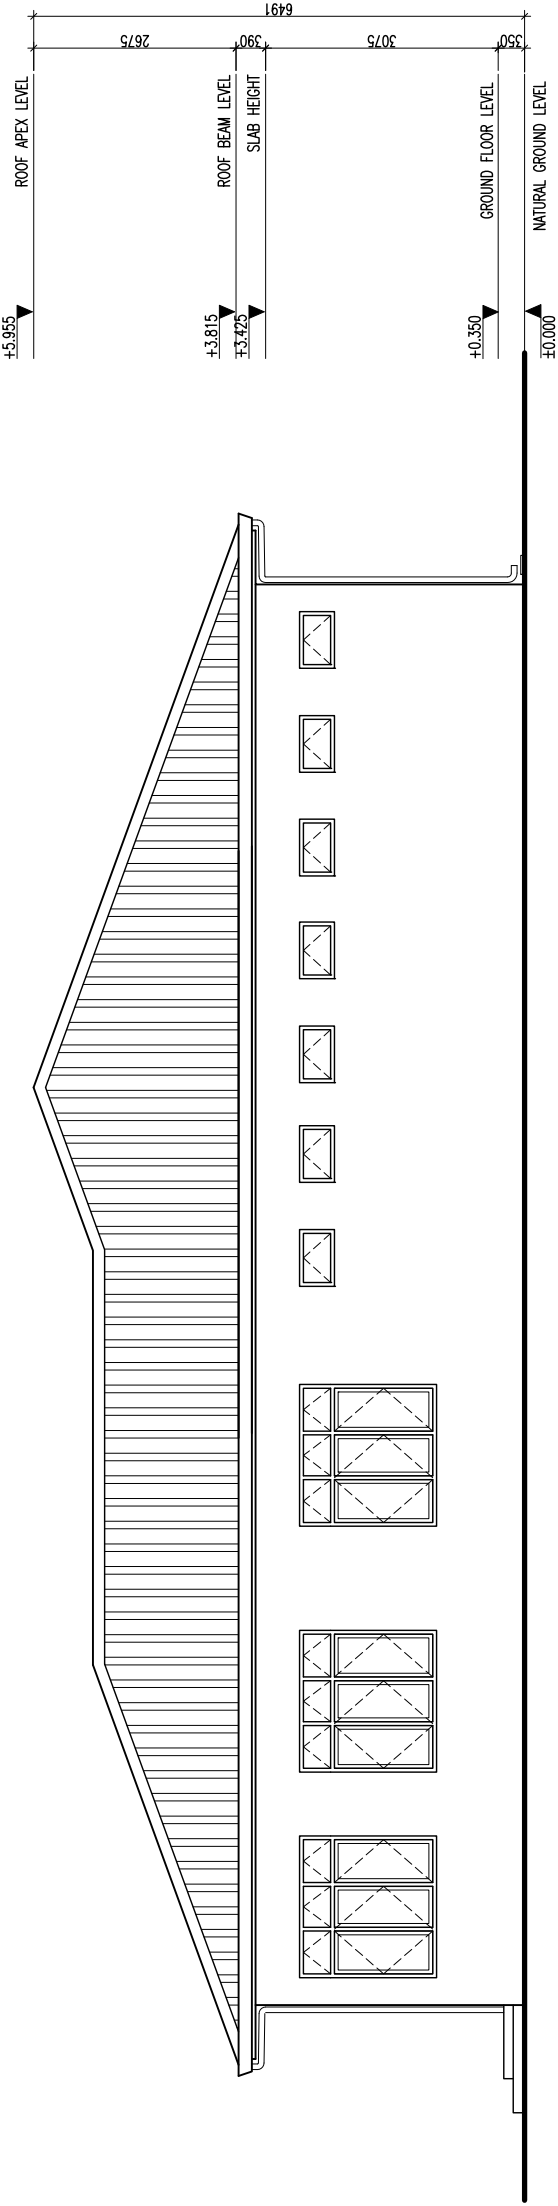


ELEVATION - C
SCALE 1:100

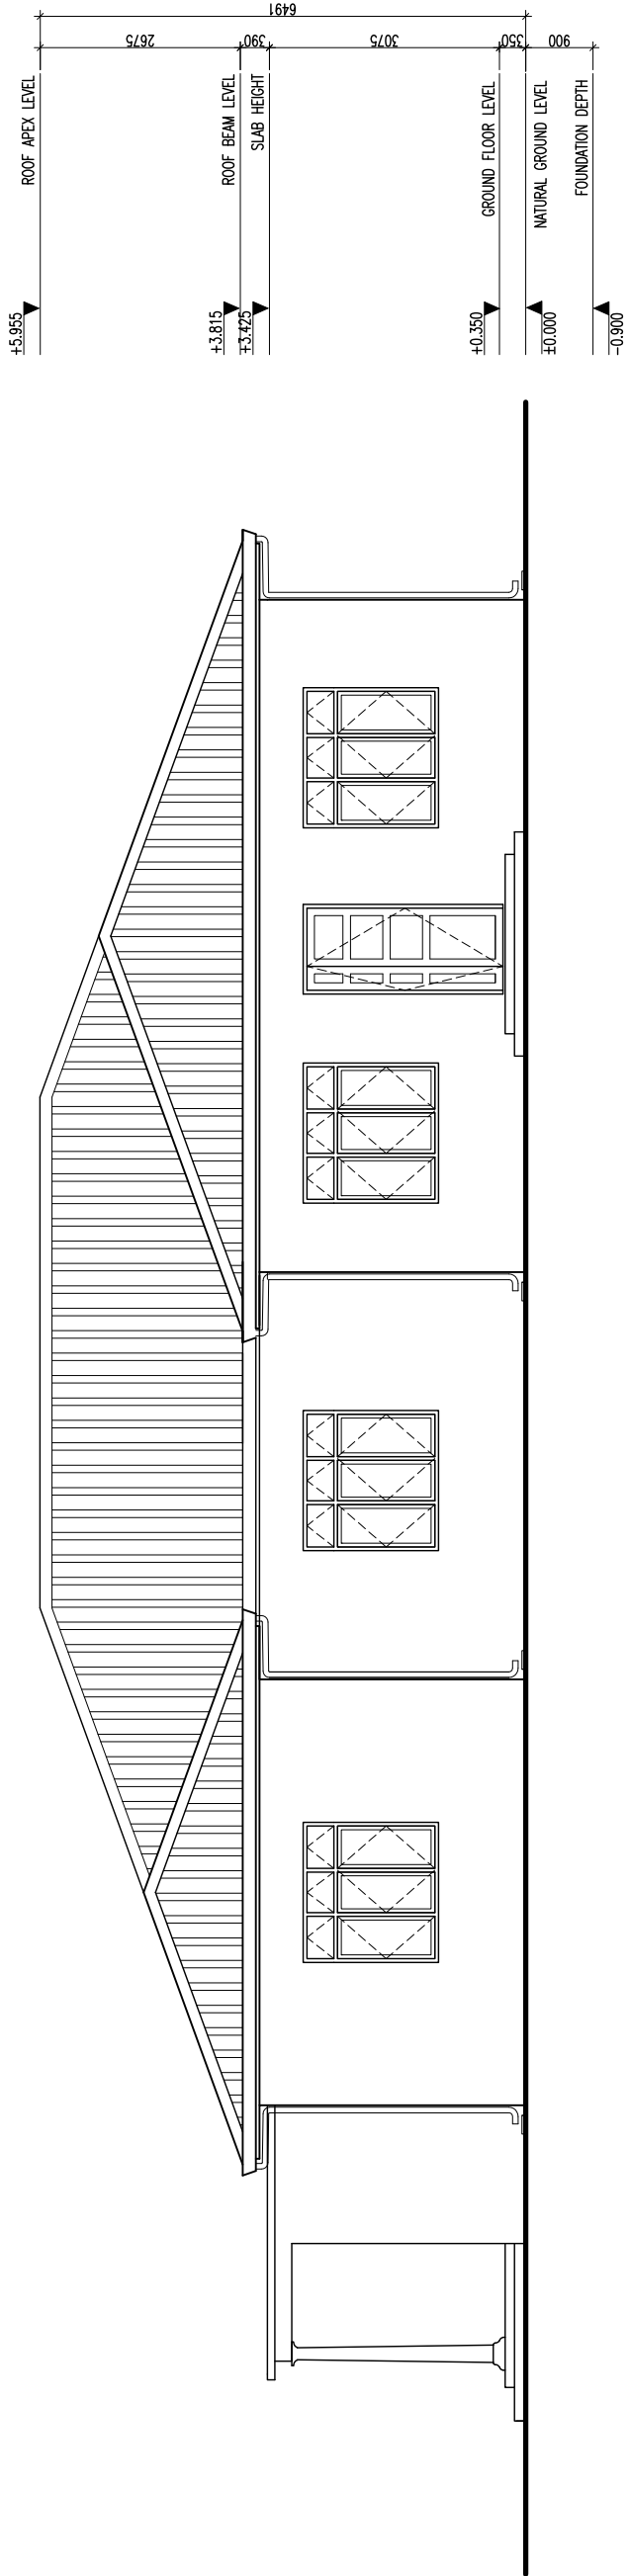

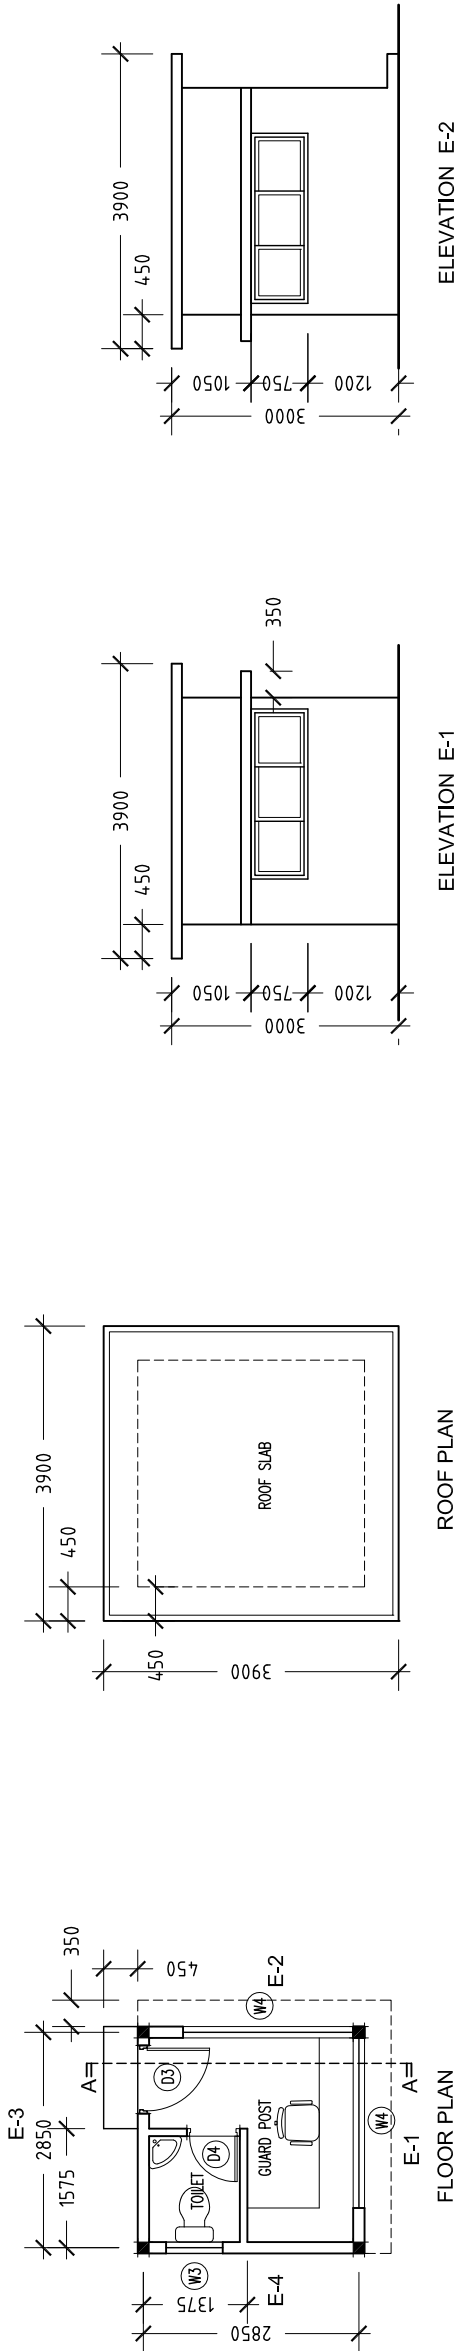

CONTRACTORS MUST CHECK ALL DIMENSIONS ON SITE BEFORE STARTING ANY WORK OR SHOP DRAWINGS. FIGURED DIMENSIONS TO TAKE PRECEDENCE OVER SCALE READINGS. DO NOT SCALE DRAWINGS, IN CASE DOUBT, PLEASE ASK.

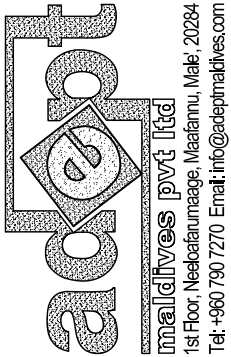





REVISION:





ARCHITECT: ABDUL WAHID MOAHEMD
ENGINEER: HASSAN NIHAD
SERVICES ENG.: -
ESTIMATOR: HASSAN NIHAD
DRAWN BY: ABDUL WAHID MOAHEMD

PROJECT: COUCIL OFFICE FOR M. MADUVVARI ISLAND
LOCATION: MEEMU ATOLL, REPUBLIC OF MALDIVES
DWG TITLE.: AS GIVEN
CLIENT: OFFICE FOR PROGRAMMES AND PROJECTS (OPP)
SCALE: AS GIVEN
DIMENSION: mm

A-08
DWG NO.:
PROJECT NO: AM-2013-00

ARCHITECTURAL DESIGN | STRUCTURAL DESIGN | COASTAL DESIGN | COST ESTIMATION | LAND SURVEYING | PROJECT MANAGEMENT | URBAN PLANNING | MANAGEMENT CONSULTANCY

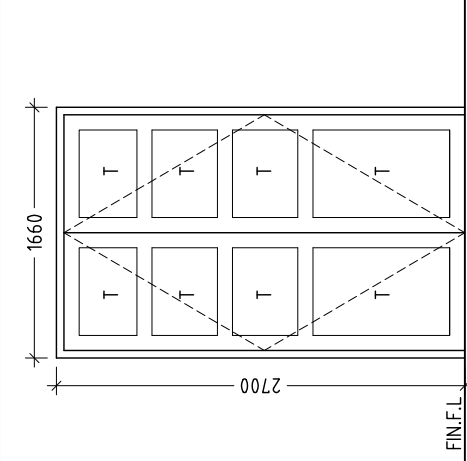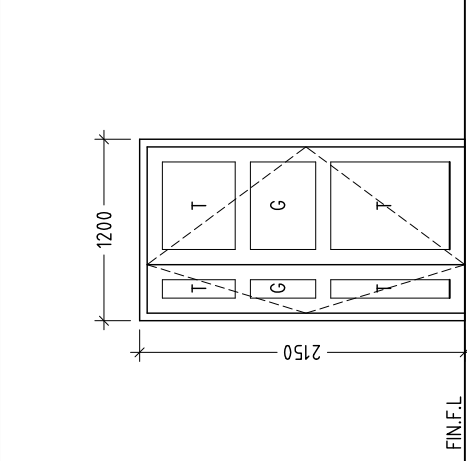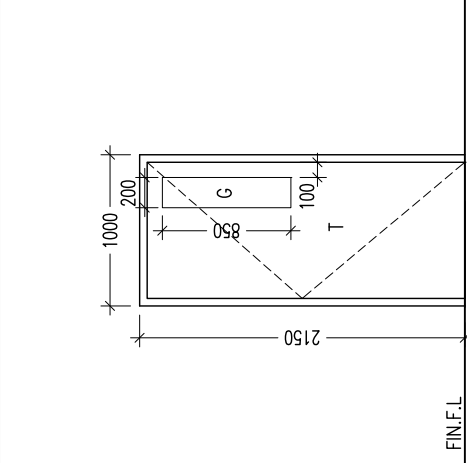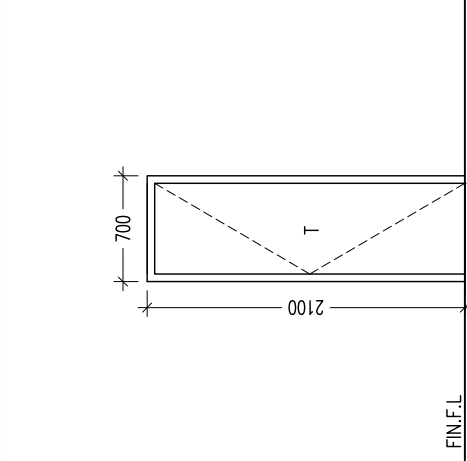 FIN.F.L.	 FIN.F.L.	 FIN.F.L.	 FIN.F.L.
DOOR NO. D1	DOOR NO. D2	DOOR NO. D3	DOOR NO. D4
DOOR FRAME Timber framed Door	DOOR FRAME Timber framed Door	DOOR FRAME Timber framed Door	DOOR FRAME Timber framed Door
REMARKS Treated timber panel	REMARKS Clear glass fixed at mid of door panel	REMARKS -	REMARKS -

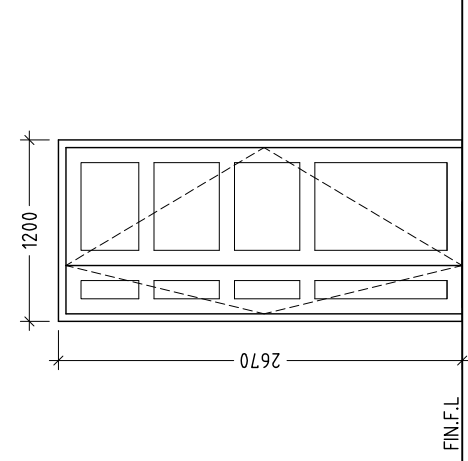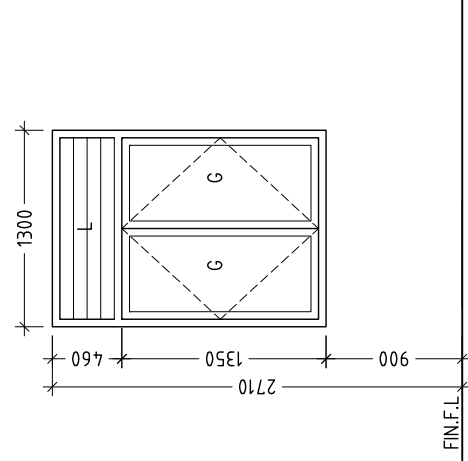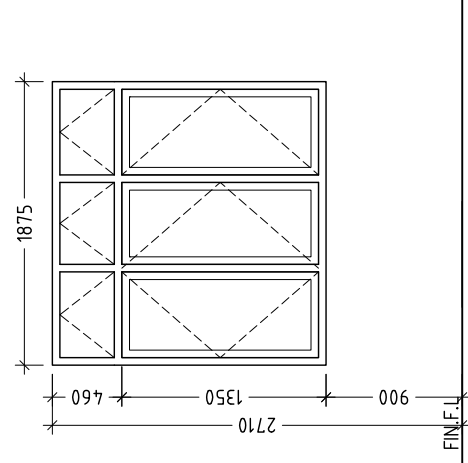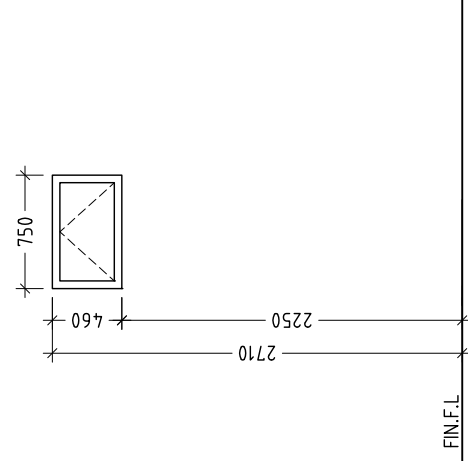 FIN.F.L.	 FIN.F.L.	 FIN.F.L.	 FIN.F.L.
WINDOW NO. D5	WINDOW NO. W1	WINDOW NO. W2	WINDOW NO. W3
FRAME Aluminium frame	FRAME Aluminium frame	FRAME Aluminium frame	FRAME Aluminium frame
REMARKS -	REMARKS -	REMARKS -	REMARKS -

GENERAL NOTES

Dimensions shown on drawings indicate effective openings of frame. All wooden frame depths are 75mm. Wooden door panel thickness = 35mm.

External units must comply the following weather conditions: –Wind pressure: 200Kg/sqm. –Water tightness: 25Kg/sqm.

All external frames/ wall joints must be sealed with silicon sealant and wedges trimmed with 12x12mm H/W beading fixed to frames by brass nails.

All hardwood shall be provided for the performance of all functions of the units.

Hinges shall conform to Door size more than 700Wx2100H WD: 125mmx2 sets SD: 150mmx3 sets Door size less than 700Wx2100H WD: 100mmx2 sets SD: 150mmx3 sets locks shall be cylindrical w/master keysets. Door knobs shall be 900mm above finished floor level.

Door swings are indicated on the floor plans.


All elevations shown from outside and window swings DEFINED on the schedule.

LEGEND:
FG: 6mm thk. fixed glazing
G: 6mm thk. clear glazing
L: aluminium louvers
T: Treated Timber

DOOR/WINDOW SCHEDULE
SCALE 1:50

CONTRACTORS MUST CHECK ALL
DIMENSIONS ON SITE BEFORE
STARTING ANY WORK OR SHOP DRAWINGS,
FIGURED DIMENSIONS TO TAKE
PRECEDENCE OVER SCALE READINGS.
DO NOT SCALE DRAWINGS, IN CASE DOUBT,
PLEASE ASK.

ARCHITECTURAL DESIGN | STRUCTURAL DESIGN | COASTAL DESIGN | COST ESTIMATION | LAND SURVEYING | PROJECT MANAGEMENT | URBAN PLANNING | MANAGEMENT CONSULTANCY

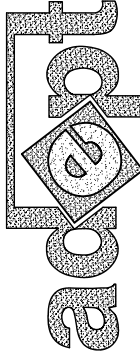

maldives pvt ltd
1st Floor, Neebafarumage, Maafannu, Male, 20284
Tel: +960 790 7270 Email: info@adeptmaldives.com

REVISION:

ARCHITECT: ABDUL WAHID MOAHEMD

ENGINEER: HASSAN NIHAD

SERVICES ENG.: - DWG TITLE: AS GIVEN


ESTIMATOR: HASSAN NIHAD
CLIENT: OFFICE FOR PROGRAMMES AND PROJECTS (OPP)

DRAWN BY:	ABDUL WAHID MOAHEMD	SCALE:	AS GIVEN	DIMENSION:	mm	DATE:	07th DECEMBER 2013
-----------	---------------------	--------	----------	------------	----	-------	--------------------

PROJECT NO: AM-2013-00


PROJECT NO: AM-2013-00

CONCEPT AND DESIGN IN THIS DRAWING ARE THE PROPERTIES OF ADEPT MALDIVES PRIVATE LIMITED. UNAUTHORISED USE OR REPRODUCTION OF WHOLE OR PART OF THE CONCEPT, DESIGN OR DRAWINGS TO USE IN ANY OTHER PROJECTS OR SITES OTHER THAN SPECIFIED ON THIS DRAWING IS PROHIBITED.


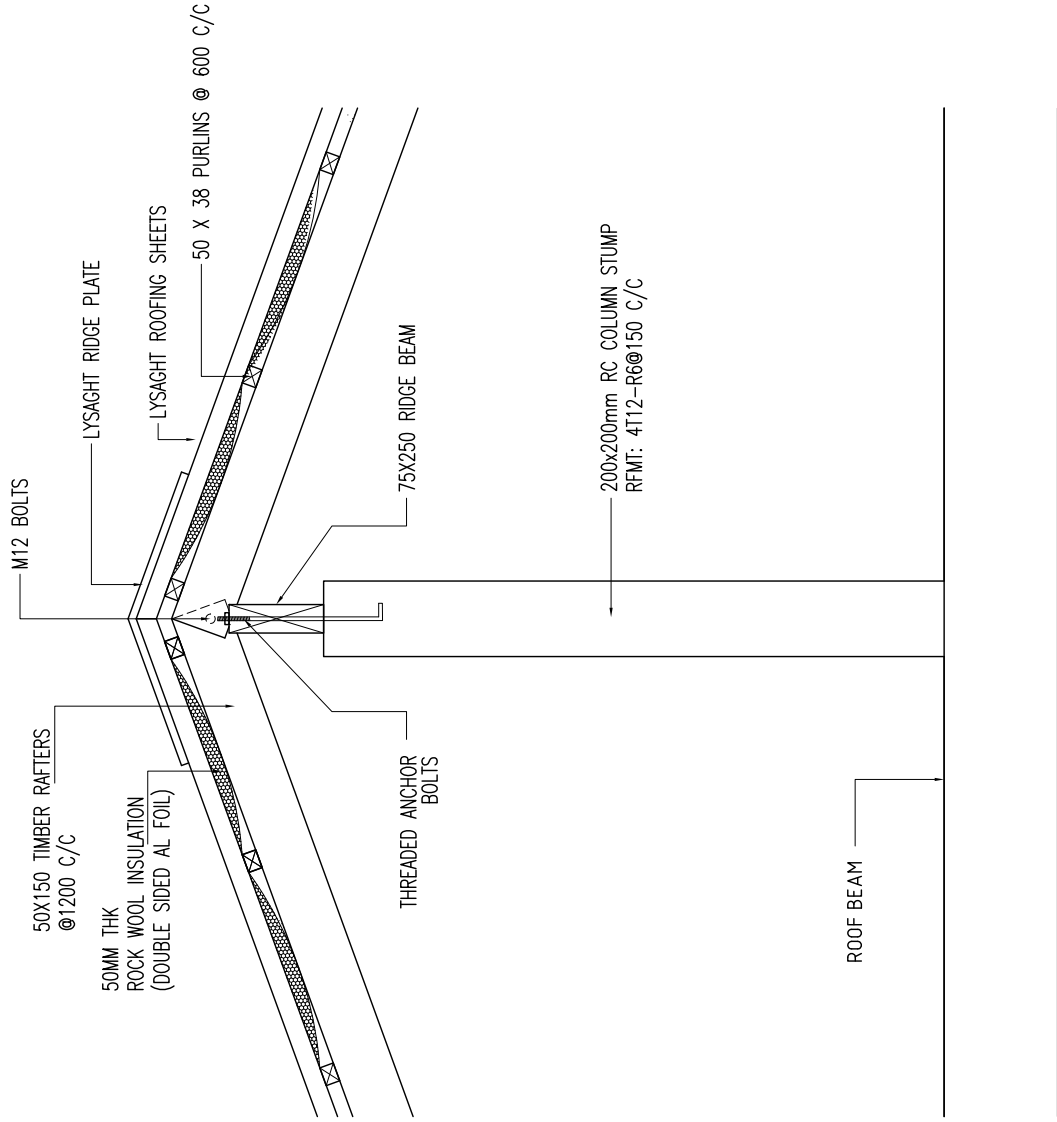


NOTE: PROVIDE ANCHORAGE AT ALL OTHER RAFTER - RC BEAM JOINTS

DETAIL -1
SCALE 1:20

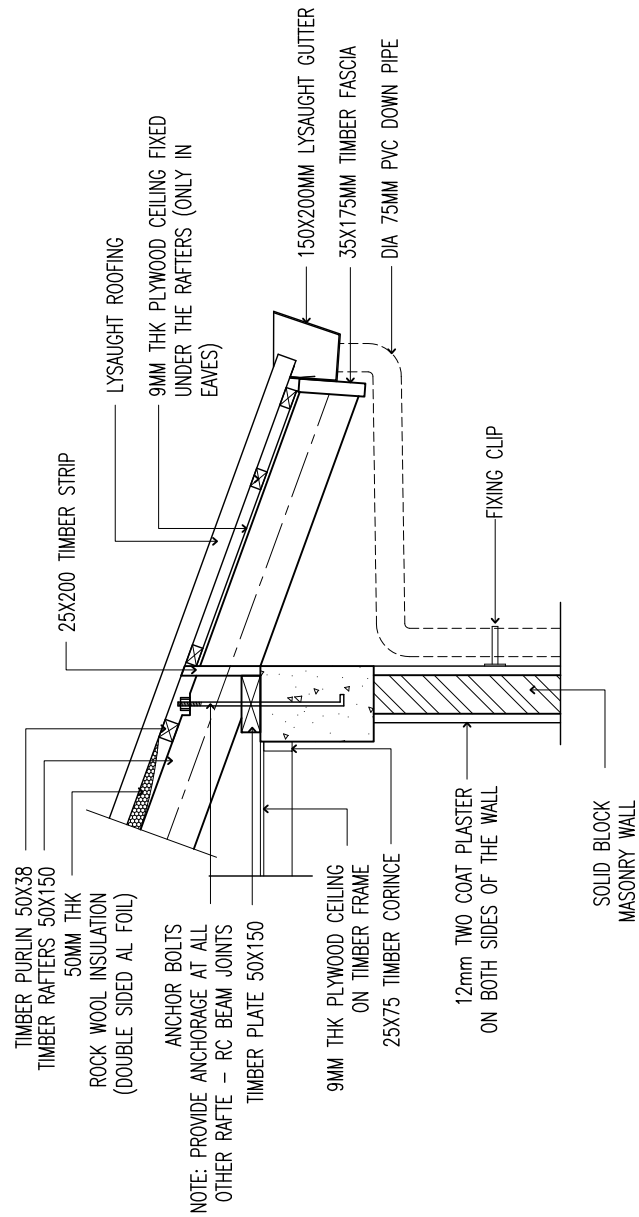

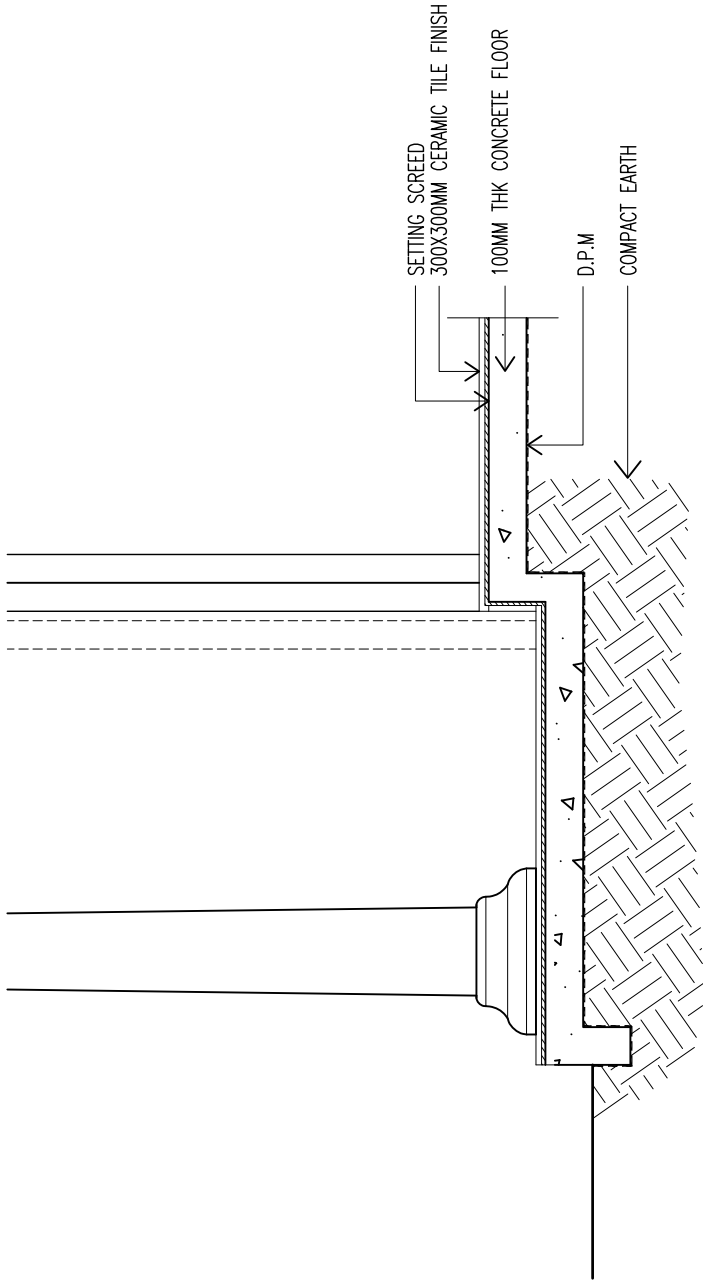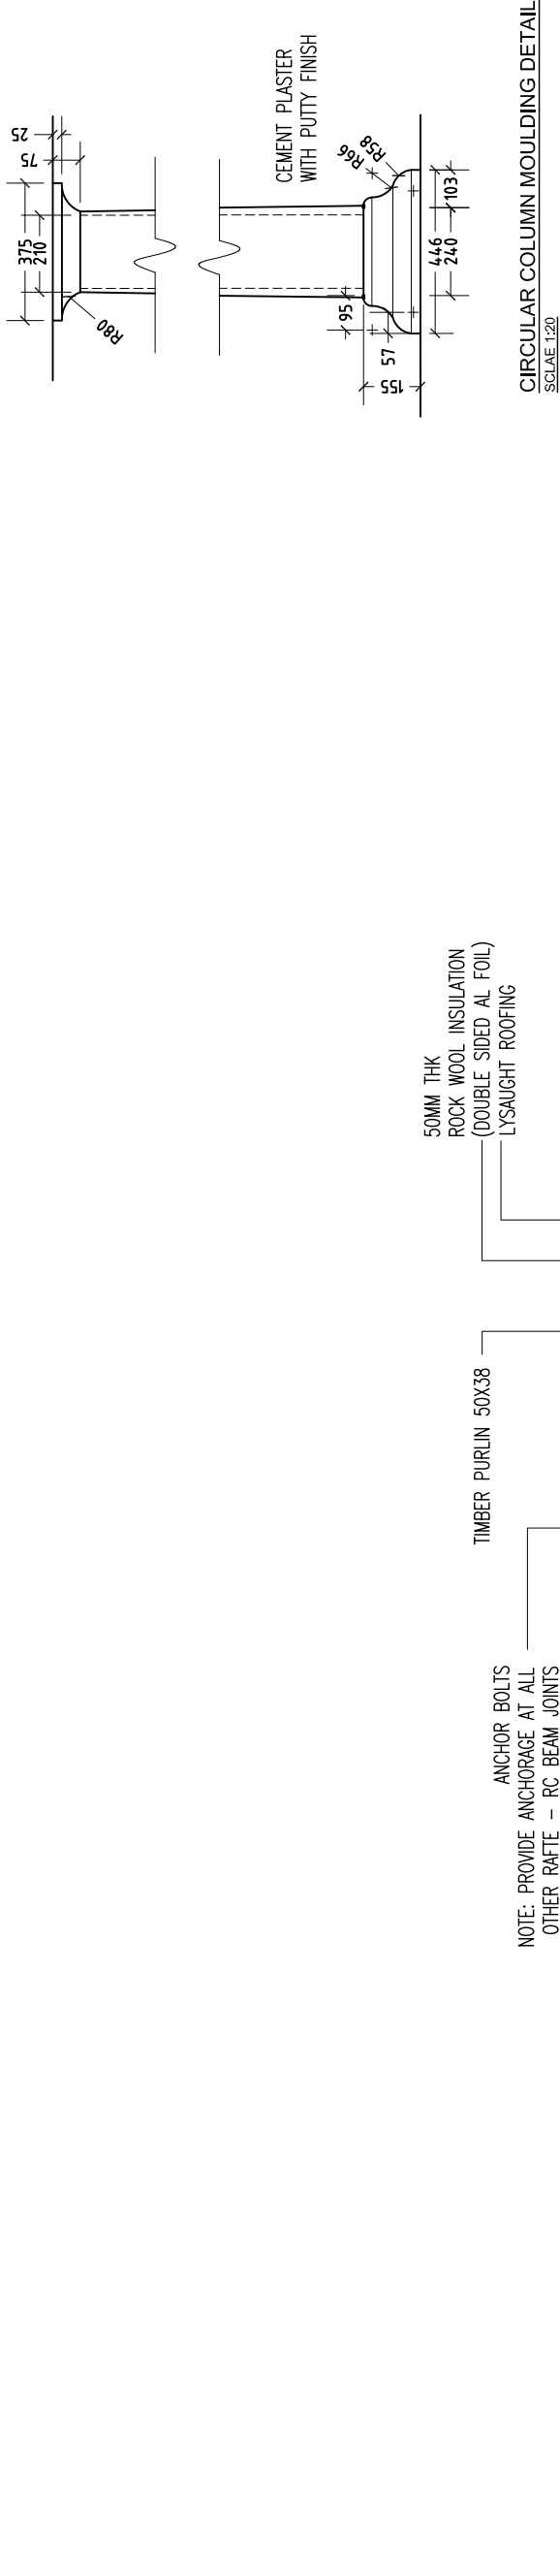

DETAIL -2
SCALE 1:20




DETAIL -4
SCALE 1:20

CONTRACTORS MUST CHECK ALL DIMENSIONS ON SITE BEFORE STARTING ANY WORK OR SHOP DRAWINGS, FIGURED DIMENSIONS TO TAKE PRECEDENCE OVER SCALE READINGS. DO NOT SCALE DRAWINGS, IN CASE DOUBT, PLEASE ASK.	REVISION:		ARCHITECT:	ABDUL WAHID MOAHEMD	PROJECT:	COUCIL OFFICE FOR M. MADUVVARI ISLAND		A-11
			ENGINEER:	HASSAN NIHAD	LOCATION:	MEEMU ATOLL, REPUBLIC OF MALDIVES		
			SERVICES ENG.:	-	DWG TITLE::	AS GIVEN		
			ESTIMATOR:	HASSAN NIHAD	CLIENT:	OFFICE FOR PROGRAMMES AND PROJECTS (OPP)		
			DRAWN BY:	ABDUL WAHID MOAHEMD	SCALE:	AS GIVEN	DIMENSION: mm	
PROJECT NO: AM-2013-00								



maldives pvt ltd
1st Floor, Neelofarunage, Maafannu, Male, 20284
Tel: +960 790 7270 Email: info@adeptmaldives.com

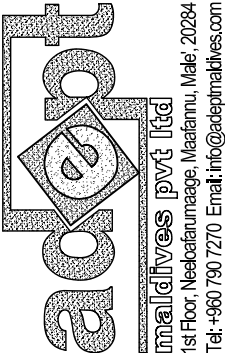

CONTRACTORS MUST CHECK ALL DIMENSIONS ON SITE BEFORE STARTING ANY WORK OR SHOP DRAWINGS, FIGURED DIMENSIONS TO TAKE PRECEDENCE OVER SCALE READINGS. DO NOT SCALE DRAWINGS, IN CASE DOUBT, PLEASE ASK.

adept

maldives pvt ltd

1st Floor, Neelatarunage, Maafanu, Male, 20284

Tel: +960 790 7270 Email: info@adeptmaldives.com

REVISION:

ARCHITECT:	ABDUL WAHID MOAHMED
ENGINEER:	HASSAN NIHAD
SERVICES ENG.:	-
ESTIMATOR:	HASSAN NIHAD
DRAWN BY:	ABDUL WAHID MOAHMED


PROJECT:	COUCIL OFFICE FOR M. MADUVVARI ISLAND		
LOCATION:	MEEMU ATOLL, REPUBLIC OF MALDIVES		
DWG TITLE.:	AS GIVEN		
CLIENT:	OFFICE FOR PROGRAMMES AND PROJECTS (OPP)		
SCALE:	AS GIVEN	DIMENSION: mm	DATE: 07th DECEMBER 2013

A-12

DWG NO.:


PROJECT NO: AM-2013-00

ARCHITECTURAL DESIGN | STRUCTURAL DESIGN | COASTAL DESIGN | COST ESTIMATION | LAND SURVEYING | PROJECT MANAGEMENT | URBAN PLANNING | MANAGEMENT CONSULTANCY

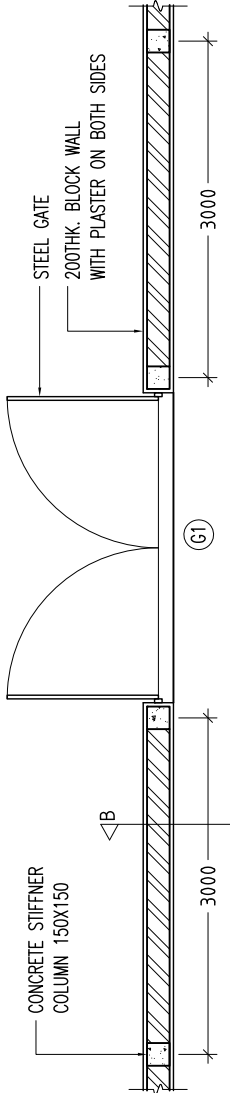


BOUNDARY WALL / ENTRANCE GATE DETAIL
(PLAN)

SCALE 1:50

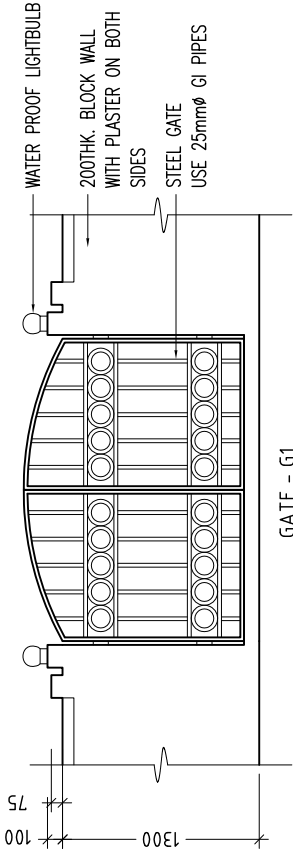

ENTRANCE GATE DETAIL
(ELEVATION)

SCALE 1:50

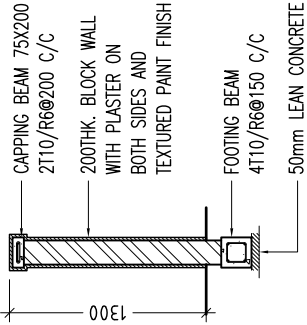

BOUNDARY WALL DETAIL
(SECTION-B)

SCALE 1:50

CONTRACTORS MUST CHECK ALL
DIMENSIONS ON SITE BEFORE
STARTING ANY WORK OR SHOP DRAWINGS.
FIGURED DIMENSIONS TO TAKE
PRECEDENCE OVER SCALE READINGS.
DO NOT SCALE DRAWINGS, IN CASE DOUBT,
PLEASE ASK.



ARCHITECTURAL DESIGN (CONCEPT) AND DESIGN IN THIS DRAWING ARE THE PROPERTIES OF ADEPT MALDIVES PRIVATE LIMITED. UNAUTHORISED USE OR REPRODUCTION OF WHOLE OR PART OF THE CONCEPT, DESIGN OR DRAWINGS TO USE IN ANY OTHER PROJECTS OR SITES OTHER THAN SPECIFIED ON THIS DRAWING IS PROHIBITED.


REVISION:	

ARCHITECT:	ABDUL WAHID MOAHMED
ENGINEER:	HASSAN NIHAD
SERVICES ENG.:	-
ESTIMATOR:	HASSAN NIHAD
DRAWN BY:	ABDUL WAHID MOAHMED

PROJECT:	COUGL OFFICE FOR M. MADUVVARI ISLAND
LOCATION:	MEEMU ATOLL, REPUBLIC OF MALDIVES
DWG TITLE:	AS GIVEN
CLIENT:	OFFICE FOR PROGRAMMES AND PROJECTS (OPP)
SCALE:	AS GIVEN
DIMENSION:	mm
DATE:	07th DECEMBER 2013
PROJECT NO.:	AM-2013-00
DWG NO.:	S-01

FOUNDATION BEAM & COLUMN PLAN

SCALE 1:100

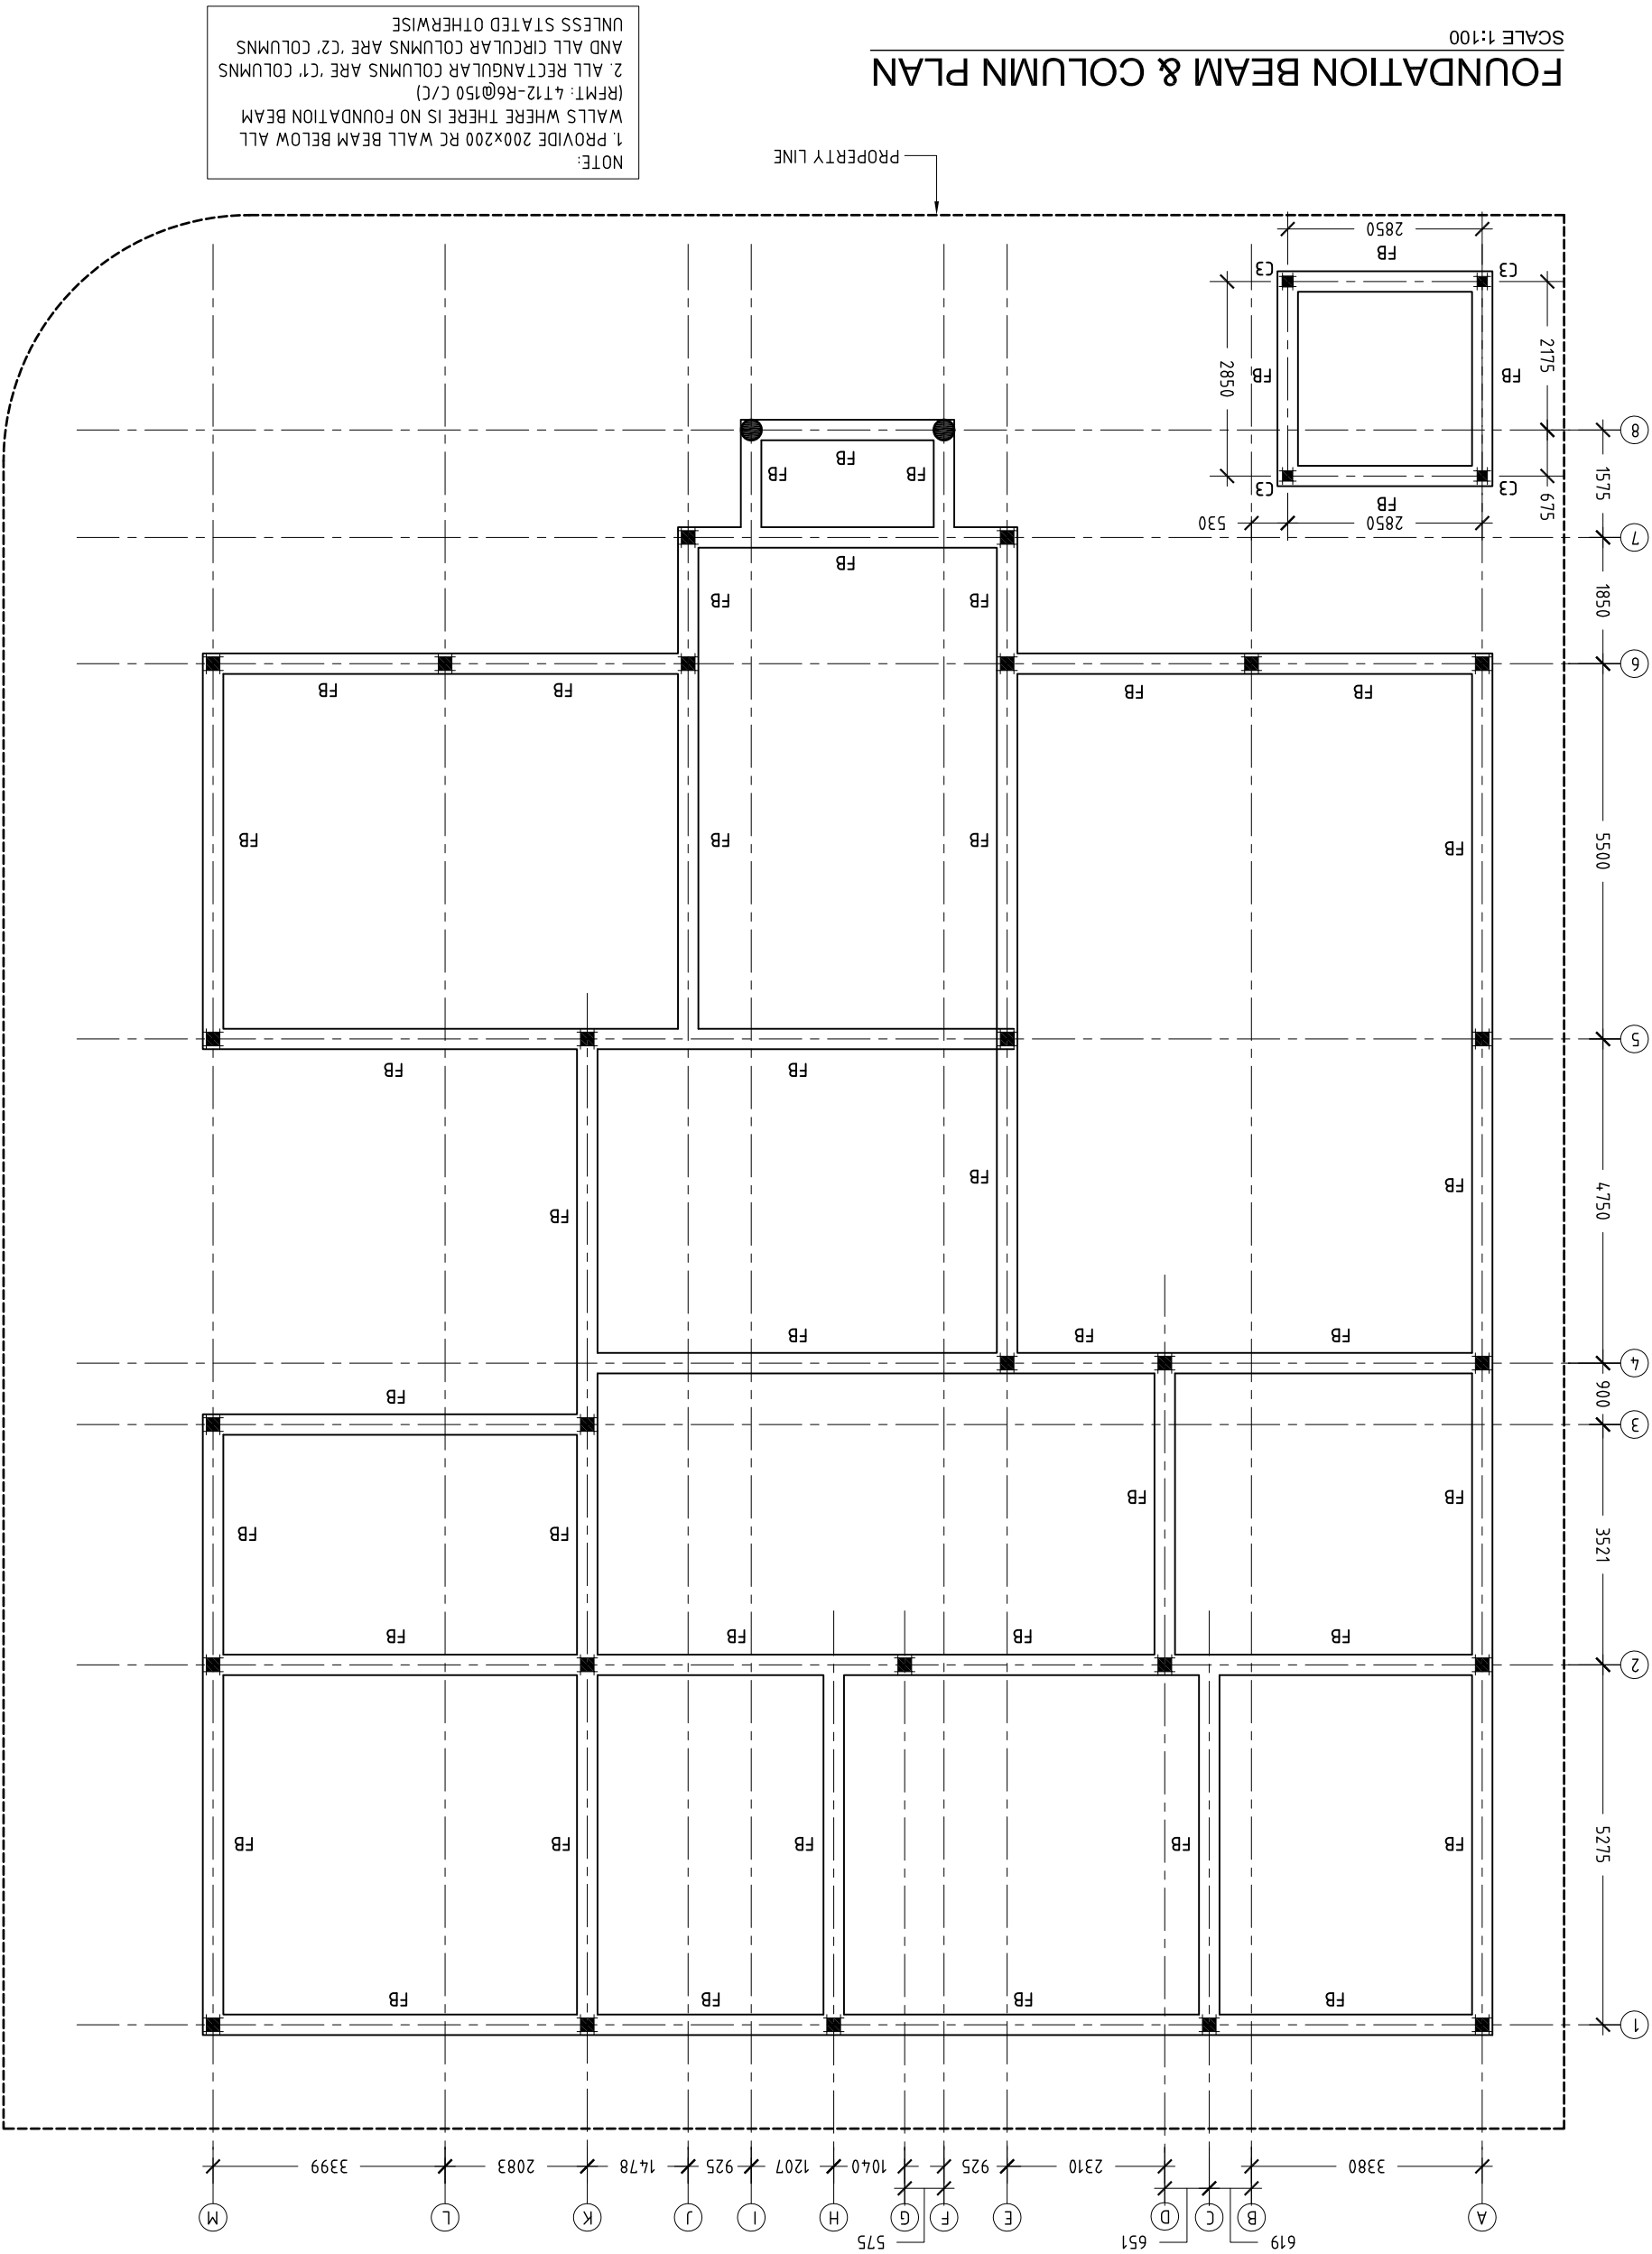

CONTRACTORS MUST CHECK ALL
DIMENSIONS ON SITE BEFORE
STARTING ANY WORK OR SHOP DRAWINGS.
FIGURED DIMENSIONS TO TAKE
PRECEDENCE OVER SCALE READINGS.
DO NOT SCALE DRAWINGS, IN CASE DOUBT,
PLEASE ASK.




ARCHITECTURAL DESIGN (STRUCTURAL DESIGN) COST ESTIMATION (LAW AND SURVEYING) PROJECT MANAGEMENT (LAW AND SURVEYING) PROJECT MANAGEMENT CONSULTANCY
1st Floor, Neebolenimuge, Maadenu, Male, 20284
Tel: +960 790 7270 Email: info@adeptmaldives.com


ROOF STRUCTURE PLAN

SCALE 1:100

REVISION:	
ARCHITECT:	ABDUL WAHID MOAHMED
ENGINEER:	HASSAN NIHAD
SERVICES ENG.:	-
ESTIMATOR:	HASSAN NIHAD
DRAWN BY:	ABDUL WAHID MOAHMED
PROJECT:	COUL. OFFICE FOR M. MADUVVARI ISLAND
LOCATION:	MEEMU ATOLL, REPUBLIC OF MALDIVES
DWG TITLE:	AS GIVEN
CLIENT:	OFFICE FOR PROGRAMMES AND PROJECTS (OPP)
SCALE:	AS GIVEN
DIMENSION:	mm
DATE:	07th DECEMBER 2013
PROJECT NO:	AM-2013-00
DWG NO.:	S-03


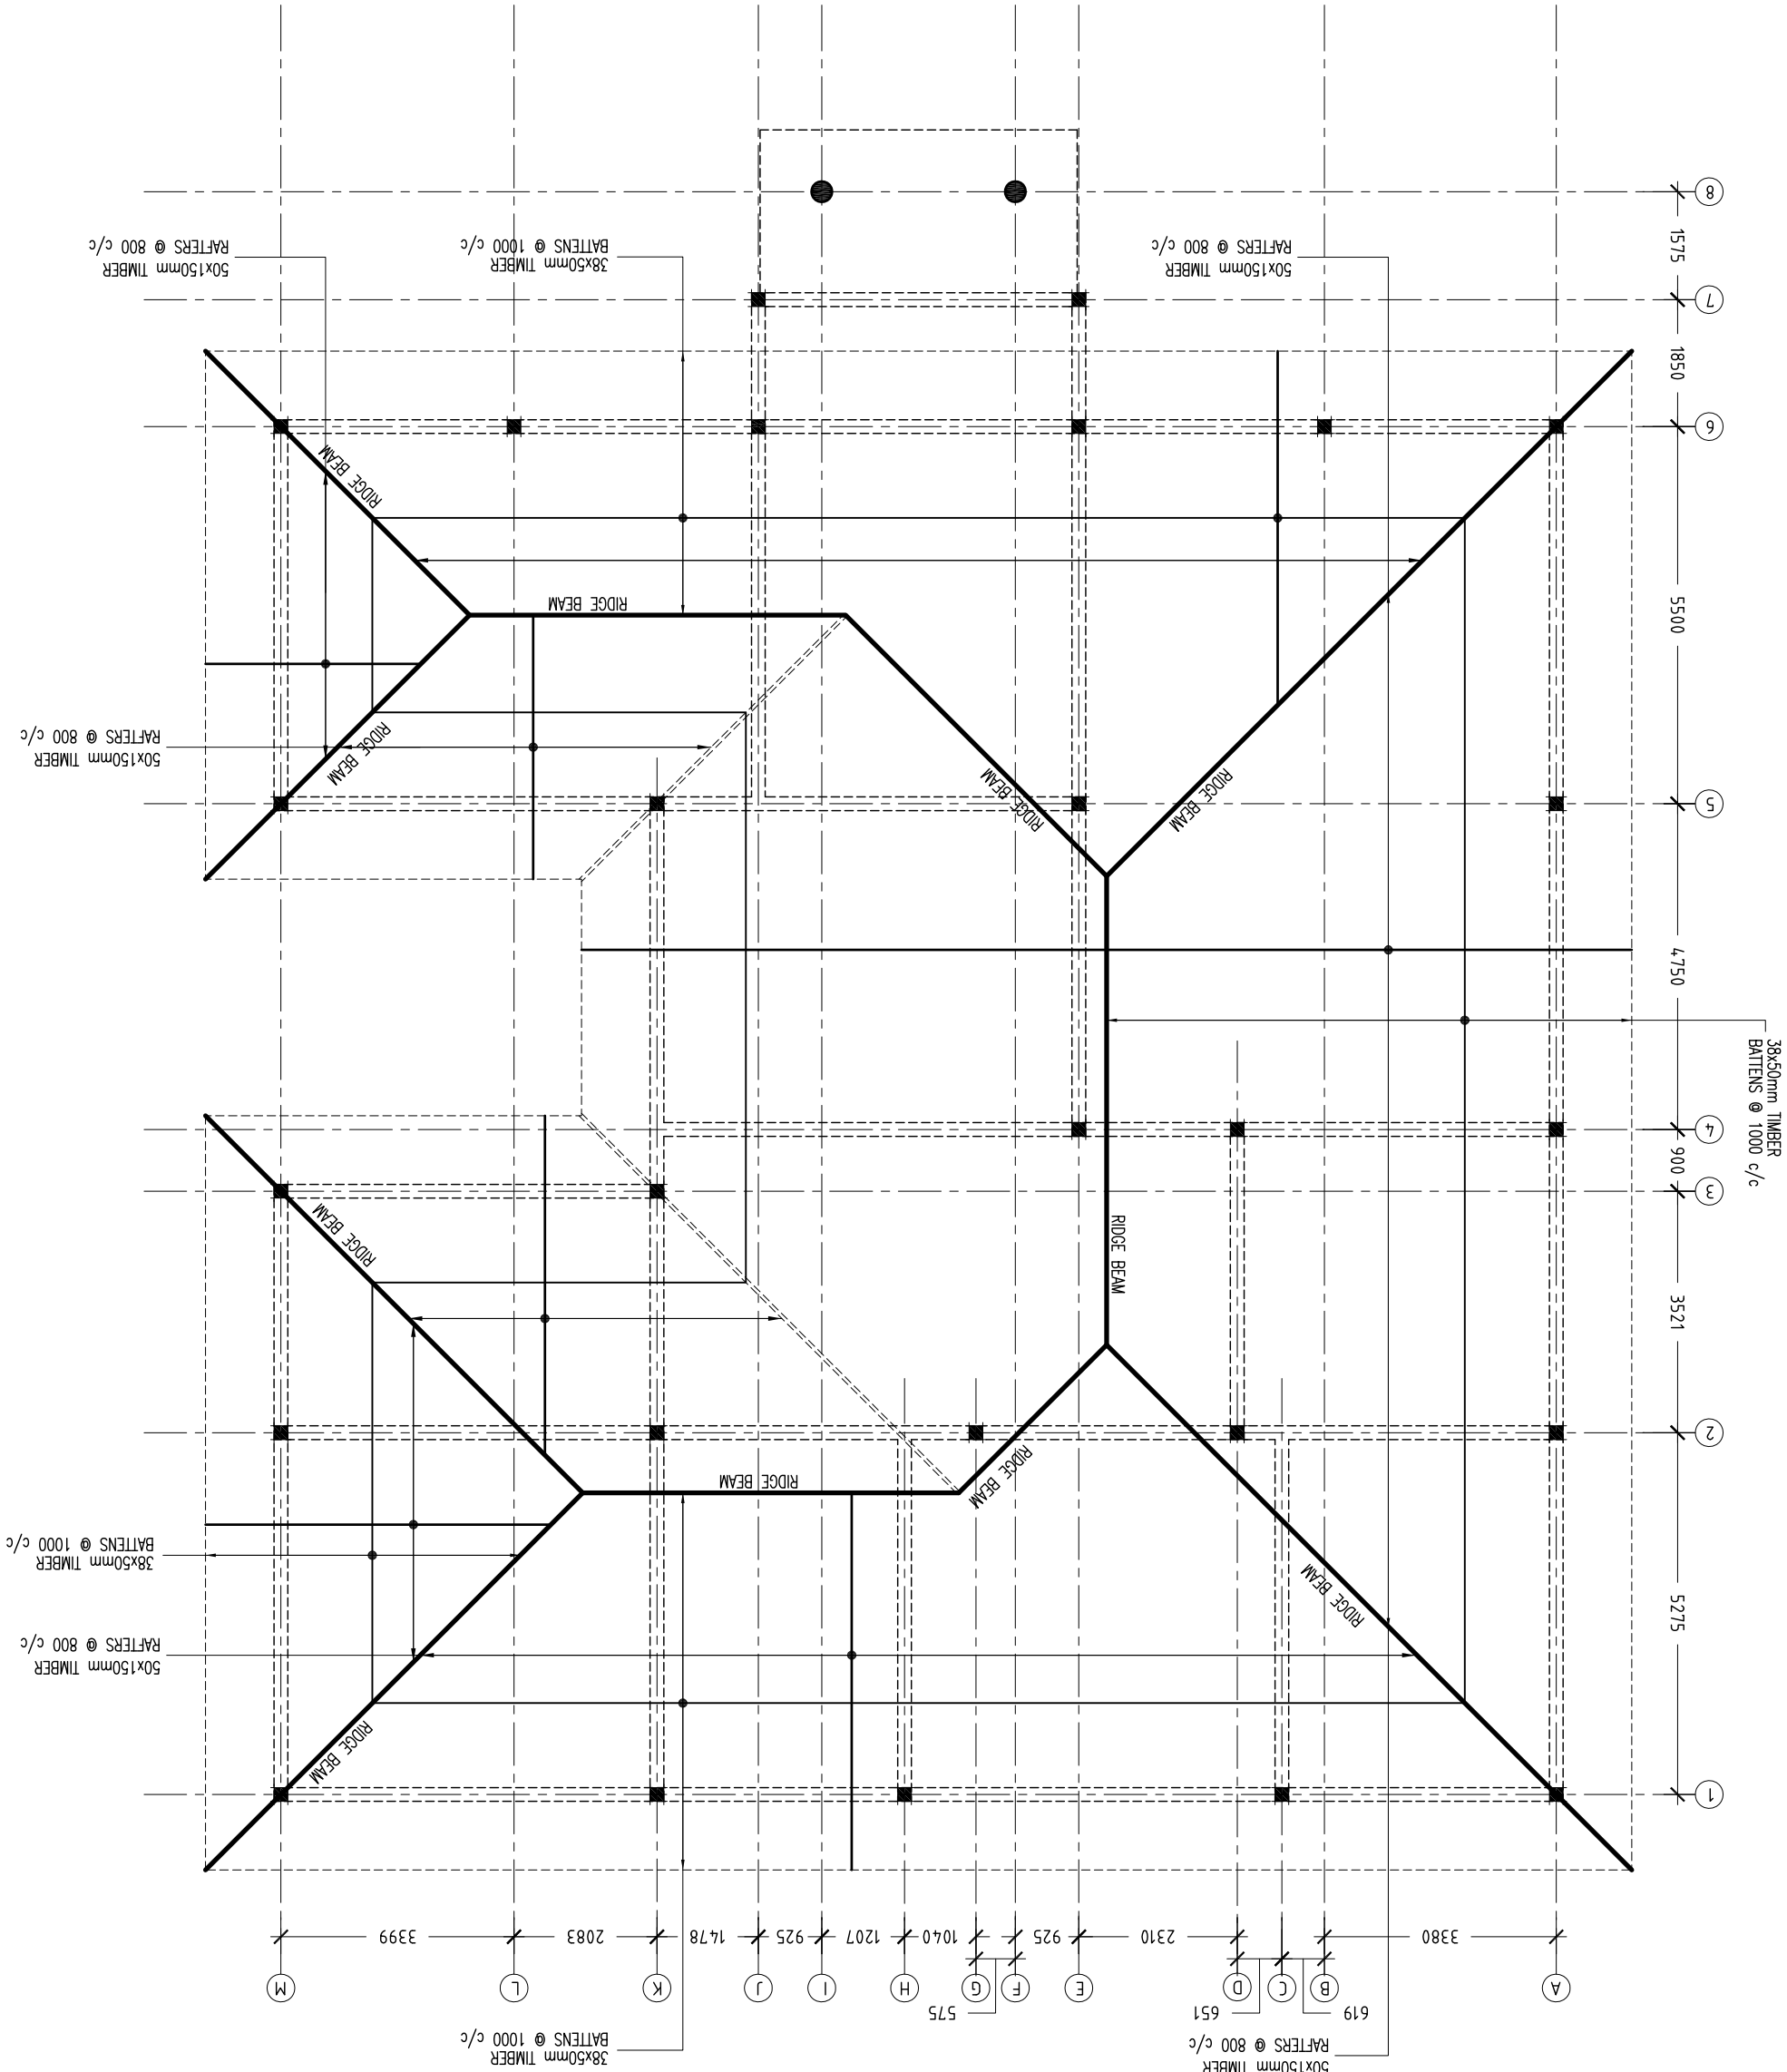


CONTRACTORS MUST CHECK ALL DIMENSIONS ON SITE BEFORE STARTING ANY WORK OR SHOP DRAWINGS, FIGURED DIMENSIONS TO TAKE PRECEDENCE OVER SCALE READINGS, DO NOT SCALE DRAWINGS, IN CASE DOUBT, PLEASE ASK.

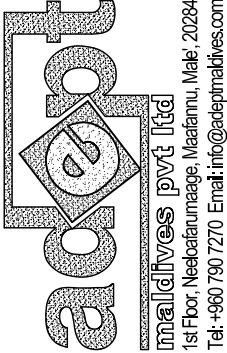

CONCEPT AND DESIGN IN THIS DRAWING ARE THE PROPERTIES OF ADEPT MALDIVES PRIVATE LIMITED. UNAUTHORISED USE OR REPRODUCTION OF WHOLE OR PART OF THE CONCEPT, DESIGN OR DRAWINGS TO USE IN ANY OTHER PROJECTS OR SITES OTHER THAN SPECIFIED ON THIS DRAWING IS PROHIBITED.


REVISION:	ARCHITECT:	ABDUL WAHID MOAHEMD	PROJECT:	COUCIL OFFICE FOR M. MADUVVARI ISLAND	<div>S-04</div>
	ENGINEER:	HASSAN NIHAD	LOCATION:	MEEMU ATOLL, REPUBLIC OF MALDIVES	
	SERVICES ENG.:	-	DWG TITLE.:	AS GIVEN	
	ESTIMATOR:	HASSAN NIHAD	CLIENT:	OFFICE FOR PROGRAMMES AND PROJECTS (OPP)	
	DRAWN BY:	ABDUL WAHID MOAHEMD	SCALE:	AS GIVEN	
			DIMENSION:	mm	DATE: 07th DECEMBER 2013
					DWG NO.:
					PROJECT NO: AM-2013-00

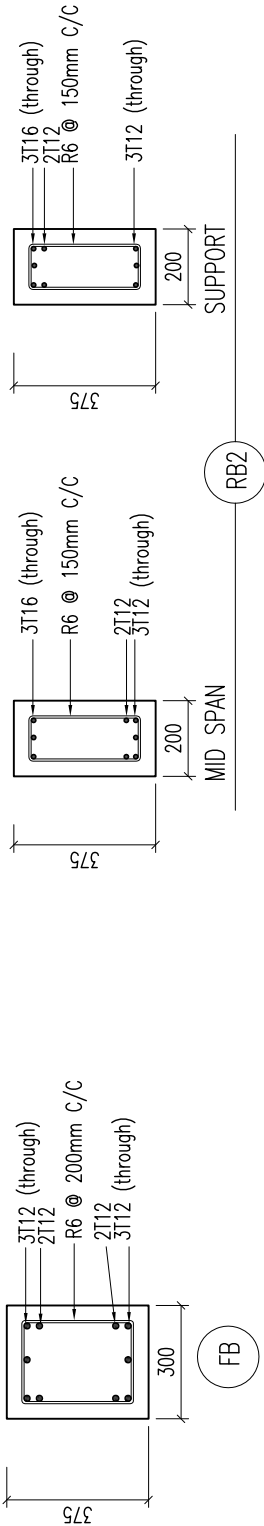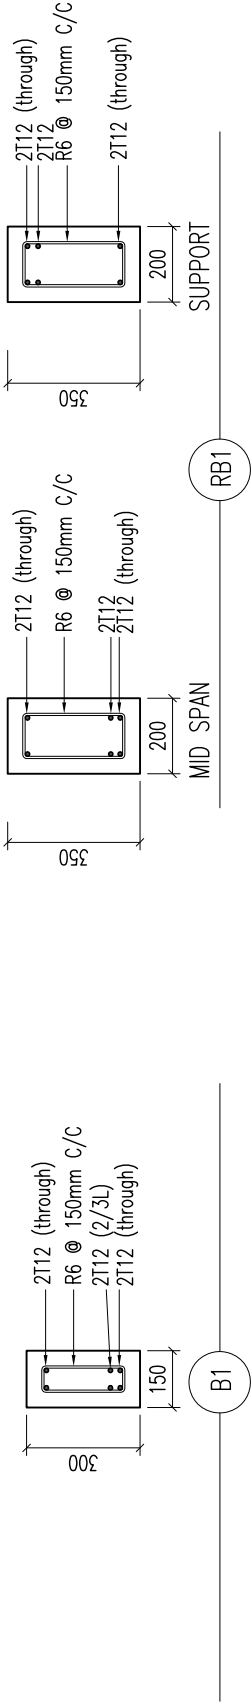

FOUNDATION DEPTH = 900mm


BEAM DETAILS


Scale 1:20

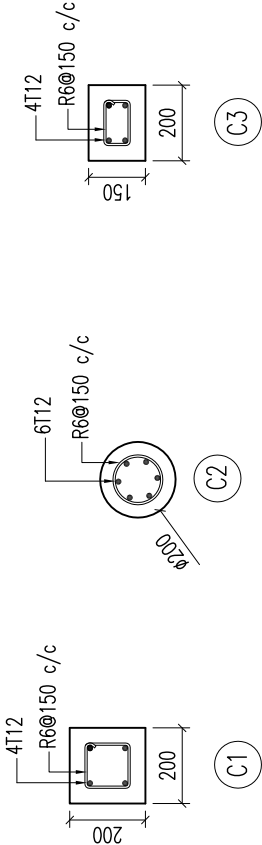

COLUMN DETAILS

Scale 1:20

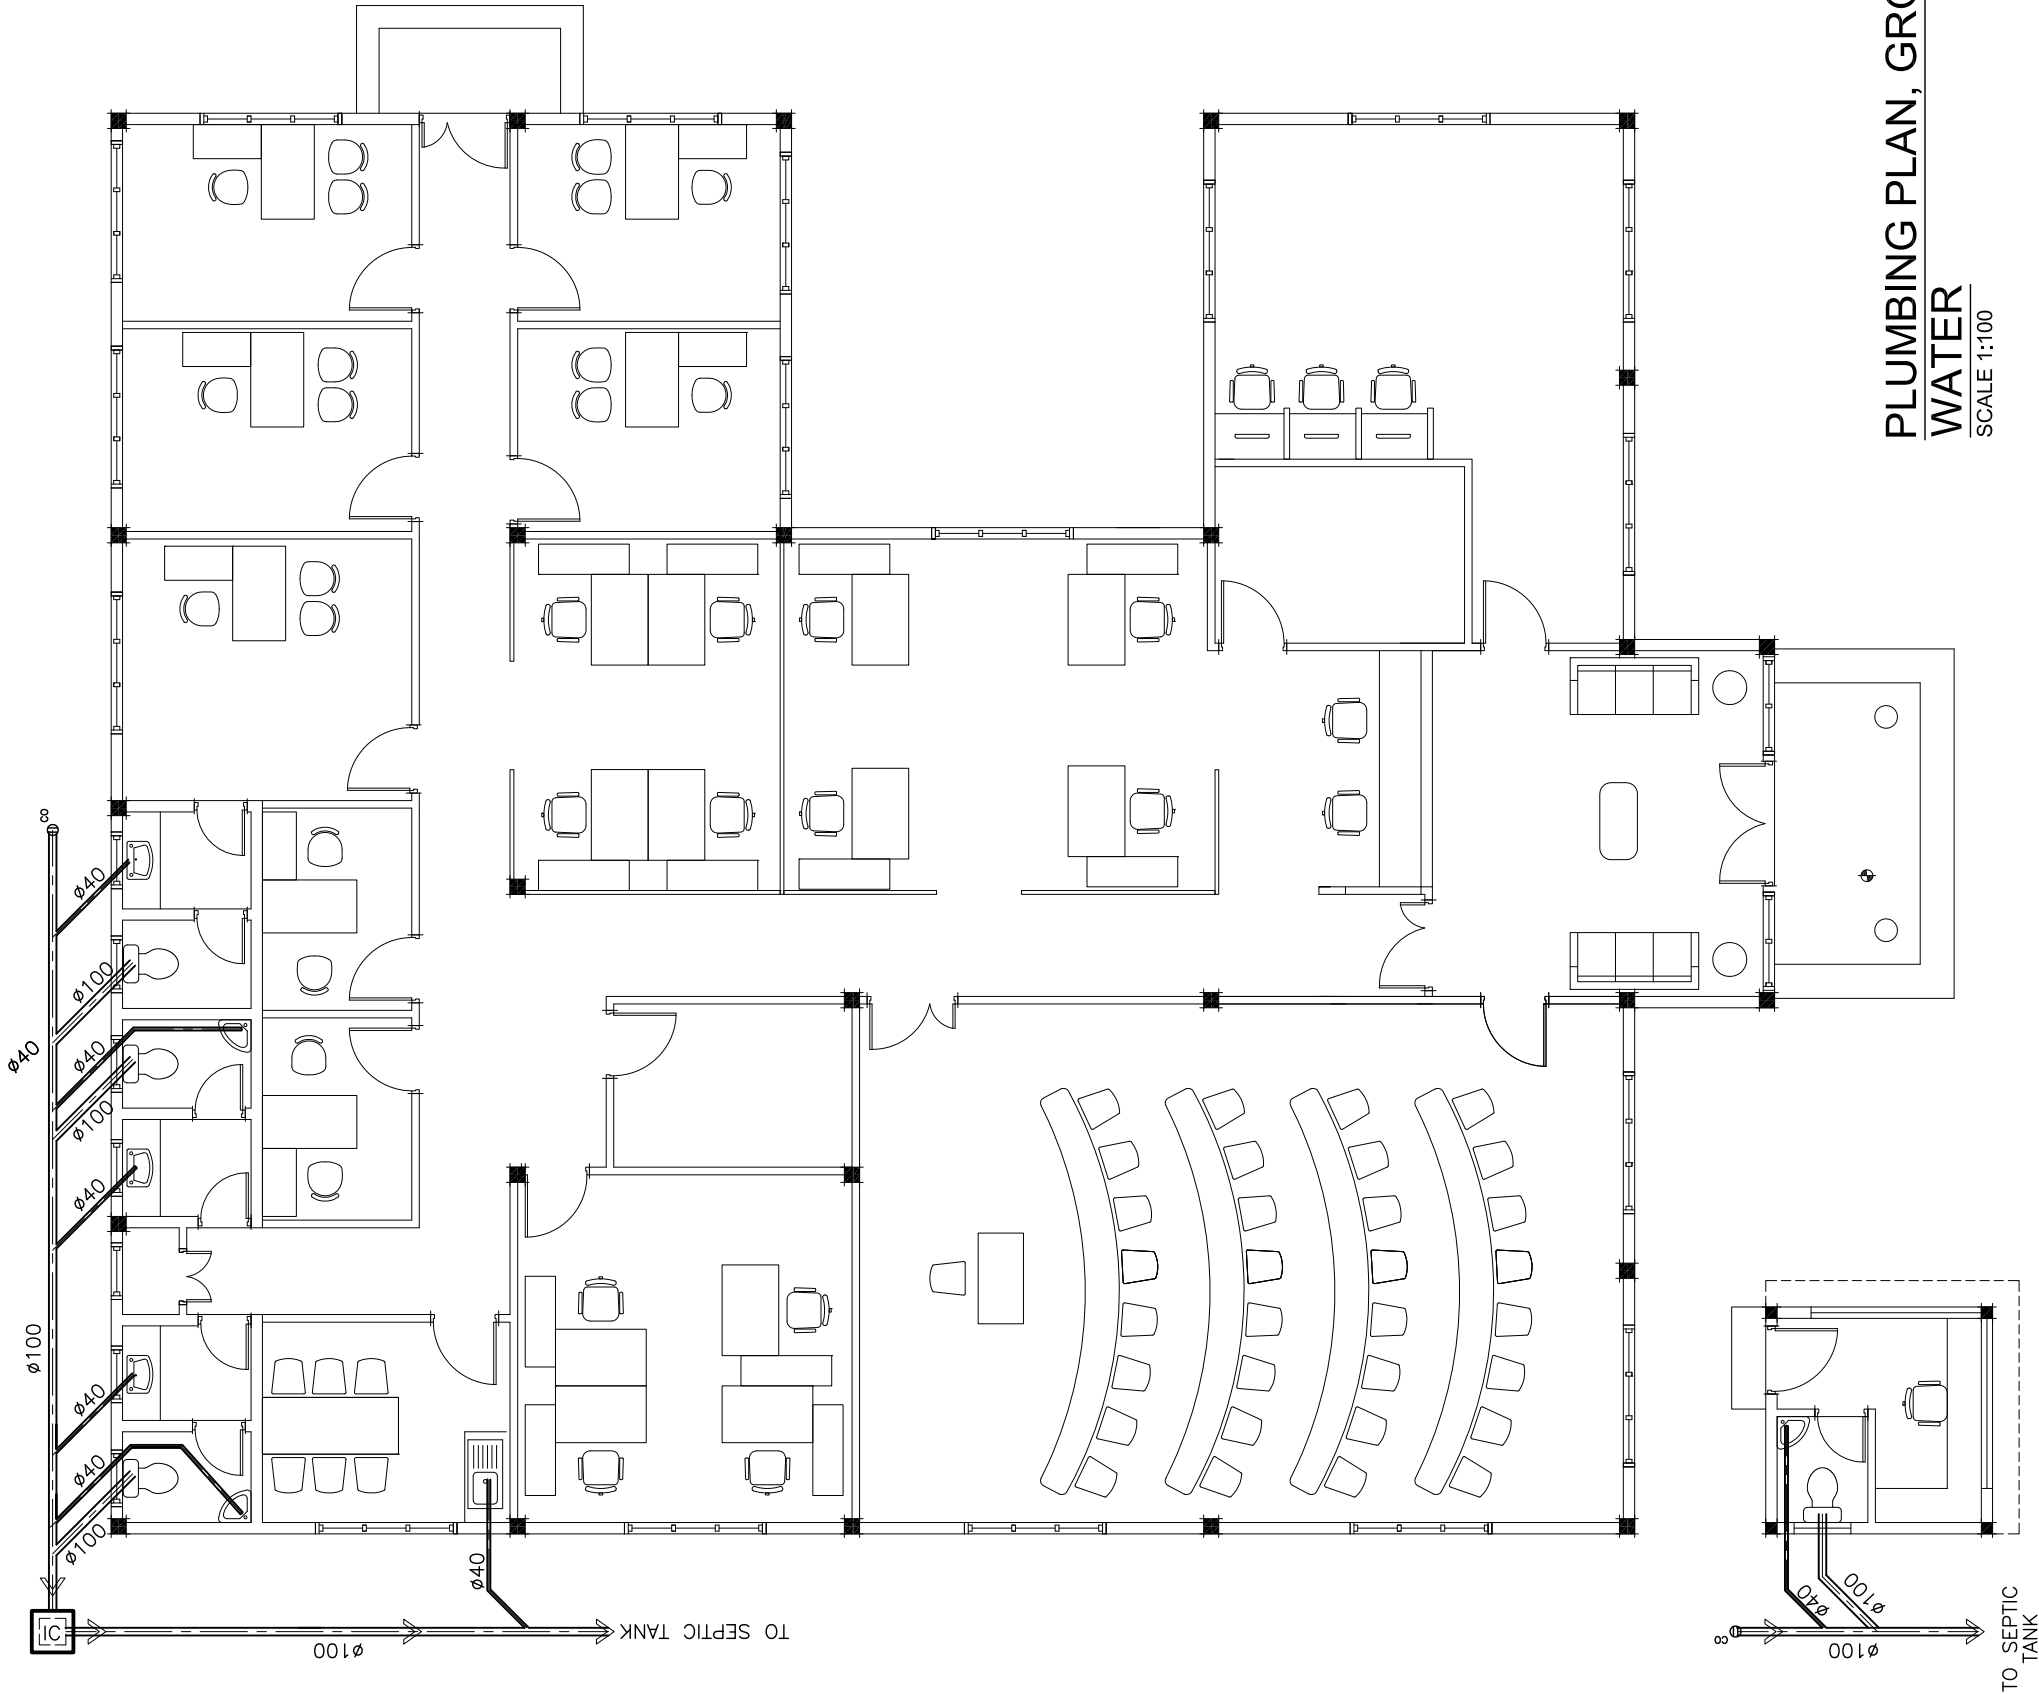

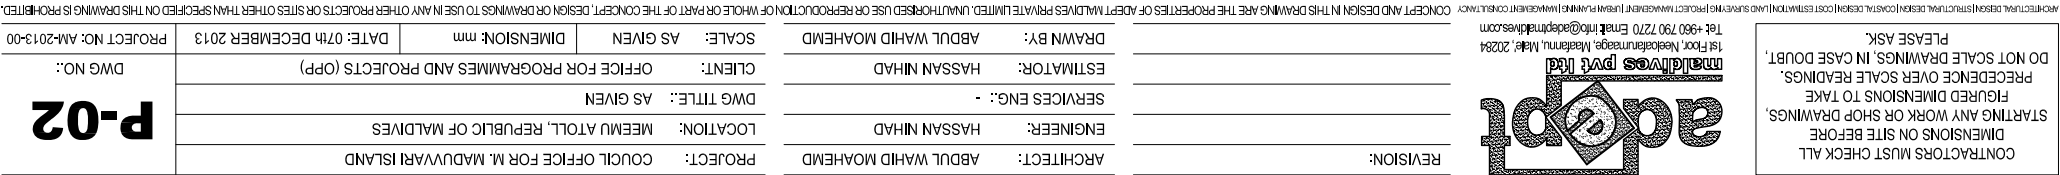

PLUMBING PLAN, GROUND
WATER

SCALE 1"=100'

