


POWER & NETWORK LEGENDS	
	POWER SOCKET 2.4M (2GNG)
	POWER SOCKET 1.2M (2GNG)
	POWER SOCKET 0.3M (2GNG)
	POWER SOCKET[WEATHER PROOF] 0.3M (2GNG)
	POWER SOCKET[WEATHER PROOF] 1.2M (2GNG)
	POWER SOCKET 0.3M 15 AMPERE (2GNG)
	POWER SOCKET 1.2M 15 AMPERE (2GNG)
	POWER SOCKET[WEATHER PROOF] 2.4M (2GNG)
	INTRANET DOUBLE GANG WITH SEPARATE CABLE
	CCTV CAMERA POINT
	CABLE TV POINT
	CONTROLLED [CARD] ACCESS POINT
	RACK UNIT

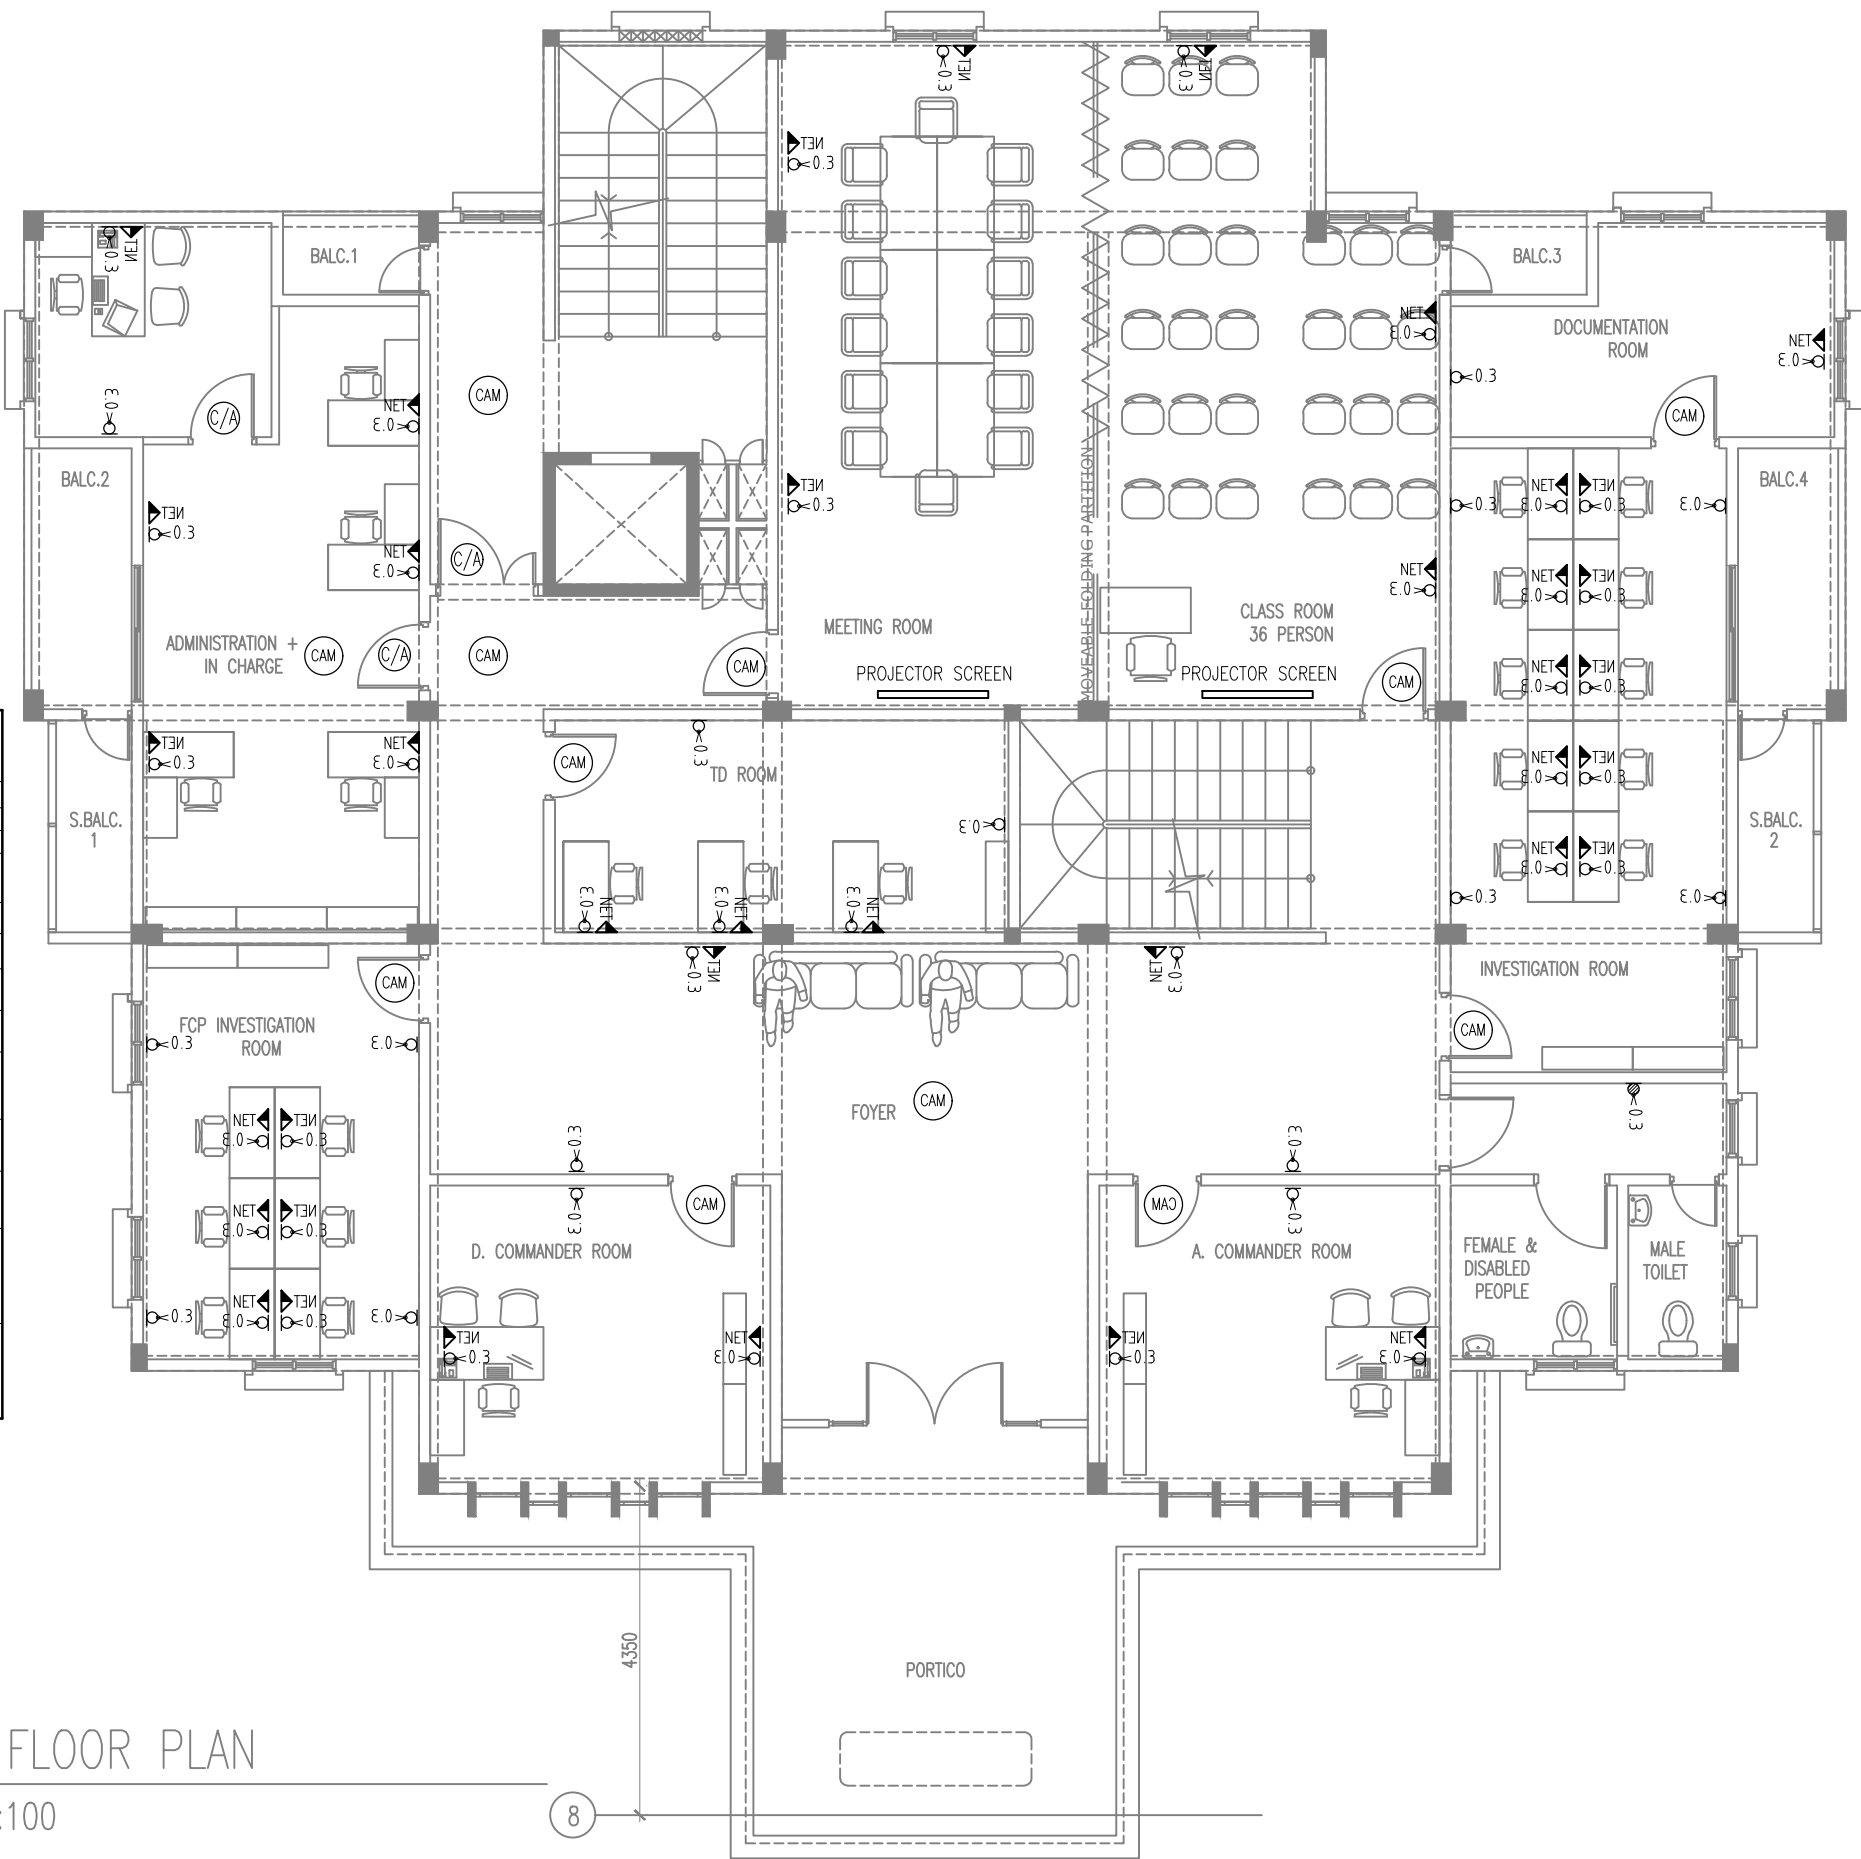

FIRST FLOOR PLAN
SCALE 1:100

FINANCE AND ASSET MANAGEMENT INFRASTRUCTURE UNIT MALDIVES POLICE SERVICE	
PROJECT TITLE: N. MANDHOO POLICE STATION	
MALDIVES POLICE SERVICE SEAL & SIGN	
CONTRACTORS SEAL & SIGN	
THE DRAWINGS, CONCEPT AND DESIGN CONTAINED AREA THE PROPERTIES OF MALDIVES POLICE SERVICE. USE OF ANY KIND OR COPY OF WHOLE OR PART OF THIS DRAWING CONCEPT OR DESIGN OR USE ON OTHER PROJECTS OR SITES OTHER THAN THAT SPECIFIED ON THIS DRAWINGS IS STRICTLY PROHIBITED	
ARCHITECT/DESIGNER ASSISTANT DIRECTOR AHMED SADHEEM	DRAFTED BY SUB INSP OF POLICE MOHAMED FALAAH
STRUCTURAL ENGINEER SUB INSP OF POLICE FAZEEN	DRAFTED BY SUB INSP OF POLICE MOHAMED FALAAH
CHECKED BY ASSISTANT DIRECTOR AHMED SADHEEM	CHECKED BY SUB INSP OF POLICE AHMED NIZAL
ARCHITECTURAL DRAWINGS	
SHEET NO.	DATE: 19 AUG 2021
E-02	