


POWER & NETWORK LEGENDS	
	POWER SOCKET 2.4M (2GNG)
	POWER SOCKET 1.2M (2GNG)
	POWER SOCKET 0.3M (2GNG)
	POWER SOCKET[WEATHER PROOF] 0.3M (2GNG)
	POWER SOCKET[WEATHER PROOF] 1.2M (2GNG)
	POWER SOCKET 0.3M 15 AMPERE (2GNG)
	POWER SOCKET 1.2M 15 AMPERE (2GNG)
	POWER SOCKET[WEATHER PROOF] 2.4M (2GNG)
	INTRANET DOUBLE GANG WITH SEPARATE CABLE
	CCTV CAMERA POINT
	CABLE TV POINT
	CONTROLLED [CARD] ACCESS POINT
	RACK UNIT

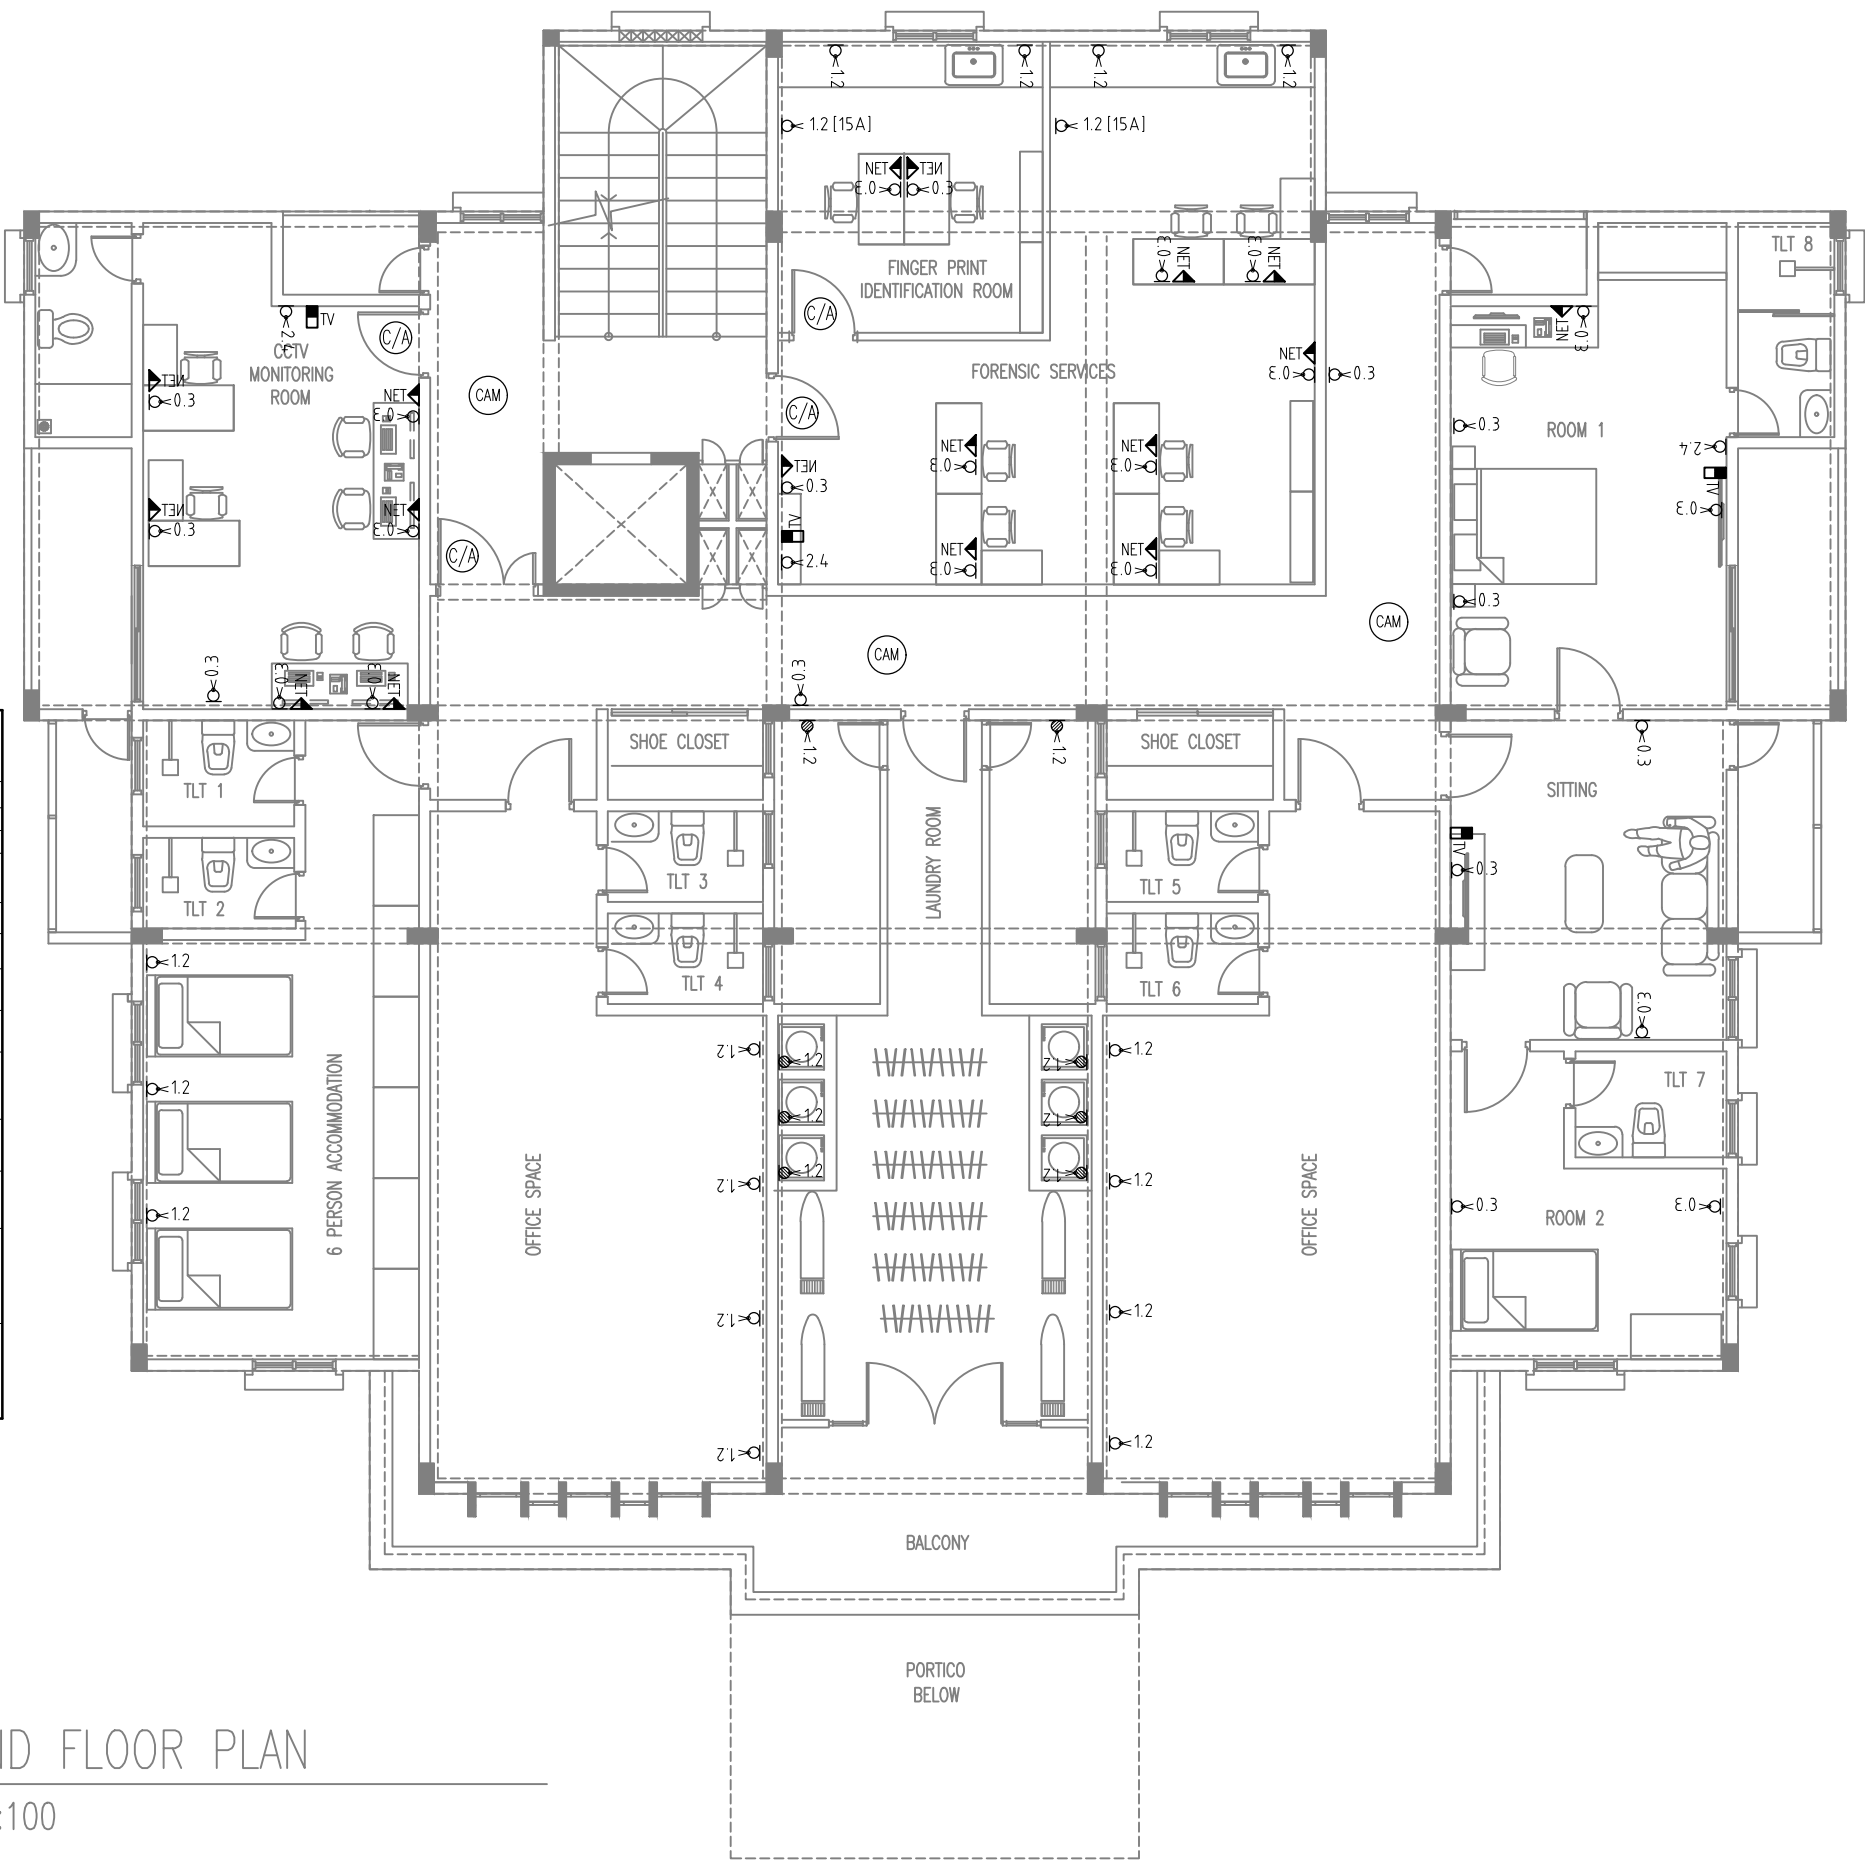

SECOND FLOOR PLAN
SCALE 1:100

FINANCE AND ASSET MANAGEMENT
INFRASTRUCTURE UNIT
MALDIVES POLICE SERVICE

PROJECT TITLE:
N. MANDHOO POLICE STATION

MALDIVES POLICE SERVICE SEAL & SIGN

CONTRACTORS SEAL & SIGN

THE DRAWINGS, CONCEPT AND DESIGN CONTAINED AREA THE PROPERTIES OF MALDIVES POLICE SERVICE. USE OF ANY KIND OR COPY OF WHOLE OR PART OF THIS DRAWING CONCEPT OR DESIGN OR USE ON OTHER PROJECTS OR SITES OTHER THAN THAT SPECIFIED ON THIS DRAWINGS IS STRICTLY PROHIBITED

ARCHITECT/DESIGNER
ASSISTANT DIRECTOR
AHMED SADHEEM

DRAFTED BY
SUB INSP OF POLICE
MOHAMED FALAHH

STRUCTURAL ENGINEER
SUB INSP OF POLICE
FAZEEN

DRAFTED BY
SUB INSP OF POLICE
MOHAMED FALAHH

CHECKED BY
ASSISTANT DIRECTOR
AHMED SADHEEM

CHECKED BY
SUB INSP OF POLICE
AHMED NIZAL

ARCHITECTURAL DRAWINGS

SHEET NO.

DATE: 19 AUG 2021

E-03