

FINANCE AND ASSET MANAGEMENT

INFRASTRUCTURE UNIT

MALDIVES POLICE SERVICE

PROJECT TITLE:
N. MANDHOO POLICE STATION
VEHICLE SHED

MALDIVES POLICE SERVICE SEAL & SIGN

CONTRACTORS SEAL & SIGN

THE DRAWINGS,CONCEPT AND DESIGN CONTAINED AREA
THE PROPERTIES OF MALDIVES POLICE SERVICE,USE OF
ANY KIND OR COPY OF WHOLE OR PART OF THIS
DRAWING CONCEPT OR DESIGN OR USE ON OTHER
PROJECTS OR SITES OTHER THAN THAT SPECIFIED ON
THIS DRAWINGS IS STRICTLY PROHIBITED

ARCHITECT/DESIGNER
ASSISTANT DIRECTOR
AHMED SADHEEM

DRAFTED BY
SUB INSP OF POLICE
MOHAMED FALAAH

STRUCTURAL ENGINEER
SUB INSP OF POLICE
FAZEEN

DRAFTED BY
SUB INSP OF POLICE
MOHAMED FALAAH

CHECKED BY
ASSISTANT DIRECTOR
AHMED SADHEEM


CHECKED BY
SUB INSP OF POLICE
AHMED NIZAL

ARCHITECTURAL DRAWINGS

SHEET NO.


DATE: 19 AUG 2021

ADO1

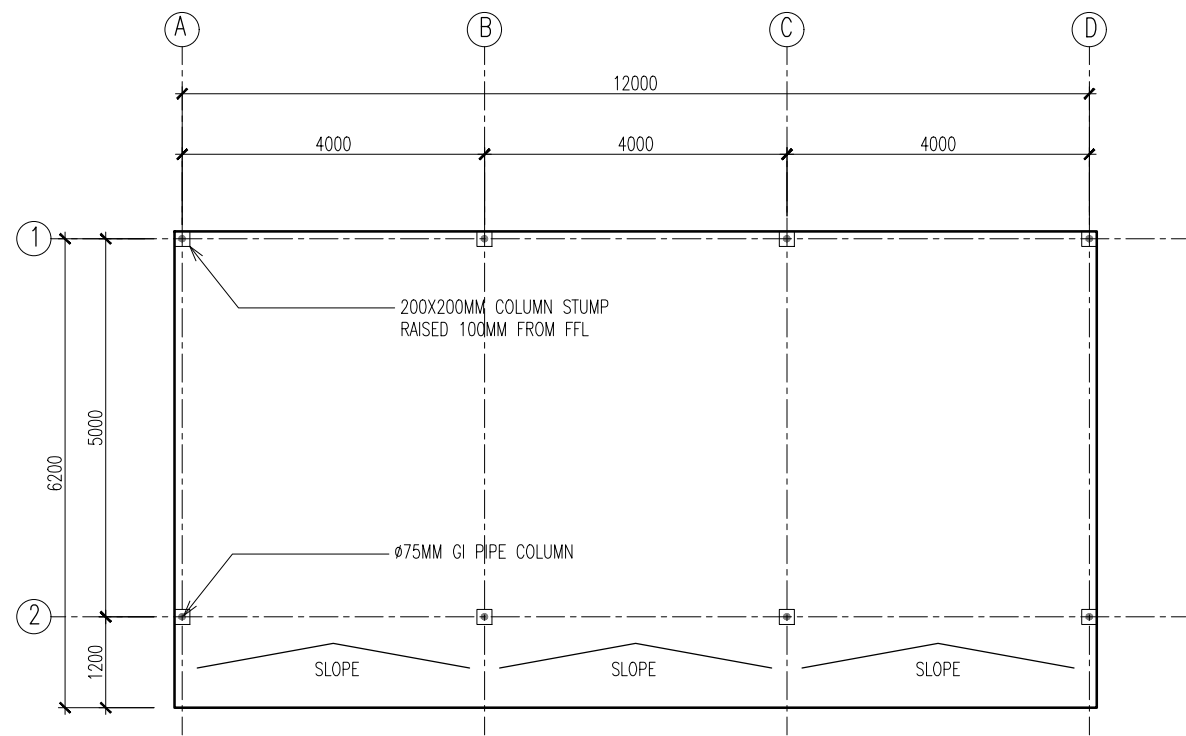


GROUND FLOOR PLAN

SCALE 1:100

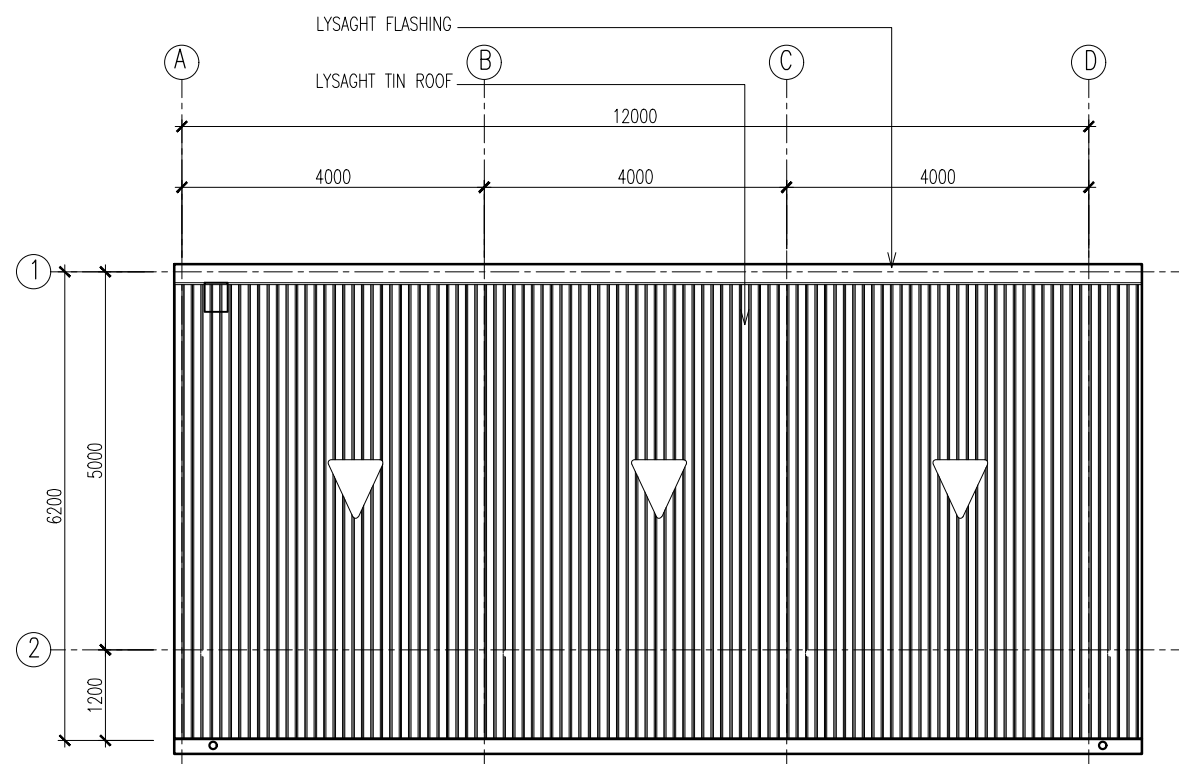


ROOF PLAN

SCALE 1:100

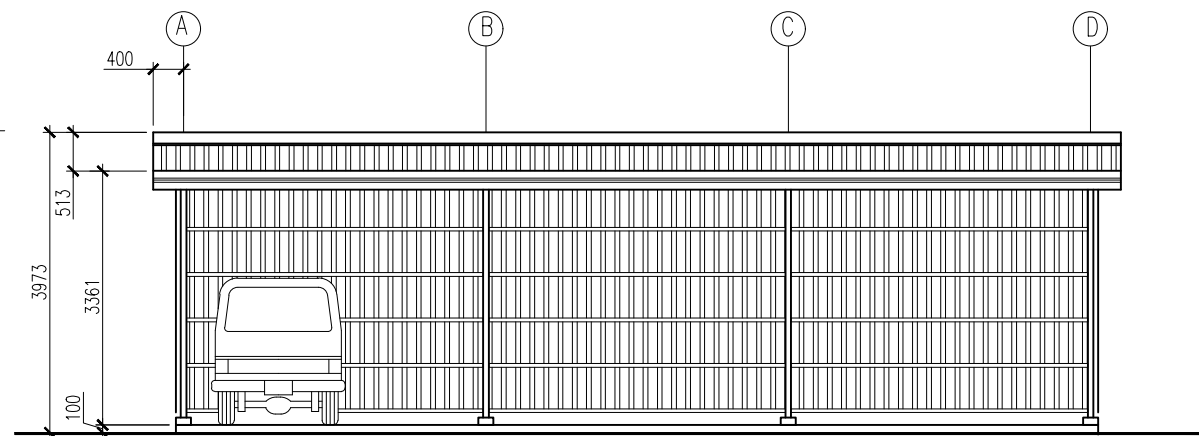

FRONT ELEVATION

SCALE 1:100

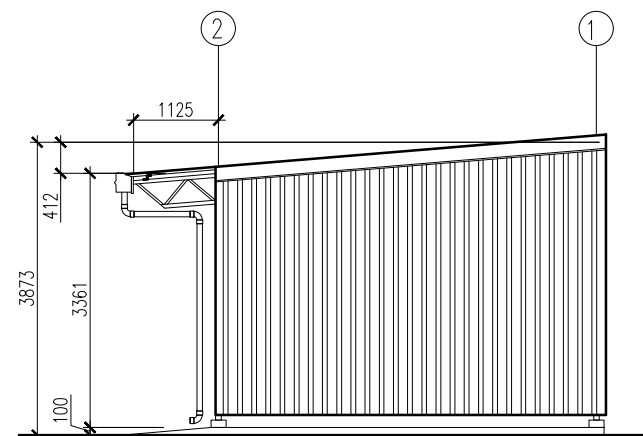

RIGHT SIDE ELEVATION

SCALE 1:100