

PROJECT TITLE:
N.MANADHOO POLICE STATION
CUSTODIAL BUILDING

MALDIVES POLICE SERVICE SEAL & SIGN

CONTRACTORS SEAL & SIGN

THE DRAWINGS, CONCEPT AND DESIGN CONTAINED AREA
THE PROPERTIES OF MALDIVES POLICE SERVICE. USE OF
ANY KIND OR COPY OF WHOLE OR PART OF THIS
DRAWING CONCEPT OR DESIGN OR USE ON OTHER
PROJECTS OR SITES OTHER THAN THAT SPECIFIED ON
THIS DRAWINGS IS STRICTLY PROHIBITED

ARCHITECT/DESIGNER DRAFTED BY
ASSISTANT DIRECTOR SUB INSP OF POLICE
AHMED SADHEEM MOHAMED FALAHH


STRUCTURAL ENGINEER DRAFTED BY
SUB INSP OF POLICE SUB INSP OF POLICE
FAZEEN MOHAMED FALAHH

CHECKED BY CHECKED BY
ASSISTANT DIRECTOR SUB INSP OF POLICE
AHMED SADHEEM AHMED NIZAL

ARCHITECTURAL DRAWINGS

SHEET NO. DATE: 19 AUG 2021

E-01

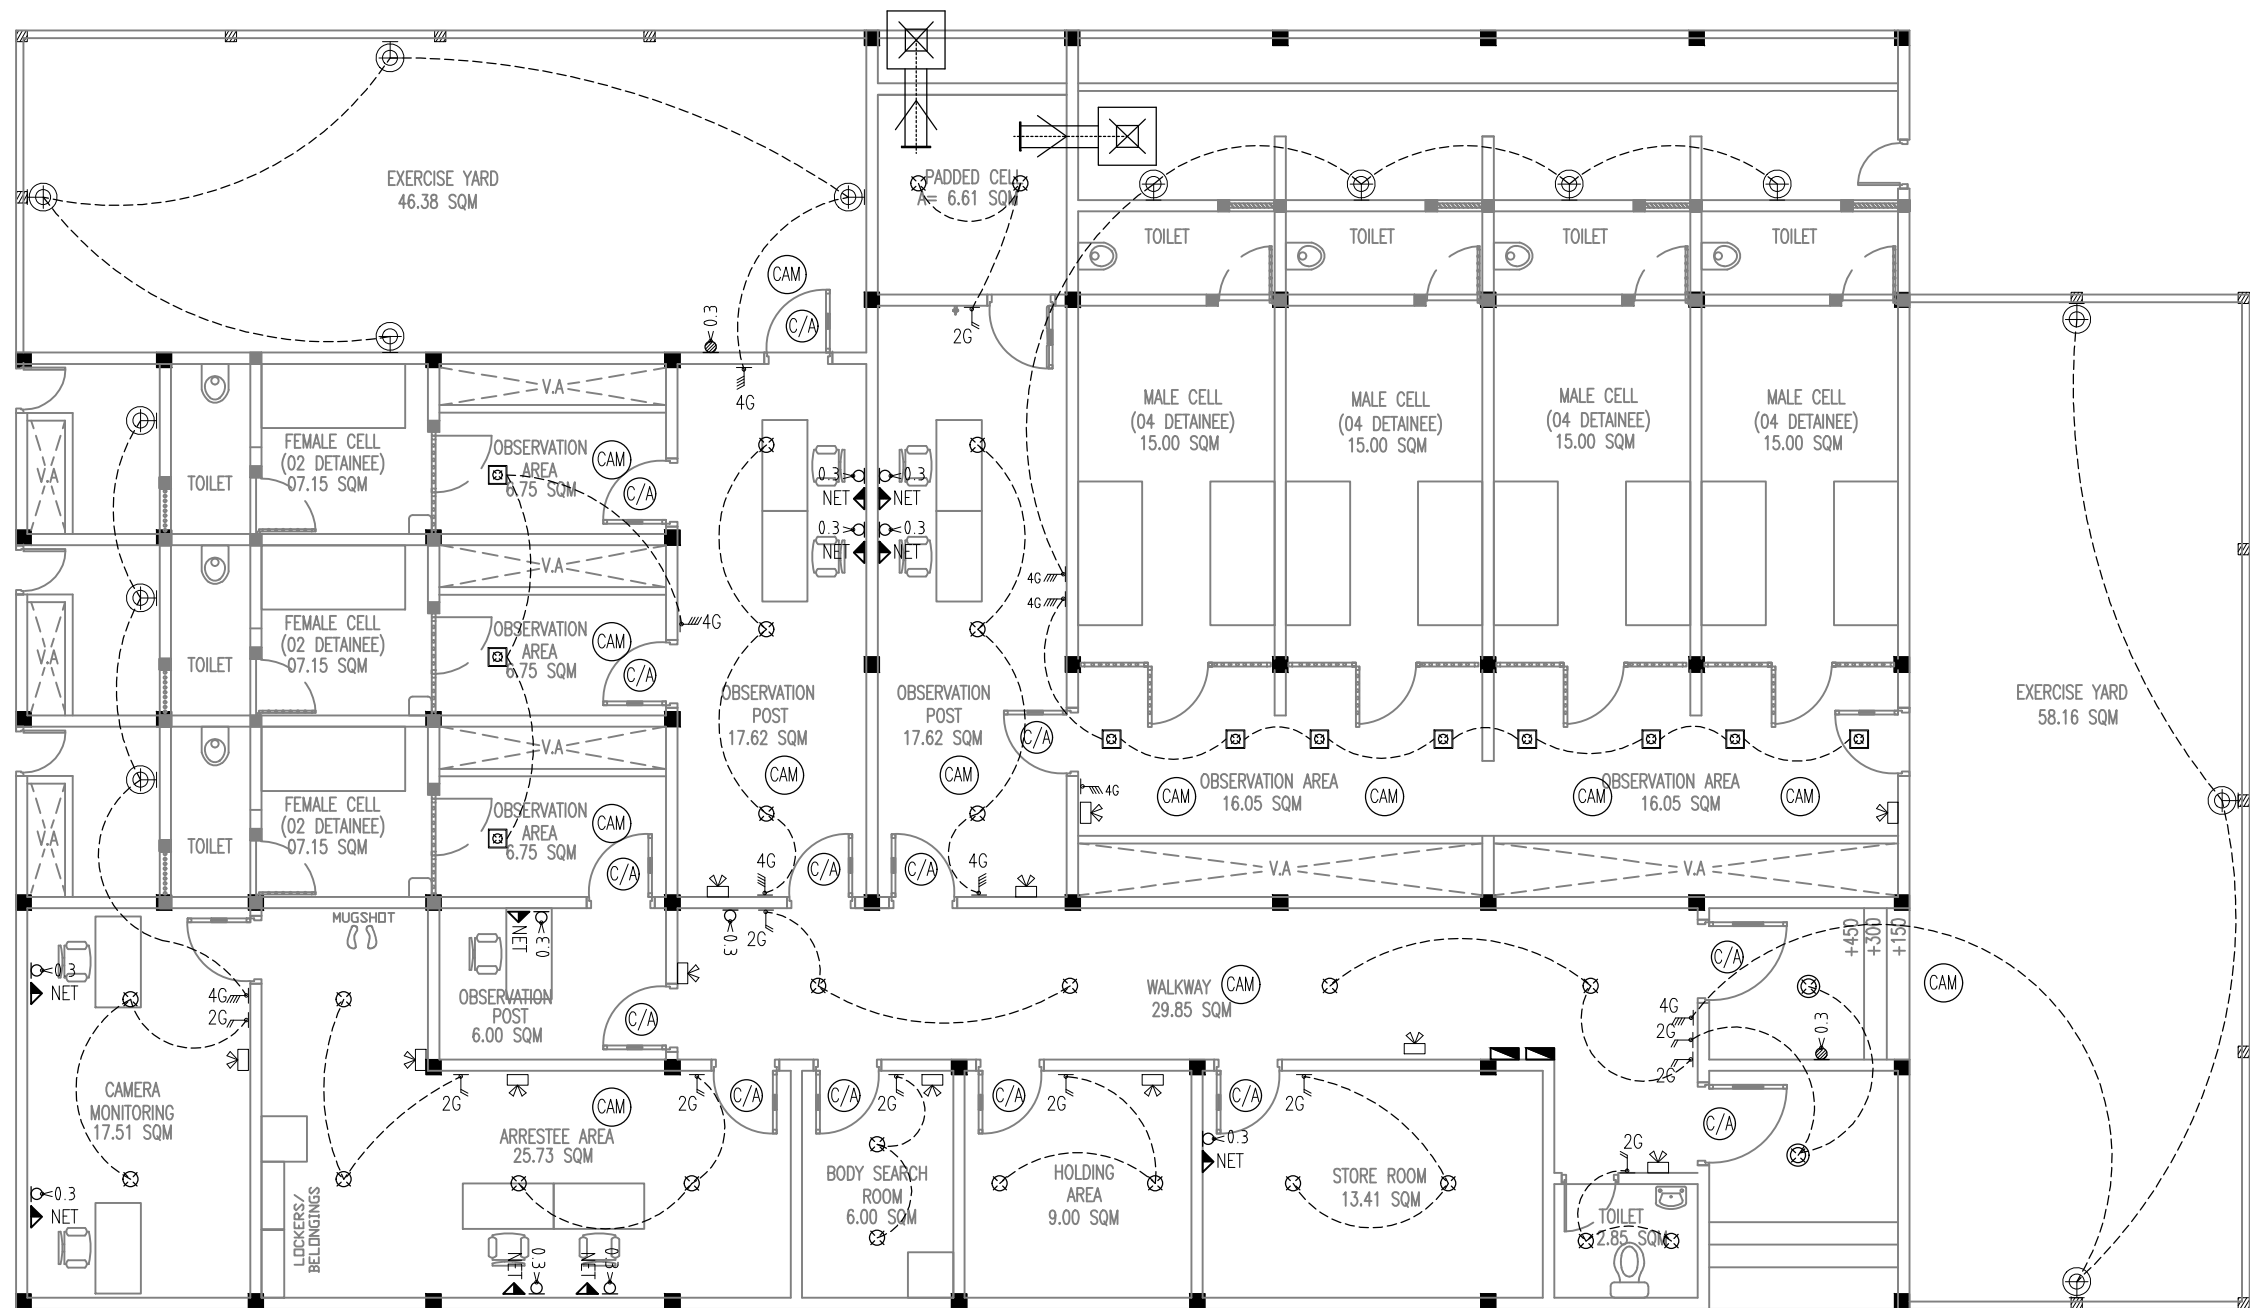

ELECTRICAL PLAN

SCALE 1:100

ELECTRICAL + NETWORK LEDGENDS

2 GANG SWITCH	2 GANG 13A POWER SOCKET (@ 0.3MM)
4 GANG SWITCH	2 GANG 13A WEATHER PROOF POWER SOCKET (@ 0.3MM)
CEILING RECESSED 18W LED LIGHT	2 GANG INTRANET SOCKET
WALL FIXED WEATHER PROOF LED LIGHT	CONTROLLED [CARD] ACCESS POINT
WALL FIXED LED LIGHT	
WALL FIXED EMERGENCY LED LIGHT	
D-BOARD	
CEILING RECESSED 32W(6000 COOL WHITE) LED LIGHT	STAINLESS STEEL DUCT VENTILATION
CCTV CAMERA POINT	[KDK INDUSTRIAL HIGH PRESSURE (REVERSIBLE) 30CM (12") VENTILATING FAN (30GSE)]
	INCLUDE ALUMINUM GRILLE ON BOTH SIDE WITH INSECT NET