

PROJECT TITLE:
N. MANDHOO POLICE STATION

MALDIVES POLICE SERVICE SEAL & SIGN

CONTRACTORS SEAL & SIGN

THE DRAWINGS, CONCEPT AND DESIGN CONTAINED AREA
THE PROPERTIES OF MALDIVES POLICE SERVICE. USE OF
ANY KIND OR COPY OF WHOLE OR PART OF THIS
DRAWING CONCEPT OR DESIGN OR USE ON OTHER
PROJECTS OR SITES OTHER THAN THAT SPECIFIED ON
THIS DRAWINGS IS STRICTLY PROHIBITED

ARCHITECT/DESIGNER DRAFTED BY
ASSISTANT DIRECTOR AHMED SADHEEM SUB INSP OF POLICE MOHAMED FALAHH

STRUCTURAL ENGINEER DRAFTED BY
SUB INSP OF POLICE FAZEEN SUB INSP OF POLICE MOHAMED FALAHH


CHECKED BY CHECKED BY
ASSISTANT DIRECTOR AHMED SADHEEM SUB INSP OF POLICE AHMED NIZAL

ARCHITECTURAL DRAWINGS

SHEET NO. DATE: 19 AUG 2021

E-01

ELECTRICAL + A/C LEGEND	
1G	ONE WAY SWITCH 1.2M (1GNG)
2G	ONE WAY SWITCH 1.2M (2GNG)
4G	ONE WAY SWITCH 1.2M (4GNG)
	CEILING MOUNTH EXHAUST FAN WITH DELAY TIMER
	CEILING RECESSED 18W LED LIGHT
	CEILING RECESSED 18W LED LIGHT(WEATHER PROOF)
	WALL FIXED WEATHER PROOF LED LIGHT
	WALL FIXED LED LIGHT
	PENDANT DECORATIVE LIGHT
	MOTION SENSOR LED LIGHT 12W
	1000W FLOOD LIGHT
	WALL MOUNT LED LIGHT (PROVIDE 13A SINGLE SOCKET@2.8M I.E. INSIDE CEILING)
A/C	CEILING MOUNT VRV INDOOR UNIT

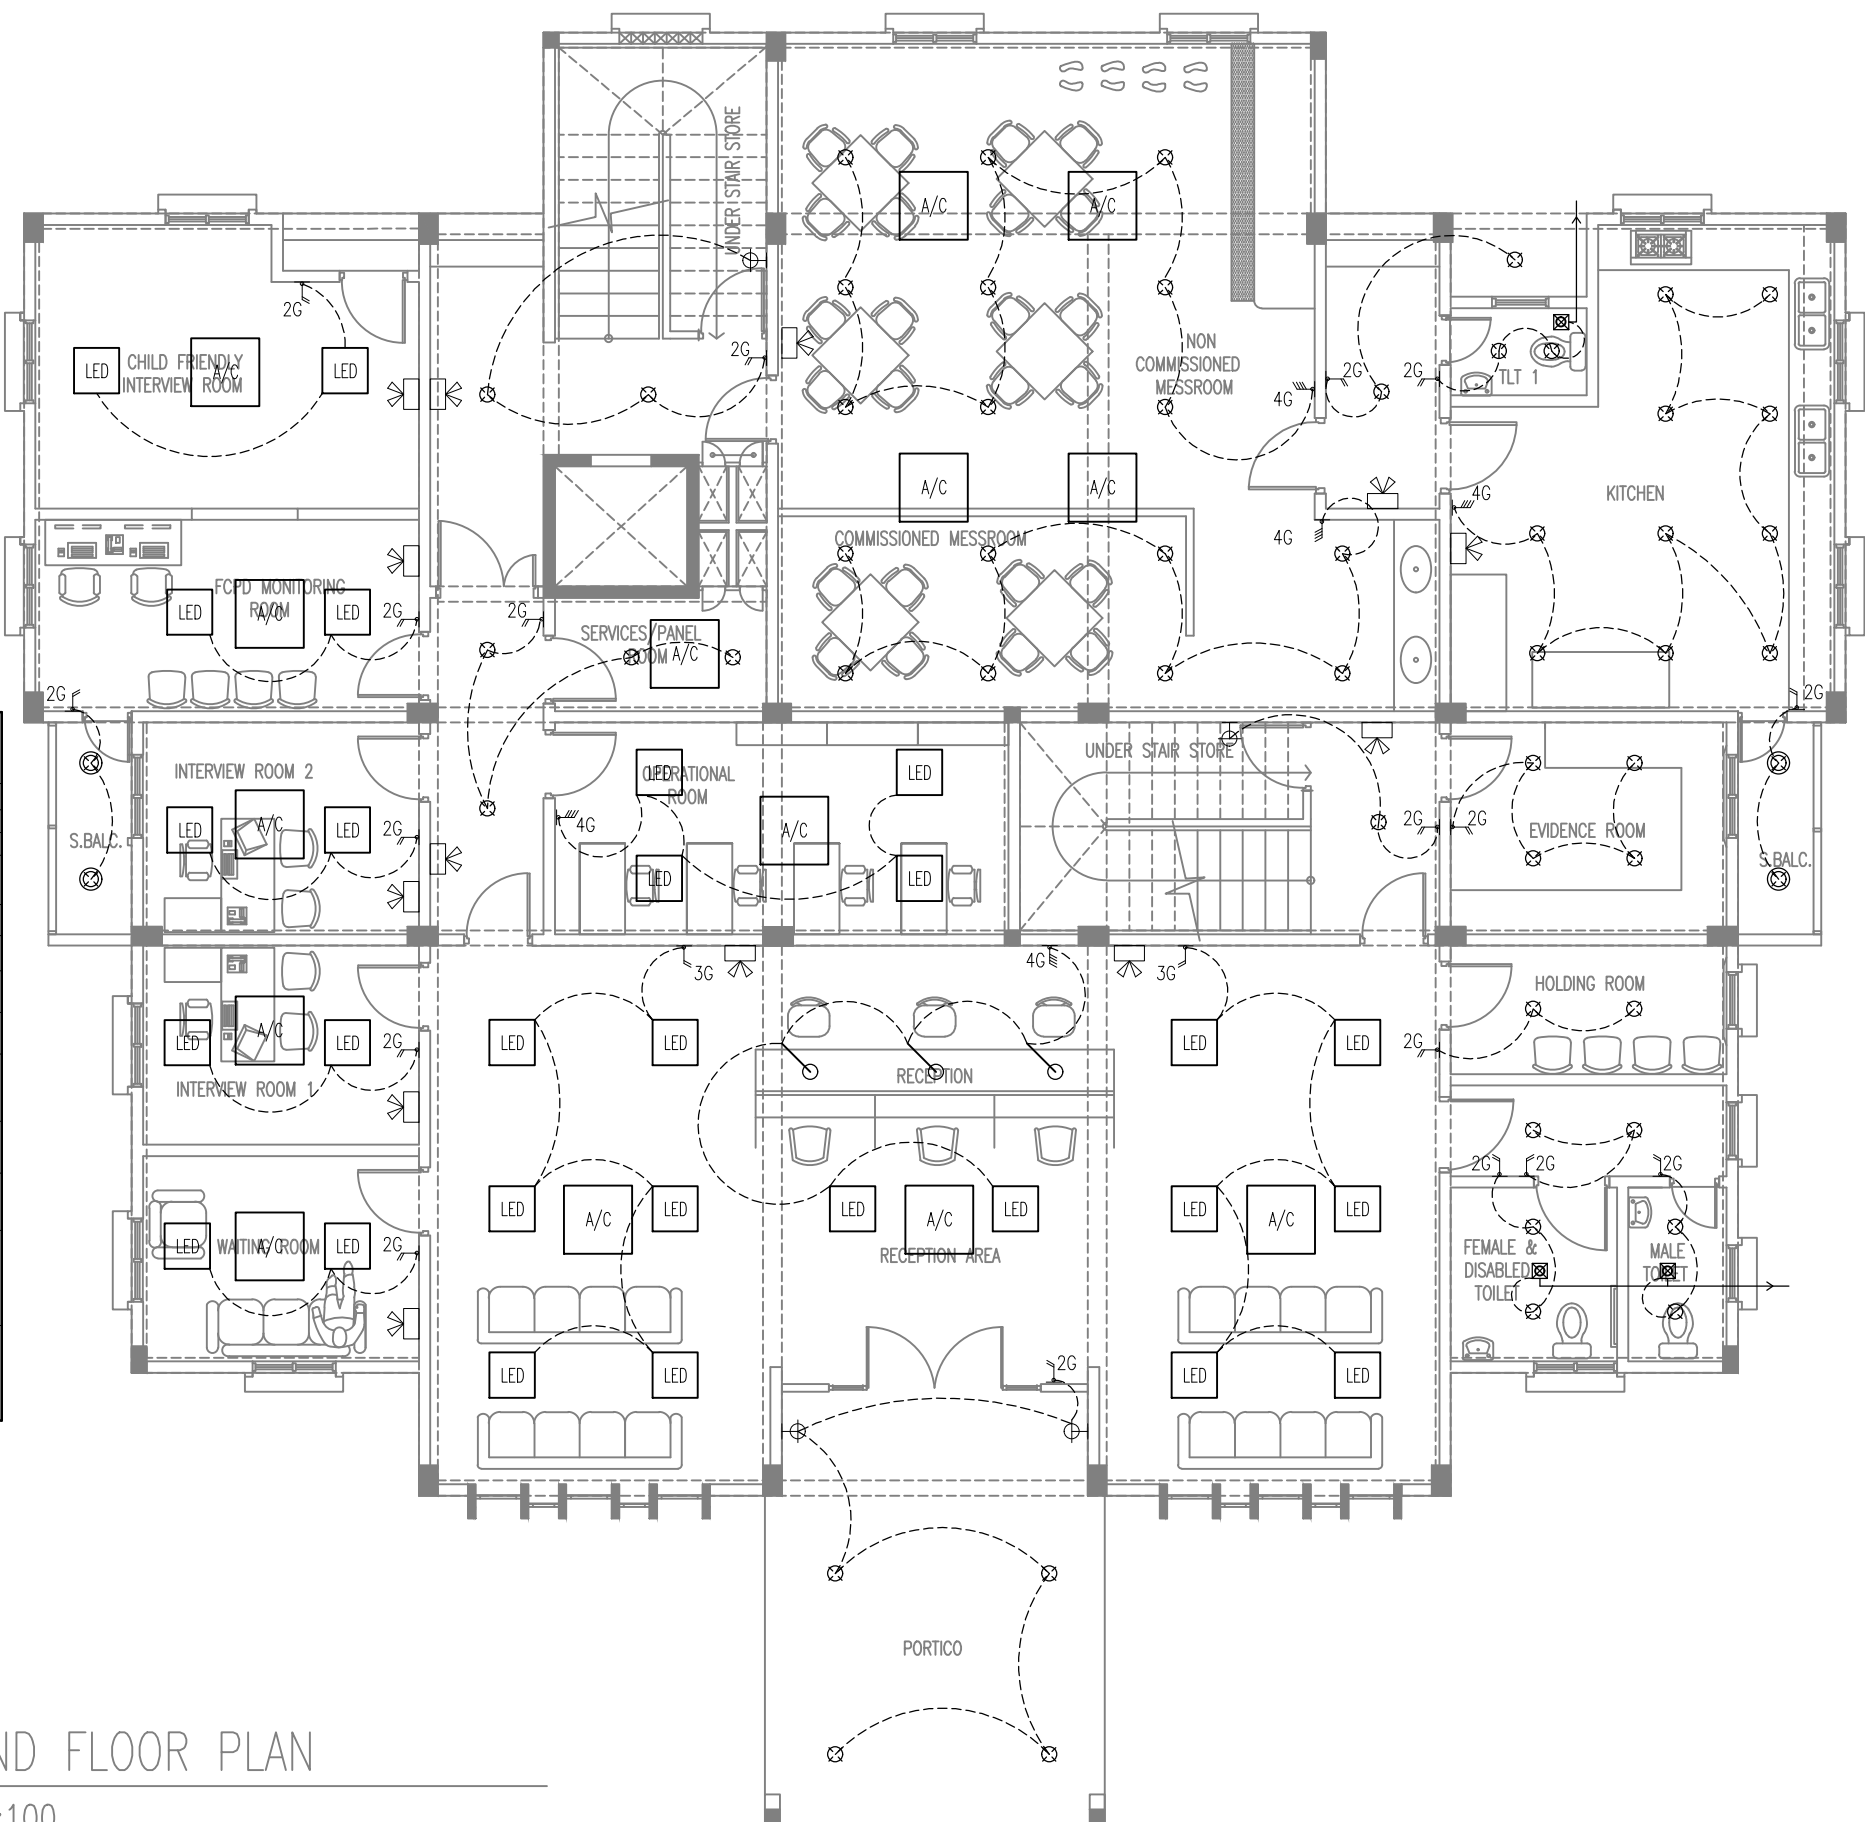

GROUND FLOOR PLAN
SCALE 1:100