

PLUMBING LEGEND

- ⊥


TAP
- ⊥
├

TAP WITH BRANCH TO MUSLIM SHOWER
- ⊥
├
└─┬─┘

SHOWER SET
- ⊥
├
└─┬─┘
└─┬─┘

STOP WALVE

NOTE :
– DRAWING IS SCHEMATIC. CONTRACTOR MUST SUBMIT DETAIL DRAWINGS/ SHOP DRAWINGS BEFORE COMMENCING ANY WORK.
– AFTER INSTALLING ANY SERVICE CONTRACTOR MUST SUBMIT AS-BUILT DRAWINGS

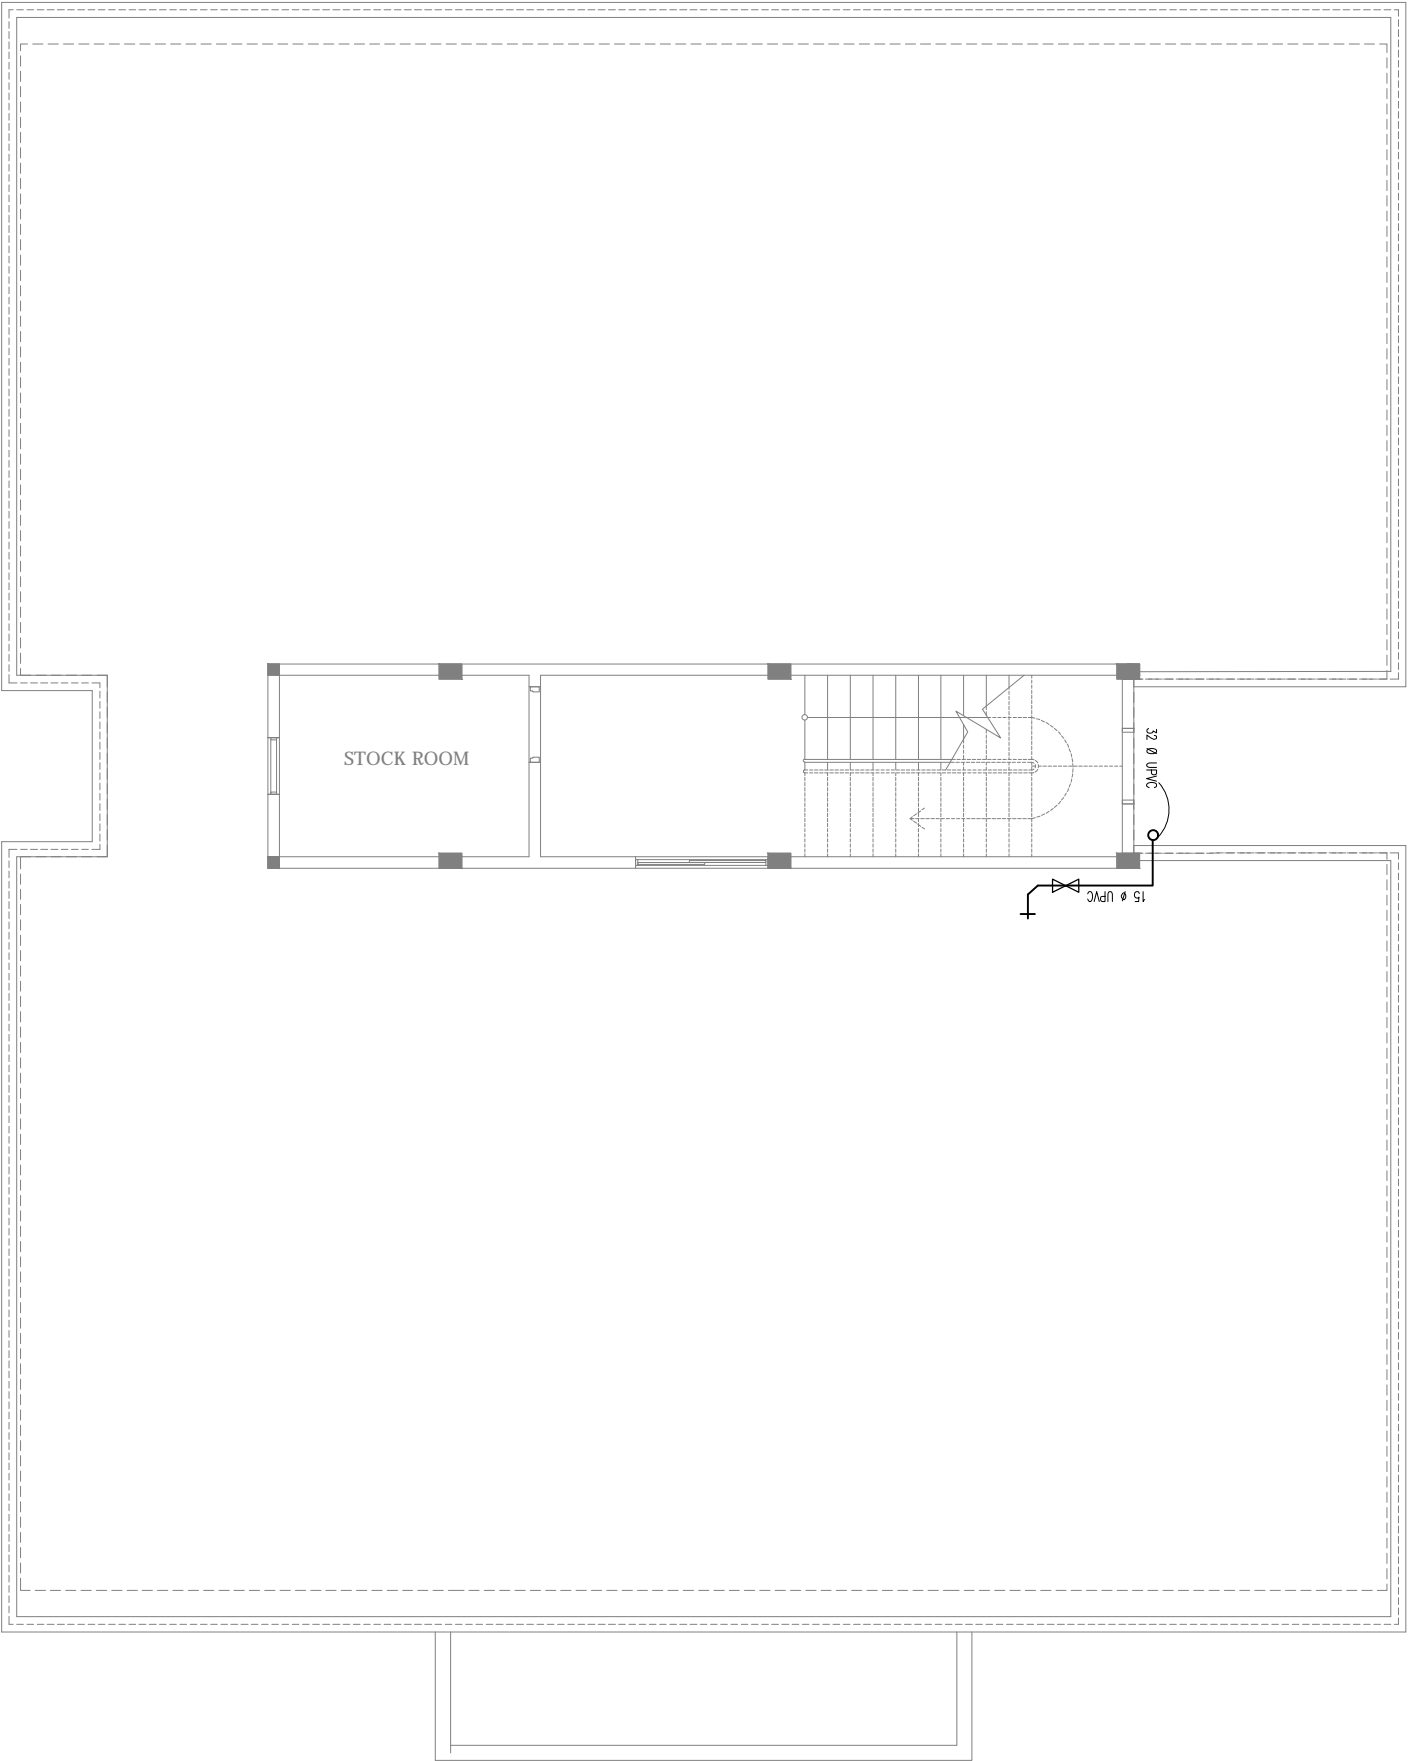

TERRACE FLOOR FRESH WATER LAYOUT

SCALE 1:100

FINANCE AND ASSET MANAGEMENT INFRASTRUCTURE UNIT MALDIVES POLICE SERVICE	
PROJECT TITLE: S. HITHADHOO POLICE ACCOMMODATION	
MALDIVES POLICE SERVICE SEAL & SIGN	
CONTRACTORS SEAL & SIGN	
THE DRAWINGS,CONCEPT AND DESIGN CONTAINED AREA THE PROPERTIES OF MALDIVES POLICE SERVICE,USE OF ANY KIND OR COPY OF WHOLE OR PART OF THIS DRAWING CONCEPT OR DESIGN OR USE ON OTHER PROJECTS OR SITES OTHER THAN THAT SPECIFIED ON THIS DRAWINGS IS STRICTLY PROHIBITED	
ARCHITECT/DESIGNER ASSISTANT DIRECTOR AHMED SADHEEM	DRAFTED BY ASSISTANT DIRECTOR AHMED SADHEEM
STRUCTURAL ENGINEER SUB INSP OF POLICE MOHAMED FAZEEN	DRAFTED BY ASSISTANT DIRECTOR AHMED SADHEEM
CHECKED BY SUB INSP OF POLICE MOHAMED FALAAH	CHECKED BY SUB INSP OF POLICE AHMED NIZAL
ARCHITECTURAL DRAWINGS	
SHEET NO.	DATE: 19 AUGUST 2021