

9 STOREY ACCOMMODATION BUILDING

BANDAAARA KOSHI / MALE

SHEET CONTENT:

DESIGN APPROVAL:

BRIG. GEN. AHMED SHAHID

VICE CHIEF OF DEFENCE FORCE

RECOM. APPROVAL:

CPT. AHMED SHARIM

OFFICER COMMANDING

APPROVED:

MAJ. GEN. AHMED SHIYAM

CHIEF OF DEFENCE FORCE

APPROVED DATE:

DESIGNED:

L.CPT. A.U. MUTHASIM

PTE. M. SAIF ABDULLA

Architectural

WO1. AHMED SHAZEEL

Structural

CHECKED:

CPT. MOHAMED SHIFA'AU

Architectural

WO3. AMINATH AU

Structural

Electrical & Mechanical

Communication

DRAWN:

L.CPT. A.U. MUTHASIM

PTE. M. SAIF ABDULLA

Architectural

DATE:

07 AUGUST 2015

SCALE:

1:200

REVISION:

PTE. HUSSAIN GASIM

PTE. YAMIN SAEED

DATE:

11 SEPTEMBER 2016


SHEET NO.:

-




MALDIVES NATIONAL DEFENCE FORCE
State, Republic of Maldives

The drawings, concept and design contained are the properties of Military Engineers MNDFF. Use of any kind or copy of whole or part of this drawing, concept or design or use on other projects or sites other than that specified on this drawing is strictly prohibited.

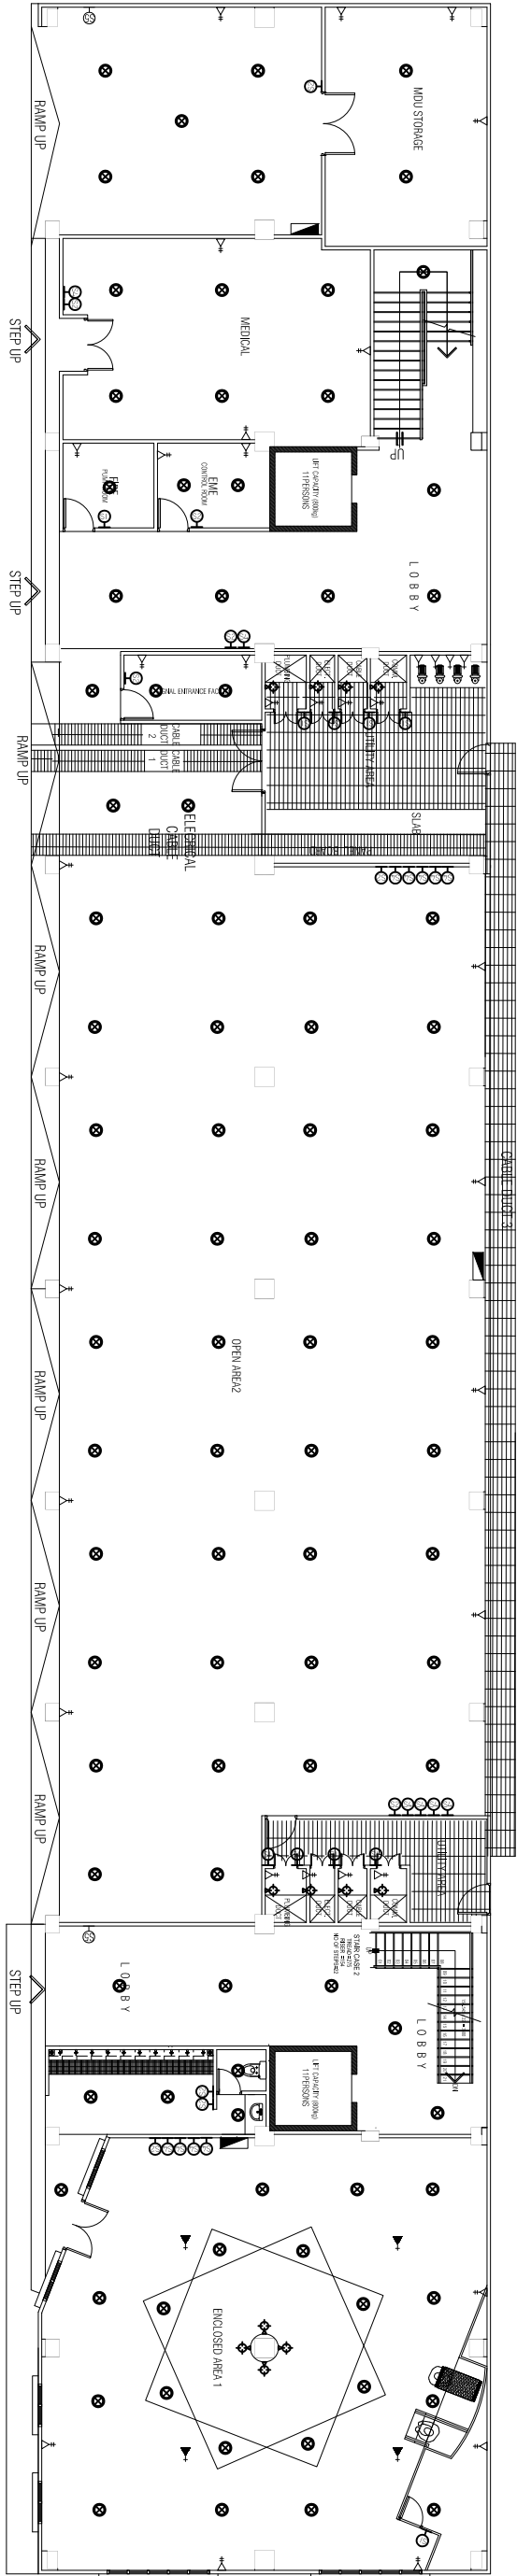

GROUND FLOOR PLAN

SCALE: 1:200

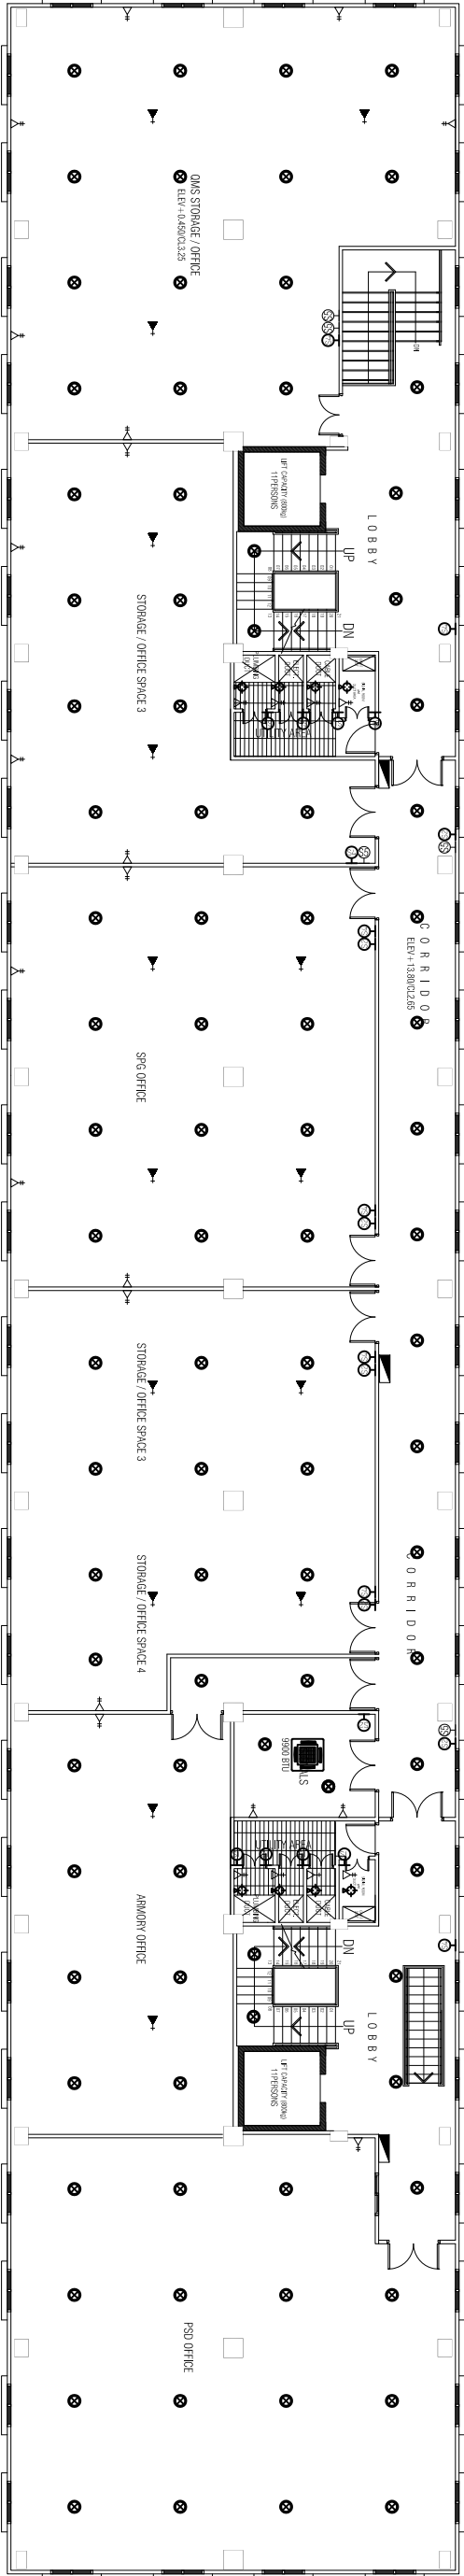

FIRST FLOOR PLAN

SCALE: 1:200

LEGEND:

SYMBOL QUANTITY DESCRIPTION

GRND 1ST

| | | |
|----|----|-----------------------------------|
| 93 | 92 | DOWN LIGHTS C.W 20W ENERGY SAVING |
| 11 | 08 | ONE GANG SWITCH |
| 08 | 07 | TWO GANG SWITCH |
| 26 | 07 | FOUR GANG SWITCH |
| 02 | 10 | FIVE GANG SWITCH |
| 04 | 08 | INDOOR WALL LIGHT |
| 03 | 03 | DISTRIBUTION BOARD |
| 25 | 40 | 2413A POWER OUTLET |
| 07 | 19 | 1415A POWER OUTLET |

BANDARA KOSHI / MALE

BRIG. GEN. AHMED SHAHID

VICE CHIEF OF DEFENCE FORCE

RECOM. APPROVAL

CPT. AHMED SHARIM

OFFICER COMMANDING

APPROVED:

MAJ. GEN. AHMED SHIYAM

CHIEF OF DEFENCE FORCE

APPROVED DATE:

DESIGNED:

| | |
|----------------------|-------------------|
| L. CPL ALI MUTHASIM | WO1. AHMED SHAZEE |
| PTE. M. SAIF ABDULLA | |

Architectura

CHECKED:

CPT. MOHAMED SHIFAU **WO3. ALIMINATH AL**

Architectura

Electrical & Mechanical Communication

DRAWN:

| | |
|----------------------|--------------------|
| L. CPL ALI MUTHASIM | PTE. HUSSAIN GASIM |
| PTE. M. SAIF ABDULLA | PTE. YAMIN SAEED |

DATE:

07 AUGUST 2015 11 SEPTEMBER 2016

SCALE: SHEET NO

1:200



The drawings, concept and design contained are the property of Military Engineers MNDF. Use of any kind of copy of whole or part of this drawing, concept or design for use on other projects or sites other than that specified in this drawing is strictly prohibited.

9 STOREY ACCOMMODATION BUILDING

BANDAAARA KOSHI / MALE

SHEET CONTENT:

DESIGN APPROVAL:

BRIG. GEN. AHMED SHAHID

VICE CHIEF OF DEFENCE FORCE

RECOM. APPROVAL:

CPT. AHMED SHARIM

OFFICER COMMANDING

APPROVED:

MAJ. GEN. AHMED SHIYAM

CHIEF OF DEFENCE FORCE

APPROVED DATE:

DESIGNED:

L.CPT. ALI MUTHASIM

PTE. M. SAIF ABDULLA

Architectural

WO1. AHMED SHAZEEL

Structural

CHECKED:

CPT. MOHAMED SHIFA'AU

Architectural

WO3. AMINATH ALI

Structural

Electrical & Mechanical

Communication

DRAWN:

L.CPT. ALI MUTHASIM

PTE. M. SAIF ABDULLA

DATE:

07 AUGUST 2015

SCALE:

1:200

REVISION:

PTE. HUSSAIN GASIM

PTE. YAMIN SAEED

DATE:

11 SEPTEMBER 2016


SHEET NO.:

-




NATIONAL DEFENCE FORCE
MALDIVES
State, Republic of Maldives

The drawings, concept and design contained are the properties of Military Engineers MNDFF. Use of any kind or copy of whole or part of this drawing, concept or design or use on other projects or sites other than that specified on this drawing is strictly prohibited.

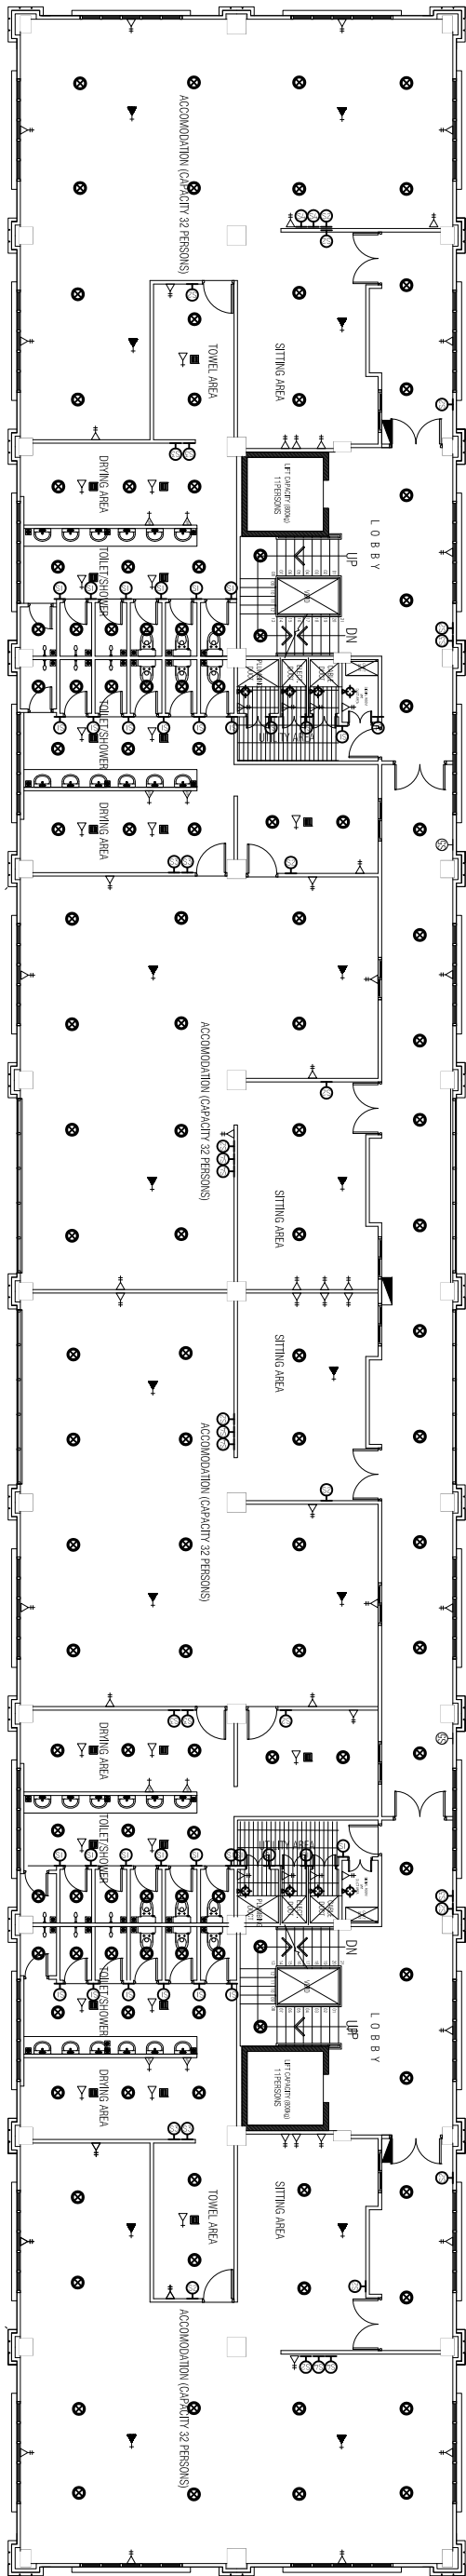

FOURTH FLOOR PLAN

SCALE 1:200

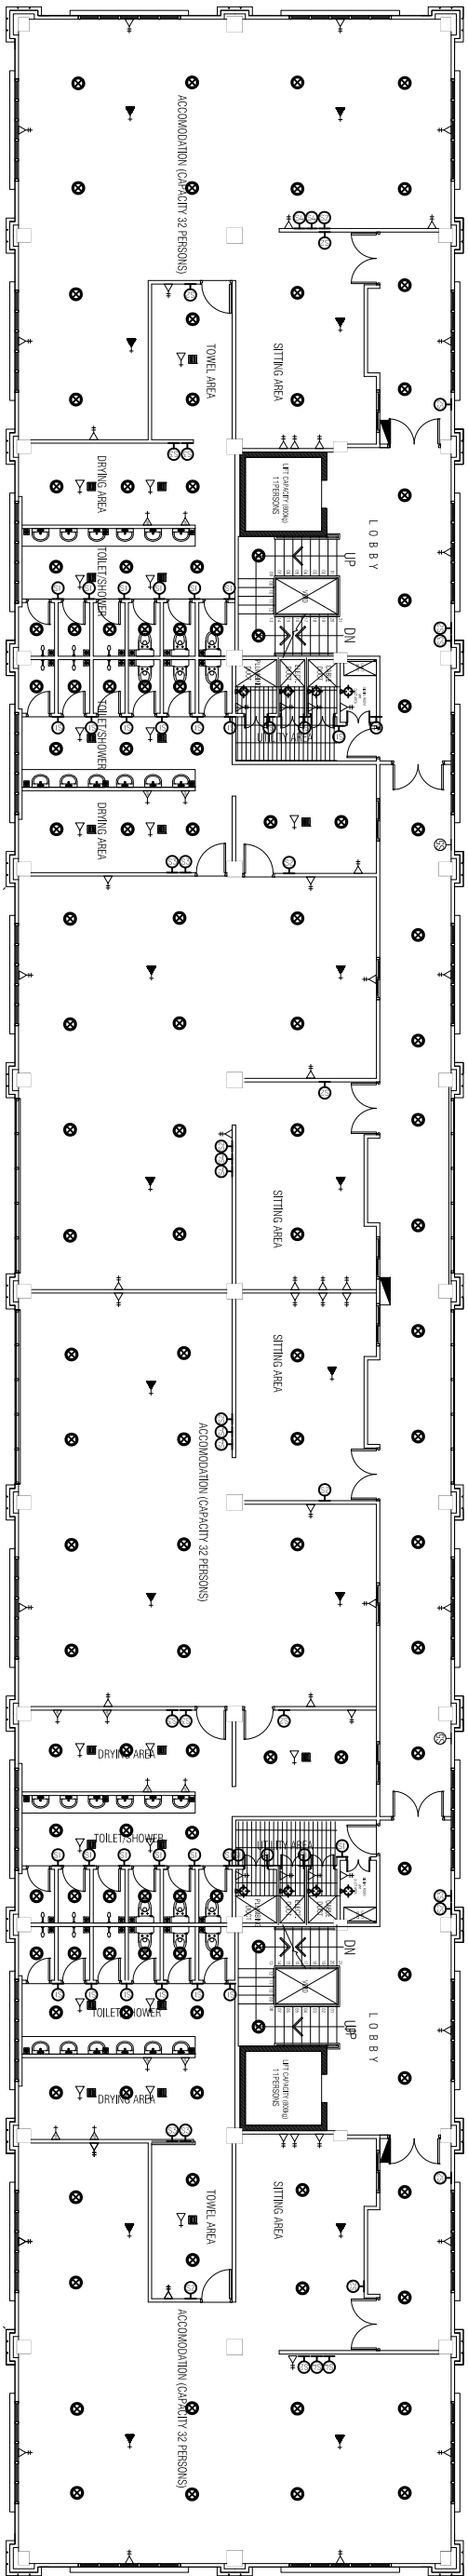

FIFTH & SIXTH FLOOR PLAN

SCALE 1:200

LEGEND:

| SYMBOL | QUANTITY | DESCRIPTION |
|--------|----------|----------------------------------|
| 128 | 128 | DOWNLIGHTS C/W 20W ENERGY SAVING |
| 32 | 32 | ONE GANG SWITCH |
| 16 | 16 | TWO GANG SWITCH |
| 10 | 10 | THREE GANG SWITCH |
| 08 | 08 | FOUR GANG SWITCH |
| 02 | 02 | FIVE GANG SWITCH |
| 20 | 20 | CEDLING EXHAUST |
| 03 | 03 | DISTRIBUTION BOARD |
| 08 | 08 | 11.5A POWER OUTLET (WATER PROOF) |
| 20 | 20 | 13A POWER OUTLET |
| 55 | 55 | 21.5A POWER OUTLET |
| 16 | 16 | 11.5A POWER OUTLET |

NOTE:
ALL SWITCHES @ 12.750W/FTL

9 STOREY ACCOMMODATION BUILDING

BANDAAFA KOSHI / MALE

SHEET CONTENT:

DESIGN APPROVAL:

BRIG. GEN. AHMED SHAHID

VICE CHIEF OF DEFENCE FORCE

RECOM. APPROVAL:

CPT. AHMED SHARIM

OFFICER COMMANDING

APPROVED:

MAJ. GEN. AHMED SHIYAM

CHIEF OF DEFENCE FORCE

APPROVED DATE:

DESIGNED:

L.CPT. AU MUTHASIM

PTE. M. SAIF ABDULLA

Architectural

WO1. AHMED SHAZEEL

Structural

CHECKED:

CPT. MOHAMED SHIFA AU

Architectural

WO3. AMINATH AU

Structural

Electrical & Mechanical

Communication

DRAWN:

L.CPT. AU MUTHASIM

PTE. M. SAIF ABDULLA

DATE:

07 AUGUST 2015

SCALE:

1:200

REVISION:

PTE. HUSSAIN GASIM


PTE. YAMIN SAEED

DATE:

11 SEPTEMBER 2016


SHEET NO:

-

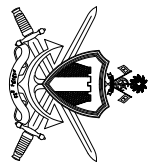


NATIONAL ENGINEERS
MALDIVES NATIONAL DEFENCE FORCE
Male, Republic of Maldives

The drawings, concept and design contained are the properties of Military Engineers MNDFF. Use of any kind or copy of whole or part of this drawing, concept or design or use on other projects or sites other than that specified on this drawing is strictly prohibited.

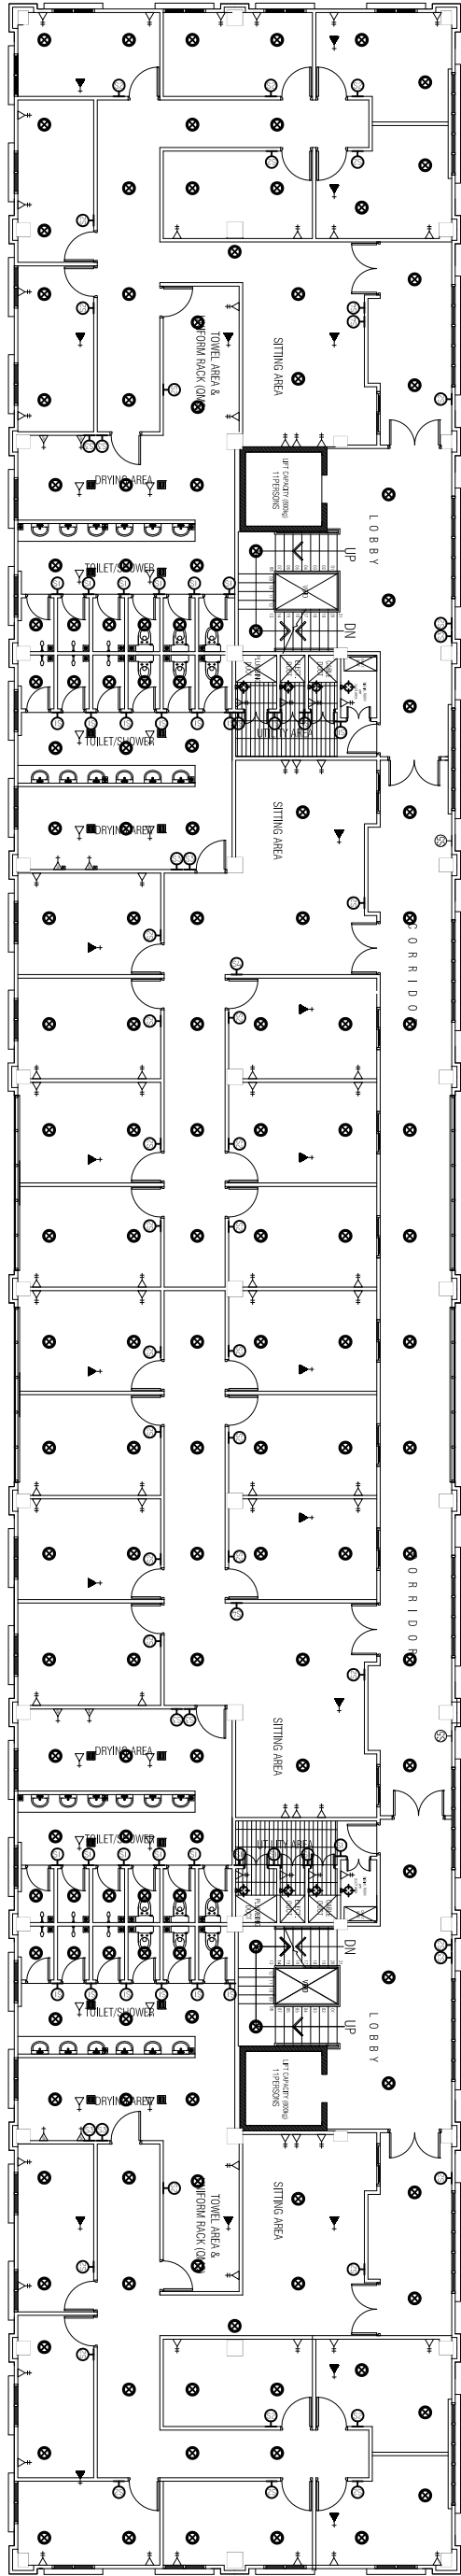

SEVENTH FLOOR PLAN

SCALE 1:200

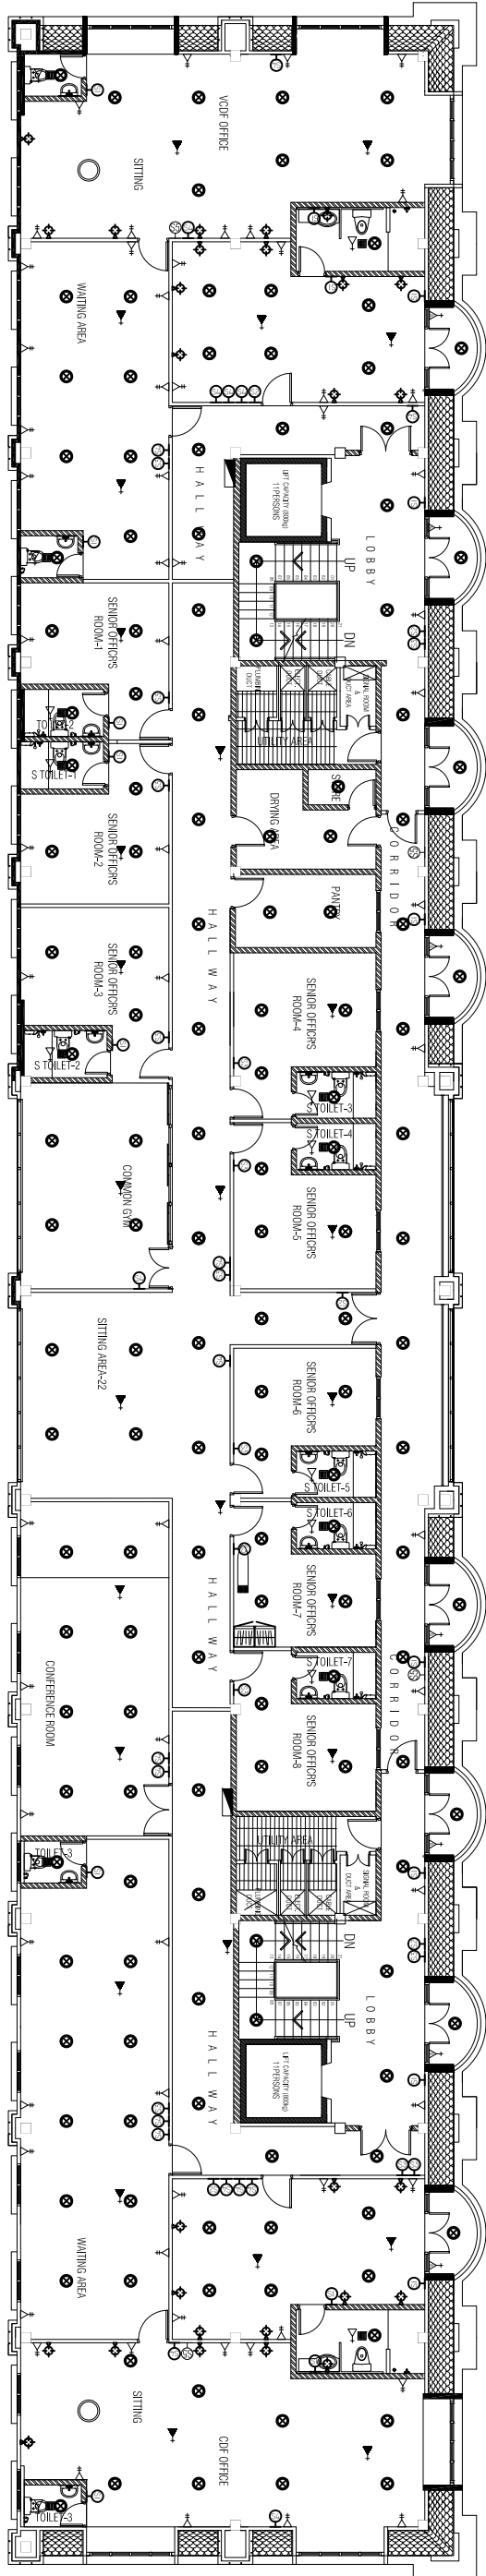

EIGHTH FLOOR PLAN

SCALE 1:200

| SYMBOL | QUANTITY | DESCRIPTION |
|--------|----------|----------------------------------|
| 160 | 136 | DOWN LIGHTS 20W ENERGY SAVING |
| 32 | 18 | ONE GANG SWITCH |
| 37 | 05 | TWO GANG SWITCH |
| 09 | 15 | THREE GANG SWITCH |
| 02 | 19 | FOUR GANG SWITCH |
| 02 | 04 | FIVE GANG SWITCH |
| 16 | 14 | CEILING EXHAUST |
| 08 | 29 | INDOOR WALL LIGHT |
| 00 | 02 | DECOMPRATE CEILING LIGHT |
| 00 | 02 | DISTRIBUTION BOARD |
| 08 | 09 | 1413A POWER OUTLET (WATER PROOF) |
| 16 | 14 | 1413A POWER OUTLET |
| 80 | 66 | 2413A POWER OUTLET |
| 22 | 28 | 1415A POWER OUTLET |

NOTE:
ALL SWITCHES @ 12 FROM FFL

9 STOREY ACCOMMODATION BUILDING

BANDARA KOSHI / MALE

SHEET CONTENT:

DESIGN APPROVAL:

BRIG. GEN. AHMED SHAHID
VICE CHIEF OF DEFENCE FORCE

RECOM. APPROVAL:

CPT. AHMED SHARIM
OFFICER COMMANDING

APPROVED:

MAJ. GEN. AHMED SHIYAM

CHIEF OF DEFENCE FORCE

APPROVED DATE:

DESIGNED:

L.CPT. AUI MUTHASIM
PTE. M. SAIF ABDULLA

WO1. AHMED SHAZEEL

Architectural

Structural

CHECKED:

CPT. MOHAMED SHIFA'AU
Architectural

WO3. AMINATH AUI

Structural

Electrical & Mechanical

Communication

DRAWN:

REVISION:

L.CPT. AUI MUTHASIM
PTE. M. SAIF ABDULLA

PTE. HUSSAIN GASIM
PTE. YAMIN SAEED

DATE:

DATE:

07 AUGUST 2015

11 SEPTEMBER 2016

SCALE:

SHEET NO:


1:200

-



NATIONAL DEFENCE FORCE
MALDIVES
State, Republic of Maldives

The drawings, concept and design contained are the properties of Military Engineers MNDFF. Use of any kind or copy of whole or part of this drawing, concept or design or use on other projects or sites other than that specified on this drawing is strictly prohibited.

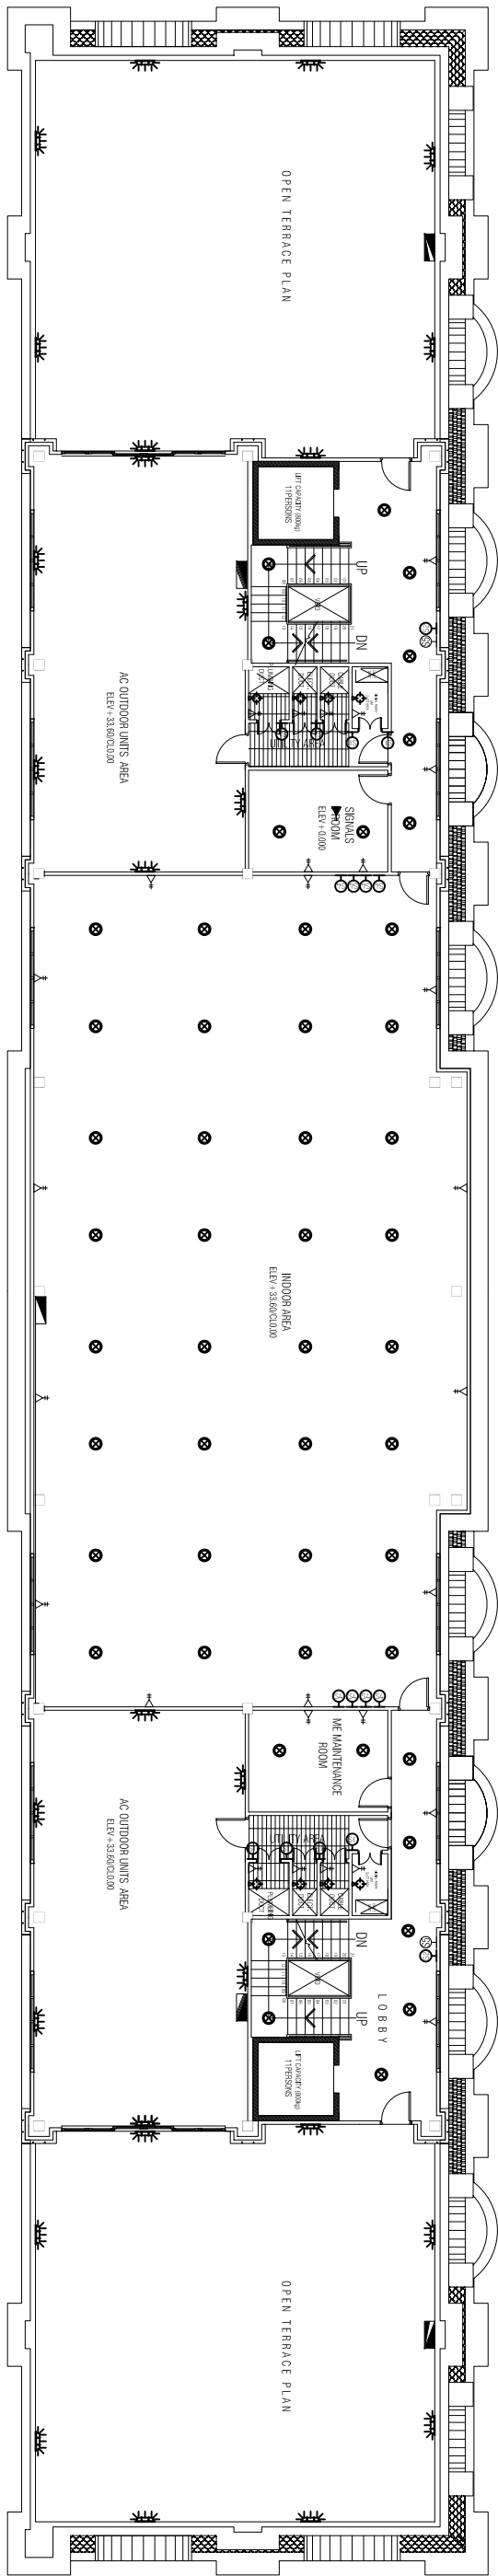

TERRACE FLOOR PLAN
SCALE 1:200

LEGEND:

| SYMBOL | QUANTITY | DESCRIPTION |
|---------|----------|---|
| TERRACE | | |
| ● | 50 | DOWN LIGHTS C/W 20W ENERGY SAVERS |
| ○ | 08 | ONE GANG SWITCH |
| ○ | 02 | TWO GANG SWITCH |
| ○ | 08 | FOUR GANG SWITCH |
| ○ | 02 | FIVE GANG SWITCH |
| ○ | 08 | INDOOR WALL LIGHT |
| ○ | 20 | WATER WHITE 8W FLS LIGHT |
| ○ | 01 | WALL MOUNTING TYPE WATER PROOF DISTRIBUTION BOARD |
| ○ | 02 | OUTDOOR DISTRIBUTION BOARD |
| ○ | 02 | 3 PHASE DISTRIBUTION BOARD |
| ○ | 20 | 2x15A POWER OUTLET |
| ○ | 01 | 1x15A POWER OUTLET |

NOTE:
ALL SWITCHES @ 12.750W FFL

9 STOREY ACCOMMODATION BUILDING

BANDAAARA KOSHI / MALE

SHEET CONTENT:

DESIGN APPROVAL:

BRIG. GEN. AHMED SHAHID

VICE CHIEF OF DEFENCE FORCE

RECOM. APPROVAL:

CPT. AHMED SHARIM

OFFICER COMMANDING

APPROVED:

MAJ. GEN. AHMED SHIYAM

CHIEF OF DEFENCE FORCE

APPROVED DATE:

DESIGNED:

L.CPT. AUI MUTHASIM

PTE. M. SAIF ABDULLA

Architectural

WO1. AHMED SHAZEEL

Structural

CHECKED:

CPT. MOHAMED SHIFA'AU

Architectural

WO3. AMINATH AUI

Structural

Electrical & Mechanical

Communication

DRAWN:

REVISION:

L.CPT. AUI MUTHASIM

PTE. M. SAIF ABDULLA

DATE:

PTE. HUSSAIN GASIM

PTE. YAMIN SAEED

DATE:

07 AUGUST 2015

11 SEPTEMBER 2016

SCALE:

SHEET NO:


1:200

-




NATIONAL DEFENCE FORCE
MALDIVES
State, Republic of Maldives



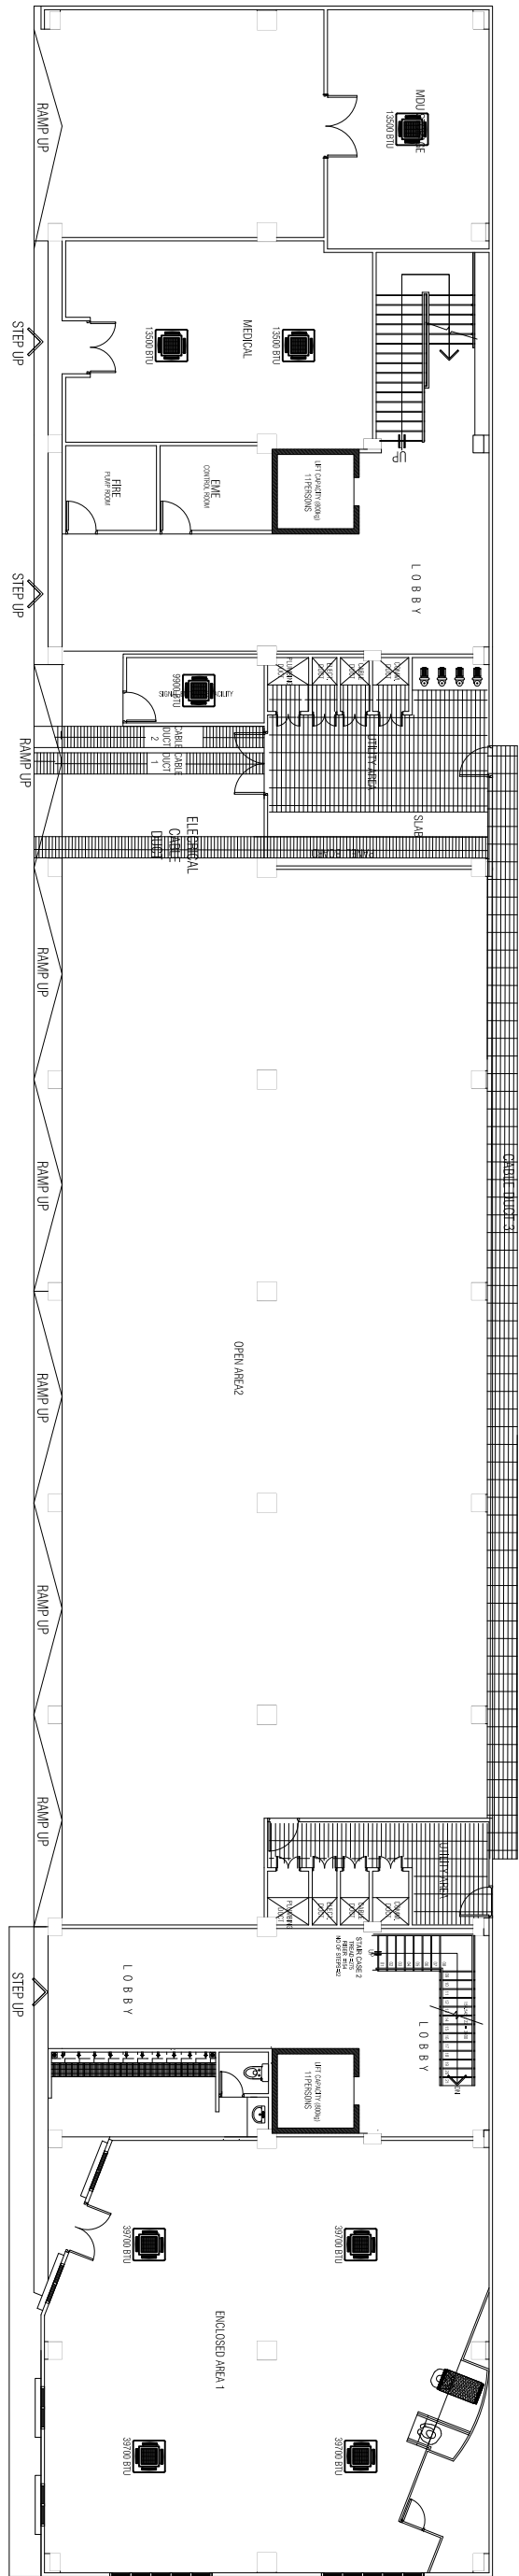

The drawings, concept and design contained are the properties of Military Engineers MNDFF. Use of any kind or copy of whole or part of this drawing, concept or design or use on other projects or sites other than that specified on this drawing is strictly prohibited.

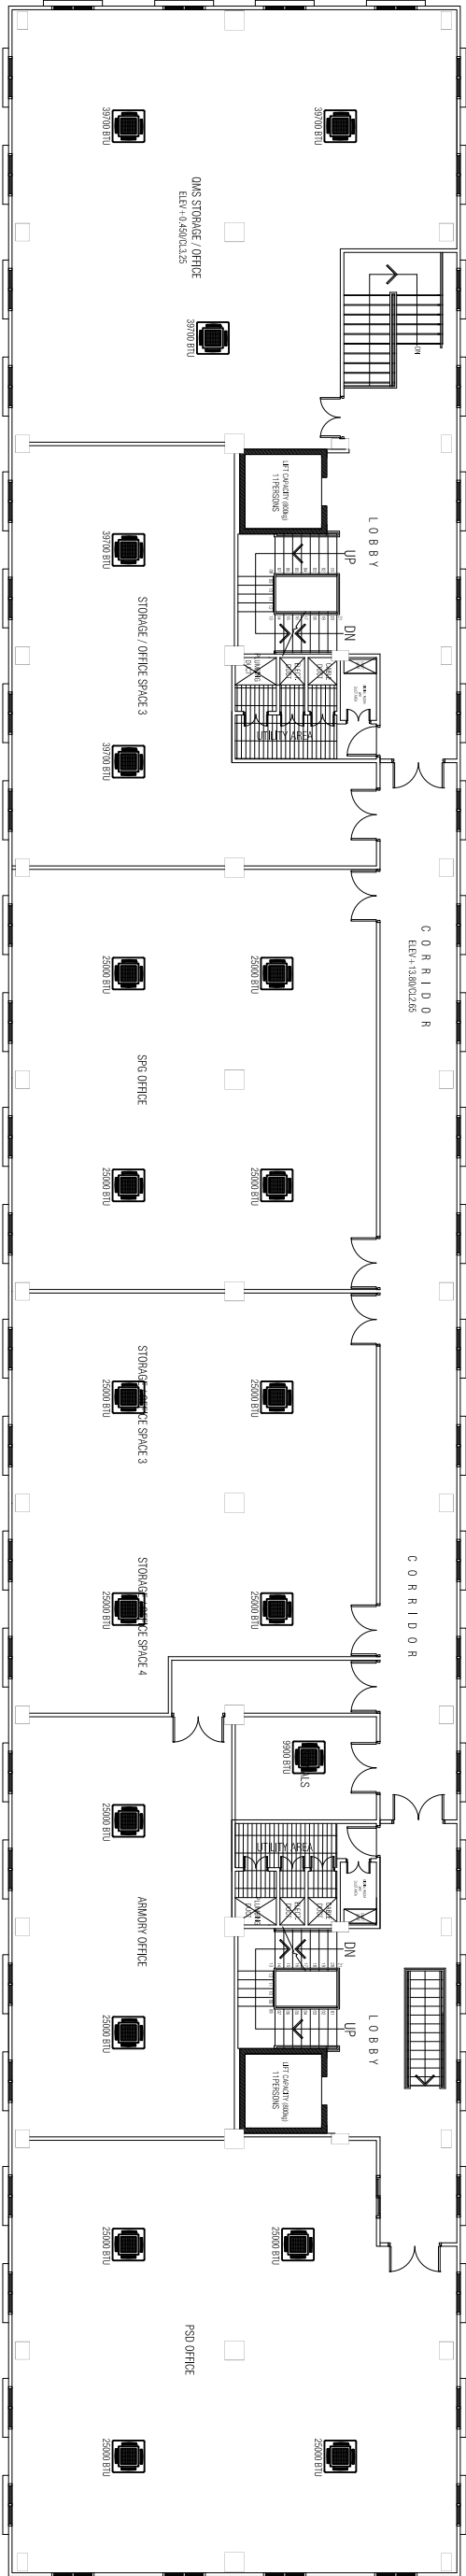

GROUND FLOOR PLAN



FIRST FLOOR PLAN

| LEGEND: | | | |
|---|----------|-------------|-----------------------------------|
| SYMBOL | QUANTITY | DESCRIPTION | |
| GRND 1ST | | | |
|  | 00 | 14 | CASSETTE TYPE A0 UNIT (25000 BTU) |
|  | 04 | 05 | CASSETTE TYPE A0 UNIT (25000 BTU) |
|  | 03 | 00 | CASSETTE TYPE A0 UNIT (25000 BTU) |
|  | 01 | 01 | CASSETTE TYPE A0 UNIT (25000 BTU) |