



FRONT ELEVATION

SCALE 1 : 100

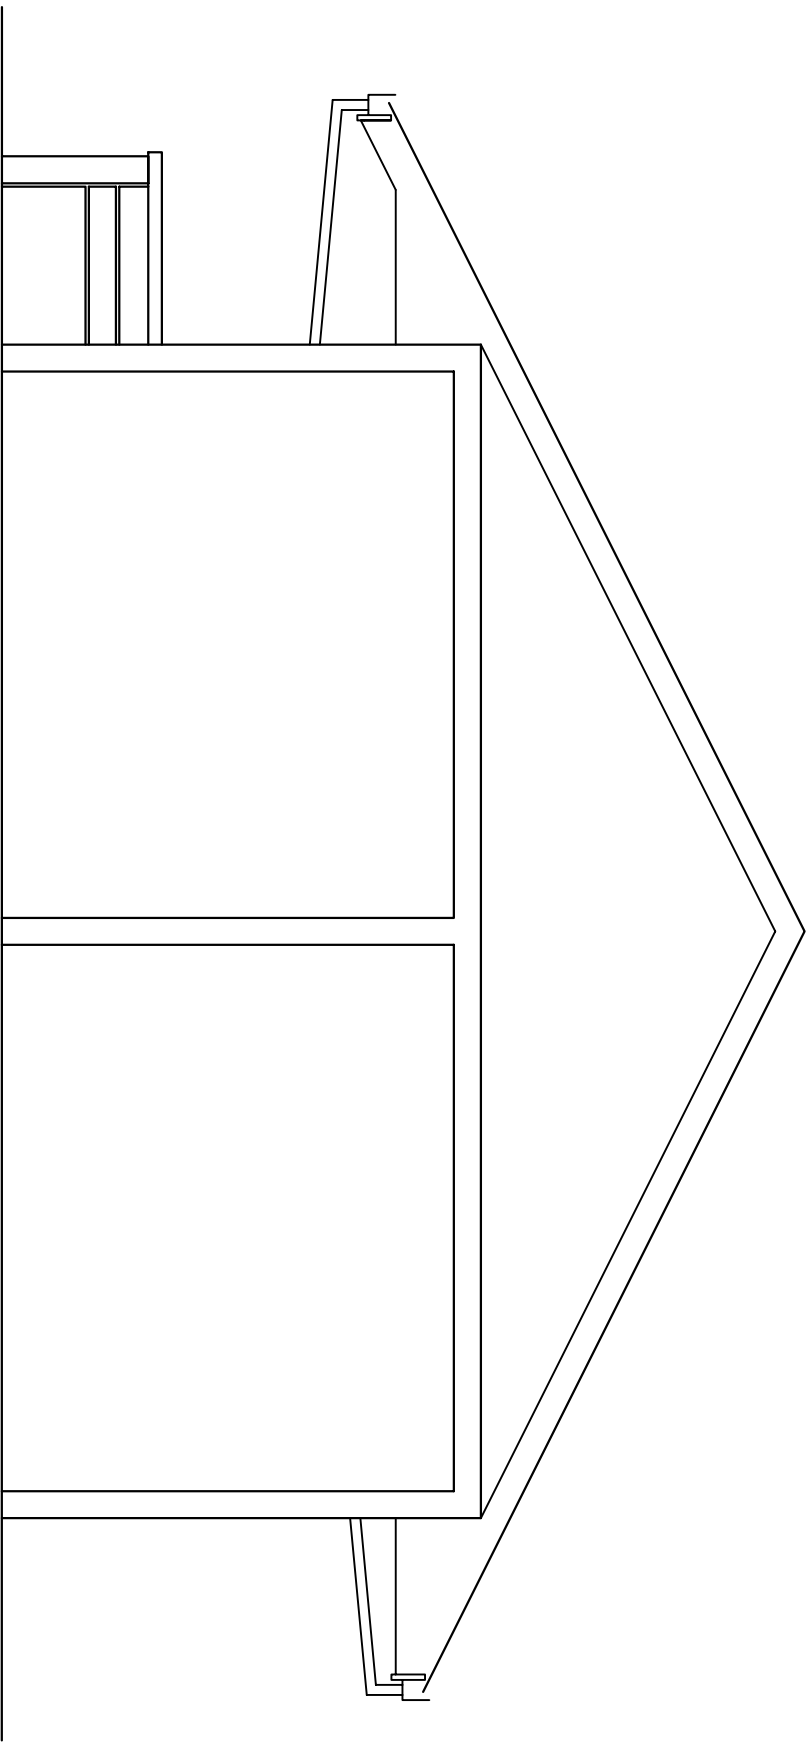

SIDE ELEVATION

SCALE 1 : 100

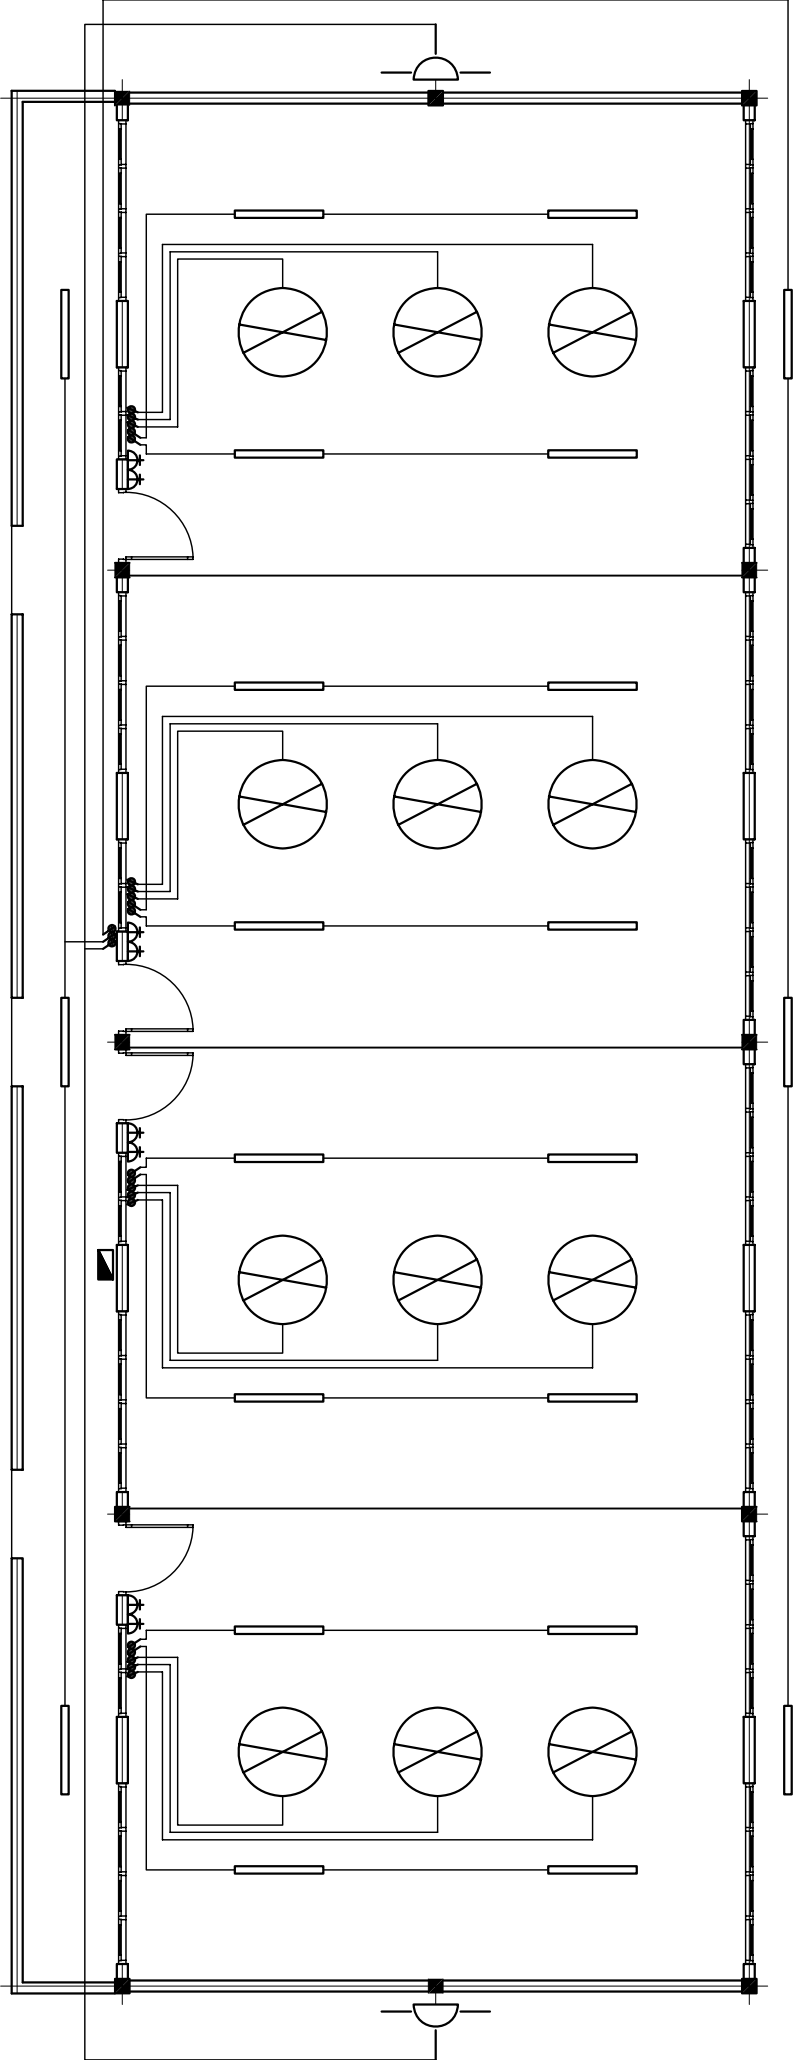

LEGEND



CEILING FAN 1200dia



WALL MOUNTED GLOBE LIGHT



DISTRIBUTION BOX



FLOURESCENT TUBE LIGHT 40W
(with presmatic cover)



13A SOCKET OUTLET




ONE WAY SWITCH



FAN REGULATOR

ELECTRICAL PLAN

SCALE 1 : 100

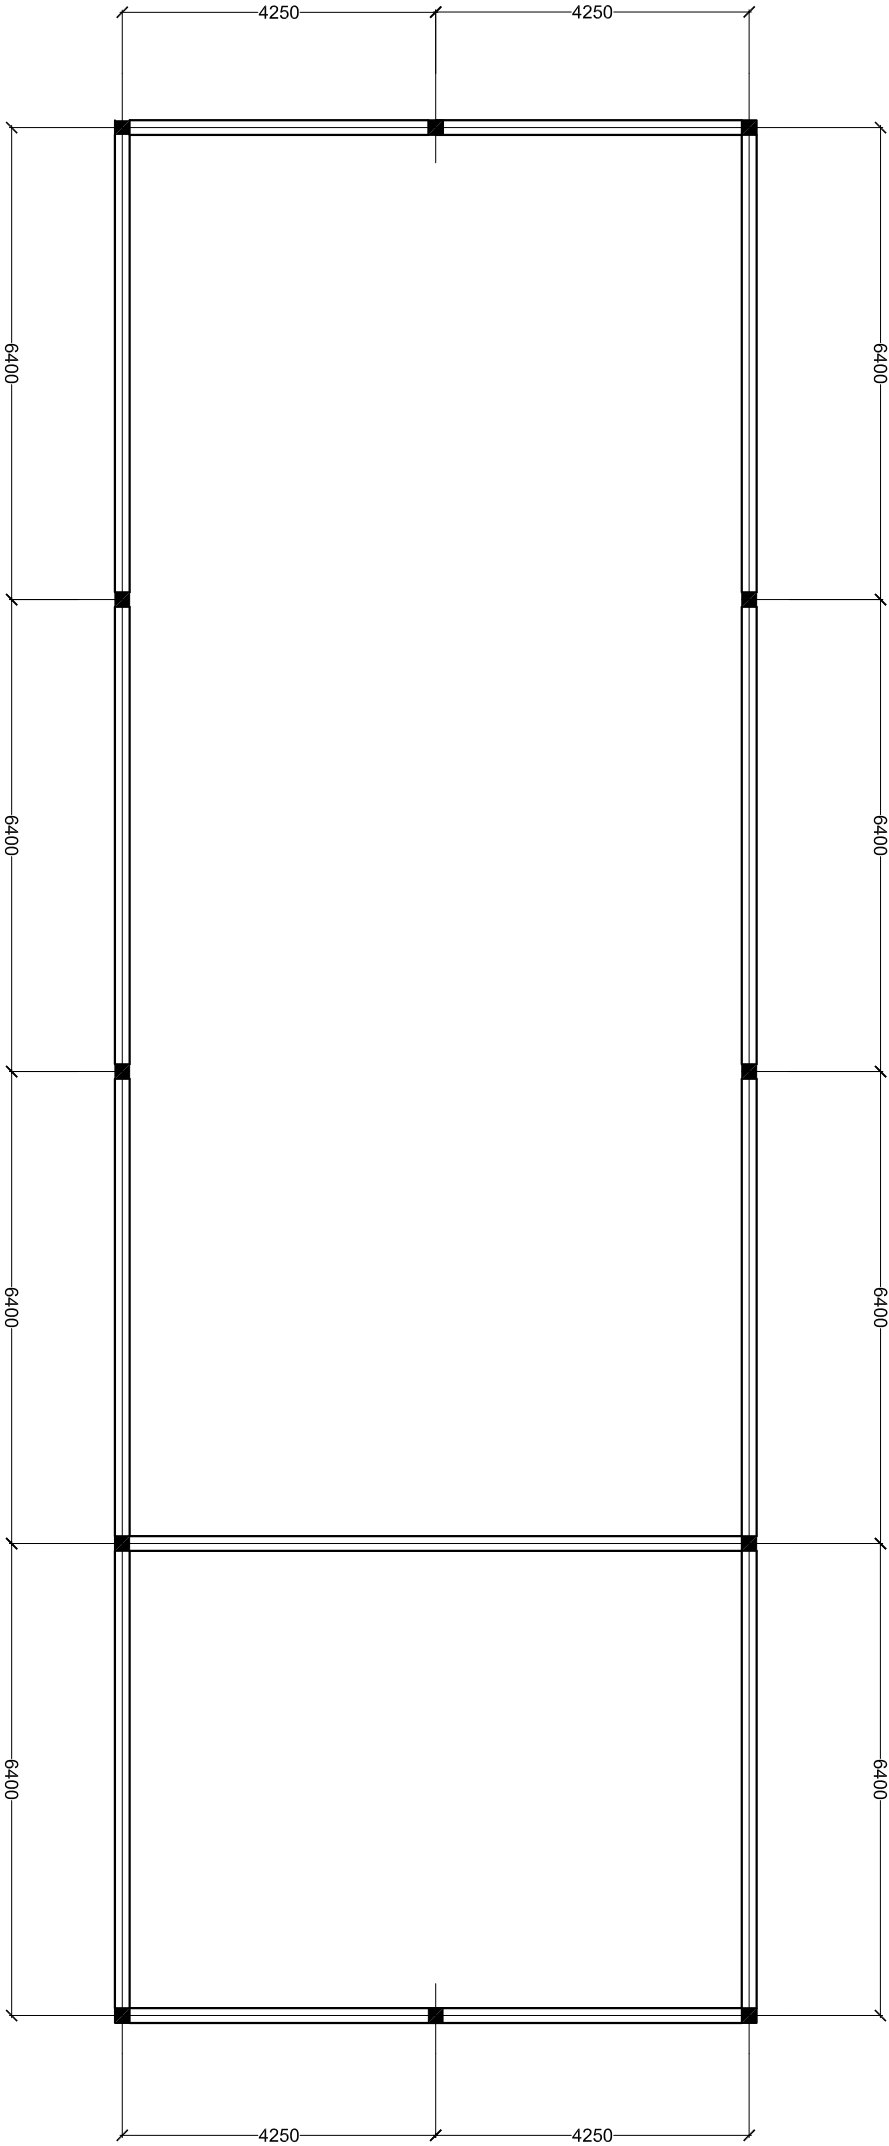


FOUNDATION PLAN

SCALE 1 : 100




SCALE 1 : 100

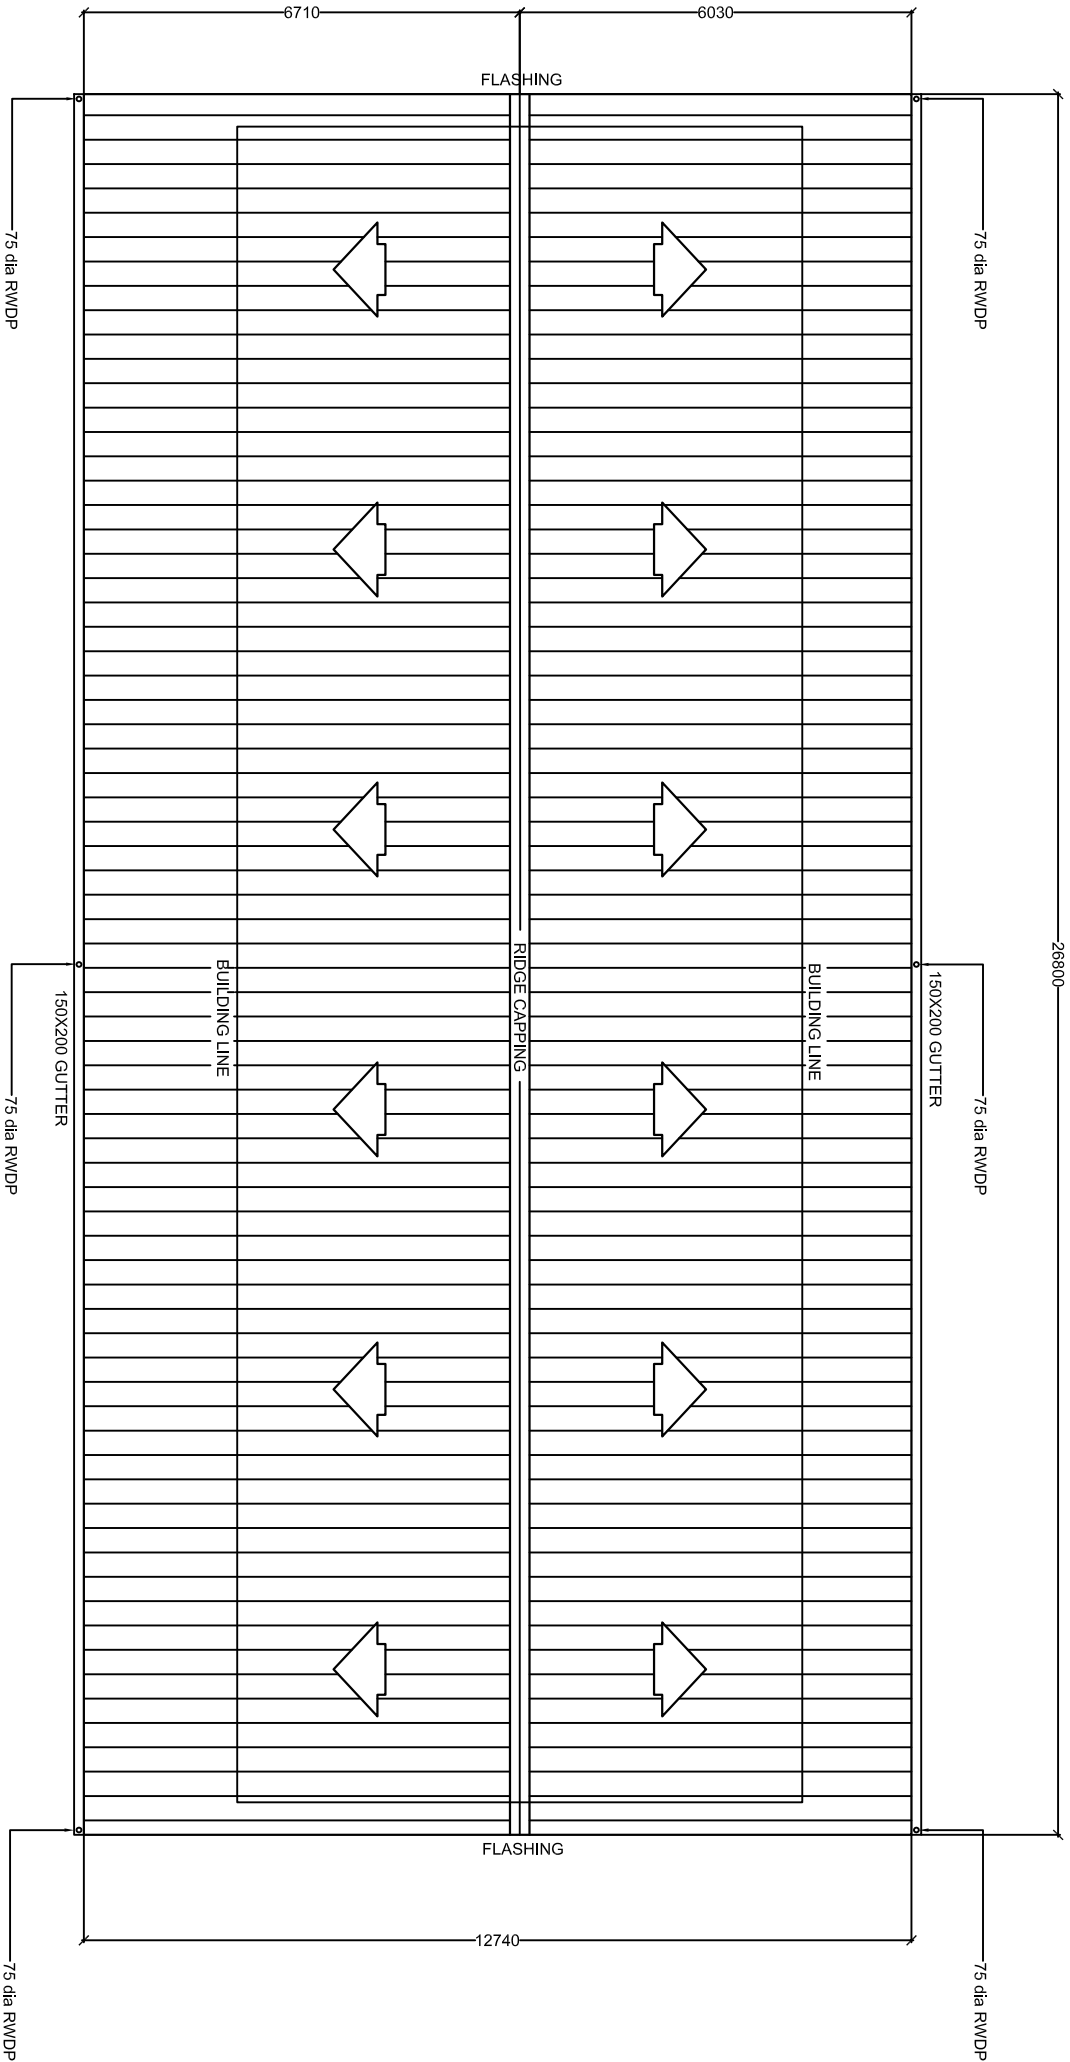


ROOF PLAN


SCALE 1 : 100

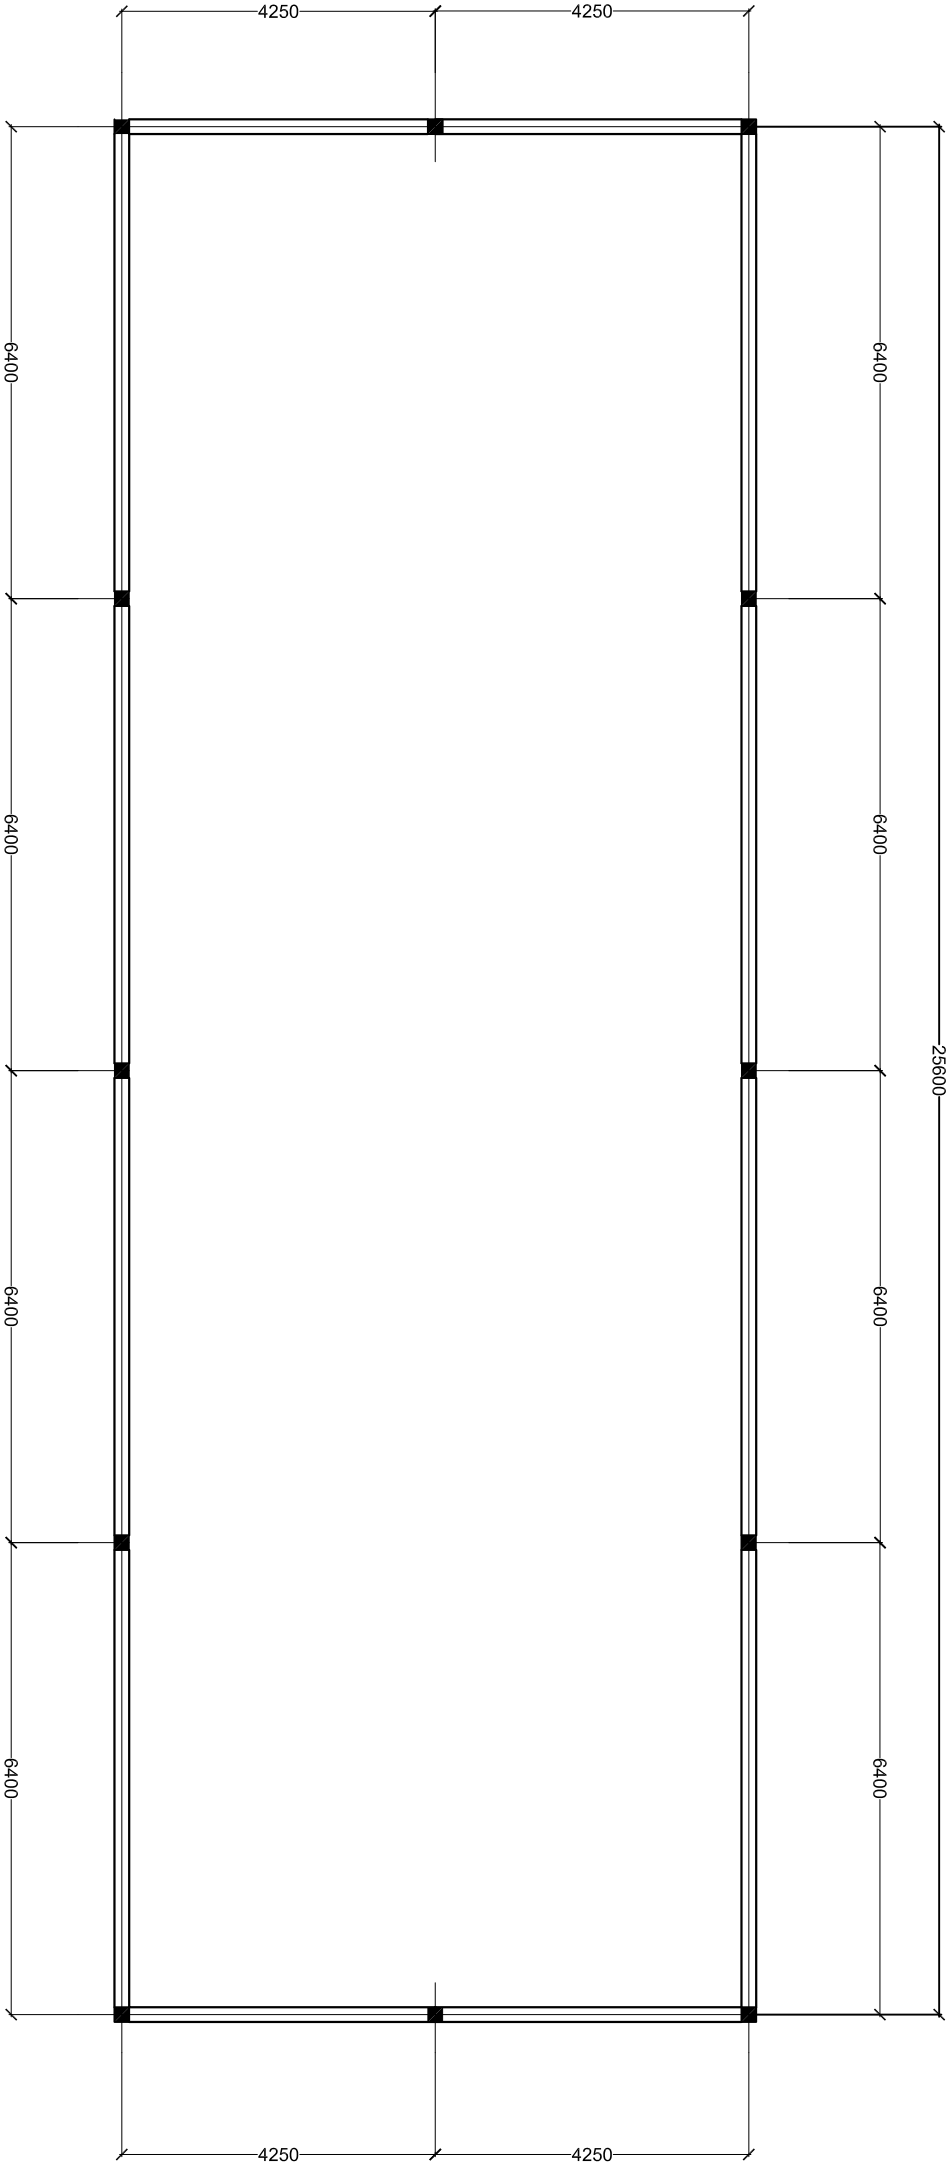

ROOF BEAM PLAN


SCALE 1 : 100

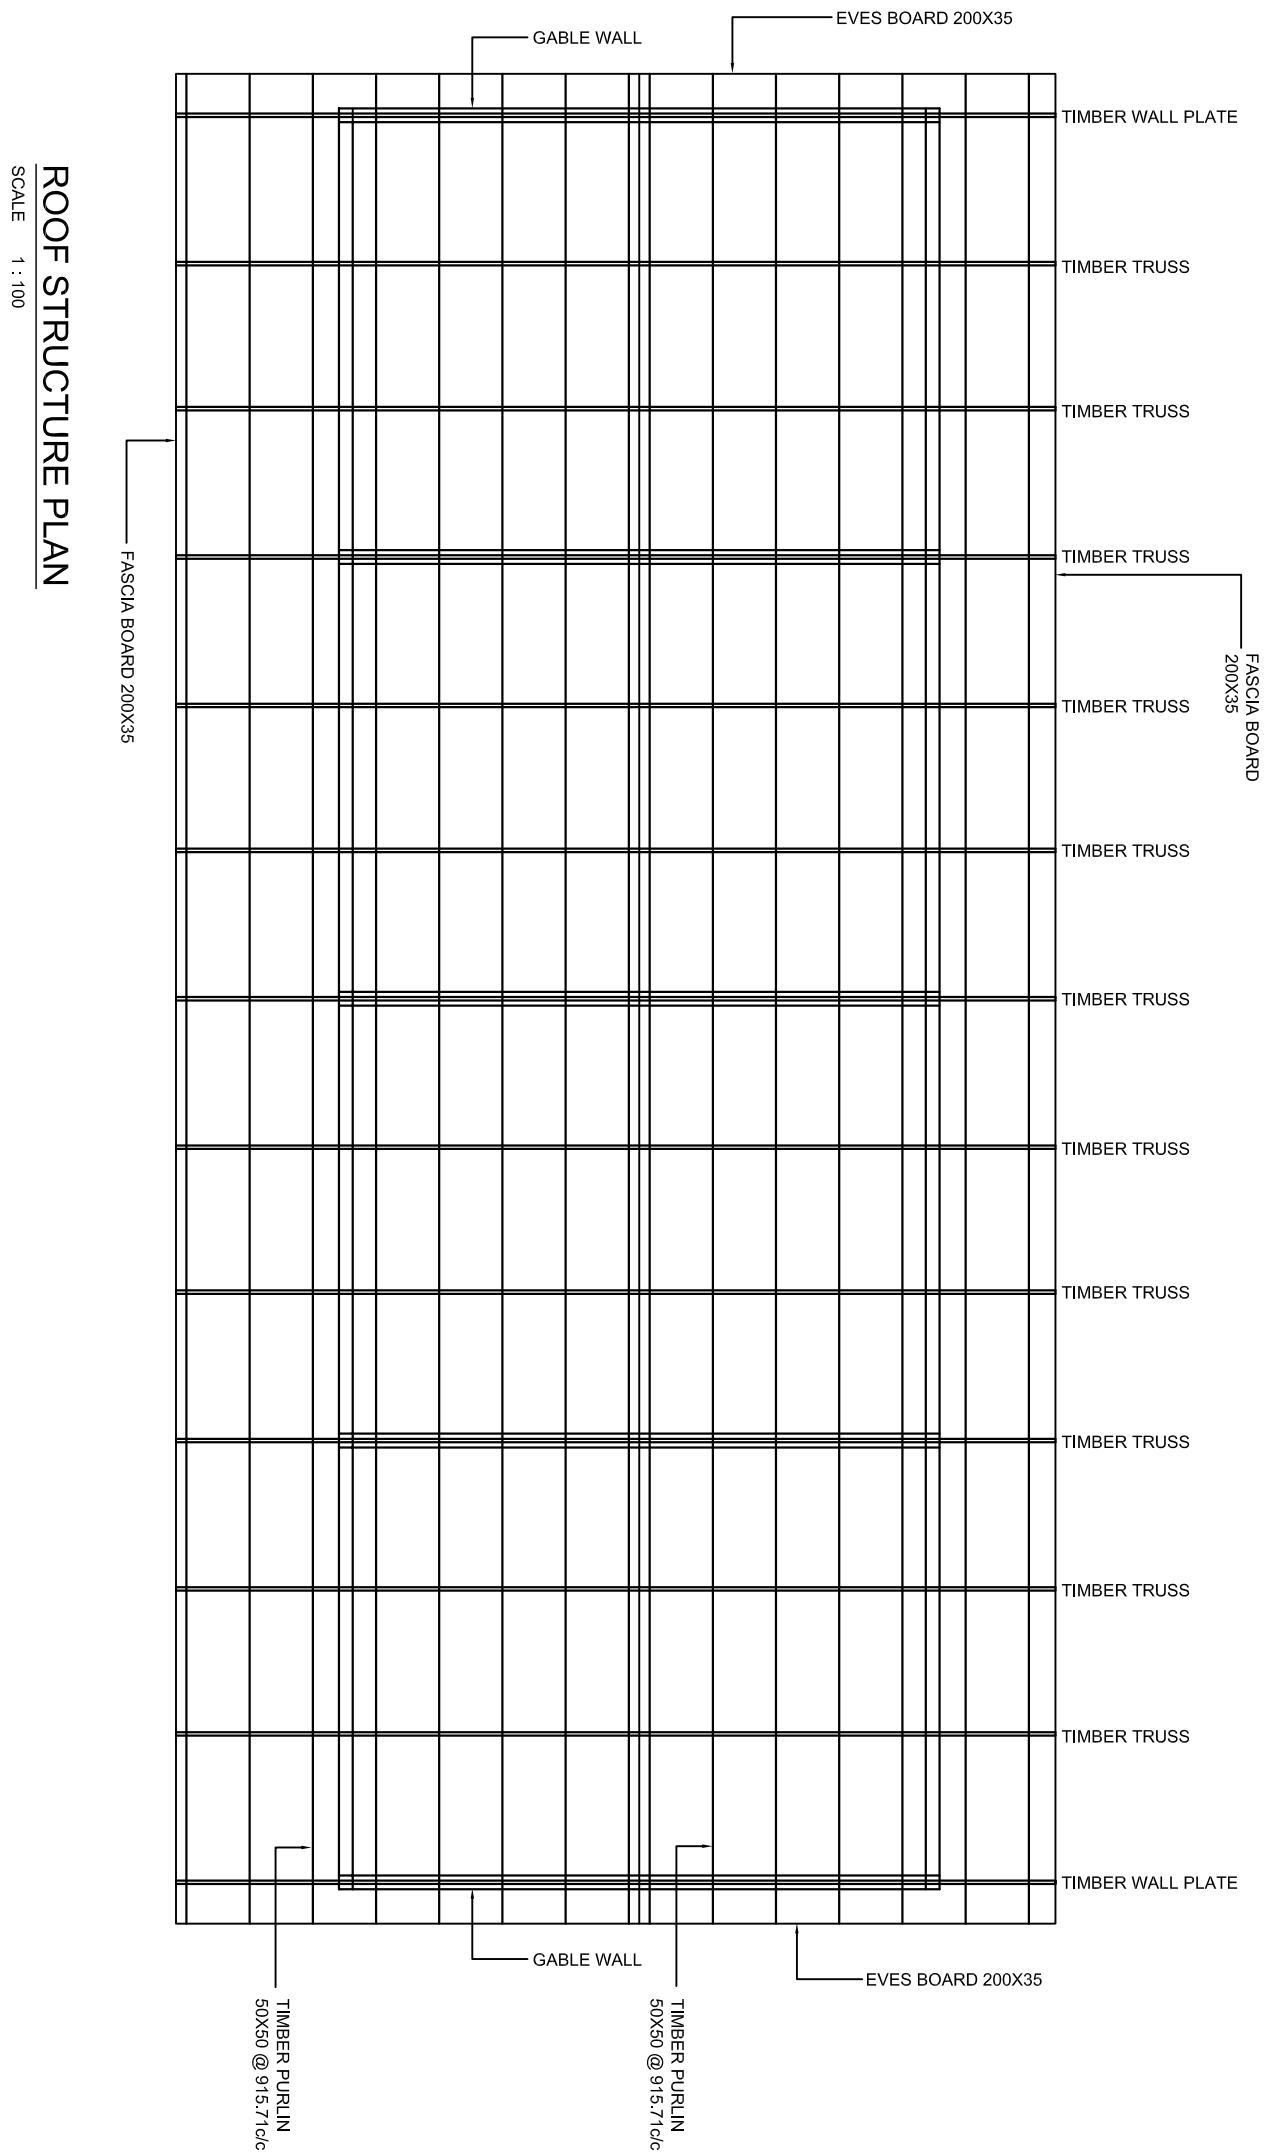

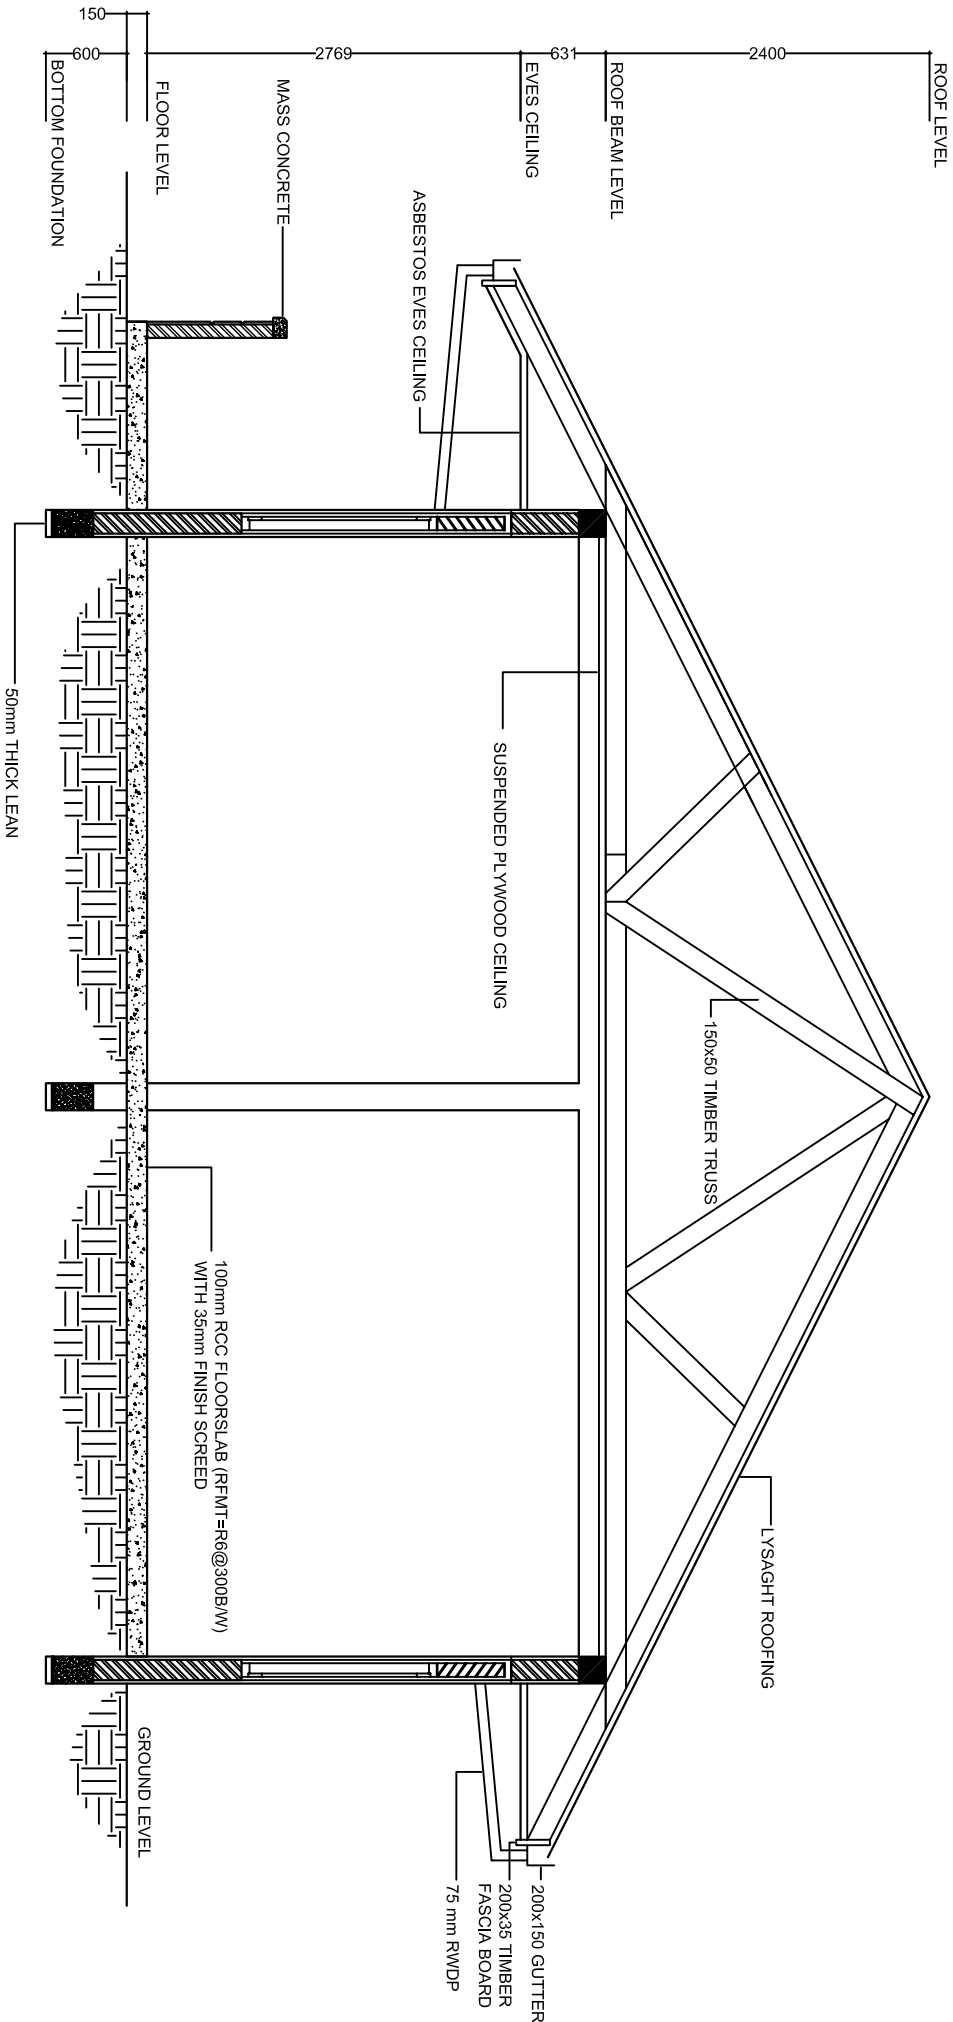


CROSS SECTION

SCALE 1 : 50

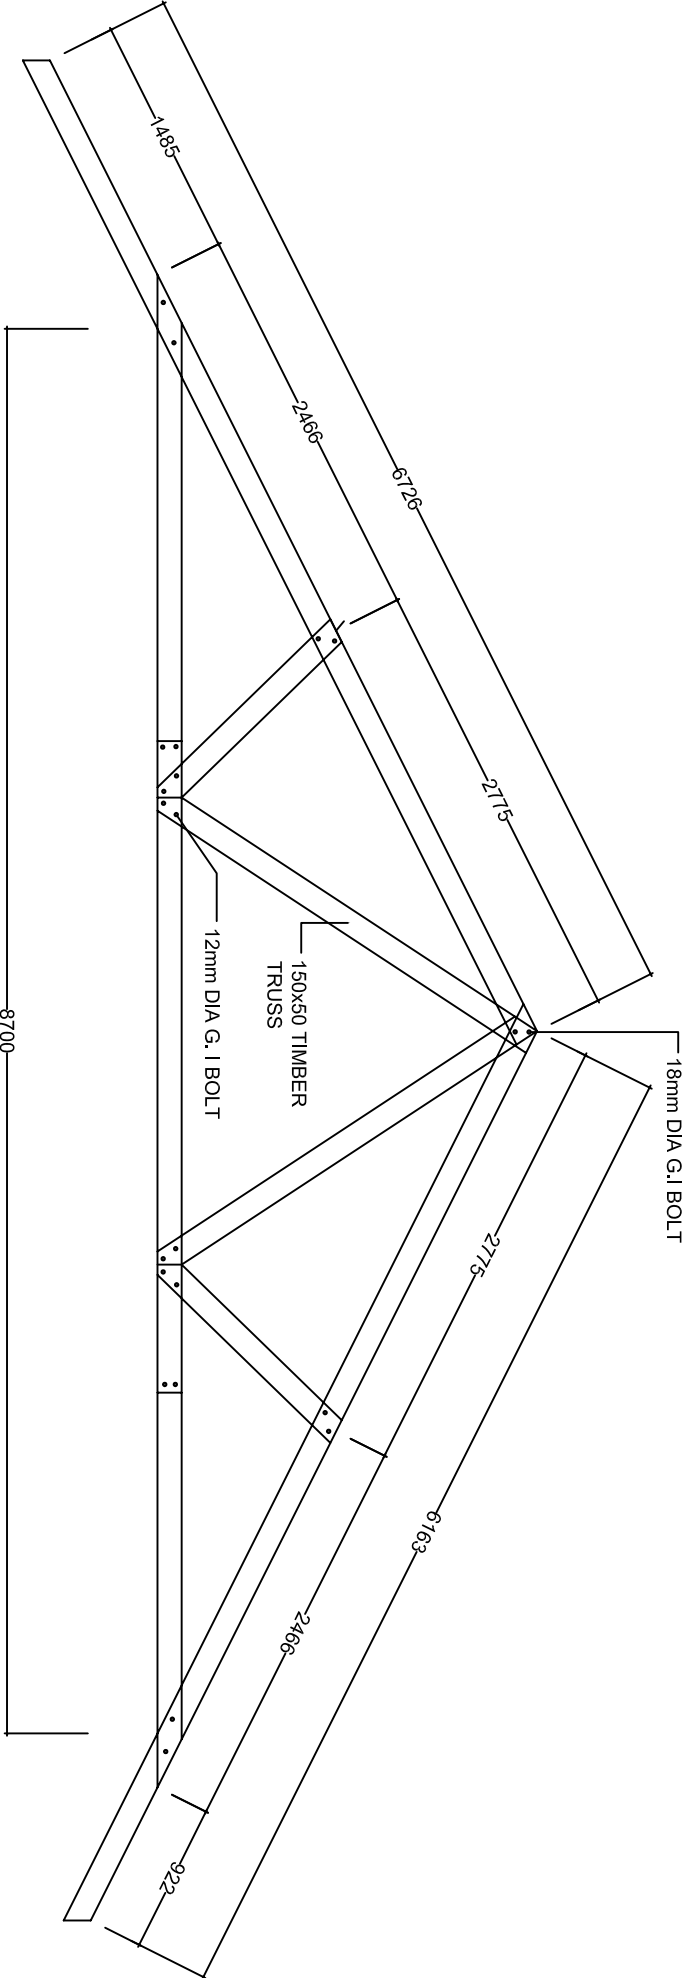

TRUSS DETAILS

SCALE 1 : 50

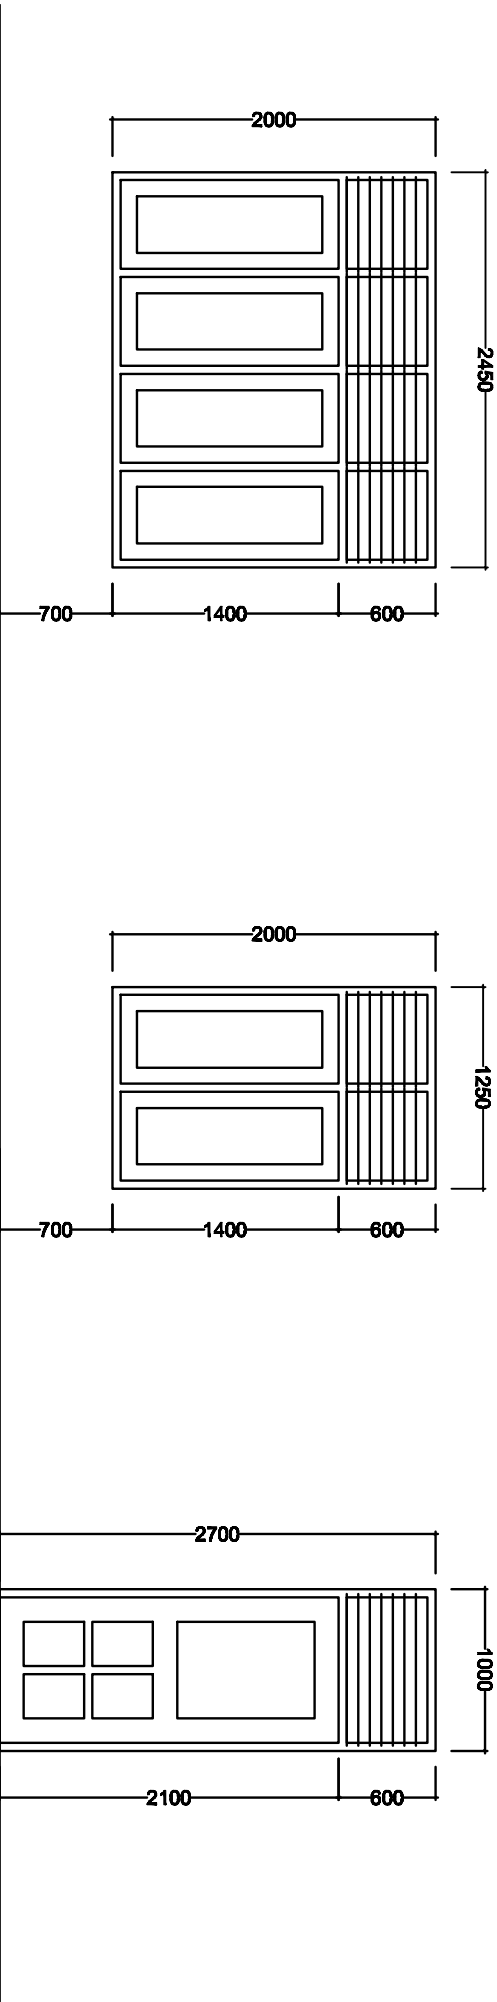

DOOR WINDOW SCHEDULE

SCALE 1 : 50