


- KEY
- G - GLASS
 - T - TIMBER
 - G - GLASS
 - FAL - FIXED ALUMINUM LOUVERS
 - FG - FIXED GLASS

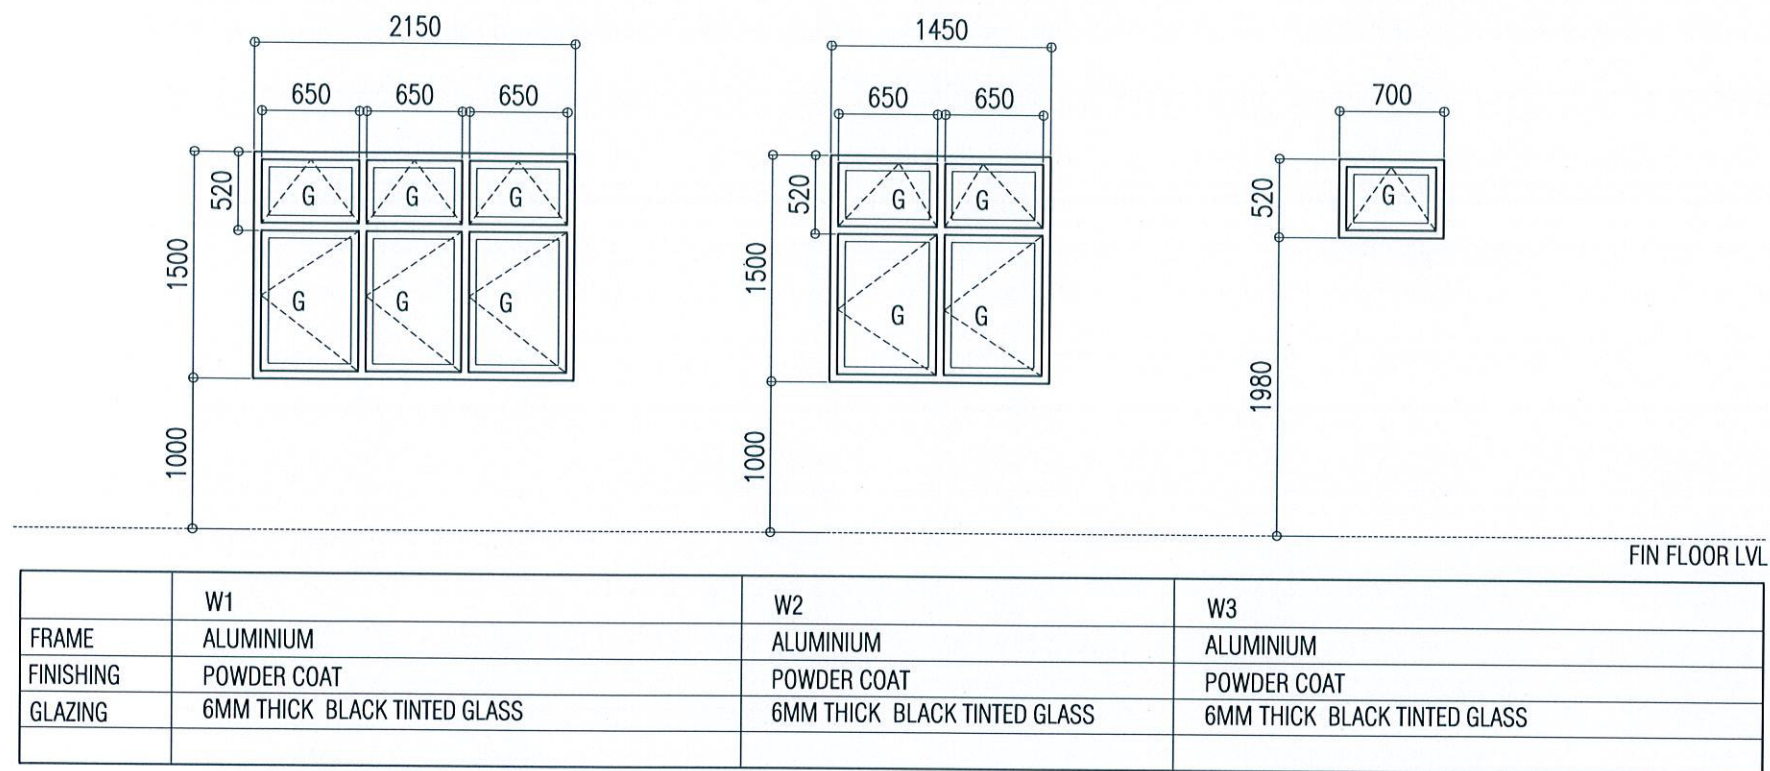

DOOR AND WINDOW DETAILS

SCALE - 1:50


GROUND FLOOR	AIR CONDITIONED AREA
FIRST FLOOR	AIR CONDITIONED AREA
ALL TOILETS	MECHANICALLY VENTILATED

10 % VENTILATION SCHEDULE




REVISIONS:		
PROJECT TITLE:		
DHA. ATOLL COUNCIL		
CLIENT :		
LGA		
ARCH. DESIGN:	SHAMIN	PROJECT NO
STRUC. DESIGN:	ASHRAF	DHC-11/15
DATE :	MAY 2015	DRAWING NO
SCALE:	AS GIVEN	A9
ALAAF		
ALAAF PRIVATE LIMITED THARUWAKKE(GROUND FLOOR)SABUDHERIYA MAGUJALE 20004, TEL: (960)7773601, E-MAIL: alaaftvt@gmail.com, Web		

COPYRIGHT: THE CONCEPT AND DESIGN IN THIS DRAWING ARE THE PROPERTIES OF ALAAF PVT. LTD. THIS DRAWING SHOULD BE USED ONLY FOR THE PROJECT MENTIONED ON THIS SHEET.

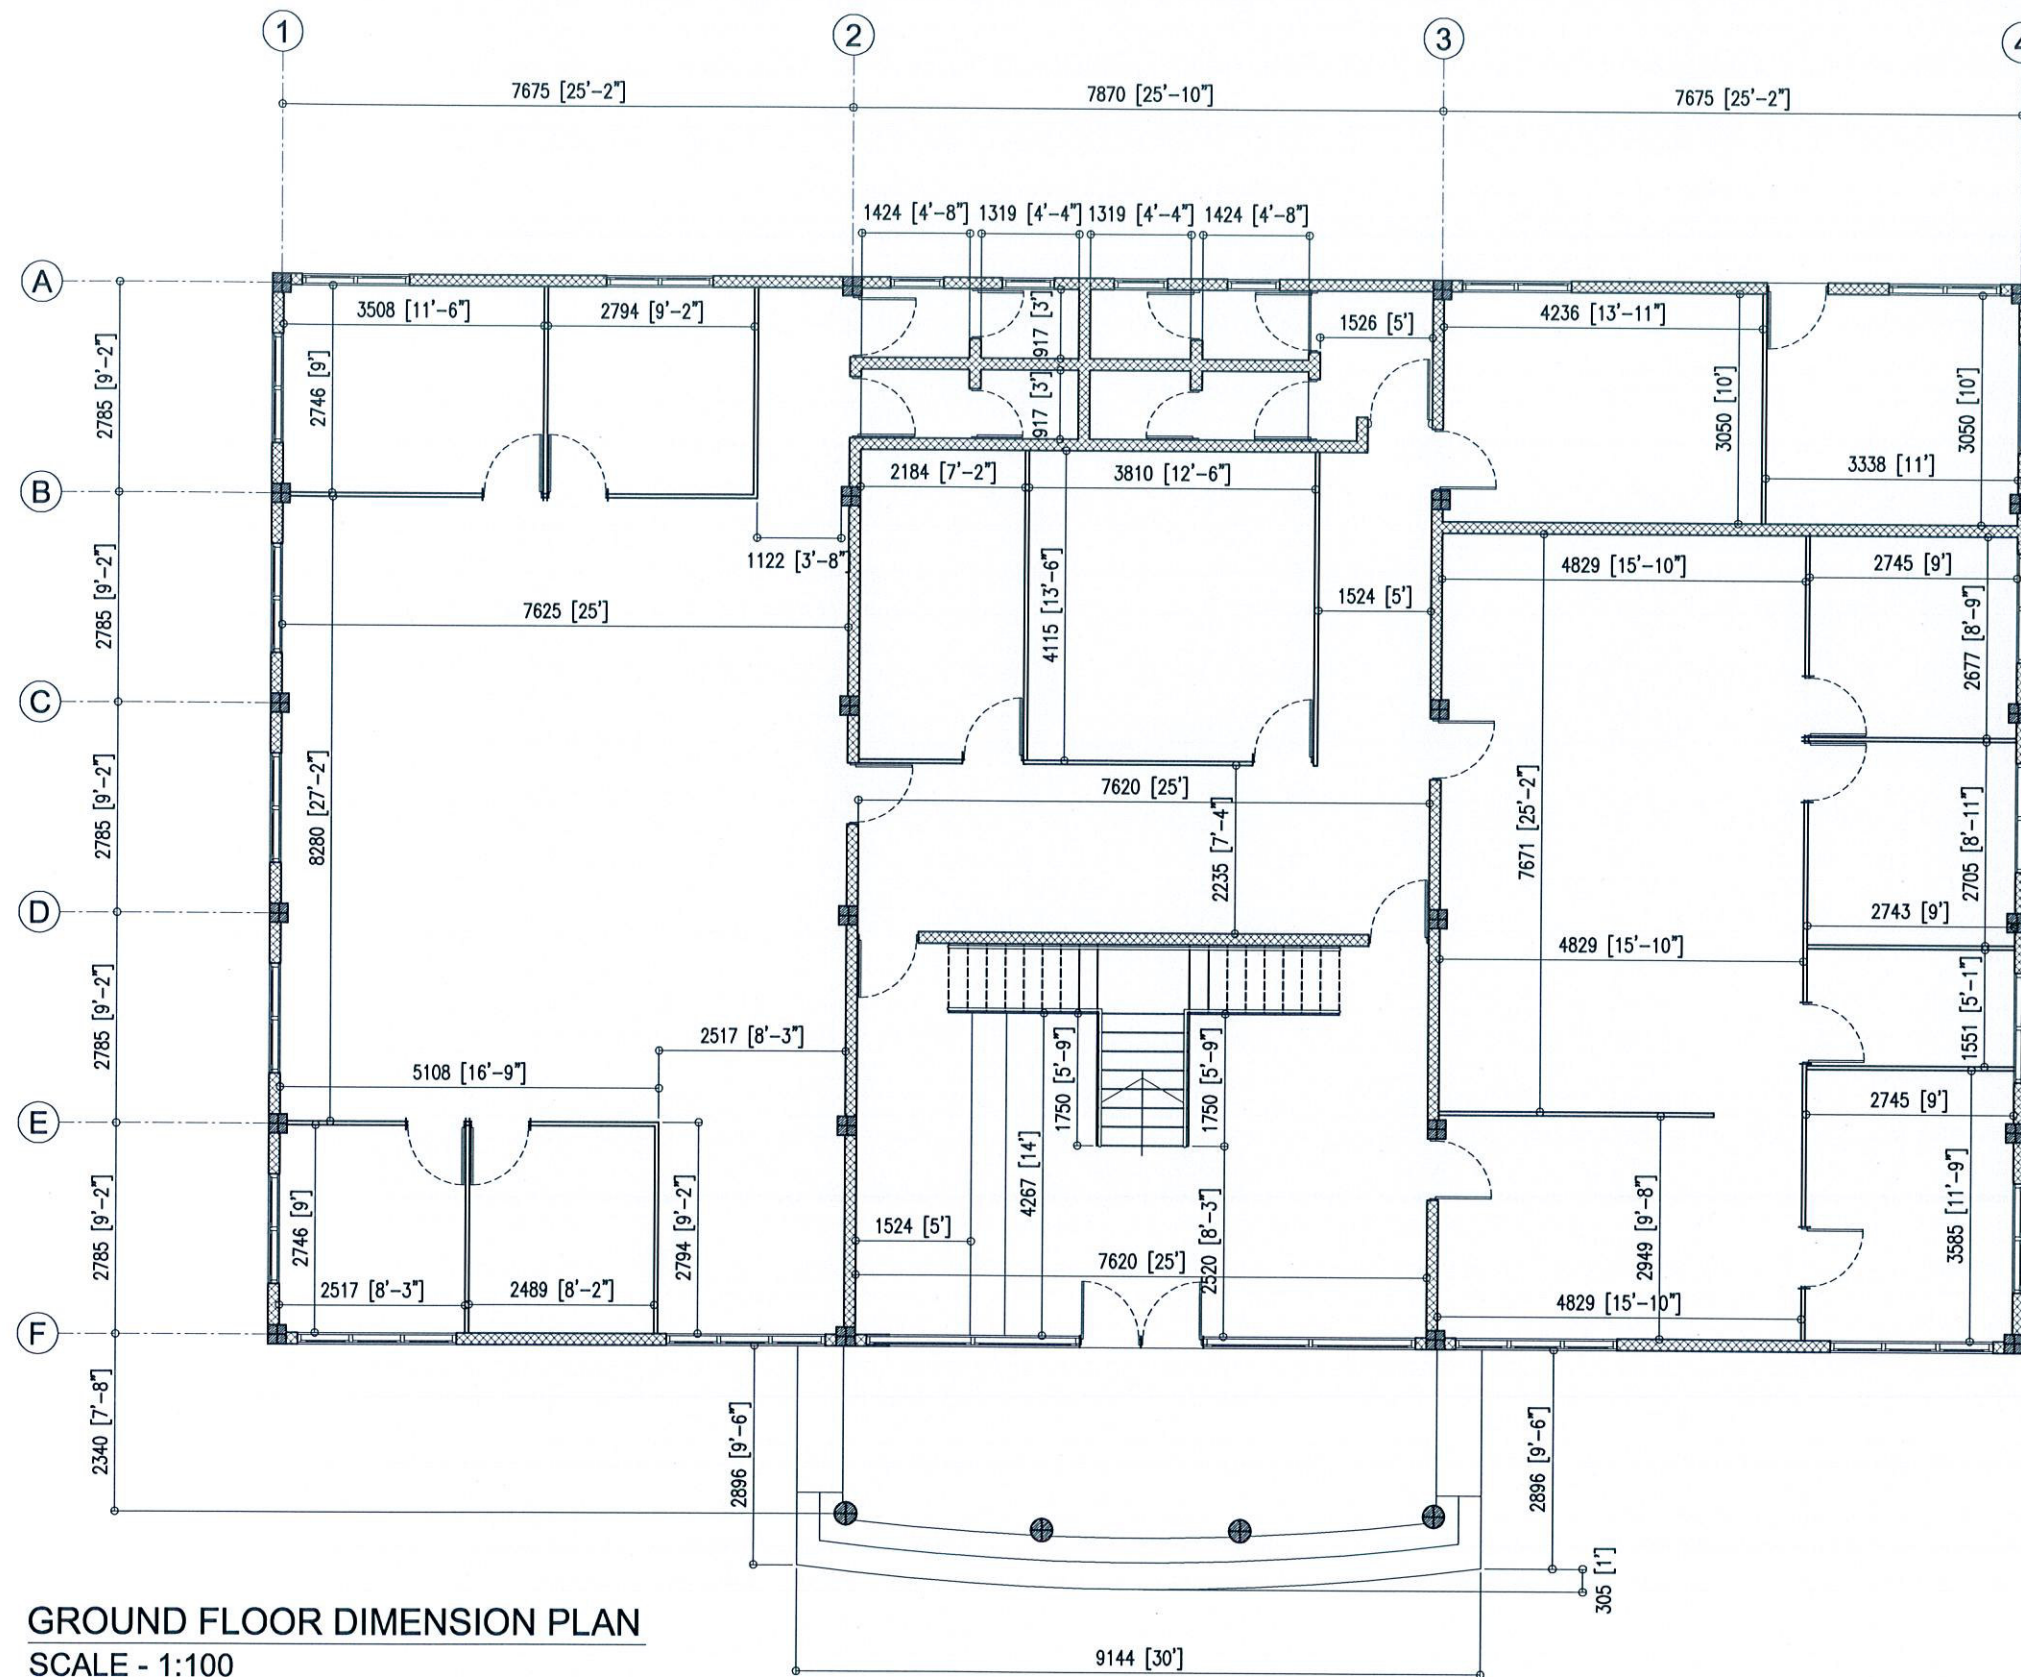


GROUND FLOOR DIMENSION PLAN
SCALE - 1:100

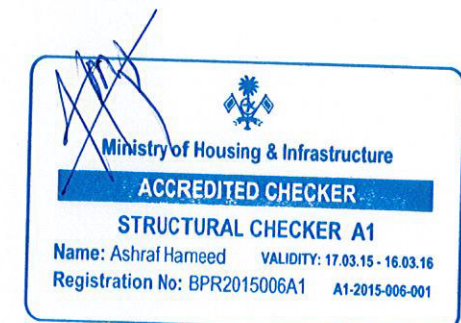

REVISIONS:		
PROJECT TITLE:		
DHA. ATOLL COUNCIL		
CLIENT:		
LGA		
ARCH. DESIGN:	SHAMIN	PROJECT NO
STRUC. DESIGN:	ASHRAF	DHC-11/15
DATE:	MAY 2015	DRAWING NO
SCALE:	AS GIVEN	A10
ALAAF		
ALAAF PRIVATE LIMITED		
THARUENICE(GROUND FLOOR)SABUDHERIYA MAGUJALE 20004,		
TEL: (960)7773801, E-MAIL: alaaftv@gmail.com, Web		

COPYRIGHT: THE CONCEPT AND DESIGN IN THIS DRAWING ARE THE PROPERTIES OF ALAAF PVT LTD. THIS DRAWING SHOULD BE USED ONLY FOR THE PROJECT MENTIONED ON THIS SHEET.

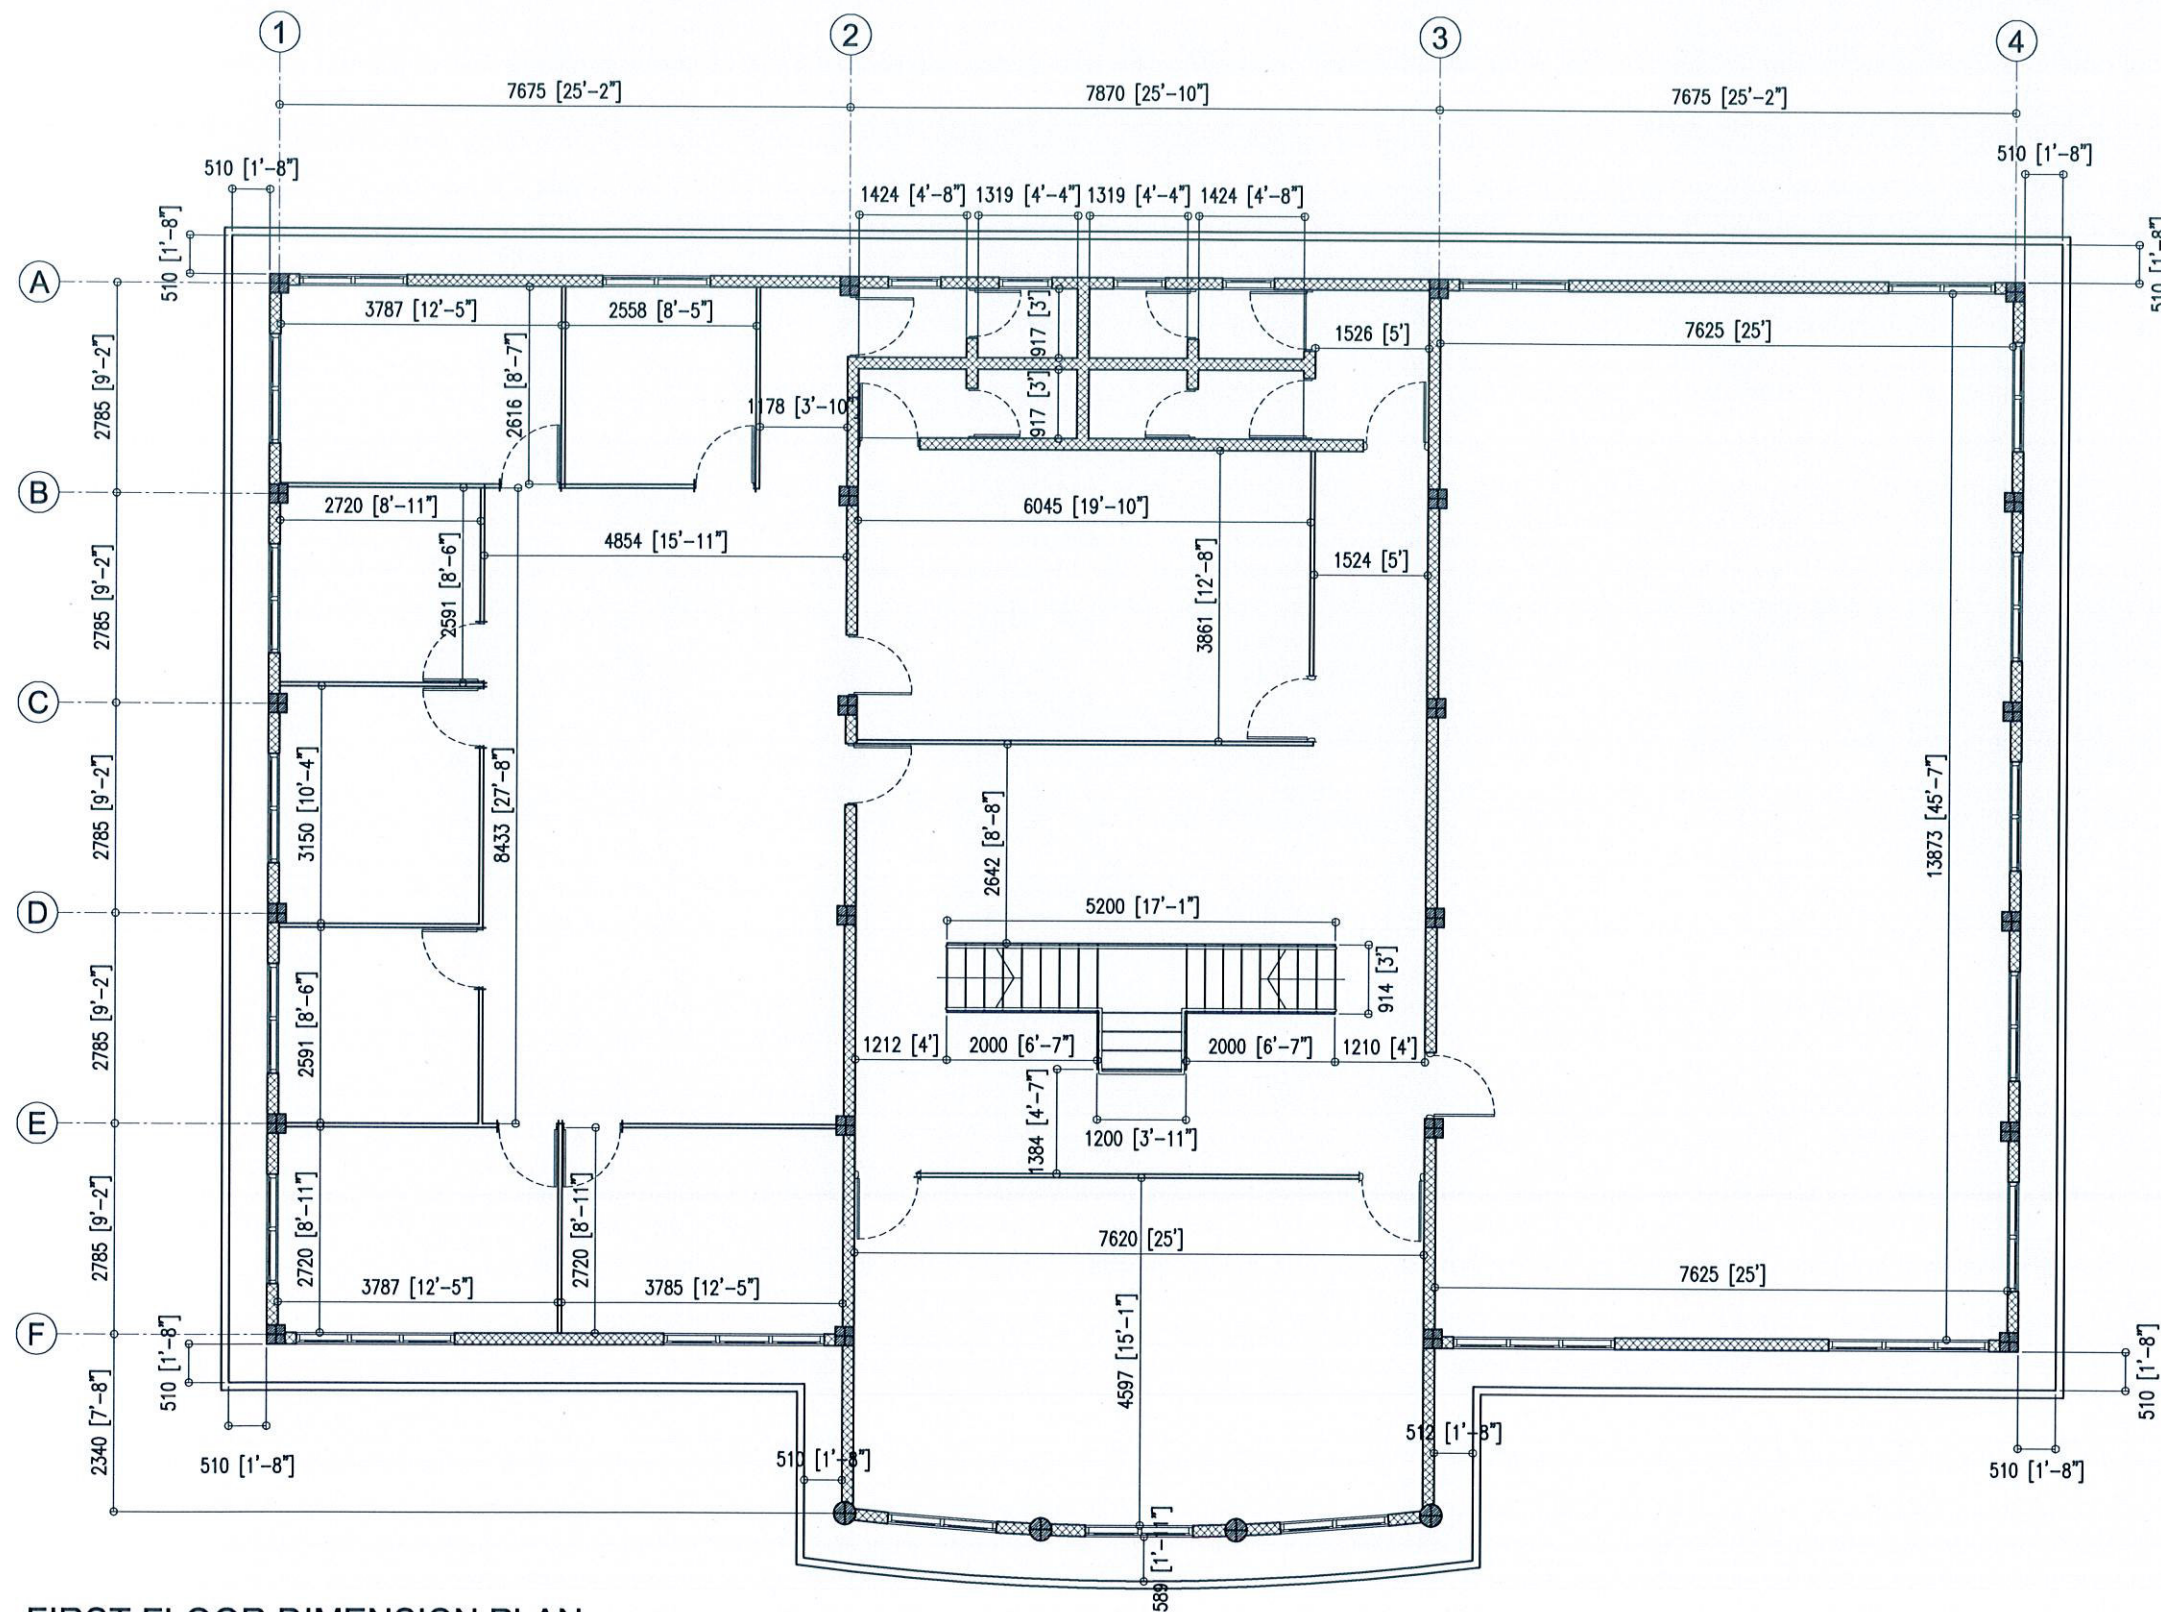

FIRST FLOOR DIMENSION PLAN
SCALE - 1:100

Ministry of Housing & Infrastructure
ACCREDITED CHECKER
STRUCTURAL CHECKER A1
Name: Ashraf Hameed VALIDITY: 17.03.15 - 16.03.16
Registration No: BPR2015006A1 A1-2015-006-001

REVISIONS:		
PROJECT TITLE:		
DHA. ATOLL COUNCIL		
CLIENT :		
LGA		
ARCH. DESIGN:	SHAMIN	PROJECT NO
STRUC. DESIGN:	ASHRAF	DHC-11/15
DATE :	MAY 2015	DRAWING NO
SCALE:	AS GIVEN	A11
ALAAF ALAAF PRIVATE LIMITED THARUVEHOE (GROUND FLOOR) BUDHERYA MAGUWALE 20004, TEL: (960) 7773801, E-MAIL: alAAF.pvt@gmail.com, Web		


COPYRIGHT: THE CONCEPT AND DESIGN IN THIS DRAWING ARE THE PROPERTIES OF ALAAF PVT. LTD. THIS DRAWING SHOULD BE USED ONLY FOR THE PROJECT MENTIONED ON THIS SHEET.



REVISIONS:

CLIENT : LGA

ARCH. DESIGN:	SHAMIN	PROJECT NO DHC-11/15 DRAWING NO S1
STRUC. DESIGN:	ASHRAF	
DATE :	MAY 2015	
SCALE:	AS GIVEN	

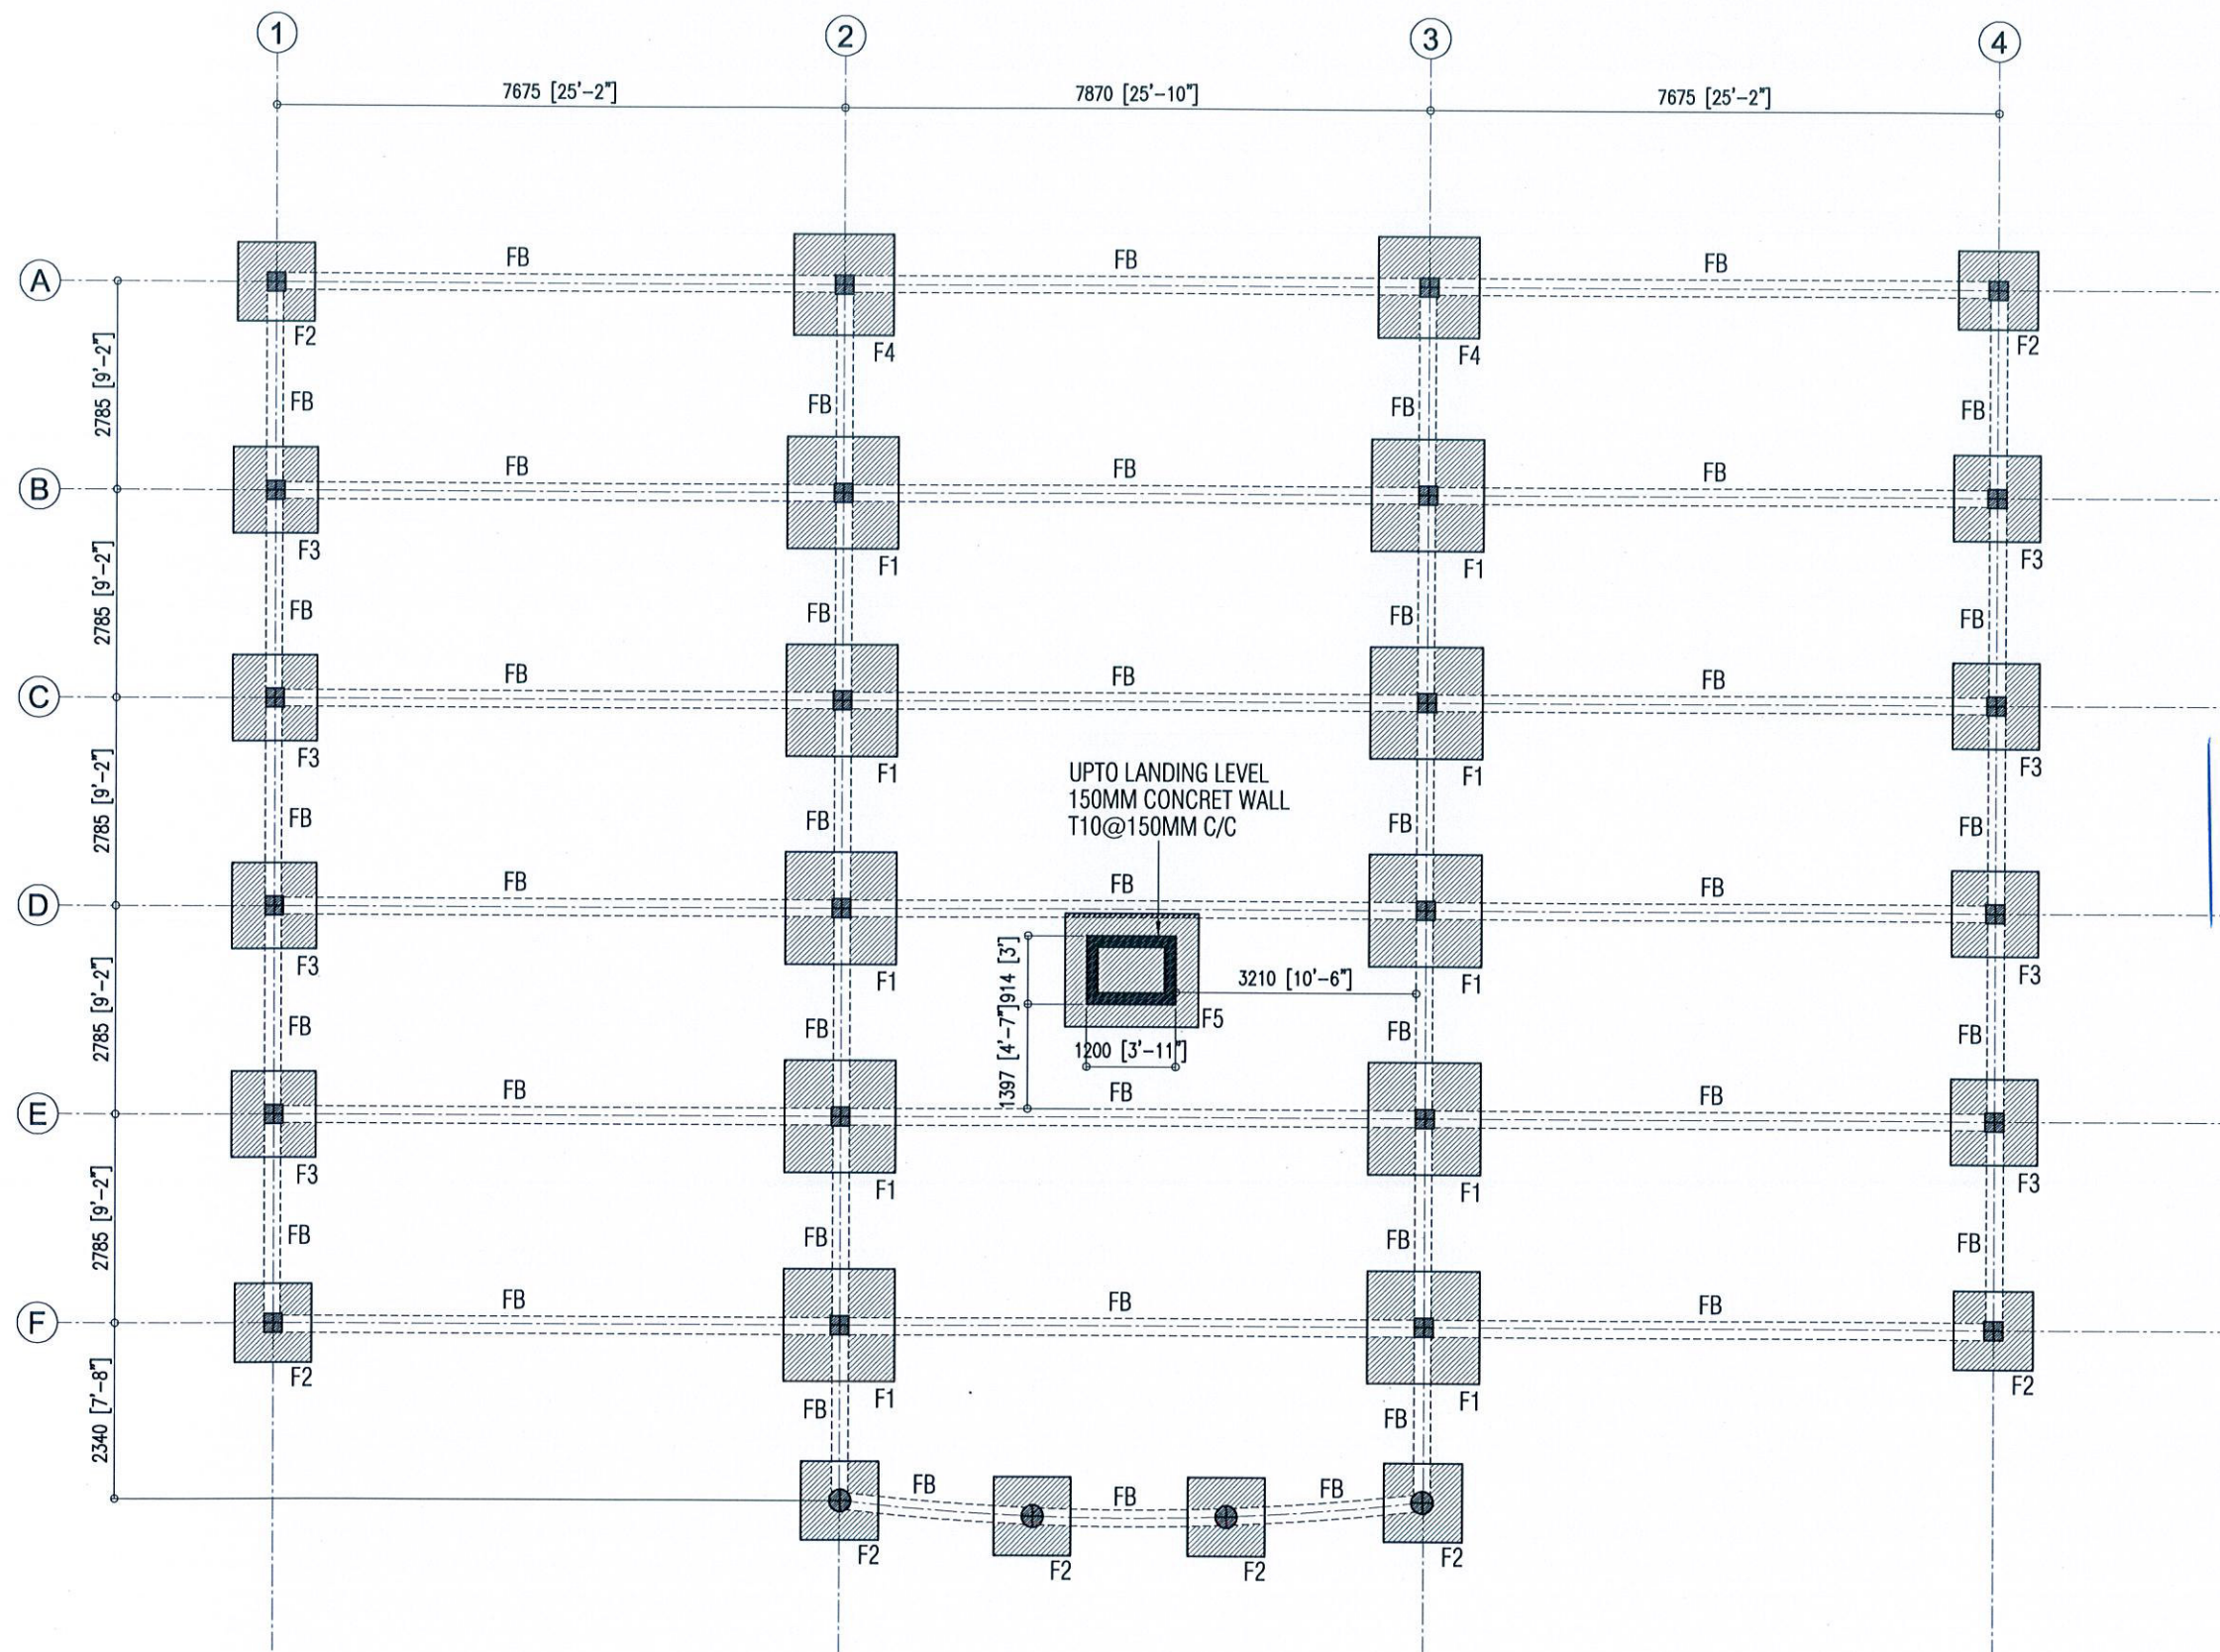


Ministry of Housing & Infrastructure
ACCREDITED CHECKER
STRUCTURAL CHECKER A1
 Name: Ashraf Hameed VALIDITY: 17.03.15 - 16.03.16
 Registration No: BPR2015006A1 A1-2015-006-001

FOUNDATION PLAN
 SCALE - 1:100

REVISIONS:		
PROJECT TITLE:		
DHA. ATOLL COUNCIL		
CLIENT :		
LGA		
ARCH. DESIGN:	SHAMIN	PROJECT NO
STRUC. DESIGN:	ASHRAF	DHC-11/15
DATE:	MAY 2015	DRAWING NO
SCALE:	AS GIVEN	S2
ALAAF ALAAF PRIVATE LIMITED THARUWAGE(GROUND FLOOR)SABUHERIYA MAGUMALE'20004, TEL: (960)7773801, E-MAIL: alaaaf.pvt@gmail.com, Web		

COPYRIGHT: THE CONCEPT AND DESIGN IN THIS DRAWING ARE THE PROPERTIES OF ALAAF PVT. LTD. THIS DRAWING SHOULD BE USED ONLY FOR THE PROJECT MENTIONED ON THIS SHEET.

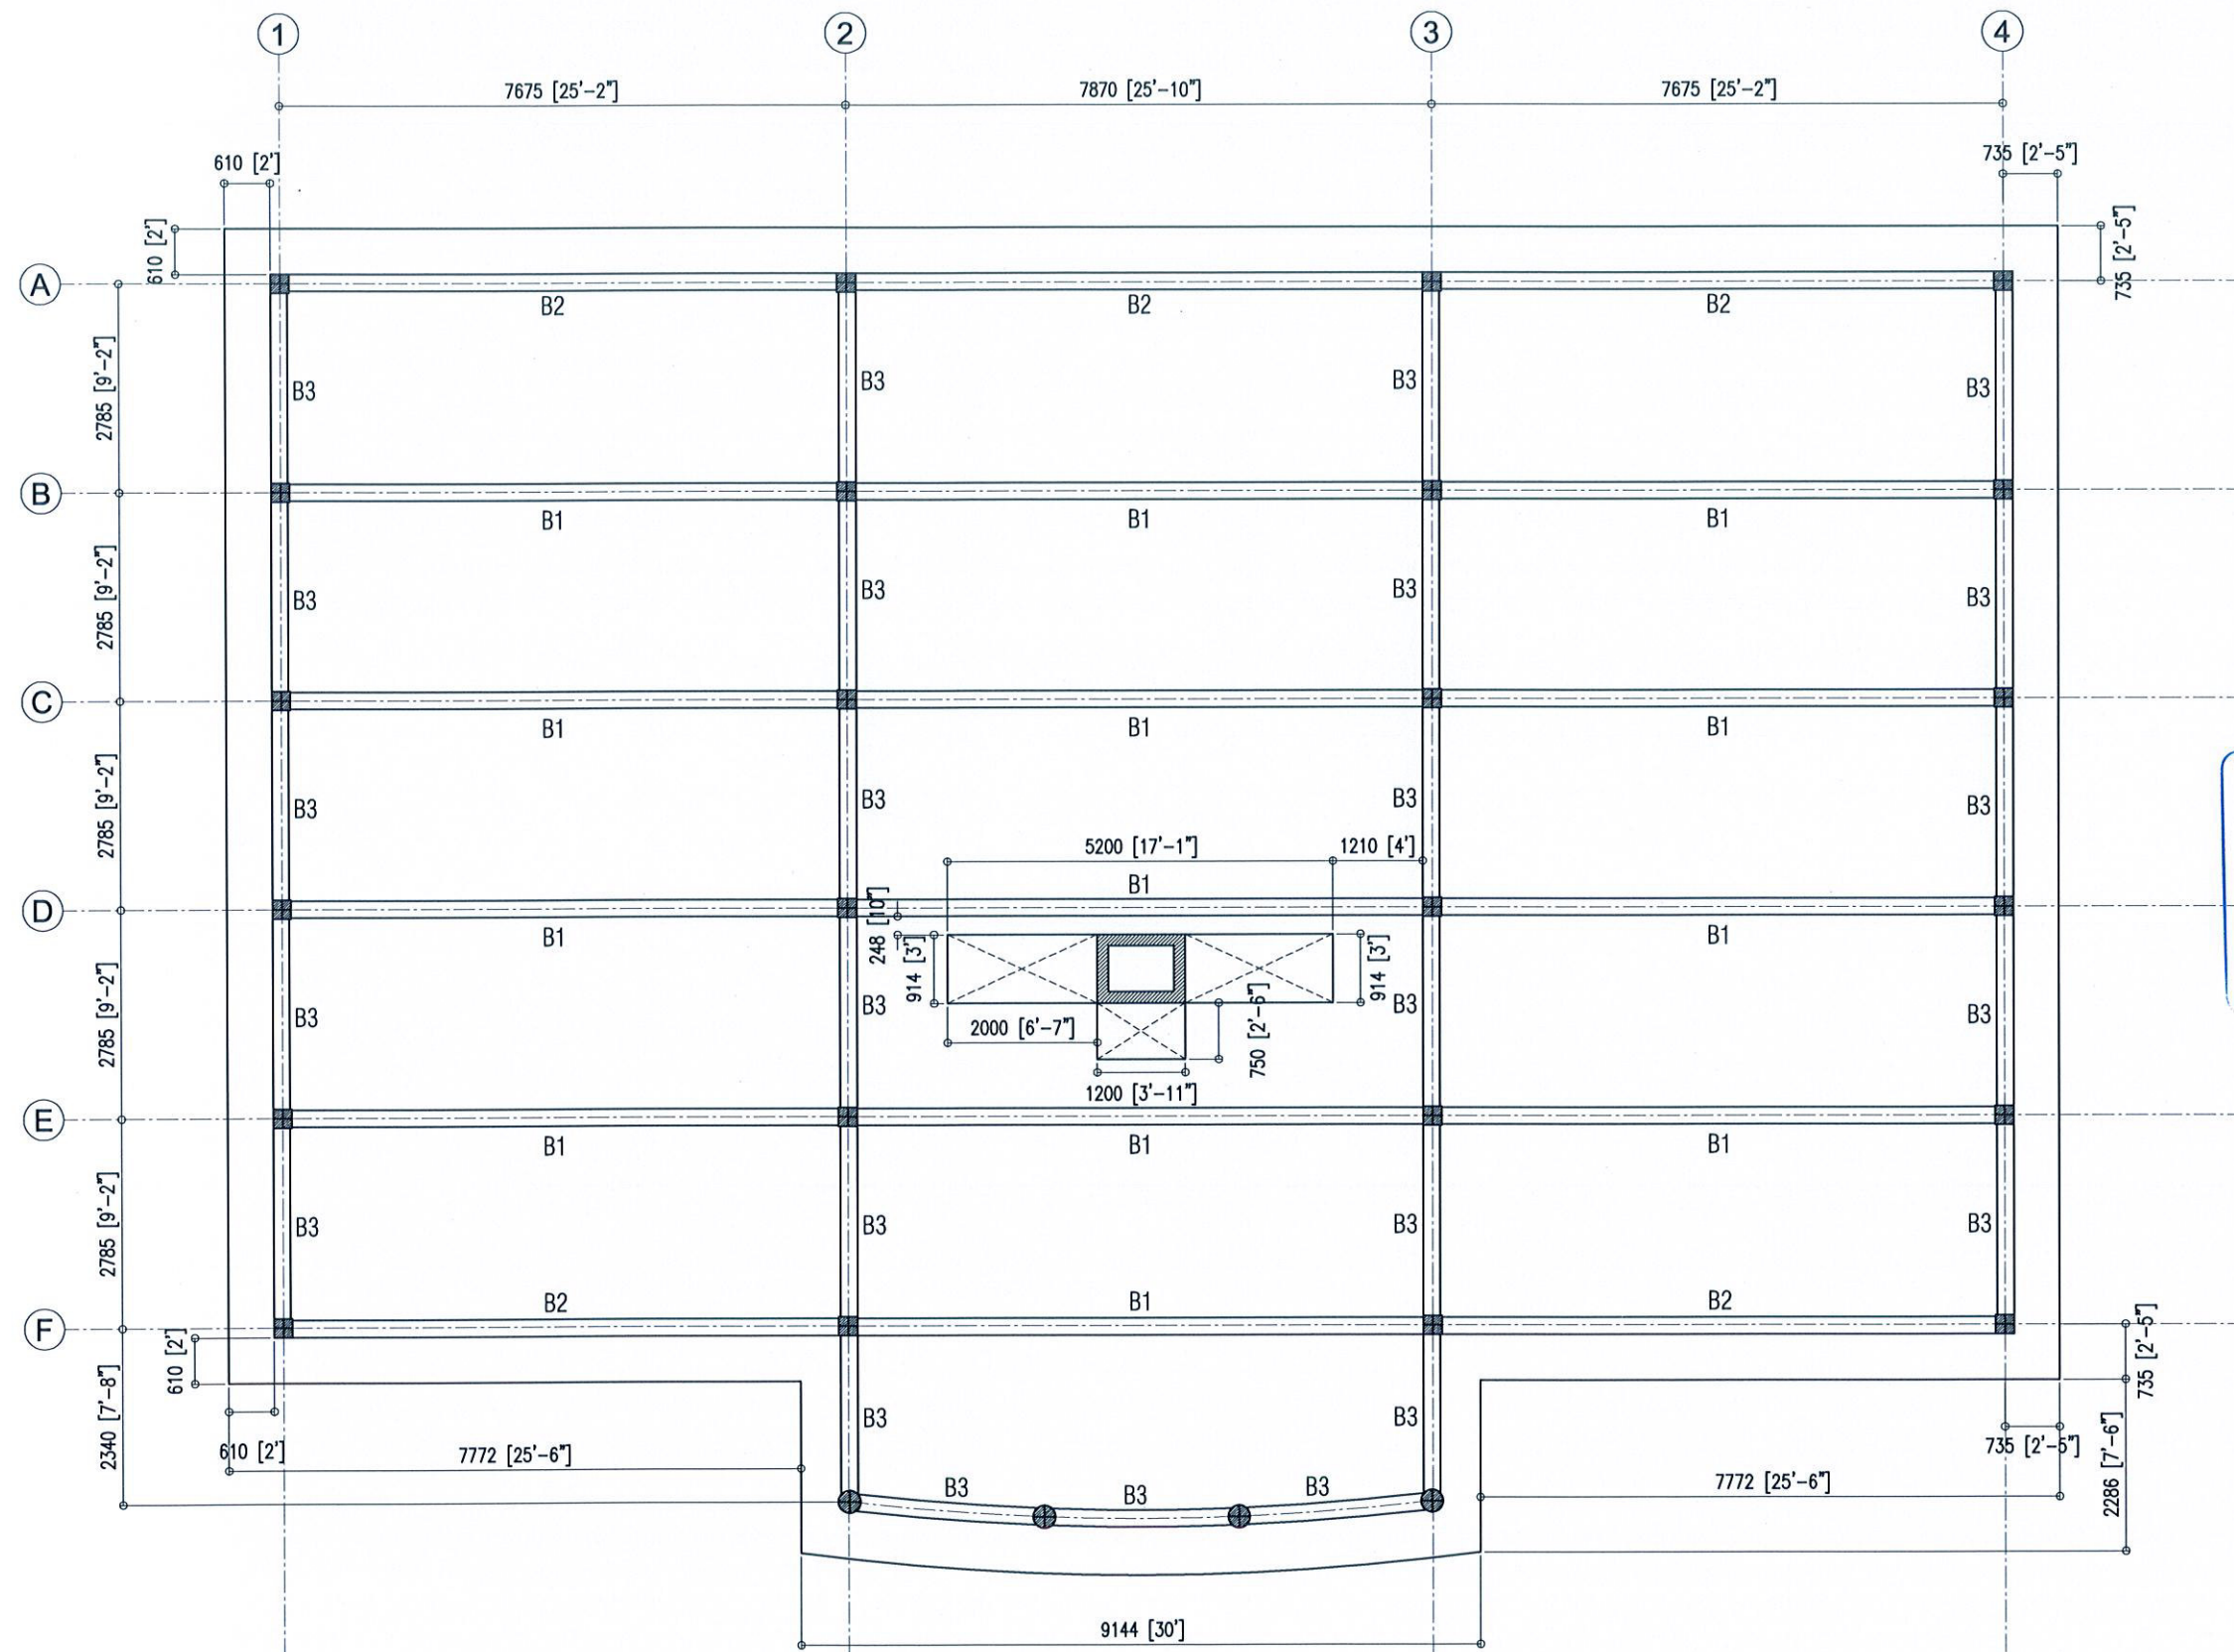


1ST FLOOR BEAM PLAN
SCALE - 1:100



REVISIONS:		
PROJECT TITLE:		
DHA. ATOLL COUNCIL		
CLIENT:		
LGA		
ARCH. DESIGN:	SHAMIN	PROJECT NO
STRUC. DESIGN:	ASHRAF	DHC-11/15
DATE:	MAY 2015	DRAWING NO
SCALE:	AS GIVEN	S3
ALAAF ALAAF PRIVATE LIMITED THARUENHIGE (GROUND FLOOR) SABUDHERYA MAGUJALE 20004, TEL: (980) 7773601, E-MAIL: alaaftpvt@gmail.com, Web		

COPYRIGHT: THE CONCEPT AND DESIGN IN THIS DRAWING ARE THE PROPERTIES OF ALAAF PVT. LTD. THIS DRAWING SHOULD BE USED ONLY FOR THE PROJECT MENTIONED ON THIS SHEET.

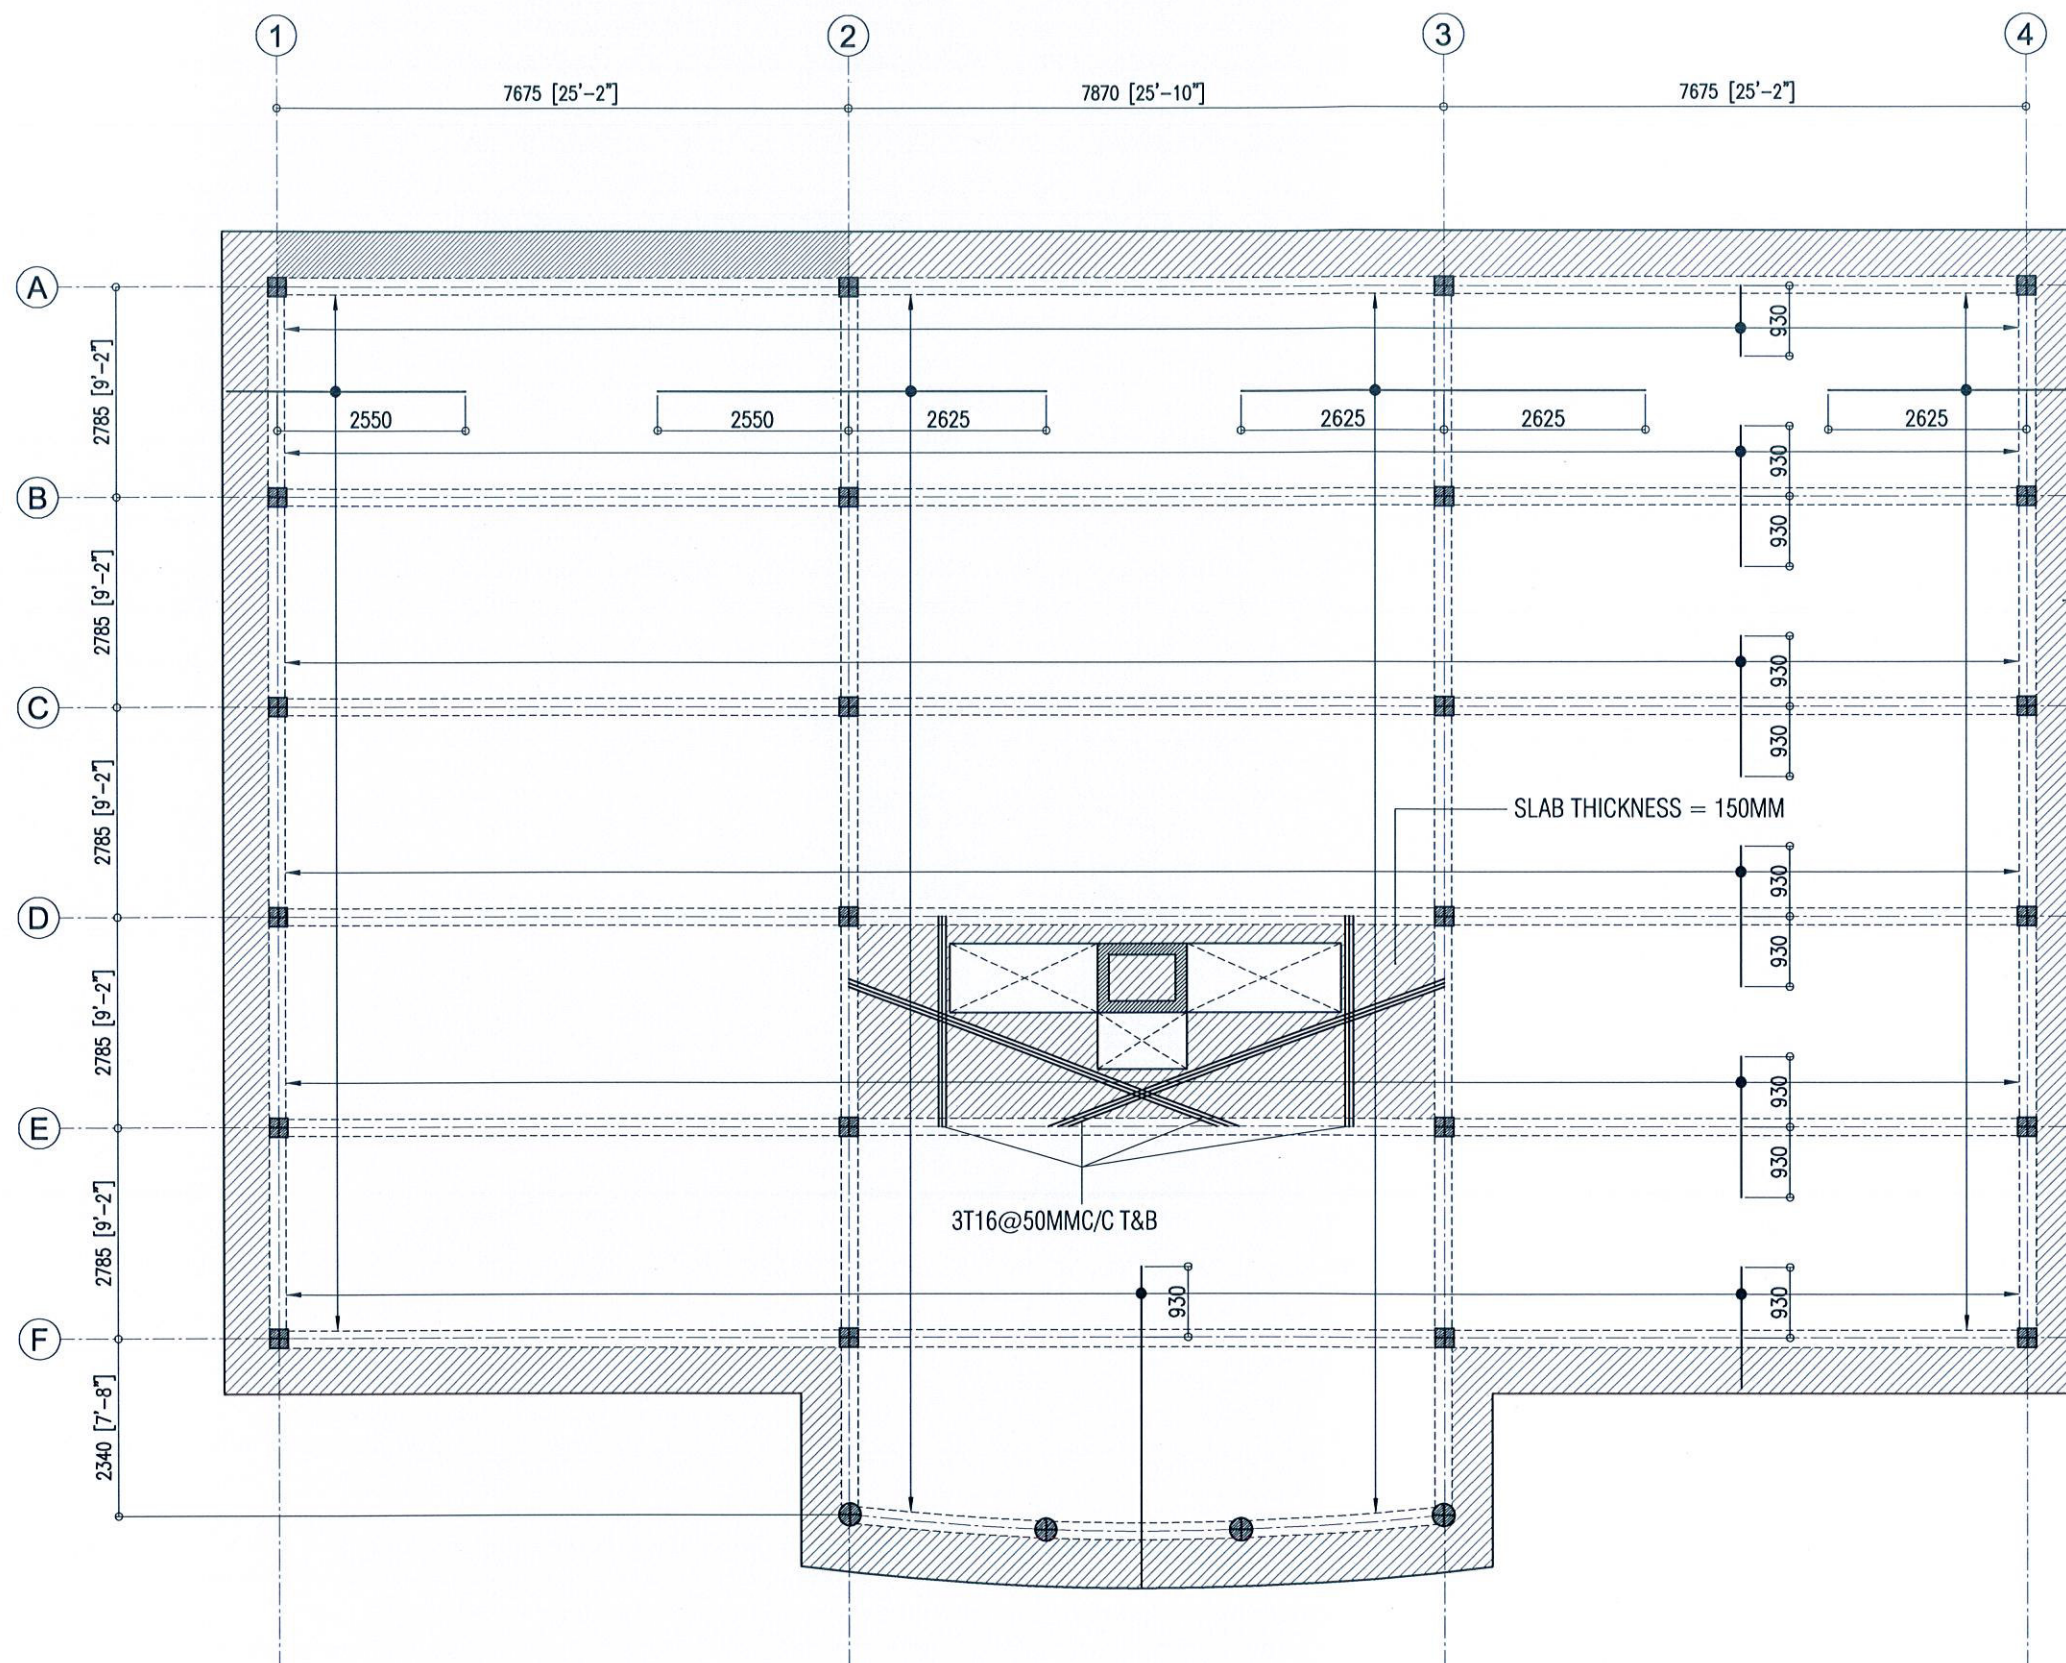

NOTE:-
 SLAB THICKNESS = 130MM
 TOP RFMNT = T10 @ 150 C/C BW (SHOWN)
 BOTTOM RFMNT = T10 @ 150 C/C BW (NOT SHOWN)
 DISTRIBUTION BARS = T10 @ 300 C/C BW (NOT SHOWN)
 REINFORCEMENT BARS WILL BE DISCONTINUOUS OVER VOIDS
 FOLLOW STANDARD REINFORCEMENT DETAILS FOR ALL OPENINGS
 ALL MAIN BARS SHAL HAVE BENDS UP OR DOWN EQUAL TO 12Ø FROM FACE OF SUPPORT


SLAB THICKNESS = 150MM



1ST FLOOR SLAB RFMT PLAN
 SCALE - 1:100

REVISIONS:		
PROJECT TITLE: DHA. ATOLL COUNCIL		
CLIENT: LGA		
ARCH. DESIGN:	SHAMIN	PROJECT NO DHC-11/15
STRUC. DESIGN:	ASHRAF	DRAWING NO S4
DATE:	MAY 2015	
SCALE:	AS GIVEN	
 ALAAF PRIVATE LIMITED THARUHOE (GROUND FLR) SABUDHEERIYA MAGU, MALE' 20004, TEL: (960) 7773801, E-MAIL: alaaf.pvt@gmail.com, Web		

COPYRIGHT: THE CONCEPT AND DESIGN IN THIS DRAWING ARE THE PROPERTIES OF ALAAF PVT. LTD. THIS DRAWING SHOULD BE USED ONLY FOR THE PROJECT MENTIONED ON THIS SHEET.

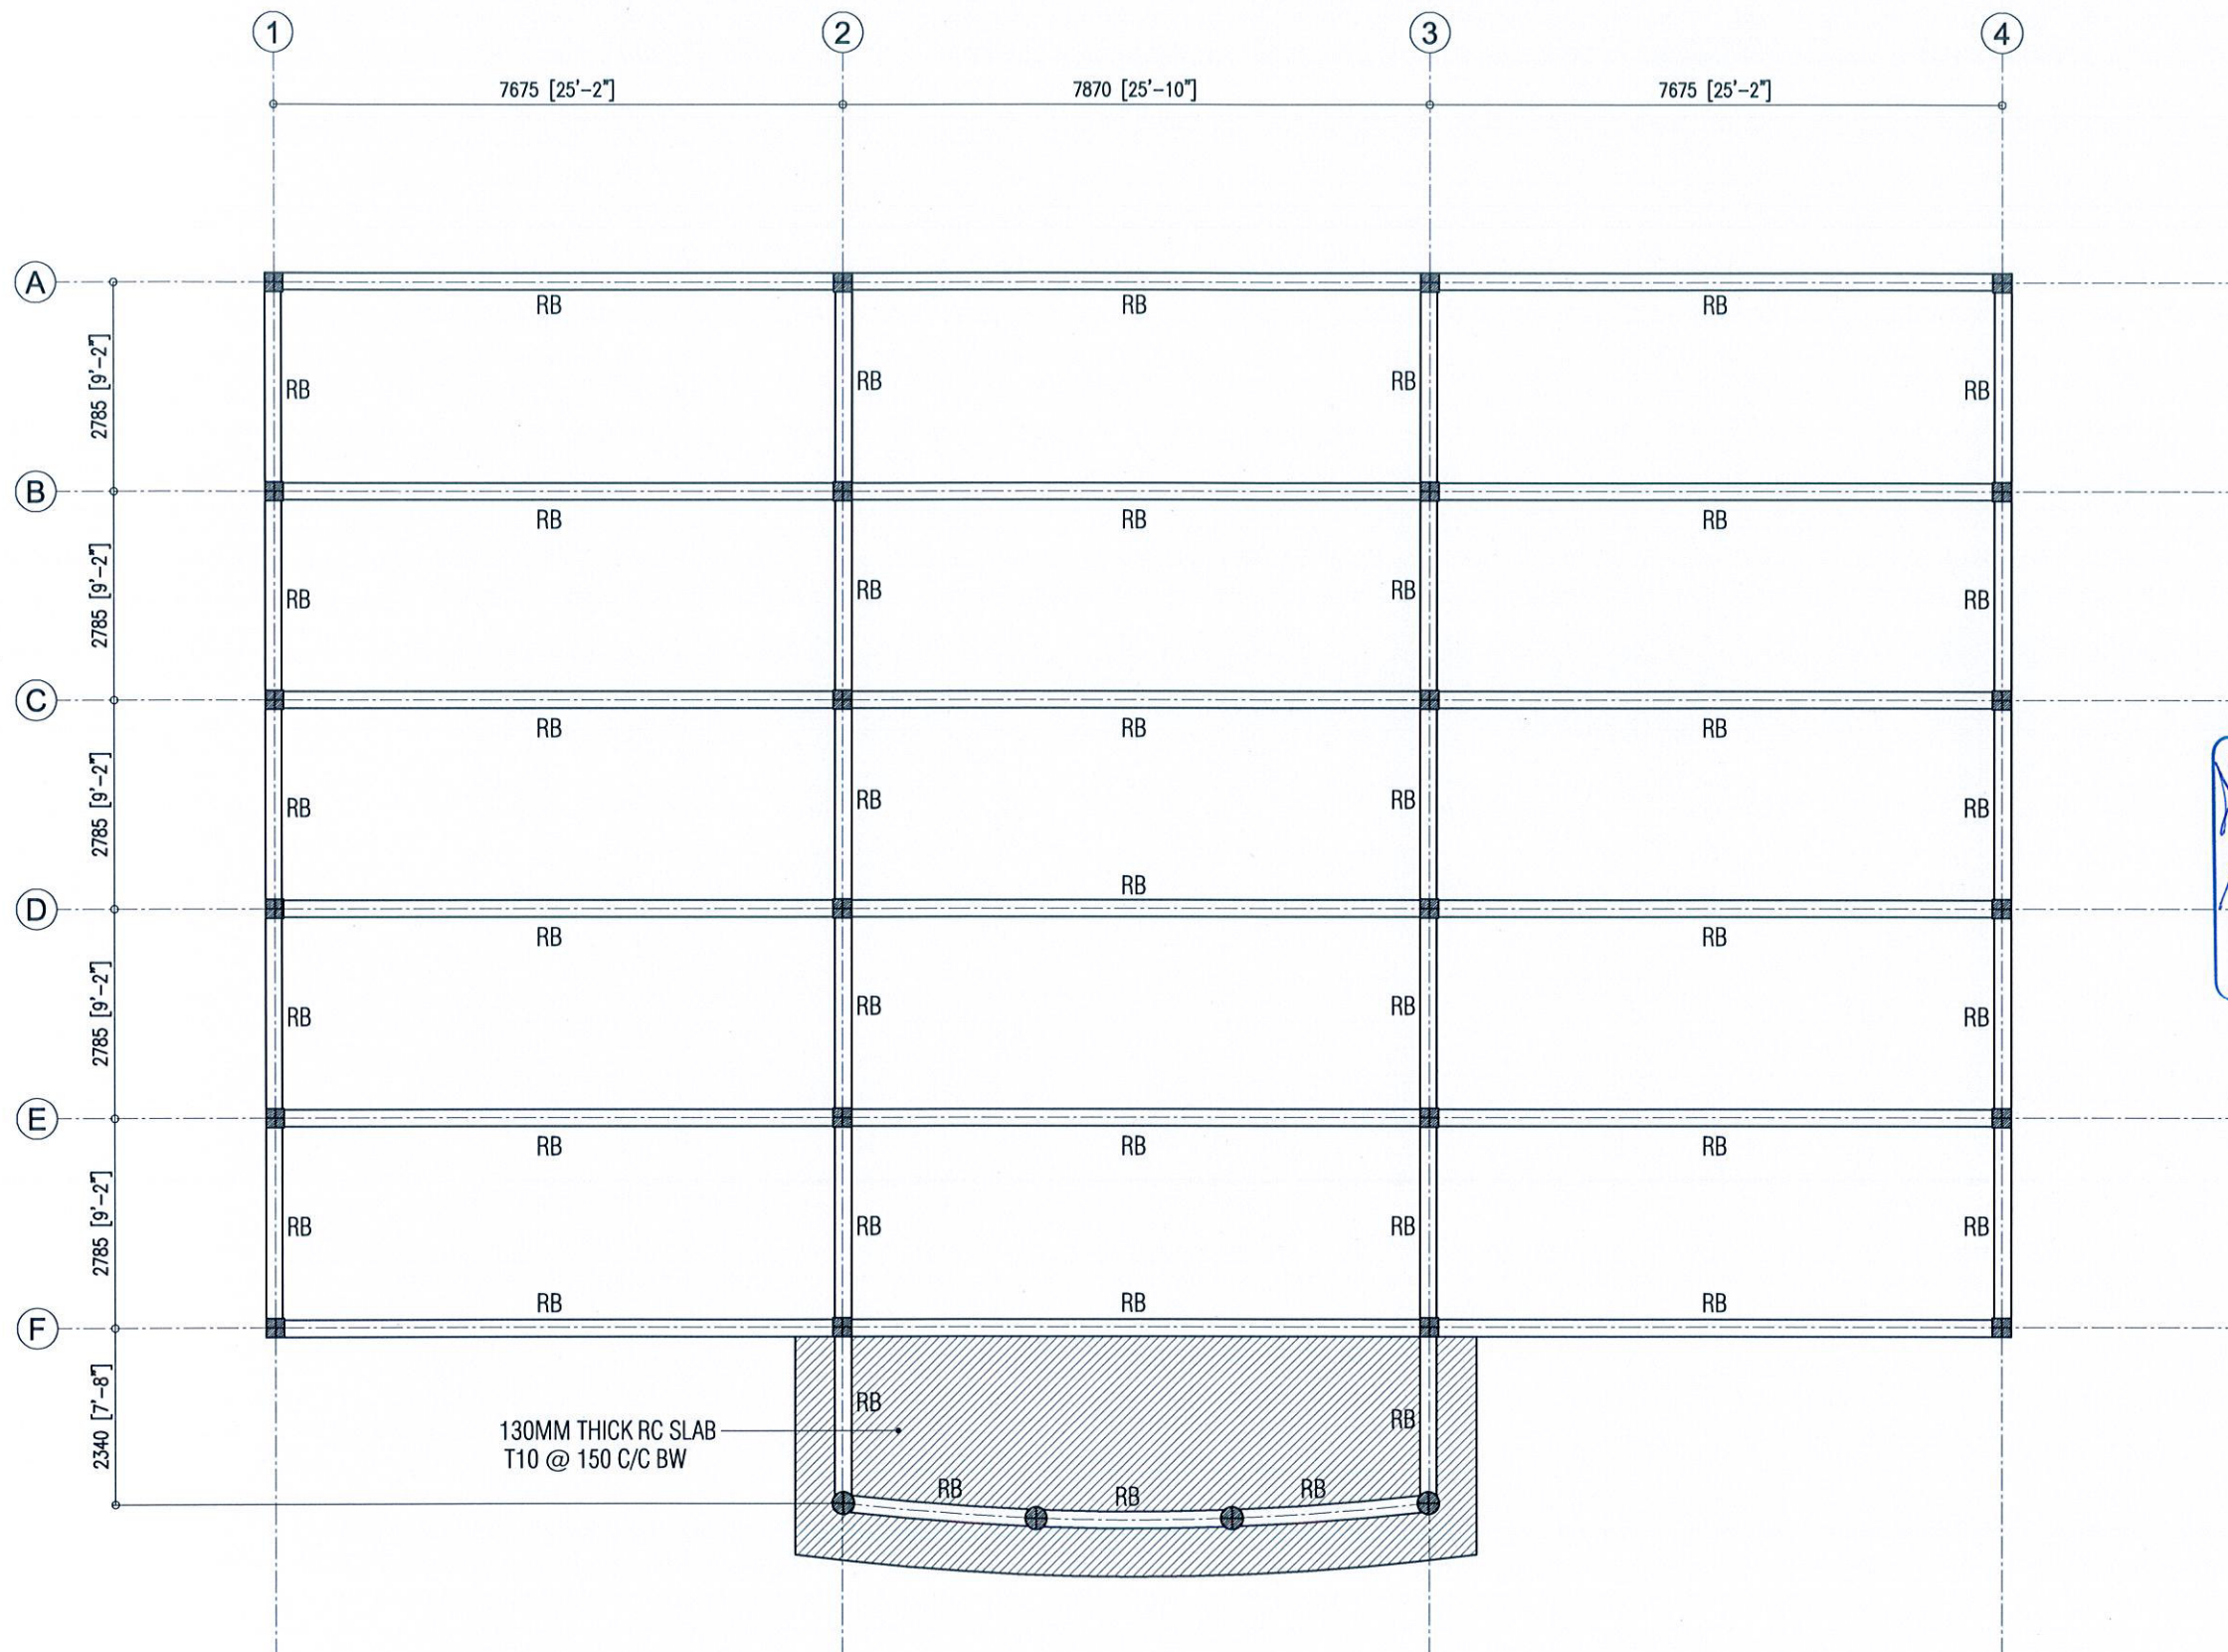

ROOF BEAM PLAN
SCALE - 1:100



REVISIONS:


PROJECT TITLE:
DHA. ATOLL COUNCIL

CLIENT:
LGA

ARCH. DESIGN:	SHAMIN	PROJECT NO
STRUC. DESIGN:	ASHRAF	DHC-11/15
DATE:	MAY 2015	DRAWING NO
SCALE:	AS GIVEN	S5



COPYRIGHT: THE CONCEPT AND DESIGN IN THIS DRAWING ARE THE PROPERTIES OF ALAAF PVT LTD. THIS DRAWING SHOULD BE USED ONLY FOR THE PROJECT MENTIONED ON THIS SHEET.

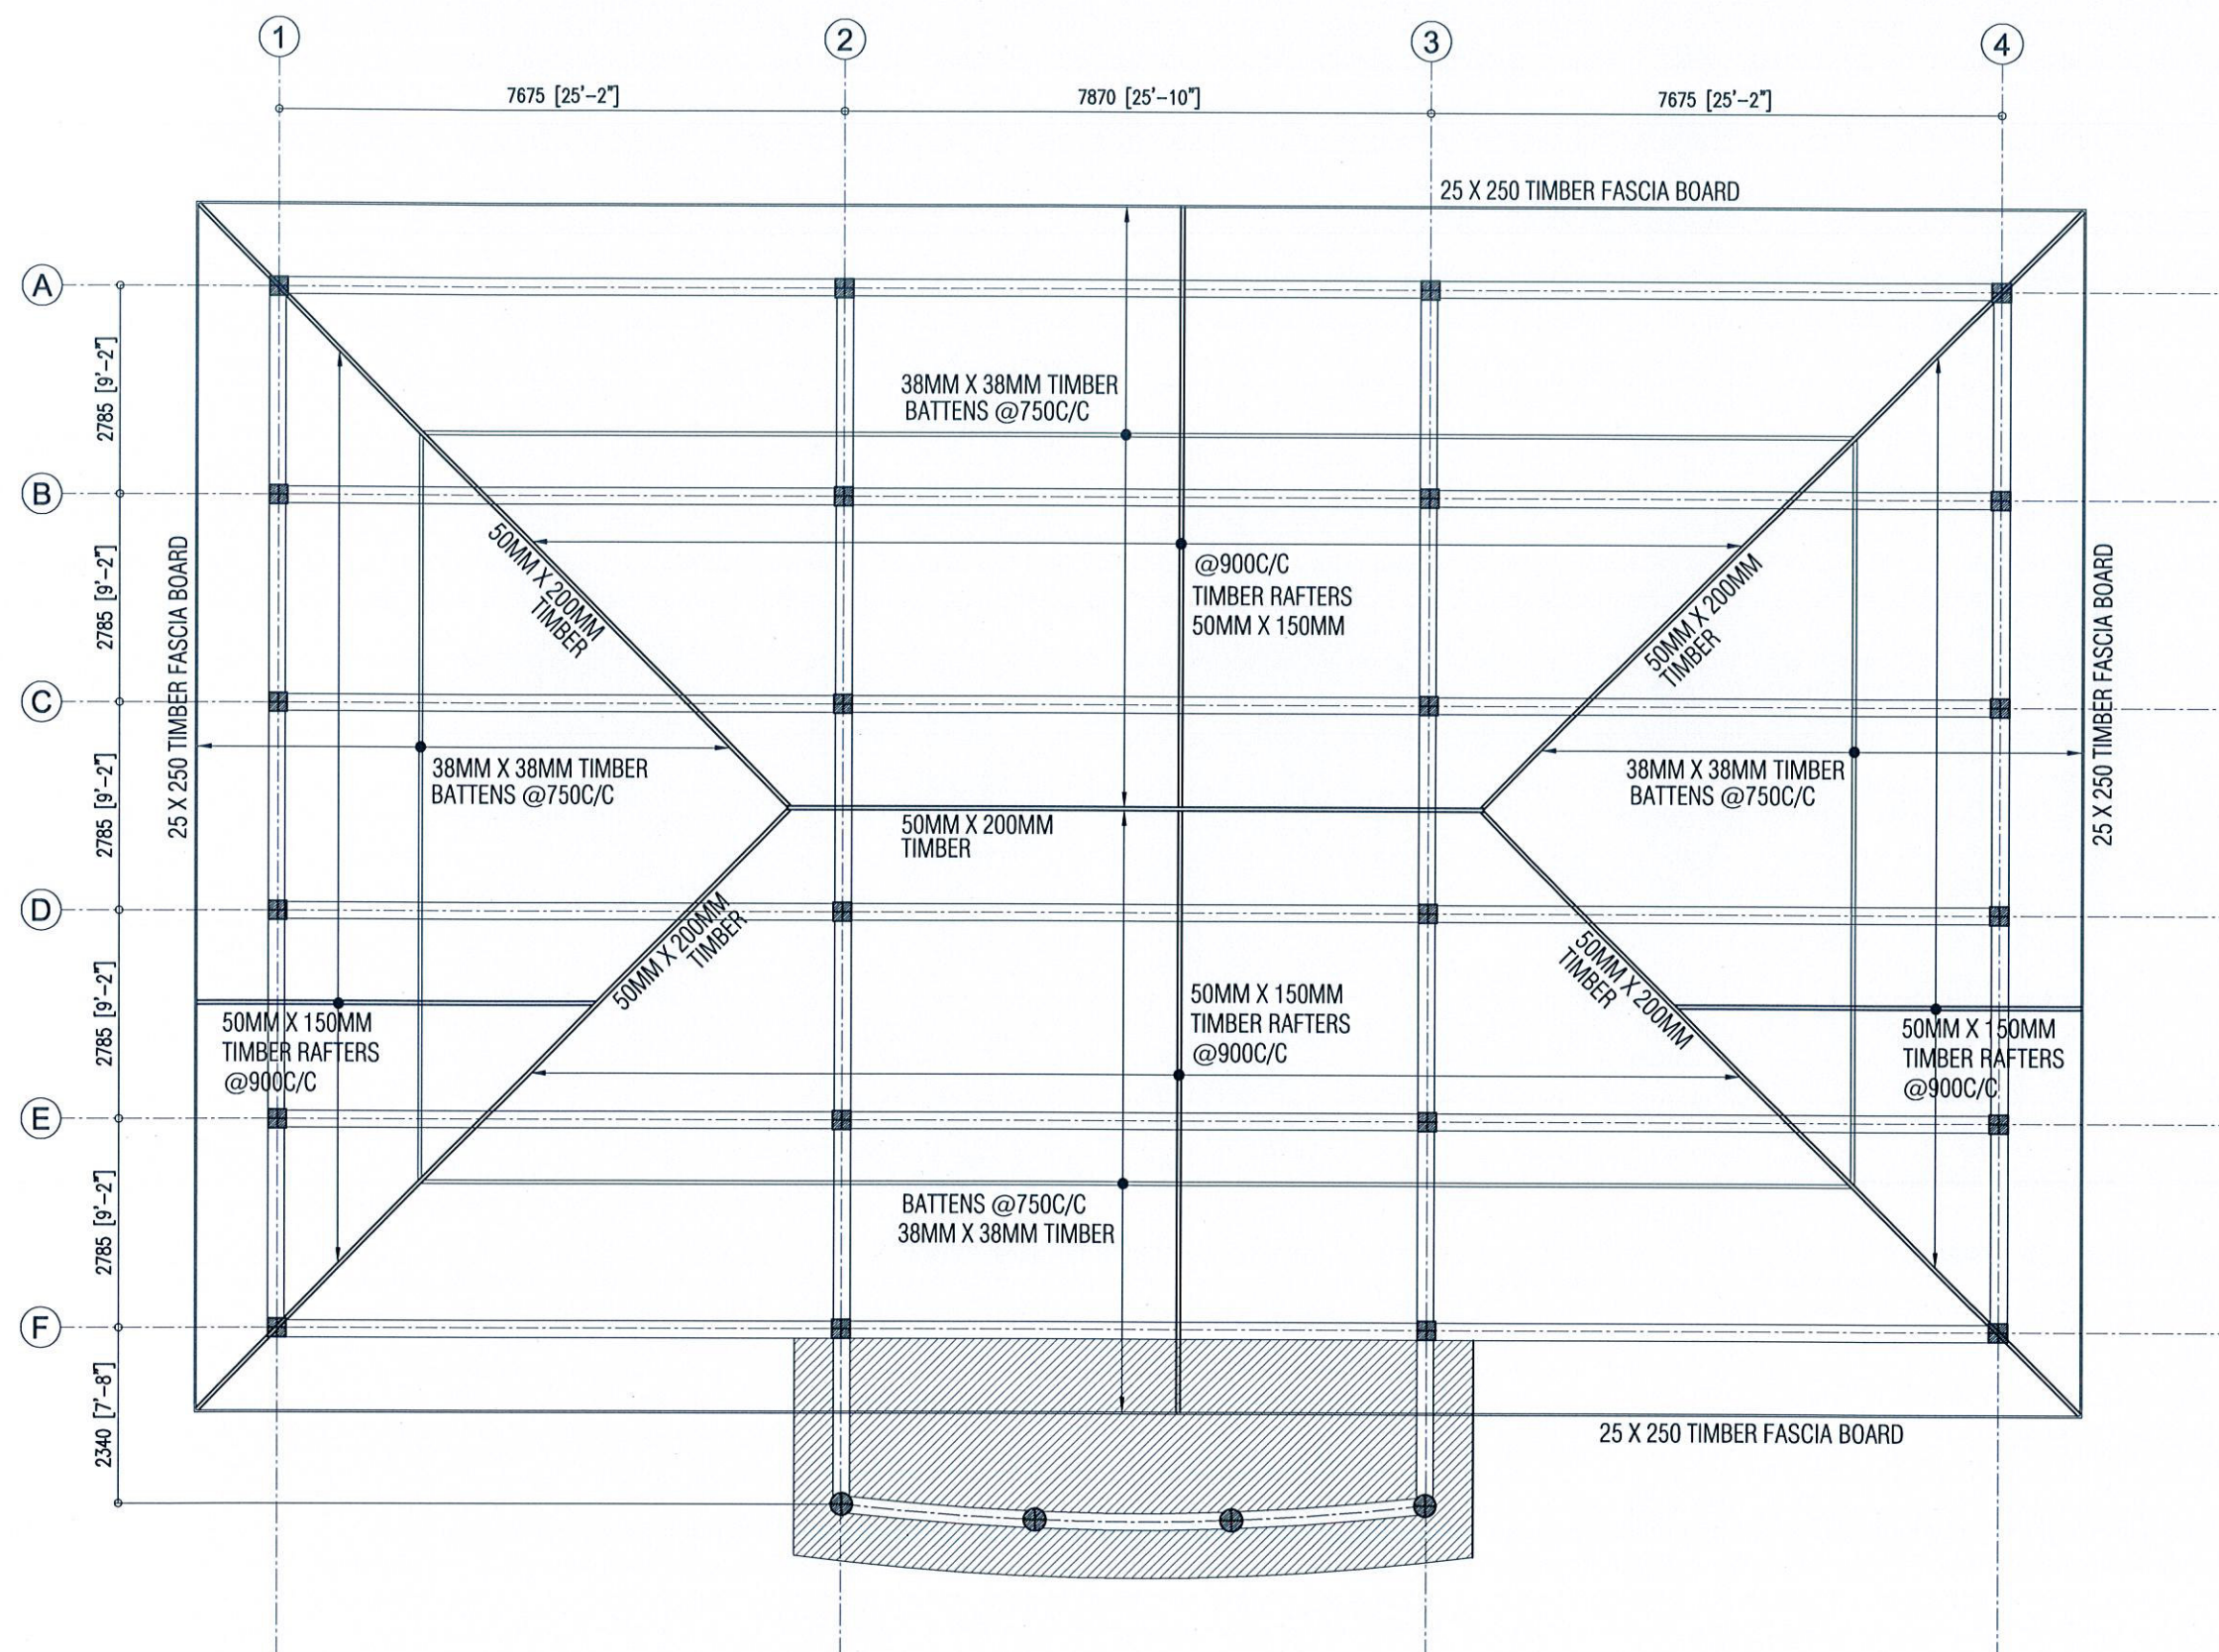
[illegible]

CLIENT : LGA


ALAAF
ALAAF PRIVATE LIMITED
THARUWEGE(GROUND FLR)SABUDHERYA MAGU,MALE'20004,
TEL: (980)7773801, E-MAIL: alAAF.pvt@gmail.com,Web

ROOF FRAMING PLAN


SCALE - 1:100

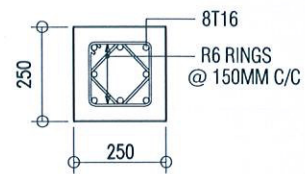

C1

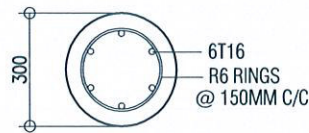


C2

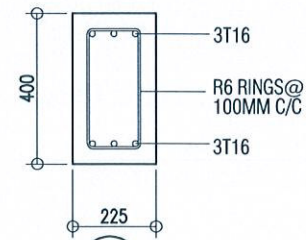


FB


FOUNDATION BEAM AND COLUMN DETAILS SCALE-1:20

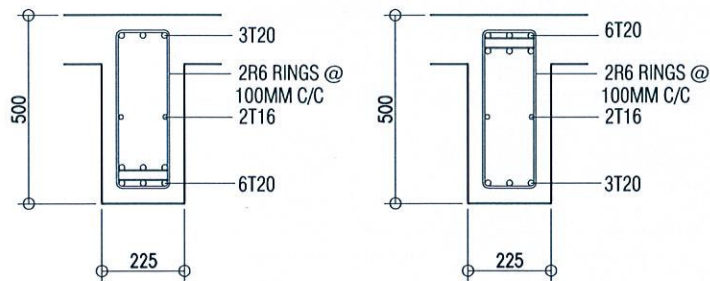

B1

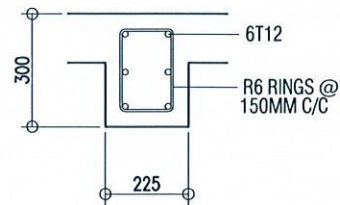


B3

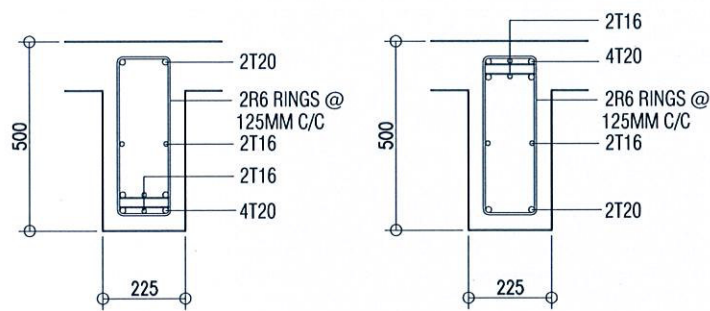

B2


BEAM DETAILS SCALE 1:20

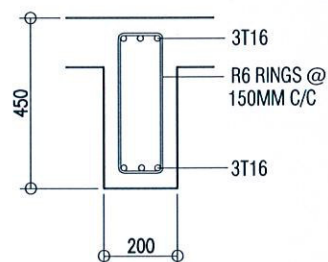


RB

ROOF BEAM DETAILS SCALE 1:20

FOUNDATION FOOTING DETAILS	FOUNDATION FOOTING DIMENSION	FOUNDATION FOOTING RFMT
F1	1500MM X 1500MM X 300MM	T12 @ 125MM C/C BW BOTTOM
F2	1050MM X 1050MM X 300MM	T10 @ 150MM C/C BW BOTTOM
F3	1150MM X 1150MM X 300MM	T10 @ 150MM C/C BW BOTTOM
F4	1350MM X 1350MM X 300MM	T10 @ 125MM C/C BW BOTTOM
F5	1500MM X 1800MM X 300MM	T10 @ 125MM C/C BW BOTTOM

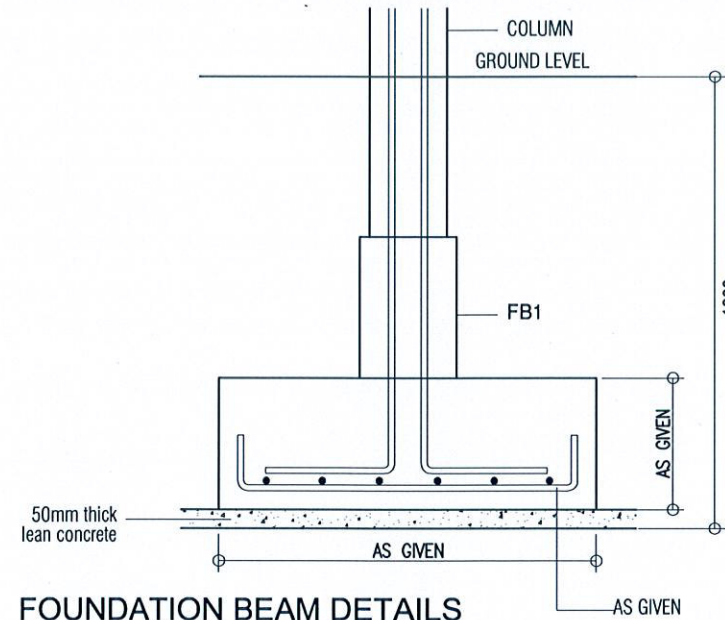

FOUNDATION BEAM DETAILS SCALE 1:20

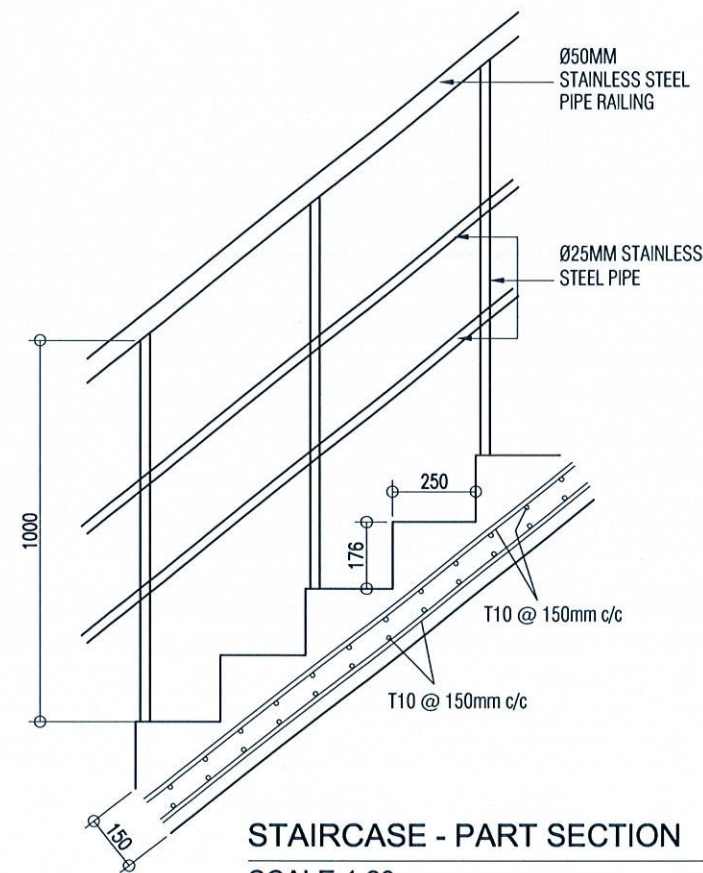

STAIRCASE - PART SECTION SCALE 1:20

SPECIFICATIONS FOR CONCRETE WORKS

- USE RIVER SAND AND GRANITE FOR AGGREGATES.
- MAIN REINFORCEMENT STEEL TO BE HIGH STRENGTH DEFORMED BARS FOR CONCRETING
- USE WATER FREE OF SALT AND ANY OTHER IMPURITIES

NOTE:

- APPROVED TYPE OF WATER PROOFING TO BE APPLIED ON ALL THE FOUNDATION

MIN. REINFORCEMENT CLEAR COVERS :

- FOUNDATION BEAMS 50MM (BOT, TOP, SIDES)
- COLUMNS 40MM (SIDES)
- SLAB BEAM 35MM (BOT), 40MM (SIDES)
- SLAB 30MM (BOT), 40MM (SIDES)



REVISIONS:

PROJECT TITLE:
DHA. ATOLL COUNCIL

CLIENT :
LGA

ARCH. DESIGN:	SHAMIN	PROJECT NO
STRUC. DESIGN:	ASHRAF	DHC-11/15
DATE :	MAY 2015	DRAWING NO
SCALE:	AS GIVEN	S7

ALAAF
ALAAF PRIVATE LIMITED
THARUWAGE(GROUND FLR)SABUDHERYA MAGUMALE 20004.
TEL: (980)7773801, E-MAIL: alaaaf.pvt@gmail.com, Web

COPYRIGHT: THE CONCEPT AND DESIGN IN THIS DRAWING ARE THE PROPERTIES OF ALAAF PVT LTD. THIS DRAWINGS SHOULD BE USED ONLY FOR THE PROJECT MENTIONED ON THIS SHEET.