


**B. GOIDHOO HEALTH CENTER**  
**PAVING AREA SITE PLAN**

SCALE: 1 : 100

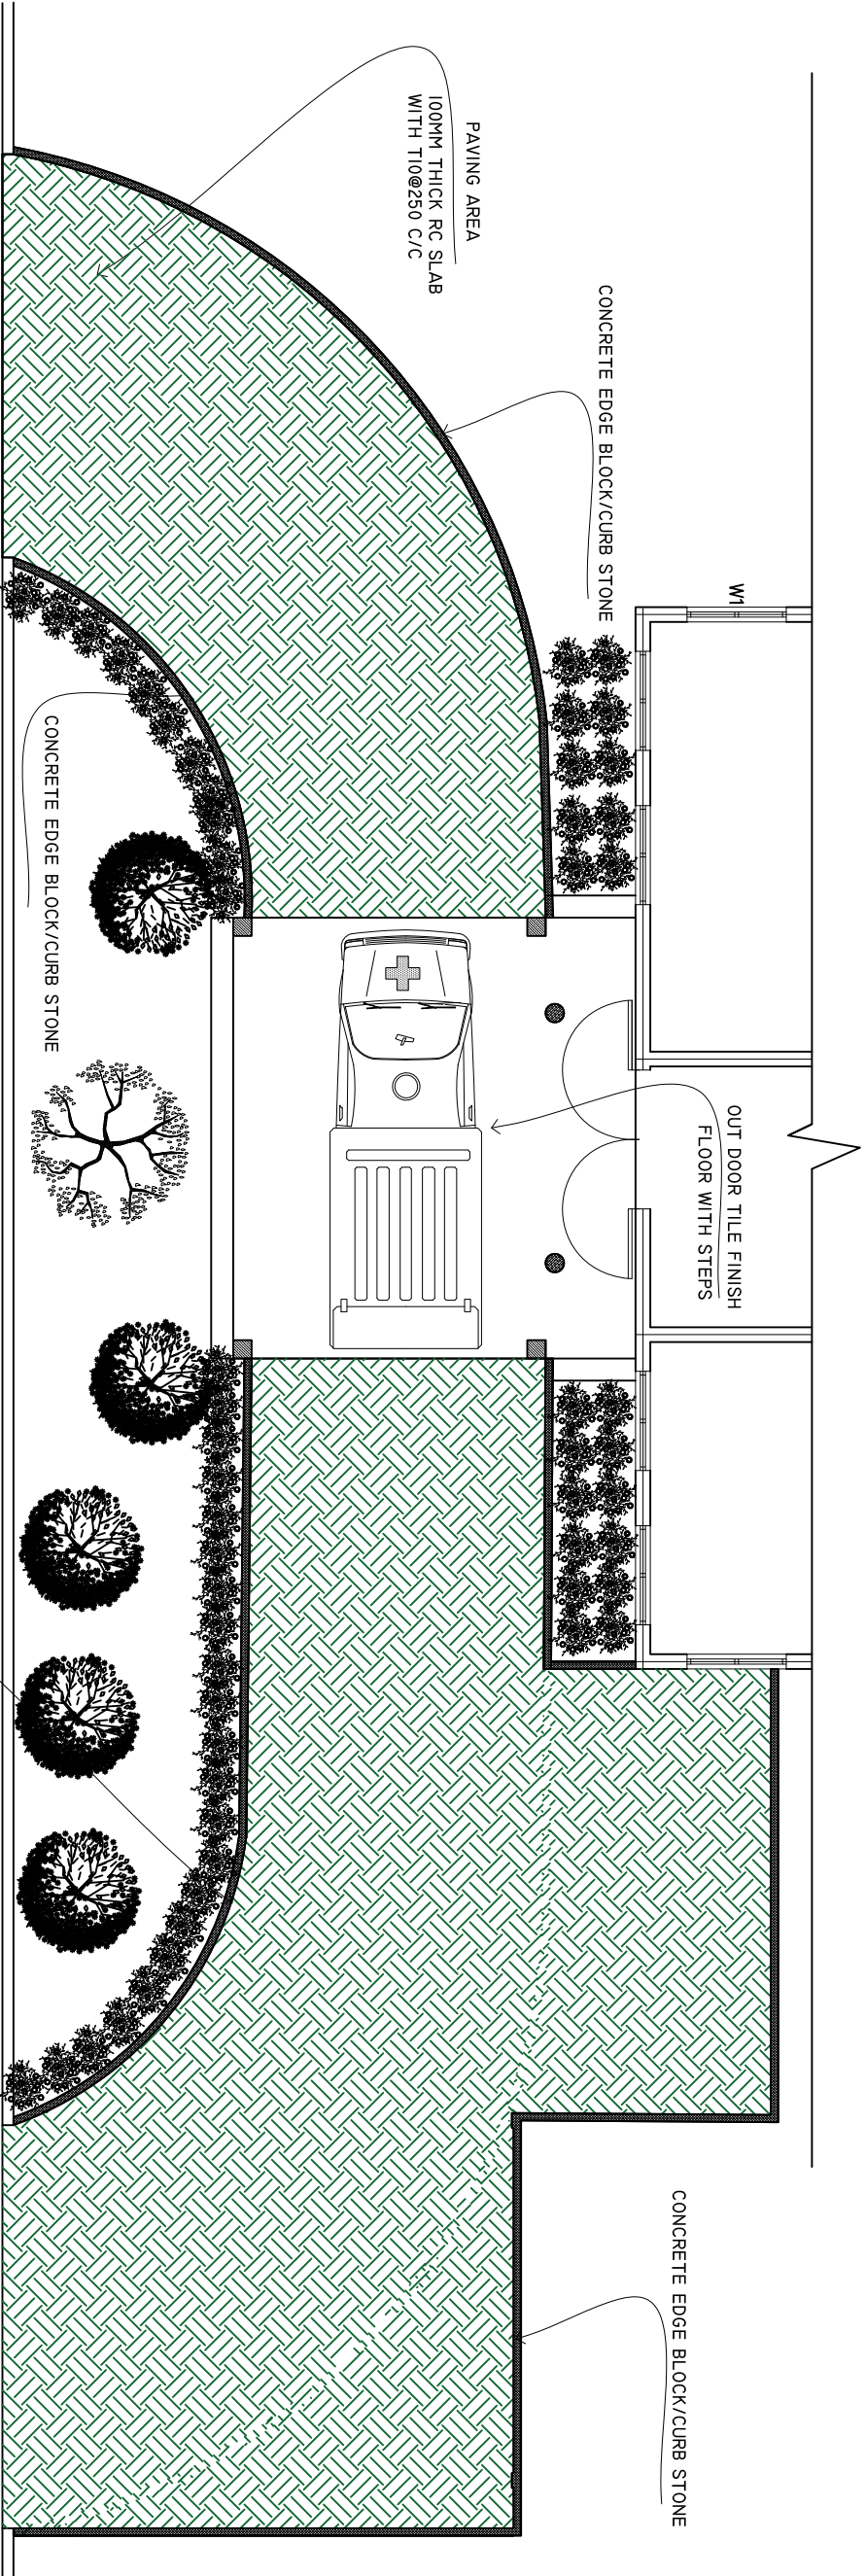

SHEET CONTENTS :

REVISION NOTES:

PROJECT:

CONSTRUCTION OF  
AMBULANCE PORTICO

CLIENT:

MINISTRY OF HEALTH

LOCATION:

DIFFERENT ISLANDS

CONTENTS: AS GIVEN

PROJECT MANAGER:

DESIGNER: ARIZ

CIV/STR. ENGINEER:

SURVEYED BY: -

DRAWN BY: ARIZ

CHECKED BY:

DATE : FEBRUARY 2021

SHEET NO. : /


PAPER SIZE: A3



ADMIN DIVISON  
Ministry of Health  
Roshanee Building  
Sosun Magu  
Tel: 332 8887, Fax: 3328889


COLUMN AND FOOTIONG PLAN

SCALE: 1 : 100

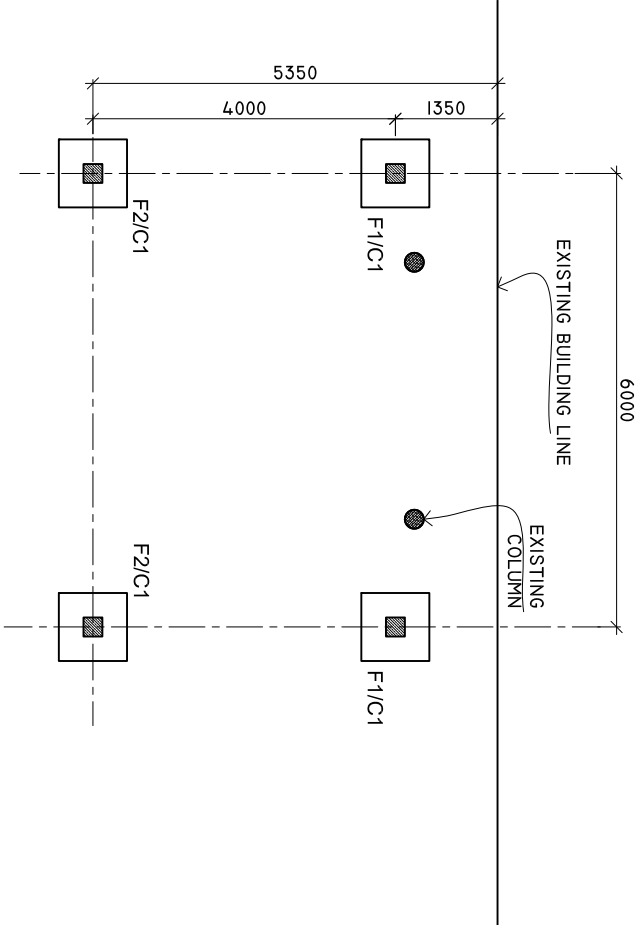


TIE BEAM PLAN

SCALE: 1 : 100

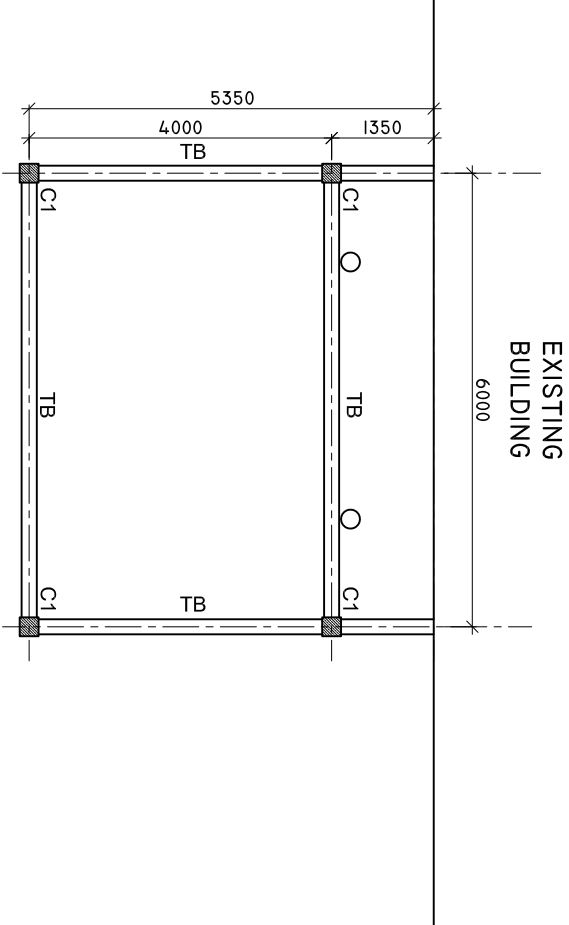

ROOF BEAM PLAN

SCALE: 1 : 100

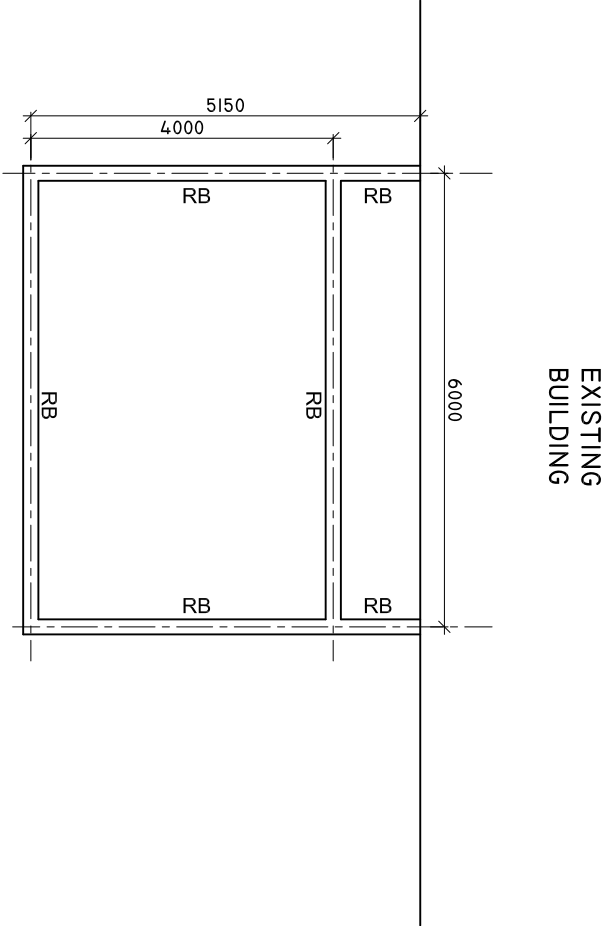

SHEET CONTENTS :

REVISION NOTES:

PROJECT:

CONSTRUCTION OF  
AMBULANCE PORTICO

CLIENT:

MINISTRY OF HEALTH

LOCATION:

DIFFERENT ISLANDS

CONTENTS: AS GIVEN

PROJECT MANAGER:

DESIGNER: ARIZ

CIV/STR. ENGINEER:

SURVEYED BY: -

DRAWN BY: ARIZ

CHECKED BY:

DATE : FEBRUARY 2021

SHEET NO. : /


PAPER SIZE: A3



ADMIN DIVISION  
Ministry of Health  
Roshane Building  
Sana'a, Yemen  
Tel: 332 8887, Fax: 332 8889

---


SCALE: 1:50

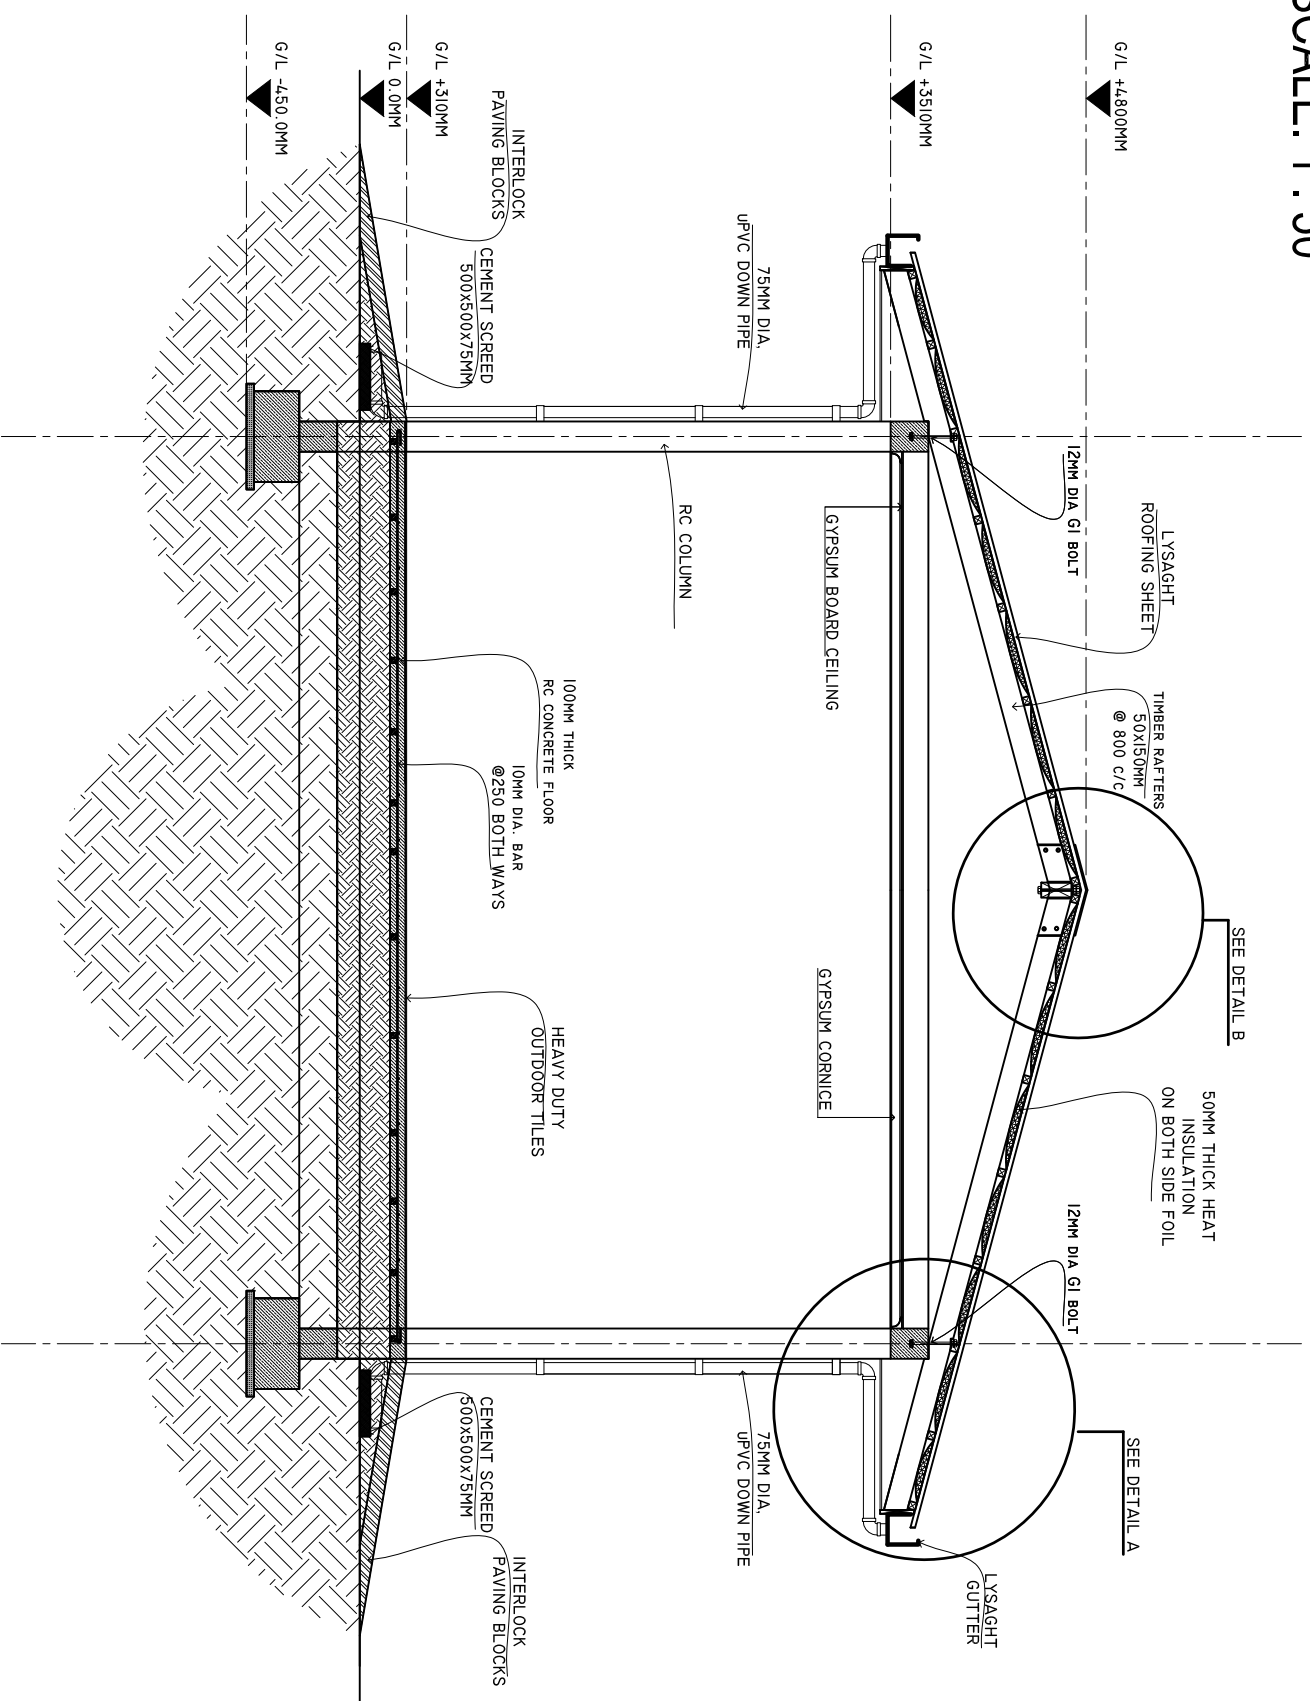

NOTE: PORTICO AND EXISTING BUILDING GUTTER LEVEL MUST BE SAME.

---

**SCALE: 1 : 25**

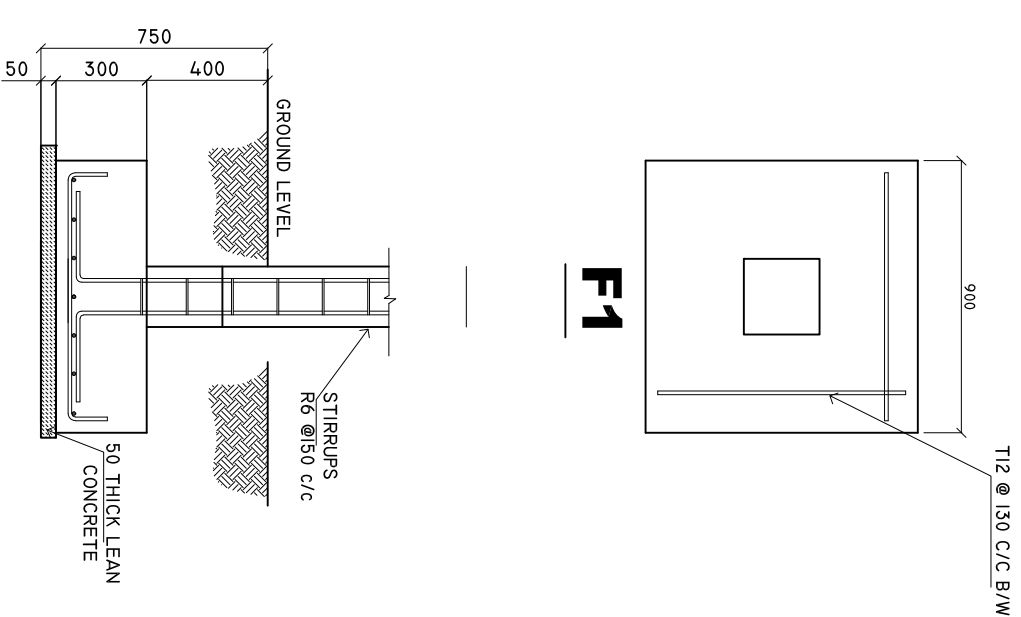


SHEET CONTENTS :	
-----	
-----	
-----	
-----	
-----	
-----	
REVISION NOTES:	
-----	
-----	
-----	
-----	
-----	
-----	
PROJECT:	
CONSTRUCTION OF	
AMBULANCE PORTICO	
-----	
CLIENT:	
MINISTRY OF HEALTH	
-----	
LOCATION:	
DIFFERENT ISLANDS	
-----	
CONTENTS: AS GIVEN	
-----	
PROJECT MANAGER:	
DESIGNER: ARIZ	
CIV/STR. ENGINEER:	
SURVEYED BY: -	
DRAWN BY: ARIZ	
CHECKED BY:	
DATE : FEBRUARY 2021	
SHEET NO. : /	
PAPER SIZE: A3	



*ADMIN DIVISION  
Ministry of Health  
Roshanee Building  
Sosun Magat'  
Tel: 332 8887, Fax: 3328889*


ROOF FRAMING PLAN

SCALE: 1 : 100

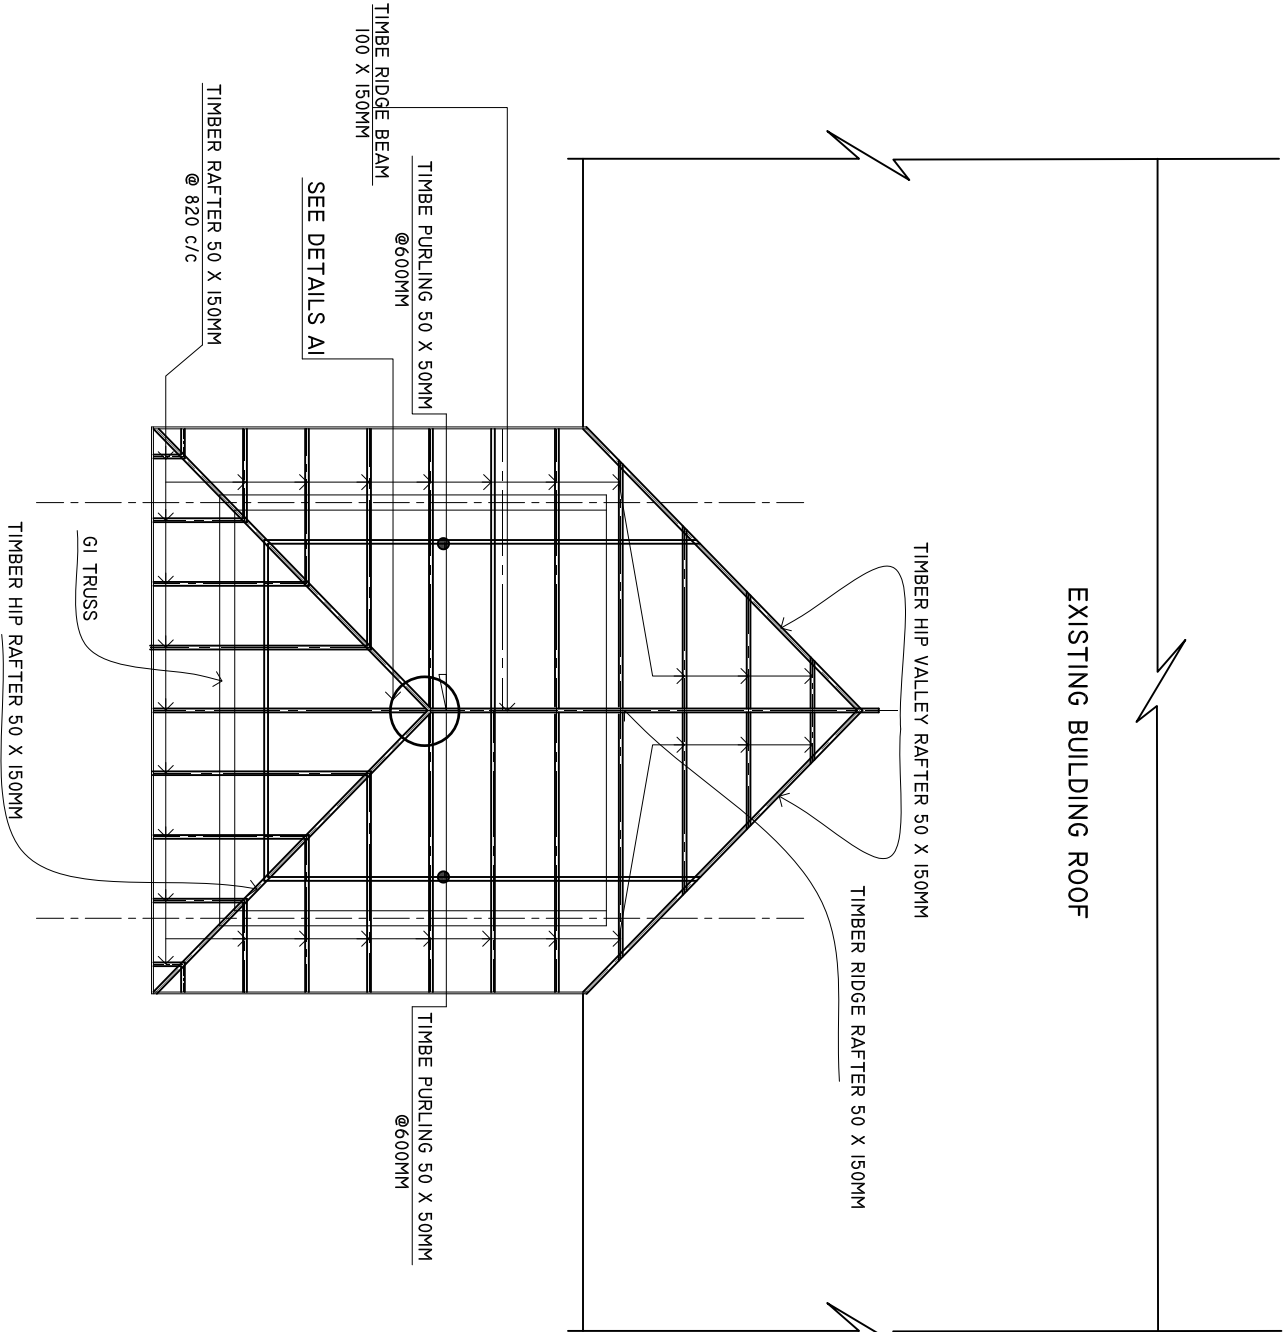

ROOF PLAN

SCALE: 1 : 100

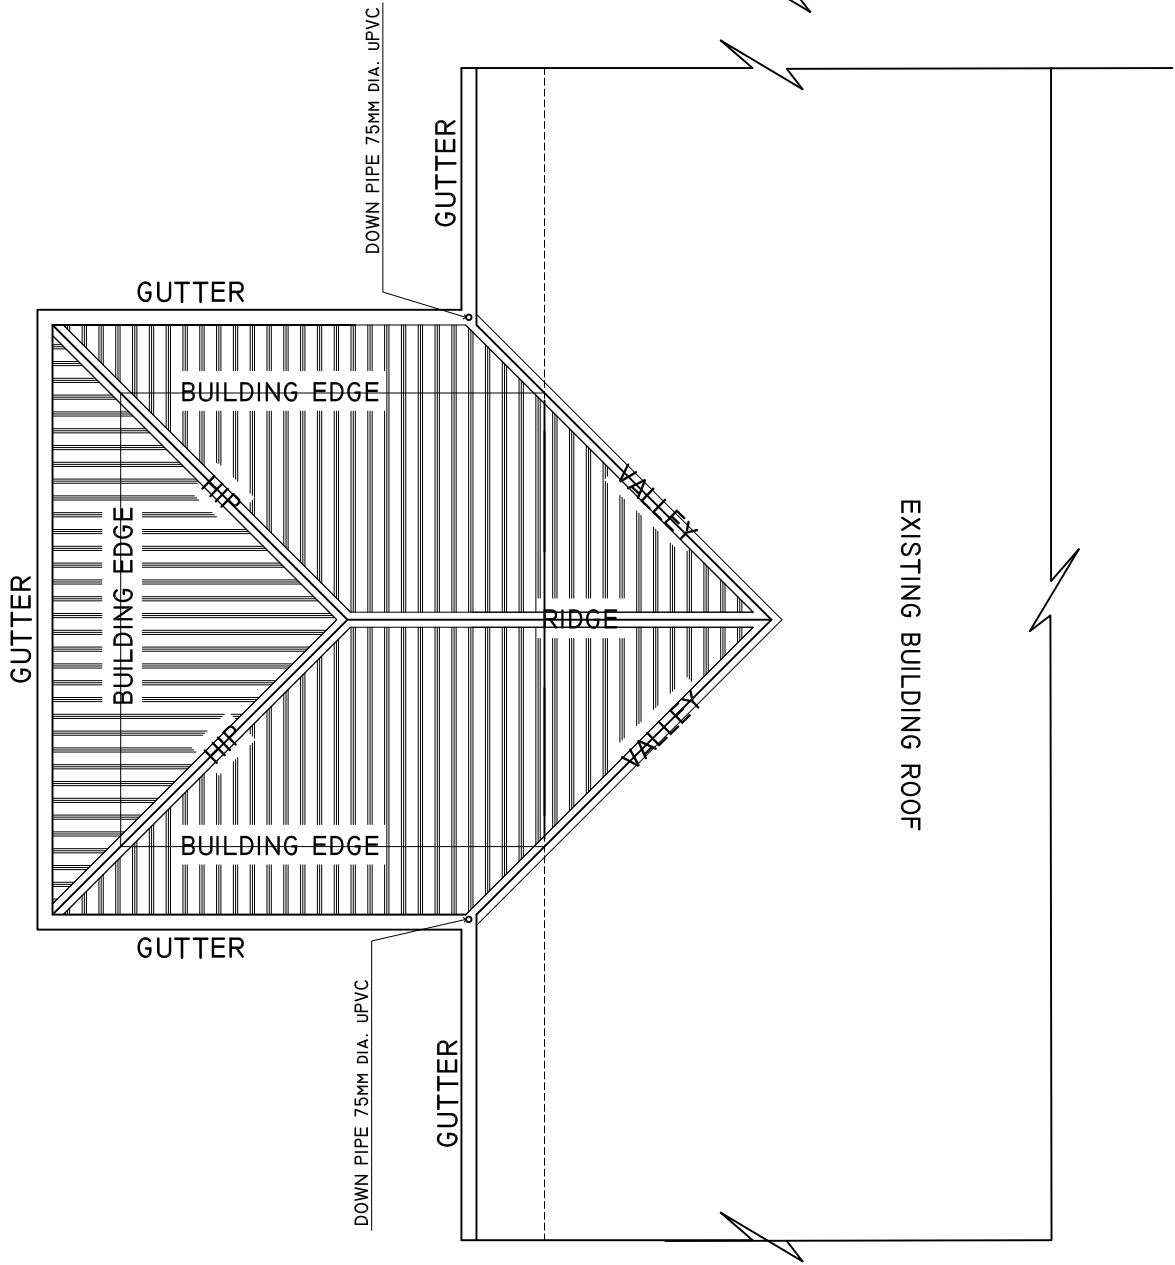

SHEET CONTENTS :

REVISION NOTES:

PROJECT:

CONSTRUCTION OF  
AMBULANCE PORTICO

CLIENT:

MINISTRY OF HEALTH

LOCATION:

DIFFERENT ISLANDS

CONTENTS: AS GIVEN

PROJECT MANAGER:

DESIGNER: ARIZ

CIV/STR. ENGINEER:

SURVEYED BY: -

DRAWN BY: ARIZ

CHECKED BY:

DATE : FEBRUARY 2021


SHEET NO. : /

PAPER SIZE: A3



**FRONT ELEVATION**


SCALE: 1:50

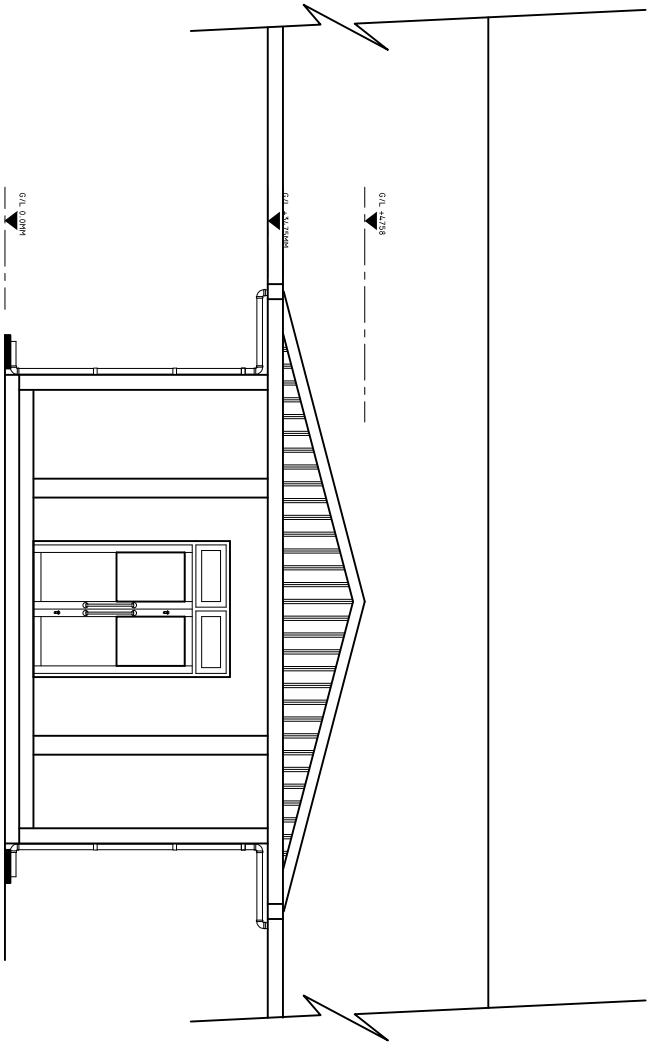

NOTE: PORTICO AND EXISTING BUILDING GUTTER LEVEL MUST BE SAME.

**SIDE ELEVATION**

SCALE: 1:50

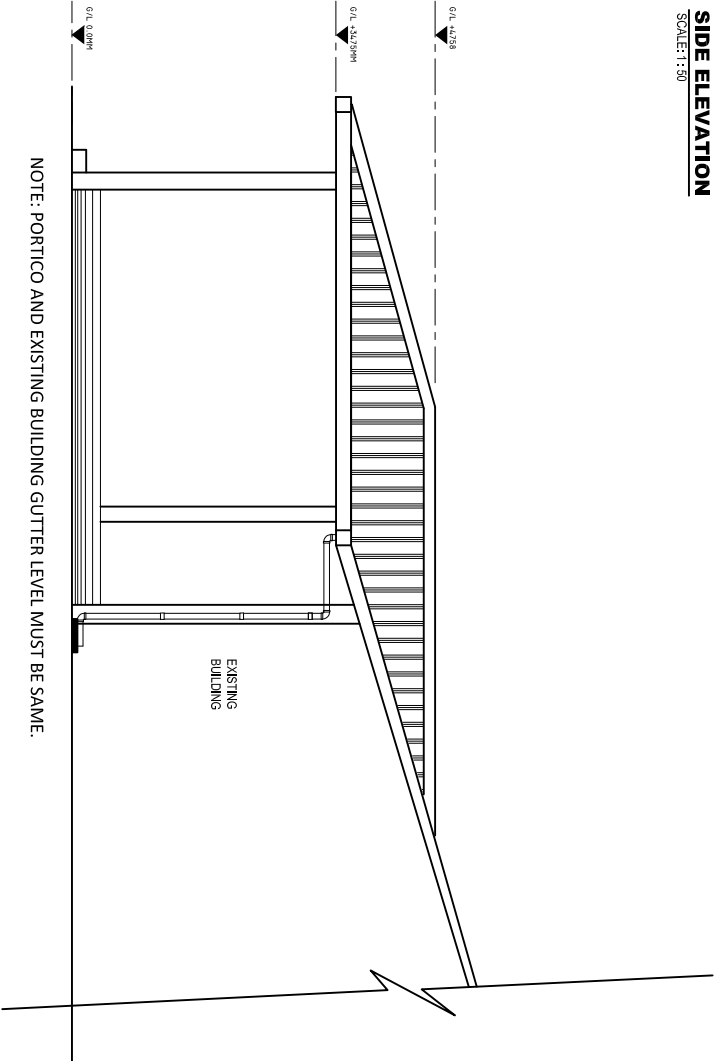


NOTE: PORTICO AND EXISTING BUILDING GUTTER LEVEL MUST BE SAME.

**ELECTRICAL LAYOUT**

SCALE: 1 : 100

**EXISTING  
BUILDING**

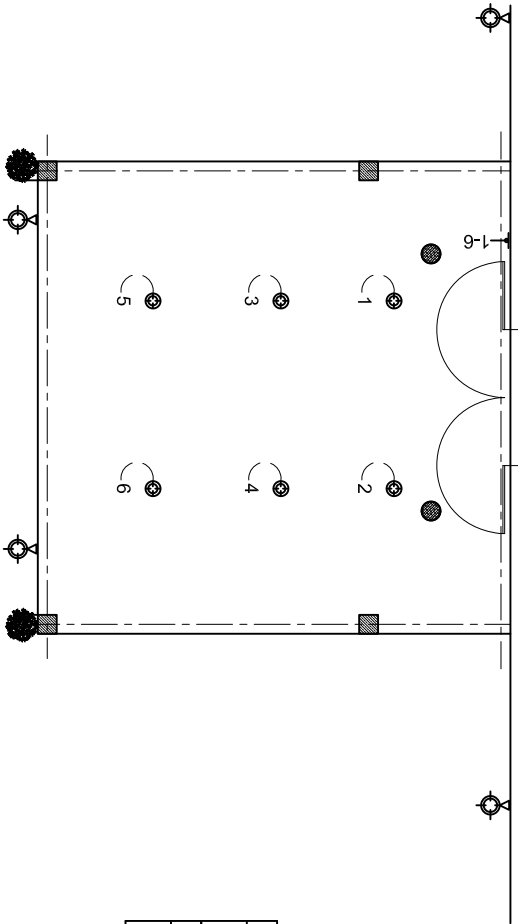

**LEGEND**

SYMBOL	DESCRIPTION
	OUR DOOR WHETHER PROOF LIGHT 21W PHILIPS.
	FOUR GANG SWITCH
	OUTDOOR WHETHER PROOF LIGHT 21W PHILIPS.

**SHEET CONTENTS :**


**REVISION NOTES:**


**PROJECT:**

CONSTRUCTION OF  
AMBULANCE PORTICO

**CLIENT:**

MINISTRY OF HEALTH

**LOCATION:**

DIFFERENT ISLANDS

CONTENTS: AS GIVEN

PROJECT MANAGER:

DESIGNER: ARIZ

CIV/STR. ENGINEER:

SURVEYED BY: -

DRAWN BY: ARIZ

CHECKED BY:

DATE : FEBRUARY 2021


SHEET NO. : /

PAPER SIZE: A3




ADMIN DIVISION  
Ministry of Health  
Roshane Building  
Sasun Nagar  
Tel: 332 8887, Fax: 3328889

**DETAIL B**  
**SCALE: 1 : 10**

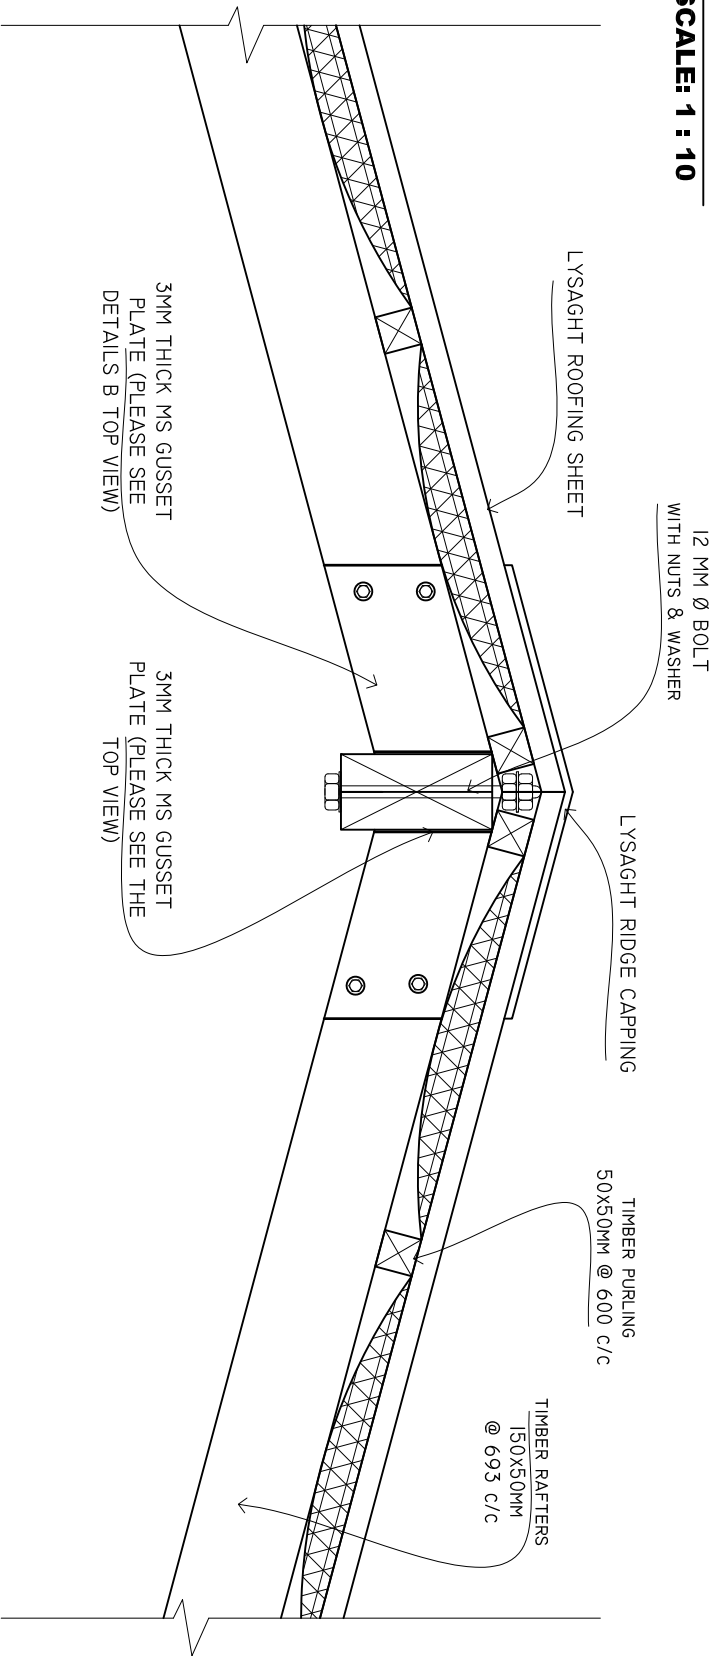

**DETAILS B (TOP VIEW)**  
**SCALE: 1 : 10**

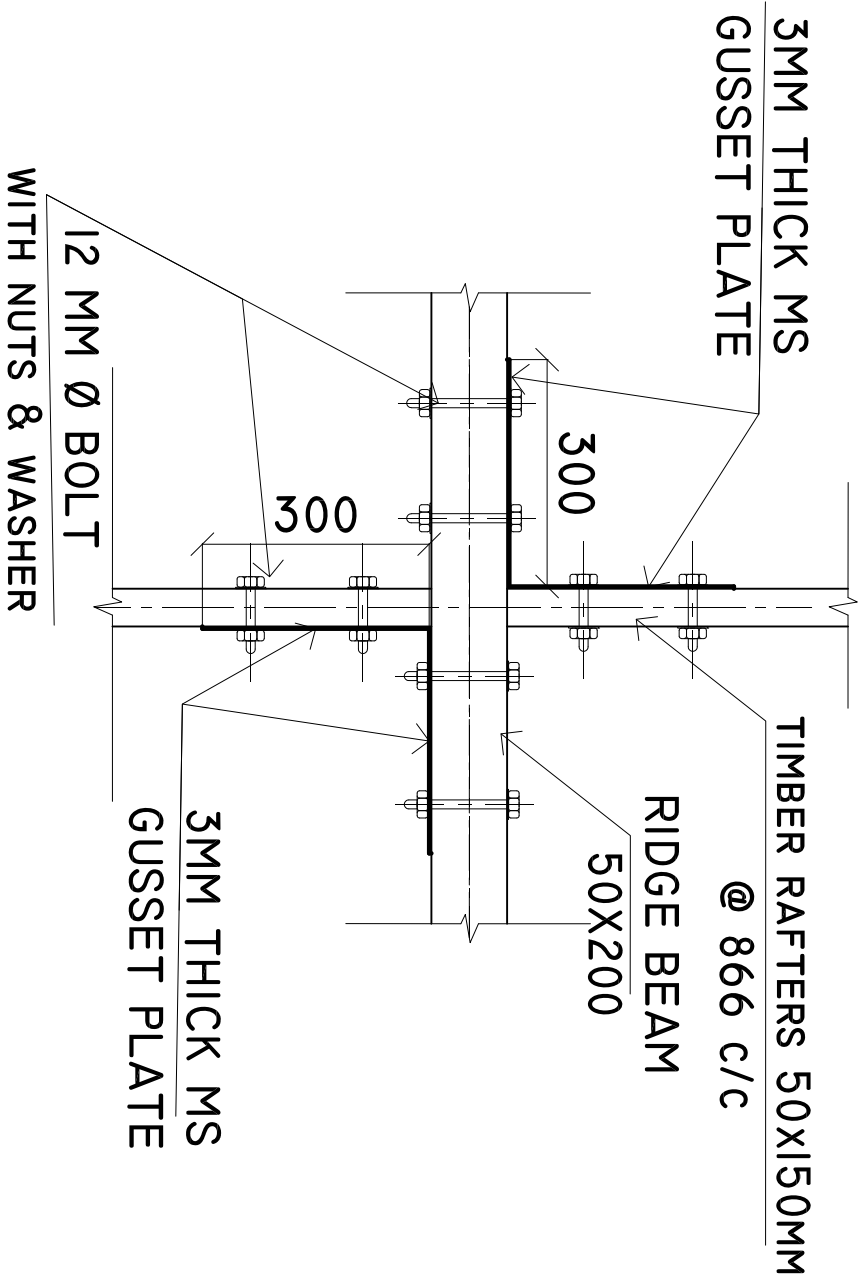

SHEET CONTENTS :

REVISION NOTES:

PROJECT:

CONSTRUCTION OF  
AMBULANCE PORTICO

CLIENT:

MINISTRY OF HEALTH

LOCATION:

DIFFERENT ISLANDS

CONTENTS: AS GIVEN

PROJECT MANAGER:

DESIGNER: ARIZ

CIV/STR. ENGINEER:

SURVEYED BY: -

DRAWN BY: ARIZ

CHECKED BY:


DATE : FEBRUARY 2021

SHEET NO. : /

PAPER SIZE: A3



**DETAIL A**  
**SCALE: 1 : 10**

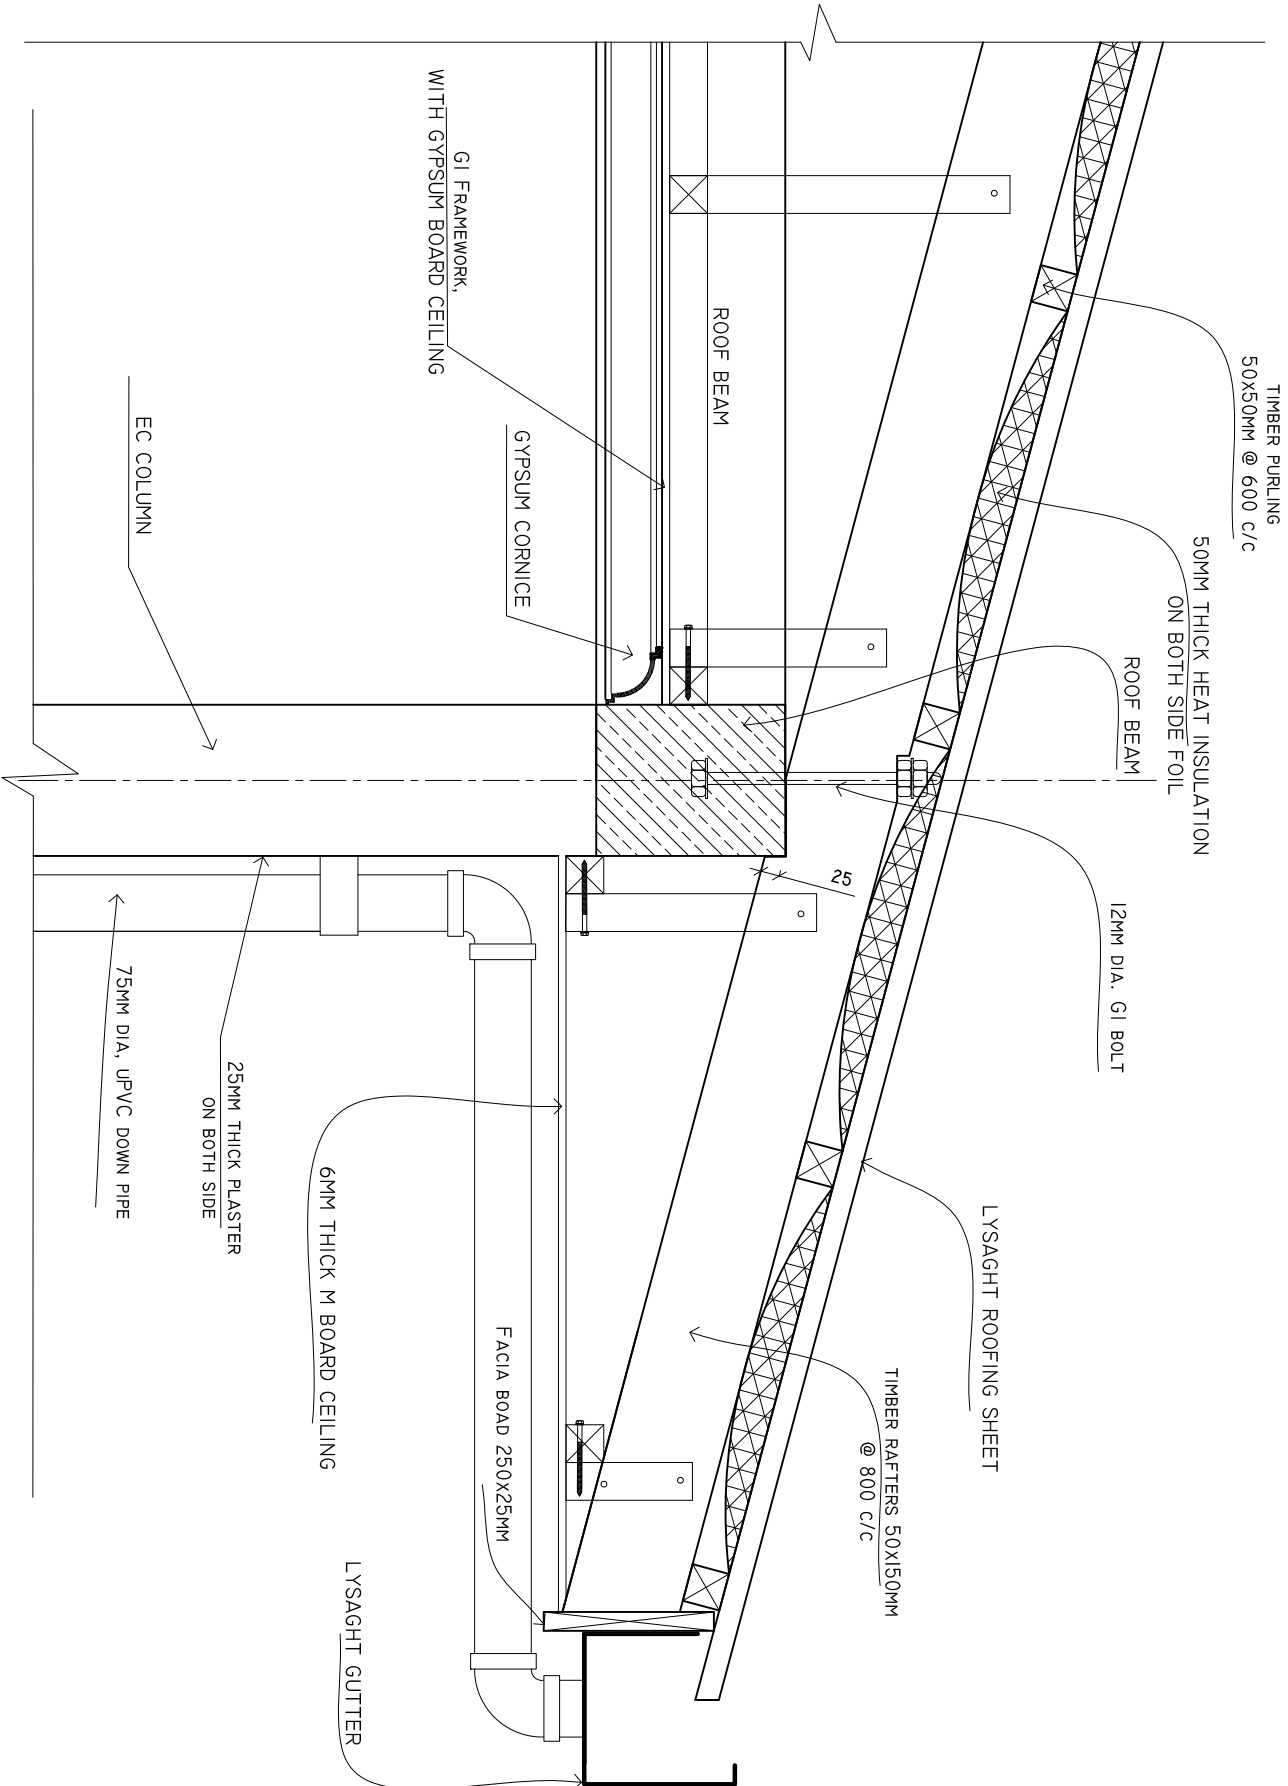

SHEET CONTENTS :

REVISION NOTES:

PROJECT:

CONSTRUCTION OF  
AMBULANCE PORTICO

CLIENT:

MINISTRY OF HEALTH

LOCATION:

DIFFERENT ISLANDS

CONTENTS: AS GIVEN

PROJECT MANAGER:

DESIGNER: ARIZ

CIV/STR. ENGINEER:

SURVEYED BY: -

DRAWN BY: ARIZ

CHECKED BY:

DATE : FEBRUARY 2021


SHEET NO. : /

PAPER SIZE: A3




# DETAILS A1

SCALE: 1 : 10

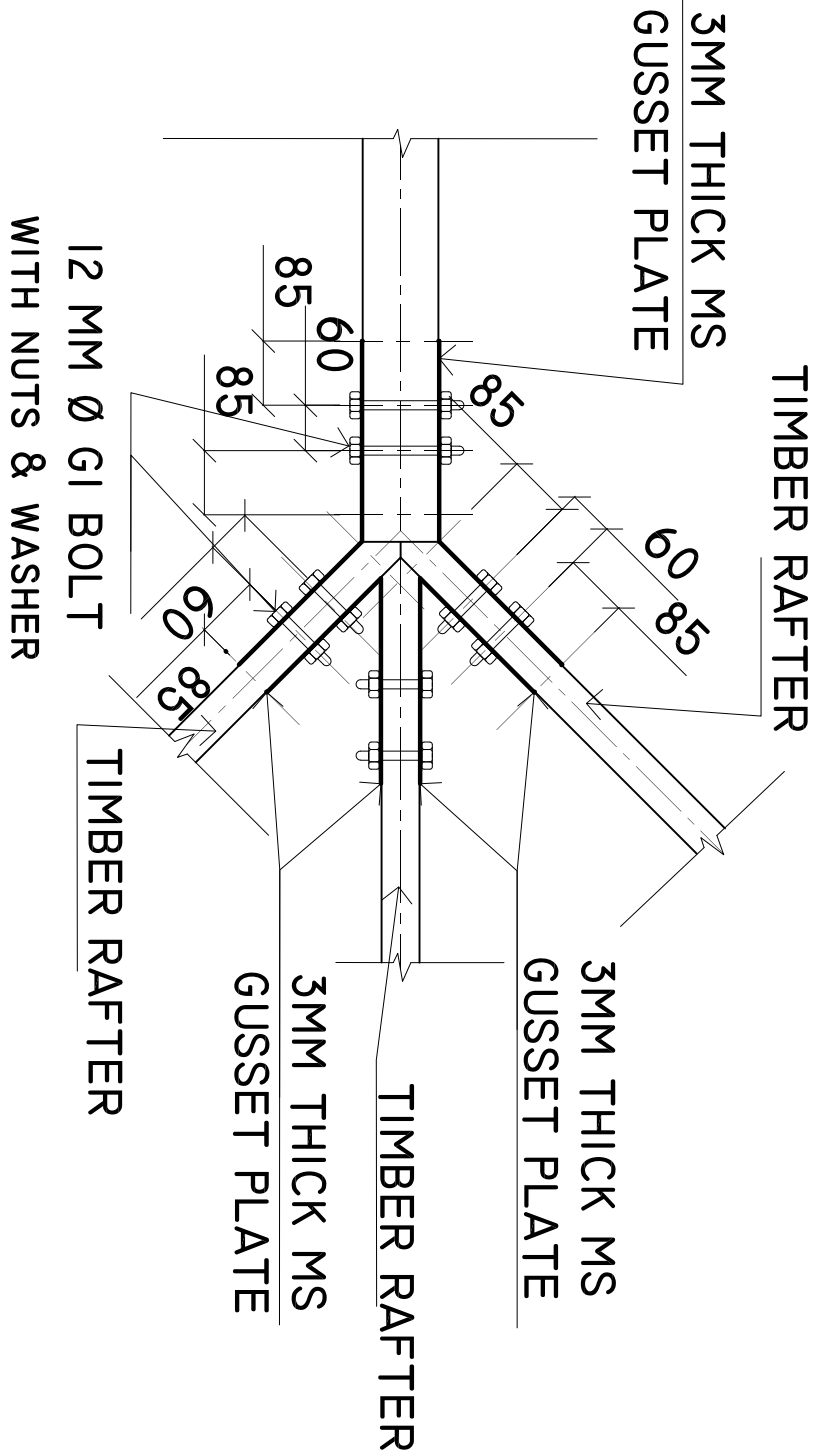

## HIP RAFTER CONNECTIO DETAIL

SCALE: 1 : 10

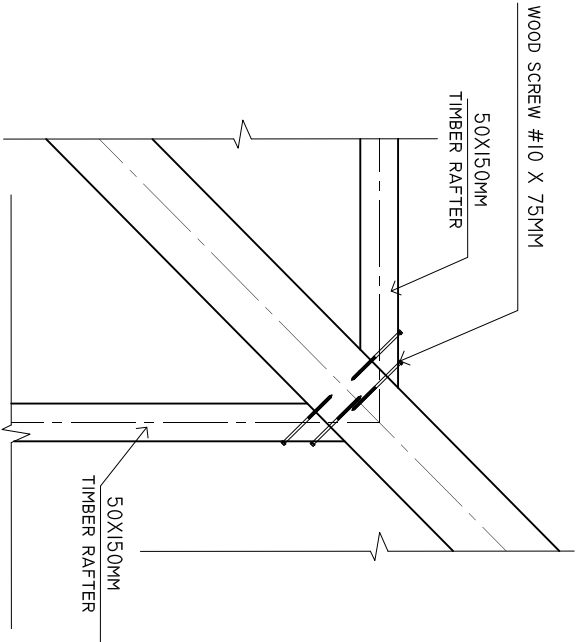

SHEET CONTENTS :

REVISION NOTES:

PROJECT:

CONSTRUCTION OF  
AMBULANCE PORTICO

CLIENT:

MINISTRY OF HEALTH

LOCATION:  
DIFFERENT ISLANDS

CONTENTS: AS GIVEN

PROJECT MANAGER:

DESIGNER: ARIZ

CIV/STR. ENGINEER:

SURVEYED BY: -

DRAWN BY: ARIZ

CHECKED BY:

DATE : FEBRUARY 2021

SHEET NO. : /


PAPER SIZE: A3





PAVING AREA DETAILS

SCALE: 1 : 10

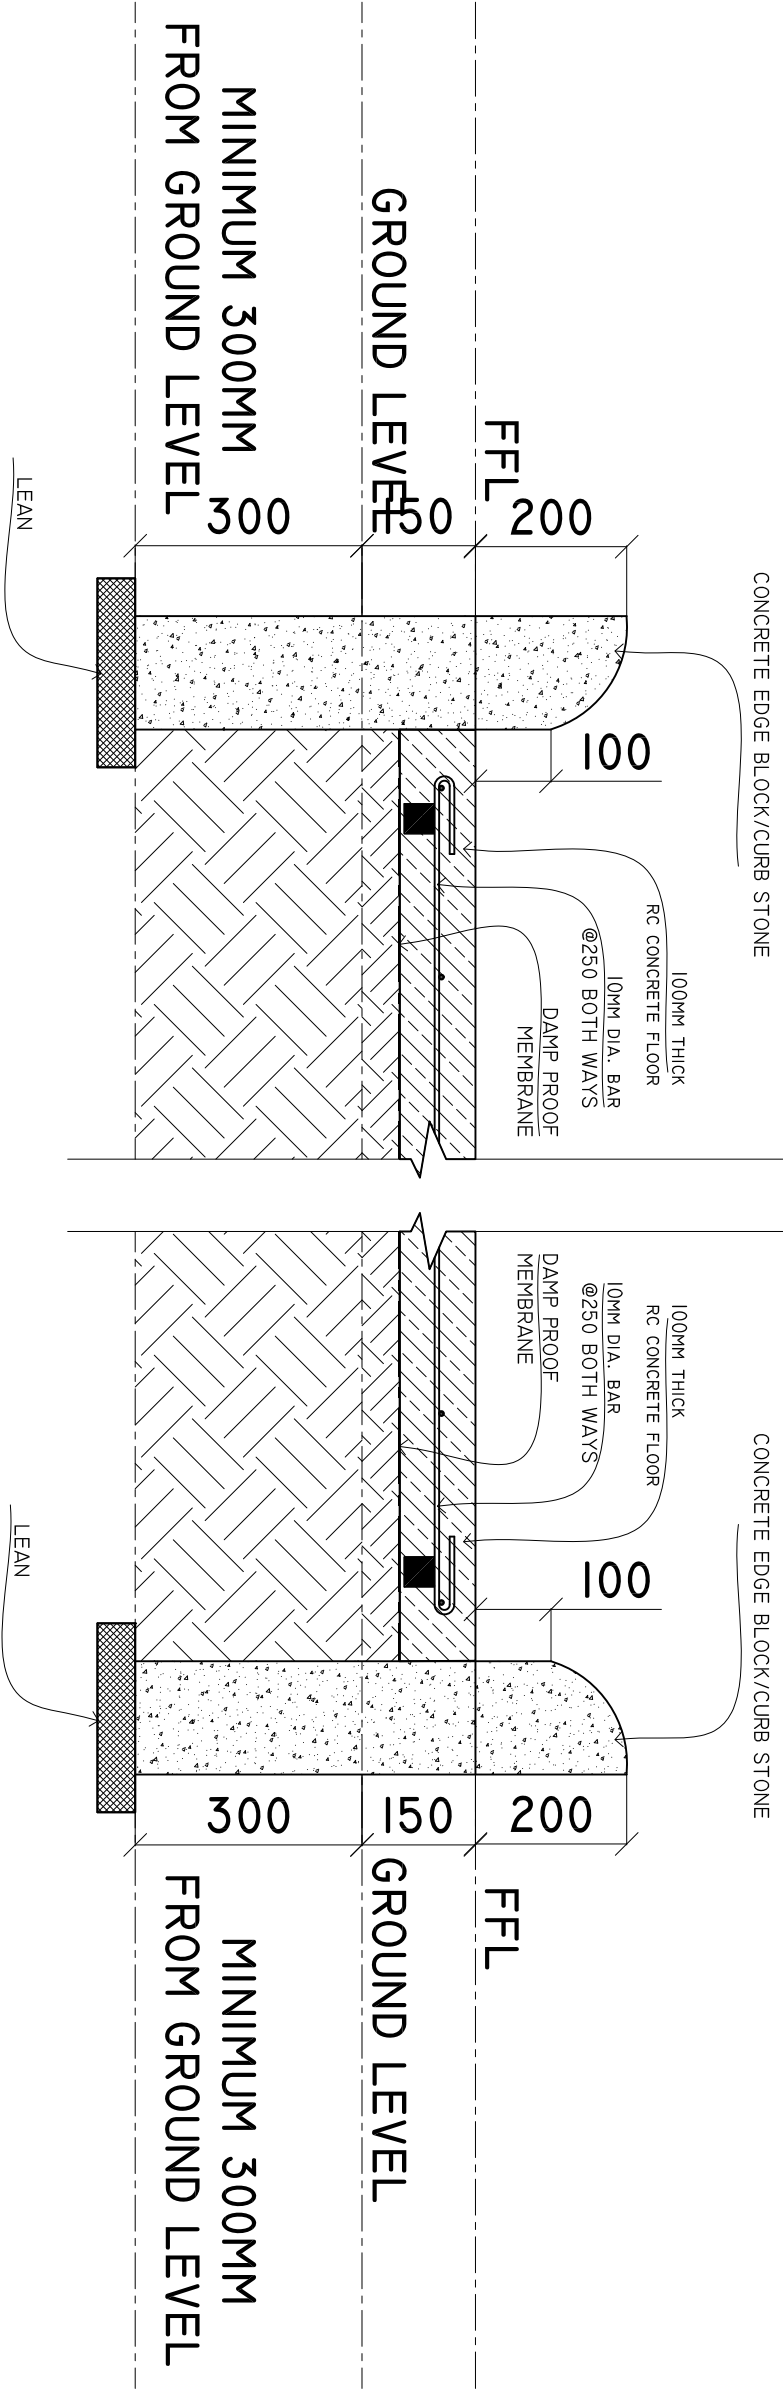

SHEET CONTENTS :

REVISION NOTES:

PROJECT:

CONSTRUCTION OF  
AMBULANCE PORTICO

CLIENT:

MINISTRY OF HEALTH

LOCATION:  
DIFFERENT ISLANDS

CONTENTS: AS GIVEN

PROJECT MANAGER:

DESIGNER: ARIZ

CIV/STR. ENGINEER:

SURVEYED BY: -

DRAWN BY: ARIZ

CHECKED BY:

DATE : FEBRUARY 2021


SHEET NO. : /

PAPER SIZE: A3



## **B. GOIDHOO HEALTH CENTER**

SCALE: 1 : 100

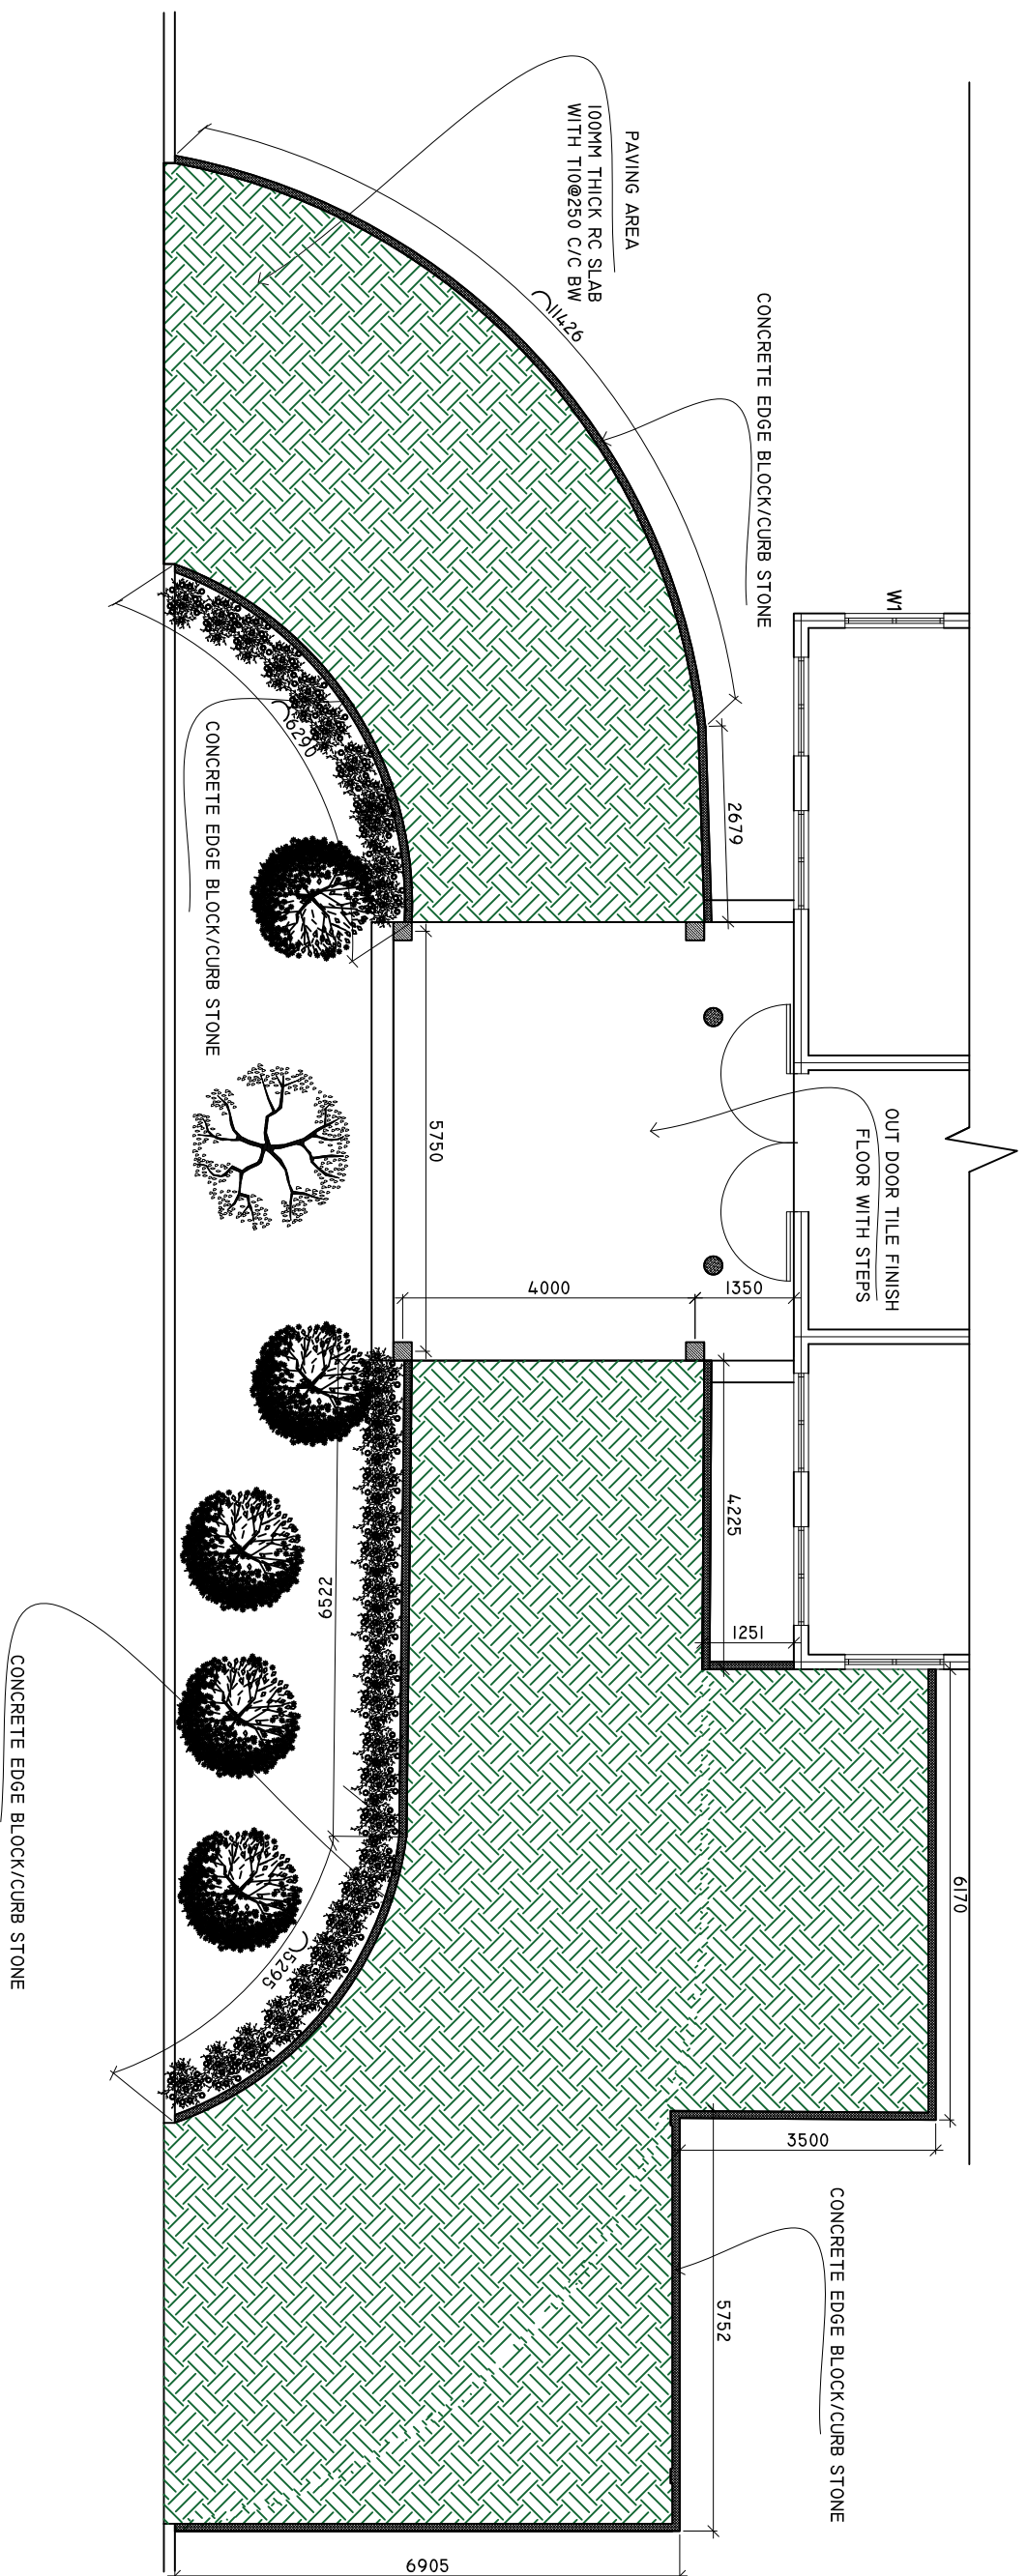

SHEET CONTENTS :	
-----	
-----	
-----	
-----	
-----	
-----	
REVISION NOTES:	
-----	
-----	
-----	
-----	
-----	
PROJECT:	
CONSTRUCTION OF AMBULANCE PORTICO	
CLIENT:	
MINISTRY OF HEALTH	
LOCATION:	
DIFFERENT ISLANDS	
CONTENTS: AS GIVEN	
PROJECT MANAGER:	
DESIGNER: ARIZ	
CIV/STR. ENGINEER:	
SURVEYED BY: -	
DRAWN BY: ARIZ	
CHECKED BY:	
DATE : FEBRUARY 2021	
SHEET NO. : /	
PAPER SIZE: A3	

