

LEGEND


- 3 Phase Distribution Board
- 2x13A Socket Outlet (300mm Above Floor Level)
- 1x13A Socket Outlet (2700mm Above Floor Level)
- One gang One way Switch
- Four gang One way Switch
- Fan Dimmer
- Down light with 20W Energy saving
- Weather proof eve light with 20W Energy saving
- Emergency Wall mount light (Non maintained, 2 hours)
- Ceiling Fan (1.2m Ø)

NOTE

- Distribution Board Should be connected to panel board

ELECTRICAL LAYOUT

SCALE 1:100

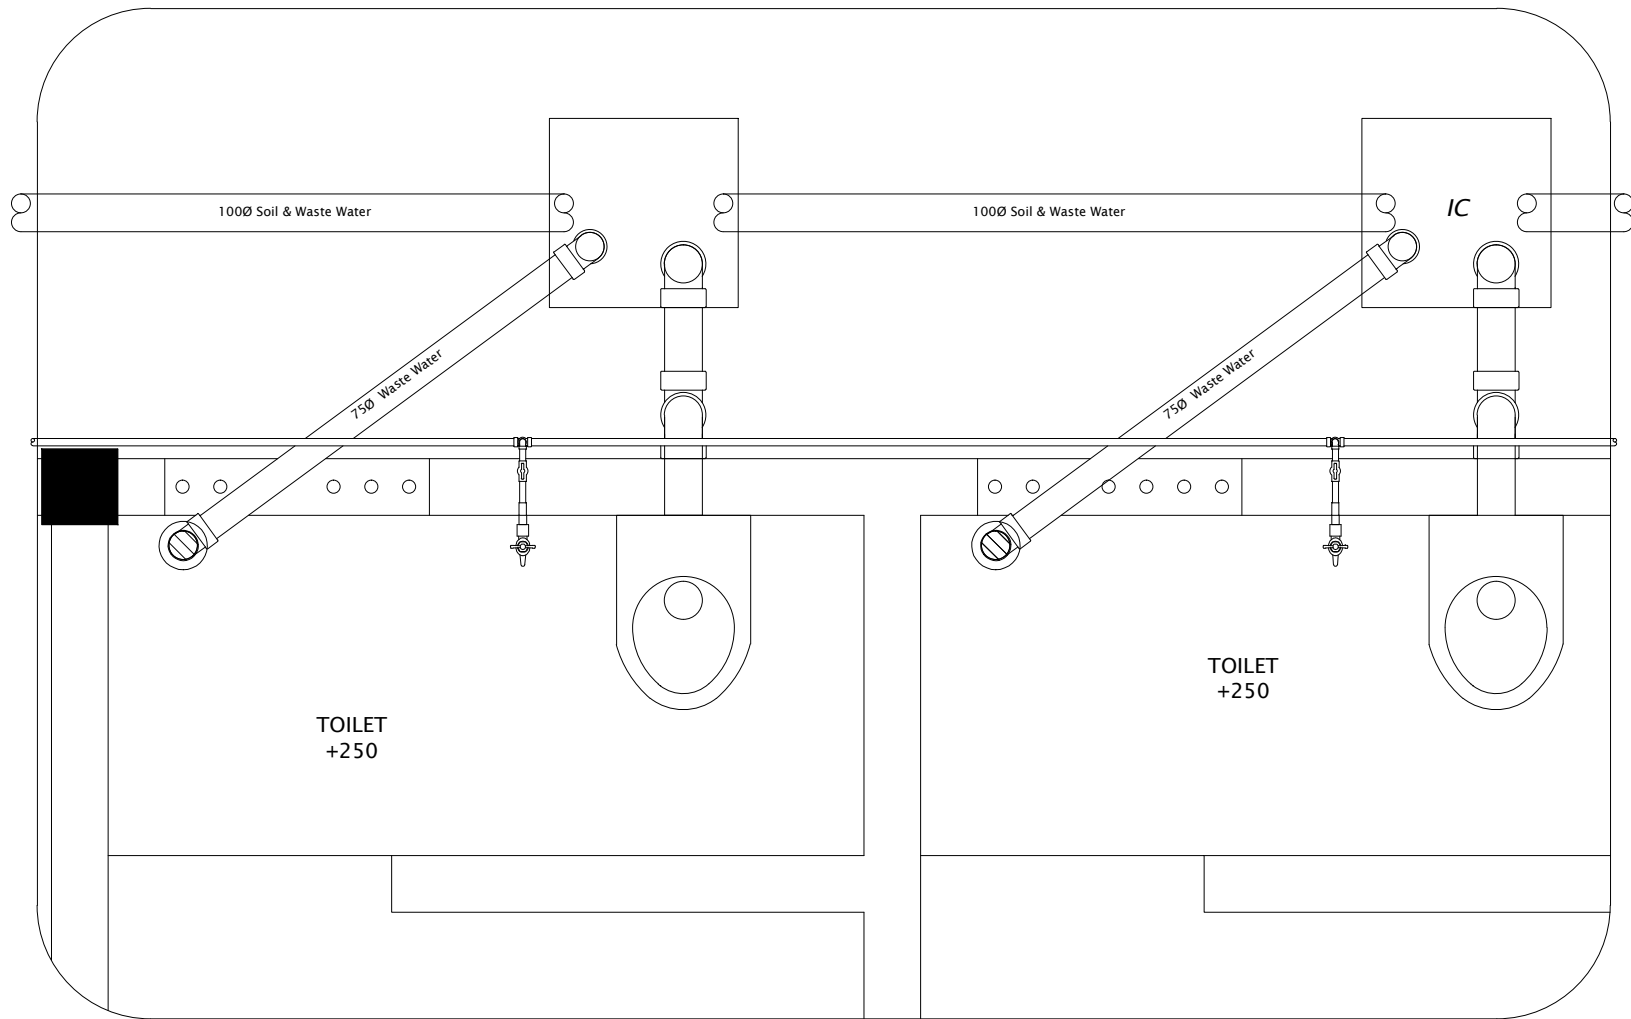


DETAIL A

SCALE 1:20

LEGEND:


- Tap
- Faucet
- Stop Valve
- Floor Drain with P-Trap Gully
- Electric pump
- Inspection Chamber
- 100mm Ø UPVC pipe for Sewerage Disposal
- 75mm Ø UPVC pipe for Waste Water Disposal
- 25mm Ø UPVC pipe for Fresh water

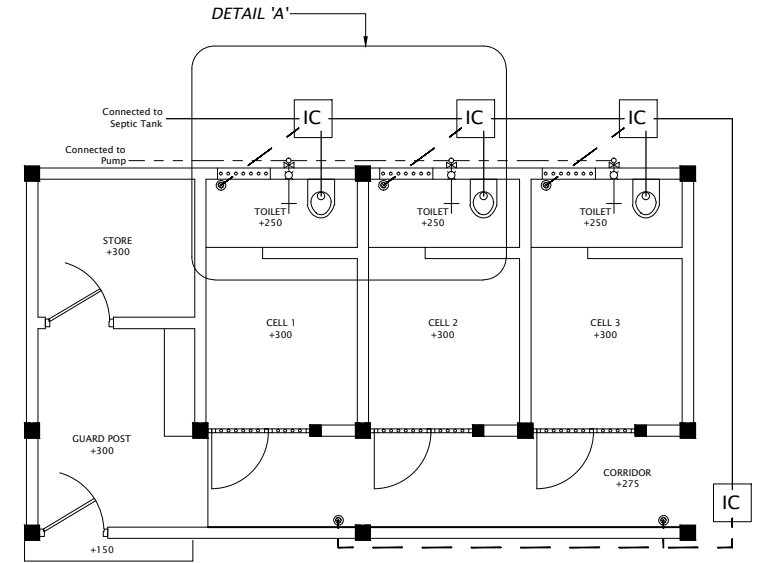

- All Fresh water and Ground water should be connected to pump room

PLUMBING LAYOUT

SCALE 1:100

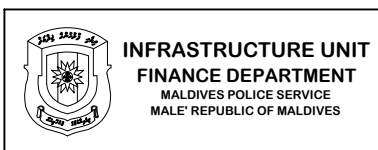

PROJECT TITLE
**GA. GEMANAFUSHI POLICE
STATION
CELL BLOCK**

RECOMMENDATION APPROVED BY
ABDUL MANNAAN YOOSUF
CHIEF SUPERINTENDENT OF POLICE

DESIGN APPROVED BY
AZEEM WAHEED
CHIEF INSPECTOR OF POLICE

APPROVED BY
AHMED MOHAMED
CHIEF SUPERINTENDENT OF POLICE

ARCHITECT / DESIGNER
AHMED MOOSA
SUB INSPECTOR OF POLICE
STRUCTURAL ENGINEER

DRAWN BY
AHMED MOOSA
SUB INSPECTOR OF POLICE
CHECKED BY

DATE
25 - 05 - 2013
REVISED DATE
25 - 05 - 2015

DRAWING NO
CB - SR1
SHEET NO

The drawings, concept and design contained are the properties of Maldives Police Service. Use of any kind of copy of whole or part of this drawing, concept or design or use on other projects or sites other than that specified on this drawing is strictly prohibited.