





TYPICAL JUNCTION DETAILS OF BEAM & COLUMN  
SCALE 1:20

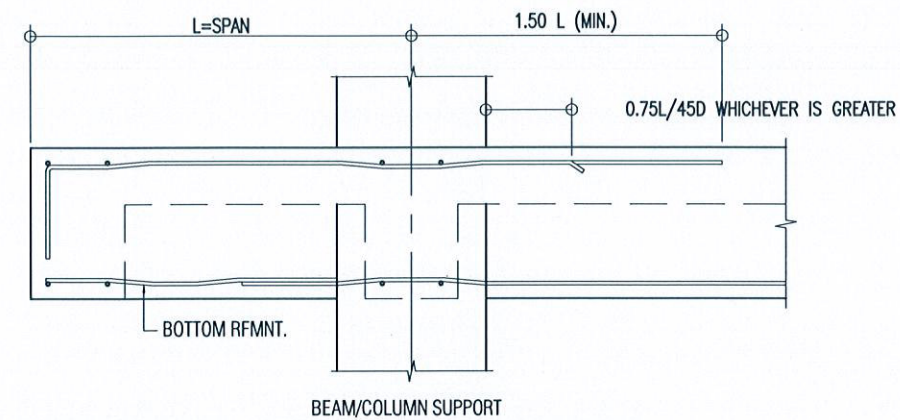

TYPICAL BEAM DETAILS FOR CANTILEVER  
SCALE 1:20

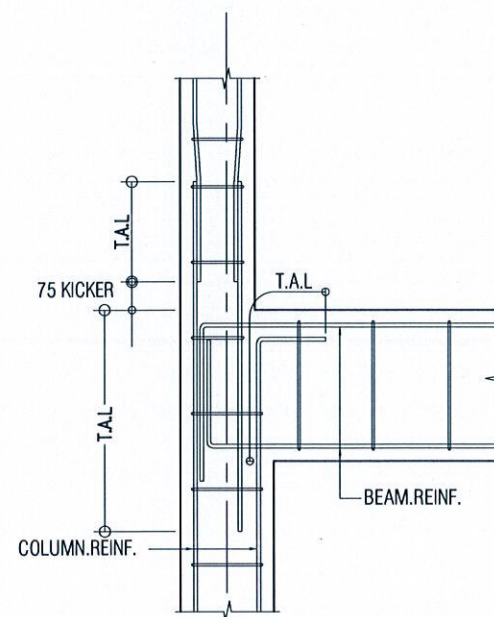

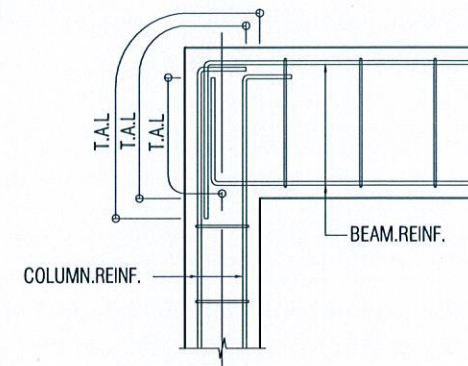

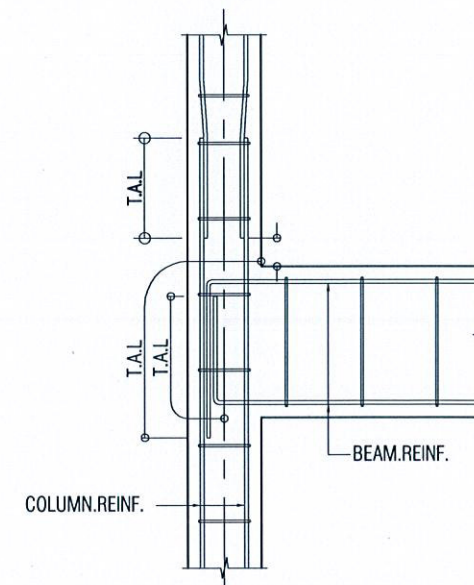




 


TYPICAL JUNCTION DETAILS OF BEAM & COLUMN  
SCALE 1:20



REVISIONS:		
PROJECT TITLE:		
DHA. ATOLL COUNCIL		
CLIENT :		
LGA		
ARCH. DESIGN:	SHAMIN	PROJECT NO
STRUC. DESIGN:	ASHRAF	DHC-11/15
DATE :	MAY 2015	DRAWING NO
SCALE:	AS GIVEN	S8
<b>ALAAF</b> ALAAF PRIVATE LIMITED THARUJHGE(GROUND FLOOR)SABUDHERYA MAGUMALE'20004, TEL: (080)7773801, E-MAIL: alaa.pvt@gmail.com,Web		

COPYRIGHT: THE CONCEPT AND DESIGN IN THIS DRAWING ARE THE PROPERTIES OF ALAAF PVT LTD. THIS DRAWINGS SHOULD BE USED ONLY FOR THE PROJECT MENTIONED ON THIS SHEET.

ELECTRICAL LEGEND

-  CEILING MOUNT LIGHT
-  600 MM - L LENGTH FLOURESCENT TUBE LIGHT LUMINARE
-  ONE WAY SWITCH 1.2MH
-  TELEPHONE SOCKET
-  NETWORK
-  WALL SOCKET OUTLET (SGL GNG 13A)
-  WALL SOCKET OUTLET (DBL GNG 13A)
-  WALL SOCKET OUTLET (SERVICE 15A)
-  D-BOARD
-  WEATHER PROOF MOUNT LIGHT

REVISIONS:

PROJECT TITLE:  
DHA. ATOLL COUNCIL


CLIENT :  
LGA

ARCH. DESIGN:	SHAMIN	PROJECT NO
STRUC. DESIGN:	ASHRAF	DHC-11/15
DATE :	MAY 2015	DRAWING NO
SCALE:	AS GIVEN	E1

**ALAAF**  
ALAAF PRIVATE LIMITED  
THARUHEGE(GROUND FLR)SABUDHERIYA MAGU,MALE'20004,  
TEL: (960)7773801, E-MAIL: alaat.pvt@gmail.com,Web

COPYRIGHT: THE CONCEPT AND DESIGN IN THIS DRAWING ARE THE PROPERTIES OF ALAAF PVT LTD. THIS DRAWINGS SHOULD BE USED ONLY FOR THE PROJECT MENTIONED ON THIS SHEET.



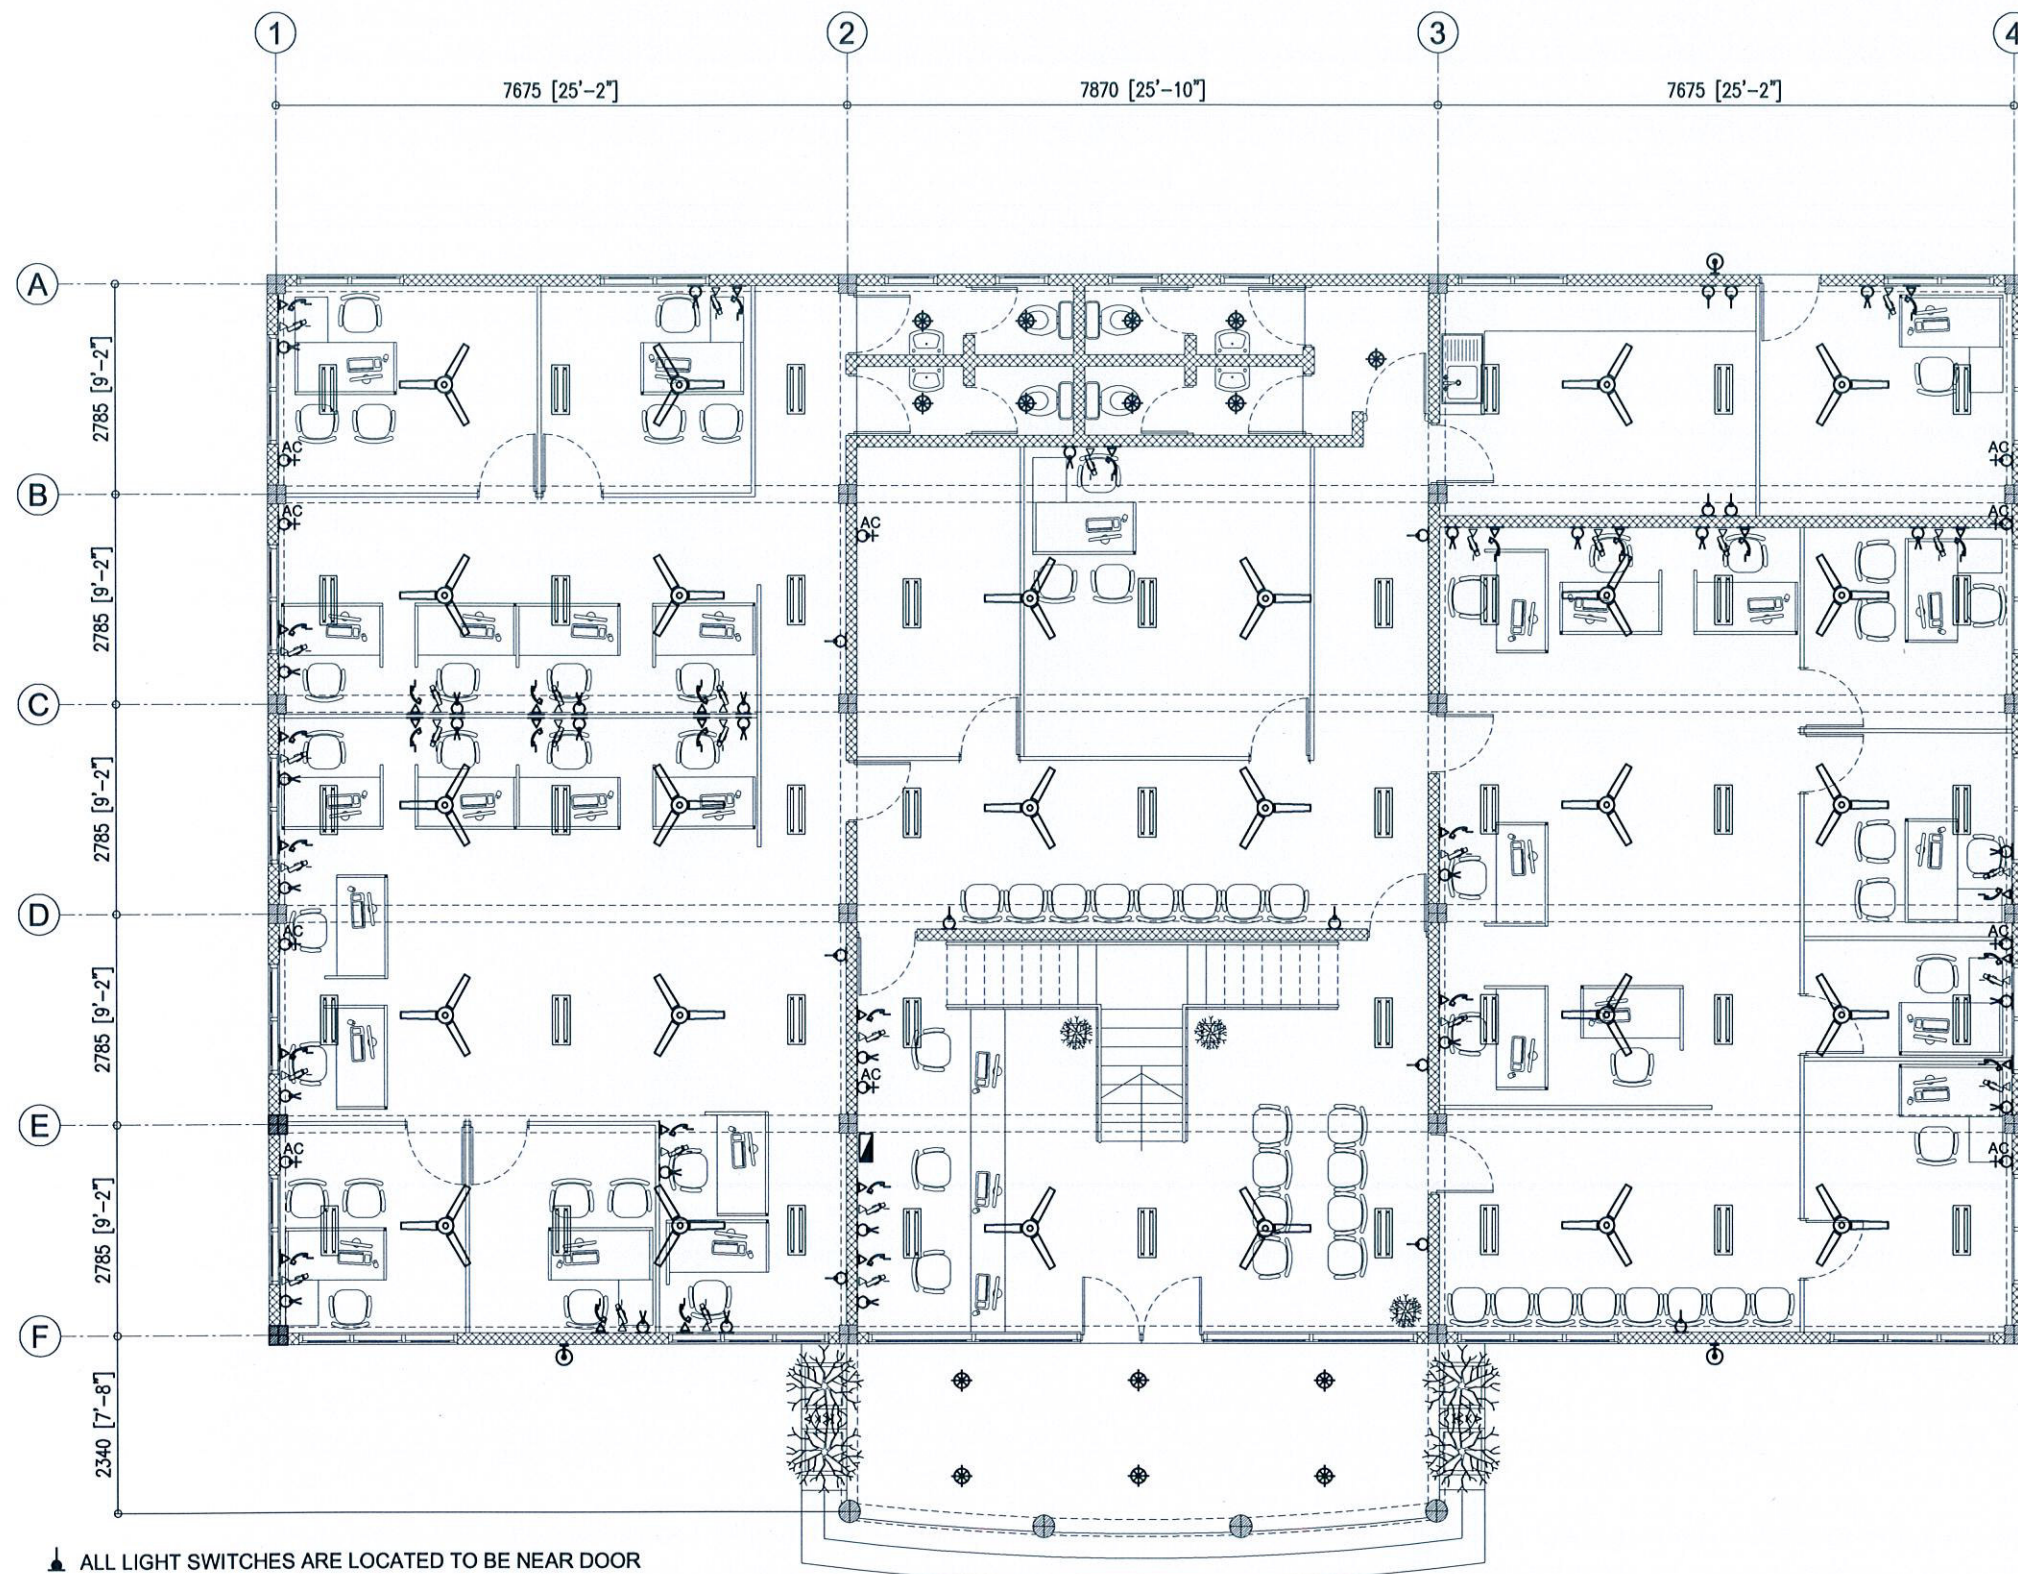


**GROUND ELECTRICAL LAYOUT**  
SCALE - 1:100

REVISIONS:		
PROJECT TITLE:		
DHA. ATOLL COUNCIL		
CLIENT :		
LGA		
ARCH. DESIGN:	SHAMIN	PROJECT NO
STRUC. DESIGN:	ASHRAF	DHC-11/15
DATE :	MAY 2015	DRAWING NO
SCALE:	AS GIVEN	E2
<b>ALAAF</b> ALAAF PRIVATE LIMITED THIRUVARUR (GROUND FLOOR) SHARADHERIYA, MADURAI-20004, TEL: (980)7773801, E-MAIL: alaaftpr@gmail.com, Web		

COPYRIGHT: THE CONCEPT AND DESIGN IN THIS DRAWING ARE THE PROPERTIES OF ALAAF PVT. LTD. THIS DRAWING SHOULD BE USED ONLY FOR THE PROJECT MENTIONED ON THIS SHEET.



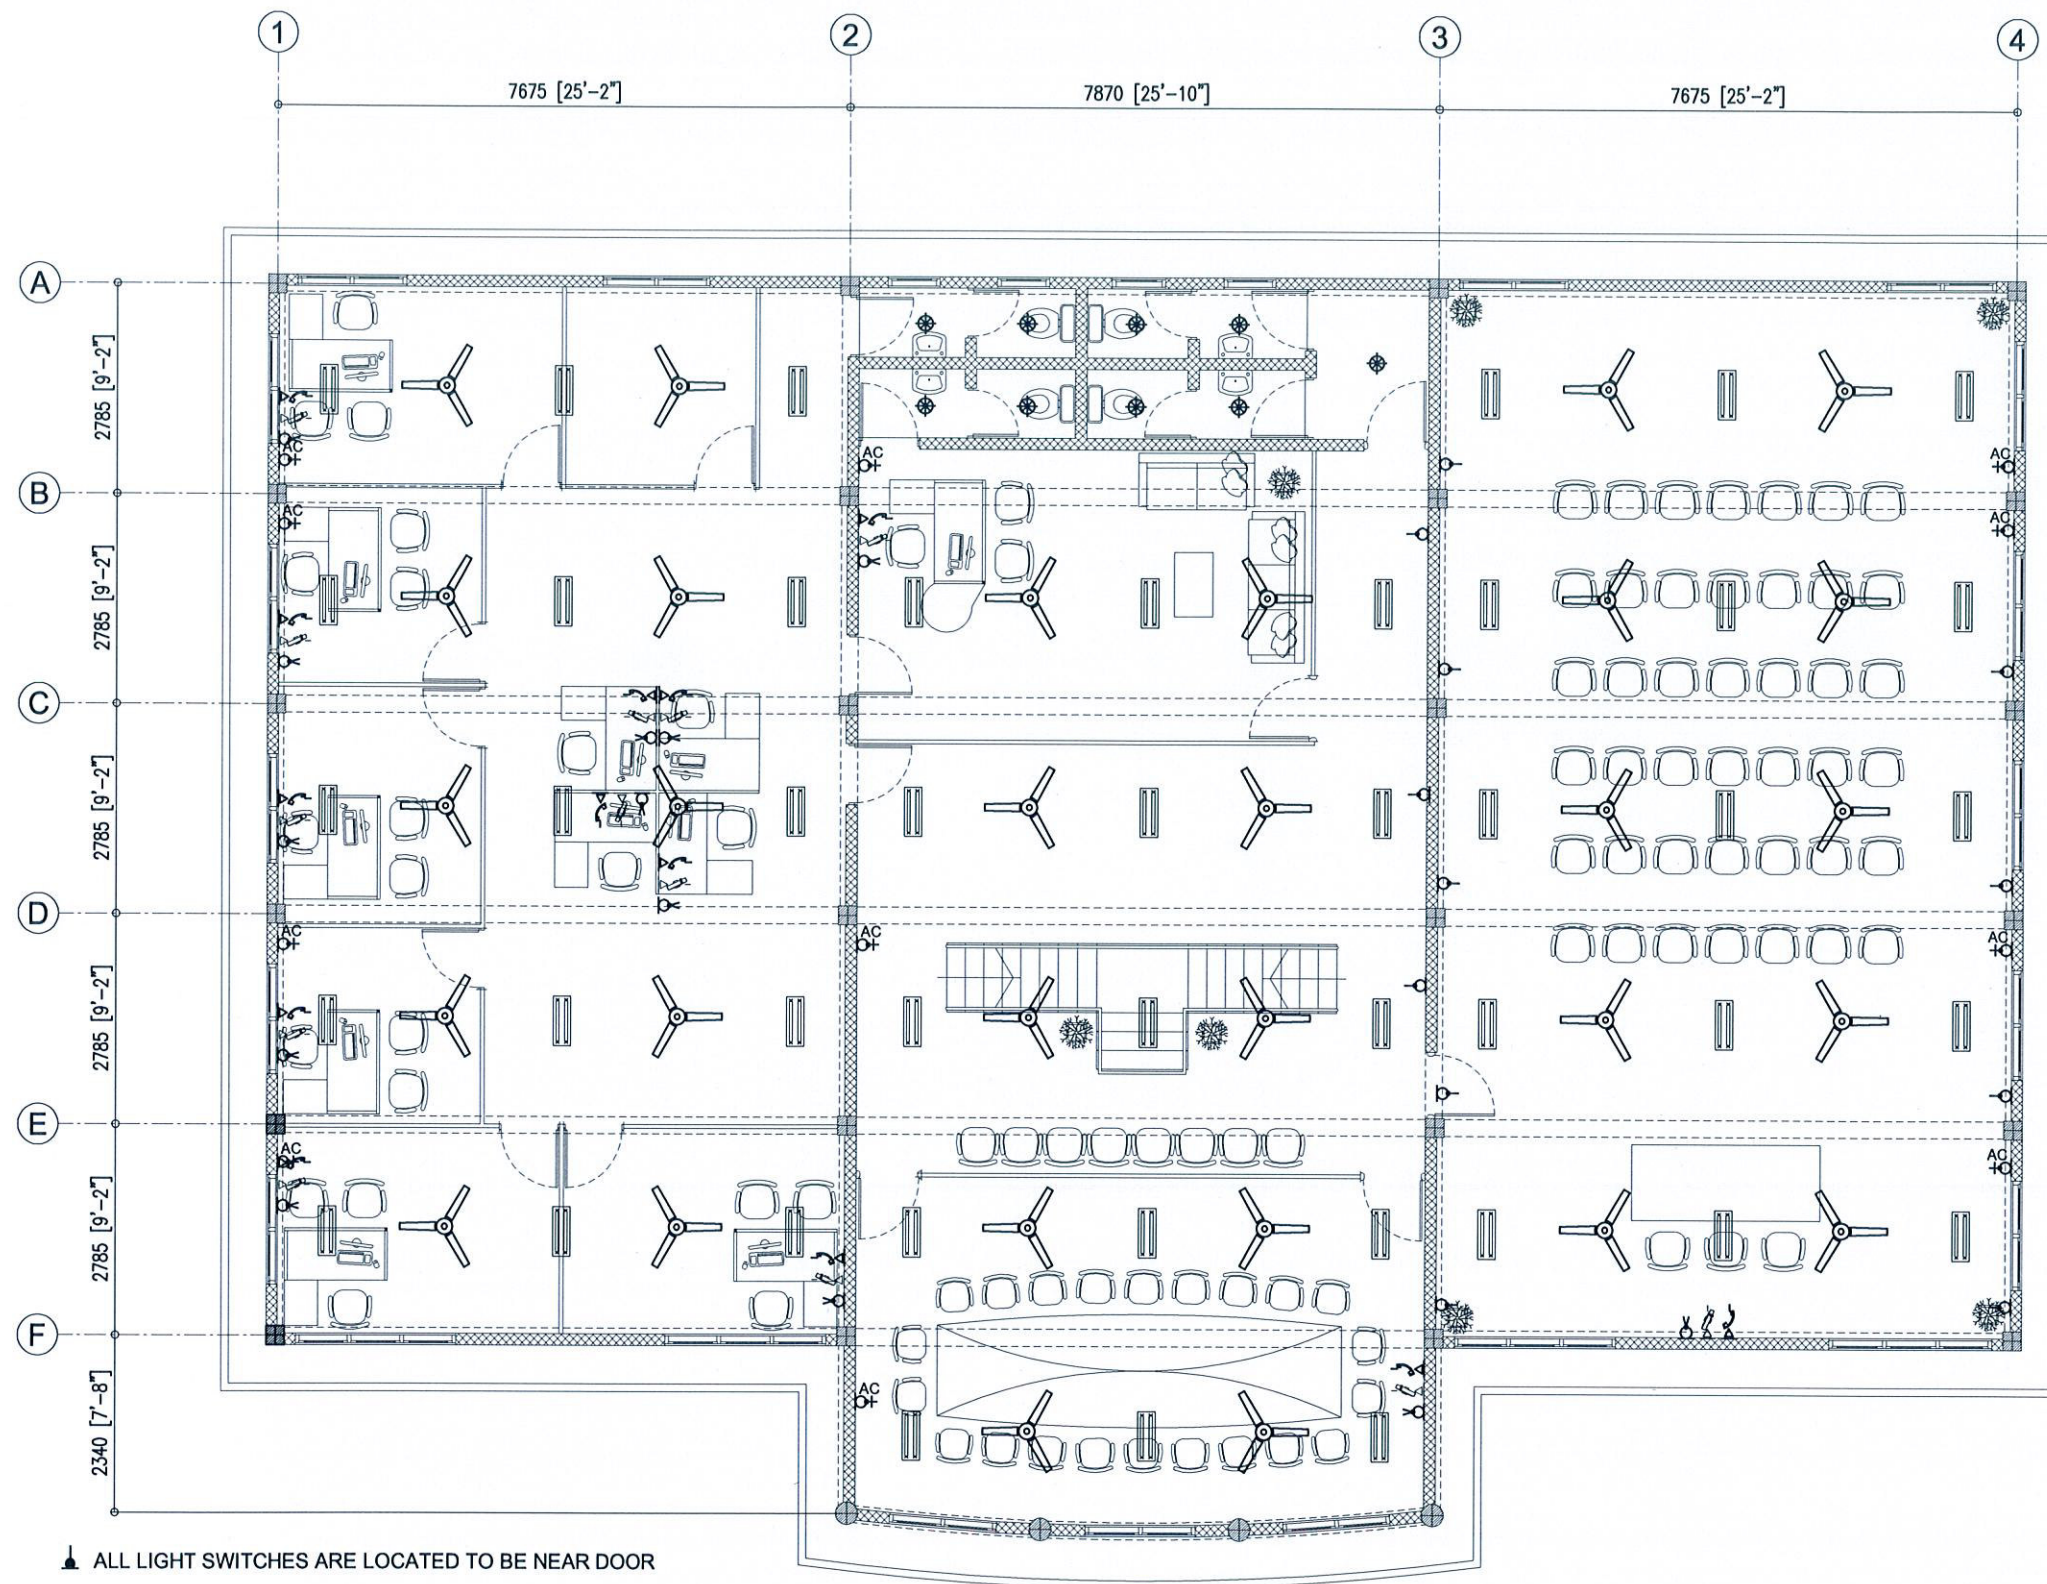







 


 



 
**1ST FLOOR ELECTRICAL LAYOUT**  
SCALE - 1:100

REVISIONS:     		
PROJECT TITLE: <b>DHA. ATOLL COUNCIL</b>		
CLIENT : LGA		
ARCH. DESIGN: SHAMIN	PROJECT NO DHC-11/15	DRAWING NO <b>E3</b>
STRUC. DESIGN: ASHRAF	DATE : MAY 2015	
SCALE: AS GIVEN		
<b>ALAAF</b> ALAAF PRIVATE LIMITED THARUDHGE(GROUND FLR)SABUDHERRYA MAGUMALE'20004. TEL: (980)7773801, E-MAIL: doof.pvt@gmail.com, Web		

COPYRIGHT: THE CONCEPT AND DESIGN IN THIS DRAWING ARE THE PROPERTIES OF ALAAF PVT. LTD. THIS DRAWING SHOULD BE USED ONLY FOR THE PROJECT MENTIONED ON THIS SHEET.



Plumbing Symbols Key:

SYMBOLS	DESCRIPTION	SYMBOLS	DESCRIPTION
	- SEWAGE DISPOSAL LINE (Ø100)		- FLOOR DRAIN
	- WASTE WATER LINE(Ø35)		- STOP/GATE VALVE
	- MWSC WATER PIPE(Ø35)		- PUMP
	- GROUND WATER PIPE(Ø35)		- MWSC WATER METER
	- VENT PIPE(Ø50)		- Ø100MM CLEAN OUT WITH CAP
	- FAUCET (F)		- SHOWER (S)
	- MUSLIM SHOWER (M)		- BOOSTER BUMP


NOTE:

- \* ALL THE CONNECTION SHOULD BE DONE THROUGH GATE VALVE
- \* THIS DRAWING IS ONLY FOR PLUMBING USE

REVISIONS:		
PROJECT TITLE:		
DHA. ATOLL COUNCIL		
CLIENT :		
LGA		
ARCH. DESIGN:	SHAMIN	PROJECT NO
STRUC. DESIGN:	ASHRAF	DHC-11/15
DATE :	MAY 2015	DRAWING NO
SCALE:	AS GIVEN	P1
		
ALAAF PRIVATE LIMITED THARUDHIGE(GROUND FLOOR)SABUDHERIYA MAGUMALE'20004, TEL: (980)7773601, E-MAIL: alaaf.pvt@gmail.com,Web		

COPYRIGHT: THE CONCEPT AND DESIGN IN THIS DRAWING ARE THE PROPERTIES OF ALAAF PVT LTD. THIS DRAWINGS SHOULD BE USED ONLY FOR THE PROJECT MENTIONED ON THIS SHEET.



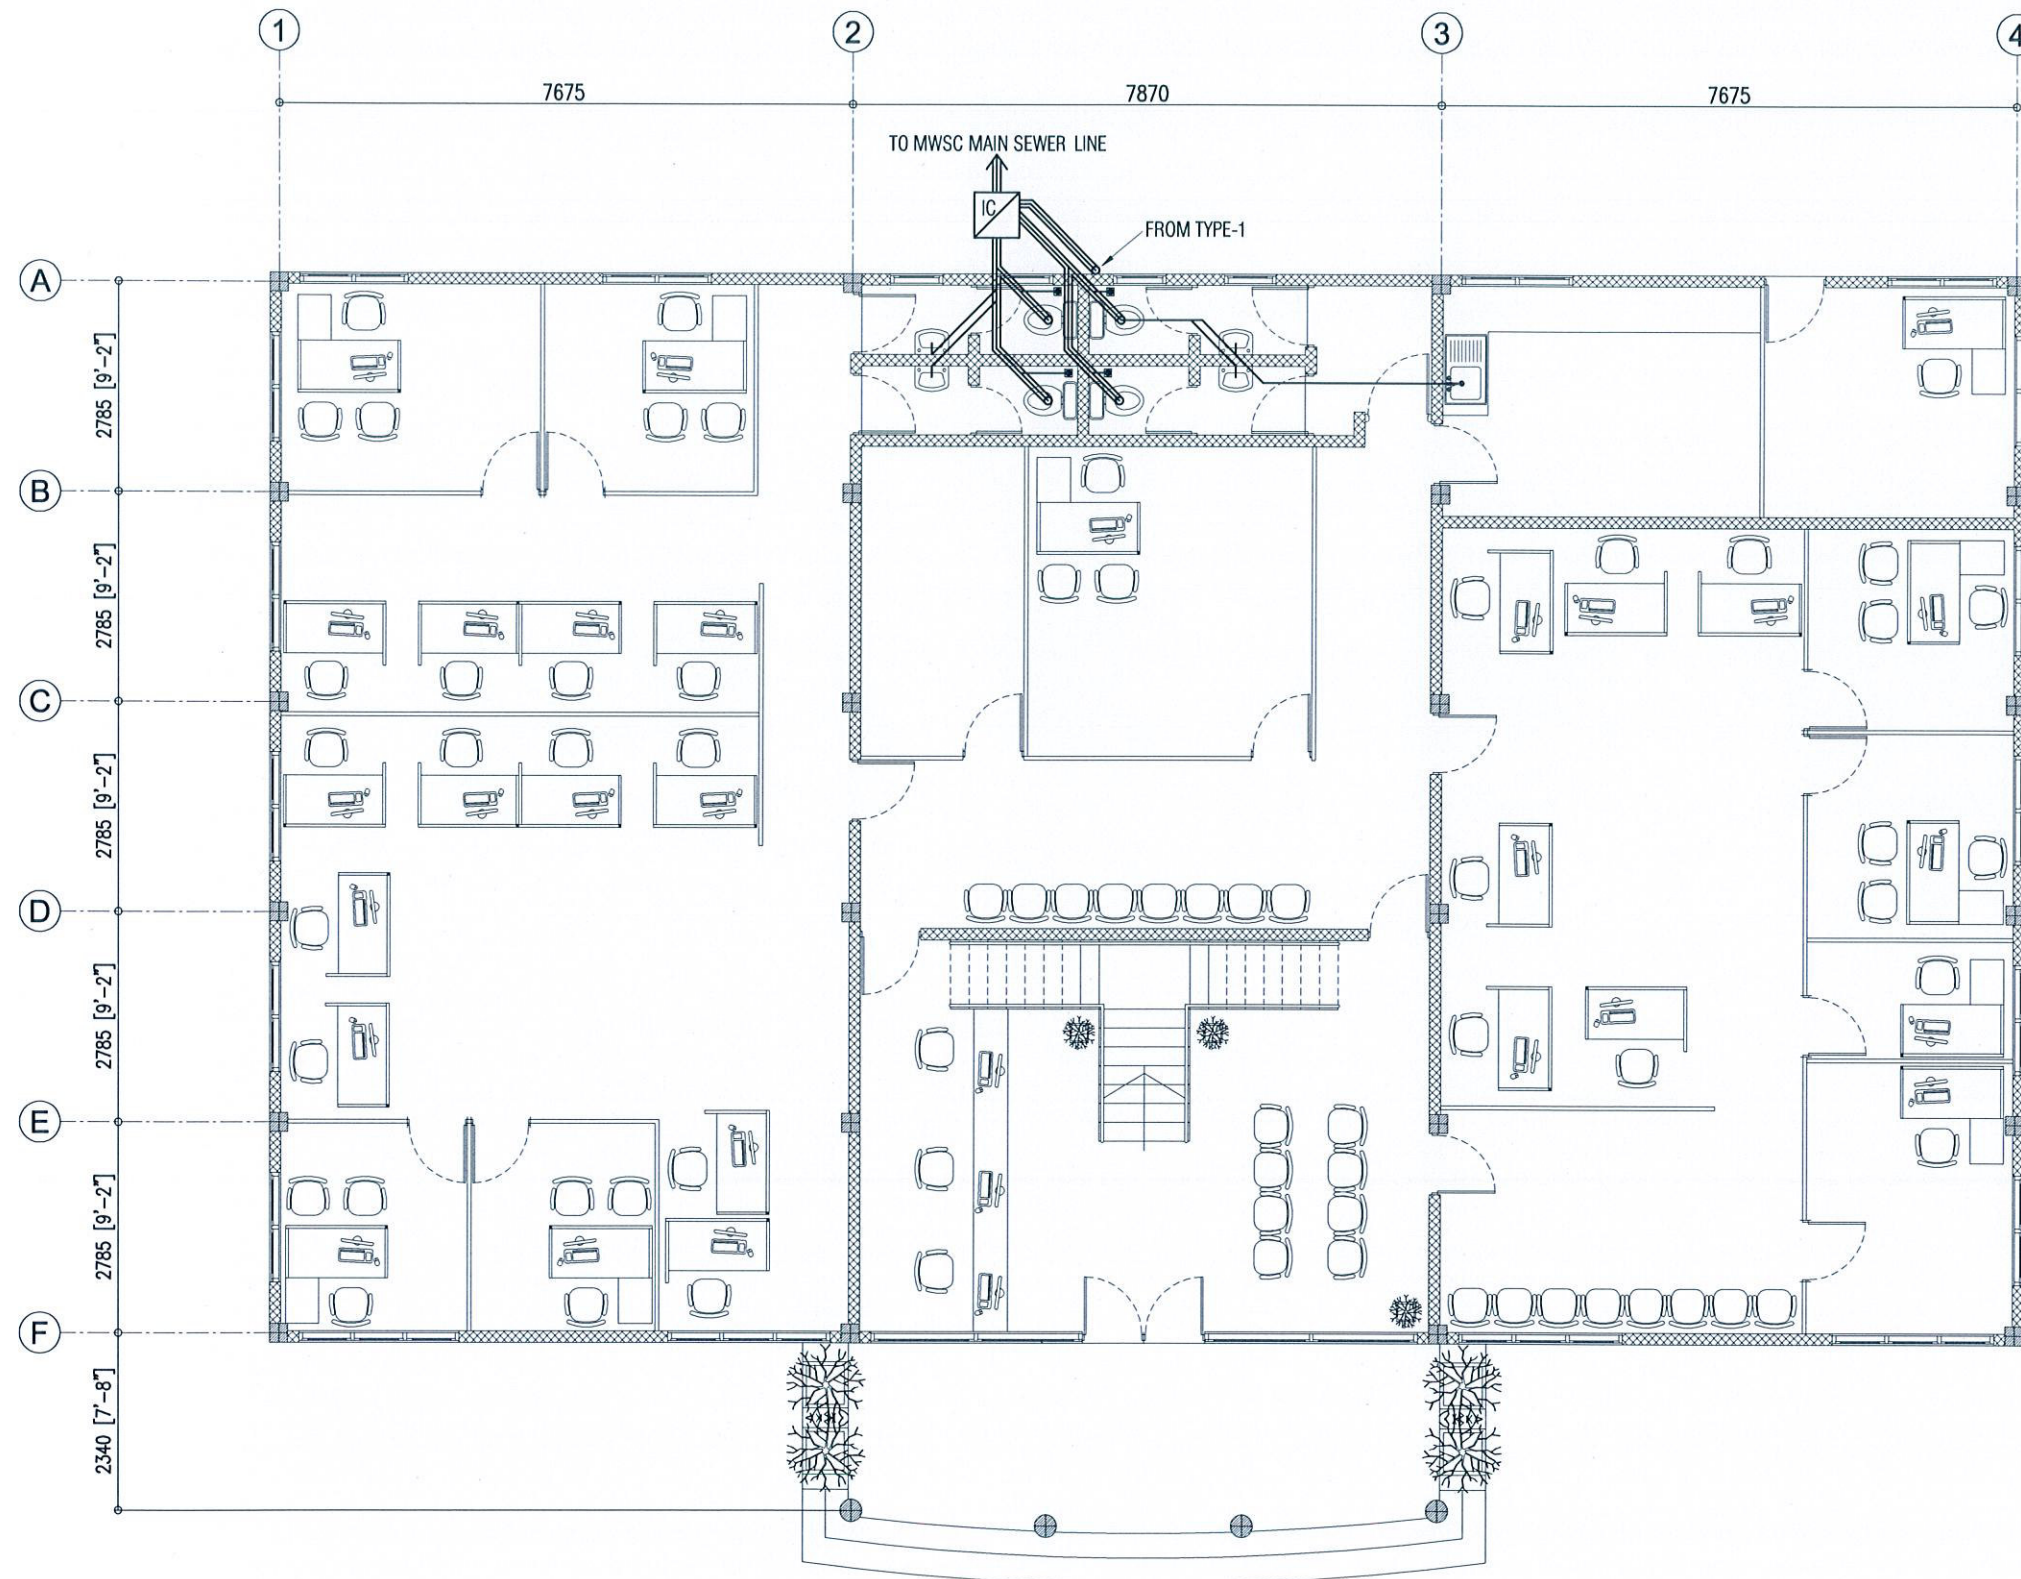


**GROUND FLOOR WASTE WATER LINE LAYOUT**  
**SCALE - 1:100**

REVISIONS:		
PROJECT TITLE:		
DHA. ATOLL COUNCIL		
CLIENT :		
LGA		
ARCH. DESIGN:	SHAMIN	PROJECT NO
STRUC. DESIGN:	ASHRAF	DHC-11/15
DATE :	MAY 2015	DRAWING NO
SCALE:	AS GIVEN	P2
<b>ALAAF</b> ALAAF PRIVATE LIMITED THARUJHIGE(GROUND FLOOR)BUDHERIYA MAGUJALE'20004, TEL: (960)7773601, E-MAIL: alaaaf.pvt@gmail.com, Web		

COPYRIGHT: THE CONCEPT AND DESIGN IN THIS DRAWING ARE THE PROPERTIES OF ALAAF PVT. LTD. THIS DRAWING SHOULD BE USED ONLY FOR THE PROJECT MENTIONED ON THIS SHEET.



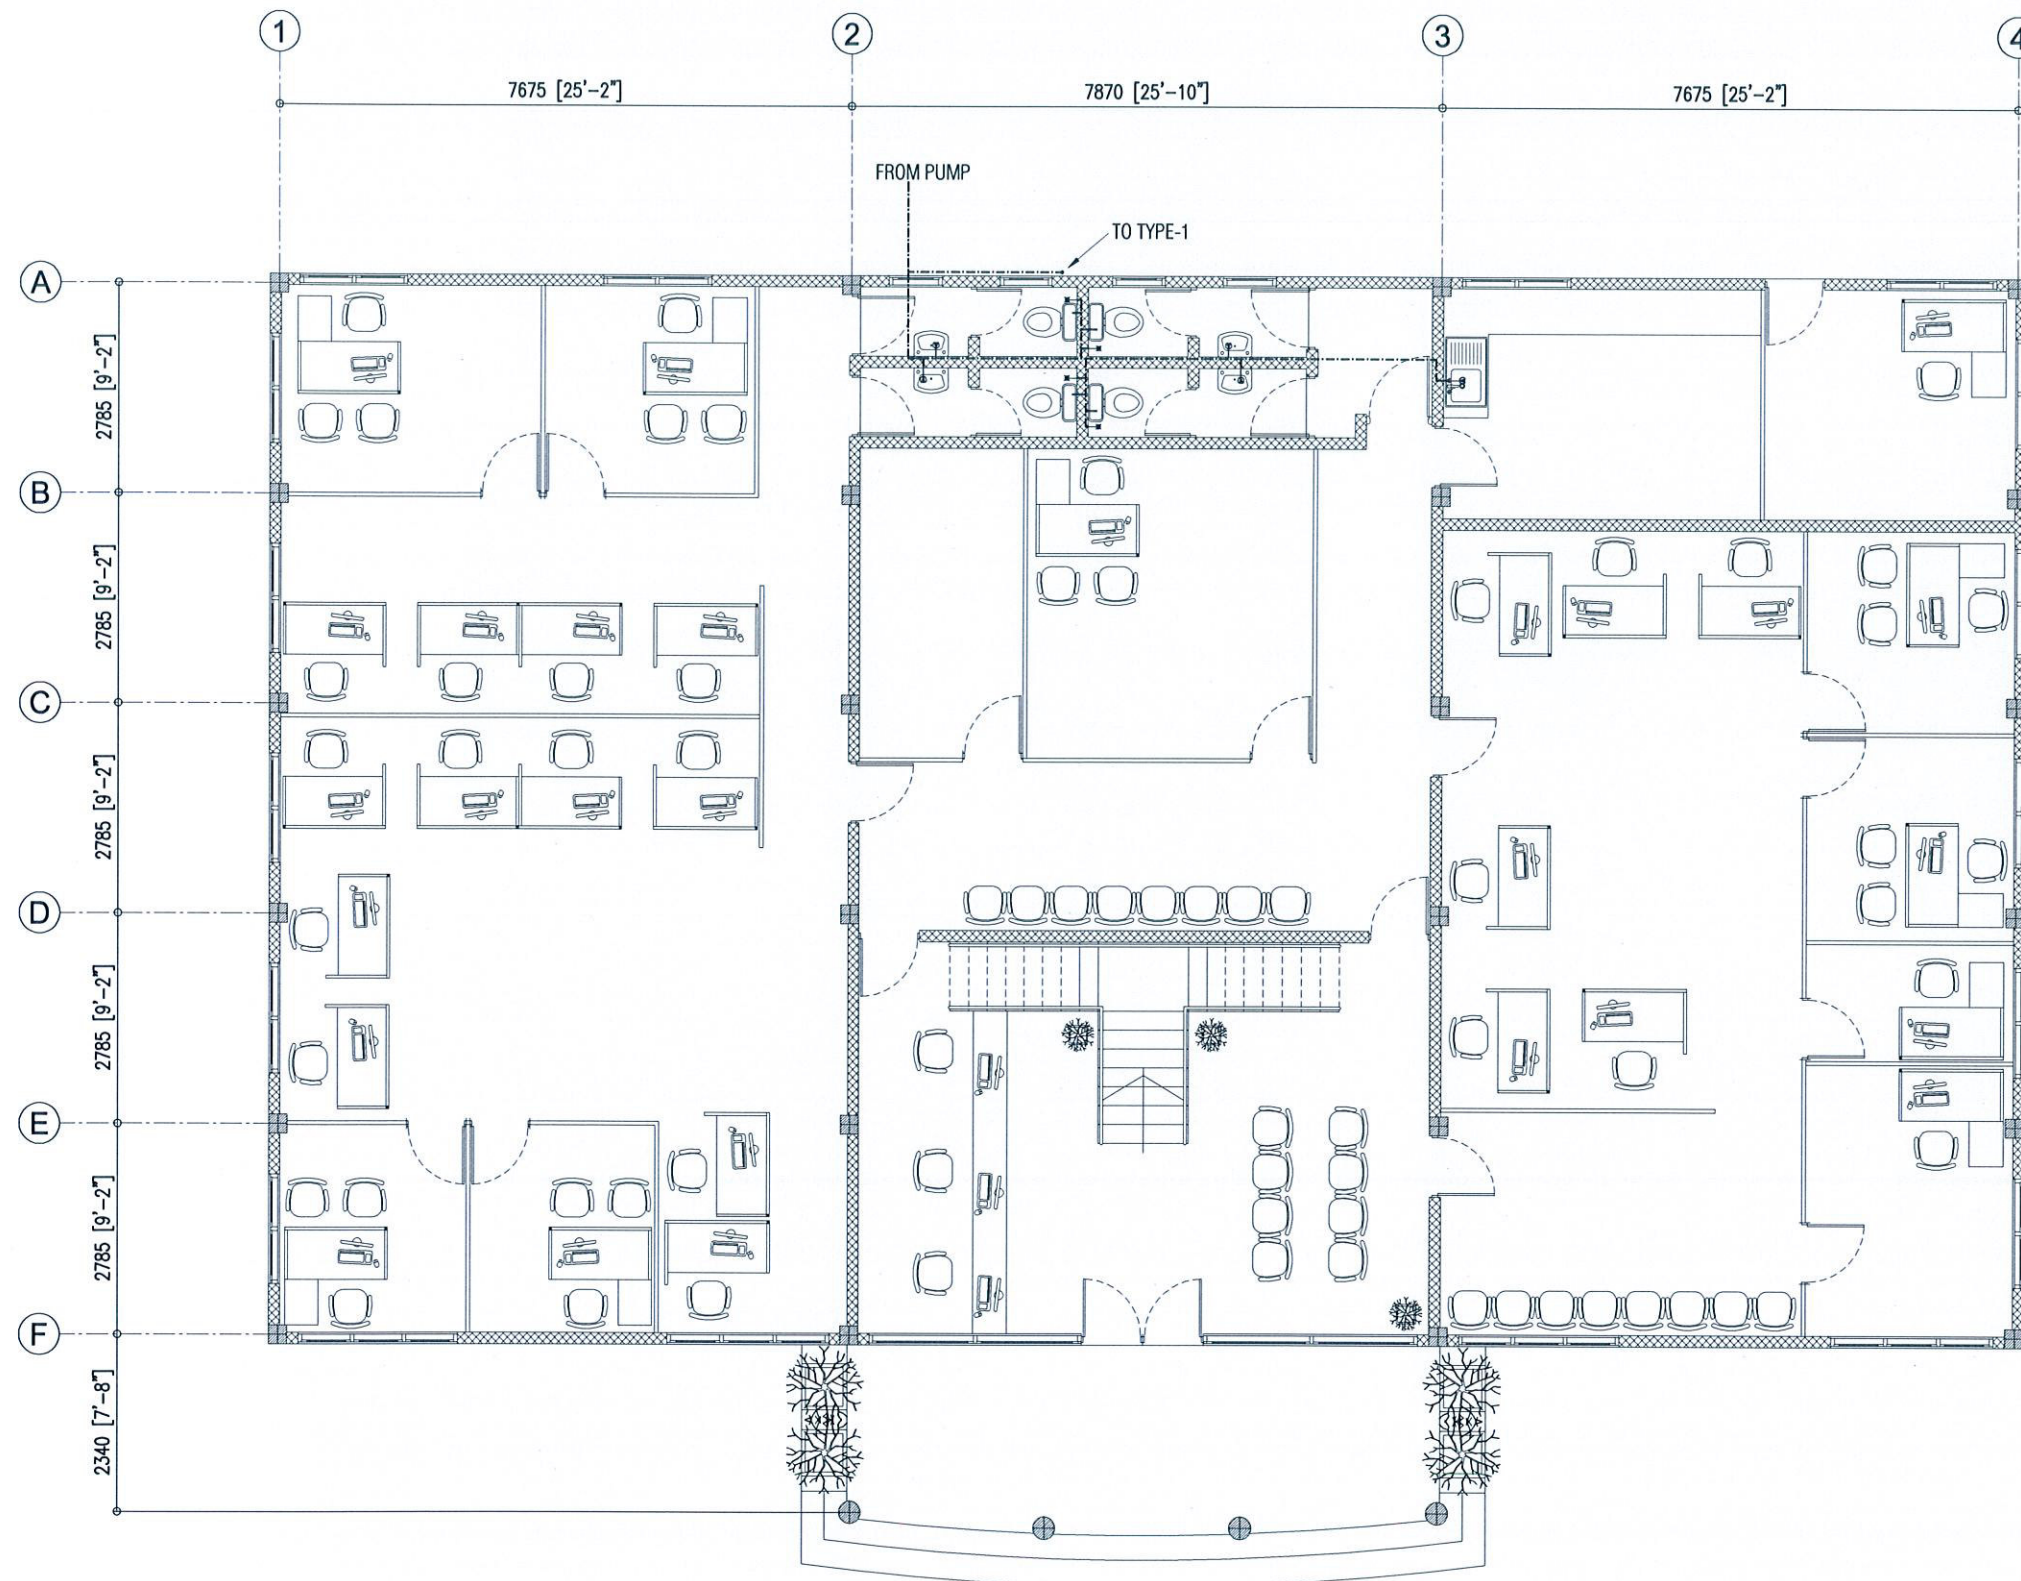


**GROUND FLOOR WELL WATER LINE LAYOUT**  
**SCALE - 1:100**

REVISIONS:		
PROJECT TITLE:		
DHA. ATOLL COUNCIL		
CLIENT :		
LGA		
ARCH. DESIGN:	SHAMIN	PROJECT NO
STRUC. DESIGN:	ASHRAF	DHC-11/15
DATE :	MAY 2015	DRAWING NO
SCALE:	AS GIVEN	P3
<b>ALAAF</b> ALAAF PRIVATE LIMITED THIRUVARHOOR(GROUND FLOOR)BROOKHURRYA WAGUJALLE 20004, TEL: (980)7773601, E-MAIL: alaaaf.pvt@gmail.com, Web		

COPYRIGHT: THE CONCEPT AND DESIGN IN THIS DRAWING ARE THE PROPERTIES OF ALAAF PVT LTD. THIS DRAWING SHOULD BE USED ONLY FOR THE PROJECT MENTIONED ON THIS SHEET.



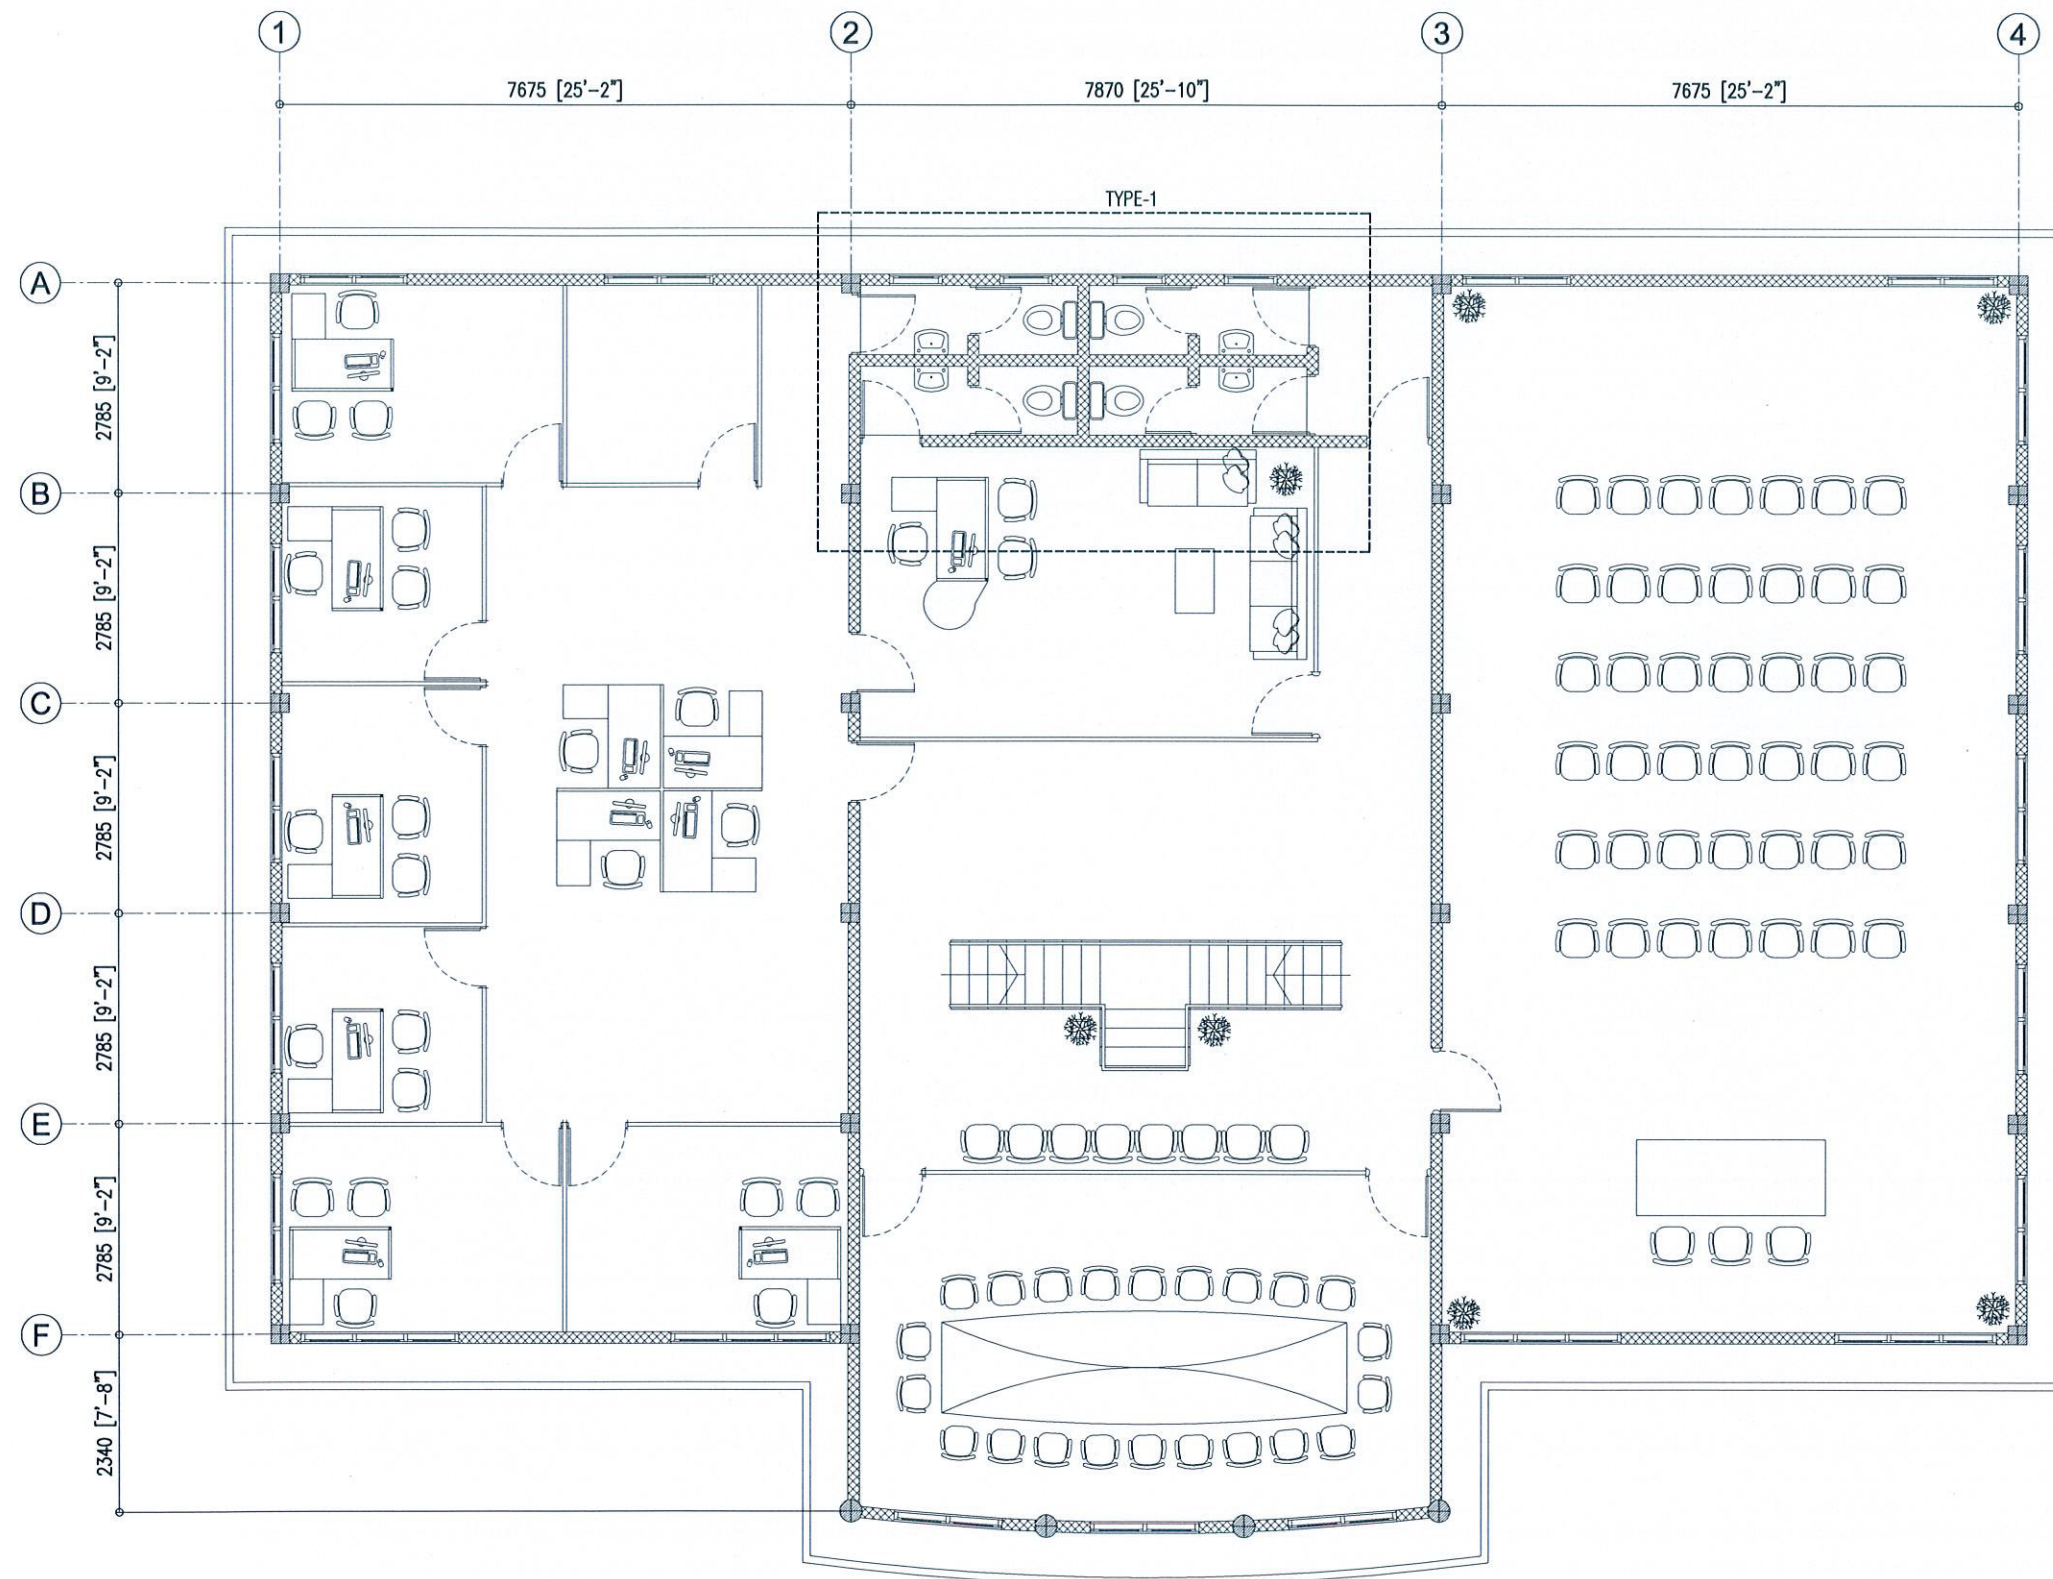


**1ST FLOOR KEY PLAN**  
SCALE - 1:100

REVISIONS:		
PROJECT TITLE:		
DHA. ATOLL COUNCIL		
CLIENT :		
LGA		
ARCH. DESIGN:	SHAMIN	PROJECT NO
STRUC. DESIGN:	ASHRAF	DHC-11/15
DATE :	MAY 2015	DRAWING NO
SCALE:	AS GIVEN	P4
<b>ALAAF</b> ALAAF PRIVATE LIMITED THARUDHIGE (GROUND FLR) SABUDHERIYA MAGU, MALE' 20004, TEL: (960) 7773601, E-MAIL: alAAF.pvt@gmail.com, Web		

COPYRIGHT: THE CONCEPT AND DESIGN IN THIS DRAWING ARE THE PROPERTIES OF ALAAF PVT. LTD. THIS DRAWING SHOULD BE USED ONLY FOR THE PROJECT MENTIONED ON THIS SHEET.



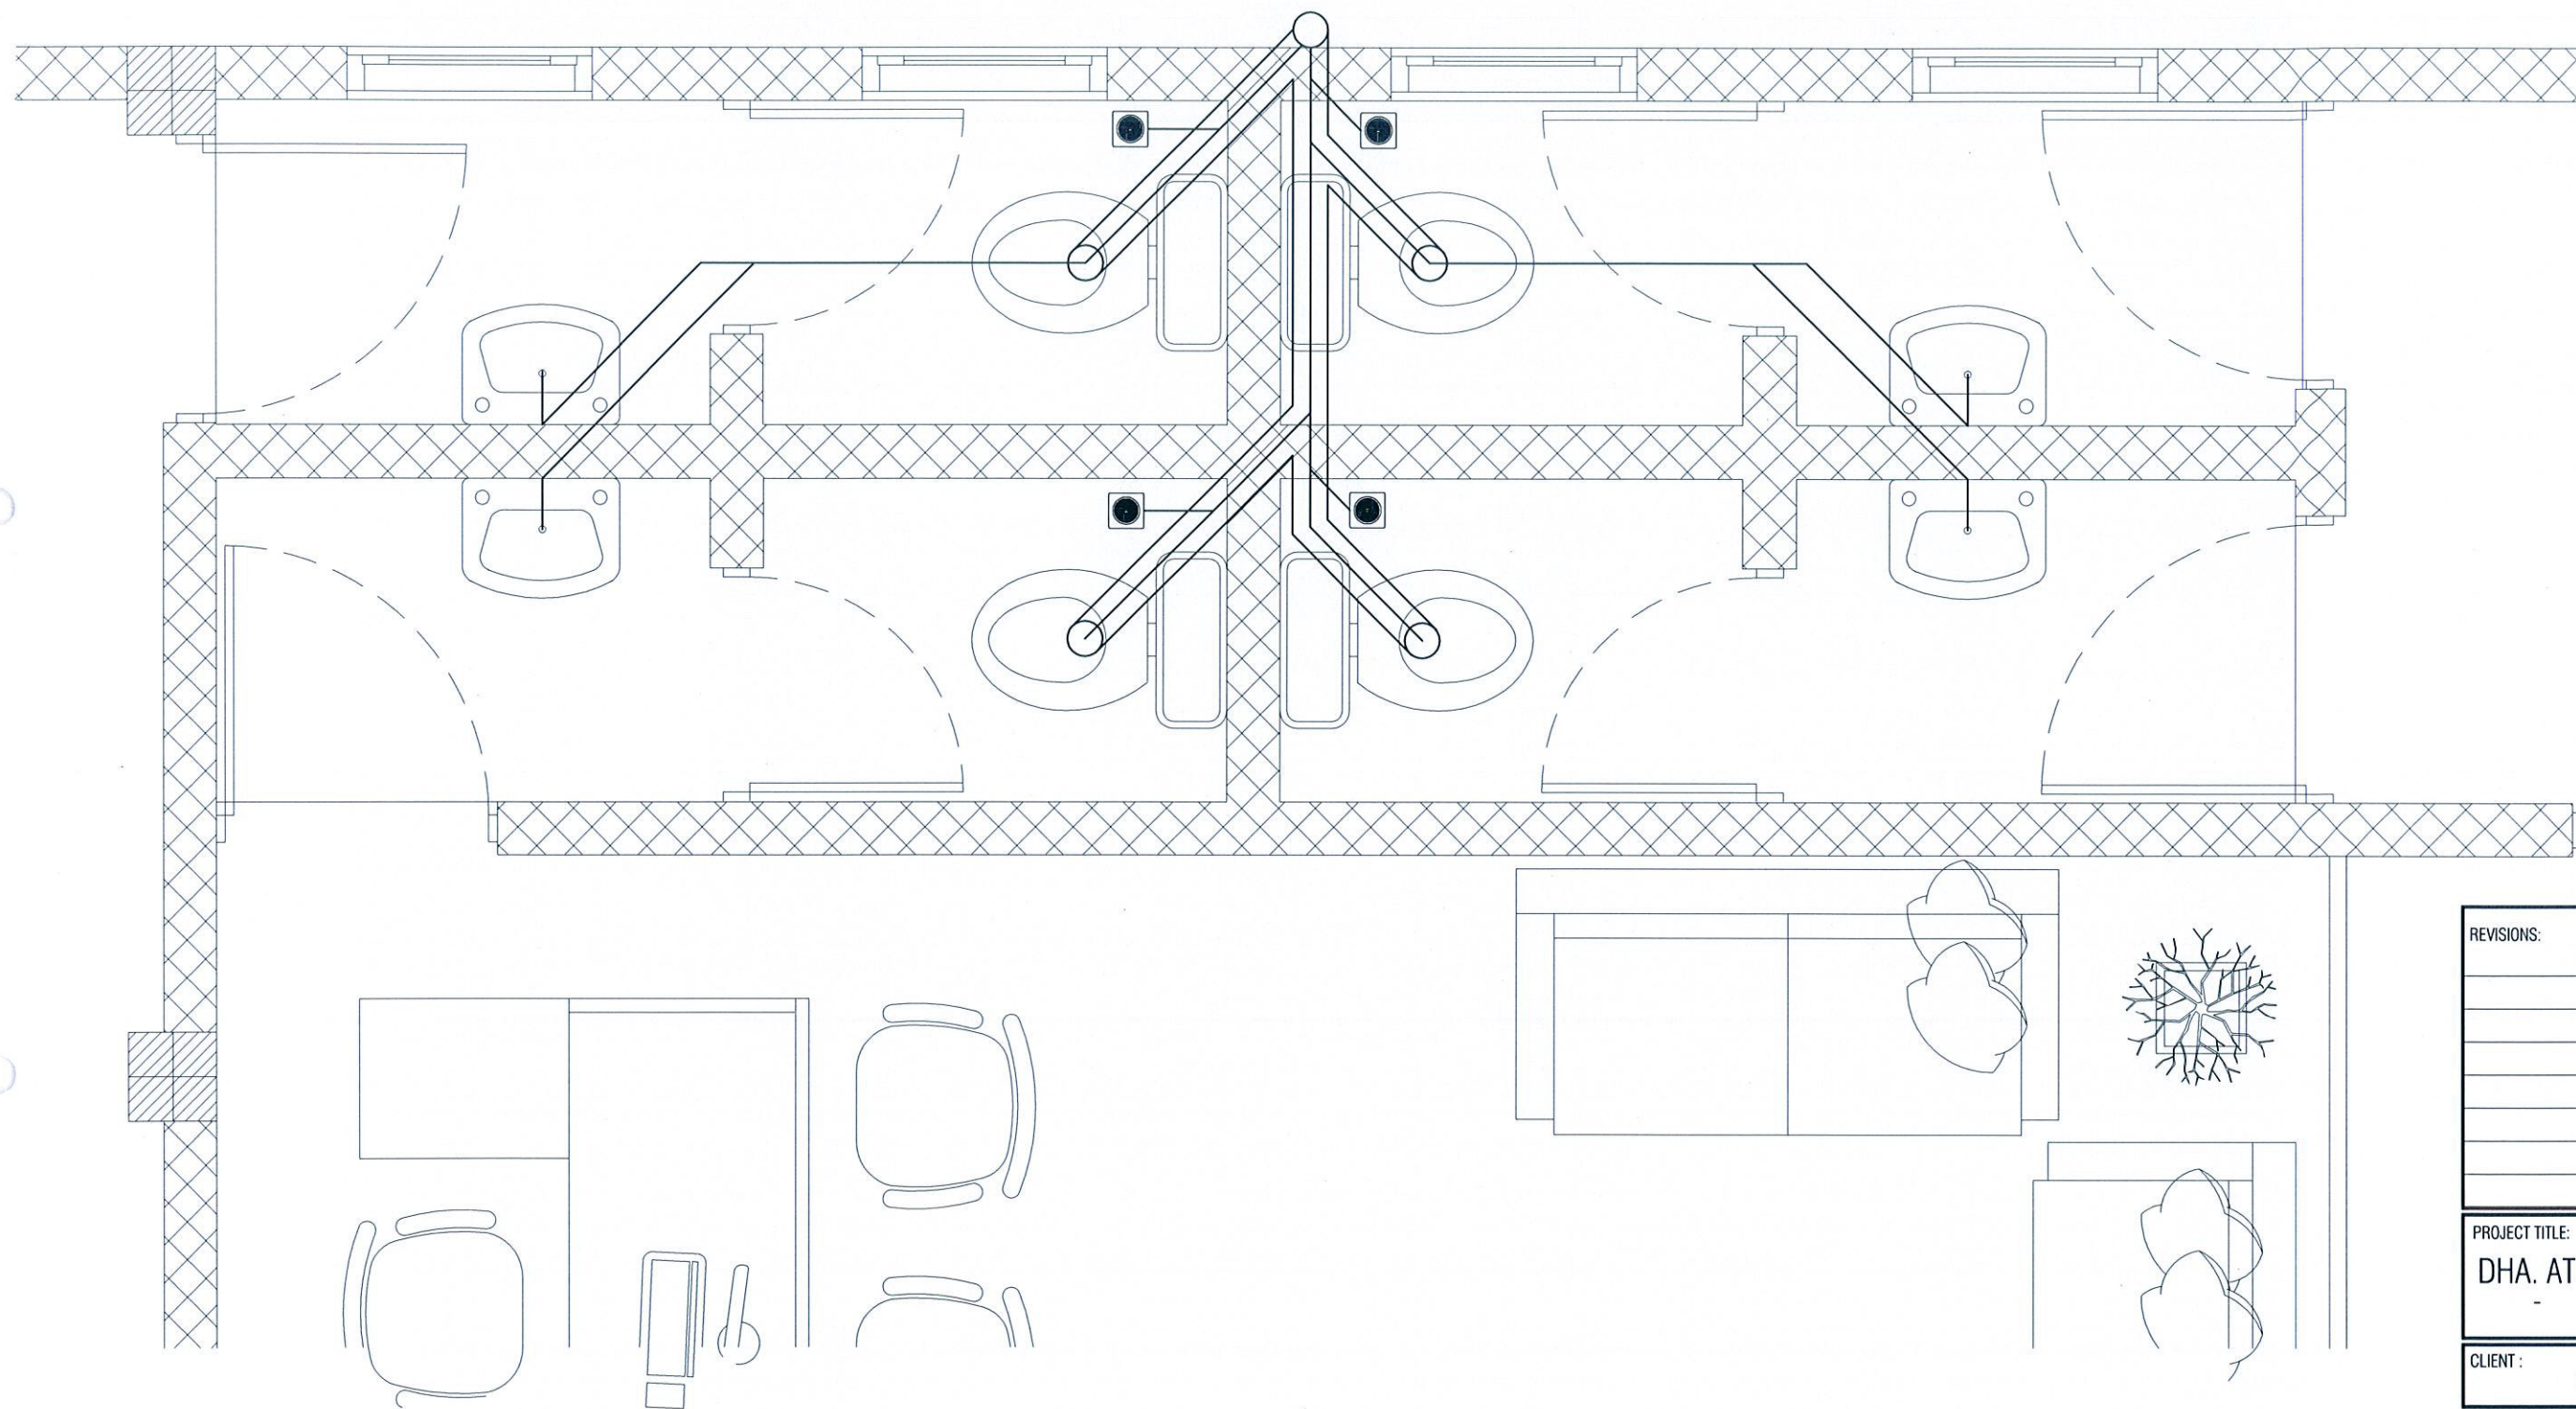


**WASTE WATER AND SEWAGE DISPOSAL LAYOUT - TYPE-1**  
**SCALE - 1:20**

REVISIONS:		
PROJECT TITLE:		
DHA. ATOLL COUNCIL		
CLIENT :		
LGA		
ARCH. DESIGN:	SHAMIN	PROJECT NO
STRUC. DESIGN:	ASHRAF	DHC-11/15
DATE :	MAY 2015	DRAWING NO
SCALE:	AS GIVEN	P5
<b>ALAAF</b> ALAAF PRIVATE LIMITED THARUWAKKE (GROUND FLOOR) BUKHARIYA WAGUWALE 20004, TEL: (960) 7773001, E-MAIL: alaaftpt@gmail.com, Web		

COPYRIGHT: THE CONCEPT AND DESIGN IN THIS DRAWING ARE THE PROPERTIES OF ALAAF PVT LTD. THIS DRAWING SHOULD BE USED ONLY FOR THE PROJECT MENTIONED ON THIS SHEET.



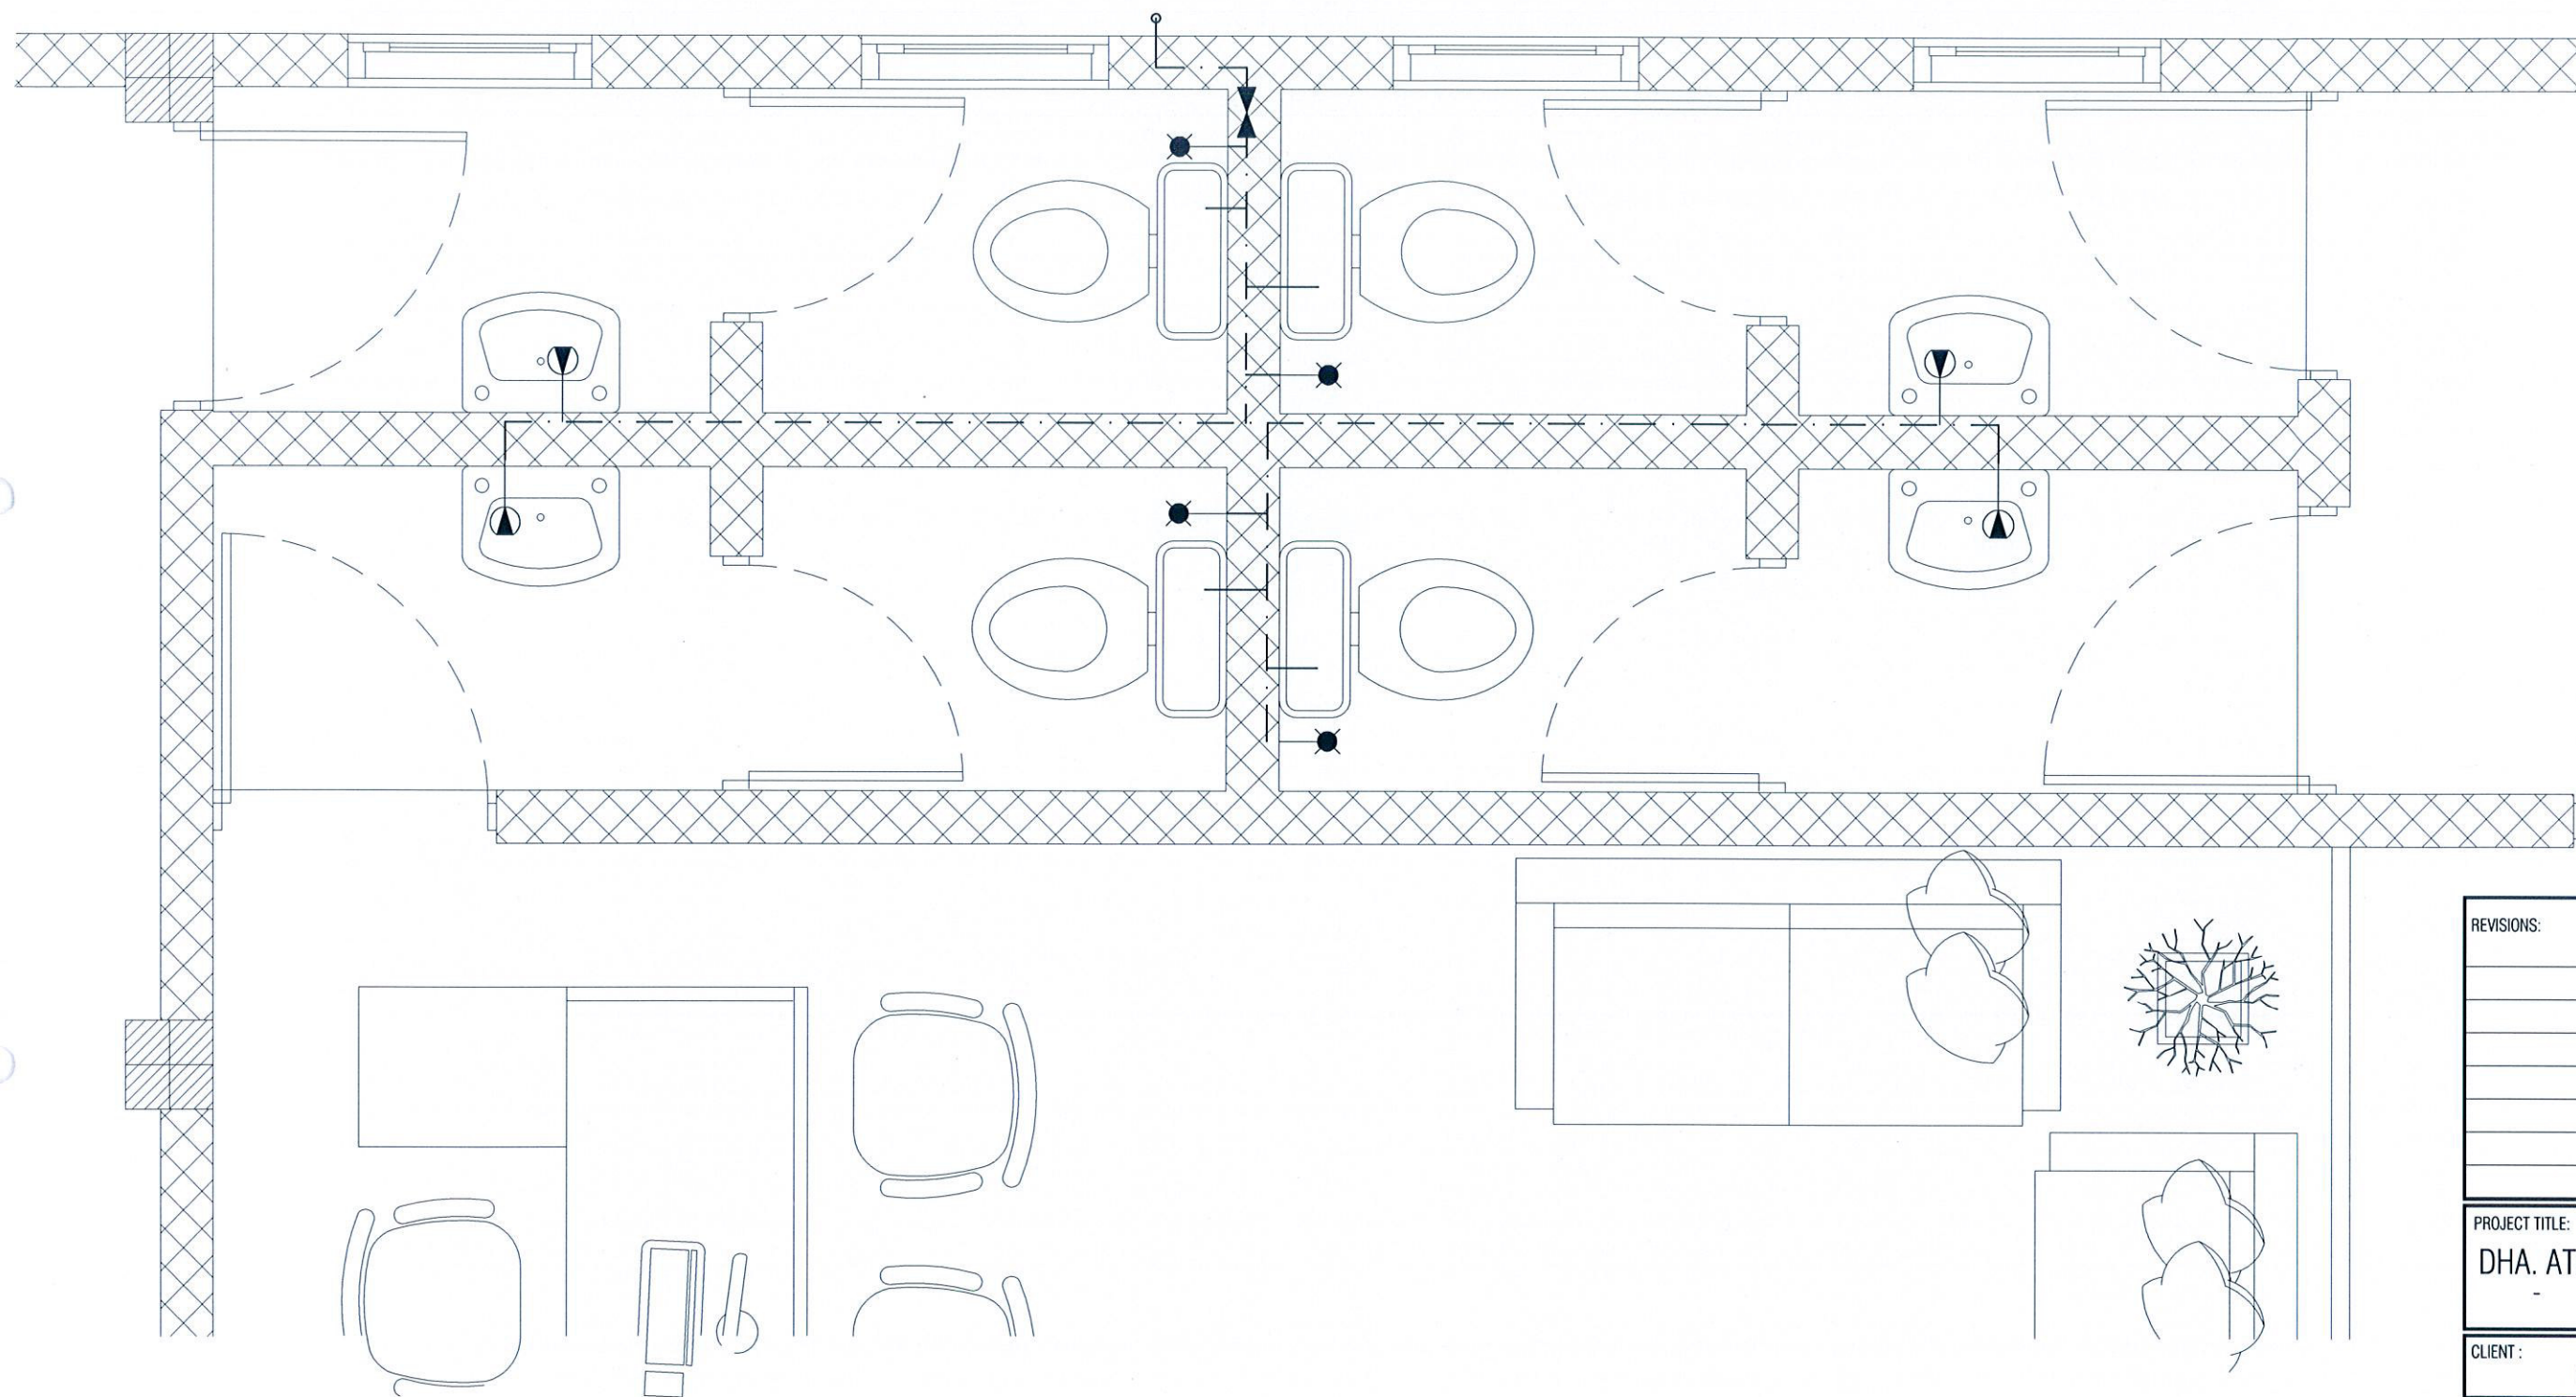

**GROUND WATER SUPPLY LAYOUT - TYPE-1**  
**SCALE - 1:20**

REVISIONS:

PROJECT TITLE:
DHA. ATOLL COUNCIL

CLIENT :
LGA

ARCH. DESIGN:	SHAMIN	PROJECT NO
STRUC. DESIGN:	ASHRAF	DHC-11/15
DATE :	MAY 2015	DRAWING NO
SCALE:	AS GIVEN	P6

<b>ALAAF</b>
ALAAF PRIVATE LIMITED
THARUWEGE(GROUND FLR)SABUDHERYA MAGU,MALE'20004,
TEL: (960)7773601, E-MAIL: alaaftvt@gmail.com,Web

COPYRIGHT: THE CONCEPT AND DESIGN IN THIS DRAWING ARE THE PROPERTIES OF ALAAF PVT. LTD. THIS DRAWINGS SHOULD BE USED ONLY FOR THE PROJECT MENTIONED ON THIS SHEET.